


KEARNEY ST. (MO 744)
A.A.D.T. - 2020 = 10,638
A.A.D.T. - 2040 = 13,325
D.H.V. (WB) = 8.86% D.H.V. (EB) = 20.60%
T (WB) = 9.90% T (EB) = 3.70%
V = 45 M.P.H.
FUNCTIONAL CLASSIFICATION - MINOR/PRINCIPAL
ARTERIAL

WEST BYPASS (US 160)
 A.A.D.T. - 2020 = 16,315
 A.A.D.T. - 2040 = 18,420
 D.H.V. (WB) = 8.16% D.H.V. (EB) = 11.86%
 T (WB) = 7.03% T (EB) = 7.12%
 V = 45 M.P.H.
 FUNCTIONAL CLASSIFICATION - FREEWAY/EXPRESSWAY


THIS SHALL BE A PARTIAL CONTROLLED ACCESS HIGHWAY,
EXCEPT AT LOCATIONS AND AS OTHERWISE SPECIFICALLY
SHOWN ON THESE PLANS. NO ABUTTER'S RIGHTS IN OR OF
DIRECT ACCESS TO, FROM, OR ACROSS THE HIGHWAY OR ITS
RIGHT-OF-WAY SHALL ATTACH OR BELONG TO ANY PERSON
ABUTTING ON SAID SECTION OF HIGHWAY OR TO ANY PERSON
WHICH MAY BECAUSE OF OWNERSHIP OF SUCH ABUTTING PROPERTY
WHERE THE SYMBOL SHOWN BELOW IS SHOWN ON THE
RIGHT-OF-WAY LINE.

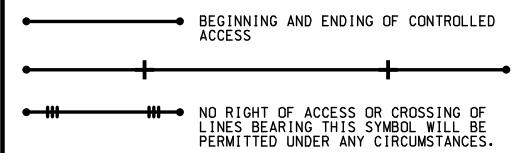

	EXISTING	NEW
BUILDINGS AND STRUCTURES		
GUARD RAIL		
GUARD CABLE		
CONCRETE RIGHT-OF-WAY MARKER		
STEEL RIGHT-OF-WAY MARKER		
LOCATION SURVEY MARKER		
UTILITIES		
FIBER OPTICS	-FO-	-FO-
OVERHEAD CABLE TV	-OTV-	-OTV-
UNDERGROUND CABLE TV	-UTV-	-UTV-
OVERHEAD TELEPHONE	-OT-	-OT-
UNDERGROUND TELEPHONE	-UT-	-UT-
OVERHEAD POWER	-OE-	-OE-
UNDERGROUND POWER	-UE-	-UE-
SANITARY SEWER	-S-	-S-
STORM SEWER	-SS-	-SS-
GAS	-G-	-G-
WATER	-W-	-W-
MANHOLE		
FIRE HYDRANT		
WATER VALVE		
WATER METER		
DROP INLET		
DITCH BLOCK		
GROUND MOUNTED SIGN		
LIGHT POLE		
H-FRAME POWER POLE		
TELEPHONE PEDESTAL		
FENCE		
CHAIN LINK		
WOVEN WIRE		
GATE POST		
BENCHMARK		

NOTE: DASHED OR OPEN SYMBOLS INDICATE
EXISTING FEATURES


SHOWING LOCATION
OF GREENE COUNTY

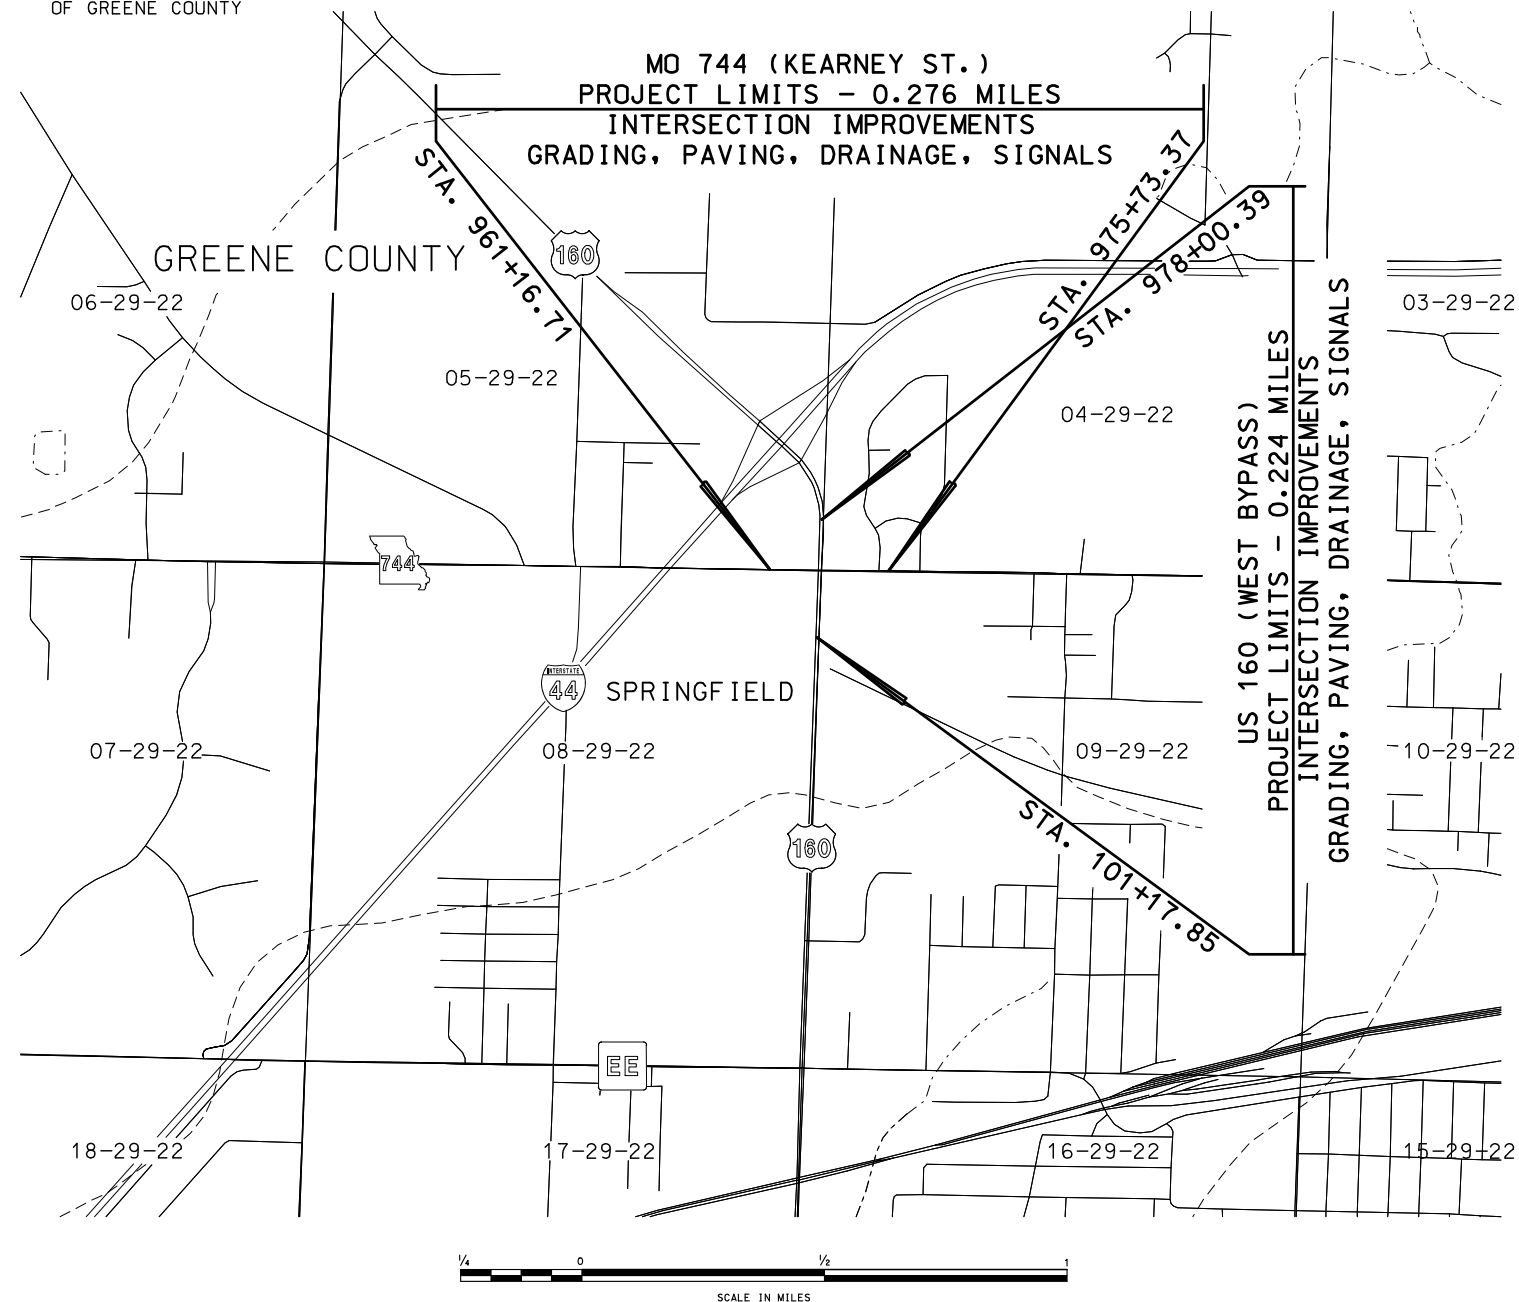

THE EXISTENCE AND APPROXIMATE LOCATION OF UTILITY FACILITIES KNOWN TO EXIST, AS SHOWN ON THE PLANS, ARE BASED ON THE BEST INFORMATION AVAILABLE TO THE COMMISSION AT THIS TIME. THIS INFORMATION IS PROVIDED BY THE COMMISSION "AS-IS" AND THE COMMISSION EXPRESSLY DISCLAIMS ANY REPRESENTATION OR WARRANTY AS TO THE COMPLETENESS, ACCURACY, OR SUITABILITY OF THE INFORMATION FOR ANY USE. RELIANCE UPON THIS INFORMATION IS DONE AT THE RISK AND PERIL OF THE USER, AND THE COMMISSION SHALL NOT BE LIABLE FOR ANY DAMAGES THAT MAY ARISE FROM ANY ERROR IN THE INFORMATION. IT IS, THEREFORE, THE RESPONSIBILITY OF THE CONTRACTOR TO VERIFY THE EXISTENCE, LOCATION AND STATUS OF ANY FACILITY. SUCH VERIFICATION INCLUDES DIRECT CONTACT WITH THE LISTED UTILITIES.

DESCRIPTION	NUMBER
TITLE SHEET -----	1
TYPICAL SECTIONS (TS) (14 SHEETS)---	2
QUANTITIES (QU) (8 SHEETS)-----	3
PLAN-PROFILE (PP)-----	4-11
RIGHT OF WAY (RW)-----	12-15
COORDINATE POINTS (CP)-----	16-17
SPECIAL SHEETS (SS)-----	18-22
TRAFFIC CONTROL SHEETS (TC)-----	23-32
EROSION CONTROL SHEETS (EC)-----	33-37
SIGNALS (SG)-----	38-45
SIGNING (SN)-----	46-54
PAVEMENT MARKING (PM)-----	55-59
CULVERT SECTIONS (CS)-----	60-62
DITCH PROFILES -----	63
UTILITY PLANS (CU)-----	CU-1
CROSS SECTIONS (XS)-----	1-49


<u>MO 744</u>		
BEGINNING OF PROJECT	STA. 961+16.71	
END OF PROJECT	STA. 975+73.37	
APPARENT LENGTH	1456.66	FEET
	0.276	MILES
EQUATIONS AND EXCEPTIONS:	NONE	
<u>US 160 (NORTH LEG)</u>		
BEGINNING OF PROJECT	STA. 978+00.39	
END OF PROJECT	STA. 984+39.07	
APPARENT LENGTH	638.68	FEET
	0.121	MILES
EQUATIONS AND EXCEPTIONS:	NONE	
<u>US 160 (SOUTH LEG)</u>		
BEGINNING OF PROJECT	STA. 101+17.85	
END OF PROJECT	STA. 813+13.20	
APPARENT LENGTH	71195.35	FEET
	13.484	MILES
EQUATIONS AND EXCEPTIONS:		
STA. 103+97.60 BK =	70649.98	FEET
STA. 810+47.58 AH		
TOTAL CORRECTIONS	70649.98	FEET
NET LENGTH OF PROJECT	2640.71	FEET
STATE LENGTH	0.500	MILES
FOR INFORMATION ONLY		
ESTIMATED DISTURBED ACRES	1.590	ACRES

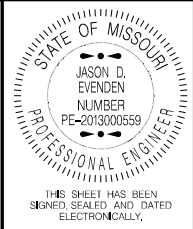

DATE PREPARED	
9/23/2021	
ROUTE	STATE
744/160	MO
DISTRICT	SHEET NO.
SW	1
COUNTY	
GREENE	
JOB NO.	
J8P3087D	
CONTRACT ID.	
PROJECT NO.	
BRIDGE NO.	


[illegible]


MISSOURI HIGHWAYS AND TRANSPORTATION COMMISSION
 105 WEST CAPITOL
 JEFFERSON CITY, MO 65102
 1-888-ASK-MDOT (1-888-275-6636)

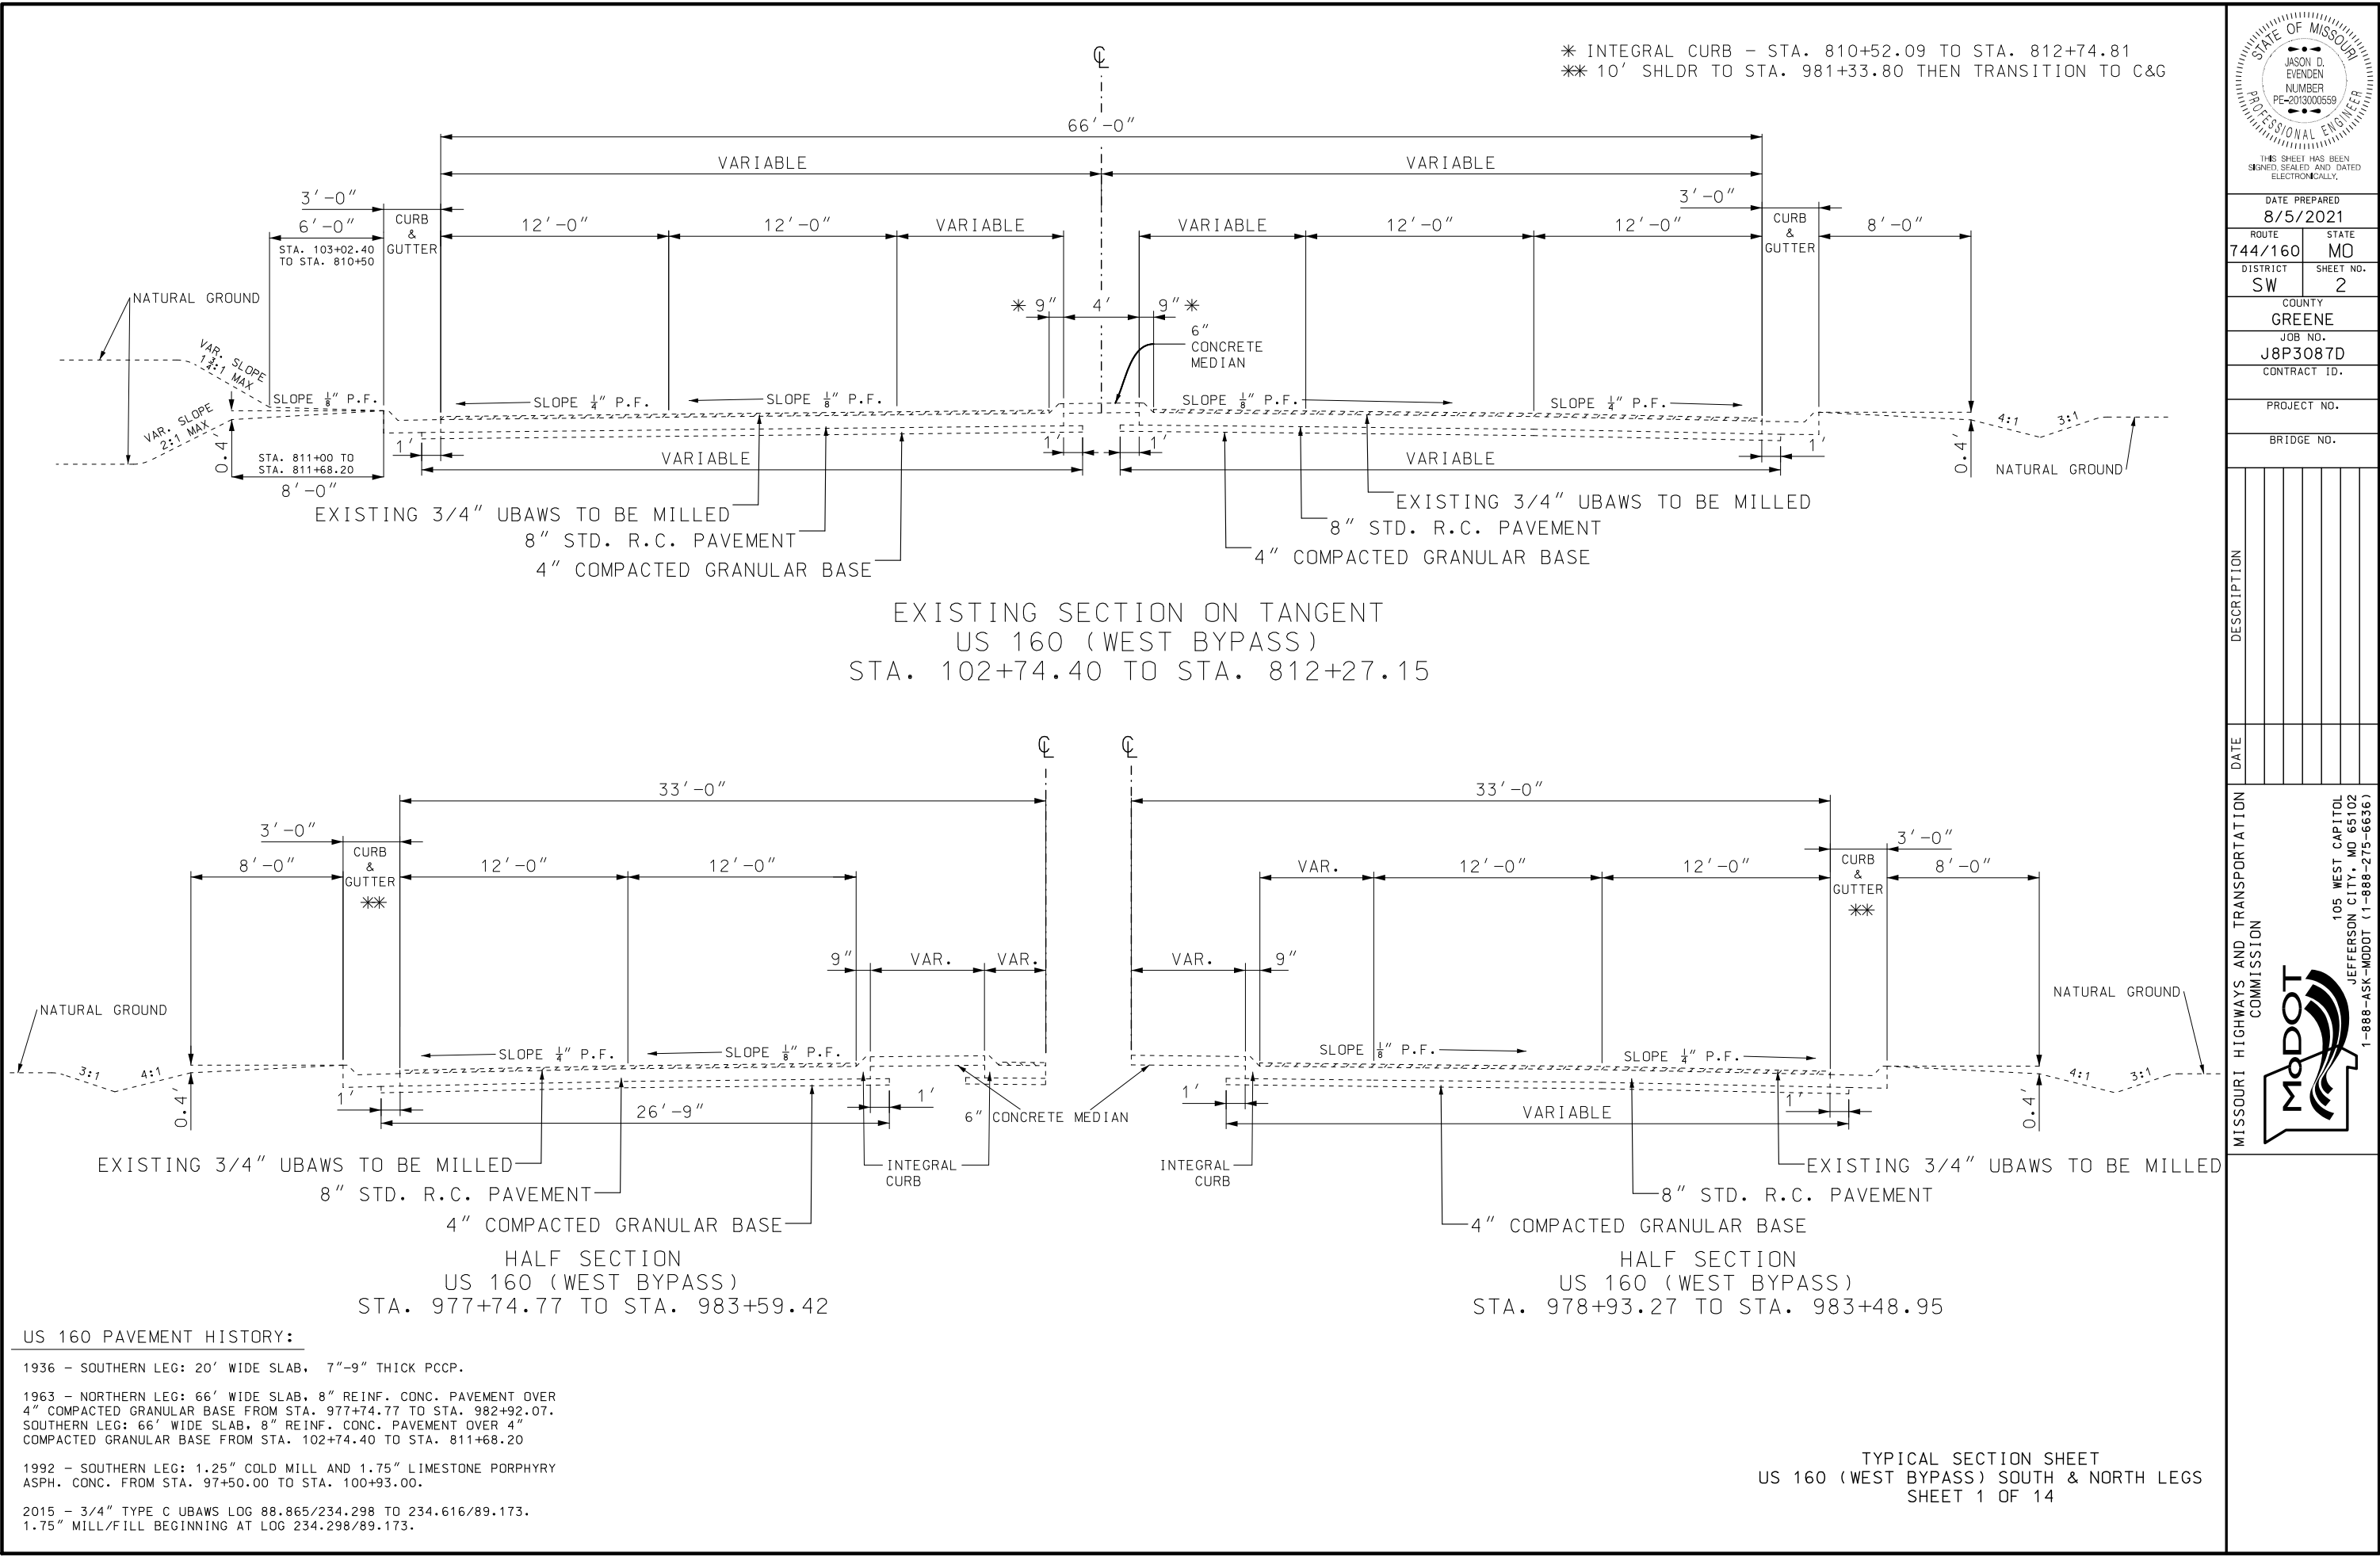

* INTEGRAL CURB - STA. 810+52.09 TO STA. 812+74.81
** 10' SHLDR TO STA. 981+33.80 THEN TRANSITION TO C&G

EXISTING SECTION ON TANGENT
US 160 (WEST BYPASS)
STA. 102+74.40 TO STA. 812+27.15

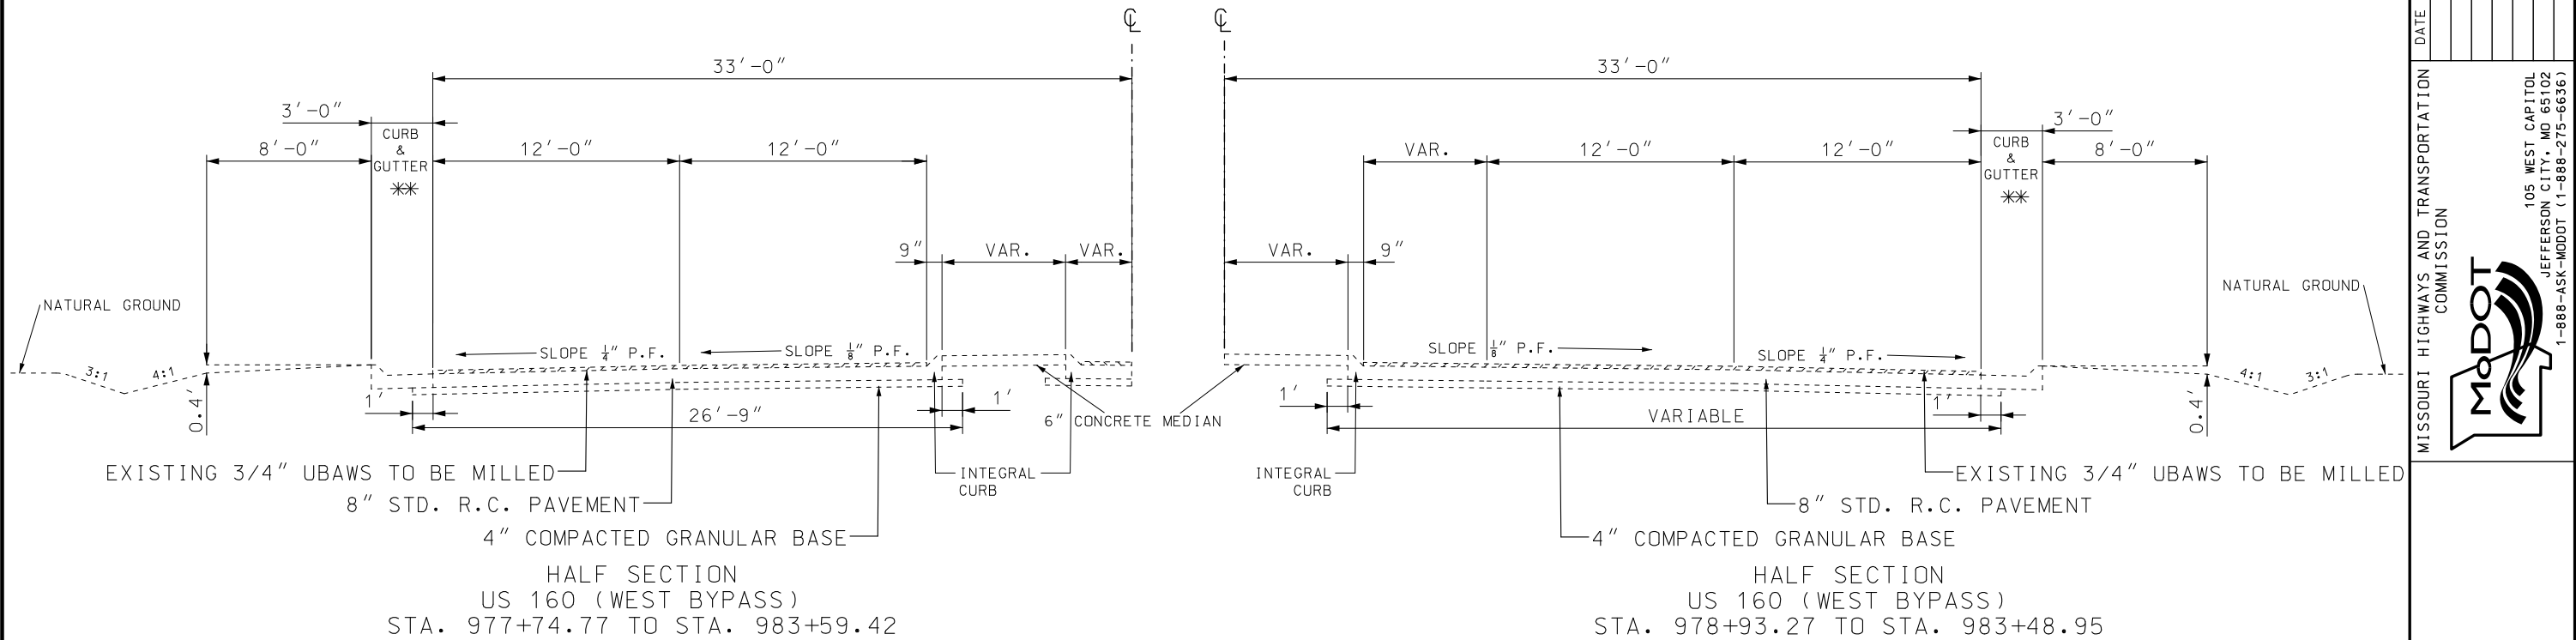

US 160 PAVEMENT HISTORY:

1936 - SOUTHERN LEG: 20' WIDE SLAB, 7"-9" THICK PCCP.

1963 - NORTHERN LEG: 66' WIDE SLAB, 8" REINF. CONC. PAVEMENT OVER 4" COMPACTED GRANULAR BASE FROM STA. 977+74.77 TO STA. 982+92.07.
SOUTHERN LEG: 66' WIDE SLAB, 8" REINF. CONC. PAVEMENT OVER 4" COMPACTED GRANULAR BASE FROM STA. 102+74.40 TO STA. 811+68.20

1992 - SOUTHERN LEG: 1.25" COLD MILL AND 1.75" LIMESTONE PORPHYRY ASPH. CONC. FROM STA. 97+50.00 TO STA. 100+93.00.

2015 - 3/4" TYPE C UBAWS LOG 88.865/234.298 TO 234.616/89.173.
1.75" MILL/FILL BEGINNING AT LOG 234.298/89.173.

TYPICAL SECTION SHEET
US 160 (WEST BYPASS) SOUTH & NORTH LEGS
SHEET 1 OF 14

STATE OF MISSOURI

JASON D. EVENDEN

NUMBER

PE-2013000659

PROFESSIONAL ENGINEER

THIS SHEET HAS BEEN
SIGNED, SEALED AND DATED
ELECTRONICALLY.

DATE PREPARED

8/5/2021

ROUTE

744/160

STATE

MO

DISTRICT

SW

SHEET NO.

2

COUNTY

GREENE

JOB NO.

J8P3087D

CONTRACT ID.

PROJECT NO.

BRIDGE NO.

DESCRIPTION

DATE


MISSOURI HIGHWAYS AND TRANSPORTATION
COMMISSION

105 WEST CAPITOL

JEFFERSON CITY, MO 65102


1-888-ASK-MODOT (1-888-275-6636)

IF A SEAL IS PRESENT ON THIS SHEET IT HAS BEEN ELECTRONICALLY SEALED AND DATED.

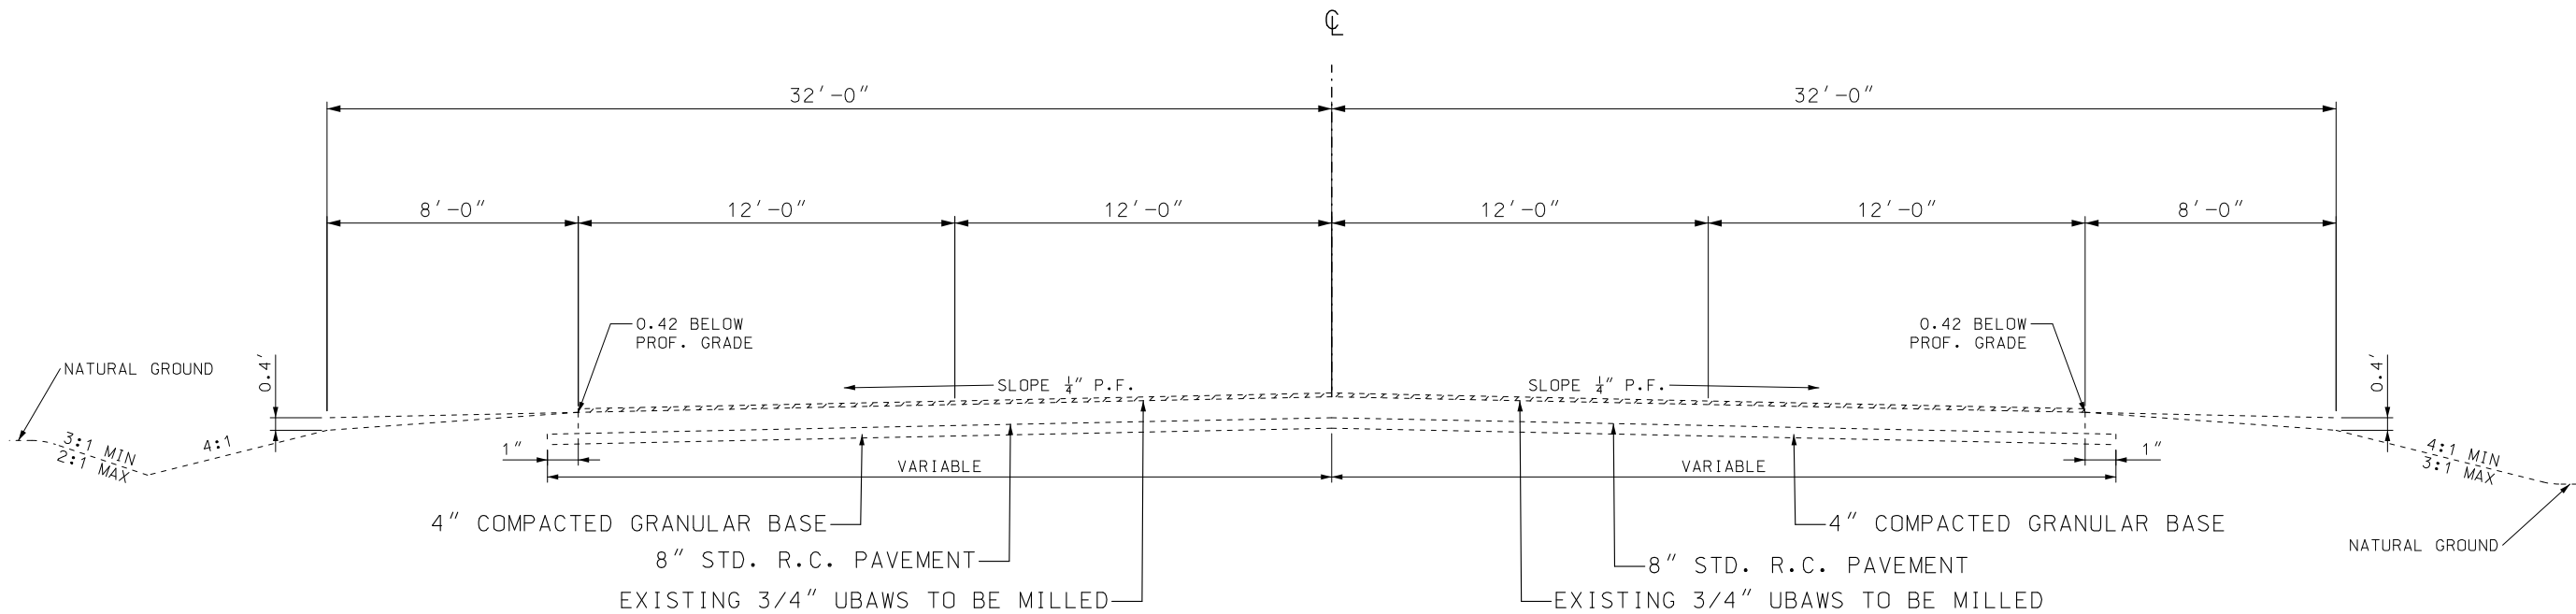

EXISTING SECTION ON TANGENT
MO 744 (KEARNEY ST.)
STA. 961+16.71 TO STA. 961+70.83

* CONCRETE MEDIAN STRIP TRANSITIONS
FROM 14' TO 4' FOR LEFT TURN LANE

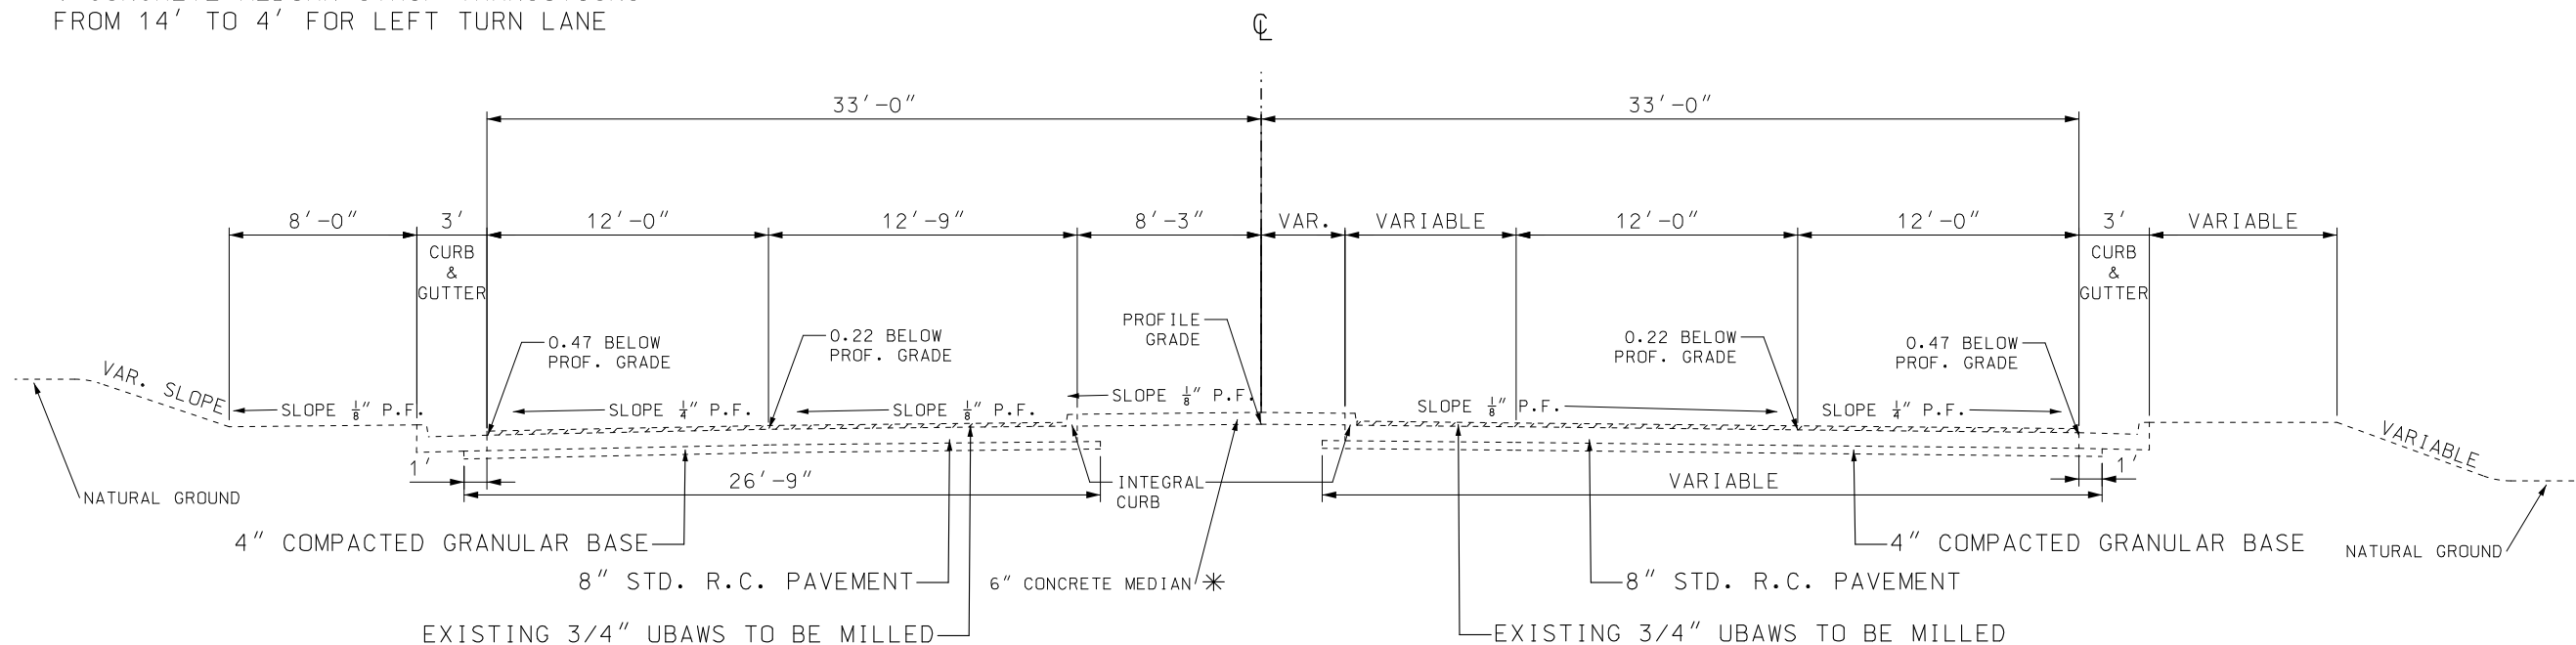


EXISTING SECTION ON TANGENT
MO 744 (KEARNEY ST.)
STA. 963+15.60 TO STA. 966+19.70

MO 744 PAVEMENT HISTORY:

- 1932 - 20' WIDE SLAB, 7"-9" THICK PCCP.
- 1963 - FOUR 12' LANES & VAR. WIDTH TURN LANE OF 8" REINFORCED CONCRETE ON 4" COMPACTED GRANULAR BASE SEPARATED BY VAR. WIDTH CONCRETE MEDIAN. 3' STD. C&G.
- 1990 - WIDEN 2'-16.4' (BOTH LANES) 10" REINFORCED CONCRETE ON 4" TYPE 1 OR 2 BASE AT STA. 971+90 TO STA. 974+88. PLUS 3' TYPE A C&G AND 5' BORDER OF 2" TYPE C ASHP. CONC. OVER 4" TYPE 1 OR 2 AGG.
- 2009 - 1 & 3/4" SP125C OVERLAY, SHOULDERS OVERLAID W/ BP-1. DIAMOND GRINDING ON EXISTING CONCRETE PAVEMENT.
- 2015 - 3/4" TYPE C UBAWS LOG 1.663 TO 1.910

TYPICAL SECTION SHEET
MO 744 (KEARNEY ST.) WEST LEG
SHEET 2 OF 14

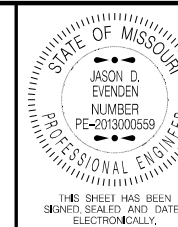


DATE PREPARED 8/5/2021	
ROUTE 744/160	STATE MO
DISTRICT SW	SHEET NO. 2
COUNTY GREENE	
JOB NO. J8P3087D	
CONTRACT ID.	
PROJECT NO.	
BRIDGE NO.	

DATE	DESCRIPTION



 IF A SEAL IS PRESENT ON THIS SHEET IT HAS BEEN ELECTRONICALLY SEALED AND DATED.



8/5/2021	
ROUTE	STATE

DISTRICT	SHEET NO.
SW	2

GREENE

CONTRACT ID.

--	--

--	--	--	--	--	--	--

DATE	DESCRIPTION

PTIC

EST


TRA
N

AN
ISS
L
FFF



ISS


[illegible]

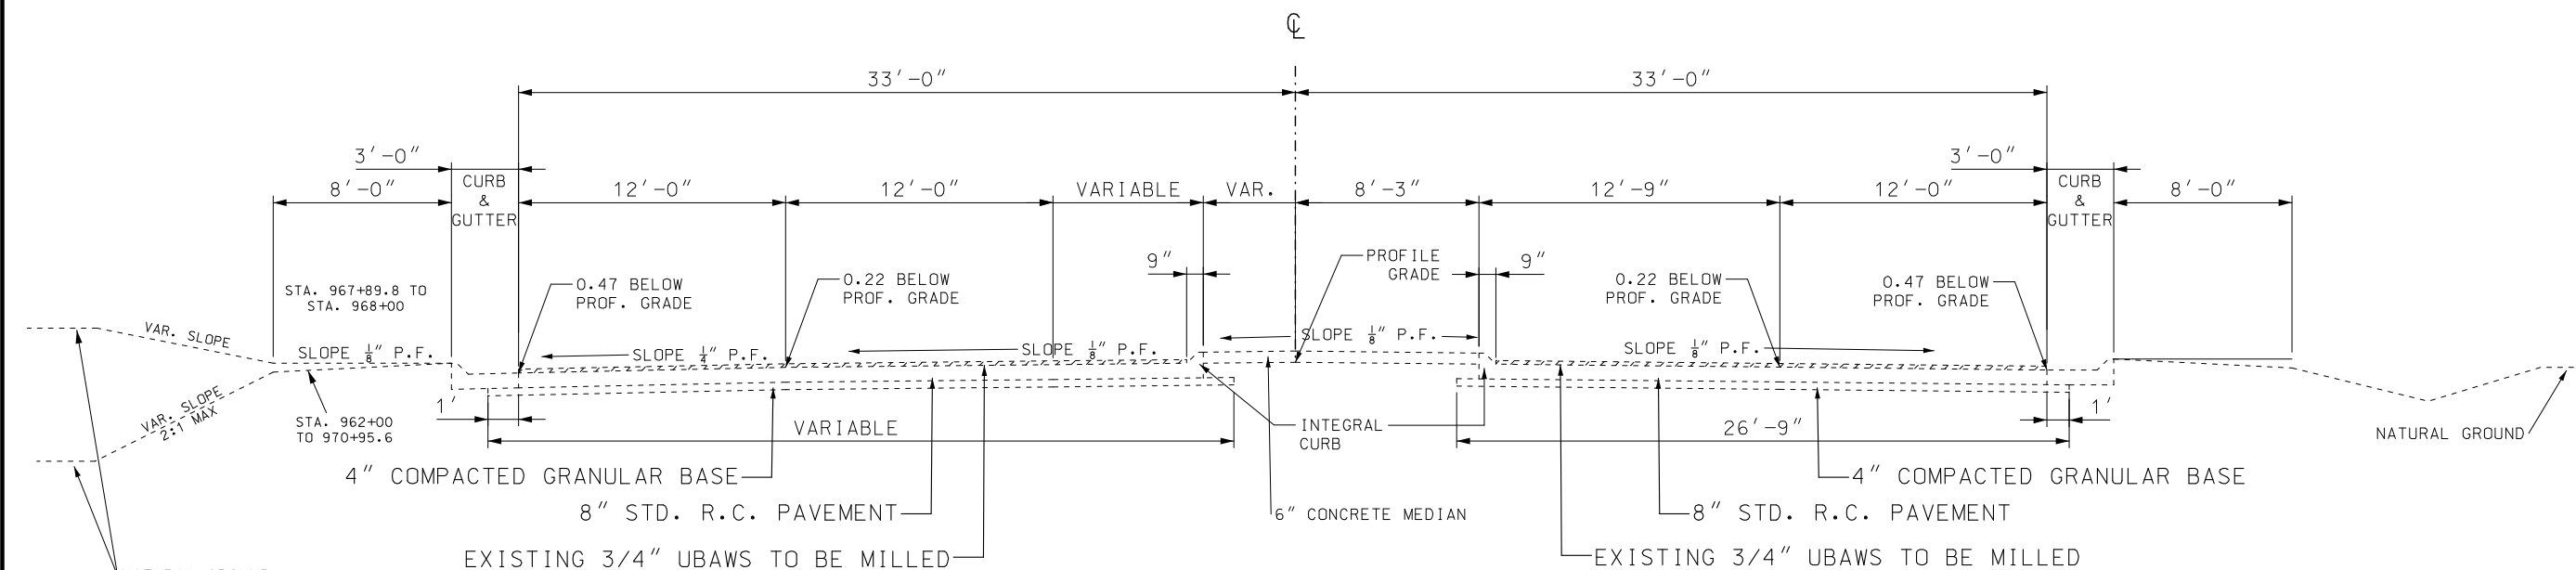

EXISTING SECTION ON TANGENT
MO 744 (KEARNEY ST.)
STA. 967+89.50 TO STA. 970+93.60

TYPICAL SECTION SHEET
MO 744 (KEARNEY ST.) EAST LEG
SHEET 3 OF 14

[illegible]

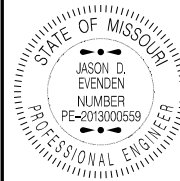


DATE PREPARED 8/5/2021	
ROUTE 744/160	STATE MO
DISTRICT SW	SHEET NO. 2
COUNTY GREENE	
JOB NO. J8P3087D	
CONTRACT ID.	
PROJECT NO.	
BRIDGE NO.	

DESCRIPTION	DATE


MISSOURI HIGHWAYS AND TRANSPORTATION COMMISSION

MoDOT

105 WEST CAPITOL
JEFFERSON CITY, MO 65102
1-888-ASK-MODOT (1-888-275-6636)

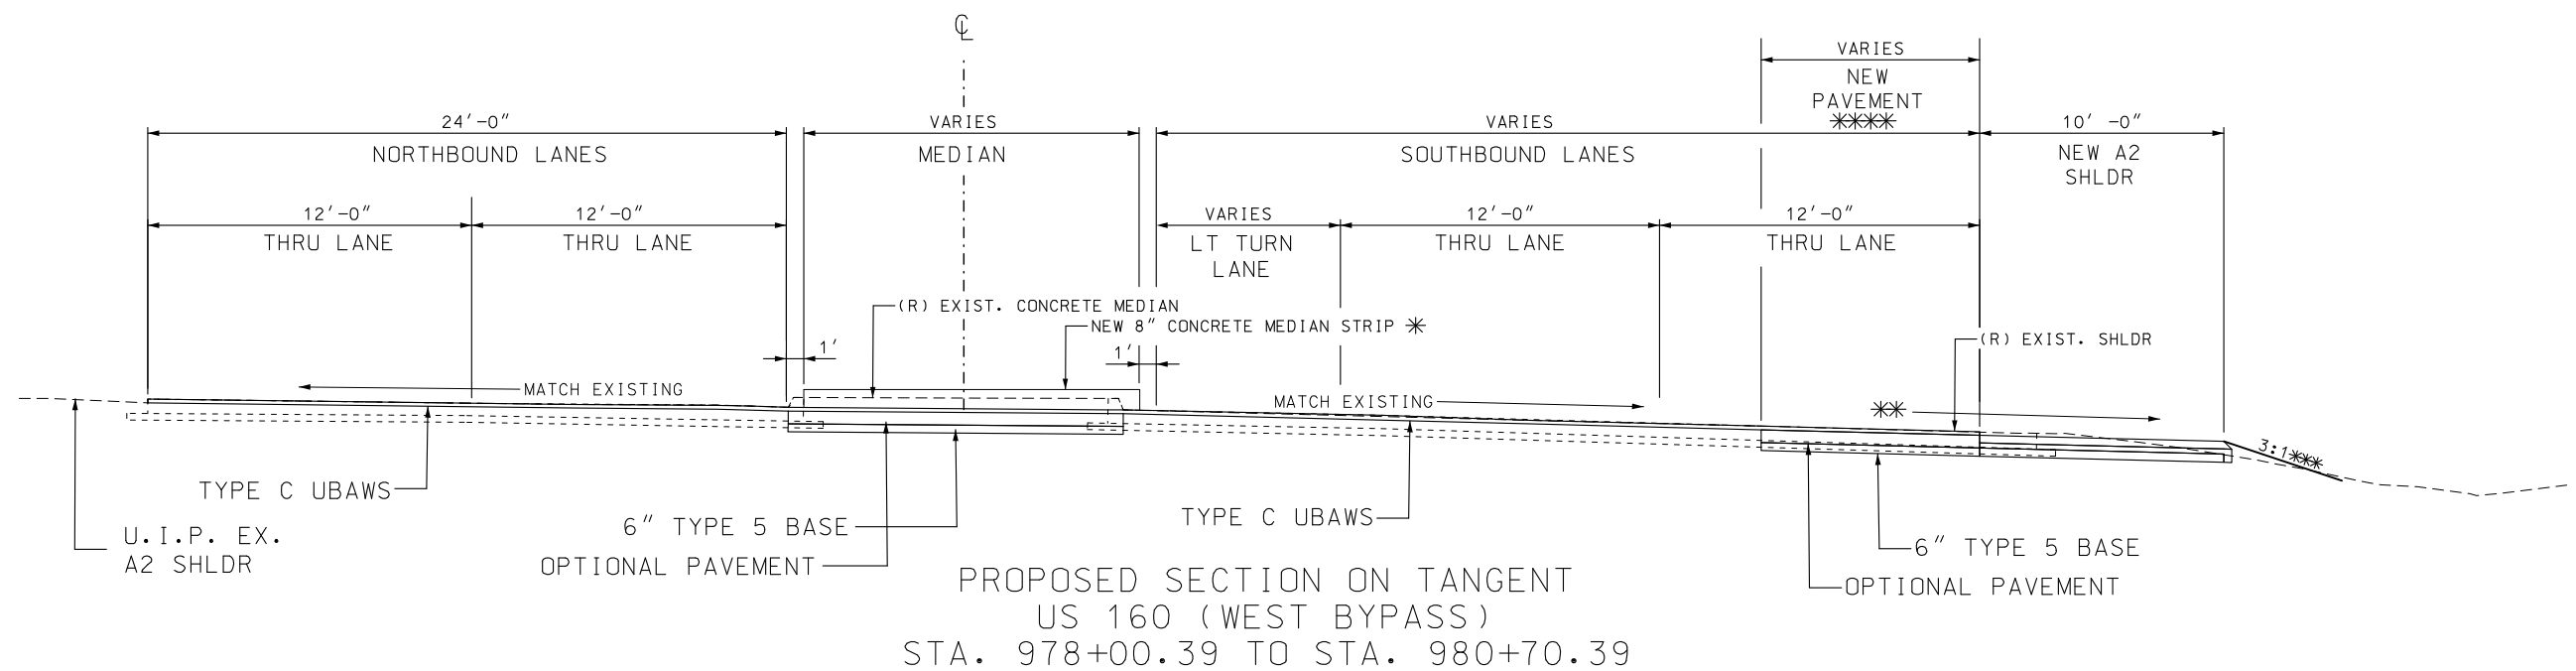

PROPOSED SECTION ON TANGENT
US 160 (WEST BYPASS)
STA. 978+00.39 TO STA. 980+70.39

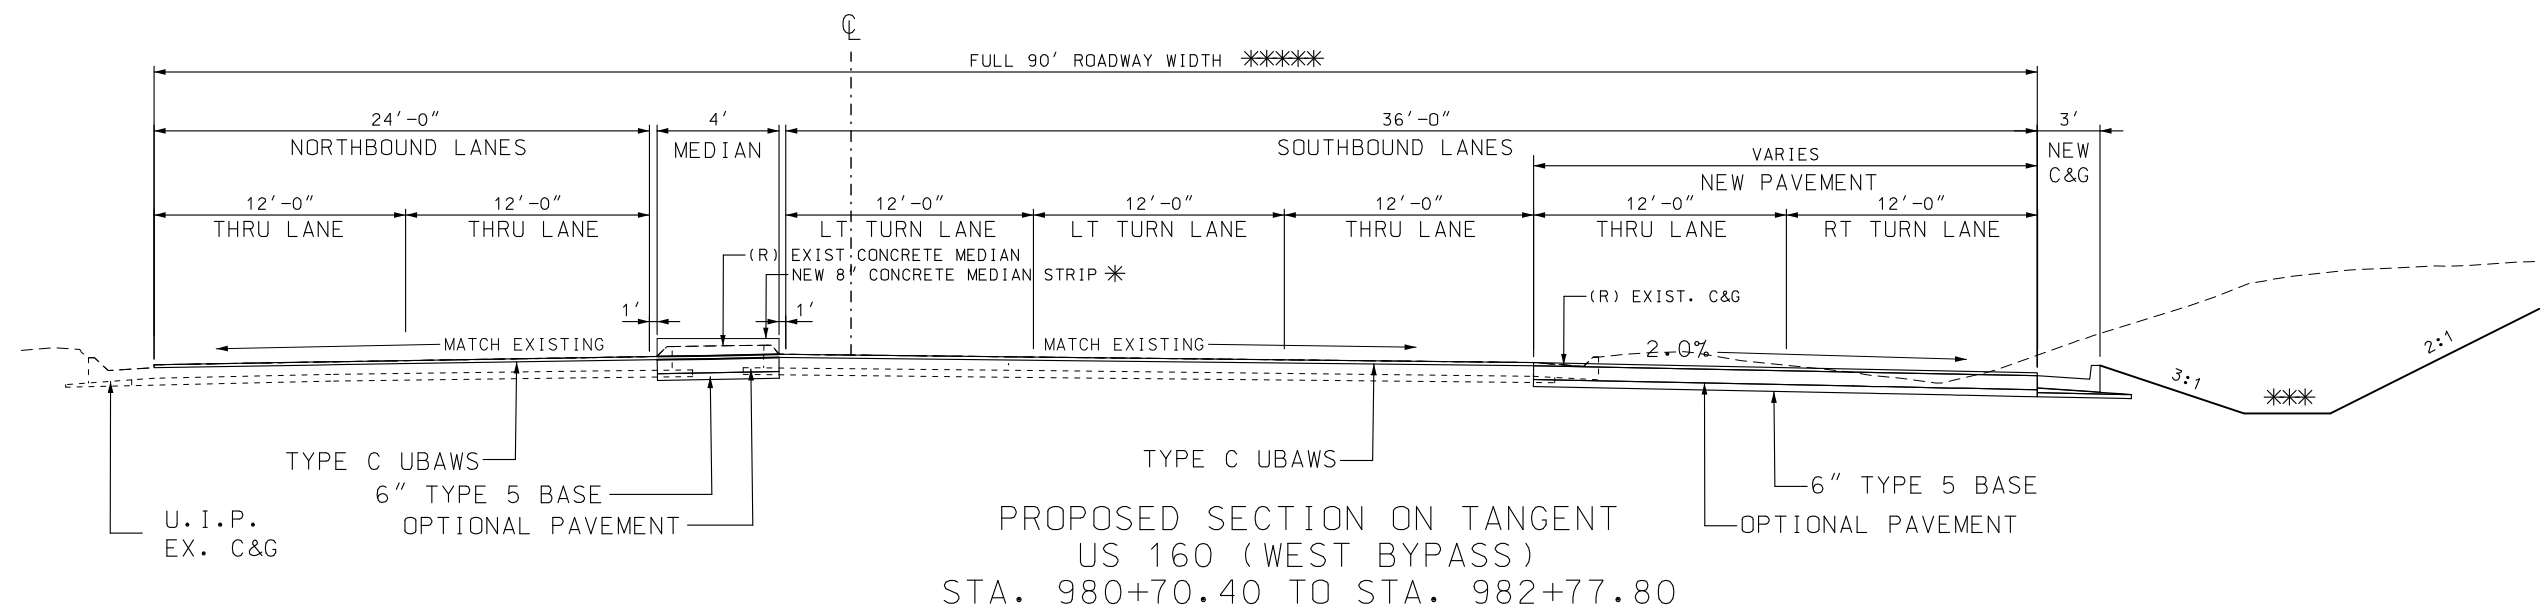


PROPOSED SECTION ON TANGENT
US 160 (WEST BYPASS)
STA. 980+70.40 TO STA. 982+77.80


- NOTES:
- * TRANSITION CONCRETE MEDIAN FROM EXISTING WIDTH AT 978+00.39 TO 4' WIDE AT STA. 980+67.07. MAINTAIN 4' CONCRETE MEDIAN TO STA. 983+24.00.
 - ** MATCH ADJACENT CROSS SLOPE FROM STA. 978+00.39 TO STA. 980+70.39. THEN BEGIN 2.0% CROSS SLOPE.
 - *** SEE CROSS SECTIONS FOR 4' FLAT BOTTOM DITCH DETAILS FROM STA. 979+92.34 TO STA. 982+77.81
 - **** 2' PAVEMENT WIDTH FROM STA. 978+00.39 TO STA. 978+50.13.
 - ***** FULL 90' ROADWAY WIDTH AT STA. 981+70.39 TO STA. 982+77.80.

OPTIONAL PAVEMENT	
HMA DESIGN	PCCP DESIGN
12" HMA CONSISTING OF:	9 1/2" PCCP W/:
1 3/4" SP125C W/ PG76-22 OVER	15 FT. JOINT SPACING
3" SP250C W/ PG76-22 OVER	& 1 1/4" DOWELS
7 1/4" SP250C W/ PG 64-22	

IF A SEAL IS PRESENT ON THIS SHEET IT HAS BEEN ELECTRONICALLY SEALED AND DATED.

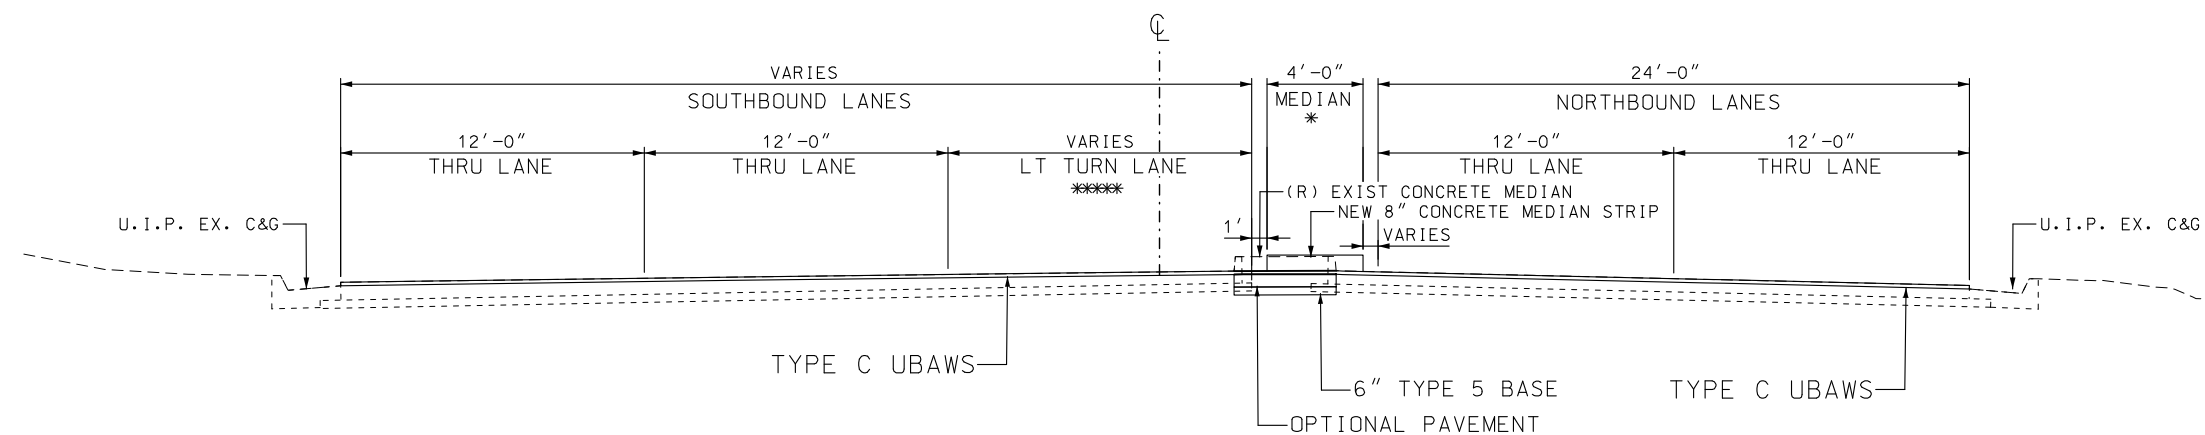

PROPOSED SECTION ON TANGENT
US 160 (WEST BYPASS)
STA. 101+17.85 TO STA. 103+32.14

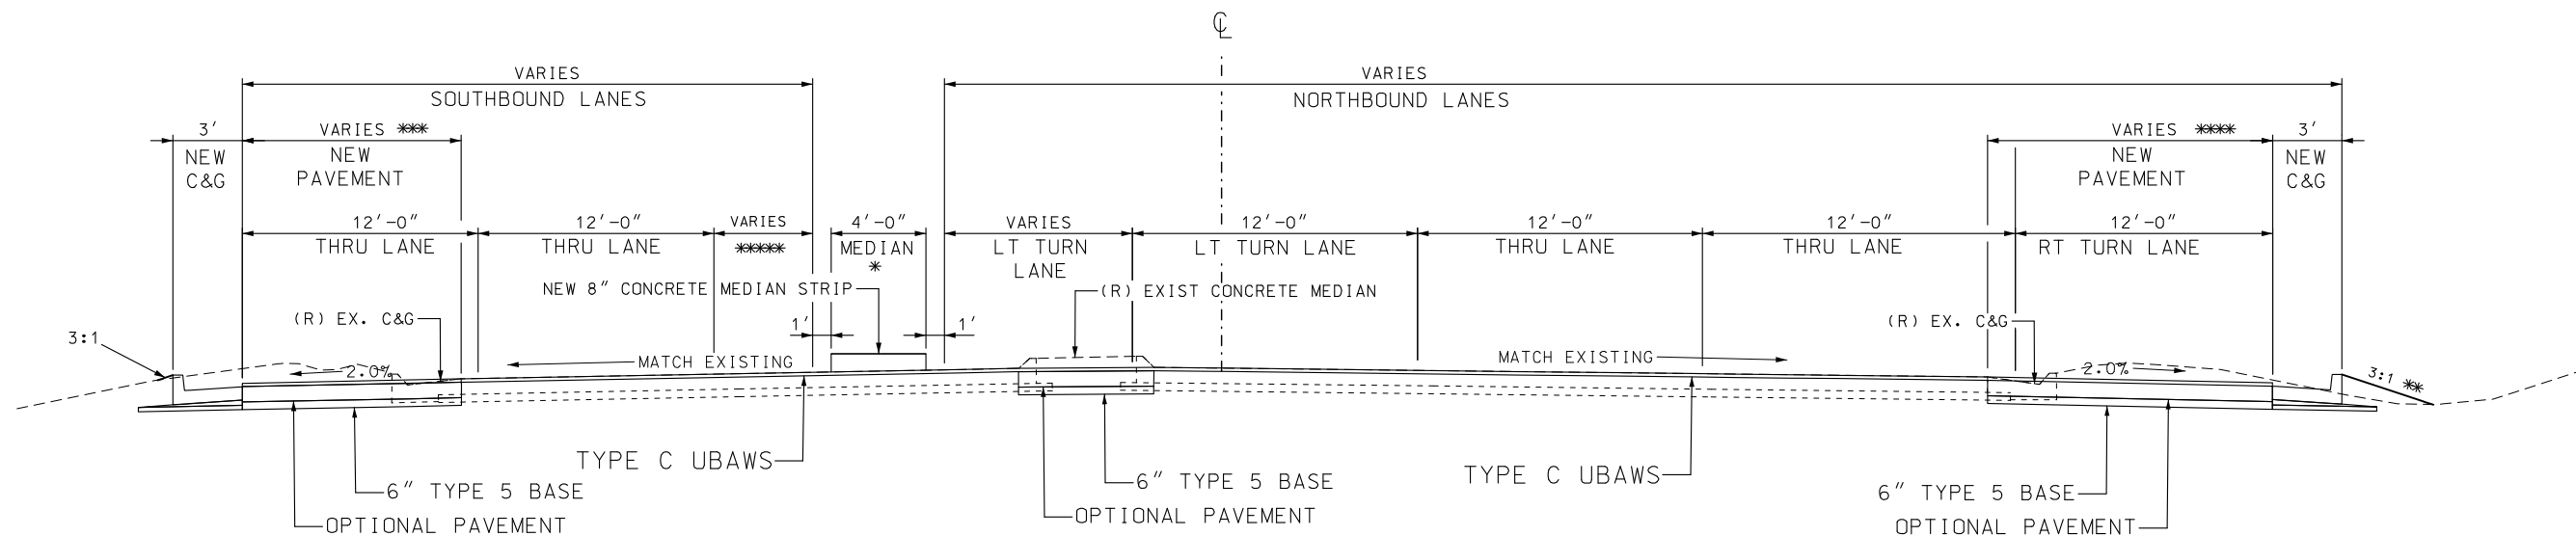

PROPOSED SECTION ON TANGENT
US 160 (WEST BYPASS)
STA. 103+32.15 TO STA. 811+59.15

NOTES:

- * 4' MEDIAN BEGINS AT STA. 101+83.55, ENDS AT STA. 812+02.45
- ** SEE CROSS SECTIONS FOR 4' FLAT BOTTOM DITCH AT STA. 810+70.40 TO STA. 811+59.18
- *** 2' PAVEMENT WIDTH FROM STA. 103+32.15 TO STA. 103+61.67.
- *** 2' PAVEMENT WIDTH FROM STA. 103+32.15 TO STA. 103+47.90.
- **** 12' SB LT TURN LANE INTO GAS STATION FROM STA. 101+81.88 TO STA. 103+03.72. TRANSITION FROM FULL WIDTH LT TURN LANE AT STA. 103+03.72 TO STA. 811+51.98.

TYPICAL SECTION SHEET
US 160 (WEST BYPASS) SOUTH LEG
SHEET 5 OF 14





DATE PREPARED
8/5/2021
ROUTE
744/160
STATE
MO
DISTRICT
SW
SHEET NO.
2
COUNTY
GREENE
JOB NO.
J8P3087D
CONTRACT ID.

PROJECT NO.
BRIDGE NO.


DATE	DESCRIPTION

MISSOURI HIGHWAYS AND TRANSPORTATION
COMMISSION
105 WEST CAPITOL
JEFFERSON CITY, MO 65102
1-888-ASK-MODOT (1-888-275-6636)

IF A SEAL IS PRESENT ON THIS SHEET IT HAS BEEN ELECTRONICALLY SEALED AND DATED.

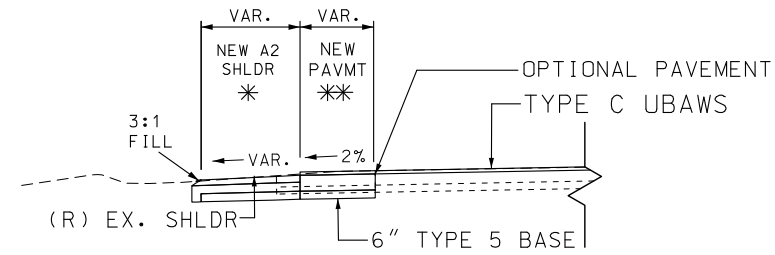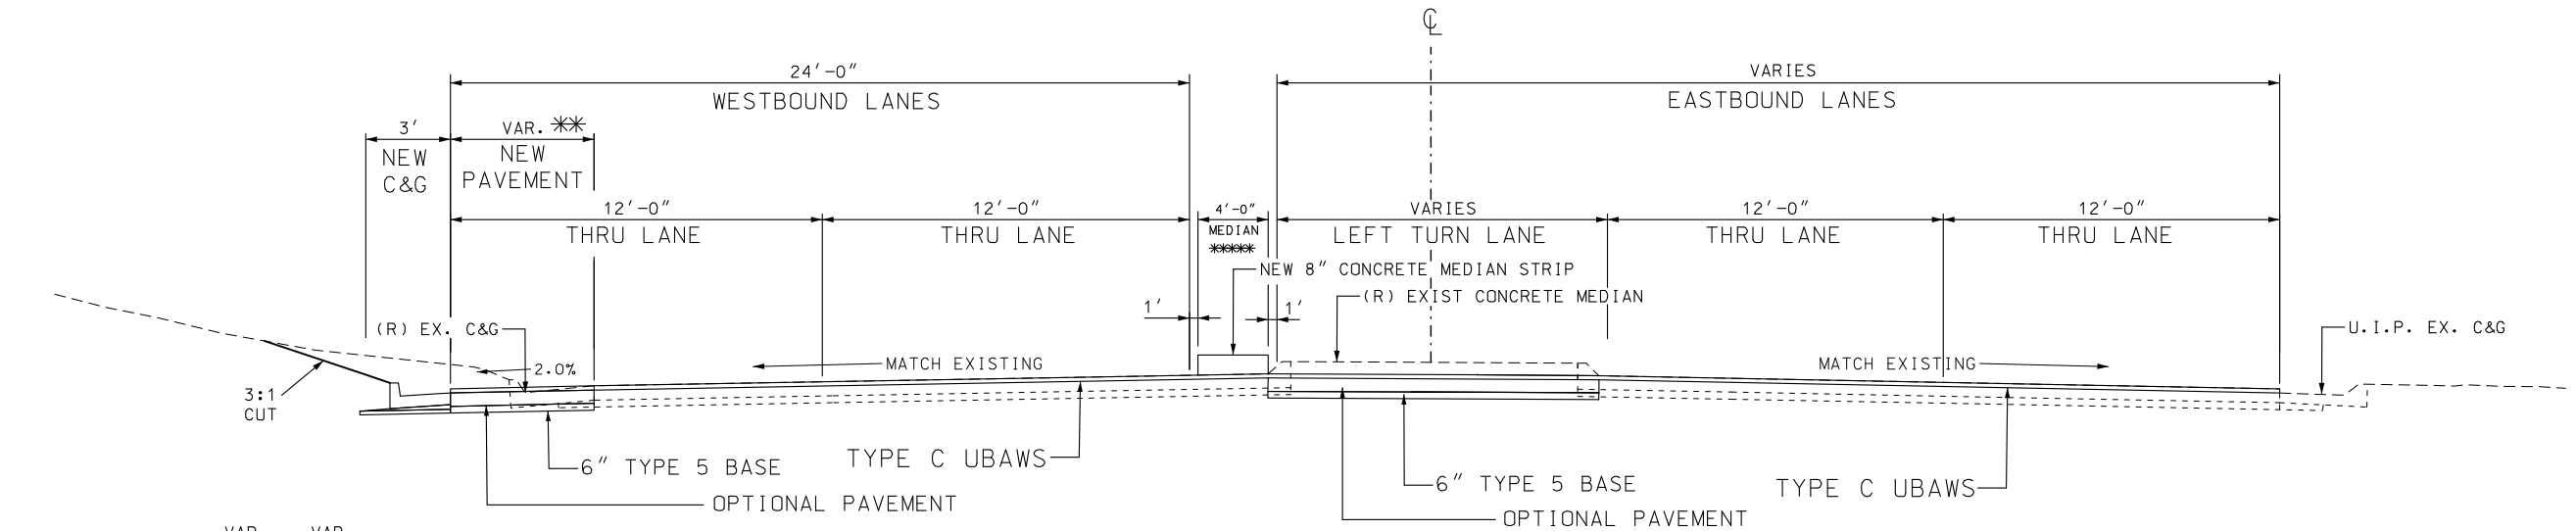

WESTBOUND SHOULDER TIE-IN
MO 744 (KEARNEY ST.)
STA. 961+16.71 TO STA. 961+71.17

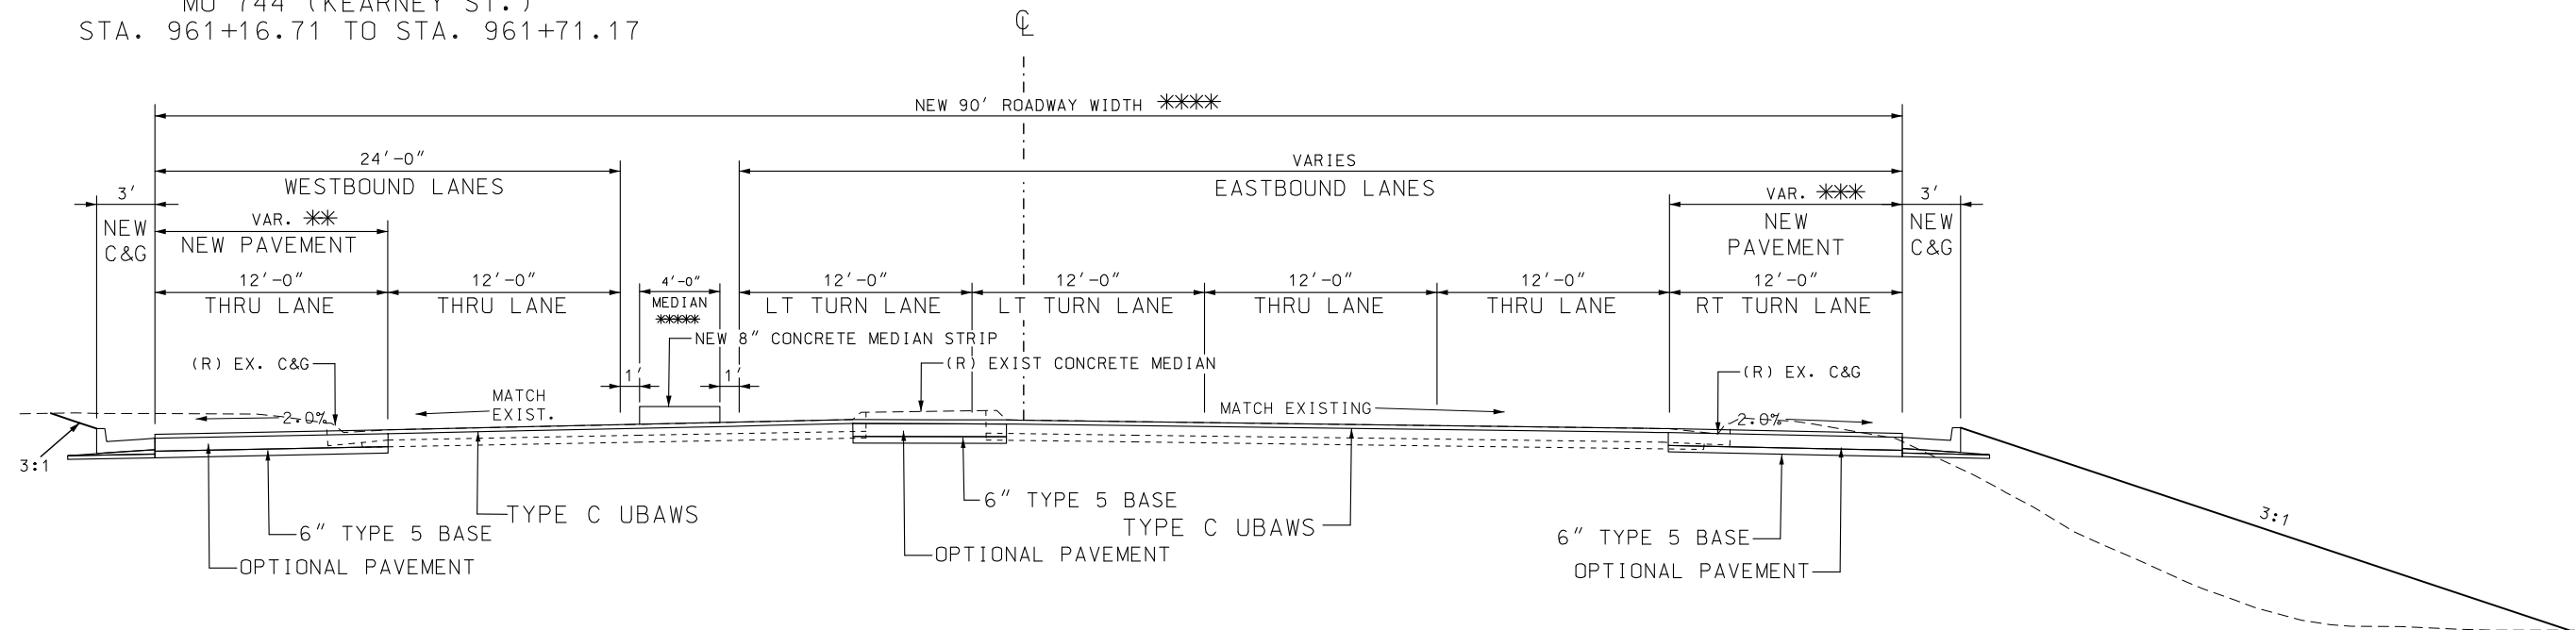


NOTES:

- * TRANSITION SHOULDER FROM EXIST. WIDTH AT STA. 961+16.71 TO 2.0' AT STA. 961+71.17.
- ** 2' PAVEMENT WIDTH FROM STA. 961+16.71 TO STA. 961+52.11. WIDEN TO 12' AT STA. 963+86.71.
- *** 2' PAVEMENT WIDTH FROM STA. 963+19.62 TO STA. 963+36.83. WIDEN TO 12' AT STA. 964+19.62.
- **** FULL NEW 90' ROADWAY WIDTH AT STA. 964+19.62 TO STA. 965+27.78.
- ***** 4' MEDIAN TO BE CONSTRUCTED FROM STA. 961+88.22 TO STA. 965+75.10.


PROPOSED SECTION ON TANGENT
MO 744 (KEARNEY ST.)
STA. 963+19.63 TO STA. 965+78.96

TYPICAL SECTION SHEET
MO 744 (KEARNEY ST.) WEST LEG
SHEET 6 OF 14

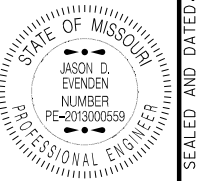


DATE PREPARED 8/5/2021	
ROUTE 744/160	STATE MO
DISTRICT SW	SHEET NO. 2
COUNTY GREENE	
JOB NO. J8P3087D	
CONTRACT ID.	
PROJECT NO.	
BRIDGE NO.	


DATE	DESCRIPTION

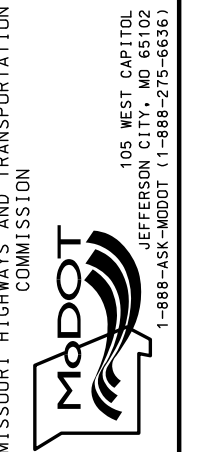


IF A SEAL IS PRESENT ON THIS SHEET IT HAS BEEN ELECTRONICALLY SEALED AND DATED.

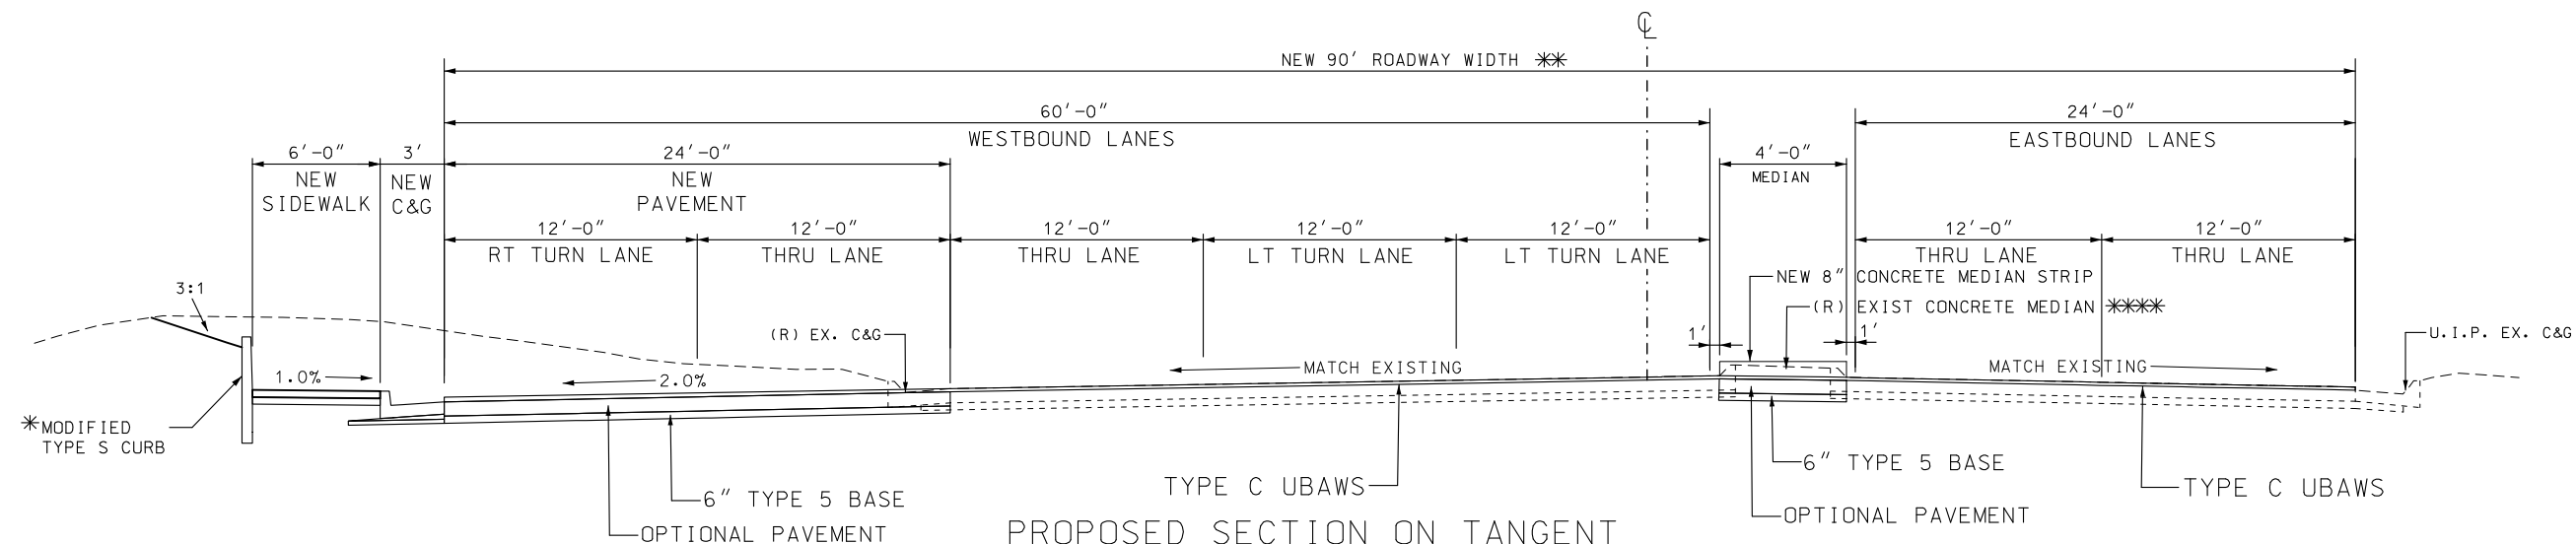

PROPOSED SECTION ON TANGENT
MO 744 (KEARNEY ST.)
STA. 968+35.78 TO STA. 969+40.00

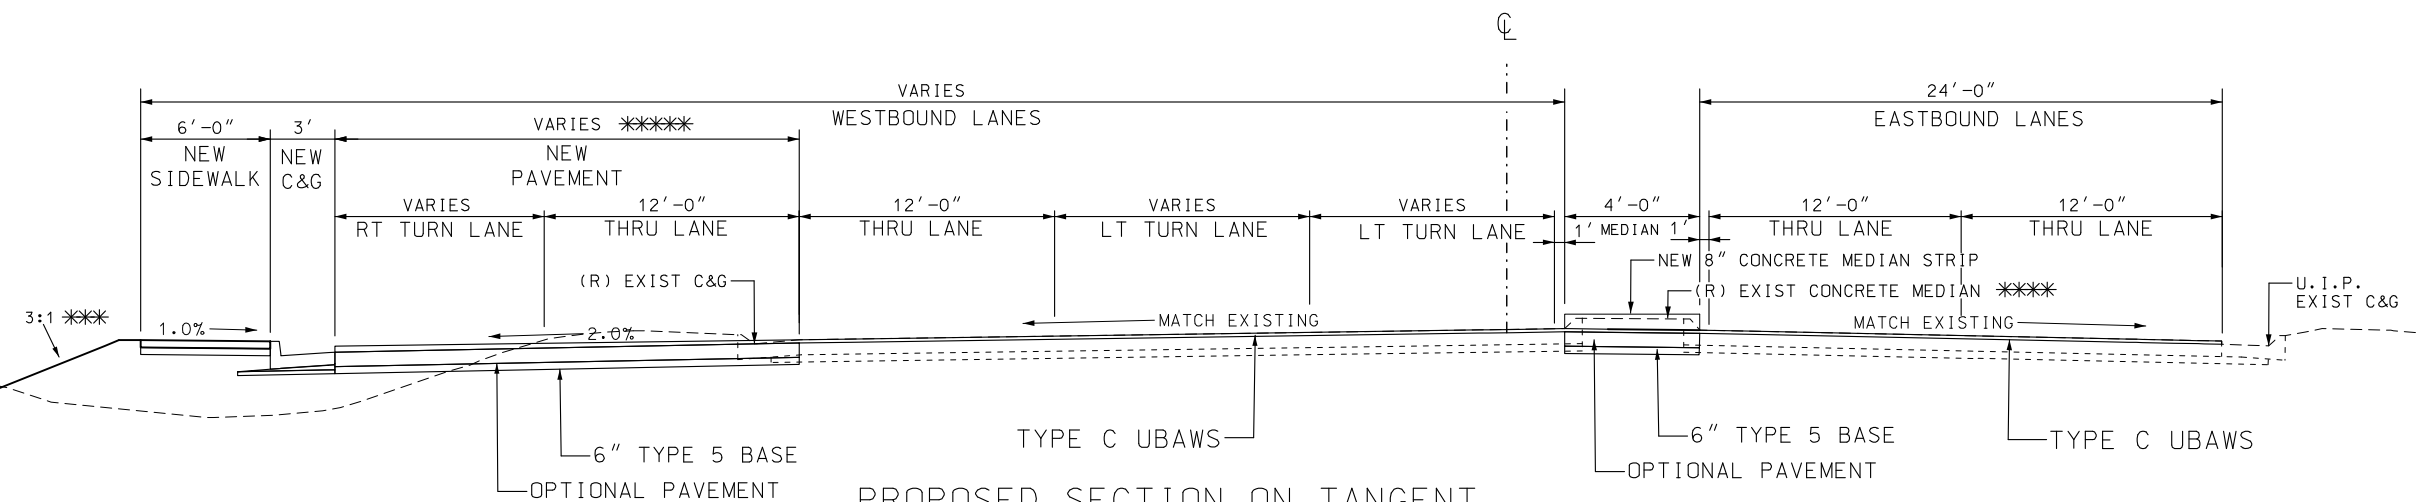

PROPOSED SECTION ON TANGENT
MO 744 (KEARNEY ST.)
STA. 969+40.01 TO STA. 972+45.57

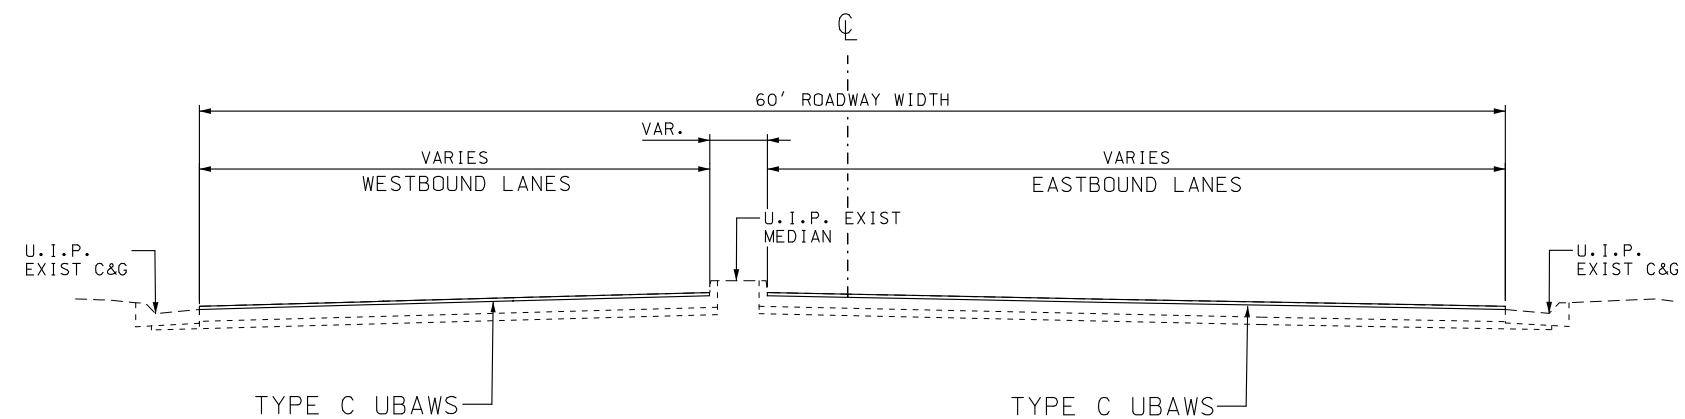

PROPOSED SECTION ON TANGENT
MO 744 (KEARNEY ST.)
STA. 972+45.58 TO STA. 974+87.72

NOTES:

* TRANSITION MODIFIED S CURB HEIGHT FROM 2.5' TALL AT STA. 968+70.00 TO 0' TALL AT STA. 969+40.00. TRANSITION S CURB DEPTH FROM 2.5' DEEP AT STA. 968+70.00 TO 1.5' DEEP AT STA. 969+12.00. MAINTAIN CURB DEPTH OF 1.5' TO STA. 969+40.00. SEE TYPICAL SECTION SHEET #14 FOR DETAILS.


** FULL 90' ROADWAY WIDTH AT STA. 968+35.78 TO STA. 970+40.85.

*** TRANSITION SLOPE FROM 3:1 AT STA. 971+30.00 TO 2:1 AT STA. 971+40.00. TRANSITION SLOPE BACK TO 3:1 FROM STA. 971+65.00 TO STA. 971+75.00.

**** EXISTING CONCRETE MEDIAN TO BE REMOVED FROM STA. 967+42.69 TO STA. 971+00.00. LEAVE REMAINING MEDIAN IN PLACE.


***** 2' PAVEMENT WIDTH FROM STA. 972+25.24 TO STA. 972+45.57.

TYPICAL SECTION SHEET
MO 744 (KEARNEY ST.) EAST LEG
SHEET 7 OF 14

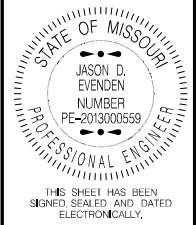







DATE PREPARED 9/23/2021	
ROUTE 744/160	STATE MO
DISTRICT SW	SHEET NO. 2
COUNTY GREENE	
JOB NO. J8P3087D	
CONTRACT ID.	
PROJECT NO.	
BRIDGE NO.	

DESCRIPTION	DATE

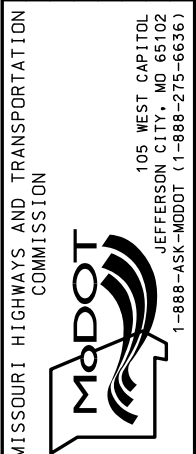

IF A SEAL IS PRESENT ON THIS SHEET IT HAS BEEN ELECTRONICALLY SEALED AND DATED.

1. CONCRETE SIDEWALK, CURB RAMP AND DETECTABLE WARNING DEVICE (TRUNCATED DOMES) DETAILS SHALL CONFORM TO ADA REQUIREMENTS UNLESS NOTED OTHERWISE IN THESE PLANS. FOR SIDEWALK JOINT AND CURB DETAILS, SEE STANDARD PLAN 609.00.
2. TINTED CONCRETE SHALL NOT BE USED. TRUNCATED DOMES SHALL BE OF A COLOR CONTRASTING WITH UNTINTED CONCRETE AND APPROVED BY THE ENGINEER. TRUNCATED DOMES ARE REQ'D. AT STREET INTERSECTIONS AND COMMERCIAL ENTRANCES WITH TRAFFIC CONTROL ONLY. (STOP/YIELD SIGNS OR SIGNALS)
3. CONCRETE SHALL BE IN ACCORDANCE WITH SEC. 608 & SEC. 609. CURING COMPOUND SHALL BE TRANSPARENT.
4. ALL CONCRETE SIDEWALK AND CURB RAMP/TRANSITION/LANDING AREAS SHALL BE 4" THICK, WITH THE EXCEPTION OF THE BOTTOM TRANSITION WHICH TIES INTO THE EXISTING PAVED APPROACH AND ROADWAY. THIS TRANSITION, OR LANDING AREA, MUST BE 8" THICK IF IT FALLS WITHIN THE RADIUS OF THE APPROACH AND SITS AT THE BACK OF CURB OF THE ROADWAY. ALL CONCRETE SIDEWALK AND CURB RAMP/TRANSITION/LANDING AREAS SHALL BE ON 4" TYPE 1 AGGREGATE BASE.
5. AGGREGATE BASE DENSITY - CONTRACTOR SHALL EXERCISE GOOD COMPACTIVE EFFORT AS APPROVED BY THE ENGINEER. DENSITY REQUIREMENTS BY NUCLEAR METHOD WILL NOT BE REQUIRED DUE TO WORK AREA CONSTRAINTS.
6. CONCRETE CURB RAMP - WIDTH = 5' MIN. LENGTH = 5' MIN. TO 15' PREFERRED MAX. (16' MAX.)
RUNNING SLOPE = >5% (MIN.) TO 8.33% (MAX.) UNIFORMLY DOWN THE LENGTH OF THE RAMP.
- CONCRETE LANDING - WIDTH = TO MATCH PROPOSED CURB RAMP AND SIDEWALK WIDTH LENGTH = 5' MIN.
SLOPE IN ALL DIRECTIONS = 1% PREFERRED (2% MAX.) UNLESS TIED TO ROADWAY EXCEPTION.
7. ALL EXISTING UTILITIES SHALL BE USED IN PLACE UNLESS OTHERWISE NOTED. ALL MANHOLE OR VALVE COVER, ETC. ELEVATIONS SHALL BE ADJUSTED AS REQUIRED IF THEY ARE LOCATED WITHIN THE IMPROVEMENT AREA.
8. "PREFORMED FIBER JOINT" SHALL BE IN ACCORDANCE WITH SEC. 1057 FOR PREFORMED FIBER JOINT EXPANSION JOINT FILLER.
9. REINFORCING STEEL TIE BARS SHALL BE IN ACCORDANCE WITH SECTION 706. ALL REINFORCING STEEL SHALL BE EPOXY COATED AND USED AS APPROVED BY THE ENGINEER. WHERE TIE BARS ARE USED, THE CONCRETE SHALL BE 8" THICK (NO DIRECT PAY).
10. CONSTRUCTION AND LENGTH OF EACH CURB RAMP INCLUDING LANDINGS AND TRANSITION AREAS SHALL BE AS SHOWN ON THE PLANS UNLESS DIFFERING FIELD CONDITIONS ARE FOUND OR AS APPROVED BY THE ENGINEER. CURB RAMP CROSS SLOPES SHALL BE 1% PREFERRED (2% MAX.) TOWARD THE STREET. CURB RAMPS ARE TO BE FORMED UP AND HAVE A TRUE AND STRAIGHT LINE.
11. SIDEWALK AND CONCRETE CURB SHALL BE POURED MONOLITHICALLY. THE CONTRACTOR SHALL MATCH EXISTING GROUND SLOPES ADJACENT TO THE CURB RAMPS OR USE AN ALTERNATE METHOD APPROVED BY THE ENGINEER.
12. S-CURB 12"-30" HIGH (MODIFIED S-CURB) WILL REQUIRE #4 REINFORC. BARS ON MAX. 12" CENTERS - SEE DETAIL (NO DIRECT PAY)
13. SODDED SLOPES AT EDGES OF SIDEWALK OR S-CURB SHOULD BE GRADED TO BE 6:1 MIN.

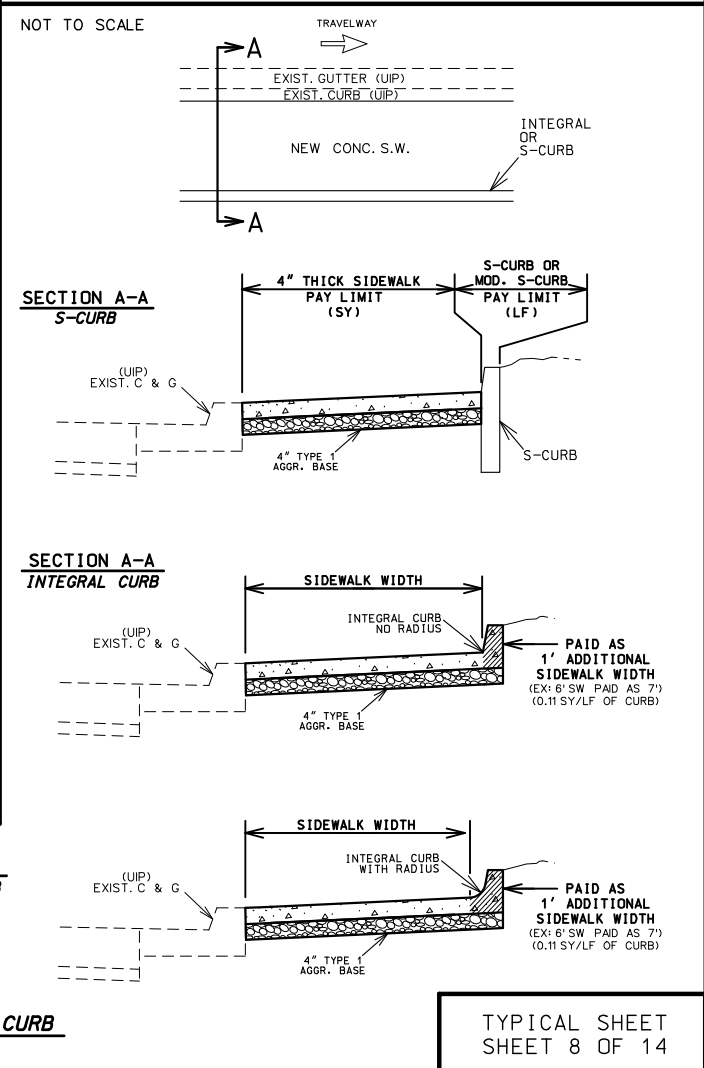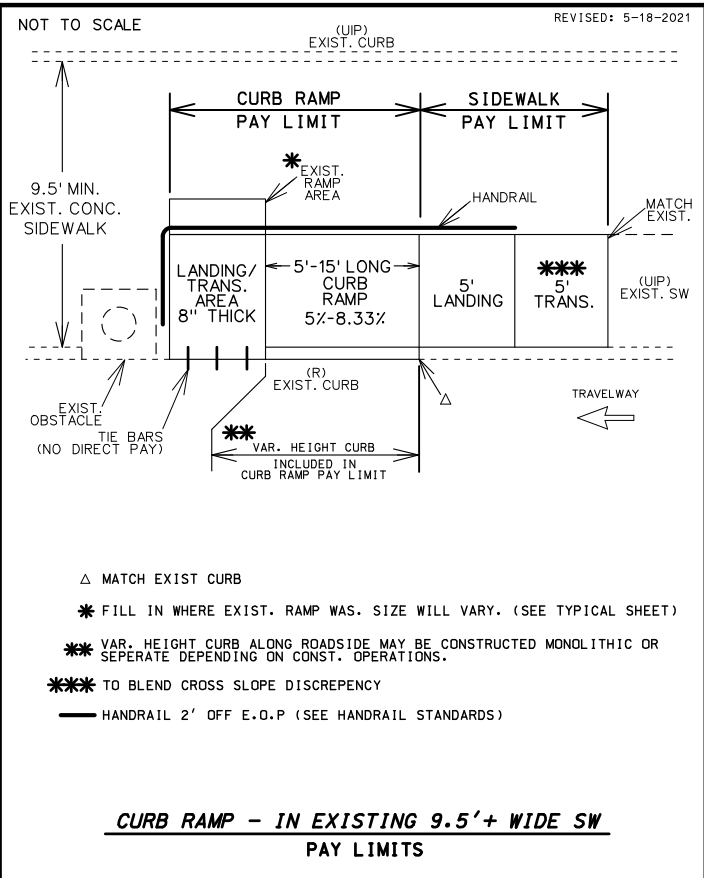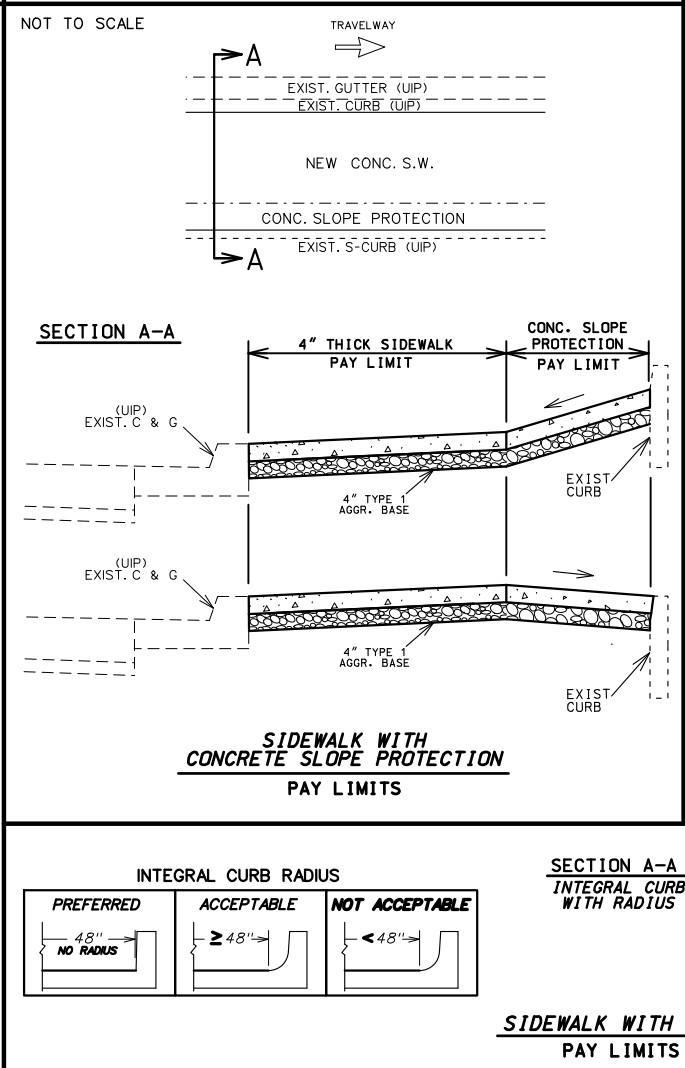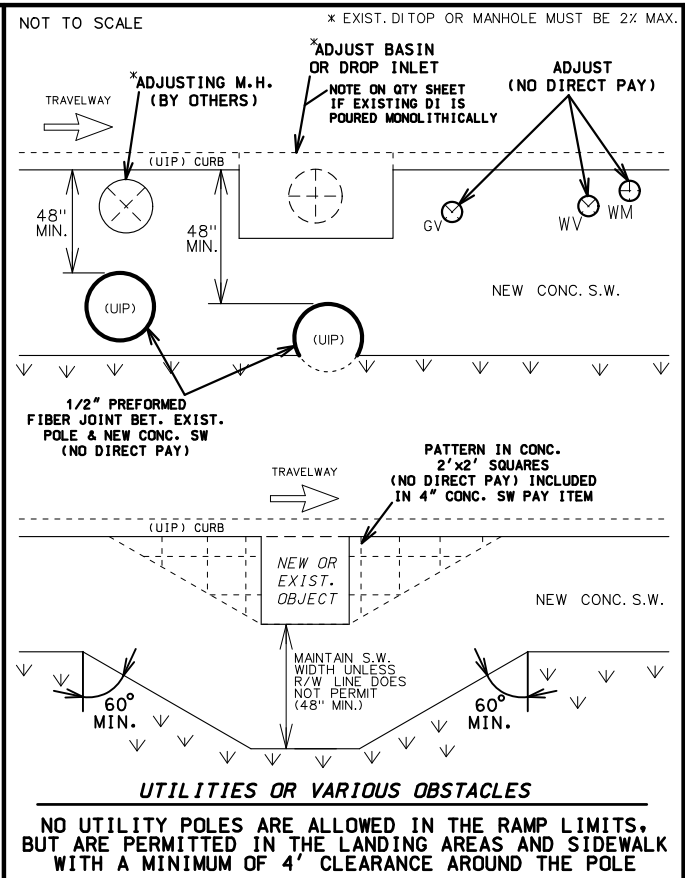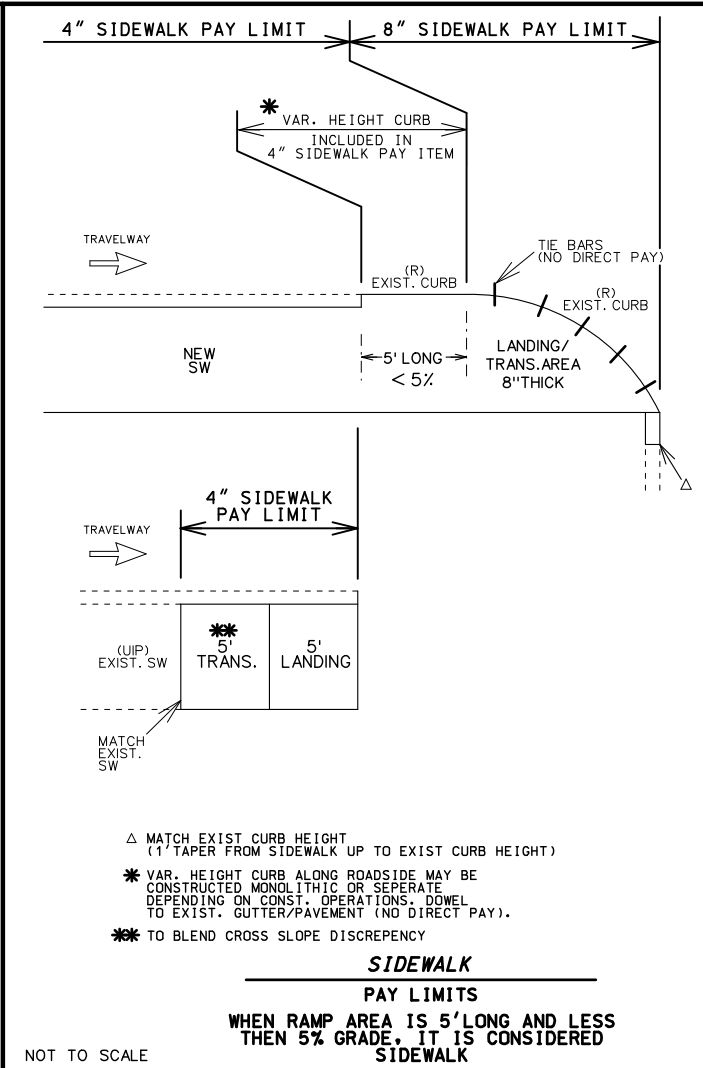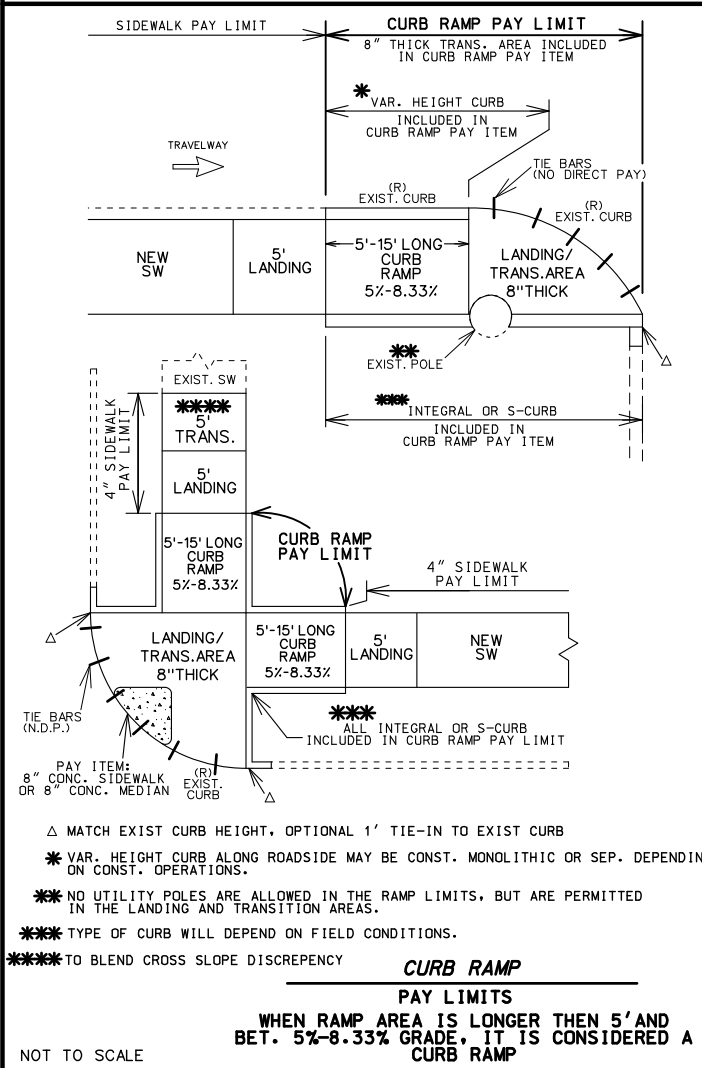

STATE OF MISSOURI
JASON D. EVENDEN
PROFESSIONAL ENGINEER
NUMBER
PE-2013000659

THIS SHEET HAS BEEN
SIGNED, SEALED AND DATED
ELECTRONICALLY.

DATE PREPARED
8/5/2021

ROUTE
744/160

DISTRICT
SW

STATE
MO

SHEET NO.
2

COUNTY
GREENE

JOB NO.
J8P3087D

CONTRACT ID.

PROJECT NO.

BRIDGE NO.

DESCRIPTION

DATE

MISSOURI HIGHWAYS AND TRANSPORTATION
COMMISSION

105 WEST CAPITAL
JEFFERSON CITY, MO 65102
1-888-ASK-MODOT (1-888-275-6636)

IF A SEAL IS PRESENT ON THIS SHEET IT HAS BEEN ELECTRONICALLY SEALED AND DATED.

PARRALLEL - TYPE 2 (cont'd.)										
TYPE 2-G										
LENGTH (LF)	WIDTH (LF)	8			12			16		
		4	5	6	4	5	6	4	5	6
TRUNCATED DOMES	SF	-	12.0	12.0	-	10.0	10.0	-	10.0	10.0
CURB RAMP	SY	-	15.7	18.0	-	20.8	23.7	-	25.8	30.2
CONC. SIDEWALK	SY	-	21.4	25.0	-	17.6	20.3	-	15.2	17.5
TYPE 1 AGGREGATE	SY	-	37.1	43.0	-	38.4	44.0	-	41.0	47.7
ADA LINEAR GRADING	LF	-	52.0	52.0	-	54.0	54.0	-	58.0	58.0
SODDING	SY	-	13.6	13.6	-	13.7	13.5	-	14.5	14.9

TYPE 2-H										
LENGTH (LF)	WIDTH (LF)	8			12			16		
		4	5	6	4	5	6	4	5	6
TRUNCATED DOMES	SF	-	12.0	12.0	-	10.0	10.0	-	10.0	10.0
CURB RAMP	SY	-	15.7	18.0	-	21.0	24.5	-	26.9	31.4
CONC. SIDEWALK	SY	-	13.2	16.0	-	12.0	14.2	-	12.0	14.4
TYPE 1 AGGREGATE	SY	-	28.9	34.0	-	33.0	38.6	-	38.9	45.8
ADA LINEAR GRADING	LF	-	42.0	42.0	-	49.0	49.0	-	55.0	55.0
SODDING	SY	-	11.1	11.2	-	12.5	12.5	-	14.5	14.9

T* - IS STILL NEEDED EVEN IF THE EXISTING SIDEWALK IS THE SAME WIDTH AS THE NEW SIDEWALK. (IT WILL BLEND THE EXIST XSLOPE INTO THE NEW LANDING XSLOPE)

T - TRANSITION TO EXISTING SW
L - LANDING
R - RAMP

↘ ↘ - SOD SLOPE 6:1 MIN.



..... - TRUNCATED DOME LOCATION, IF DIST. IS <5' OR >5'

TRUNCATED DOMES ARE USED ONLY AT STREETS & ENTRANCES UTILIZING YIELD / STOP SIGNS OR SIGNALS



▨ - CURB RAMP PAY LIMITS

..... - INCLUDED IN 4" CONC. SIDEWALK PAY LIMIT


NOTE:
QUANTITIES ARE CALCULATED BY AREA AND MAY NOT MATCH EXACT FIELD CONDITIONS.

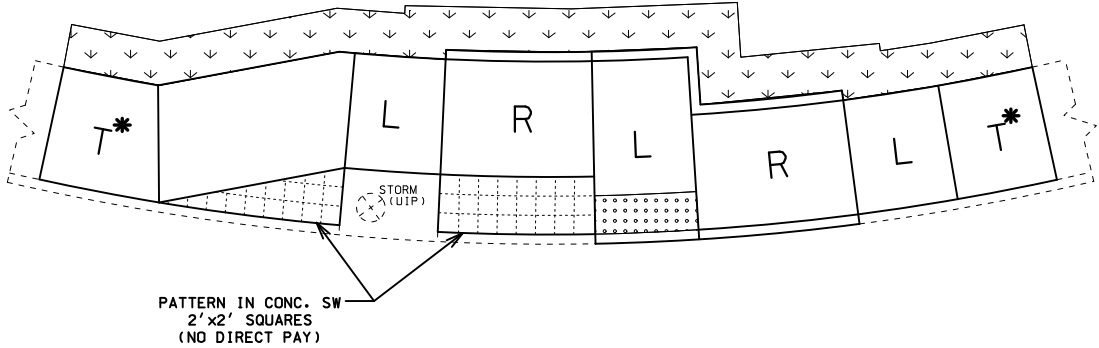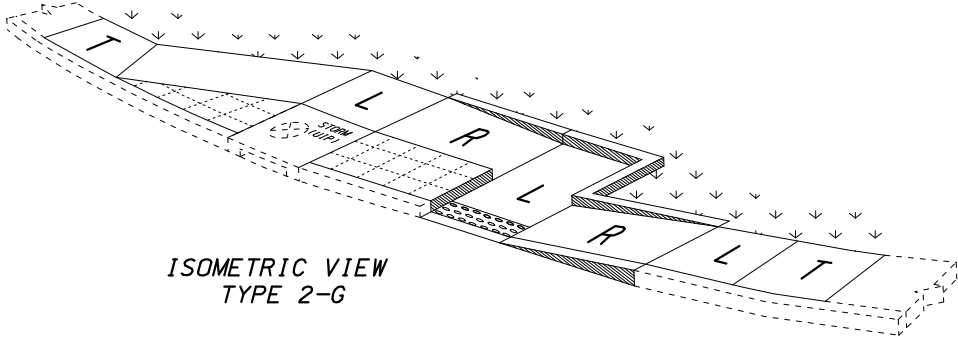

TYPE 2-G

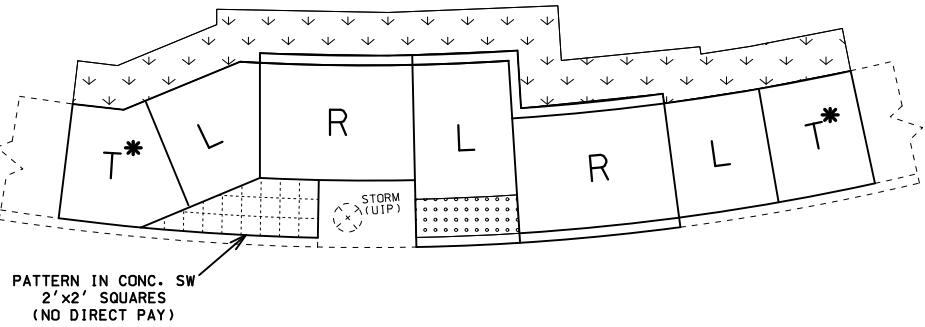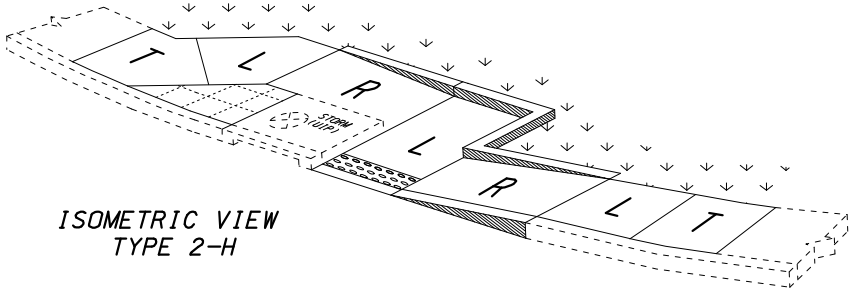

TYPE 2-H

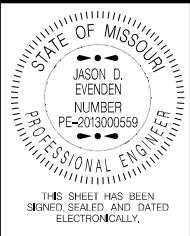

DATE PREPARED 8/5/2021	
ROUTE 744/160	STATE MO
DISTRICT SW	SHEET NO. 2
COUNTY GREENE	
JOB NO. J8P3087D	
CONTRACT ID.	
PROJECT NO.	
BRIDGE NO.	


DATE	DESCRIPTION

MISSOURI HIGHWAYS AND TRANSPORTATION COMMISSION

105 WEST CAPITOL
JEFFERSON CITY, MO 65102
1-888-ASK-MODOT (1-888-275-6636)


IF A SEAL IS PRESENT ON THIS SHEET IT HAS BEEN ELECTRONICALLY SEALED AND DATED.

DIAGONAL - TYPE 3											
TYPE 3-A											
LENGTH (LF) WIDTH (LF)		8			12			16			REMARKS
		4	5	6	4	5	6	4	5	6	
TRUNCATED DOMES	SF	-	24.0	28.0	-	20.6	25.0	-	20.6	25.0	
CURB RAMP	SY	-	24.4	27.0	-	26.9	31.2	-	32.2	37.4	
CONC. SIDEWALK	SY	-	11.2	12.8	-	9.8	11.4	-	9.8	11.4	
TYPE 1 AGGREGATE	SY	-	35.6	39.8	-	36.7	42.6	-	42.0	48.8	
ADA LINEAR GRADING	LF	-	51.0	51.0	-	59.0	59.0	-	67.0	67.0	
SODDING	SY	-	11.6	11.4	-	12.9	12.9	-	14.9	14.9	
8" MED STRIP	SY	-	3.0	2.2	-	3.0	2.2	-	3.0	2.2	
TYPE 3-B											
LENGTH (LF) WIDTH (LF)		8			12			16			REMARKS
		4	5	6	4	5	6	4	5	6	
TRUNCATED DOMES	SF	-	24.0	28.0	-	20.6	25.0	-	20.6	25.0	
CURB RAMP	SY	-	22.0	26.3	-	25.9	31.2	-	31.2	37.4	
CONC. SIDEWALK	SY	-	11.2	12.8	-	9.8	11.4	-	9.8	11.4	
TYPE 1 AGGREGATE	SY	-	33.2	39.1	-	35.7	42.6	-	41.0	48.8	
ADA LINEAR GRADING	LF	-	51.0	51.0	-	59.0	59.0	-	67.0	67.0	
SODDING	SY	-	15.2	15.3	-	17.1	17.5	-	20.1	20.5	
8" MED STRIP	SY	-	1.5	1.5	-	1.5	1.5	-	1.5	1.5	
TYPE 3-C											
LENGTH (LF) WIDTH (LF)		8			12			16			REMARKS
		4	5	6	4	5	6	4	5	6	
TRUNCATED DOMES	SF	-	20.0	24.0	-	20.0	24.0	-	20.0	24.0	
CURB RAMP	SY	-	20.7	26.8	-	25.1	31.5	-	30.4	37.7	
CONC. SIDEWALK	SY	-	11.2	12.8	-	9.8	11.4	-	9.8	11.4	
TYPE 1 AGGREGATE	SY	-	31.9	39.6	-	34.9	42.9	-	40.2	49.1	
ADA LINEAR GRADING	LF	-	51.0	51.0	-	58.0	58.0	-	67.0	67.0	
SODDING	SY	-	18.8	19.3	-	21.3	22.1	-	25.3	26.1	
8" MED STRIP	SY	-	1.0	1.6	-	1.0	1.6	-	1.0	1.6	
TYPE 3-D											
LENGTH (LF) WIDTH (LF)		8			12			16			REMARKS
		4	5	6	4	5	6	4	5	6	
TRUNCATED DOMES	SF	-	24.0	28.0	-	22.4	26.5	-	22.4	26.5	
CURB RAMP	SY	-	15.9	19.1	-	17.7	21.4	-	20.4	24.5	
CONC. SIDEWALK	SY	-	5.6	6.4	-	4.9	5.7	-	4.9	5.7	
TYPE 1 AGGREGATE	SY	-	21.5	25.5	-	22.6	27.1	-	25.3	30.2	
ADA LINEAR GRADING	LF	-	31.0	31.0	-	34.0	34.0	-	38.0	38.0	
SODDING	SY	-	12.6	12.9	-	13.5	14.0	-	15.5	16.0	
8" MED STRIP	SY	-	1.0	0.8	-	1.0	0.8	-	1.0	0.8	
TYPE 3-E											
LENGTH (LF) WIDTH (LF)		8			12			16			REMARKS
		4	5	6	4	5	6	4	5	6	
TRUNCATED DOMES	SF	-	20.0	24.0	-	20.0	24.0	-	20.0	24.0	
CURB RAMP	SY	-	17.2	19.8	-	17.7	21.4	-	20.4	24.5	
CONC. SIDEWALK	SY	-	8.4	10.7	-	7.3	9.4	-	7.3	9.4	
TYPE 1 AGGREGATE	SY	-	25.6	30.5	-	25.0	30.8	-	27.7	33.9	
ADA LINEAR GRADING	LF	-	30.0	30.0	-	35.5	35.5	-	39.5	39.5	
SODDING	SY	-	12.4	12.4	-	12.9	13.3	-	14.9	15.3	
8" MED STRIP	SY	-	1.6	1.6	-	1.6	1.6	-	1.6	1.6	

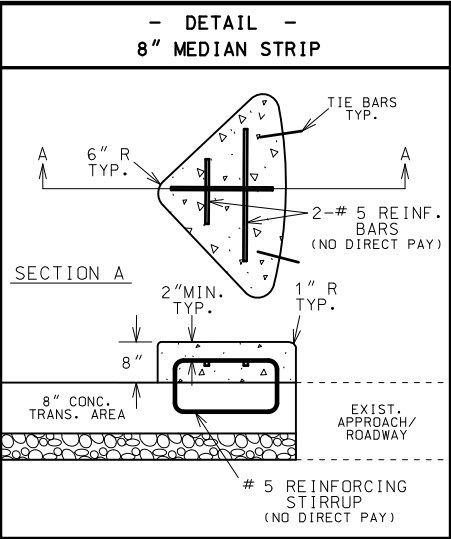

T - IS TO BE 8" THICK AT ALL PAVED APPROACHES AND STREETS. PAID FOR AS CONCRETE CURB RAMP

NOTE: QUANTITIES ARE CALCULATED BY AREA AND MAY NOT MATCH EXACT FIELD CONDITIONS.

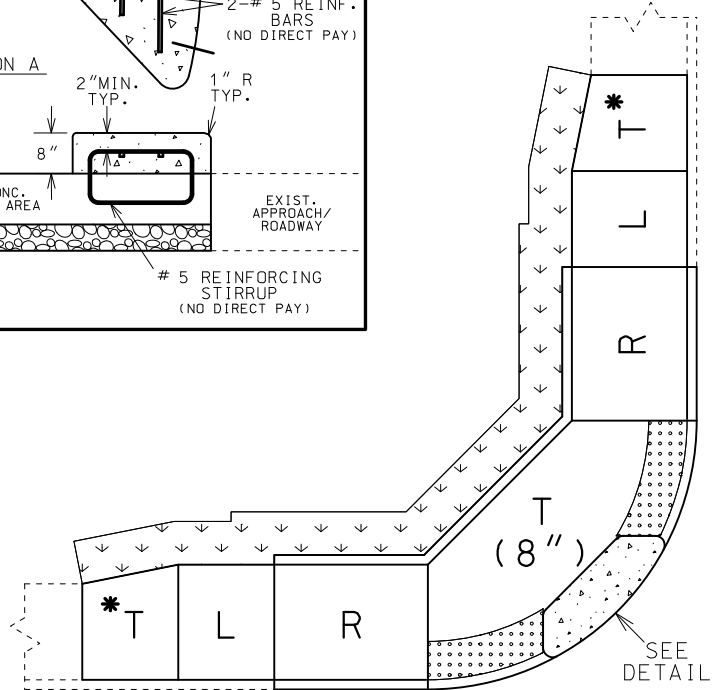

TYPE 3-A

T - TRANSITION TO EXISTING SW OR PAVED APPROACH (LANDING PREFERRED IF CONDITIONS ALLOW)

T* - IS STILL NEEDED EVEN IF THE EXISTING SIDEWALK IS THE SAME WIDTH AS THE NEW SIDEWALK. (IT WILL BLEND THE EXIST XSLOPE WITH THE NEW LANDING XSLOPE)

L - LANDING


R - RAMP

- CURB RAMP PAY LIMITS


- SOD SLOPE 6:1 MIN.

- TRUNCATED DOME LOCATION, IF DIST. IS <5' OR >5'


TRUNCATED DOMES ARE USED ONLY AT STREETS & ENTRANCES UTILIZING YIELD / STOP SIGNS OR SIGNALS

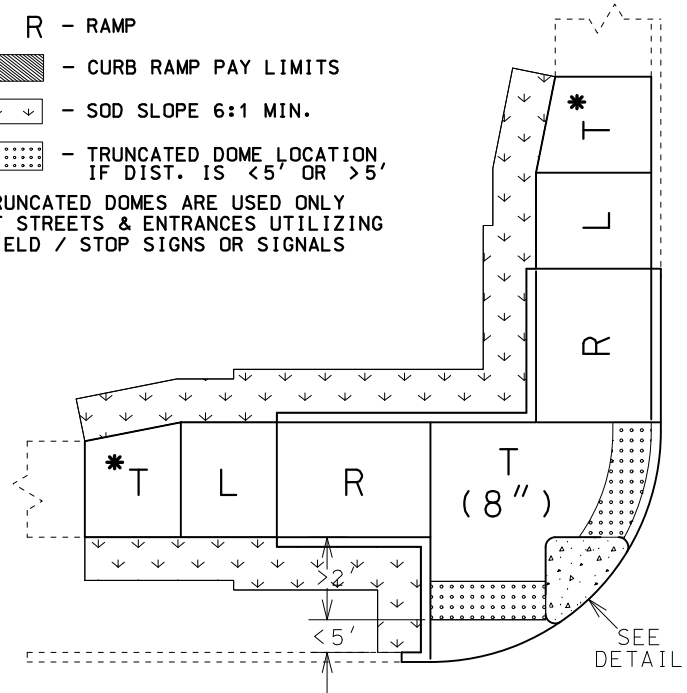


TYPE 3-B

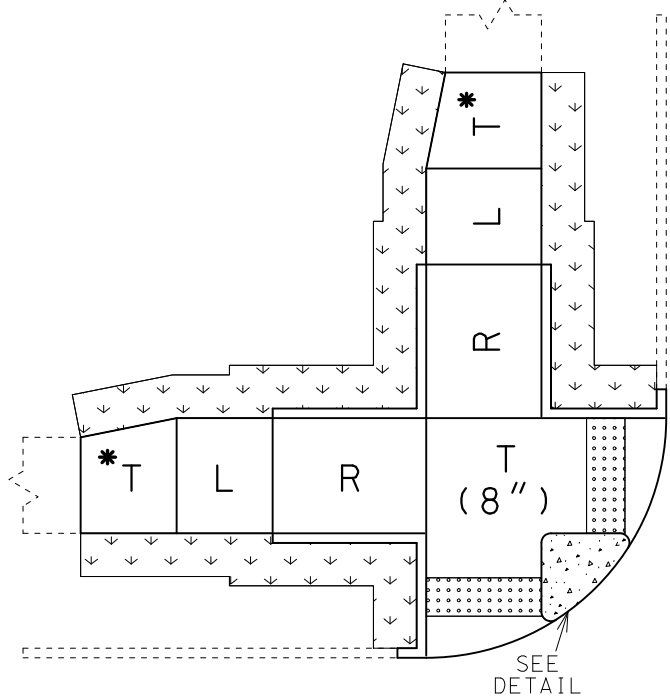

TYPE 3-C

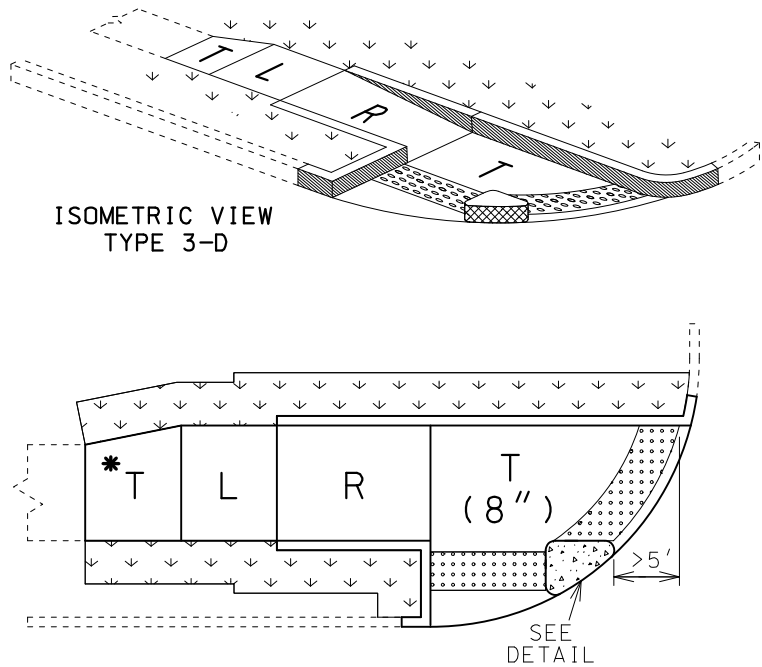


TYPE 3-D

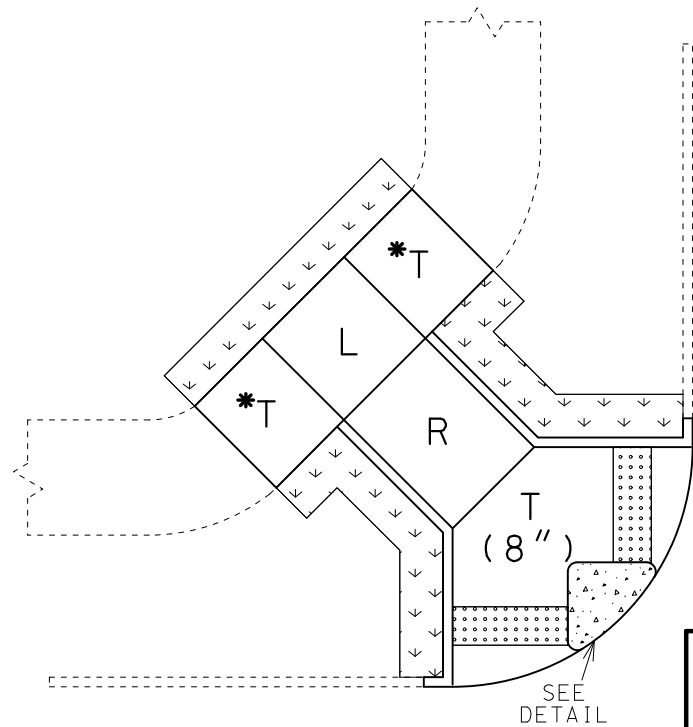

TYPE 3-E

REVISED: 02-22-2017

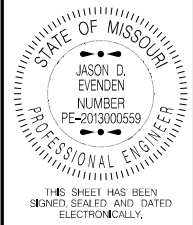

DATE PREPARED
8/5/2021

ROUTE
744/160

STATE
MO

DISTRICT
SW

SHEET NO.
2

COUNTY
GREENE

JOB NO.
J8P3087D

CONTRACT ID.

PROJECT NO.

BRIDGE NO.

DATE	DESCRIPTION

MISSOURI HIGHWAYS AND TRANSPORTATION COMMISSION

MoDOT


105 WEST CAPITOL
JEFFERSON CITY, MO 65102
1-888-ASK-MODOT (1-888-275-6636)

TYPE 3
DIAGONAL
CURB RAMPS

TYPICAL SHEET
12 OF 14

IF A SEAL IS PRESENT ON THIS SHEET IT HAS BEEN ELECTRONICALLY SEALED AND DATED.

* INTEGRAL CURB IS PAID FOR WITH
THE 8" CONC. SIDEWALK PAY ITEM.
INTEGRAL CURB IS PAID AS 1' ADDITIONAL
SIDEWALK WIDTH (EX. 6' SIDEWALK PAID AS 7')
(0.11 SY/LF OF CURB)

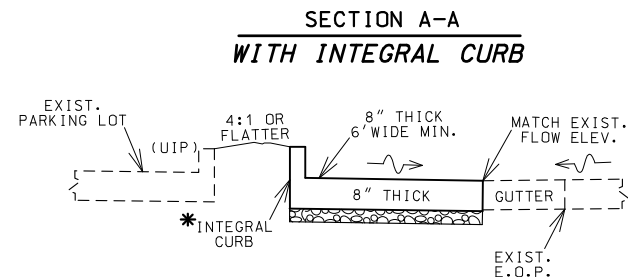

* INTEGRAL CURB IS PAID FOR AS 4" CONC. SIDEWALK PAY ITEM. S-CURB IS PAID FOR AS ITS OWN PAY ITEM.
(ALWAYS USE S-CURB IF AT R/W LINE.)

INTEGRAL CURB IS PAID AS 1' ADDITIONAL SIDEWALK WIDTH (EX. 6'SIDEWALK PAID AS 7')
(0.11 SY/LF OF CURB)

PAID AS 1' ADDITIONAL
EX. 6' SIDEWALK PAID AS 7')

VAR. LENGTH - 4" THICK SW

EXIST. CURB (UIP)

EXIST. R/W

SAWCUT

(R)

6'

* 6" MIN. INTEGRAL CURB OR S-CURB

(R)

MATCH EXIST. ENT. GRADE

E.O.P.

EXIST. C&G (UIP)

EXIST. R/W

SAWCUT

(UIP) EXIST. PAVED APPRCH. OR STREET

(UIP) EXIST. PAVED APPRCH. OR STREET

*TYPICAL
MODIFIED SIDEWALK
8" THICK*

✱✱ TRUNCATED DOMES ARE USED ONLY
AT STREETS & ENTRANCES UTILIZING
STOP/YIELD SIGNS OR SIGNALS.

X-SLOPE 2% MAX., CONSTRUCT TO DRAIN

(UIP)

SAWCUT

* INTEGRAL CURB

REMOVE EXIST.

* INTEGRAL CURB

* INTEGRAL CURB

SAWCUT

CREATE ACCESS TO EXIST. OR FUTURE PED. PUSH BUTTON

(UIP)

DETAIL

ACCESS FOR PED. PUSH BUTTON

2' MIN. CLEARANCE

2' MIN. CLEARANCE

(UIP)

The diagram illustrates a cross-section of a pavement structure. A central horizontal line represents the pavement surface, with dashed lines above and below indicating the subgrade. A solid line segment in the center is labeled "6' WIDE (5' MIN.)". This segment is flanked by two areas labeled "(UIP) ISLAND". On the left side of the central segment, there is a "SAWCUT" indicated by a double asterisk (**). On the right side, there is another "SAWCUT" indicated by a double asterisk (**). Below the central segment, the text "PVMNT." is written. To the right of the central segment, there is a legend entry: a solid black square followed by the text "UTILIZE EXIST. PAVEMENT ELEVATION".

* INTEGRAL CURB

(U.P.)

ISLAND

4" THICK (5' MIN.)

6' WIDE

* INTEGRAL CURB

(U.P.)

ISLAND

PVMNT.

PVMNT.

■ SMALL QTY. HAS BEEN INCLUDED FOR 8" THICK
SIDEWALK TO ADDRESS ANY UNFORSEEN PYMNT.
REPAIRS OR DIFFERENCES IN ELEVATION.
(OVERRUN IF FIELD CONDITIONS DO NOT WARRANT)

*** NO INTEGRAL CURB, AGGR. OR LIN. GRADING
REQUIRED IF THE ISLAND IS 'PINNED-ON'

* INTEGRAL CURB IS PAID FOR WITH
THE 4" CONC. SIDEWALK PAY ITEM.
INTEGRAL CURB IS PAID AS 1' ADDITIONAL
SIDEWALK WIDTH (EX. 6' SIDEWALK PAID AS 7')
(0.11 SY/LF OF CURB)

MODIFIED SIDEWALK
AND
SIDEWALK CUT-THRU'S

TYPICAL SHEET
13 OF 14

[illegible]MISSOURI HIGHWAYS AND TRANSPORTATION
COMMISSION

105 WEST CAPITOL
JEFFERSON CITY, MO 65102
1-888-ASK-MODOT (1-888-275-6636)

IF A SEAL IS PRESENT ON THIS SHEET IT HAS BEEN ELECTRONICALLY SEALED AND DATED:

REMOVAL OF IMPROVEMENTS								
SHEET	STATION	STATION	ROUTE	LOCATION	DESCRIPTION	UNITS	TOTAL	REMARKS
4	961+71.64		744	LT	TYPE A GUTTER	LF	30	
4	962+73.55		744	LT	SIGN	EA	1	SHARE ROAD
4	961+85.60	964+89.94	744	LT	CURB & GUTTER	LF	287	
4	963+49.25		744	LT	ENTRANCE	SY	27	
4	963+73.56		744	LT	DROP INLET	EA	1	
4	961+44.49	963+84.82	744	LT	LIGHT	EA	2	
4	964+60.90		744	LT	DROP INLET	EA	1	
4	961+70.84	965+09.00	744	LT & RT	RAISED MEDIAN	SY	400	
4	961+81.17		744	MEDIAN	SIGN	EA	1	KEEP RIGHT, IN MEDIAN
4	963+19.62	965+09.00	744	RT	CURB & GUTTER	LF	182	
4	963+30.43		744	RT	SIGN	EA	1	REMOVE & RELOCATE TO NEW POSTS
4	964+40.48		744	RT	TYPE A GUTTER	LF	25	
4	964+76.34		744	RT	PULL BOX	EA	1	
4	965+04.39		744	RT	LIGHT	EA	1	
4	964+60.29		744	RT	PIPE	LF	21	
4	964+60.29		744	RT	HEADWALL	EA	1	
5	965+14.20		744	LT	ENTRANCE	SY	26	
5	965+51.05		744	LT	DROP INLET	EA	1	
5	965+76.70		744	LT	SIGN	EA	1	WEST 744
5	966+22.46	966+60.67	744	LT	PULL BOXES & CONTROLLER	EA	8	DISCONNECT AND (R) EX. POWER SUPPLIES
5	966+37.40		744	LT	SIGNAL	EA	1	
5	966+20.23	966+23.42	744	LT	LIGHT	EA	2	
5	965+19.54	966+72.46	744	LT	CURB & GUTTER	LF	283	NW C&G
5	966+64.28		744	LT	SIGN	EA	1	EX. RTE. MARKERS
5	965+09.00	966+67.77	744	LT	RAISED MEDIAN	SY	123	
5	966+54.75		744	LT	PULL BOX	EA	1	IN MEDIAN
5	966+51.95		744	LT	SIGN	EA	1	KEEP RIGHT, IN MEDIAN
5	965+09.00	966+67.64	744	RT	CURB & GUTTER	LF	294	SW C&G
5	966+17.00		744	RT	SIGN	EA	2	EX. RTE. MARKERS
5	966+30.66	966+47.31	744	RT	PULL BOX	EA	2	
5	966+58.71		744	RT	LIGHT	EA	1	
5	966+51.09		744	RT	PULL BOX	EA	1	
5	966+50.25		744	RT	SIGN	EA	1	UTILITY MARKER
5	966+57.09		744	RT	PULL BOX	EA	2	
5	966+55.25	967+57.02	744	LT	TYPE A GUTTER	LF	47	BOTH NW & NE QUADS
5	967+64.51	967+90.76	744	LT	PULL BOX	EA	2	
5	967+51.41		744	LT	LIGHT	EA	1	
5	967+48.00		744	LT	SIGN	EA	1	WEST 160
5	967+76.39	967+81.95	744	LT	SIGN	EA	2	EX. RTE. MARKERS
5	967+11.63		744	LT	SIGN	EA	1	KEEP RIGHT, IN MEDIAN
5	967+11.60		744	LT	PULL BOX	EA	1	IN MEDIAN
5	967+55.30		744	LT	SIGNAL	EA	1	
5	967+93.06		744	LT	SIGN	EA	1	BILLBOARD
5	967+58.00	970+69.00	744	LT	SIDEWALK	SY	228	WEST OF WESTERN AVE.
5	967+44.11	970+68.00	744	LT	CURB & GUTTER	LF	427	NE C&G
5	969+34.03		744	LT	PULL BOX	EA	1	
5	969+08.70	969+28.84	744	LT	LIGHT	EA	2	
5	969+83.73		744	LT	ENTRANCE	SY	238	WESTERN AVE.
5	969+53.76	970+13.77	744	LT	PIPE	LF	60	AT WESTERN AVE.
5	970+38.68		744	LT	SIGN	EA	1	REMOVE & RELOCATE TO NEW POSTS
5	969+98.05	970+68.00	744	LT	SIDEWALK	SY	71	EAST OF WESTERN AVE.
5	966+99.00		744	RT	SIGN	EA	2	KEEP RIGHT, IN MEDIAN
5	966+98.11		744	RT	PULL BOX	EA	1	IN MEDIAN
5	967+42.93		744	RT	PULL BOX	EA	1	
5	967+72.13		744	RT	SIGNAL	EA	1	
5	967+45.20		744	RT	TYPE A GUTTER	LF	12	
5	967+38.64	968+21.66	744	RT	CURB & GUTTER	LF	214	SE C&G
5	967+48.00		744	RT	SIGN	EA	3	EX. RTE. MARKERS
5	967+84.76		744	RT	LIGHT	EA	1	
5	967+72.13		744	RT	SIGNAL	EA	1	
5	967+62.02		744	RT	SIGN & PULL BOX	EA	1	KEEP RIGHT, IN MEDIAN
5	967+45.02	970+68.00	744	RT	RAISED MEDIAN	EA	214	
6	970+97.74		744	LT	LIGHT	EA	1	
6	970+99.23		744	LT	TYPE A GUTTER	LF	17	
6	971+46.33		744	LT	LIGHT	EA	1	
6	971+71.34		744	LT	SIGN	EA	1	REMOVE & RELOCATE TO NEW POSTS
6	970+68.00	971+45.83	744	LT	SIDEWALK	SY	78	WEST OF AIRPORT DR.
6	971+63.42	972+93.30	744	LT	SIDEWALK	SY	169	WEST OF AIRPORT DR.
6	973+38.15	974+00.19	744	LT	SIDEWALK	SY	98	EAST OF AIRPORT DR.

REMOVALS (CONT.)								
6	972+84.58		744	LT	SIGN	EA	1	STOP
6	970+68.00	971+00.00	744	RT	RAISED MEDIAN	SY	22	
6	971+45.32	973+11.56	744	RT	U2 SHOULDER	SY	90	
6	973+39.48	975+62.45	744	RT	U2 SHOULDER	SY	138	
7	978+00.39	984+02.85	160	VAR	RAISED MEDIAN	SY	624	
7	981+56.97		160	RT	TYPE A GUTTER	LF	20	
7	981+64.64		160	RT	PULL BOX	EA	2	
7	982+10.52		160	RT	PULL BOX	EA	2	
7	981+65.90	983+23.75	160	RT	CURB & GUTTER	LF	73	
8	103+32.15	811+34.00	160 S	LT	CURB & GUTTER	LF	136	
8	103+08.85	811+24.34	160 S	LT	PIPE	LF	186	
8	103+54.95		160 S	LT	SIGN	EA	1	REMOVE & RELOCATE TO NEW POST
8	811+27.97		160 S	LT	DROP INLET	EA	1	
8	103+52.39		160 S	RT	SIGN	EA	1	
8	810+49.54		160 S	RT	LIGHT	EA	1	
8	810+69.43		160 S	RT	TYPE A GUTTER	LF	13	
8	810+85.02		160 S	RT	PULL BOX	EA	1	
8	811+10.49		160 S	RT	LIGHT	EA	1	
8	103+31.77	811+34.00	160 S	RT	CURB & GUTTER	LF	126	
8	101+81.89	812+74.71	160 S	VAR	RAISED MEDIAN	SY	226	
5	811+29.03	812+23.36	160 S	LT	PIPE	LF	93	
5	811+27.97		160 S	LT	DROP INLET	EA	1	
6	970+68.00	973+68.19	744	LT	CURB & GUTTER	LF	280	
1 LUMP SUM								

MOBILIZATION


1 LUMP SUM

CONTRACTOR FURNISHED SURVEYING & STAKING

1 LUMP SUM

CLEARING AND GRUBBING

LOCATION	AREA ACRE	REMARKS
160SB-744WB	0.50	NW QUADRANT
744EB-160SB	0.27	SW QUADRANT
160NB-744EB	0.16	SE QUADRANT
744WB-160NB	0.27	NE QUADRANT
TOTAL =	1.2	
USE =	1	

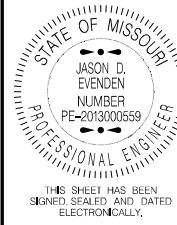

DATE PREPARED 8/26/2021	
ROUTE 744/160	STATE MO
DISTRICT SW	SHEET NO. 3
COUNTY GREENE	
JOB NO. J8P3087D	
CONTRACT ID.	
PROJECT NO.	
BRIDGE NO.	

DESCRIPTION	DATE						

MISSOURI HIGHWAYS AND TRANSPORTATION
COMMISSION



105 WEST CAPITOL
JEFFERSON CITY, MO 65102
1-888-ASK-MODOT (1-888-275-6636)


IF A SEAL IS PRESENT ON THIS SHEET IT HAS BEEN ELECTRONICALLY SEALED AND DATED.

EARTHWORK								
			STATION		UNCLASSIFIED EXCAVATION	COMPACTING EMBANKMENT	COMPACTING IN CUT	
SHEET	ROUTE	LOCATION	FROM	TO	CY	CY	STA	REMARKS
4, 5	MO 744	WEST LEG	961+16.71	965+78.96	907	495	7.6	
5, 6	MO 744	EAST LEG	968+35.51	974+87.72	912	380	3.4	
7, 5	US 160	NORTH LEG	978+00.39	982+77.74	1223	17	6.2	
8, 5	US 160	SOUTH LEG	101+17.85	811+59.15	441	8	7.8	
5	INTERSECTION	NW QUADRANT	0+00	1+48.91	543	3		ALONG EOP
5	INTERSECTION	NE QUADRANT	0+00	1+25.76	438	0		ALONG EOP
5	INTERSECTION	SW QUADRANT	0+00	1+63.40	268	31		ALONG EOP
5	INTERSECTION	SE QUADRANT	0+00	1+53.61	199	5		ALONG EOP
				TOTALS =	4,931	939	25.0	

COLDMILLING AND ULTRATHIN BONDED ASPHALT WEARING SURFACE, TYPE C							
				LENGTH	TYPE C UBAWS	COLDMILLING BIT. PAVEMENT (3 IN OR LESS)	
SHEET	STATION	STATION	LOCATION	FT	SY	SY	REMARKS
4	961+16.71	965+09.50	MO 744	392.79	1532.7	1532.7	EB LANES
4	961+16.71	965+09.50	MO 744	392.79	1656.9	1656.9	WB LANES
5	965+09.50	965+27.78	MO 744	18.28	92.1	92.1	EB LANES
5	965+09.50	965+78.96	MO 744	69.46	344.5	344.5	WB LANES
5	965+27.78	967+04.63	INTERSECTION	176.85	1594.1	1594.1	SW QUADRANT
5	965+78.96	967+04.63	INTERSECTION	125.67	1593.5	1593.5	NW QUADRANT
5	967+04.63	968+21.90	INTERSECTION	117.11	1295.5	1295.5	SE QUADRANT
5	967+04.63	968+35.52	INTERSECTION	130.89	1273.7	1273.7	NE QUADRANT
5	968+21.90	970+68.50	MO 744	246.76	911.1	911.1	EB LANES
5	968+35.52	970+68.50	MO 744	232.98	1459.7	1459.7	WB LANES
6	970+68.50	974+87.72	MO 744	419.22	1404.1	1404.1	EB LANES
6	970+68.50	974+87.72	MO 744	419.22	1634.4	1634.4	WB LANES
7	978+00.39	982+77.74	US 160	477.35	2190.4	2190.4	SB LANES
7	978+00.39	983+09.75	US 160	509.36	1890.6	1890.6	NB LANES
8	811+86.73	101+17.85	US 160	351.46	1713.7	1713.7	SB LANES
8	811+59.15	101+17.85	US 160	351.46	1633.9	1633.9	NB LANES
				TOTALS =	22,221	22,221	

PAVEMENT AND BASE									
SHEET	STATION	STATION	ROUTE	LOCATION	WIDTH FT	LENGTH FT	OPTIONAL PAVEMENT SY	6" TYPE 5 BASE SY	REMARKS
4	963+19.62	965+09.50	744	RT	VAR	189.88	189.0	189.0	EB RT TURN LANE
4	961+16.71	965+09.50	744	LT	VAR	392.79	329.5	329.5	WB THRU LANE
4, 5	961+70.83	966+67.78	744	RT & LT	VAR	496.95	517.6	517.6	BENEATH EX. WESTERN MEDIAN
5	965+09.50	966+69.83	744, 160	RT of 160 & LT of 744	VAR		650.0	650.0	EB RT TURN TO SB THRU
5	965+09.50	966+76.40	744, 160	RT of 160 & LT of 744	VAR		782.2	782.2	SB THRU, SB RT TURN TO EB THRU
5	967+38.77	970+68.48	744	LT	VAR		988.3	988.3	WB RT TURN AND THRU LANE
5	967+33.47	968+21.91	744	RT	VAR		410.1	410.1	NB RT TURN LANE
5, 6	967+42.66	971+00.00	744	RT	VAR	357.34	237.8	237.8	BENEATH EX. EASTERN MEDIAN
6	970+68.48	972+45.57	744	LT	VAR	177.09	251.4	251.4	WB RT TURN AND THRU LANE
7	978+00.39	982+46.64	160	RT	VAR		588.2	588.2	SB RT TURN AND THRU LANE
5, 7	978+00.39	984+02.85	160	RT & LT	VAR	602.46	634.7	634.7	BENEATH EX. NORTHERN MEDIAN
8	103+32.15	811+18.36	160	LT	VAR	70786.21	73.7	73.7	SB THRU LANE
8	103+32.24	811+20.30	160	RT	VAR	70787.78	123.7	123.7	NB RT TURN LANE
5, 8	101+81.89	812+74.81	160	RT & LT	VAR	73.5097444	243.4	243.4	BENEATH EX. SOUTHERN MEDIAN
						TOTALS	6,019.7	6,020	

TYPE A2 SHOULDER									
SHEET	STATION	STATION	ROUTE	LOCATION	WIDTH FT	LENGTH FT	TYPE A2 SHOULDER SY	4" TYPE 5 AGG. BASE SY	REMARKS
4	961+16.71	961+61.59	744	LT	VAR	44.88	27.9	27.9	
7	978+00.39	980+70.74	160	RT	VAR	270.35	286.0	286.0	
						TOTAL	313.9	314	

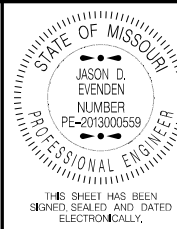

DATE PREPARED 8/26/2021	
ROUTE 744/160	STATE MO
DISTRICT SW	SHEET NO. 3
COUNTY GREENE	
JOB NO. J8P3087D	
CONTRACT ID.	

PROJECT NO.
BRIDGE NO.

DATE	DESCRIPTION

MISSOURI HIGHWAYS AND TRANSPORTATION COMMISSION

105 WEST CAPITOL
JEFFERSON CITY, MO 65102
1-888-ASK-MODOT (1-888-275-6636)

IF A SEAL IS PRESENT ON THIS SHEET IT HAS BEEN ELECTRONICALLY SEALED AND DATED.

(PEDESTRIAN FACILITIES) TRUNCATED DOMES, CURB RAMP, SIDEWALK, S-CURB																
SHEET	STATION	STATION	LOCATION	OFFSET	TRUNC. DOMES SF	CURB RAMP				4" SIDEWALK		8" SIDEWALK		4" TYPE 1 AGG	S-CURB	STEEL PLATE
						LENGTH	WIDTH	TYPE	SY	LENGTH	SY	LENGTH	SY	SY	LF	EA
5	967+71.05	969+25.82	744	LT	10	12	6	2-A	13.7	131	87.33	5	3.3	103.7	* 171.6	
5	969+25.82	970+68.48	744	LT	74	8	6	1-B	26.2	21	14.00	6	4	44.9		
6	970+68.48	974+00.19	744	LT	24	12	6	2-C	49.8	277	184.67	24	16	216.5		1
6	971+40.00	971+65.00	744	LT												
TOTAL					108	89.7				286.0		23.3		365	172	1

(PEDESTRIAN FACILITIES CONT.) ADA LINEAR GRADING AND HANDRAIL							
SHEET	STATION	STATION	LOCATION	OFFSET	ADA LINEAR GRADING LF	HANDRAIL LF	REMARKS
5	967+71.05	969+53.10	744	LT	147		NE QUADRANT TO WESTERN AVE
5	969+34	970+68	744	LT	44		WEST OF WESTERN AVE TO EDGE OF PAGE
6	970+68	974+00	744	LT	274		EDGE OF PAGE TO EAST OF AIRPORT PLAZA
6	971+40	971+65	744	LT		25	ALONG 2:1 SLOPE, NO BALUSTERS
TOTAL					465	25	

*			
S CURB LESS THAN 6" =	14	969+26	969+40
S CURB GREATER THAN 6" =	14	968+12	969+26
MODIFIED S-CURB =	144	967+74.5	969+12


CURB AND GUTTER										
SHEET	STATION	STATION	LOCATION	OFFSET	TYPE B C&G	TYPE A GUTTER	6" TYPE 5 AGGREGATE	4" TYPE 5 AGGREGATE	REMARKS	NOTES
					LF	LF	SY	SY		
4,5	961+71.87	965+78.95	744	LT	348.6	19.6	116.2	6.53	WEST LEG NORTH SIDE	Not including paved approach and radii
4,5	963+19.68	965+27.78	744	RT	197.3	34.0	65.8	11.33	WEST LEG SOUTH SIDE	Not including paved approach and radii
5,6	968+31.08	972+63.22	744	LT	309.2	17.8	103.1	5.93	EAST LEG NORTH SIDE	Not including paved approach and radii
7,5	980+70.45	982+77.74	160	RT	199.5	29.8	66.5	9.93	NORTH LEG WEST SIDE	Not including radii
8,5	103+32.15	811+86.73	160	LT	205.0		68.3		SOUTH LEG WEST SIDE	Not including radii
8,5	103+32.15	811+59.15	160	RT	172.4	7.2	57.5	2.40	SOUTH LEG EAST SIDE	Not including radii
5	965+78.95	966+49.10	744	LT	140.0		46.7		NW QUADRANT RADIUS	
5	965+27.78	966+54.52	744	RT	159.4		53.1		SW QUADRANT RADIUS	
5	967+49.13	968+21.90	744	RT	144.1	10.2	48.0	3.40	SE QUADRANT RADIUS	
5	967+43.09	968+31.29	744	LT	113.9	20.4	38.0	6.80	NE QUADRANT RADIUS	
TOTAL					1,989	139	663	46		

CURB AND GUTTER, TYPE A						
SHEET	STATION	LOCATION	OFFSET	NET LENGTH	4" TYPE 5 AGGR.	REMARKS
				LF	SY	
4	963+75.51	744	LT	72	24	ENTRANCE 1
5	969+83.60	744	LT	110	36.7	WESTERN AVE.
6	973+15.54	744	RT	97	32.3	AIRPORT PLAZA AVE.
TOTAL				279	93	

LINEAR GRADING CLASS 1					
SHEET	STATION	ROUTE	LOCATION	STA	REMARKS
4	963+87	744	LT	0.30	ENTERANCE 1
5	969+83	744	LT	0.38	WESTERN AVE
6	973+16	744	LT	0.40	N. AIRPORT PLAZA AVE.
TOTAL =				1.1	

8 IN. CONCRETE MEDIAN STRIP				
8" MEDIAN STRIP				
SHEET	LOCATION	STATION	SY	REMARKS
5	INTERSECTION	966+36	49.22	NW ISLAND (1)
5	INTERSECTION	966+13	92.07	SW ISLAND (4)
5	INTERSECTION	967+67	34.93	NE ISLAND (2)
5	INTERSECTION	967+64	59.45	SE ISLAND (3)
4,5	744	965+75	171.80	WEST MEDIAN
5,8	160	966+84	164.13	SOUTH MEDIAN
5,6	744	968+17	127.42	EAST MEDIAN
5,7	160	967+13	370.65	NORTH MEDIAN
		TOTAL	1,070	

PAVEMENT EDGE TREATMENT			
SHEET	LOCATION	EDGE TREATMENT LF	REMARKS
25	NB 160	363	NB 160 RT TURN LANE TO EB 744
25	EB 744	624	EB 744 RT TURN LANE TO SB 160
25	SB 160	1,138	SB 160 RT TURN LANE TO WB 744
25	SB 160	580	WB 744 RT TURN LANE TO NB 160
TOTAL		2,705	
NOTE: ALL DROPOFFS SHALL HAVE PAVEMENT EDGE TREATMENT UNTIL FINAL ASPHALT OPERATIONS ARE COMPLETE			

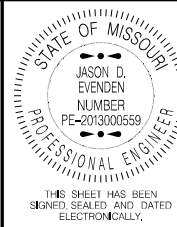

DATE PREPARED 9/23/2021	
ROUTE 744/160	STATE MO
DISTRICT SW	SHEET NO. 3
COUNTY GREENE	
JOB NO. J8P3087D	
CONTRACT ID.	
PROJECT NO.	
BRIDGE NO.	

DESCRIPTION	DATE						

MISSOURI HIGHWAYS AND TRANSPORTATION
COMMISSION



105 WEST CAPITOL
JEFFERSON CITY, MO 65102
1-888-ASK-MODOT (1-888-275-6636)

INLET PROTECTION				
SHEET	STATION	ROUTE	LOCATION	REMARKS
33	961+78	744	LT	WB ON KERNEY
33	963+40	744	LT	WB ON KERNEY
33	964+62	744	LT	WB ON KERNEY
33	964+42	744	RT	EB ON KERNEY
34	965+56	744	LT	WB ON KERNEY
34	966+15	744	LT	MANHOLE
34	969+17	744	LT	WB ON KERNEY
34	970+49	744	LT	WB ON KERNEY
34	983+2	160	RT	SB ON 160
34	984+39	160	RT	SB ON 160
34	983+28	160	LT	NB ON 160
34	982+97	160	LT	NB ON 160
35	971+21	744	LT	WB ON KERNEY
35	971+53	744	LT	WB ON KERNEY
36	981+66	160	RT	SB ON 160
36	981+60	160	LT	NB ON 160
37	810+69	160 S	RT	NB ON 160
37	102+70	160 S	RT	NB ON 160
37	811+27	160 S	LT	SB ON 160
37	103+7	160 S	LT	SB ON 160
37	102+32	160 S	LT	SB ON 160
TOTALS =				21

SEEDING – COOL SEASON MIXTURES		
LOCATION	COOL SEASON MIXTURE ACRE	REMARKS
160SB-744WB	0.13	NW QUADRANT
744EB-160SB	0.07	SW QUADRANT
160NB-744EB	0.04	SE QUADRANT
744WB-160NB	0.07	NE QUADRANT
TOTAL =	1.2	
USE =	1.2	


ADJUSTING BASIN OR INLET				
SHEET	STATION	LOCATION	ADJUSTING BASIN OR INLET EA	REMARKS
6	972+49	744 LT	1	ADJUST EX. DROP INLET TO MATCH NEW SIDEWALK
TOTAL			1	

ADJUSTING MANHOLE				
SHEET	STATION	LOCATION	ADJUSTING MANHOLE EA	REMARKS
5	966+15.58	744 LT	1	ADJUST EX. SANITARY SEWER MANHOLE
TOTAL			1	

ROCK BLANKET, TYPE 1							
SHEET	STATION	STATION	ROUTE	LOCATION	FURNISHING ROCK BLANKET CY	PLACING ROCK BLANKET CY	PERMANENT EROSION CONTROL GEOTEXTILE SY
35	971+00	972+62	744	LT			249.0
35	971+40	971+65	744	LT			64.0
35	971+00	972+62	744	LT	83.00	83.00	
TOTAL =					83	83	313
REMARKS							
COMBINED WITH TYPE 1 ROCK BLANKET							
STABILIZE 2:1 SLOPE							

ADDITIONAL MOBILIZATION FOR SEEDING
4 EACH

CULVERT CLEANOUT		
SHEET	STA.	EA
4	964+60	1
6	971+54	1
TOTAL		2

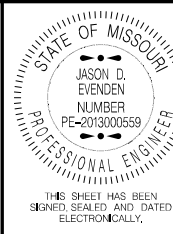

DATE PREPARED 8/26/2021	
ROUTE 744/160	STATE MO
DISTRICT SW	SHEET NO. 3
COUNTY GREENE	
JOB NO. J8P3087D	
CONTRACT ID.	
PROJECT NO.	
BRIDGE NO.	

DESCRIPTION	DATE

MISSOURI HIGHWAYS AND TRANSPORTATION
COMMISSION

105 WEST CAPITOL
JEFFERSON CITY, MO 65102
1-888-ASK-MODOT (1-888-275-6636)

IF A SEAL IS PRESENT ON THIS SHEET IT HAS BEEN ELECTRONICALLY SEALED AND DATED.


DRAINAGE – DROP INLETS, PIPES, CL. 3 EXCAVATION																			
SHEET	STATION	STATION	ROUTE	LOCATION	ELEMENT I.D.	DEPTH	3' X2.5' D.I. TYPE T (LF)	PRECAST 48 INCH CONC. MANHOLE (LF)	MH FRAME & COVER TYPE 3 (EA)	MISCELLANEOUS PIPE						PIPE COLLAR TYPE A (EA)	CL 3 EXCAV. (CY)	REMARKS	
										GRP A 12" (LF)	GRP A 15"(LF)	GRP A 18"(LF)	GRP B 24" (LF)	GRP B 30"(LF)	GRP A (EA) 18" FES				GROUP B 30" FES (EA)
4	964+61.98		744	49.2' LT	CB-1	5.0	10		1									11.8	
4, 5	964+64.98	965+52.50	744	LT	SS -3						91							59.1	
5	965+55.50		744	49.1' LT	CB-2	3.1	6		1									5.6	
4	963+44.74	964+58.98	744	LT	SS -4					114								73.7	
4	963+40.00		744	45.8' LT	CB -3	3.7	12		1									7.5	
4	964+60.23	964+60.23	744	LT	SS -2							11						6.4	SEE CULVERT SECTION
4	964+60.23		744	34.4' LT	CB -5	5.0		5	1									17.2	SEE CULVERT SECTION
	964+60.25	264+60.30	744	RT	SS -1							28			1	1		15.7	SEE CULVERT SECTION
5	969+16.00		744	61' LT	CB -6	3.8	16		1									10.6	
5	969+22.50	970+42.51	744	LT	SS -5							120						77.0	
5	970+49.00		744	60.5' LT	CB -7	4.0	16		1									18.7	
5, 6	970+55.49	971+52.16	744	LT	SS -6							111						123.2	TIE INTO EX. BOX CULVERT
8	103+08.78	811+23.33	160 S	LT	SS -10								163					62.1	TIE INTO EXISTING D.I.
8	811+27.97		160 S	47.3' LT	CB -13	5.1	10		1									17.1	
8	811+26.36	811+25.79	160 S	LT	SS -11									14		1		6.2	
TOTALS =							70	5	7	114	91	270	163	14	1	1	1	512	

TEMPORARY EROSION CONTROL						
SHEET	ROUTE	LOCATION	SILT FENCE LF	ROCK DITCH CHECK LF	SEDIMENT REMOVAL CY	REMARKS
33	744	LT	320	16	3	WEST LEG, NORTH SIDE
33	744	RT	140	0	1	WEST LEG, SOUTH SIDE
34	744	LT	100	0	1	WEST LEG, NORTH SIDE
34	744/160	RT	245	0	2	SOUTHWEST INTERSECTION CORNER
34	744	RT	0	80	5	EAST LEG, SOUTH SIDE. 5 AT 43' SPACING
34	160	LT	0	32	2	SOUTH LEG, EAST SIDE. 2 AT 150' SPACING
34	160	RT	0	16	1	NORTH LEG, WEST SIDE.
34	160	LT	0	32	2	NORTH LEG, EAST SIDE. 2 AT 60' SPACING
35	744	RT	0	48	3	EAST LEG. 2 AT 75' SPACING. 1 AT OUTFLOW
36	160	LT	0	16	1	NORTH LEG, EAST SIDE. 1 DITCH CHECK
36	160	RT	0	48	3	NORTH LEG, WEST SIDE. 3 AT 150' SPACING
36	160	RT	0	80	5	NORTH LEG, WEST SIDE. 5 AT 38' SPACING
37	160	RT	185	0	2	SOUTH LEG, WEST SIDE
37	160	LT	0	32	2	SOUTH LEG, EAST SIDE. 2 AT 150' SPACING
TOTALS =			990	400	33	

ROCK LINING					
SHEET	STATION	ROUTE	LOCATION	CY	REMARKS
4	961+53	744	LT	1.2	D=1', W=4', L=8'
4	964+40	744	RT	4.4	D=1', W=10', L=12'
4	964+60	744	RT	3.6	D=1', W=8', L=12'
5	982+88	160	RT	1.2	D=1', W=4', L=8'
5	982+85	160	LT	1.2	D=1', W=4', L=8'
5	811+26	160S	LT	3.1	D=1', W=6', L=14'
5	812+4	160S	RT	1.2	D=1', W=4', L=8'
6	971+23	744	LT	4.4	D=1', W=10', L=12'
7	981+58	160	RT	1.1	D=1', W=4', L=8'
8	8810+72	160S	RT	0.6	D=1', W=4', L=4'
			TOTAL =	22	

LANDSCAPE RELOCATION AT WESTERN AVE.
1 LUMP SUM

CONNECTION TO EXIST. BOX CULVERT
1 EACH

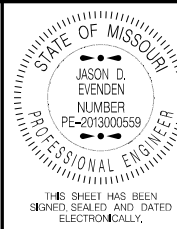

DATE PREPARED 8/26/2021	
ROUTE 744/160	STATE MO
DISTRICT SW	SHEET NO. 3
COUNTY GREENE	
JOB NO. J8P3087D	
CONTRACT ID.	
PROJECT NO.	
BRIDGE NO.	

DATE	DESCRIPTION

MISSOURI HIGHWAYS AND TRANSPORTATION COMMISSION


105 WEST CAPITOL
JEFFERSON CITY, MO 65102
1-888-ASK-MODOT (1-888-275-6636)

IF A SEAL IS PRESENT ON THIS SHEET IT HAS BEEN ELECTRONICALLY SEALED AND DATED.

PAVEMENT REPAIR – FULL DEPTH & PARTIAL DEPTH												
LOCATION	LENGTH	WIDTH	FULL DEPTH REPAIR							CLASS A PARTIAL DEPTH REPAIR		
			FURNISHING & PLACING FULL DEPTH CONCRETE	SUBGRADE COMPACTION (6")	TYPE 5 AGGREGATE (4")	FULL DEPTH SAW CUT	DOWEL BARS	DOWEL BARS W/ BASKETS	TIE BARS	FURNISHING & PLACING CONCRETE MATERIAL	REMOVAL	REMARKS
			SY	SY	SY	FT	EA	EA	EA	CY	SY	
744/160	VAR	VAR	375	38.0	38.0	1715	560	0	0	1.4	25	
TOTAL			375	38	38	1715	560	0	0	1.4	25	

TEMPORARY SURFACING			
SHEET	LOCATION	TEMPORARY SURFACING CY	REMARKS
25	744 LT	24.8	WESTERN AVE. ENTRANCE
TOTAL		25	

PAVED APPROACH, 8 IN						
SHEET	LOCATION	STATION	ENT. WIDTH	8" CONC PAVED APPROACH	4" TYPE 1 AGGREGATE BASE	REMARKS
			FT	SY	SY	
4	744	963+75.51	30	117.2	117.2	ENTRANCE 1
5	744	969+83.62	30	201.3	201.3	WESTERN AVE
6	744	973+15.39	45	228.7	228.7	AIRPORT PLAZA
TOTALS				547.2	547.2	

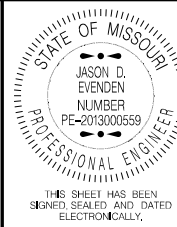

DATE PREPARED 8/26/2021	
ROUTE 744/160	STATE MO
DISTRICT SW	SHEET NO. 3
COUNTY GREENE	
JOB NO. J8P3087D	
CONTRACT ID.	
PROJECT NO.	
BRIDGE NO.	

DATE	DESCRIPTION

MISSOURI HIGHWAYS AND TRANSPORTATION
COMMISSION

105 WEST CAPITOL
JEFFERSON CITY, MO 65102
1-888-ASK-MODOT (1-888-275-6636)

IF A SEAL IS PRESENT ON THIS SHEET IT HAS BEEN ELECTRONICALLY SEALED AND DATED.

DATE PREPARED 8/26/2021	
ROUTE 160/744	STATE MO
DISTRICT SW	SHEET NO. 3

J8P3087D

BRIDGE NO.				

NOTION

[illegible]

DATE					
------	--	--	--	--	--

WEST CA
TY, MO
88-275-

U.S. DEPARTMENT OF ENERGY
OFFICE OF ENERGY EFFICIENCY & RENEWABLE ENERGY

M	V

11

11

11

1

③
SKYLINE INV CO LLC

TAU MIDWEST LLC

SNA INVESTMENTS LLC


JADE PROPERTIES LLC

N. AIRPORT PLAZA AVE.
PAVED APPROACH 973+15.54
W = 45' GR = +2.35%
LG CL 1 = 0.40 STA

SW 1/4, SW 1/4
4-29-22



④
KELLER, KARL W TRUST

NW 1/4, NW 1/4
9-29-22

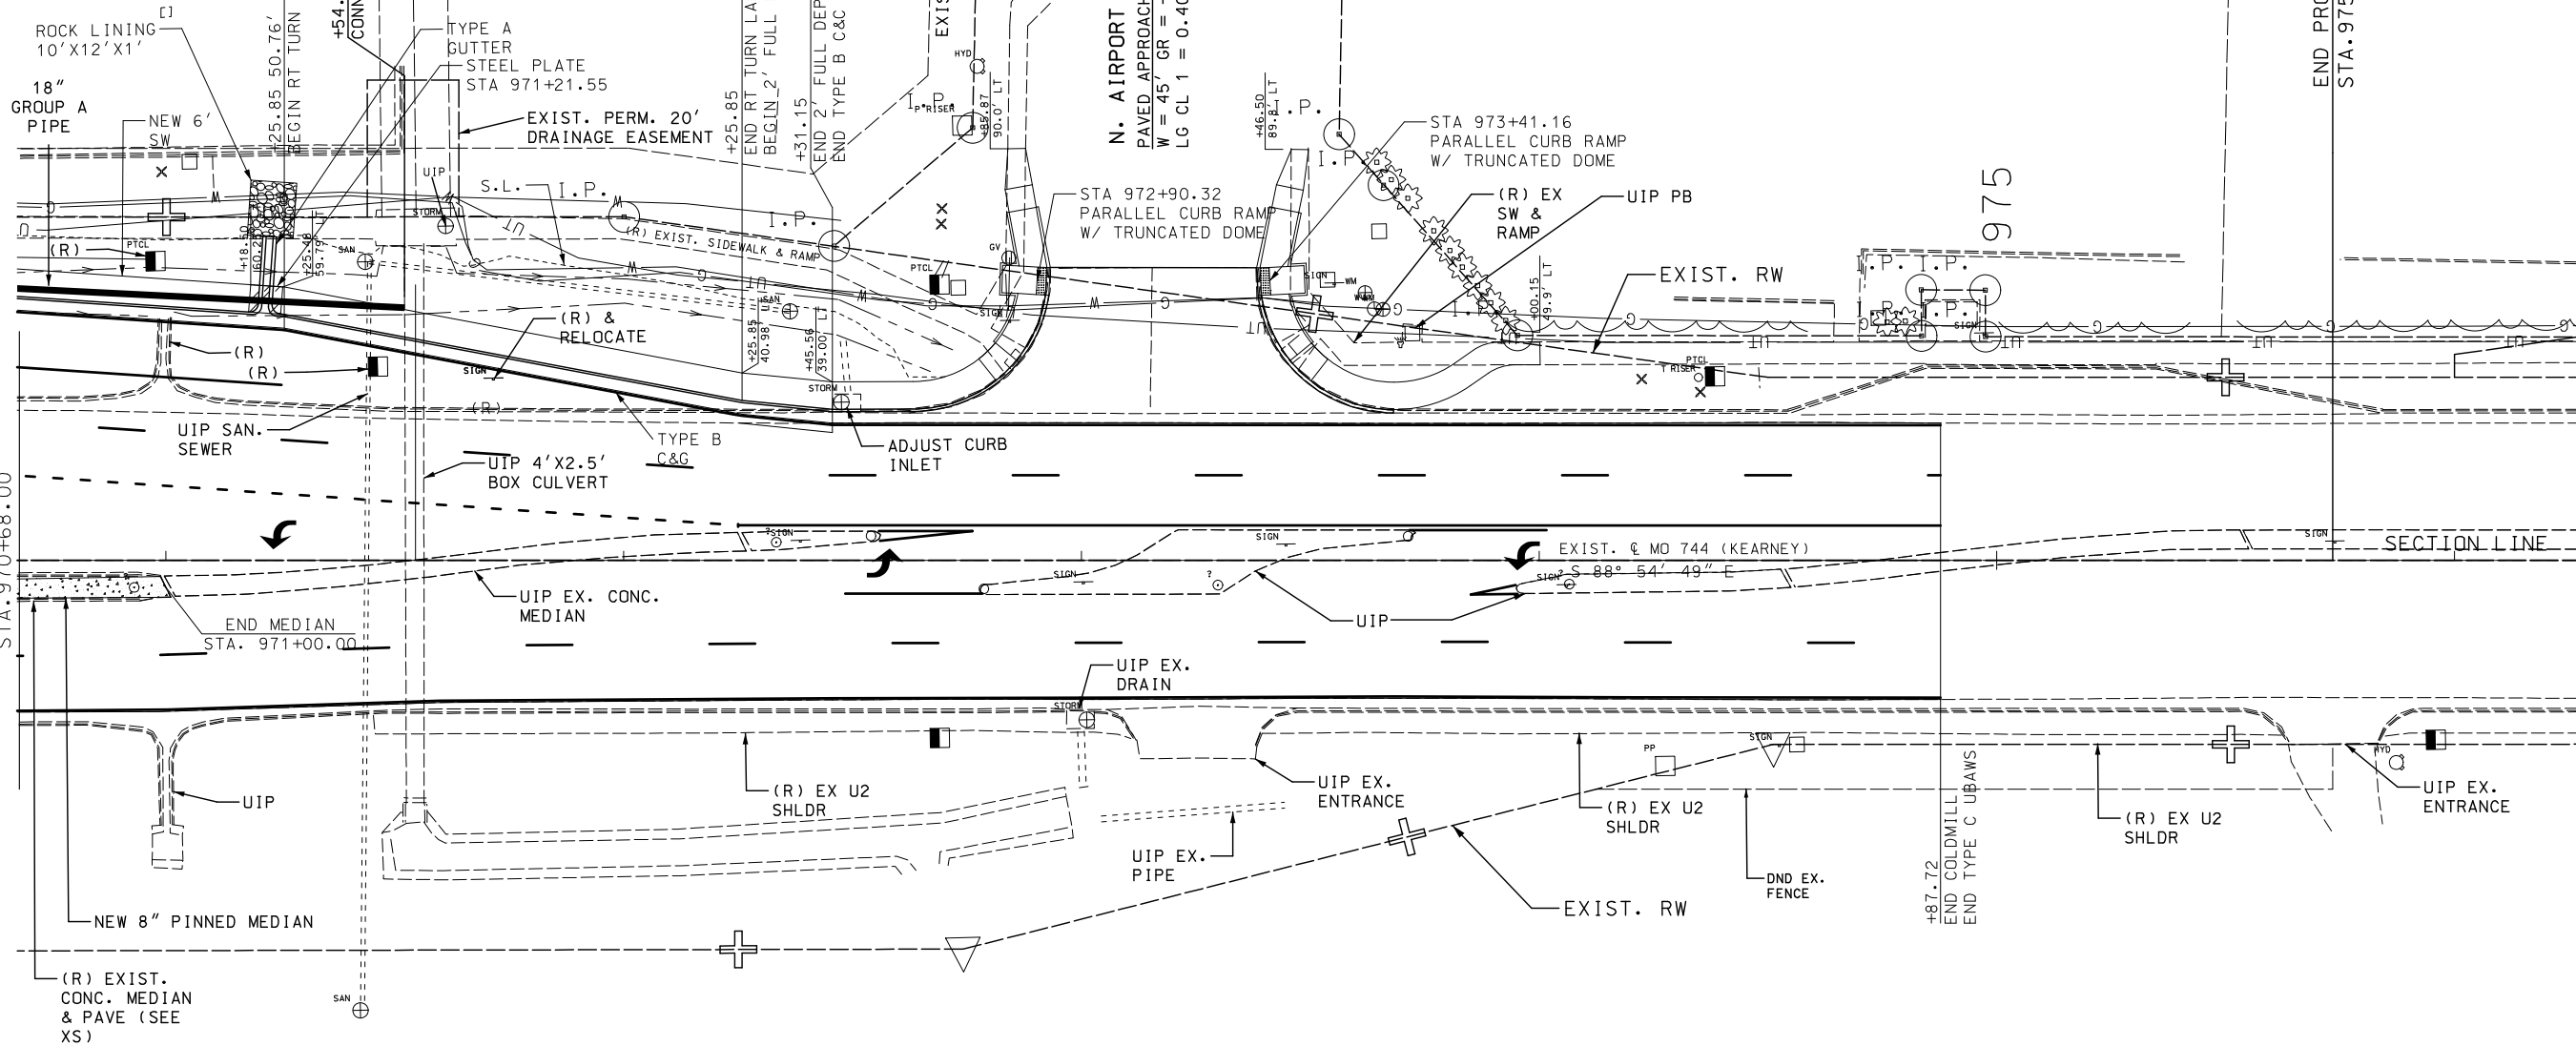


EXISTING AND CONSTRUCTED ENTRANCES MAY
BE WIDENED TO A MAXIMUM WIDTH OF 60'
BY PERMIT UNLESS OTHERWISE NOTED.

 NEW 8" PINNED CONCRETE MEDIAN

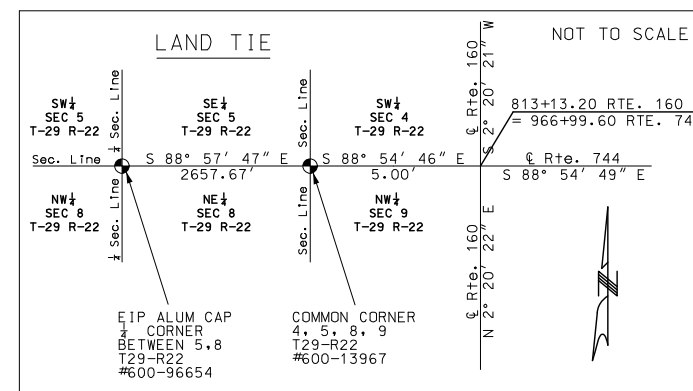

PLAN SHEET
SHEET 3 OF 5

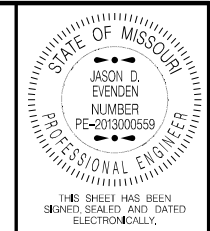


DATE PREPARED 8/5/2021	
ROUTE 744/160	STATE MO
DISTRICT SW	SHEET NO. 6
COUNTY GREENE	
JOB NO. J8P3087D	
CONTRACT ID.	
PROJECT NO.	
BRIDGE NO.	

DESCRIPTION	DATE

MISSOURI HIGHWAYS AND TRANSPORTATION
COMMISSION

105 WEST CAPITOL
JEFFERSON CITY, MO 65102
1-888-ASK-MODOT (1-888-275-6636)

IF A SEAL IS PRESENT ON THIS SHEET IT HAS BEEN ELECTRONICALLY SEALED AND DATED.

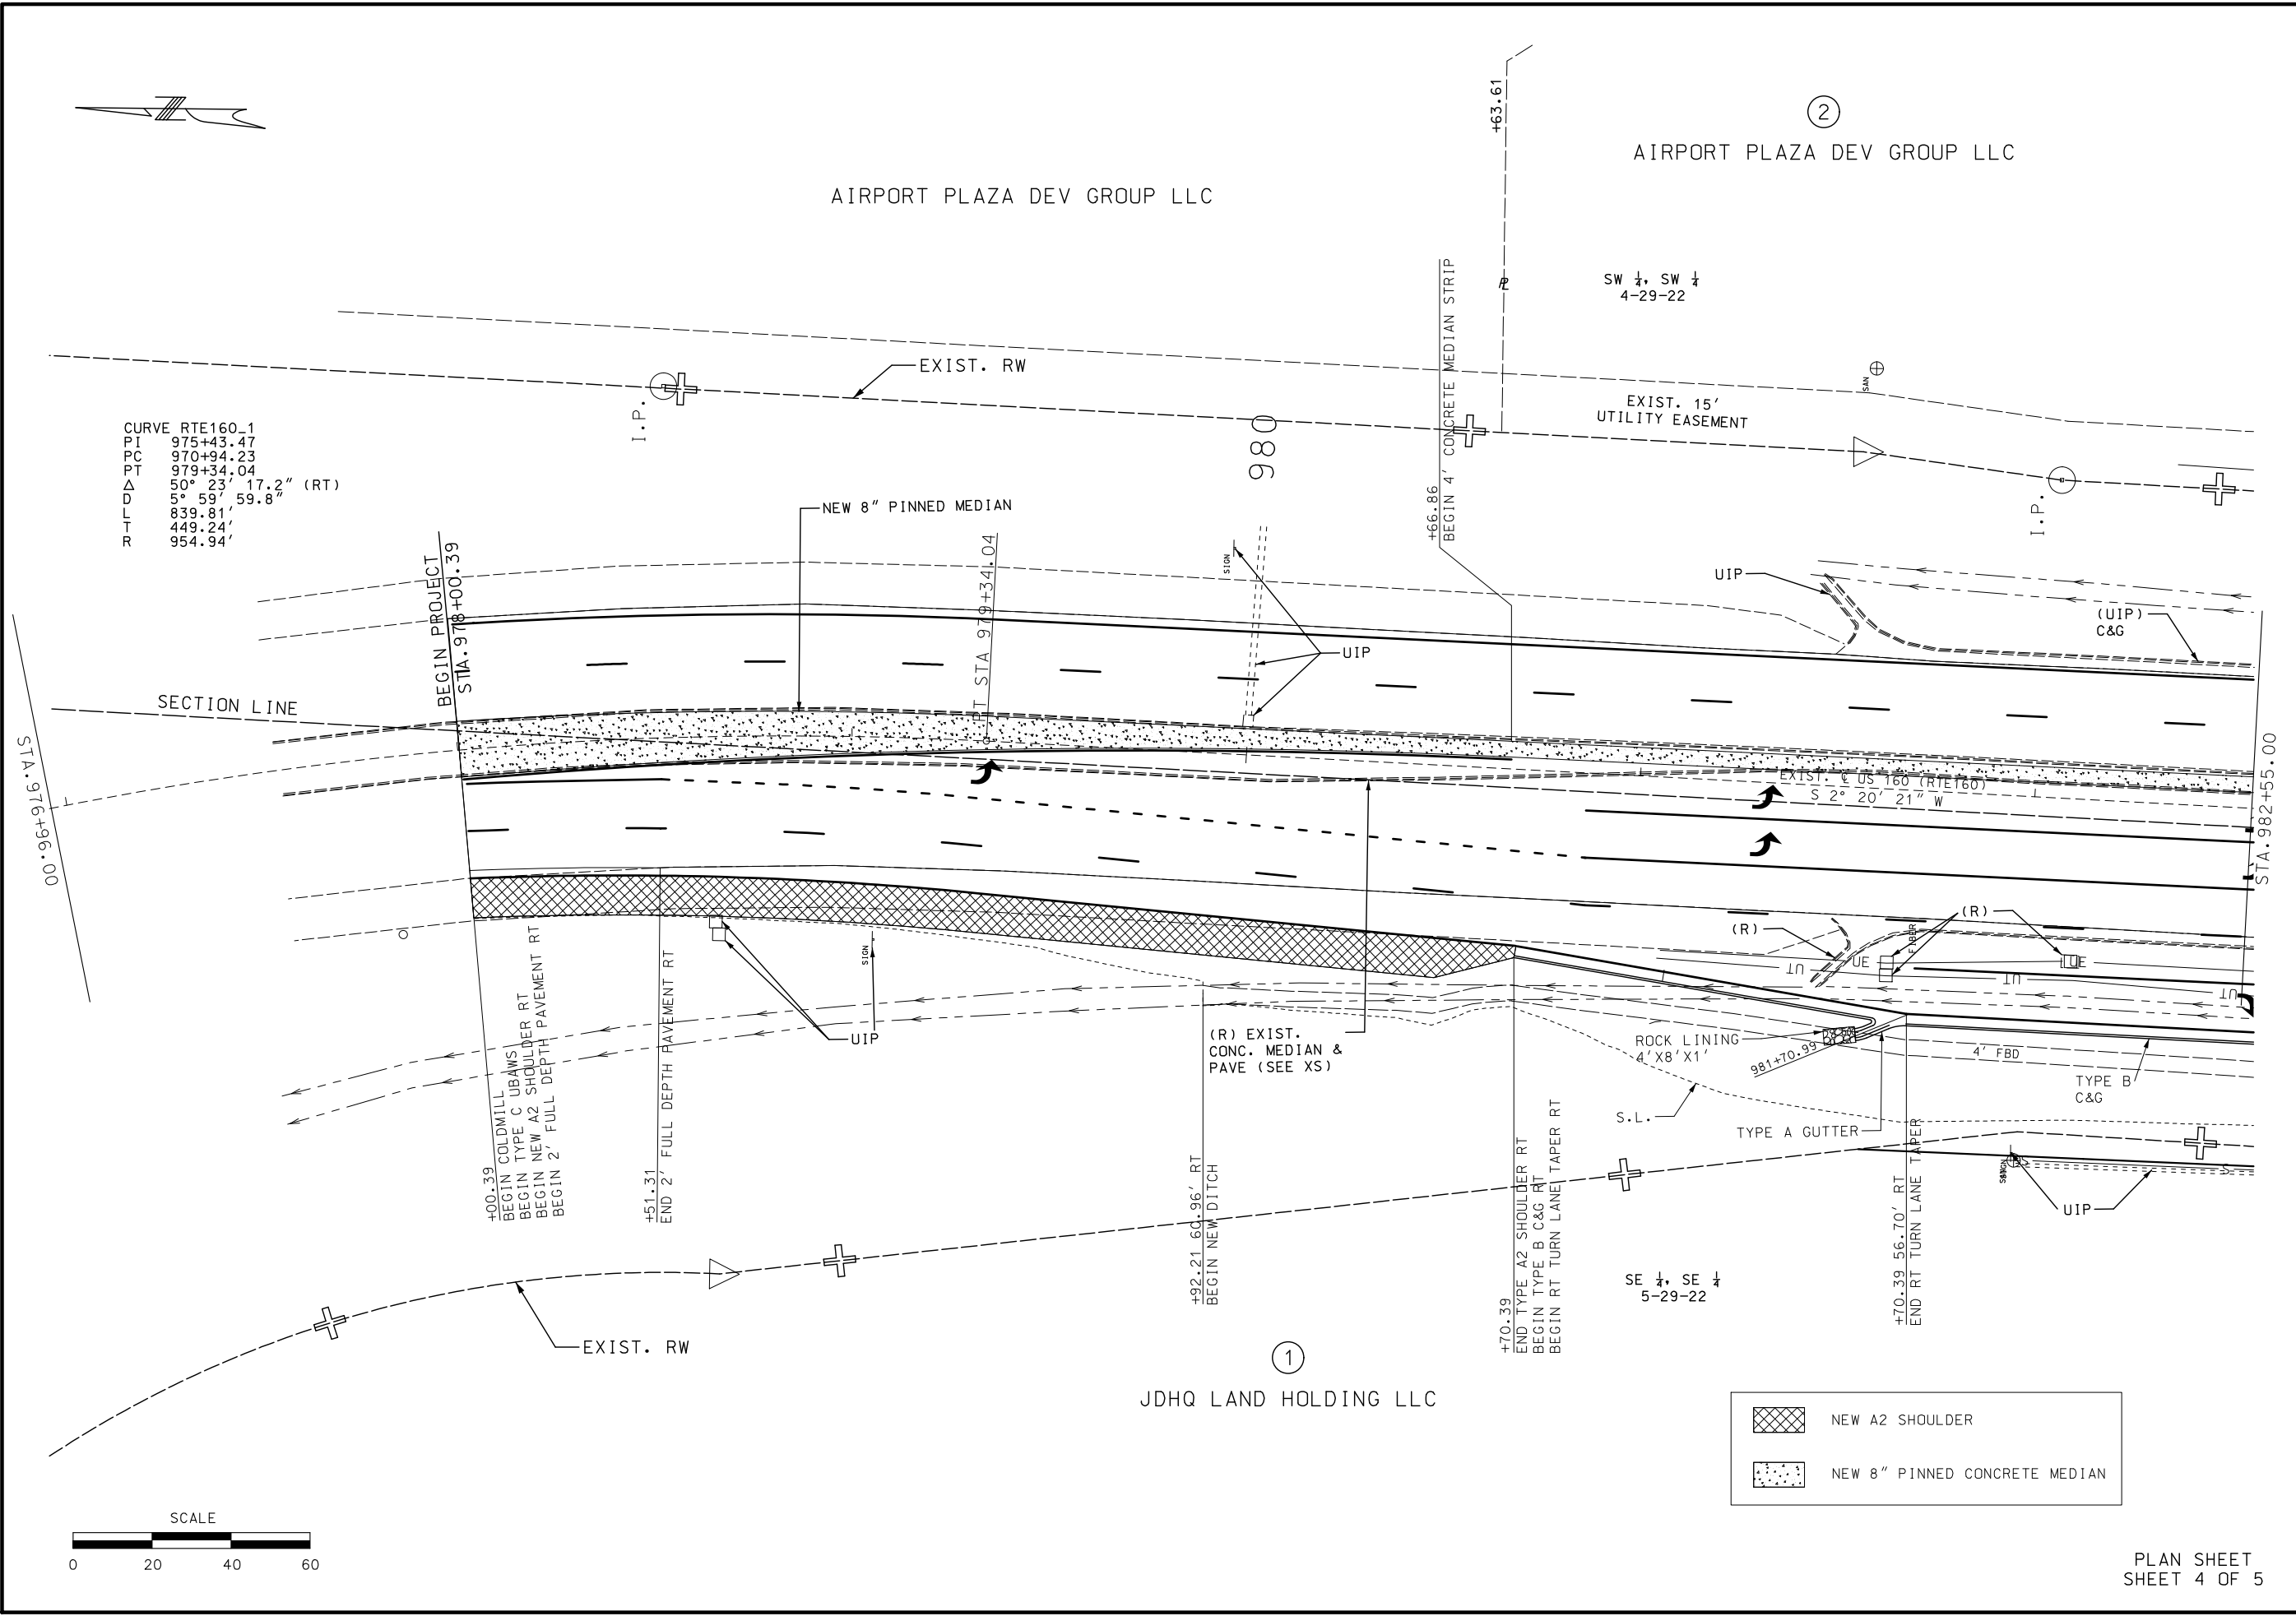

STATE OF MISSOURI

JASON D. EVENDEN

NUMBER

PE-2013000659

PROFESSIONAL ENGINEER

THIS SHEET HAS BEEN

SIGNED, SEALED AND DATED

ELECTRONICALLY.

DATE PREPARED

8/5/2021

ROUTE

744/160

STATE

MO

DISTRICT

SW

SHEET NO.

7

COUNTY

GREENE

JOB NO.

J8P3087D

CONTRACT ID.

PROJECT NO.

BRIDGE NO.

MISSOURI HIGHWAYS AND TRANSPORTATION

COMMISSION

105 WEST CAPITOL

JEFFERSON CITY, MO 65102

1-888-ASK-MODOT (1-888-275-6636)

IF A SEAL IS PRESENT ON THIS SHEET IT HAS BEEN ELECTRONICALLY SEALED AND DATED.



SMITH COMMERCIAL
ENTERPRISES LP

NE 1/4, NE 1/4
8-29-22

REX SMITH TRANSPORT INC

SMITH COMMERCIAL ENT LP

NW 1/4, NW 1/4
9-29-22

STA. 99+26.00

SECTION LINE

EXIST. C US 160 (RTE160-SOUTH)
N 2° 20' 22" E

+17.85
BEGIN COLDMILL
BEGIN TYPE C UBAWS

+83.55
BEGIN 4' MEDIAN

BEGIN PROJECT
STA. 101+17.85

NEW 8" PINNED MEDIAN

+07.57 37.6' LT
CONNECT EXIST. TYPE T D.I.

(R) &
RELOCATE
+32.14
BEGIN 2' FULL DEPTH PAVEMENT LT
BEGIN TYPE B C&G LT

+61.67
END 2' FULL DEPTH PAVEMENT LT
BEGIN PAVEMENT WIDENING LT

S.L.
UIP

30" GROUP B PIPE
TYPE B
C & G
24" GROUP B PIPE

ROCK LINING
6' X14' X1'

+26.26 65.0' LT
30" GRP B FES
+27.97 47.27' LT
TYPE T D.I.

EQUATION:
STA 810+47.58 AH =
STA 813+97.60 BK =

(R) &
RELOCATE
TYPE B
C & G
ROCK LINING
4' X4' X1'

(R)

(R)

(R)

(R)

(R)

(R)

4' FBD

TYPE A
GUTTER

S.L.

UE

G

 
+71.07 56.48' RT
BEGIN NEW DITCH

+81.75 45.43' RT
END RT TURN LANE TAPER RT


+31.77
BEGIN 2' FULL DEPTH PAVEMENT RT
BEGIN TYPE B C&G RT
+47.90
END 2' FULL DEPTH PAVEMENT RT
BEGIN RT TURN LANE TAPER RT

(R) EXIST.
CONC. MEDIAN &
PAVE (SEE XS)

NEW 8" PINNED CONCRETE MEDIAN



PLAN SHEET
SHEET 5 OF 5

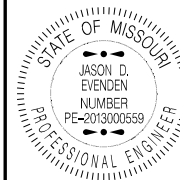

THIS SHEET HAS BEEN
SIGNED, SEALED AND DATED
ELECTRONICALLY.

DATE PREPARED
8/5/2021

ROUTE 744/160 STATE MO
DISTRICT SW SHEET NO. 8

COUNTY GREENE
JOB NO. J8P3087D
CONTRACT ID.

PROJECT NO.


BRIDGE NO.

DATE	DESCRIPTION


MISSOURI HIGHWAYS AND TRANSPORTATION
COMMISSION

105 WEST CAPITAL
JEFFERSON CITY, MO 65102
1-888-ASK-MODOT (1-888-275-6636)

 
IF A SEAL IS PRESENT ON THIS SHEET IT HAS BEEN ELECTRONICALLY SEALED AND DATED.




NORTHWEST EDGE OF PAVEMENT
RADIUS PROFILE

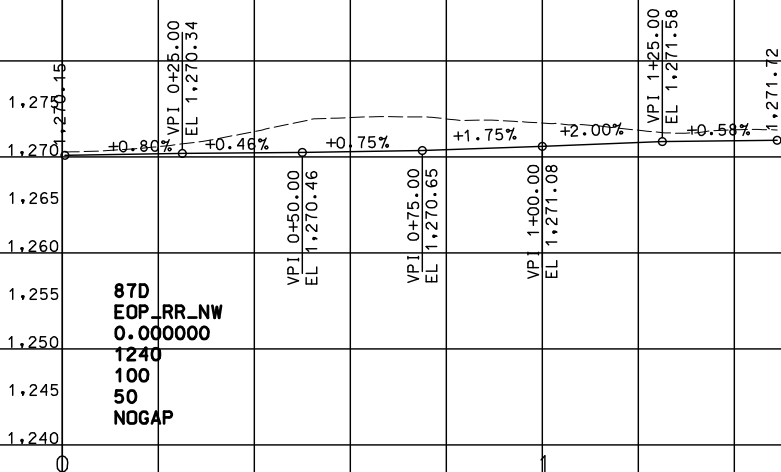



NORTHEAST EDGE OF PAVEMENT
RADIUS PROFILE

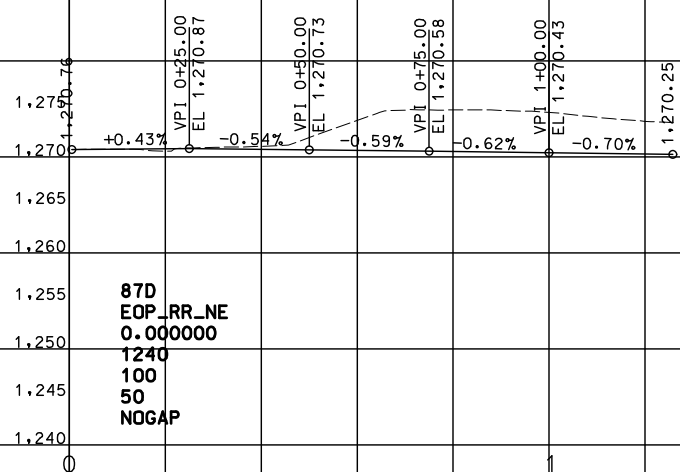

SOUTHWEST EDGE OF PAVEMENT
RADIUS PROFILE

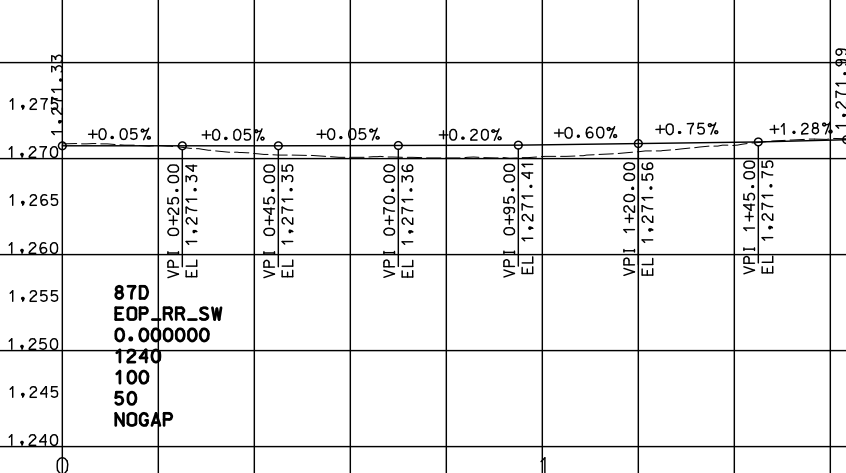

SOUTHEAST EDGE OF PAVEMENT
RADIUS PROFILE

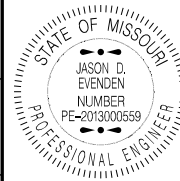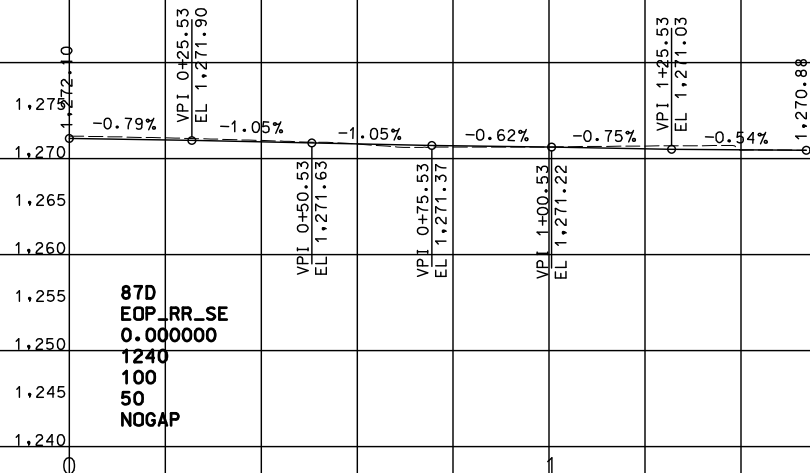

THIS SHEET HAS BEEN
SIGNED, SEALED AND DATED
ELECTRONICALLY.

DATE PREPARED
8/5/2021

ROUTE
744/160

DISTRICT
SW

STATE
MO

SHEET NO.
10

COUNTY
GREENE

JOB NO.
J8P3087D

CONTRACT ID.

PROJECT NO.

BRIDGE NO.

DESCRIPTION

DATE


MISSOURI HIGHWAYS AND TRANSPORTATION
COMMISSION

105 WEST CAPITOL
JEFFERSON CITY, MO 65102
1-888-ASK-MODOT (1-888-275-6636)

MODOT


PROFILE SHEET
EOP RADII

ENTRANCE 1 PROFILE
RTE. 744 STA. 963+75.51

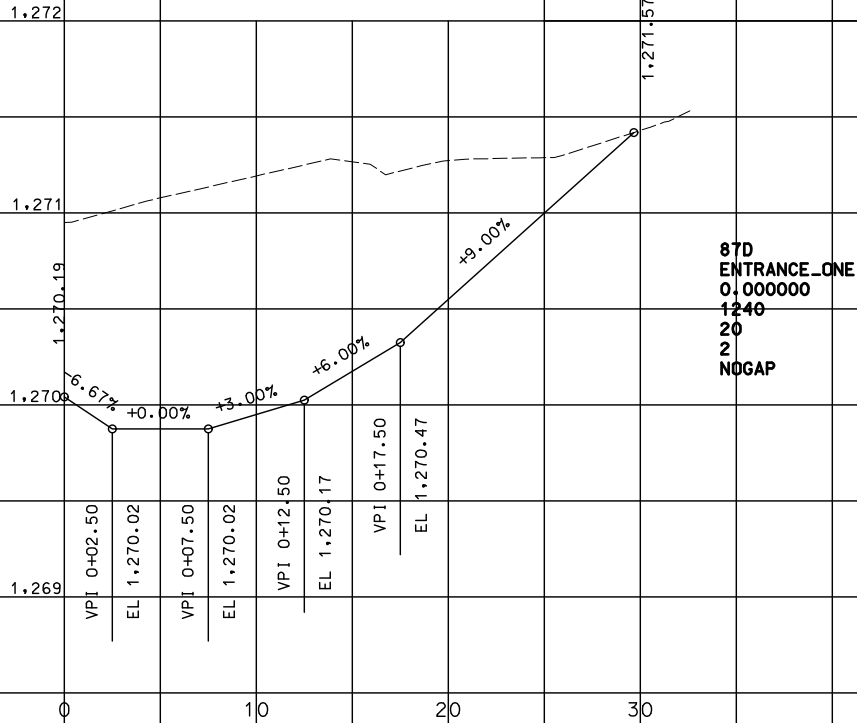


87D
ENTRANCE_ONE
0.000000
1240
20
2
NOGAP

WESTERN AVE PROFILE
RTE. 744 STA. 969+83.60

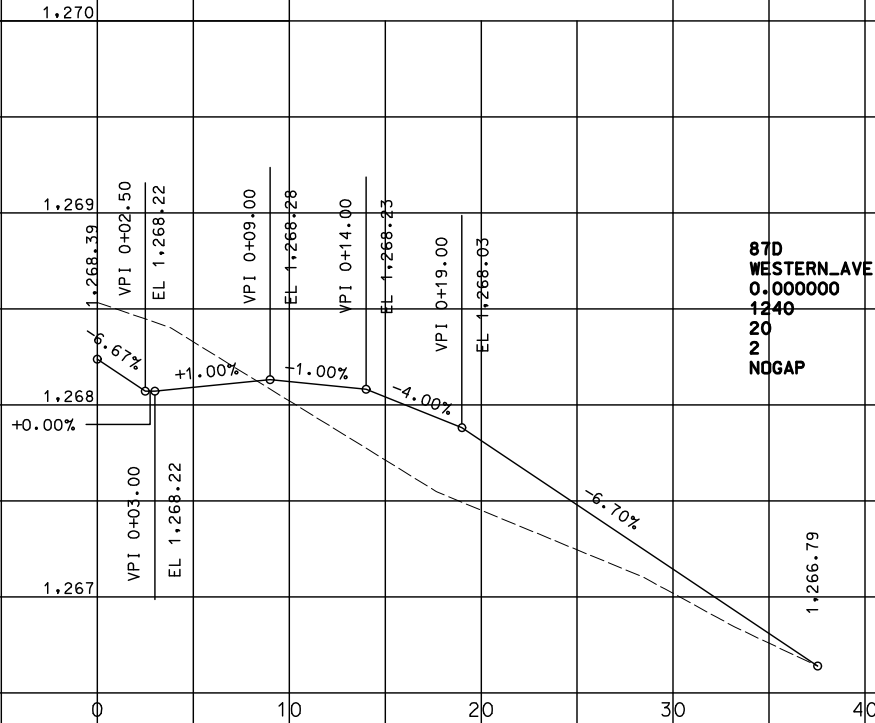


87D
WESTERN_AVE
0.000000
1240
20
2
NOGAP

AIRPORT PLAZA AVE PROFILE
RTE. 744 STA. 973+15.54

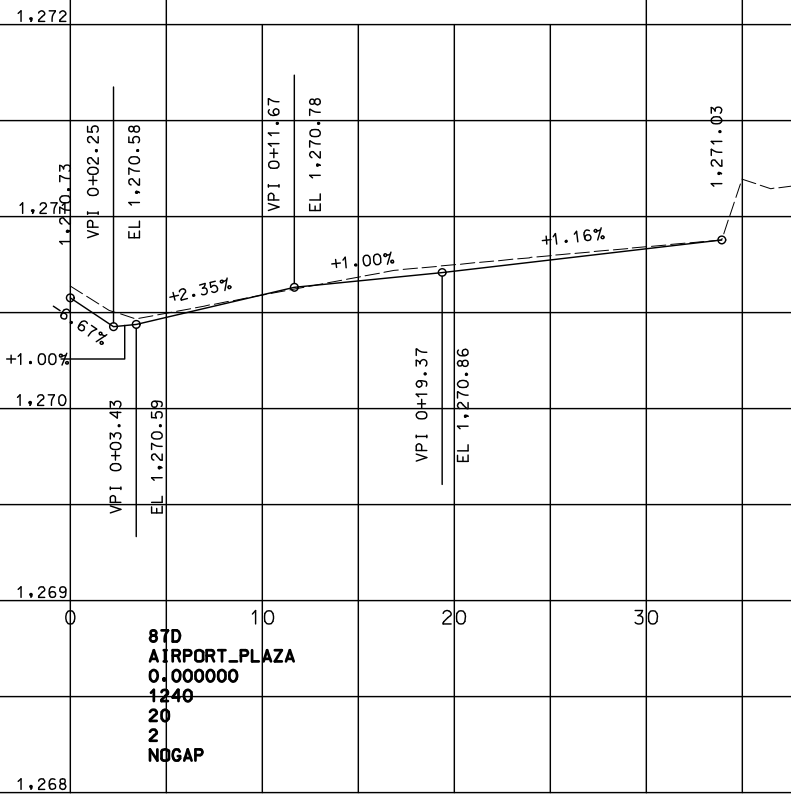

87D
AIRPORT_PLAZA
0.000000
1240
20
2
NOGAP

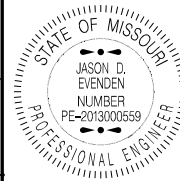

THIS SHEET HAS BEEN
SIGNED, SEALED AND DATED
ELECTRONICALLY.

DATE PREPARED
8/6/2021

ROUTE
744/160

DISTRICT
SW

STATE
MO

SHEET NO.
11

COUNTY
GREENE

JOB NO.
J8P3087D

CONTRACT ID.

PROJECT NO.

BRIDGE NO.

DESCRIPTION

DATE

MISSOURI HIGHWAYS AND TRANSPORTATION
COMMISSION

105 WEST CAPITOL
JEFFERSON CITY, MO 65102
1-888-ASK-MODOT (1-888-275-6636)

MoDOT


PROFILE SHEET
ENTRANCE PROFILES

IF A SEAL IS PRESENT ON THIS SHEET IT HAS BEEN ELECTRONICALLY SEALED AND DATED.

ANY WORK INDICATED ON THE PLANS THAT EXTENDS BEYOND THE PROJECT LIMITS IS CONSIDERED INCIDENTAL TO AND A PART OF THE CONSTRUCTION OF THIS PROJECT.

SE $\frac{1}{4}$, SE $\frac{1}{4}$
5-29-22

JDHQ LAND HOLDING LLC
1849 SF NEW R/W
3893 SF TEMP. ESM'T. (CONST.)
8.76 ACRES REMAINING

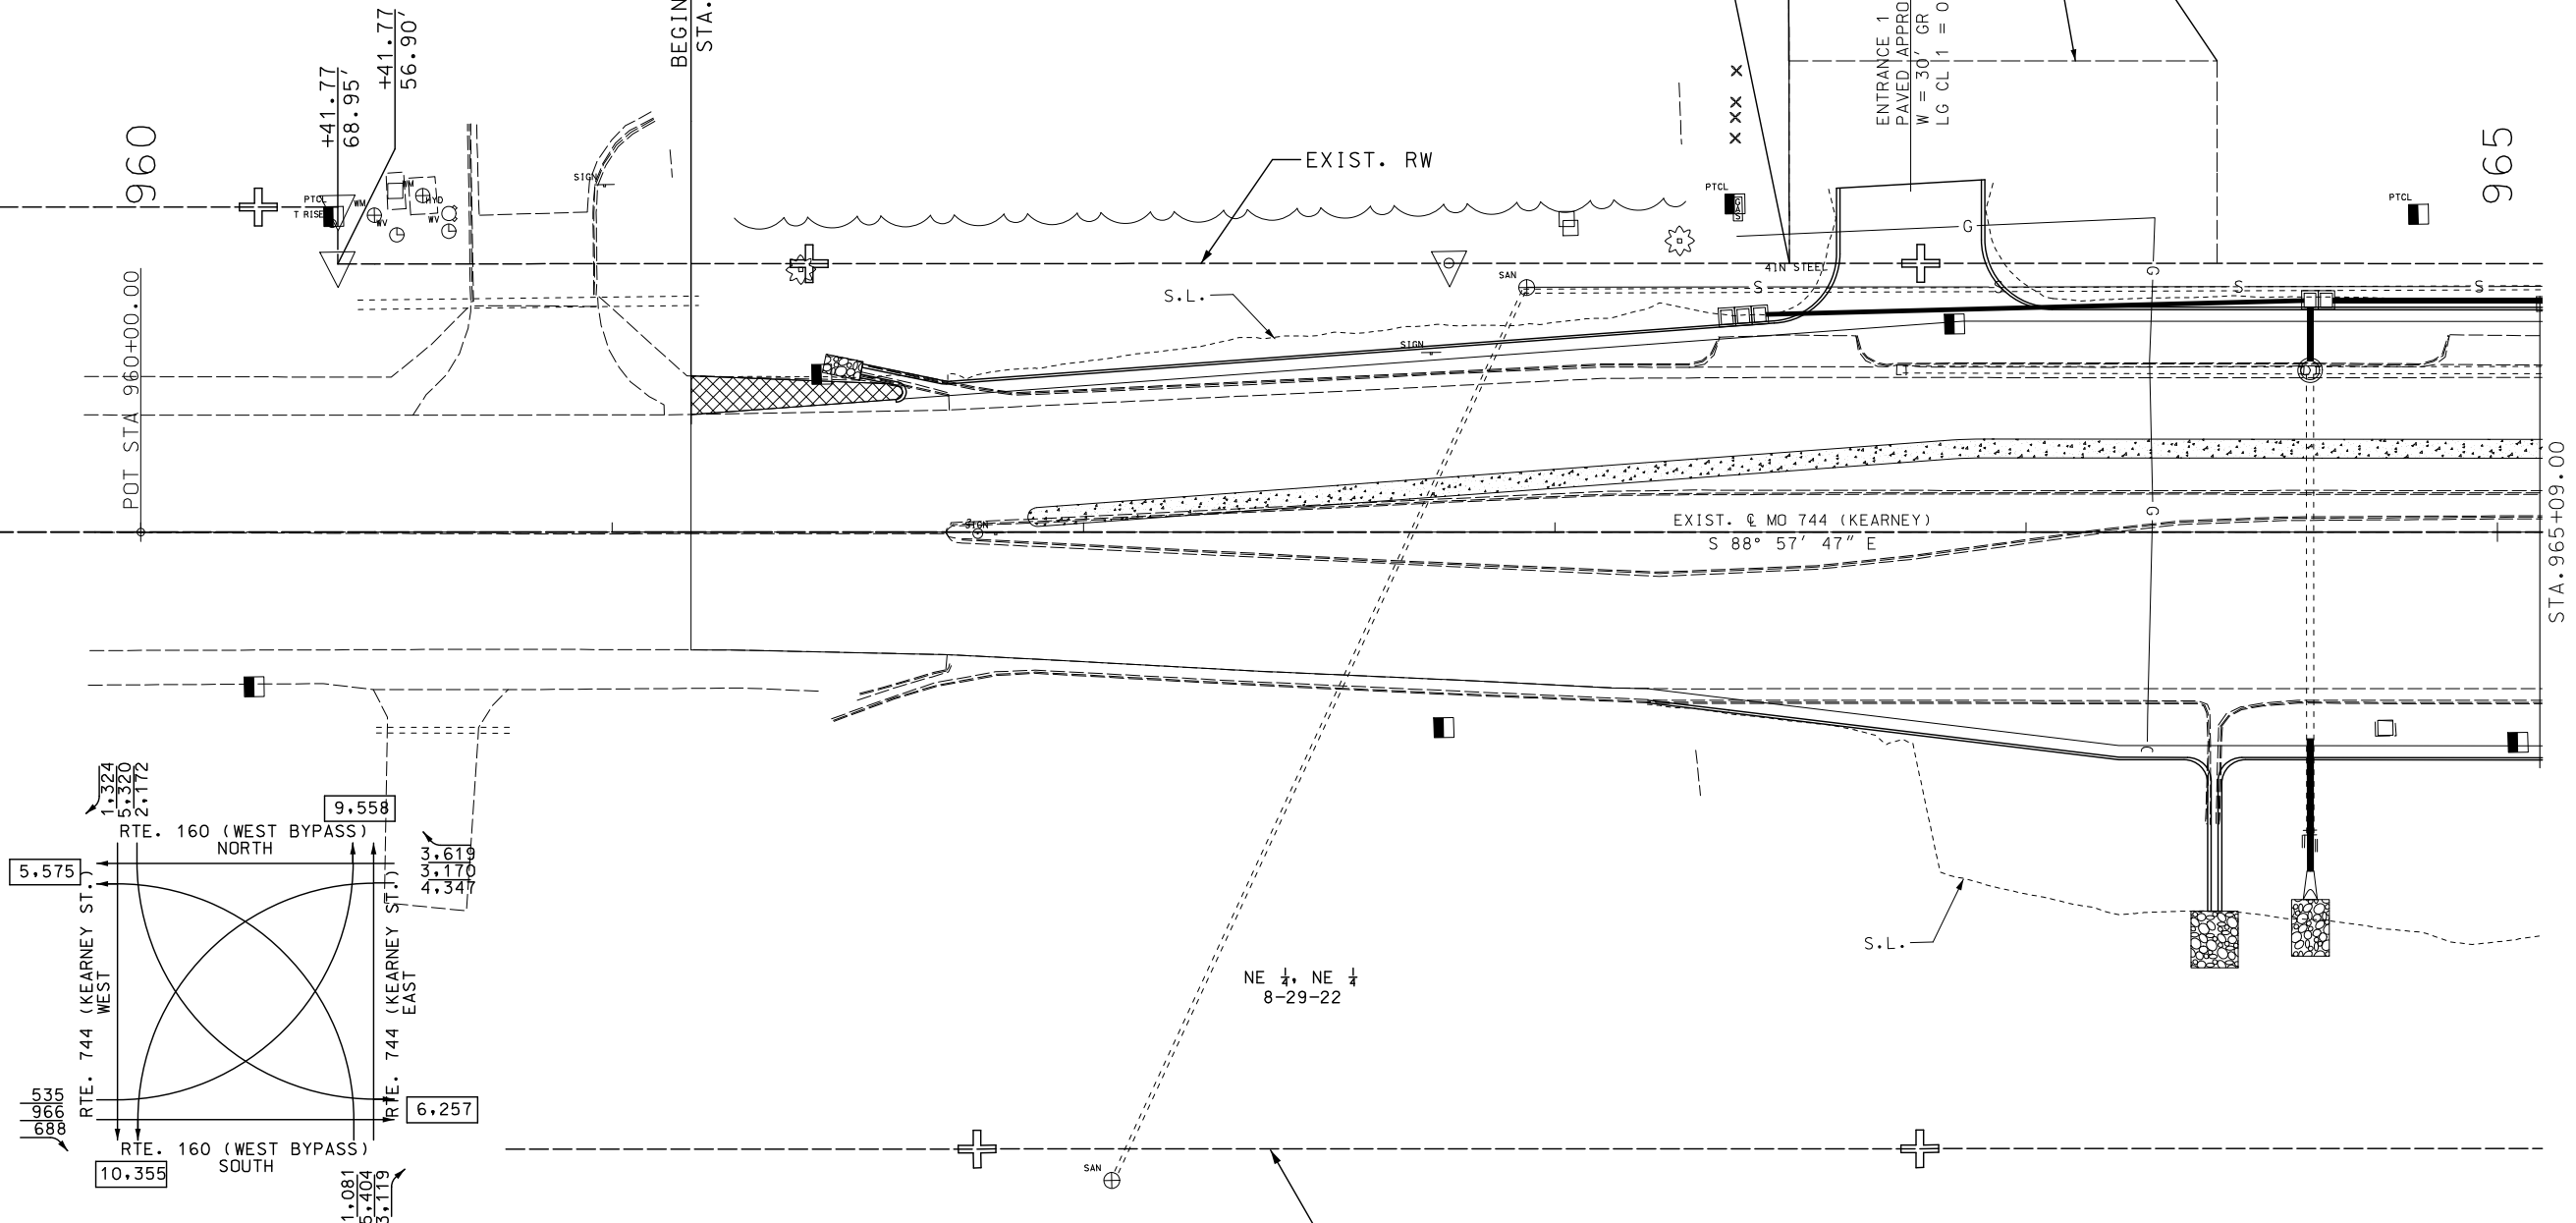


RIGHT OF WAY LIMITS FOR THIS PROJECT EXTEND ALONG RTE. 160 FROM STATION 978+00.39 TO STATION 101+17.85, A DISTANCE OF 0.224 MILES, AND ALONG RTE. 744 FROM STATION 961+16.71 TO STATION 975+73.37, A DISTANCE OF 0.276 MILES.

SMITH COMMERCIAL ENTERPRISES LP
NO TAKING

 NEW A2 SHOULDER

 NEW 8" PINNED CONCRETE MEDIAN


RIGHT OF WAY SHEET
SHEET 1 OF 4

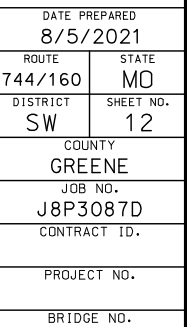[illegible]

MISSOURI HIGHWAYS AND TRANSPORTATION
COMMISSION

105 WEST CAPITOL
JEFFERSON CITY, MO 65102
1-888-ASK-MODOT (1-888-275-6636)

IF A SEAL IS PRESENT ON THIS SHEET IT HAS BEEN ELECTRONICALLY SEALED AND DATED.

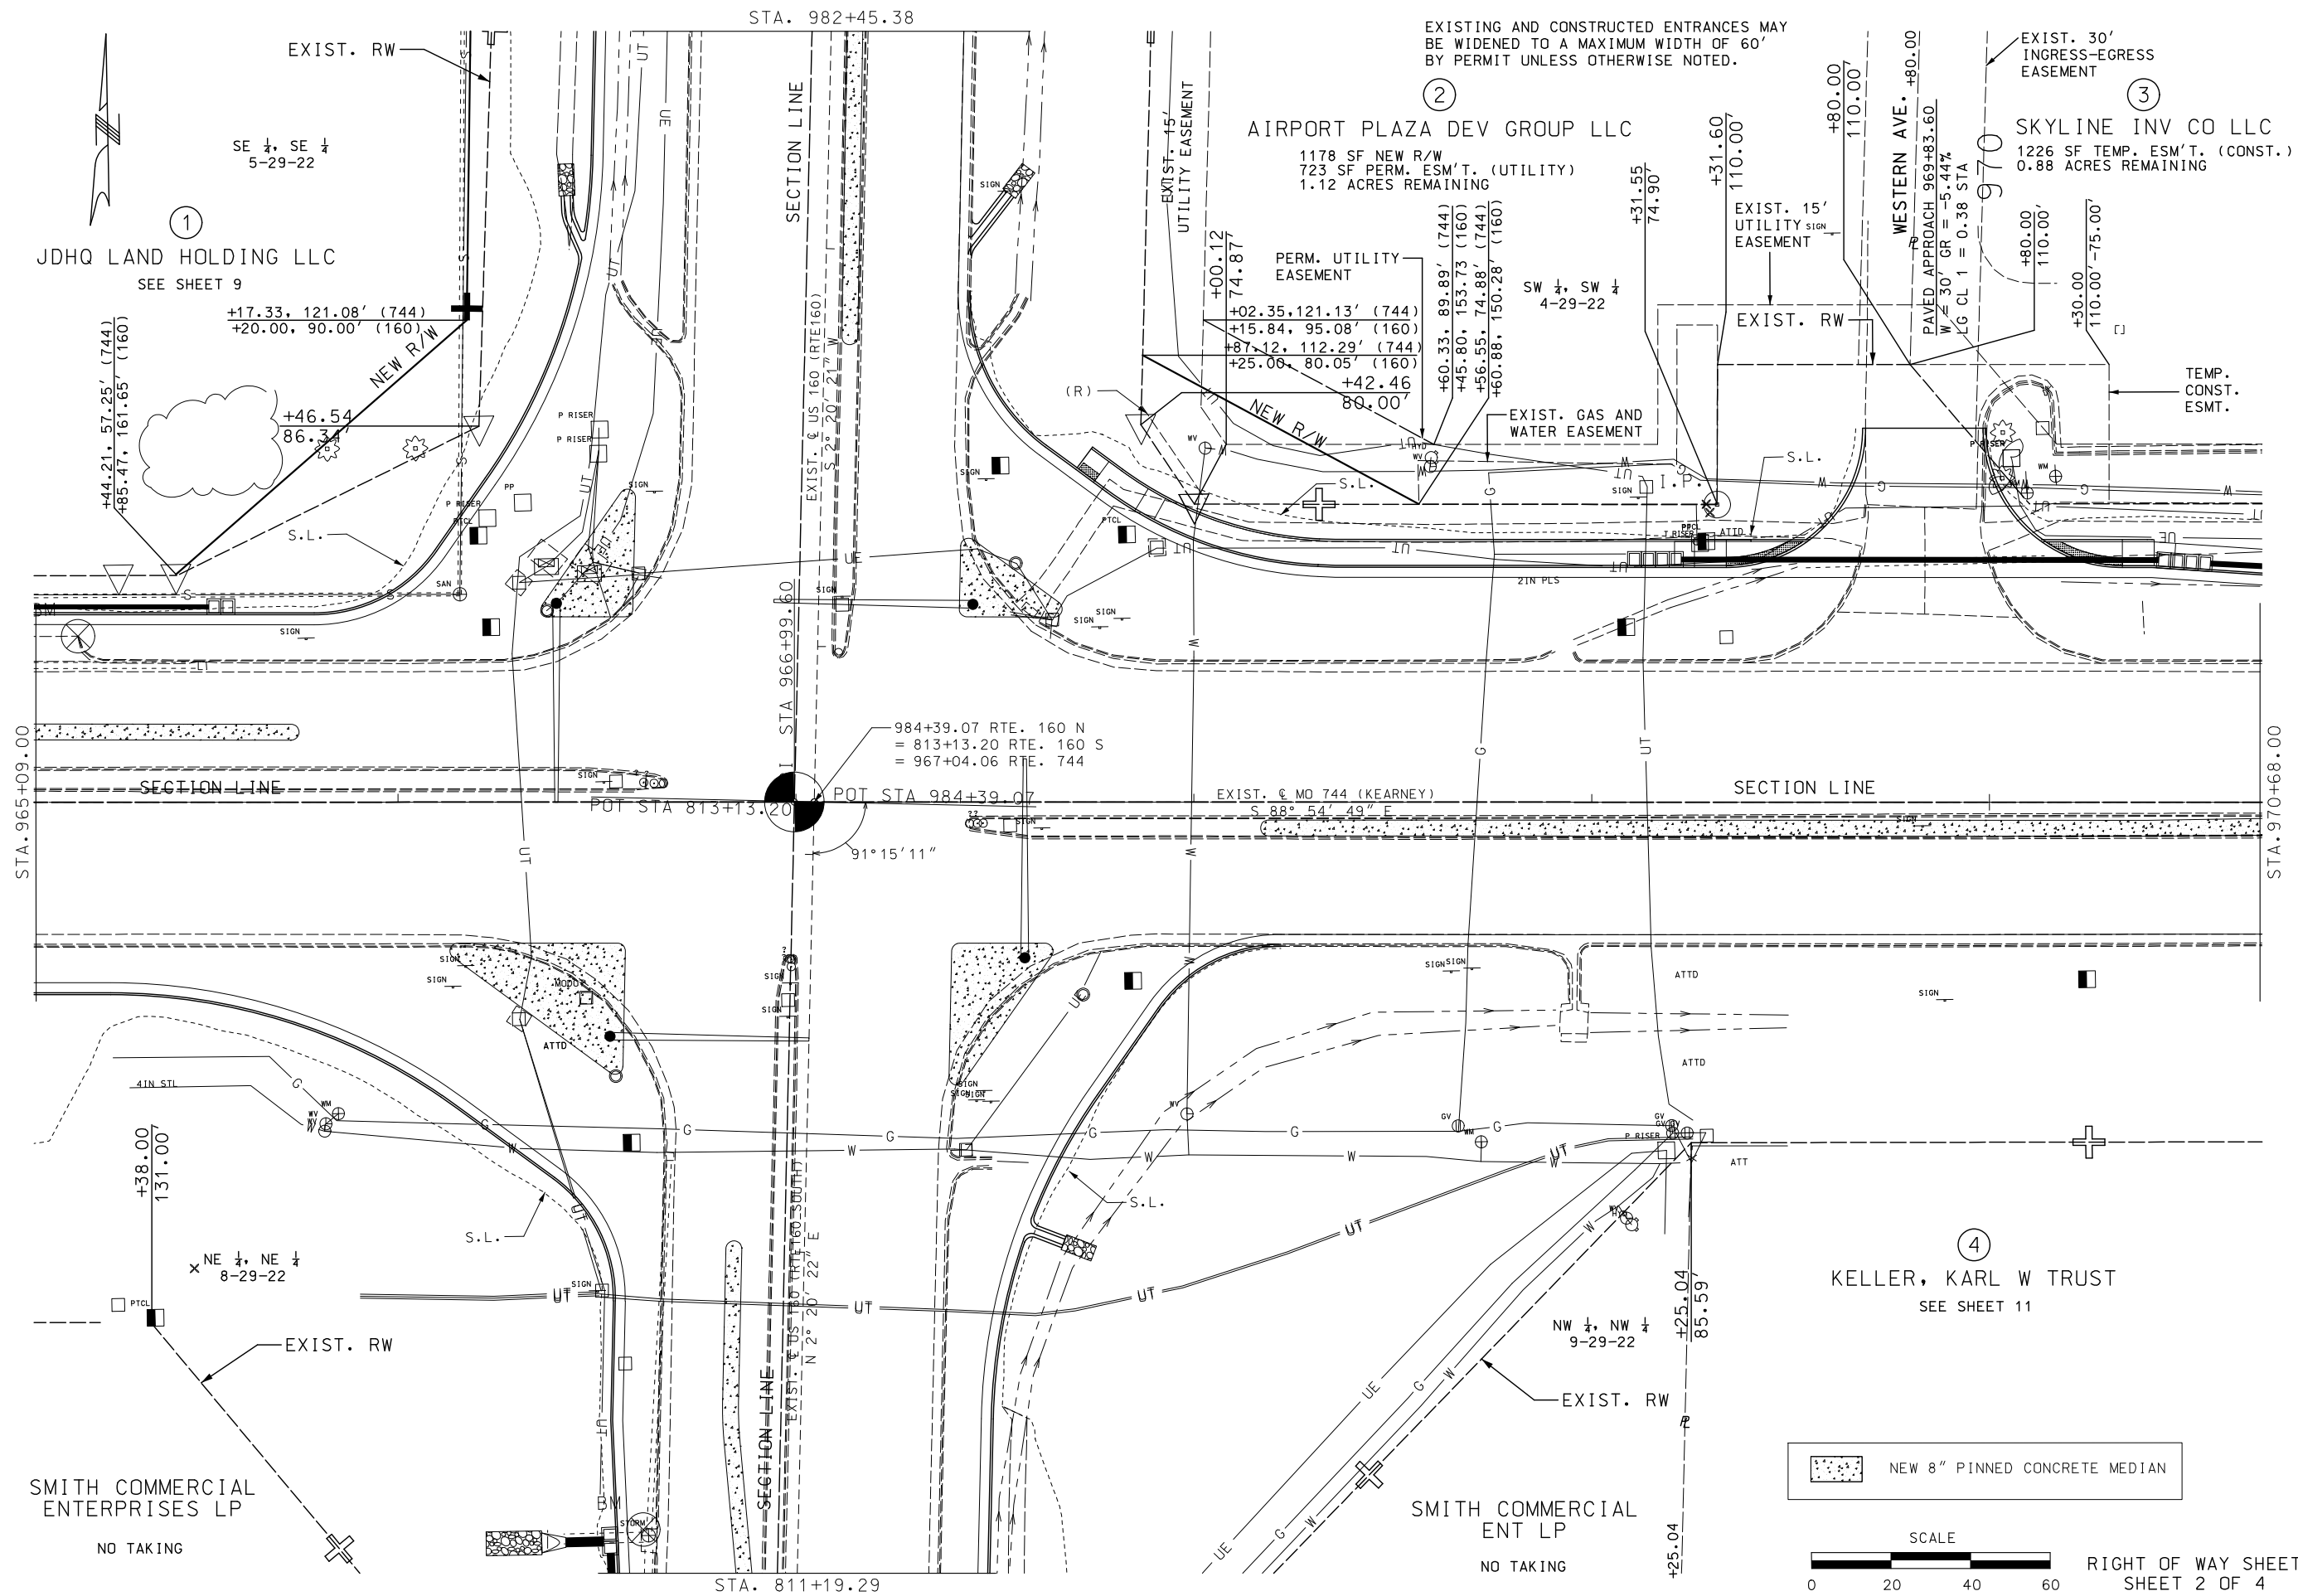

STATE OF MISSOURI

JASON D. EVENDEN
NUMBER
PE-2013000559

PROFESSIONAL ENGINEER

THIS SHEET HAS BEEN
SIGNED, SEALED AND DATED
ELECTRONICALLY.


DATE PREPARED	
8/8/2021	
ROUTE	STATE
744/160	MO
DISTRICT	SHEET NO.
SW	13
COUNTY	
GREENE	
JOB NO.	
J8P3087D	
CONTRACT ID.	
PROJECT NO.	
BRIDGE NO.	


[illegible]

MISSOURI HIGHWAYS AND TRANSPORTATION
COMMISSION

105 WEST CAPITOL
JEFFERSON CITY, MO 65102
1-888-ASK-MODOT / 1-888-275-6636

[illegible]

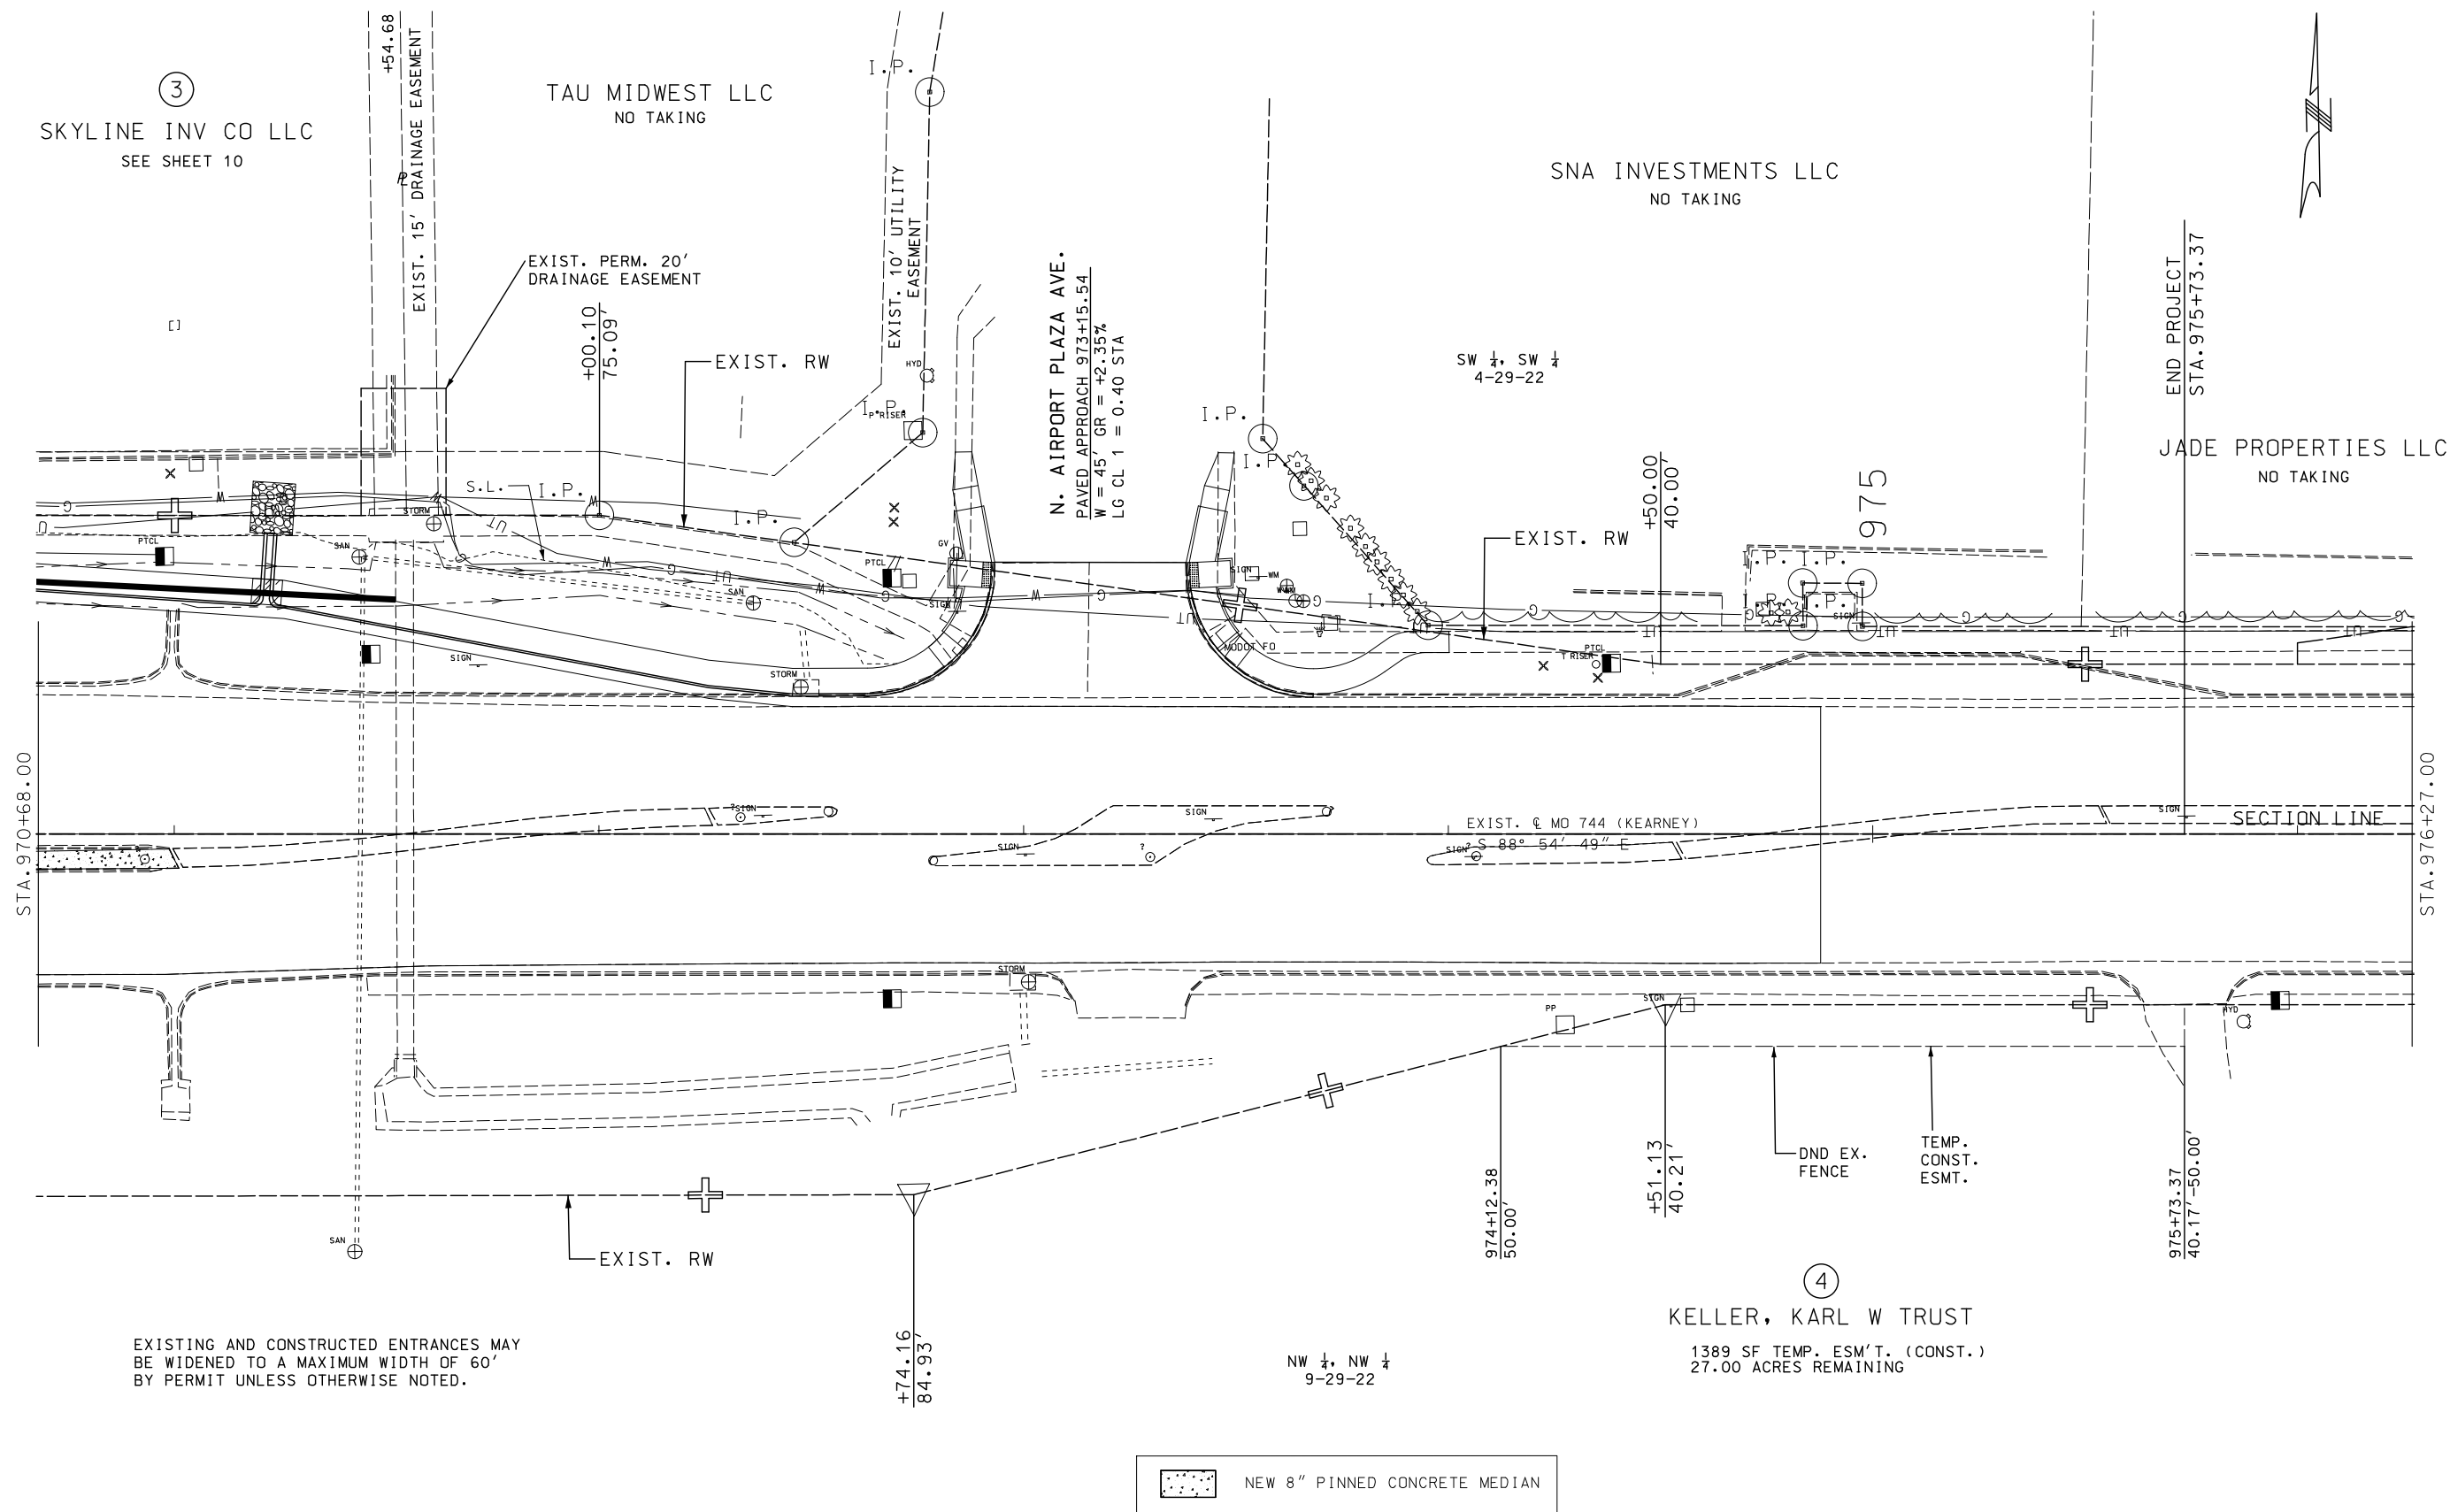

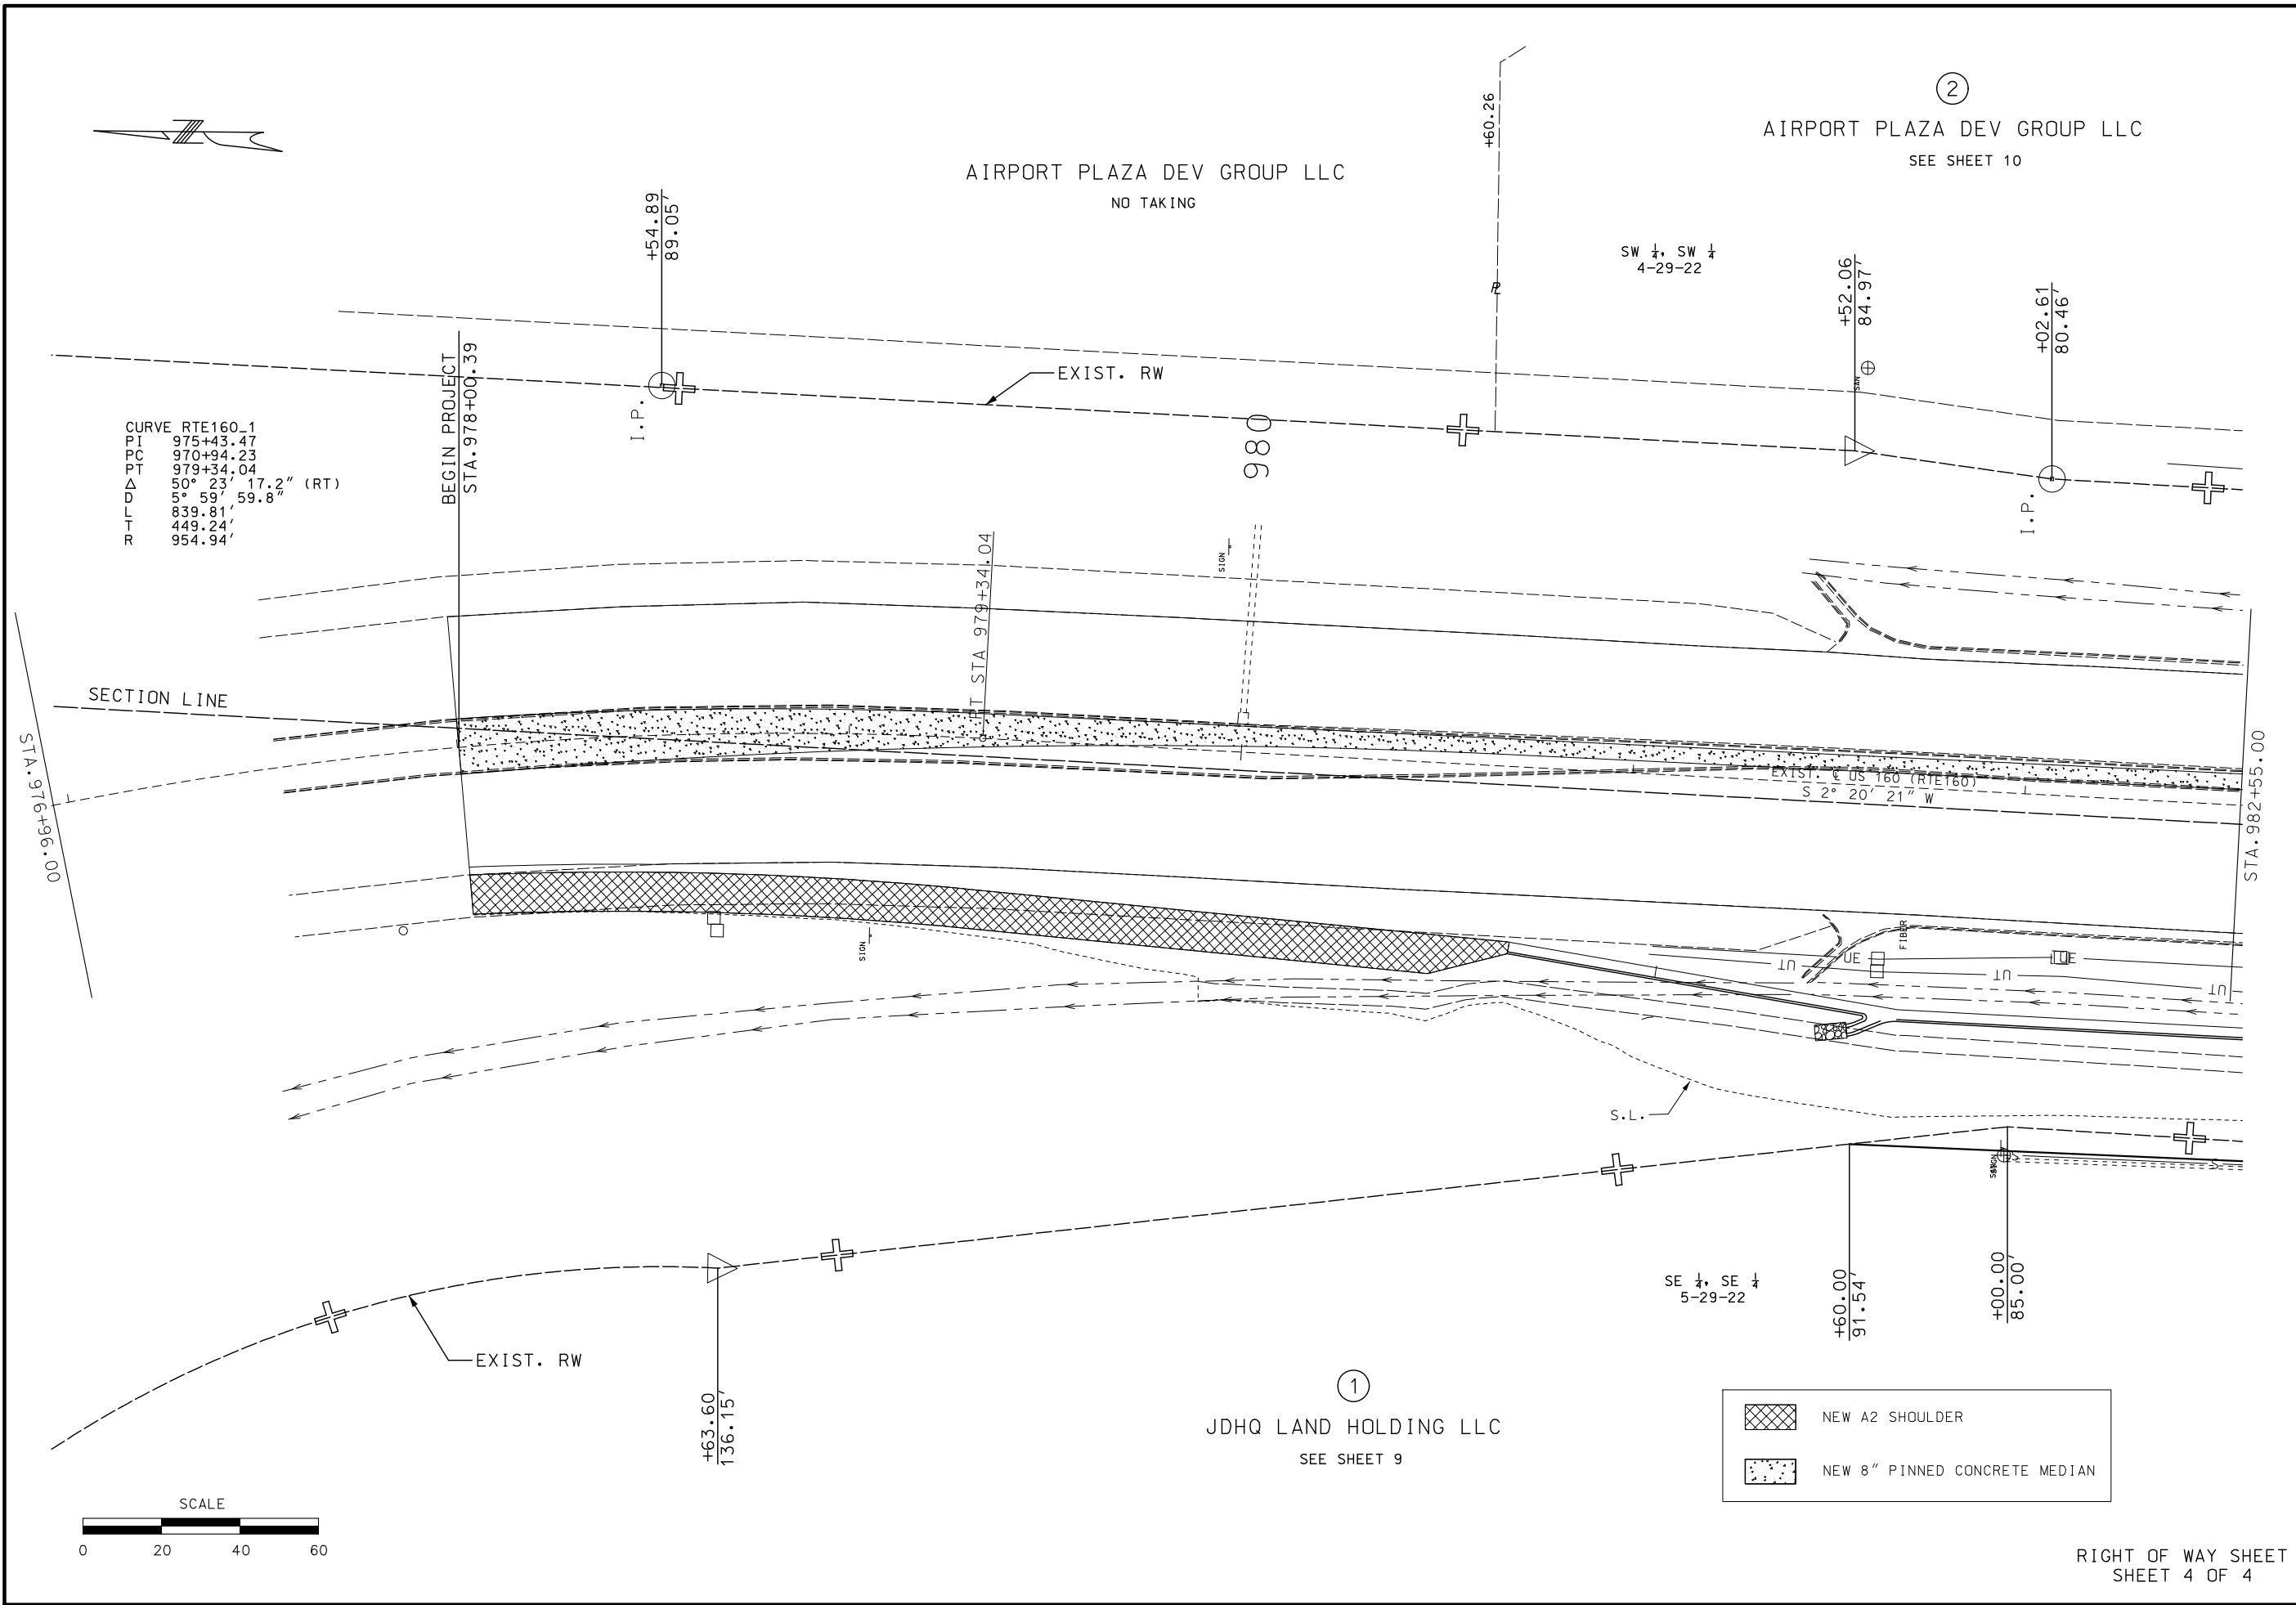

STATE OF MISSOURI

JASON D. EVENDEN

NUMBER

PE-2013000659

PROFESSIONAL ENGINEER

THIS SHEET HAS BEEN

SIGNED, SEALED AND DATED

ELECTRONICALLY.

DATE PREPARED

8/5/2021

ROUTE

744/160

STATE

MO

DISTRICT

SW

SHEET NO.

15

COUNTY

GREENE

JOB NO.

J8P3087D

CONTRACT ID.

PROJECT NO.

BRIDGE NO.

MISSOURI HIGHWAYS AND TRANSPORTATION

COMMISSION

105 WEST CAPITOL

JEFFERSON CITY, MO 65102


1-888-ASK-MODOT (1-888-275-6636)

MoDOT

IF A SEAL IS PRESENT ON THIS SHEET IT HAS BEEN ELECTRONICALLY SEALED AND DATED.

ALL PROJECT COORDINATES HAVE BEEN PROJECTED FROM THE MISSOURI STATE PLANE COORDINATE (SPC) SYSTEM OF 1983 USING AN AVERAGE PROJECT PROJECTION (GRID TO GROUND) FACTOR. TO GET BACK TO STATE PLANE COORDINATES, MULTIPLY THE PROJECT COORDINATES BY THE AVERAGE GRID FACTOR AS SHOWN IN THE "REFERENCE CONTROL INFORMATION" PORTION OF THIS TABLE.		
PROJECT COORDINATE INFORMATION		
COORDINATE SYSTEM	Modified State Plane	
HORIZONTAL DATUM	NAD83	
VERTICAL DATUM	NAVD88	
GEOID MODEL	Geoid12B	
ELEVATIONS DETERMINED BY	RTN GPS	
PROJECT PROJECTION FACTOR	1.000041179	
REFERENCE CONTROL INFORMATION		
COORDINATE SYSTEM	Modified State Plane	
CONTROL STATION	MoDOT GNSS	
DESIGNATION	MoDOT Springfield CORS ARP	
CORS_ID	MOSF	
PID	DL5388	
LATITUDE	37-14-30.33454	
LONGITUDE	93-13-47.54333	
NORTHING (M)	156530.8730	
EASTING (M)	435242.8820	
ZONE	2402 (MO-Central)	
PROJECT AVERAGE GRID FACTOR	0.99995880	
EXAMPLE OF PROJECT COORDINATE TO S.P.C.		
PROJECT NORTHING X AVERAGE GRID FACTOR = STATE PLANE NORTHING PROJECT EASTING X AVERAGE GRID FACTOR = STATE PLANE EASTING EXAMPLE: CONTROL POINT #BM1 N 513,814.0113 X 0.99995880 = N 513,792.8422 E 1,393,572.0667 X 0.99995880 = E 1,393,514.6520		
LINEAR UNIT CONVERSION		
1 METER = 3.280833333 US SURVEY FEET (USFT)		

COORDINATE POINT LISTING								
SHEET NO	STATION	LOCATION	OFFSET (USFT)	MODIFIED STATE PLANE (GROUND)			DESCRIPTION	GPK POINT ID
				NORTHING (US SURVEY FT)	EASTING (US SURVEY FT)	ELEVATION (US SURVEY FT)		
PROJECT CONTROL POINTS								
5	965+19.58	KEARNEY	41.76' LT	513,814.0113	1,393,572.0667	1,271.93	BENCHMARK 1 - STTS STEHAO	
5	966+61.54	KEARNEY	182.82' RT	513,586.8941	1,393,709.9394	1,272.90	BENCHMARK 2 - AINCRAEUF	
ALIGNMENTS								
℄ ROUTE 744 (KEARNEY)								
4	96+00.00	℄ ROUTE 744	0	513,781.6574	1,393,051.8153	1,268.94	POB	KEARNEY1
5	96+699.60	℄ ROUTE 744	0	513,768.9971	1,393,751.3007	1,272.04	PI	KEARNEY3
	98+150.00	℄ ROUTE 744	0	513,741.4973	1,395,201.4400	N/A	POE	KEARNEY4
℄ ROUTE 160 NORTH (RTE160)								
	970+94.23	℄ ROUTE 160	0	515,022.6909	1,393,461.1378	N/A	POB	
	970+94.23	℄ ROUTE 160	0	515,022.6909	1,393,461.1378	N/A	PC	
	975+43.47	℄ ROUTE 160	100.39' LT	514,722.3775	1,393,795.2456	1,263.82	PI	
	N/A	℄ ROUTE 160	N/A	514,312.4843	1,392,822.7672	N/A	CC	
7	979+34.04	℄ ROUTE 160	0	514,273.5122	1,393,776.9116	1,273.00	PT	
5	984+39.07	℄ ROUTE 160	0	513,768.9030	1,393,756.2998	1,271.99	POE	RTE1603
℄ ROUTE 160 SOUTH (RTE160_SOUTH)								
	96+93.39	℄ ROUTE 160 SOUTH	0	512,799.8837	1,393,716.7117	N/A	POB	25
8	103+97.60	℄ ROUTE 160 SOUTH	0	513,503.5068	1,393,745.4574	1,273.60	EQN BK	14
8	810+47.58	℄ ROUTE 160 SOUTH	0	513,503.5068	1,393,745.4574	1,273.60	EQN AHD	17
8	810+47.58	℄ ROUTE 160 SOUTH	0	513,503.5068	1,393,745.4574	1,273.60	PI	23
5	813+13.20	℄ ROUTE 160 SOUTH	0	513,768.9030	1,393,756.2998	1,271.99	POE	27
EDGE OF PAVEMENT ℄ NW QUAD (EOP_RR_NW)								
5	0+00.00	EOP ℄ NW QUAD	0	513,932.3568	1,393,706.2547	1,270.14	POB	
5	0+00.00	EOP ℄ NW QUAD	0	513,932.3568	1,393,706.2547	1,270.14	PC	
5	0+45.52	EOP ℄ NW QUAD	6.75' LT	513,886.8750	1,393,704.4087	1,270.59	PI	
	N/A	EOP ℄ NW QUAD	N/A	513,938.4402	1,393,556.3782	N/A	CC	
5	0+88.39	EOP ℄ NW QUAD	0	513,850.0895	1,393,677.5976	1,270.88	PT	
5	1+10.51	EOP ℄ NW QUAD	0	513,832.2103	1,393,664.5663	1,271.29	PC	
5	1+31.34	EOP ℄ NW QUAD	11.73' LT	513,815.3828	1,393,664.5663	1,271.68	PI	
	N/A	EOP ℄ NW QUAD	N/A	513,855.7704	1,393,652.3017	N/A	CC	
5	1+48.91	EOP ℄ NW QUAD	0	513,815.7776	1,393,632.2414	1,271.72	PT	
5	1+48.91	EOP ℄ NW QUAD	0	513,815.7776	1,393,631.4827	1,271.72	POE	
EDGE OF PAVEMENT ℄ NE QUAD (EOP_RR_NE)								
5	0+00.00	EOP ℄ NE QUAD	0	513,896.7595	1,393,794.8965	1,270.76	POB	
5	0+00.00	EOP ℄ NE QUAD	0	513,896.7595	1,393,794.8965	1,270.76	PC	
5	0+26.01	EOP ℄ NE QUAD	6.36' RT	513,870.7736	1,393,793.8567	1,271.01	PI	
	N/A	EOP ℄ NE QUAD	N/A	513,894.7605	1,393,844.8565	N/A	CC	
5	0+47.96	EOP ℄ NE QUAD	0	513,855.0029	1,393,814.5361	1,270.74	PT	
5	0+66.98	EOP ℄ NE QUAD	0	513,843.4684	1,393,829.6606	1,270.63	PC	
5	0+97.25	EOP ℄ NE QUAD	4.48' RT	513,825.1141	1,393,853.7277	1,270.49	PI	
	N/A	EOP ℄ NE QUAD	N/A	513,922.9837	1,393,890.3015	N/A	CC	
5	1+25.76	EOP ℄ NE QUAD	0	513,823.1867	1,393,883.9334	1,270.25	PT	
5	1+25.76	EOP ℄ NE QUAD	0	513,823.1867	1,393,883.9334	1,270.25	POE	
EDGE OF PAVEMENT ℄ SE QUAD (EOP_RR_SE)								
5	0+00.00	EOP ℄ SE QUAD	0	513,613.1323	1,393,795.3812	1,272.10	POB	
5	0+00.00	EOP ℄ SE QUAD	0	513,613.1323	1,393,795.3812	1,272.10	PC	
5	0+45.52	EOP ℄ SE QUAD	6.75' LT	513,658.6139	1,393,797.2273	1,271.82	PI	
	N/A	EOP ℄ SE QUAD	N/A	513,607.0486	1,393,945.2578	N/A	CC	
5	0+88.39	EOP ℄ SE QUAD	0	513,695.3993	1,393,824.0383	1,271.29	PT	
5	1+15.13	EOP ℄ SE QUAD	0	513,717.0094	1,393,839.7888	1,271.11	PC	
5	1+36.01	EOP ℄ SE QUAD	5.12' LT	513,733.8805	1,393,852.0853	1,271.08	PI	
	N/A	EOP ℄ SE QUAD	N/A	513,693.4492	1,393,872.1140	N/A	CC	
5	1+53.61	EOP ℄ SE QUAD	0	513,733.4403	1,393,872.9574	1,270.87	PT	
5	1+53.61	EOP ℄ SE QUAD	0	513,733.4403	1,393,872.9574	1,270.87	POE	

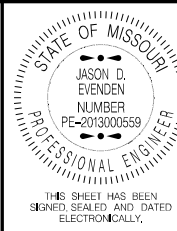

DATE PREPARED 8/5/2021	
ROUTE 744/160	STATE MO
DISTRICT SW	SHEET NO. 16
COUNTY GREENE	
JOB NO. J8P3087D	
CONTRACT ID.	

PROJECT NO.
BRIDGE NO.

DATE	DESCRIPTION

MISSOURI HIGHWAYS AND TRANSPORTATION COMMISSION



105 WEST CAPITOL
JEFFERSON CITY, MO 65102
1-888-ASK-MODOT (1-888-275-6636)

ALIGNMENTS (CONTINUED)								
EDGE OF PAVEMENT @ SW QUAD (EOP_RR_SW)								
5	0+00.00	EOP @ SW QUAD	0	513,726.7626	1,393,578.6878	1,271.33	POB	
5	0+00.00	EOP @ SW QUAD	0	513,726.7626	1,393,578.6878	1,271.33	PC	
5	0+49.08	EOP @ SW QUAD	7.83' LT	513,725.8320	1,393,627.7617	1,271.47	PI	
	N/A	EOP @ SW QUAD	N/A	513,576.7896	1,393,575.8438	N/A	CC	
5	0+94.87	EOP @ SW QUAD	0	513,696.0718	1,393,666.7930	1,271.41	PT	
5	1+24.99	EOP @ SW QUAD	0	513,677.8083	1,393,690.7461	1,271.60	PC	
5	1+45.82	EOP @ SW QUAD	5.10' LT	513,665.1789	1,393,707.3099	1,271.78	PI	
	N/A	EOP @ SW QUAD	N/A	513,645.9997	1,393,666.4930	N/A	CC	
5	1+63.40	EOP @ SW QUAD	0	513,644.3669	1,393,706.4597	1,271.99	PT	
5	1+63.40	EOP @ SW QUAD	0	513,644.3669	1,393,706.4597	1,271.99	POE	
@ ENTRANCE 1 (ENTRANCE1)								
4	0+00.00	@ ENTRANCE 1	0	513,818.8044	1,393,428.0629	1,270.19	POB	
4	0+29.66	@ ENTRANCE 1	0	513,848.8764	1,393,428.5406	1,271.57	POE	
@ ENTRANCE 2 (WesternAve)								
5	0+00.00	@ ENTRANCE 2	0	513,820.1023	1,394,036.3437	1,268.39	POB	
5	0+37.53	@ ENTRANCE 2	0	513,857.5960	1,394,037.0311	1,266.79	POE	
@ ENTRANCE 3 (AirportPlaza)								
6	0+00.00	@ ENTRANCE 3	0	513,787.3915	1,394,367.5472	1,270.73	POB	
6	0+33.93	@ ENTRANCE 3	0	513,821.3095	1,394,368.2762	1,271.03	POE	

STATE OF MISSOURI

JASON D. EVENDEN
NUMBER
PE-2013000659

PROFESSIONAL ENGINEER

THIS SHEET HAS BEEN
SIGNED, SEALED AND DATED
ELECTRONICALLY.

DATE PREPARED 8/5/2021	
ROUTE 744/160	STATE MO
DISTRICT SW	SHEET NO. 17
COUNTY GREENE	
JOB NO. J8P3087D	
CONTRACT ID.	
PROJECT NO.	
BRIDGE NO.	

DATE	DESCRIPTION

MISSOURI HIGHWAYS AND TRANSPORTATION
COMMISSION

MoDOT

105 WEST CAPITOL
JEFFERSON CITY, MO 65102
1-888-ASK-MODOT (1-888-275-6636)

IF A SEAL IS PRESENT ON THIS SHEET IT HAS BEEN ELECTRONICALLY SEALED AND DATED.



965

CURVE PRBL1
PI 0+49.08
PC 0+00.00
PT 0+94.87
Δ 36° 14' 17.0" (LT)
D 38° 11' 49.9"
L 94.87'
T 49.08'
R 150.00'

CURVE PRBL2
PI 0+20.83
PC 0+00.00
PT 0+38.41
Δ 55° 00' 54.0" (LT)
D 143° 14' 22.0"
L 38.41'
T 20.83'
R 40.00'

PC 0+00 EOP RR SW
= 965+27.78 KEARNEY

PT 0+94.87 EOP RR SW
S 52° 40' 32" E

PC 1+24.99 EOP RR SW

PT 1+63.40 EOP RR SW
= 811+86.73 RTE160 SOUTH

CURVE PRBL1

CURVE PRBL2

CURVE PRBL8
PI 0+45.52
PC 0+00.00
PT 0+88.39
Δ 33° 45' 43.5" (RT)
D 38° 11' 49.9"
L 88.39'
T 45.52'
R 150.00'

PC 0+00 EOP RR NW
= 982+77.80 RTE160

PT 1+48.91 EOP RR NW
= 965+78.15 KEARNEY

PT 0+88.39 EOP RR NW
N 36° 05' 11" E

PC 1+10.51 EOP RR NW

CURVE PRBL7

CURVE PRBL8

EXIST. & US 160 (RTE160 SOUTH)
N 2° 20' 22" E

PI STA 966+99.60

EXIST. & US 160 (RTE160)
S 2° 20' 21" W

POT STA 813+13.20 POT STA 984+39.07

EXIST. & MO 744 (KEARNEY)
S 88° 54' 49" E

PC 0+00 EOP RR SE
= 811+59.15 RTE160 SOUTH

PT 0+88.39 EOP RR SE
N 36° 05' 11" E

PC 1+53.61 EOP RR SE
= 968+21.91 KEARNEY

CURVE PRBL3

CURVE PRBL4

CURVE PRBL3
PI 0+45.52
PC 0+00.00
PT 0+88.39
Δ 33° 45' 43.2" (RT)
D 38° 11' 49.9"
L 88.39'
T 45.52'
R 150.00'

CURVE PRBL4
PI 0+20.88
PC 0+00.00
PT 0+38.48
Δ 55° 07' 18.1" (LT)
D 143° 14' 22.0"
L 38.48'
T 20.88'
R 40.00'

PC 0+00 EOP RR NE
= 983+09.75 RTE160

PT 0+47.96 EOP RR NE
S 52° 40' 11" E

 
PC 0+66.98 EOP RR NE

CURVE PRBL5


CURVE PRBL6

CURVE PRBL5
PI 0+26.01
PC 0+00.00
PT 0+47.96
Δ 54° 57' 39.7" (RT)
D 114° 35' 29.6"
L 47.96'
T 26.01'
R 50.00'

CURVE PRBL6
PI 0+30.27
PC 0+00.00
PT 0+58.78
Δ 33° 40' 45.1" (RT)
D 57° 17' 44.8"
L 58.78'
T 30.27'
R 100.00'



SPECIAL SHEET
SHEET 1 OF 5

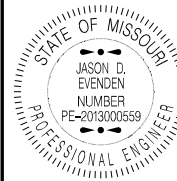

DATE PREPARED
8/5/2021

ROUTE 744/160 STATE MO

DISTRICT SW SHEET NO. 18

COUNTY
GREENE

JOB NO.
J8P3087D

CONTRACT ID.

PROJECT NO.

BRIDGE NO.

DATE	DESCRIPTION


 
MISSOURI HIGHWAYS AND TRANSPORTATION COMMISSION



105 WEST CAPITOL
JEFFERSON CITY, MO 65102
1-888-ASK-MODOT (1-888-275-6636)

IF A SEAL IS PRESENT ON THIS SHEET IT HAS BEEN ELECTRONICALLY SEALED AND DATED.

- NOTES:
- 1. ALL ELEVATIONS TAKEN AT EDGE OF PAVEMENT.
 - 2. ELEVATIONS SHOWN AT SPACING OF 10' APART EXCEPT WHERE NOTED.

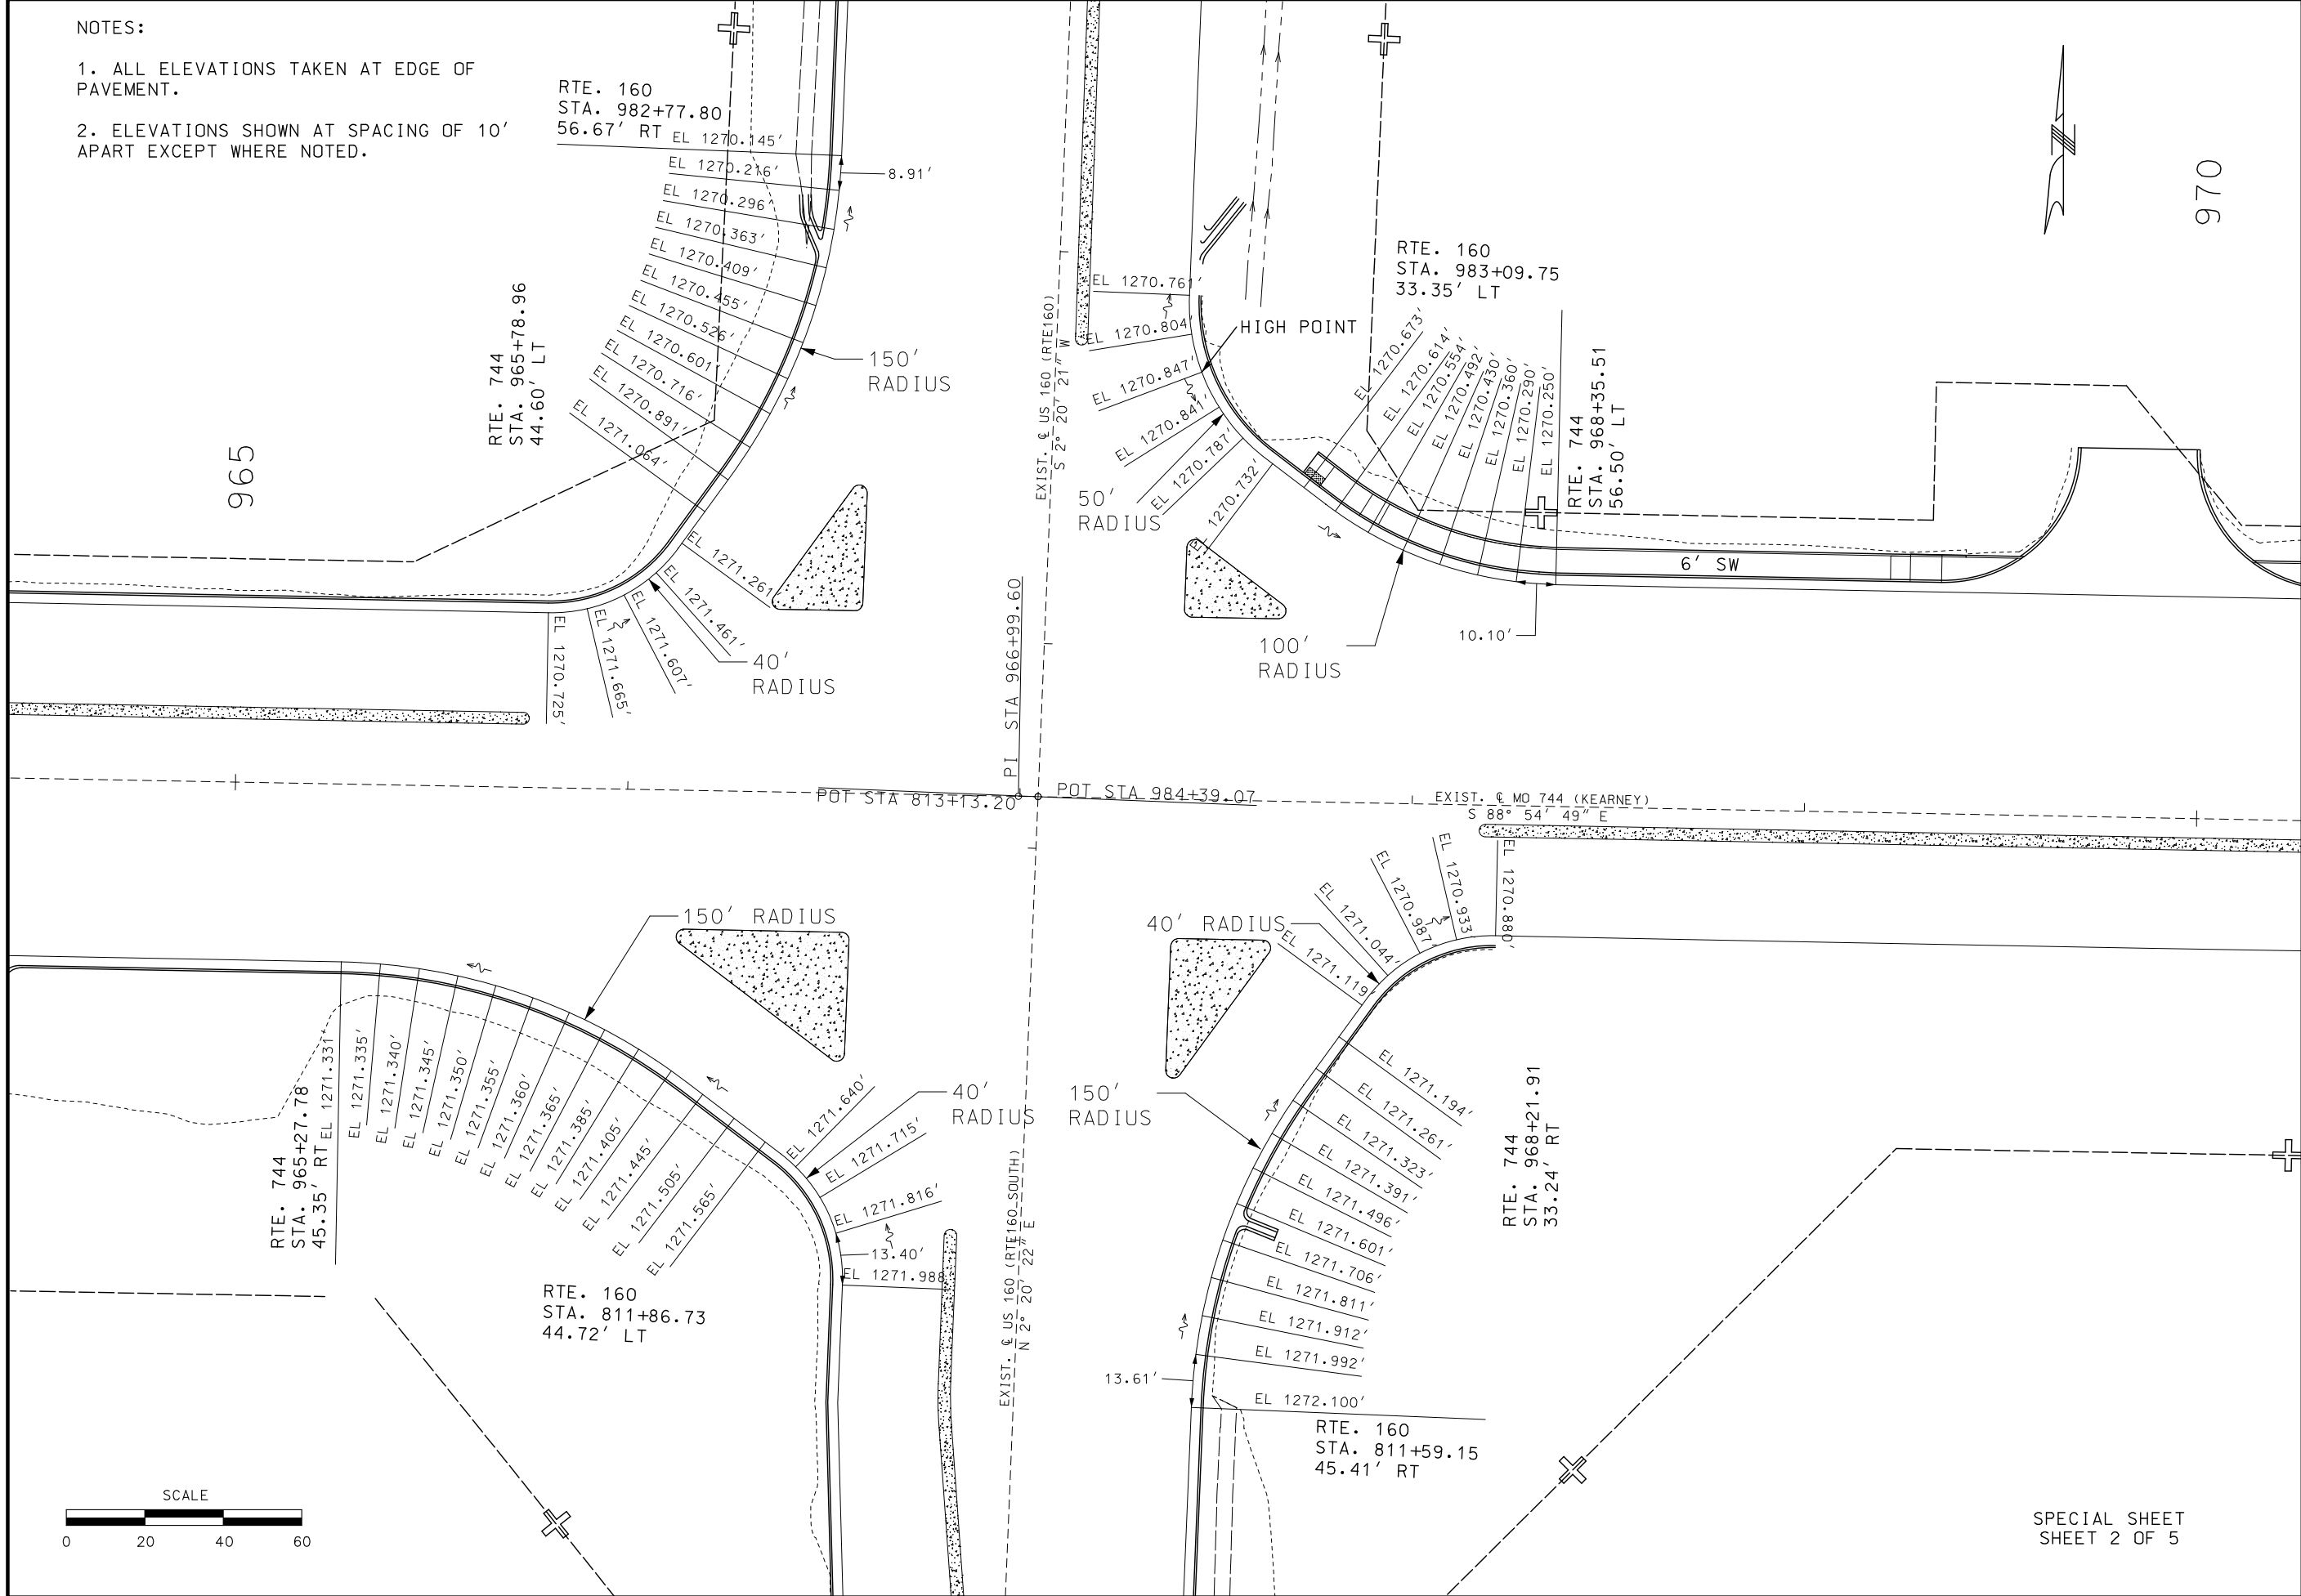

STATE OF MISSOURI

JASON D. EVENDEN

NUMBER

PE-2013000659

PROFESSIONAL ENGINEER

THIS SHEET HAS BEEN
SIGNED, SEALED AND DATED
ELECTRONICALLY.

DATE PREPARED
8/5/2021

ROUTE
744/160

STATE
MO

DISTRICT
SW

SHEET NO.
19

COUNTY
GREENE

JOB NO.
J8P3087D

CONTRACT ID.

PROJECT NO.

BRIDGE NO.


DESCRIPTION

DATE


MISSOURI HIGHWAYS AND TRANSPORTATION
COMMISSION

105 WEST CAPITOL
JEFFERSON CITY, MO 65102
1-888-ASK-MODOT (1-888-275-6636)

IF A SEAL IS PRESENT ON THIS SHEET IT HAS BEEN ELECTRONICALLY SEALED AND DATED.

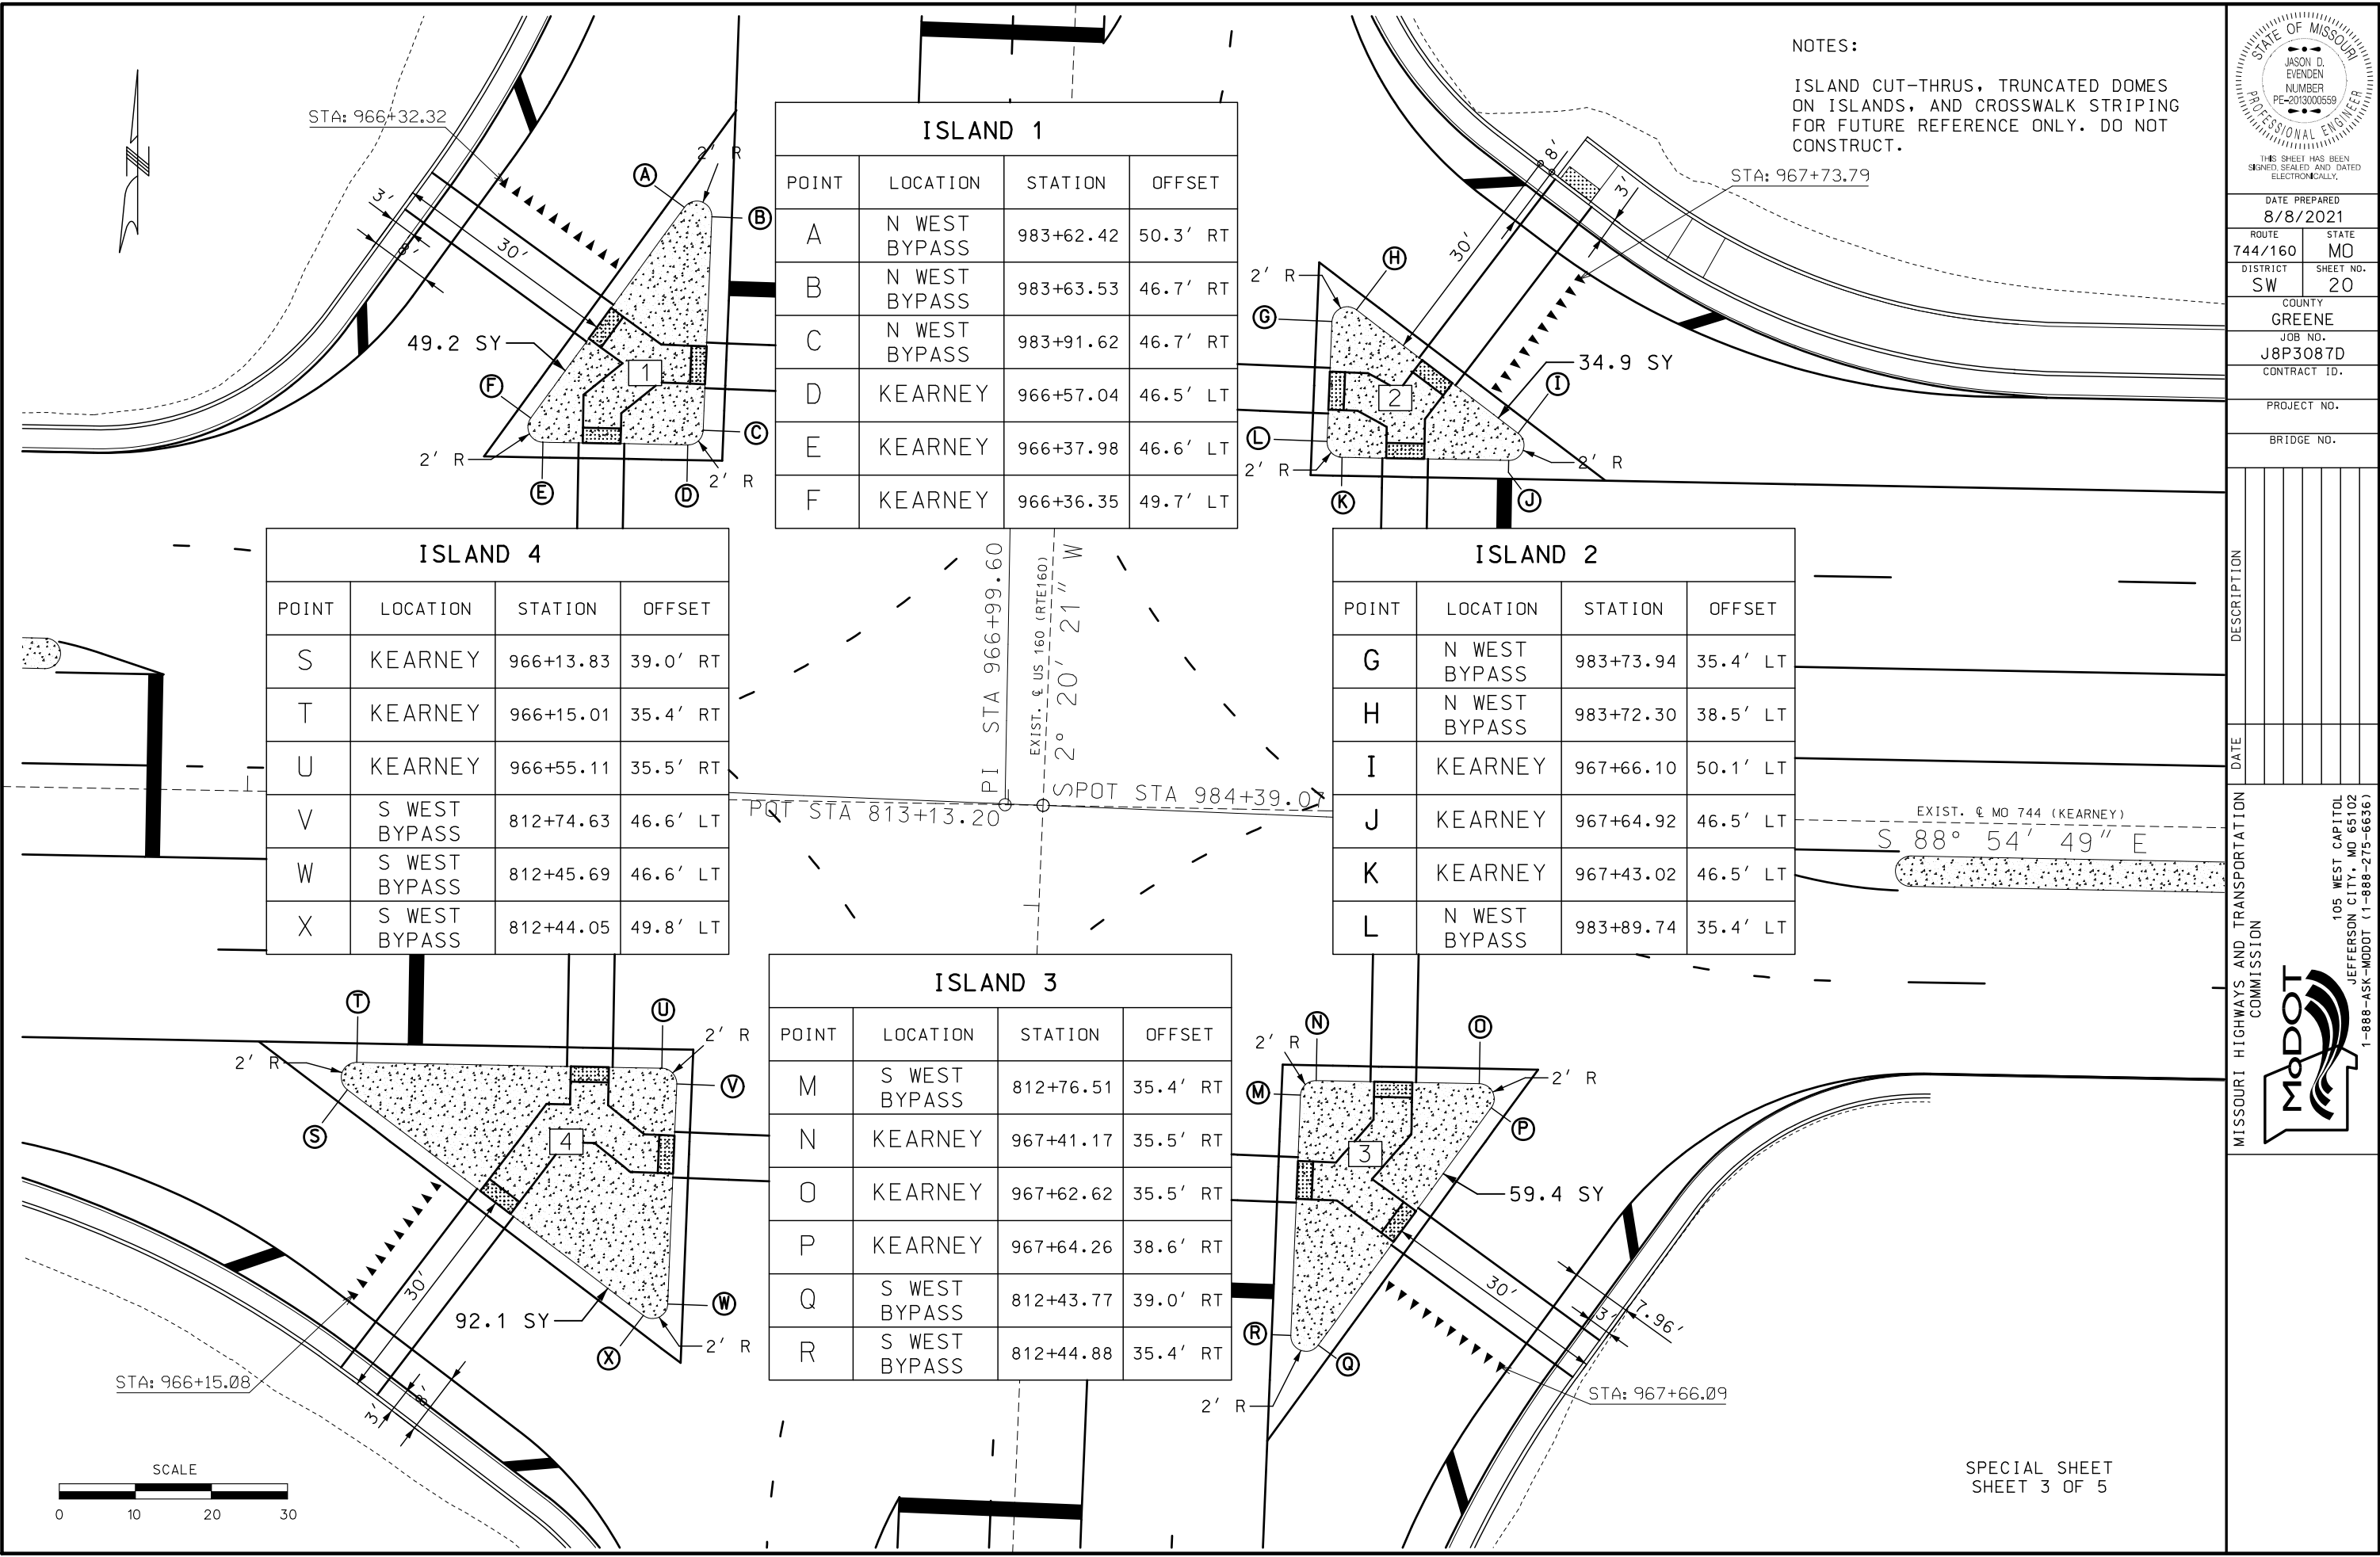

NOTES:
ISLAND CUT-THRU, TRUNCATED DOMES
ON ISLANDS, AND CROSSWALK STRIPING
FOR FUTURE REFERENCE ONLY. DO NOT
CONSTRUCT.

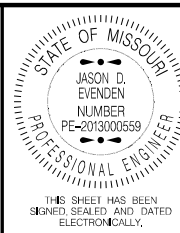

DATE PREPARED 8/8/2021	
ROUTE 744/160	STATE MO
DISTRICT SW	SHEET NO. 20
COUNTY GREENE	
JOB NO. J8P3087D	
CONTRACT ID.	
PROJECT NO.	
BRIDGE NO.	

DATE	DESCRIPTION


MISSOURI HIGHWAYS AND TRANSPORTATION
COMMISSION

MoDOT

105 WEST CAPITOL
JEFFERSON CITY, MO 65102
1-888-ASK-MODOT (1-888-275-6636)

IF A SEAL IS PRESENT ON THIS SHEET IT HAS BEEN ELECTRONICALLY SEALED AND DATED.


- NOTES:
- 1. THE 1/2" STEEL SLIP-RESISTANT PLATE SHALL HAVE A MIN. STATIC COEFFICIENT OF FRICTION OF 0.6.
 - 2. FLATHEAD BRASS MACHINE SCREWS 3/8" x 7/8". HOLES SHALL BE DRILLED AND TAPPED IN THE FIELD AT INTERVALS NOT TO EXCEED 18" CENTER TO CENTER (NO DIRECT PAY).
 - 3. ALL REINFORCING STEEL BARS SHALL BE EPOXY COATED (NO DIRECT PAY).
 - 4. ALL REINFORCING STEEL, ANCHOR BARS, ANGLE IRON, SCREWS, AND 'T' SUPPORTS SHALL BE INCIDENTAL (NO DIRECT PAY).

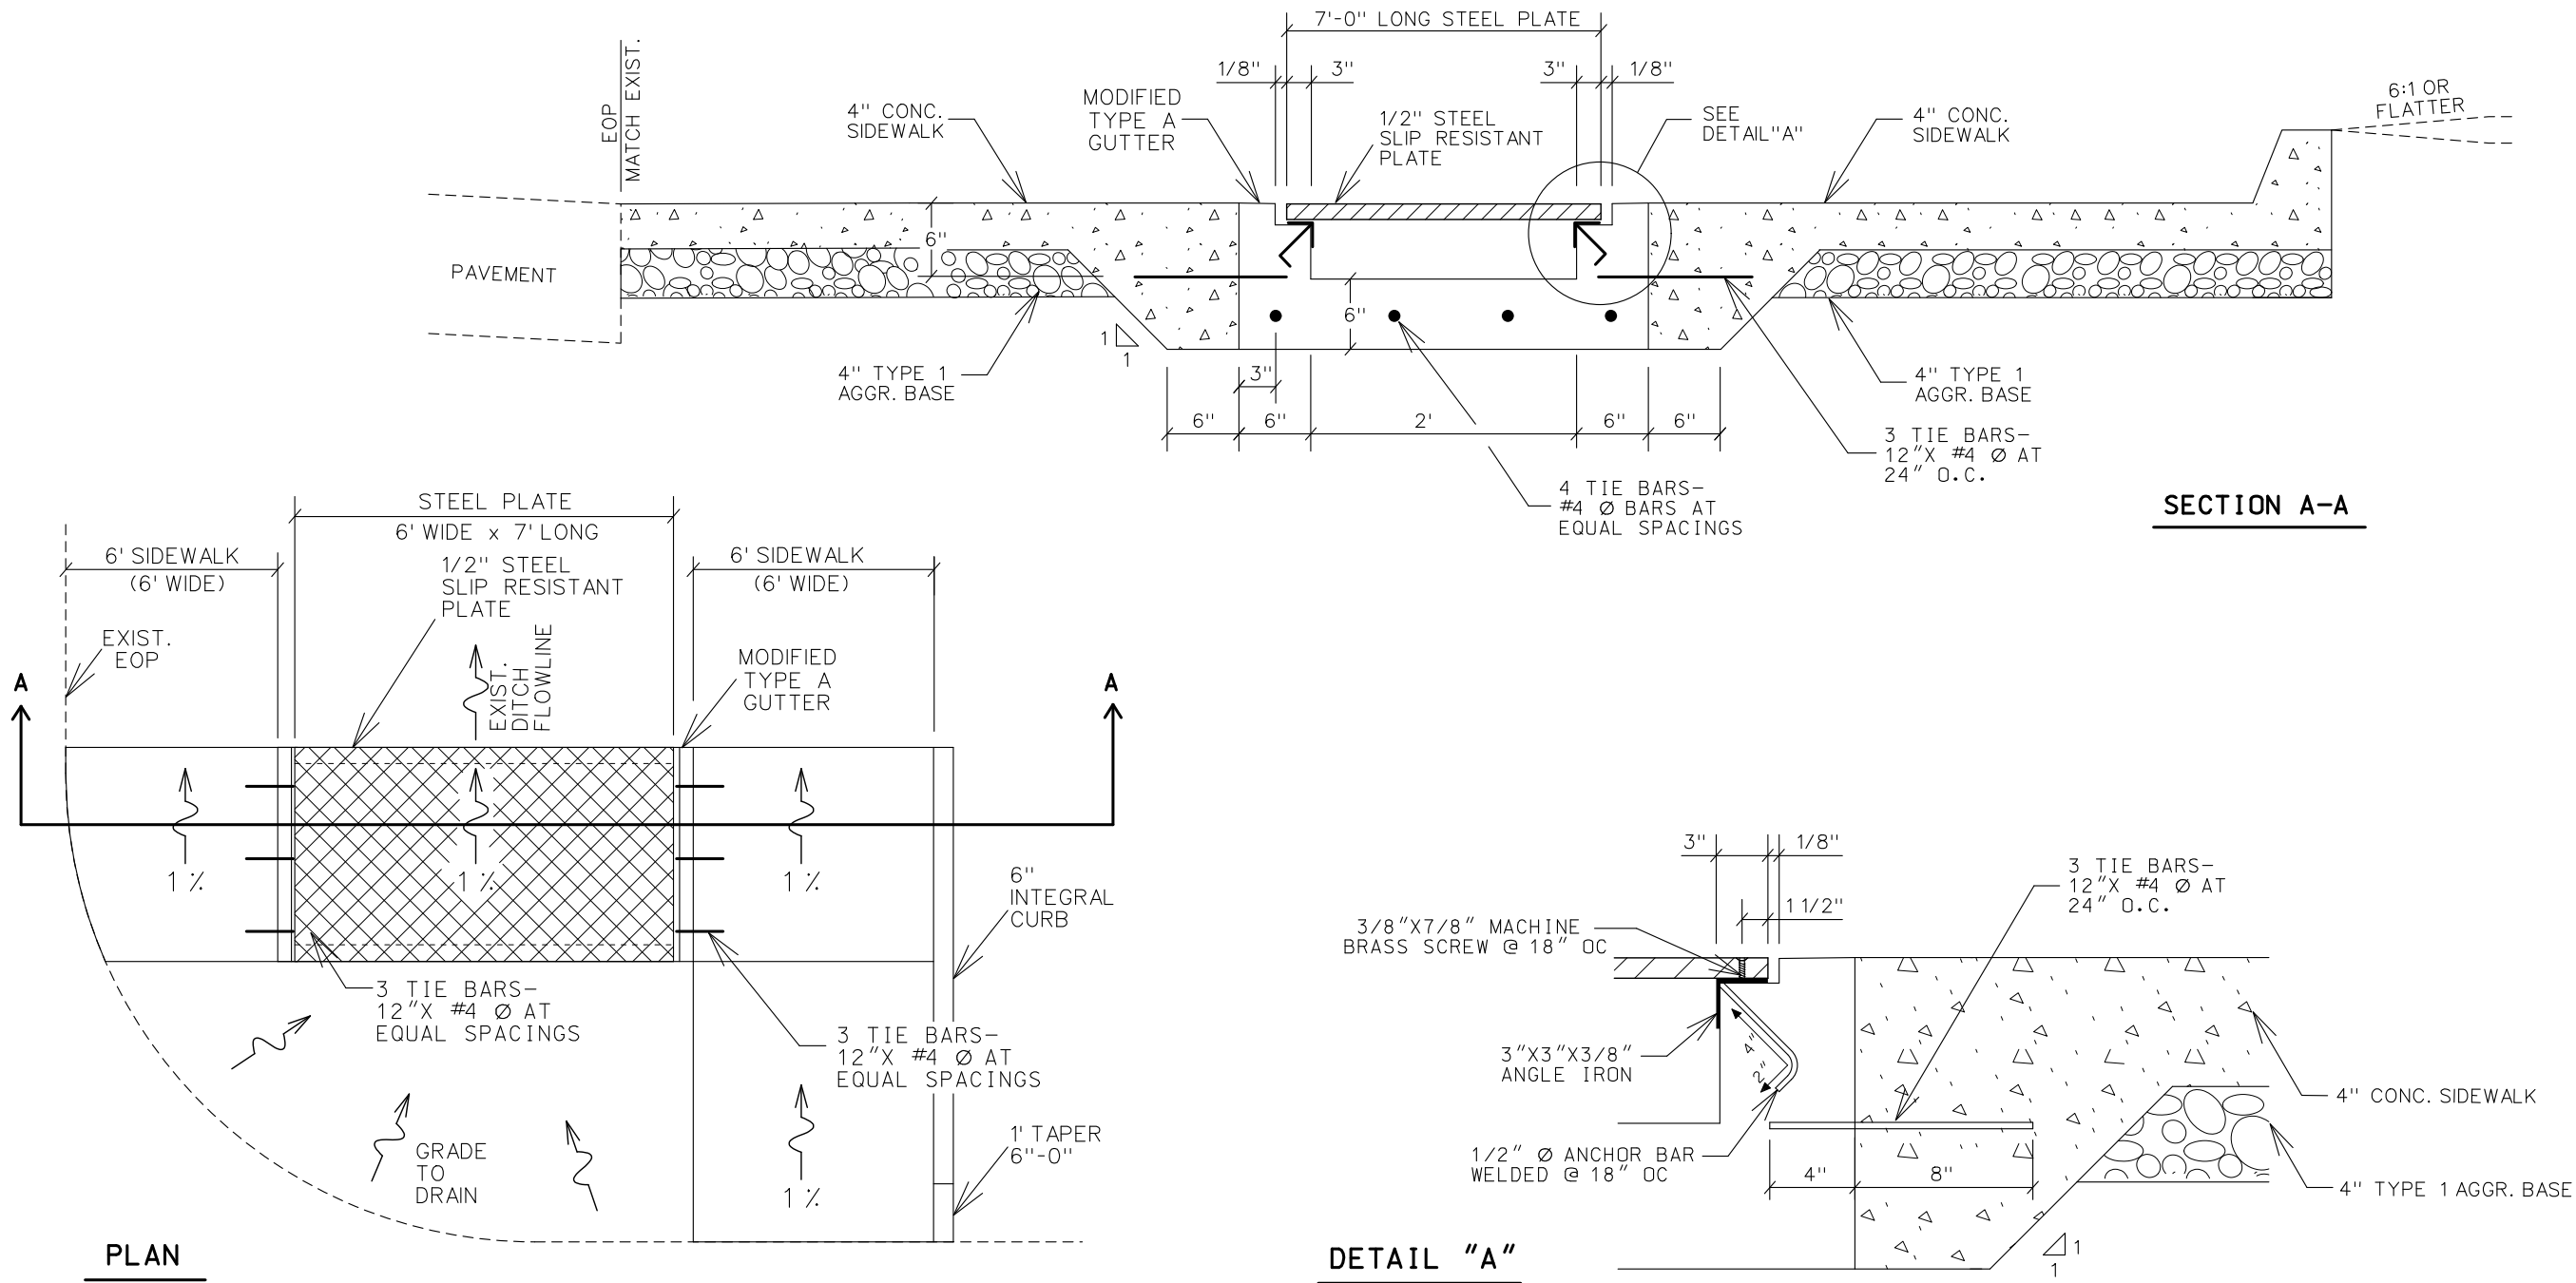

NOT TO SCALE

STA. 971+21.80
MODIFIED TYPE A GUTTER W/ STEEL PLATE

SPECIAL SHEET
5 OF 5

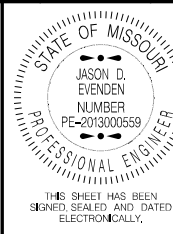


DATE PREPARED 8/6/2021	
ROUTE 744/160	STATE MO
DISTRICT SW	SHEET NO. 22
COUNTY GREENE	
JOB NO. J8P3087D	
CONTRACT ID.	
PROJECT NO.	
BRIDGE NO.	

DESCRIPTION	DATE

MISSOURI HIGHWAYS AND TRANSPORTATION COMMISSION

105 WEST CAPITOL
JEFFERSON CITY, MO 65102
1-888-ASK-MODOT (1-888-275-6636)

IF A SEAL IS PRESENT ON THIS SHEET IT HAS BEEN ELECTRONICALLY SEALED AND DATED.

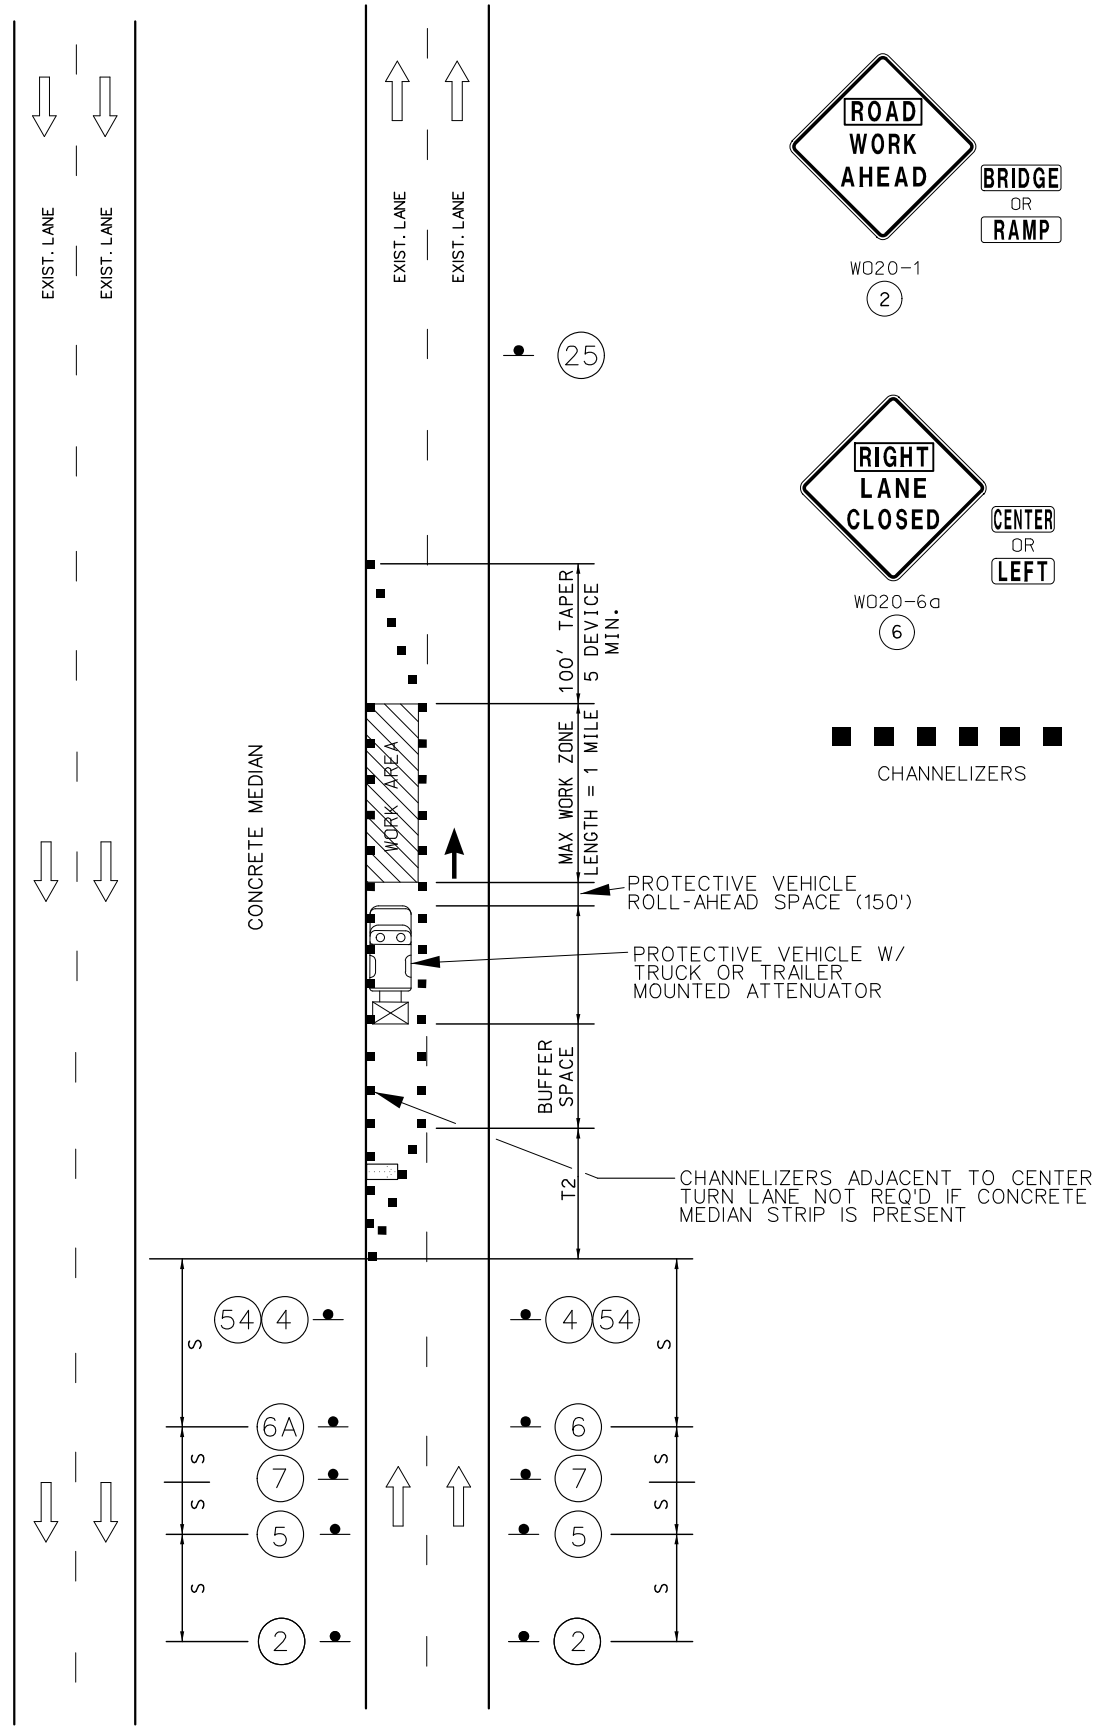

PASSING LANE CLOSURE
NOT TO SCALE

TAPER LENGTHS AND SPACING OF CHANNELIZING DEVICES					
SPEED	TAPER LENGTH (FT)		OPTIONAL	CHANNELIZER SPACING (FT)	
PERMANENT POSTED (mph)	SHOULDER (T1)	LANE (T2)	BUFFER LENGTH (FT) (B)	TAPERS	BUFFER/ WORK AREAS
0-35	70	245	280	35	40
40-45	150	540	400	40	80
50-55	185	660	560	50	80
60-70	235	840	840	60	120

SIGN SPACING FOR ADVANCE SIGN SERIES	
SPACING BETWEEN SIGNS AND SPACING BETWEEN LAST SIGN AND FLAGGER, BEGINNING OF TAPER, OR SIGNED CONDITION.	
SPACING MAY BE ADJUSTED AS NECESSARY TO MEET FIELD CONDITIONS.	
SPEED	SIGN SPACING (FT)
PERMANENT POSTED (mph)	DIVIDED (S)
0-35	200
40-45	500
50-55	1000
60-70	SA-1000 SB-1500 SC-2640

SHOULDER TAPER LENGTH BASED
ON 10 FT. (STANDARD SHOULDER
WIDTH) OFFSET.

LANE TAPER LENGTH BASED ON
12 FT. (STANDARD LANE WIDTH)
OFFSET.

- NOTES:
- SEE BEGINNING OF PROJECT SIGNING SHEET FOR ADDITIONAL SIGNS.
- TEMPORARY PAVEMENT MARKING REQUIRED WITH LONG TERM LANE CLOSURES, NO DIRECT PAY.
- NO DIRECT PAYMENT WILL BE MADE FOR THE RELOCATION OF CHANNELIZERS, CONSTRUCTION SIGNS, OR FLASHING ARROW PANEL.
- FOR SHORT TERM OPERATIONS WHERE IT IS NOT FEASIBLE TO MODIFY PAVEMENT MARKING, DEVICE SPACING ARE ONE-HALF OF THE SPACING SHOWN IN THE TABLE.
- SPEED LIMIT SIGNS INDICATING THE NORMAL SPEED LIMIT SHALL BE INSTALLED AT THE END OF THE WORK ZONE, PROVIDED NO FURTHER WORK ZONES WILL BE ENCOUNTRD WITHIN THE NEXT 1/2 MILE.
- ALL SIGNS, EXCEPT "RATE OUR WORK ZONE" AND "POINT OF PRESENCE", SHALL BE PORTABLE MOUNT AND ARE TO BE MOVED AS WORK PROGRESSES, UNLESS OTHERWISE NOTED. ALL TRAFFIC CONTROL ITEMS SHALL BE REMOVED FROM THE ROADWAY DURING NON-WORKING HOURS.
- WORK WILL REQUIRE LANE CLOSURES UNLESS OTHERWISE APPROVED BY THE ENGINEER.
- LAYOUT IS TYPICAL FOR EITHER DIRECTION OF TRAFFIC.
- SEE STANDARD DRAWING 616.10 FOR ADDITIONAL DETAILS.
- ANY EXISTING SIGNING THAT CONFLICTS WITH THE TRAFFIC CONTROL SIGNING SHALL BE COMPLETELY COVERED OR REMOVED.

STATE OF MISSOURI

JASON D. EVENDEN

NUMBER

PE-2013000659

PROFESSIONAL ENGINEER

THIS SHEET HAS BEEN
SIGNED, SEALED AND DATED
ELECTRONICALLY.

DATE PREPARED

8/5/2021

ROUTE

744/160

STATE

MO

DISTRICT

SW

SHEET NO.

24

COUNTY

GREENE

JOB NO.

J8P3087D

CONTRACT ID.

PROJECT NO.

BRIDGE NO.

DESCRIPTION

DATE

MISSOURI HIGHWAYS AND TRANSPORTATION
COMMISSION


105 WEST CAPITOL

JEFFERSON CITY, MO 65102

1-888-ASK-MODOT (1-888-275-6636)


IF A SEAL IS PRESENT ON THIS SHEET IT HAS BEEN ELECTRONICALLY SEALED AND DATED.

	SIGN (SINGLE SIDED)
	SIGN (DOUBLE SIDED)
	FLAGGER
	CONE
	CHANNELIZER
	BARRICADE
	CHANGEABLE MESSAGE BOARD

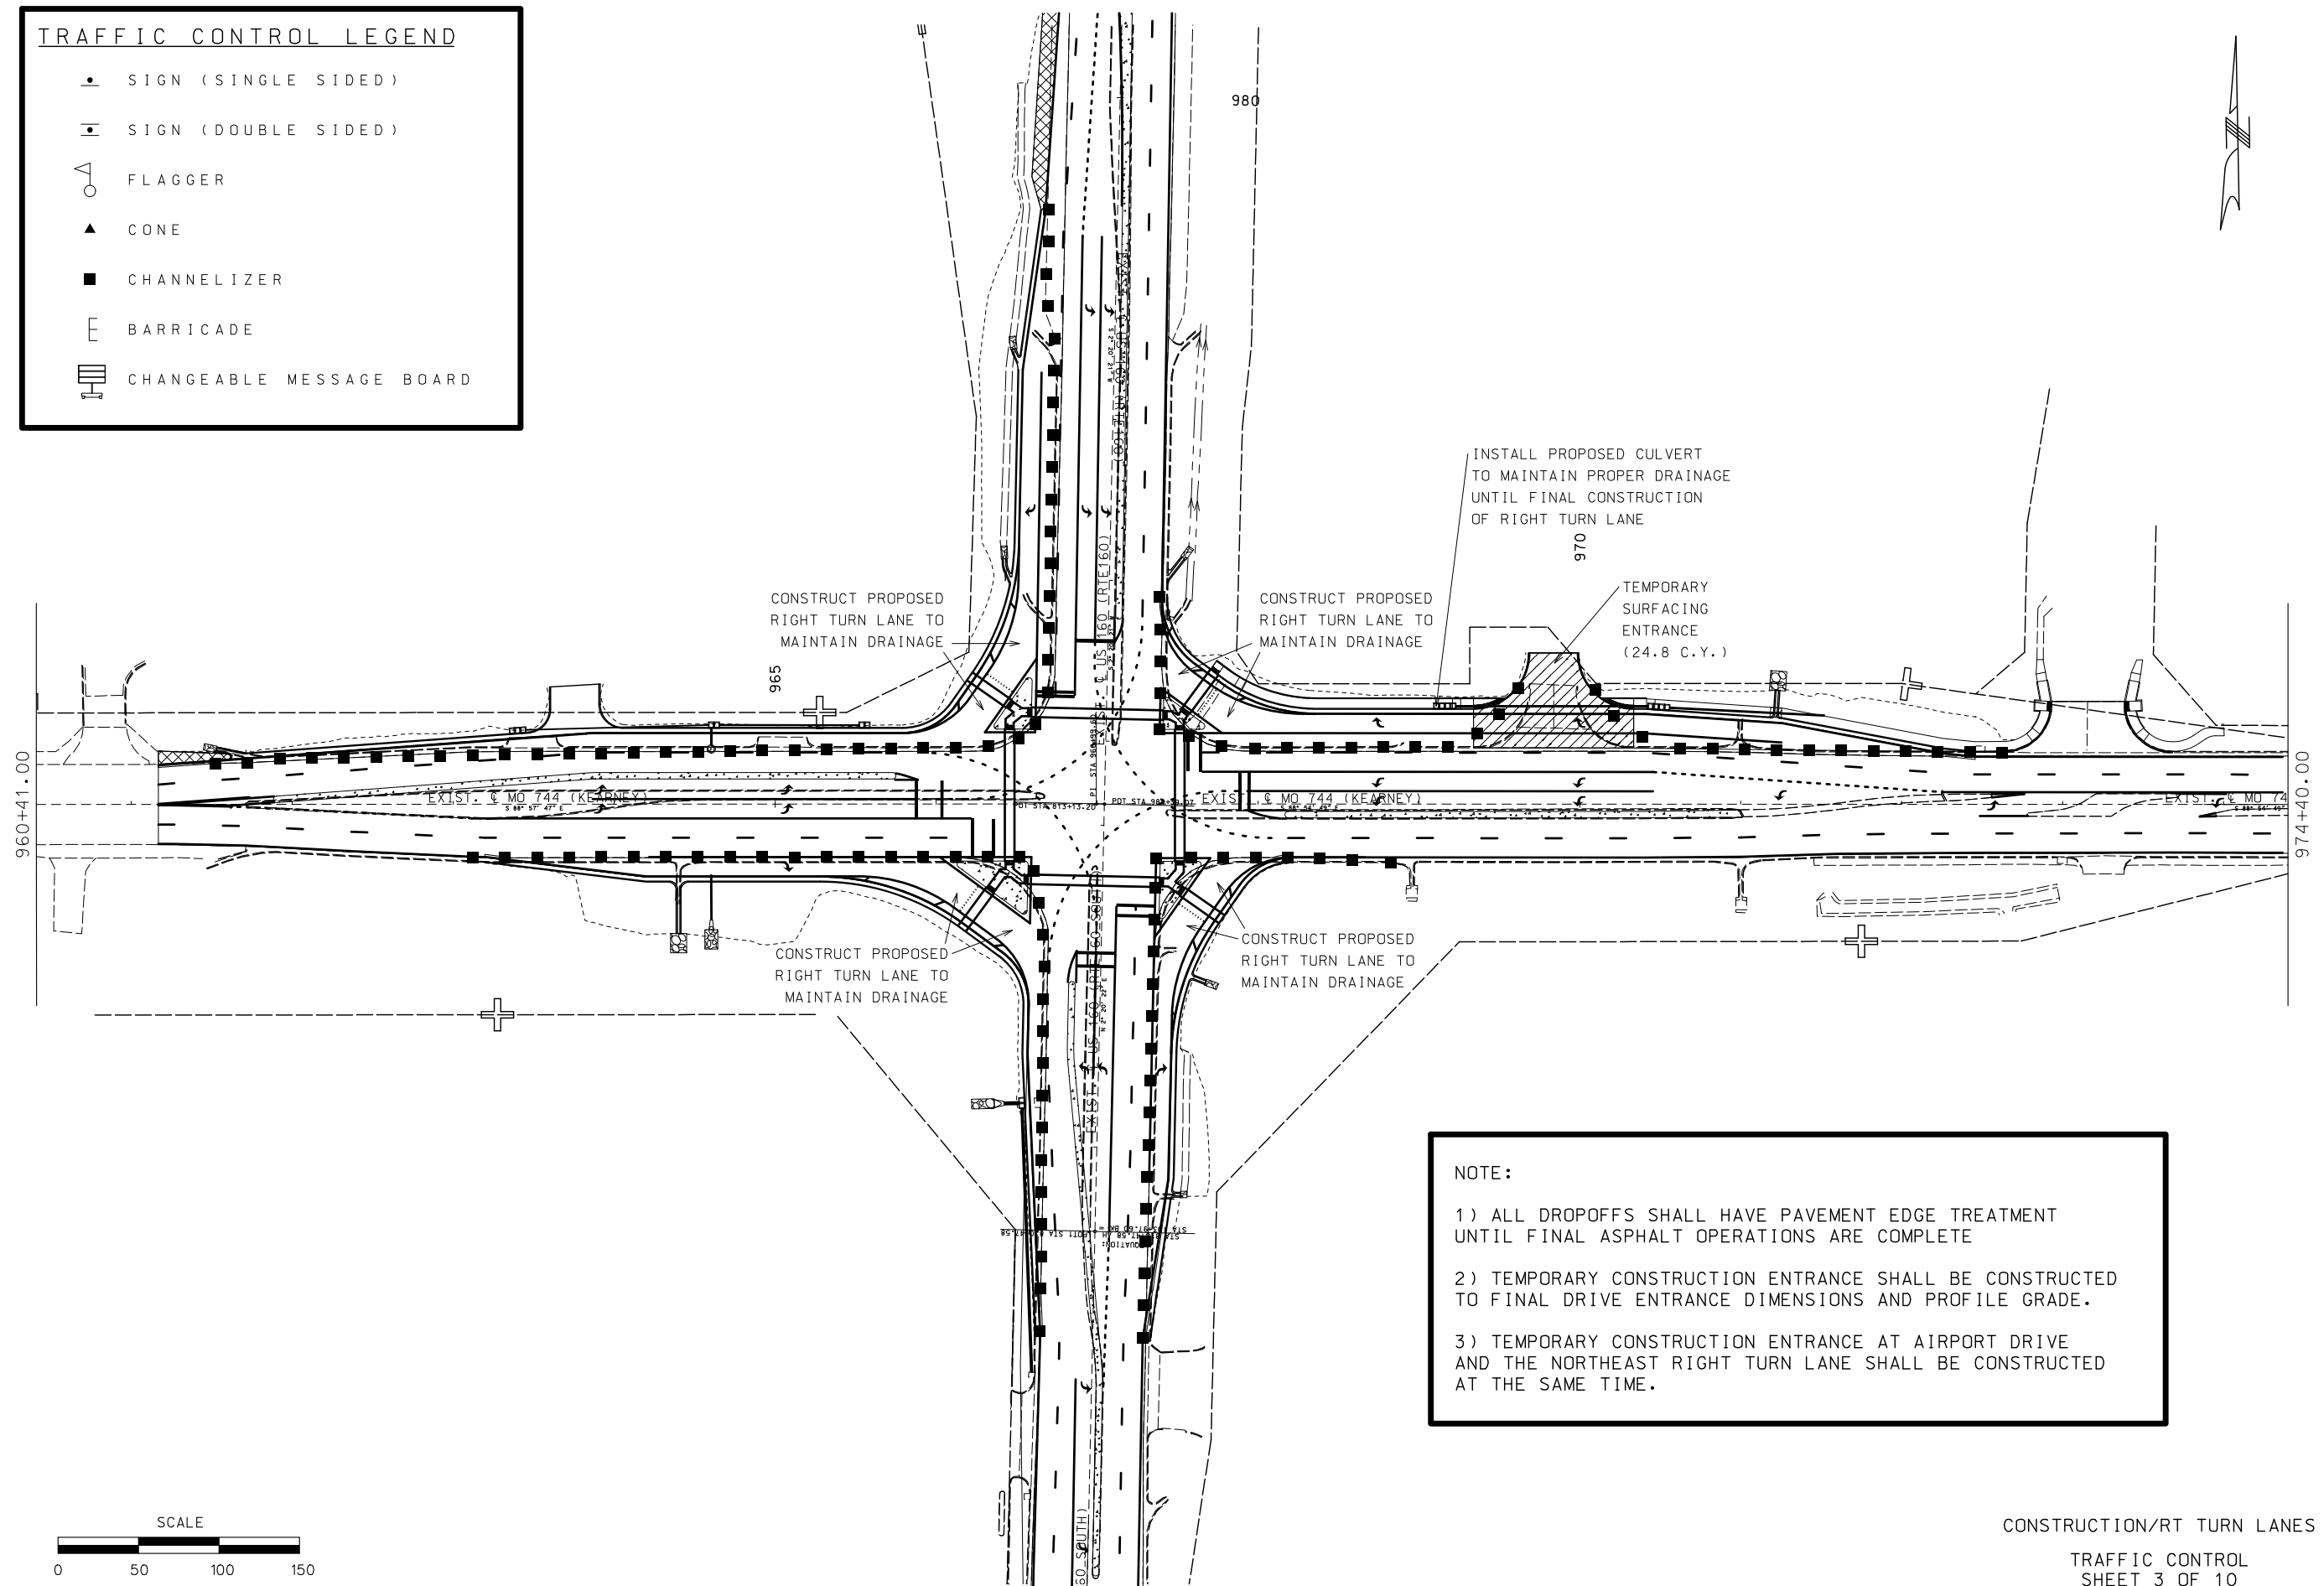

- 1) ALL DROPOFFS SHALL HAVE PAVEMENT EDGE TREATMENT UNTIL FINAL ASPHALT OPERATIONS ARE COMPLETE
- 2) TEMPORARY CONSTRUCTION ENTRANCE SHALL BE CONSTRUCTED TO FINAL DRIVE ENTRANCE DIMENSIONS AND PROFILE GRADE.
- 3) TEMPORARY CONSTRUCTION ENTRANCE AT AIRPORT DRIVE AND THE NORTHEAST RIGHT TURN LANE SHALL BE CONSTRUCTED AT THE SAME TIME.

TRAFFIC CONTROL
SHEET 3 OF 10

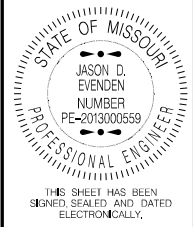

DATE PREPARED
8/5/2021

ROUTE	STATE
-------	-------

160/744	MO
---------	----

DISTRICT SW SHEET NO. 25


COUNTY
GREENE

JOB NO.
J8P3087D

CONTRACT ID.



PROJECT NO.

BRIDGE NO.

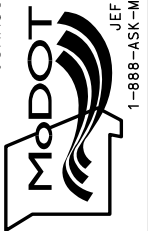[illegible]MISSOURI HIGHWAYS AND TRANSPORTATION
COMMISSION

JEFFERSON CITY, MD 65102
1-888-ASK-MODOT (1-888-275-6636)


THE
FEDERAL
BUREAU
OF
INVESTIGATION
OF
THE
DEPARTMENT
OF
JUSTICE
WASHINGTON, D. C. 20535

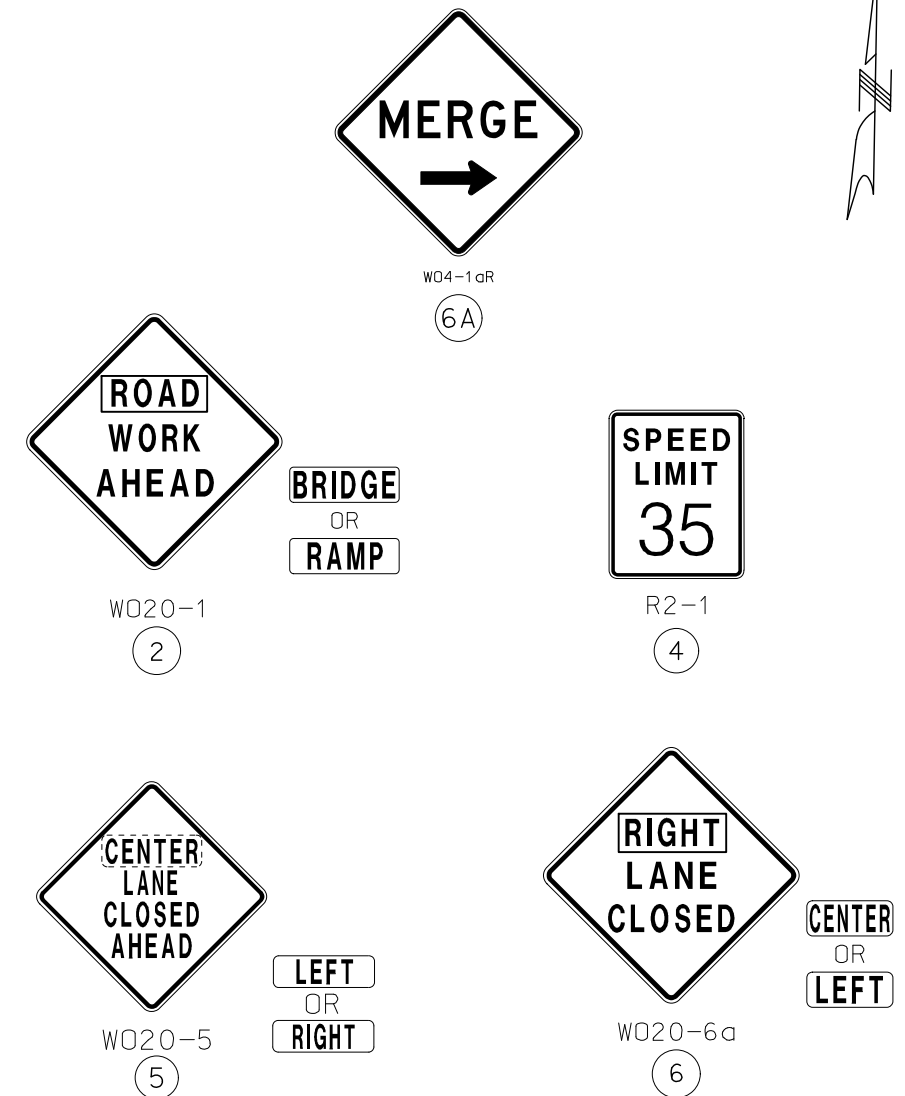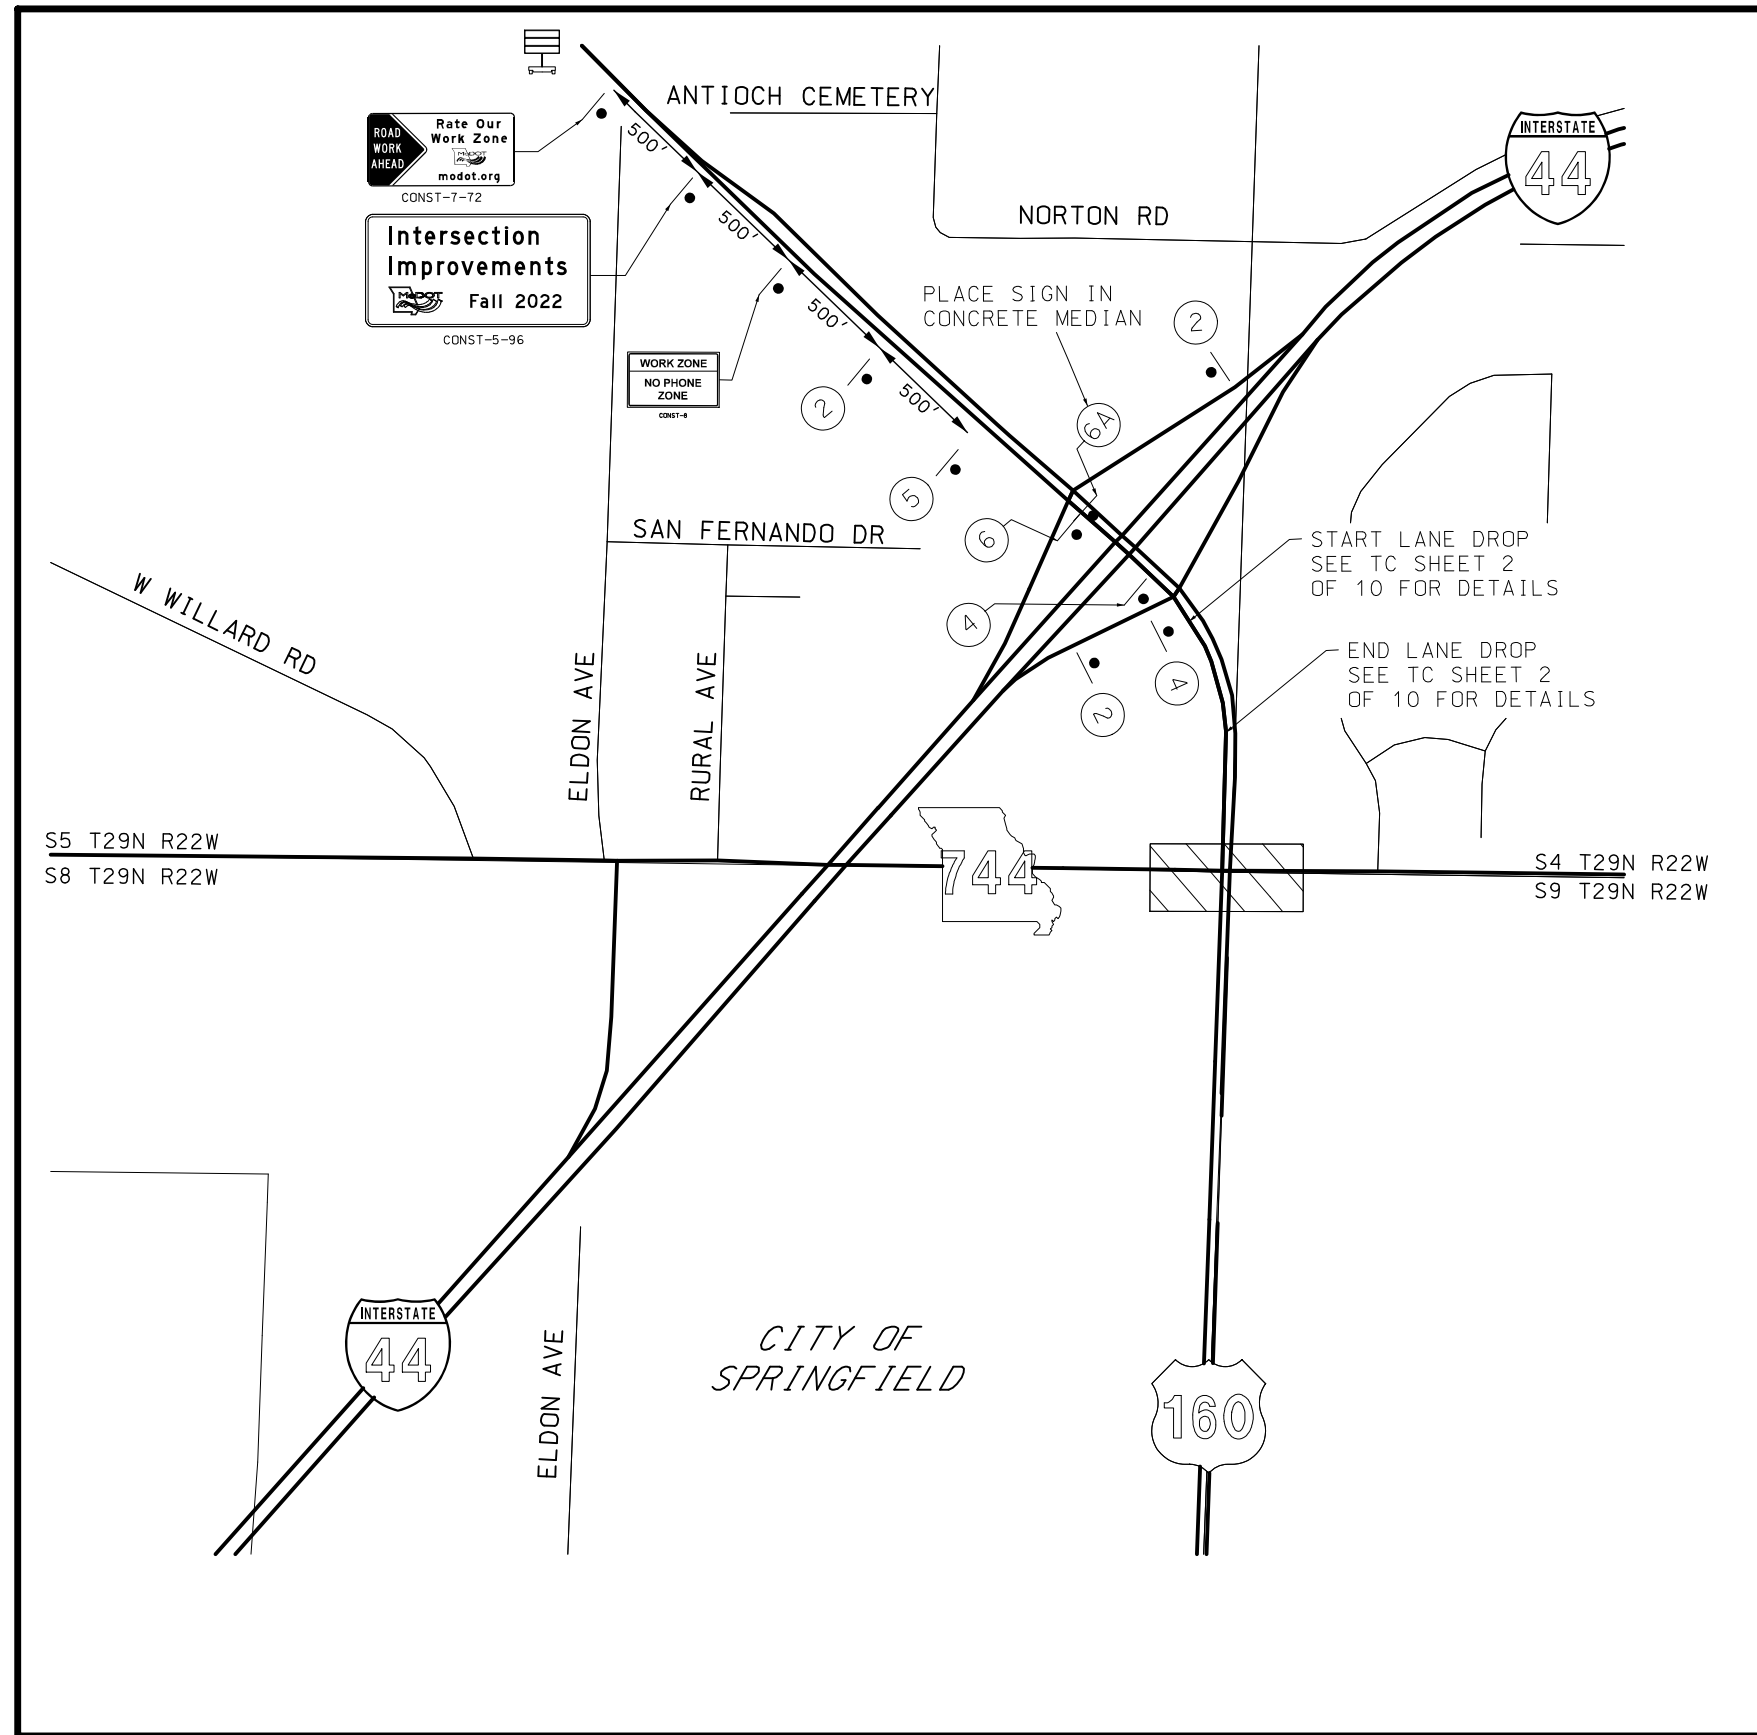

TRAFFIC CONTROL LEGEND

	SIGN (SINGLE SIDED)
	SIGN (DOUBLE SIDED)
	FLAGGER
	CONE
	CHANNELIZER
	BARRICADE
	CHANGEABLE MESSAGE BOARD


TRAFFIC CONTROL
SHEET 4 OF 10

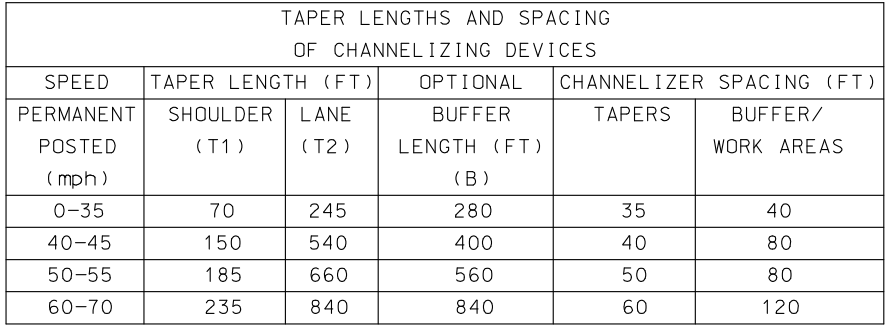

CHANNELIZERS (1)

LANE TAPER LENGTH BASED ON
12 FT. (STANDARD LANE WIDTH)
OFFSET.

IF A SEAL IS PRESENT ON THIS SHEET IT HAS BEEN ELECTRONICALLY SEALED AND DATED.

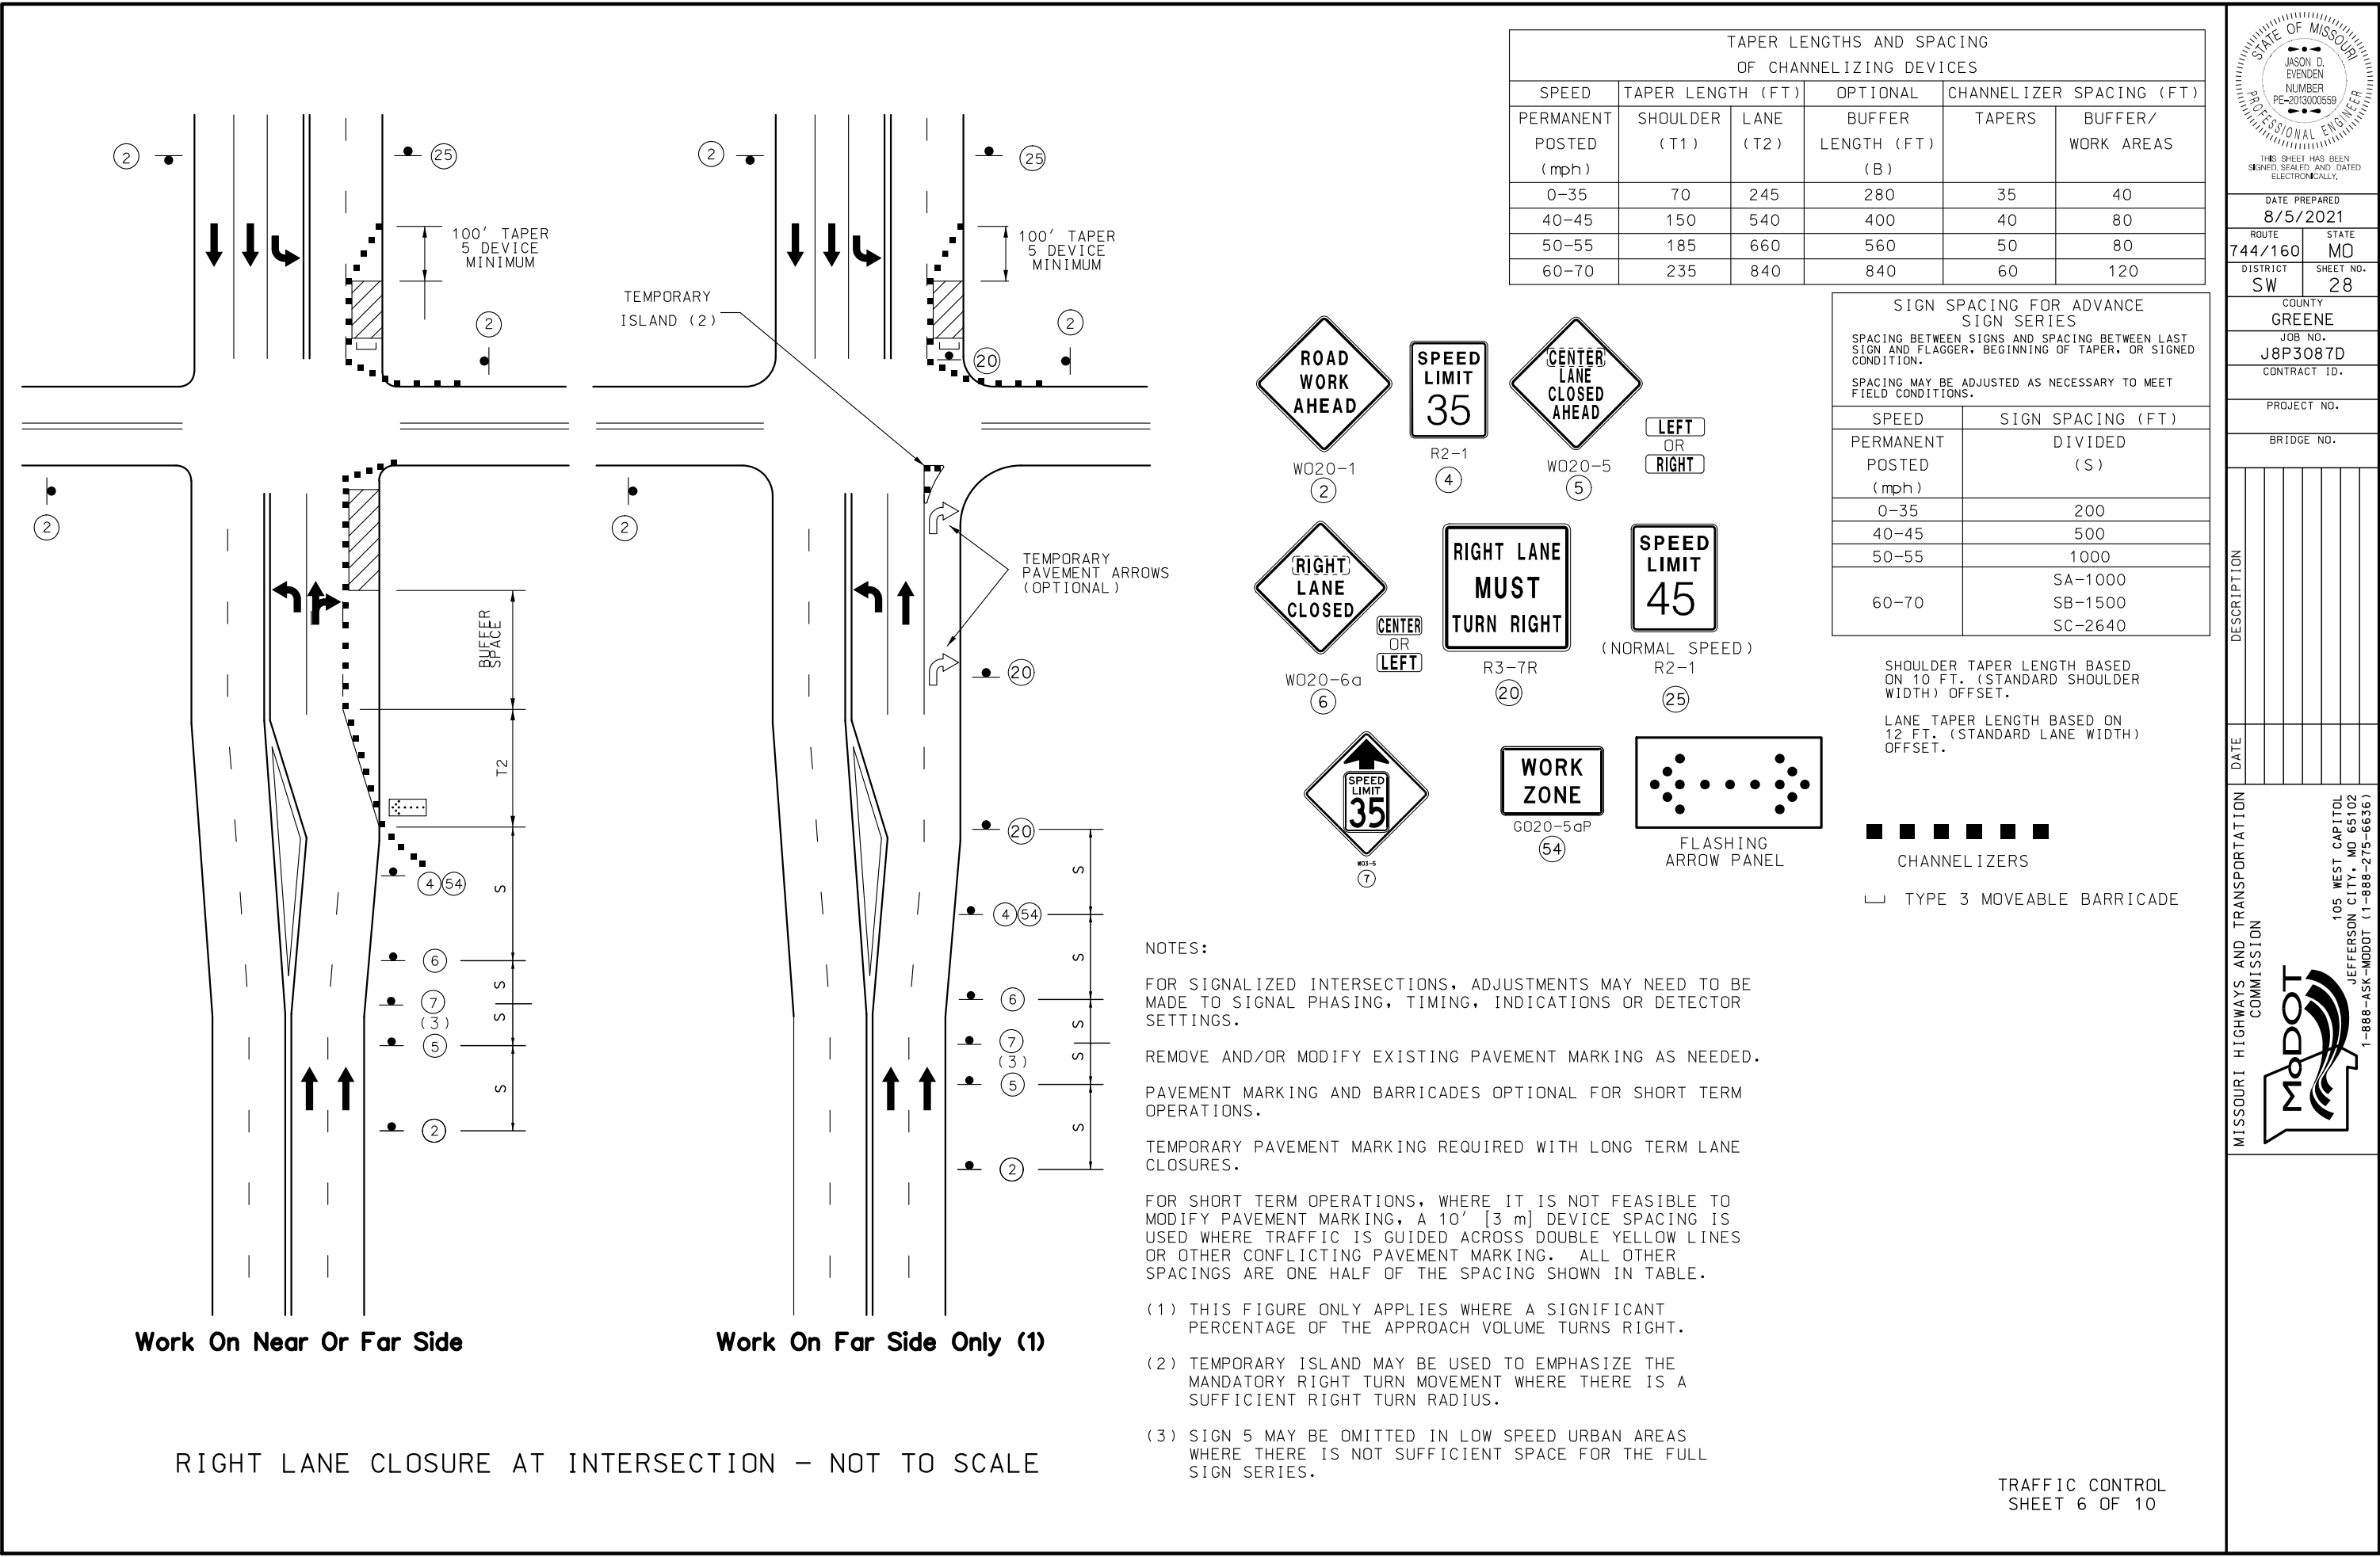

TAPER LENGTHS AND SPACING OF CHANNELIZING DEVICES					
SPEED	TAPER LENGTH (FT)		OPTIONAL	CHANNELIZER SPACING (FT)	
PERMANENT POSTED (mph)	SHOULDER (T1)	LANE (T2)	BUFFER LENGTH (FT) (B)	TAPERS	BUFFER/ WORK AREAS
0-35	70	245	280	35	40
40-45	150	540	400	40	80
50-55	185	660	560	50	80
60-70	235	840	840	60	120

SIGN SPACING FOR ADVANCE SIGN SERIES	
SPACING BETWEEN SIGNS AND SPACING BETWEEN LAST SIGN AND FLAGGER, BEGINNING OF TAPER, OR SIGNED CONDITION.	
SPACING MAY BE ADJUSTED AS NECESSARY TO MEET FIELD CONDITIONS.	
PERMANENT POSTED (mph)	SIGN SPACING (FT) DIVIDED (S)
0-35	200
40-45	500
50-55	1000
60-70	SA-1000 SB-1500 SC-2640

SHOULDER TAPER LENGTH BASED ON 10 FT. (STANDARD SHOULDER WIDTH) OFFSET.

LANE TAPER LENGTH BASED ON 12 FT. (STANDARD LANE WIDTH) OFFSET.

W020-1
(2)

R2-1
(4)

W020-5
(5)

W020-6a
(6)

CENTER OR LEFT

R3-7R
(20)

W020-5aP
(7)

G020-5aP
(54)

FLASHING ARROW PANEL

LEFT OR RIGHT

(NORMAL SPEED) R2-1
(25)

- NOTES:
- FOR SIGNALIZED INTERSECTIONS, ADJUSTMENTS MAY NEED TO BE MADE TO SIGNAL PHASING, TIMING, INDICATIONS OR DETECTOR SETTINGS.
- REMOVE AND/OR MODIFY EXISTING PAVEMENT MARKING AS NEEDED.
- PAVEMENT MARKING AND BARRICADES OPTIONAL FOR SHORT TERM OPERATIONS.
- TEMPORARY PAVEMENT MARKING REQUIRED WITH LONG TERM LANE CLOSURES.
- FOR SHORT TERM OPERATIONS, WHERE IT IS NOT FEASIBLE TO MODIFY PAVEMENT MARKING, A 10' [3 m] DEVICE SPACING IS USED WHERE TRAFFIC IS GUIDED ACROSS DOUBLE YELLOW LINES OR OTHER CONFLICTING PAVEMENT MARKING. ALL OTHER SPACINGS ARE ONE HALF OF THE SPACING SHOWN IN TABLE.
- (1) THIS FIGURE ONLY APPLIES WHERE A SIGNIFICANT PERCENTAGE OF THE APPROACH VOLUME TURNS RIGHT.
- (2) TEMPORARY ISLAND MAY BE USED TO EMPHASIZE THE MANDATORY RIGHT TURN MOVEMENT WHERE THERE IS A SUFFICIENT RIGHT TURN RADIUS.
- (3) SIGN 5 MAY BE OMITTED IN LOW SPEED URBAN AREAS WHERE THERE IS NOT SUFFICIENT SPACE FOR THE FULL SIGN SERIES.

STATE OF MISSOURI
JASON D. EVENDEN
NUMBER
PE-2013000659
PROFESSIONAL ENGINEER

THIS SHEET HAS BEEN
SIGNED, SEALED AND DATED
ELECTRONICALLY.

DATE PREPARED
8/5/2021

ROUTE
744/160

DISTRICT
SW

STATE
MO

SHEET NO.
28

COUNTY
GREENE

JOB NO.
J8P3087D

CONTRACT ID.

PROJECT NO.

BRIDGE NO.

DESCRIPTION

DATE

MISSOURI HIGHWAYS AND TRANSPORTATION COMMISSION

105 WEST CAPITOL
JEFFERSON CITY, MO 65102
1-888-ASK-MODOT (1-888-275-6636)



THE STRIPING OPERATION SHALL BE COMPLETED UNDER A LANE CLOSURE.



MISSOURI HIGHWAYS AND TRANSPORTATION
COMMISSION

105 WEST CAPITOL
JEFFERSON CITY, MO 65102
1-888-ASK-MODOT (1-888-279-6636)



IF A SEAL IS PRESENT ON THIS SHEET IT HAS BEEN ELECTRONICALLY SEALED AND DATED.

NOTES:


1. NO DIRECT PAYMENT WILL BE MADE FOR ORANGE SAFETY FENCE AS REQUIRED AROUND EXCAVATION OF SIDEWALK & CURB RAMP AREAS.
2. SEE JSP's FOR PEDESTRIAN TRAFFIC DEVICES.
3. WORKING AREAS SHALL BE GUARDED FROM PEDESTRIAN ACCESS BY BARRICADE FENCING 36" TO 48" IN HEIGHT WITH A GAP NO GREATER THAN 6" FROM THE GROUND AND HOLES NO GREATER THAN 4" IN ANY DIRECTION.
4. PEDESTRIAN ACCESS ON SIDEWALK SHALL BE PROVIDED WITH A WIDTH NOT LESS THAN 4' OF SMOOTH STABLE SURFACING ADJACENT TO BARRICADE FENCING FOR ACCESS TO THE MAIN BUILDING.
5. SIDEWALK RAMP CLOSURES FOR RECONSTRUCTION SHALL BE PERFORMED WITH ADA COMPLIANT MOVEABLE BARRICADES. TWO BARRICADES PER PEDESTRIAN APPROACH. ONE SIDEWALK CLOSED SIGN WILL BE PLACED UPON ONE BARRICADE FOR EACH APPROACH, NO MORE THAN ONE 5' SECTION OF SIDEWALK RAMP SHALL BE CLOSED LEADING TO THE MAIN BUILDING AT ANY TIME ADJACENT TO THE WORK AREA.

MULTI-LANE
TYPICAL SIDEWALK CLOSURE

NOT TO SCALE

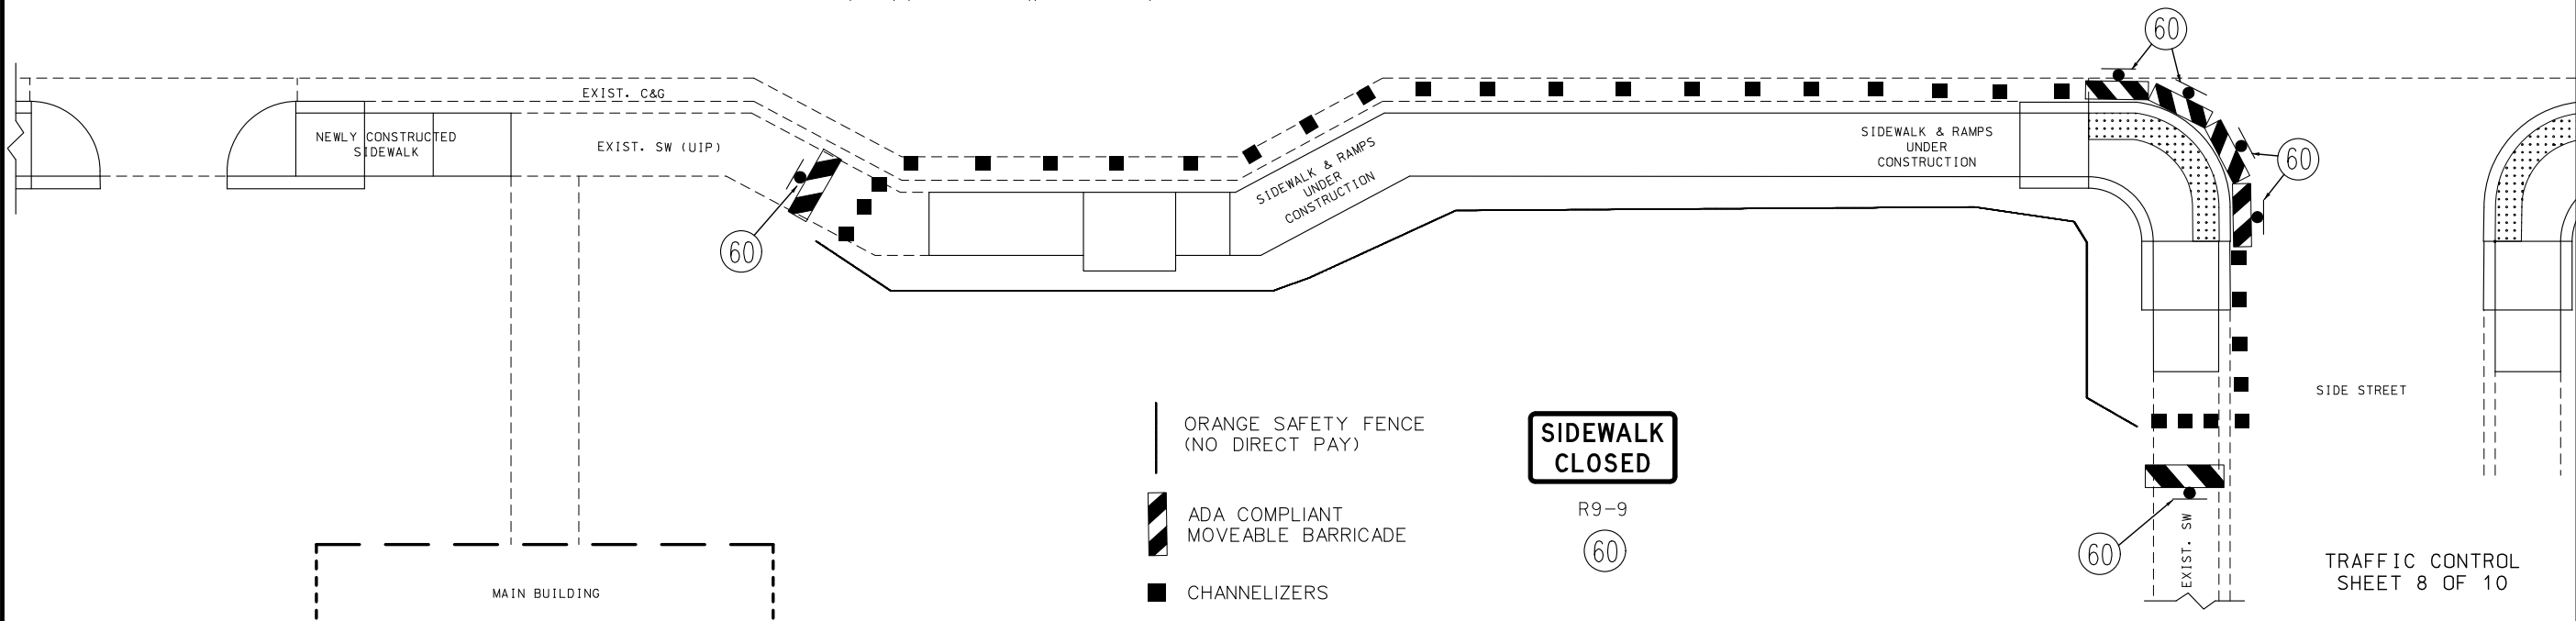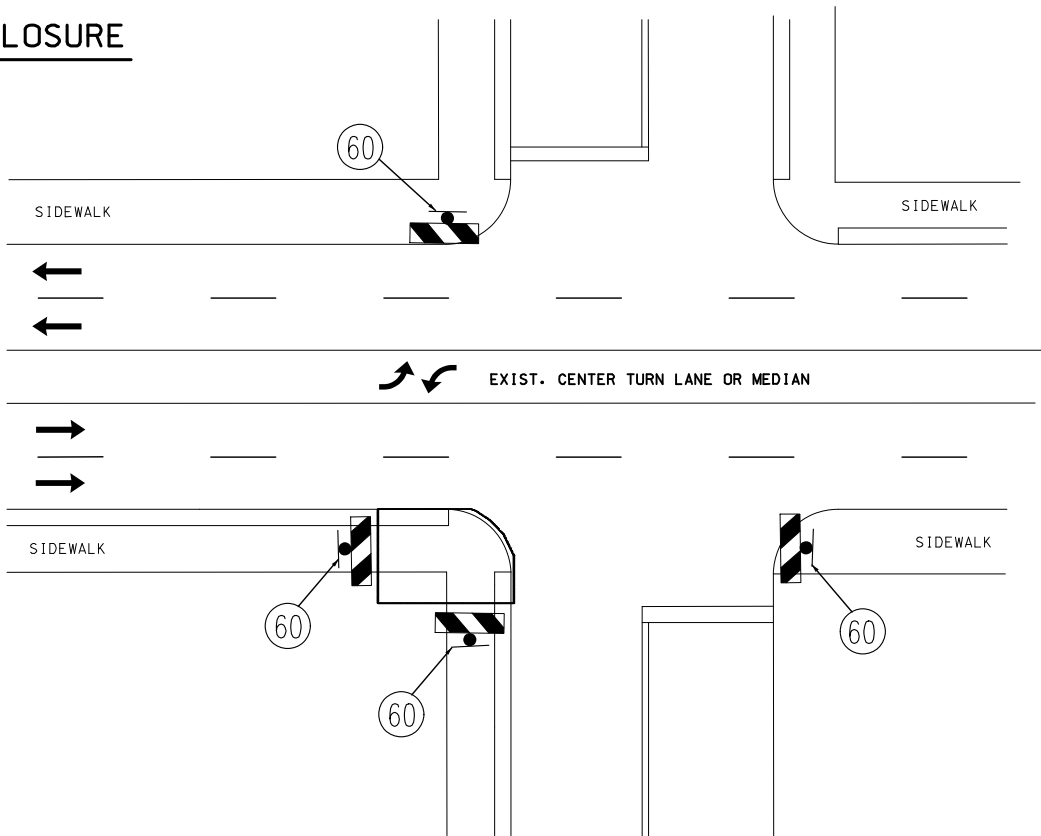


ORANGE PLASTIC SAFETY FENCE

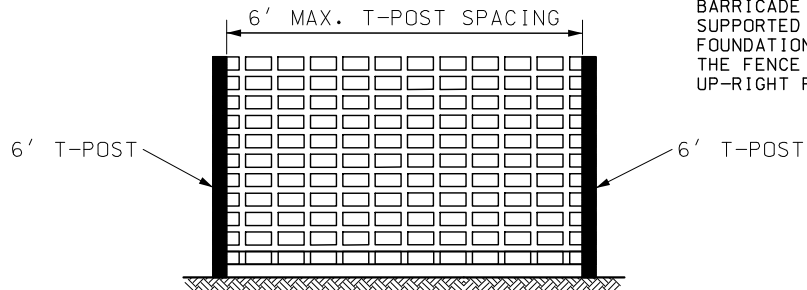

NO DIRECT PAY.
PLASTIC SAFETY NETTING USED FOR
BARRICADE FENCING SHALL BE
SUPPORTED WITH T-POST, ADEQUATE
FOUNDATIONS, AND BALLAST SO THAT
THE FENCE REMAINS TAUT AND IN AN
UP-RIGHT POSITION.




ADA COMPLIANT MOVEABLE BARRICADE

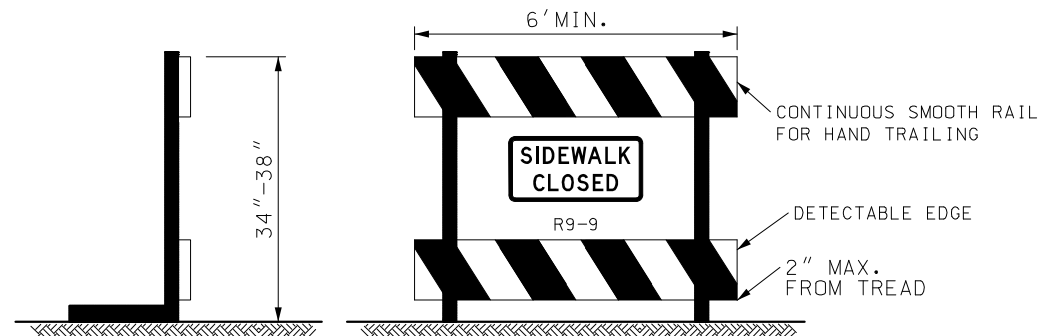

1. WARNING LIGHTS SHALL NOT BE ATTACHED TO ADA COMPLIANT BARRICADES.
2. CHEVRON RAILS ON THE ADA COMPLIANT BARRICADES MUST BE 8" WIDE MIN. AND MEET TYPE 3 RETRO-REFLECTIVE SHEETING AND COLOR CONTRAST BARRICADE RAILS AS SHOWN. THE TOP RAIL MUST PROVIDE A SMOOTH CONTINUOUS RAIL SURFACE SUITABLE FOR HAND TRAILING WITH NO SPLINTERS, BURRS, OR SHARP EDGES. A MINIMUM OF TWO 8" WIDE RAILS IS REQUIRED.
3. NO TRIPPING HAZARDS FROM THE BARRICADES ARE ALLOWED WITHIN THE PEDESTRIAN SPACE. THIS MEANS NO FEET OR BARS USED TO HOLD THE RAILS OR SUPPORT THE DEVICE ARE ALLOWED WITHIN THE WALKWAY. ALL FEET AND BALLASTS WILL NEED TO BE BEHIND THE DEVICE.
4. THE BARRICADE MUST BE THE FULL WIDTH OF THE CLOSED SIDEWALK.

REVISED: 11-19-2018

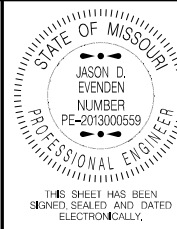

DATE PREPARED 8/5/2021	
ROUTE 744/160	STATE MO
DISTRICT SW	SHEET NO. 30
COUNTY GREENE	
JOB NO. J8P3087D	
CONTRACT ID.	

PROJECT NO.
BRIDGE NO.

DESCRIPTION	DATE



IF A SEAL IS PRESENT ON THIS SHEET IT HAS BEEN ELECTRONICALLY SEALED AND DATED.




BEGIN/END OF PROJECT SIGNING
MULTI-LANE

105 WEST CAPITOL
JEFFERSON CITY, MO 65102

IF A SEAL IS PRESENT ON THIS SHEET IT HAS BEEN ELECTRONICALLY SEALED AND DATED.

NOTE
ALL DISTURBED AREAS SHALL
BE PERMANENTLY SEEDED,
MULCHED, AND FERTILIZED
PER MODOT STANDARDS

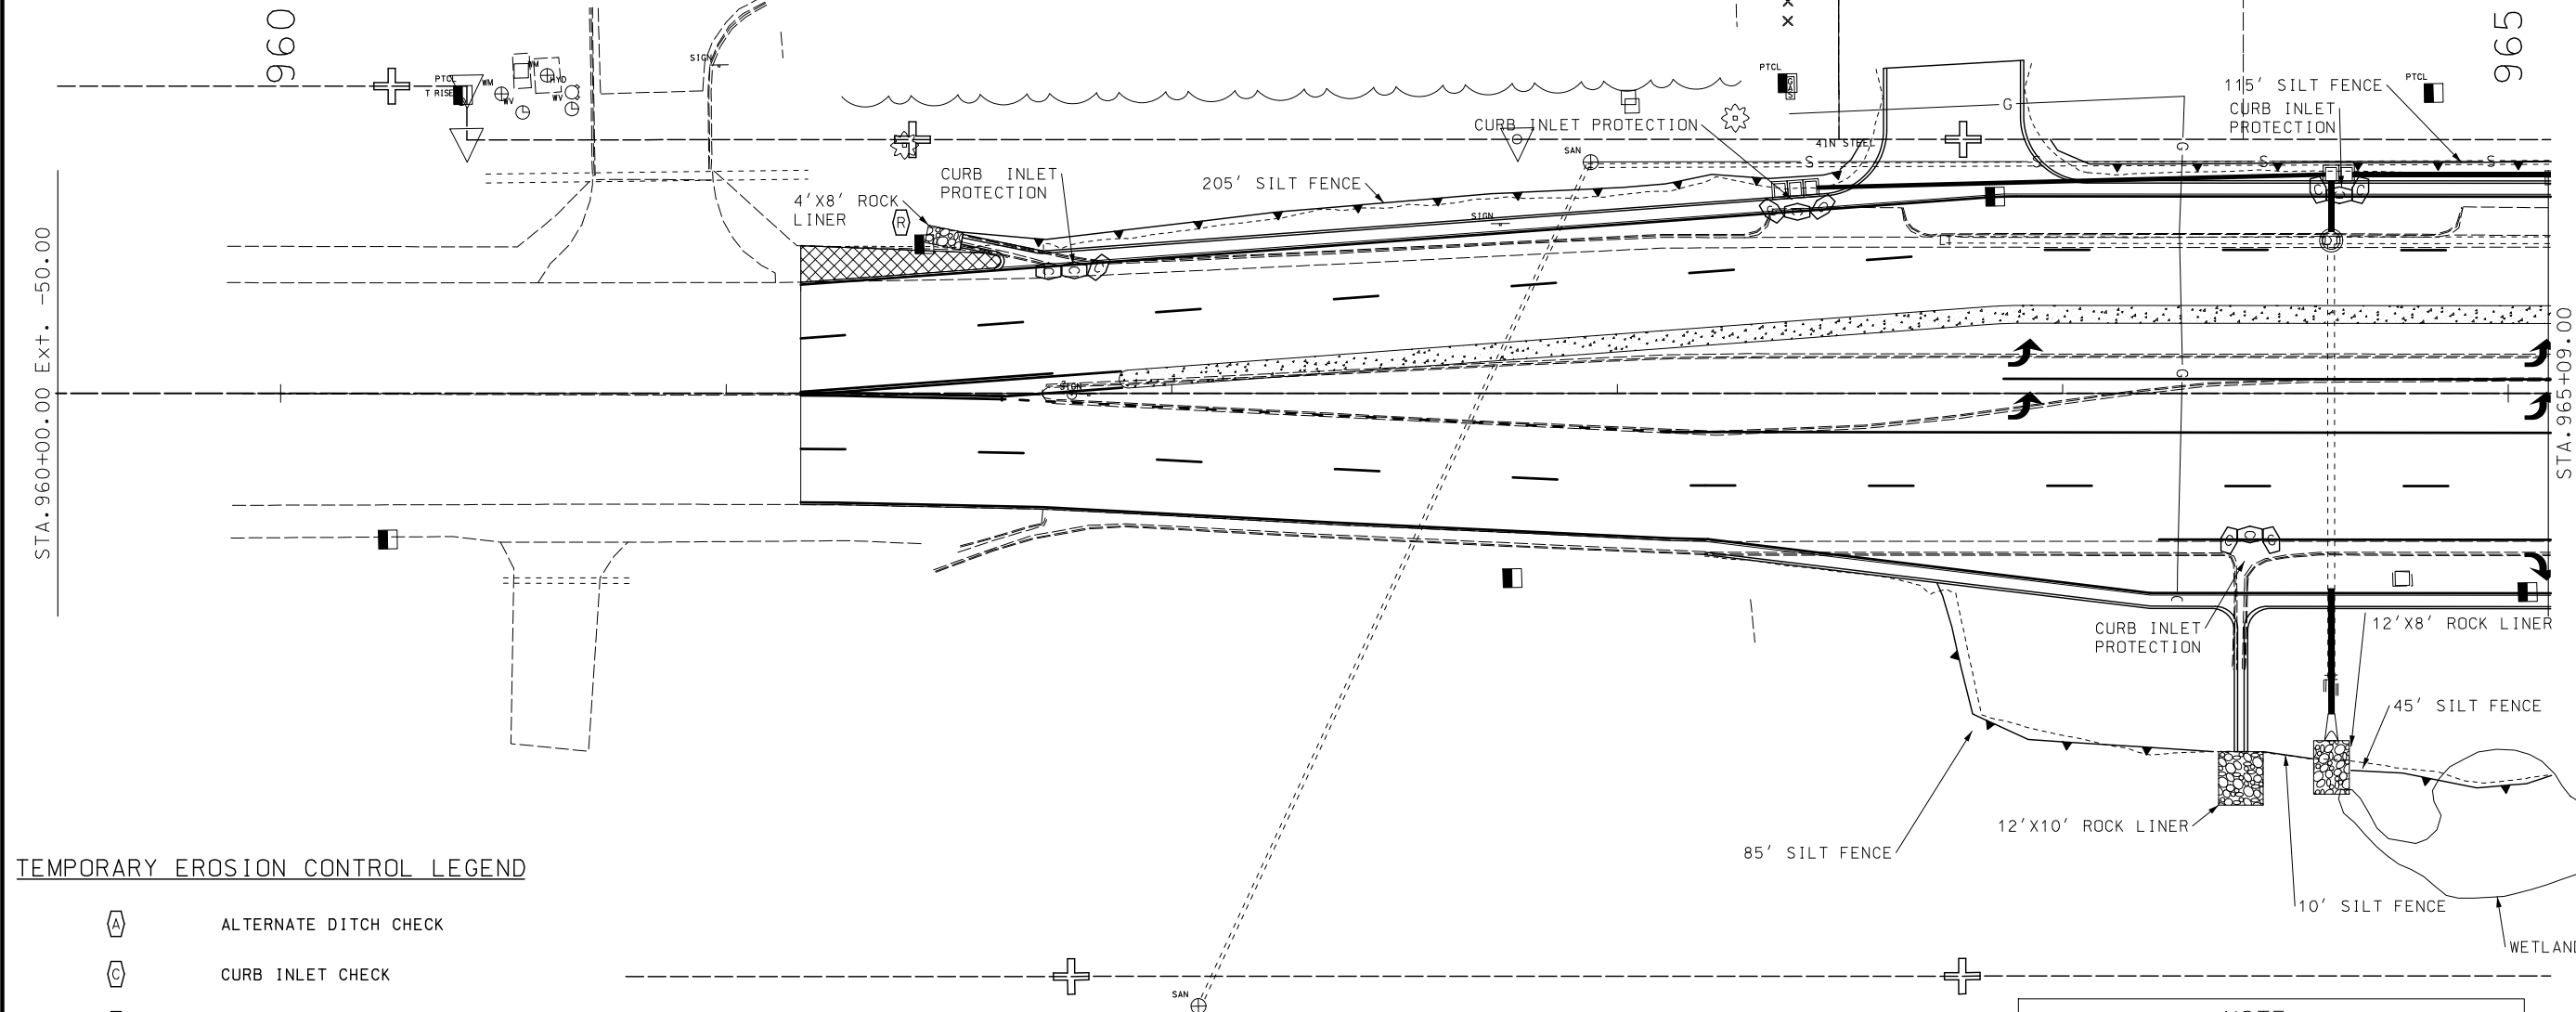


TEMPORARY EROSION CONTROL LEGEND

- ALTERNATE DITCH CHECK
- CURB INLET CHECK
- ROCK DITCH CHECK
- SEDIMENT TRAP
- SILT FENCE



NOTE
MINIMIZED CONSTRUCTION DAMAGE
TO EXISTING WETLANDS AREA

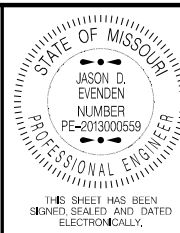


DATE PREPARED 8/8/2021	
ROUTE MO744	STATE MO
DISTRICT SW	SHEET NO. 33
COUNTY GREENE	
JOB NO. J8P3087D	
CONTRACT ID.	
PROJECT NO.	
BRIDGE NO.	

DESCRIPTION	DATE

MISSOURI HIGHWAYS AND TRANSPORTATION
COMMISSION

105 WEST CAPITOL
JEFFERSON CITY, MO 65102
1-888-ASK-MODOT (1-888-275-6636)

IF A SEAL IS PRESENT ON THIS SHEET IT HAS BEEN ELECTRONICALLY SEALED AND DATED.

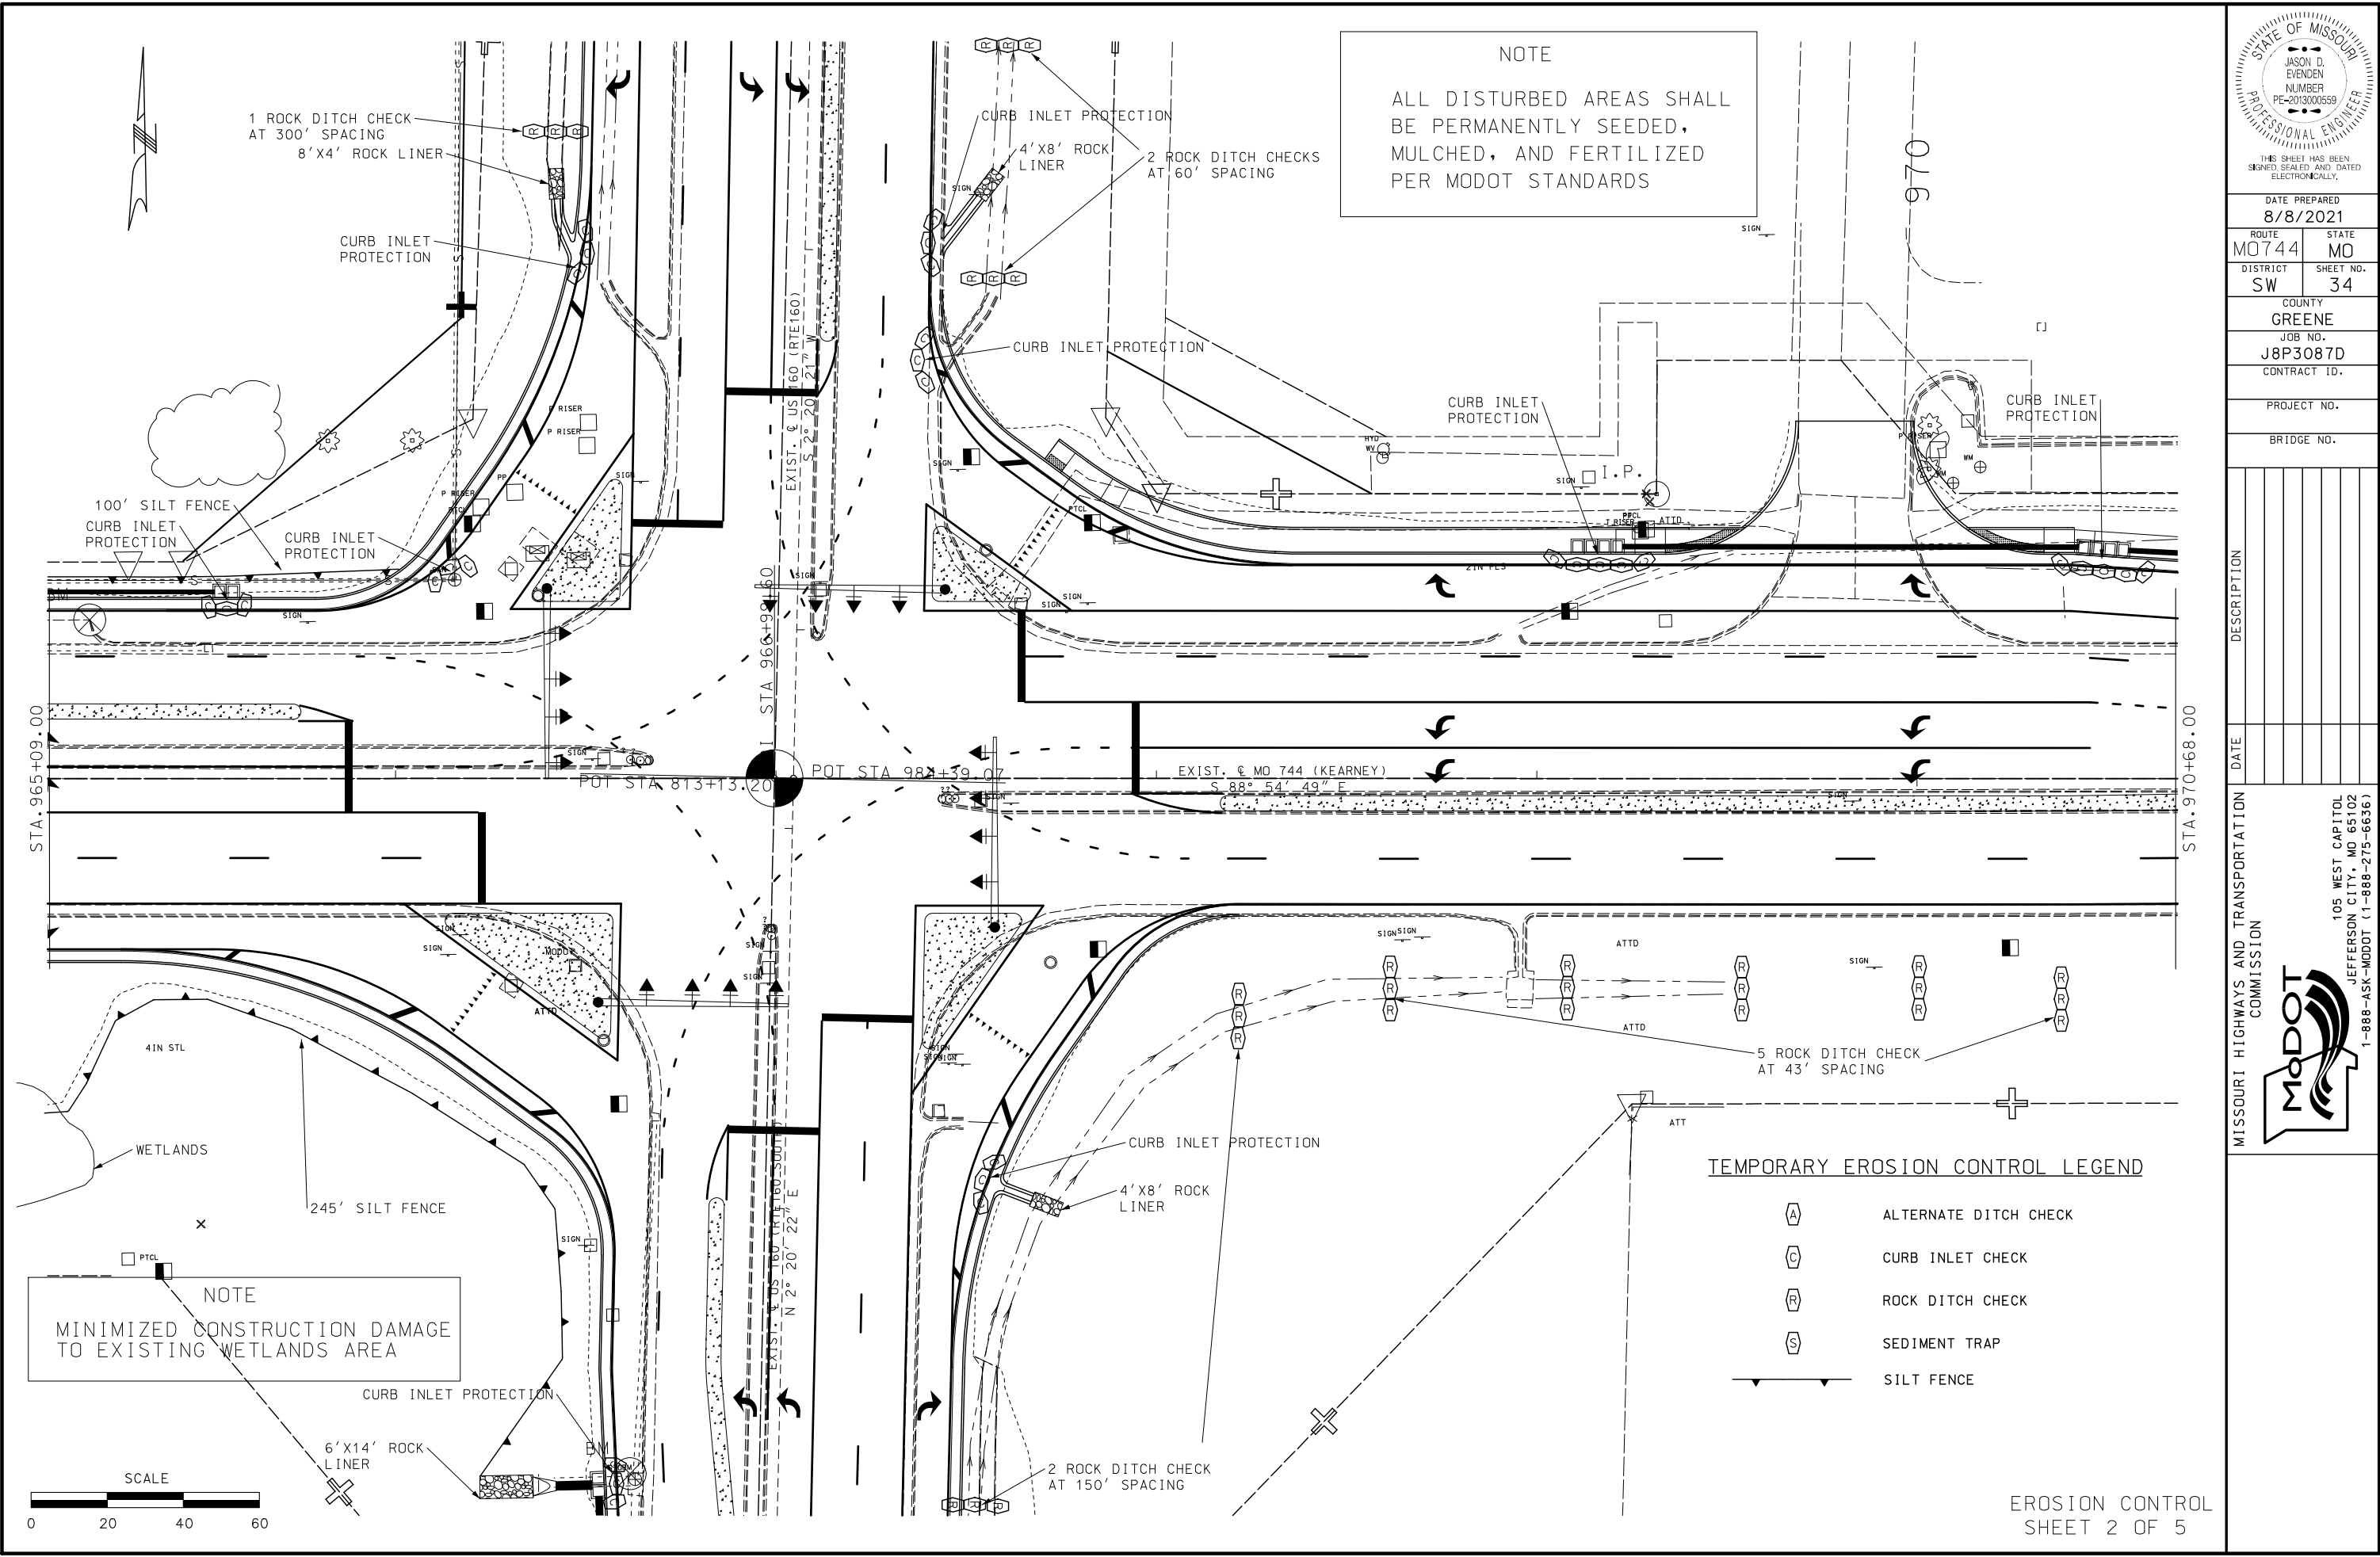

NOTE
ALL DISTURBED AREAS SHALL
BE PERMANENTLY SEEDDED,
MULCHED, AND FERTILIZED
PER MODOT STANDARDS

NOTE
MINIMIZED CONSTRUCTION DAMAGE
TO EXISTING WETLANDS AREA

TEMPORARY EROSION CONTROL LEGEND

- (A) ALTERNATE DITCH CHECK
- (C) CURB INLET CHECK
- (R) ROCK DITCH CHECK
- (S) SEDIMENT TRAP
- SILT FENCE

STATE OF MISSOURI

JASON D. EVENDEN

NUMBER

PE-2013000659

PROFESSIONAL ENGINEER

THIS SHEET HAS BEEN

SIGNED, SEALED AND DATED

ELECTRONICALLY.

DATE PREPARED

8/8/2021

ROUTE

MO 744

STATE

MO

DISTRICT

SW

SHEET NO.

34

COUNTY

GREENE

JOB NO.

J8P3087D

CONTRACT ID.

PROJECT NO.

BRIDGE NO.

DESCRIPTION

DATE

MISSOURI HIGHWAYS AND TRANSPORTATION

COMMISSION

 
105 WEST CAPITAL

JEFFERSON CITY, MO 65102

1-888-ASK-MODOT (1-888-275-6636)

IF A SEAL IS PRESENT ON THIS SHEET IT HAS BEEN ELECTRONICALLY SEALED AND DATED.

ALL DISTURBED AREAS SHALL
BE PERMANENTLY SEEDED,
MULCHED, AND FERTILIZED
PER MODOT STANDARDS




	ALTERNATE DITCH CHECK
	CURB INLET CHECK
	ROCK DITCH CHECK
	SEDIMENT TRAP
	SILT FENCE

EROSION CONTROL
SHEET 4 OF 5





IF A SEAL IS PRESENT ON THIS SHEET IT HAS BEEN ELECTRONICALLY SEALED AND DATED.

NOTE
ALL DISTURBED AREAS SHALL
BE PERMANENTLY SEEDED,
MULCHED, AND FERTILIZED
PER MODOT STANDARDS

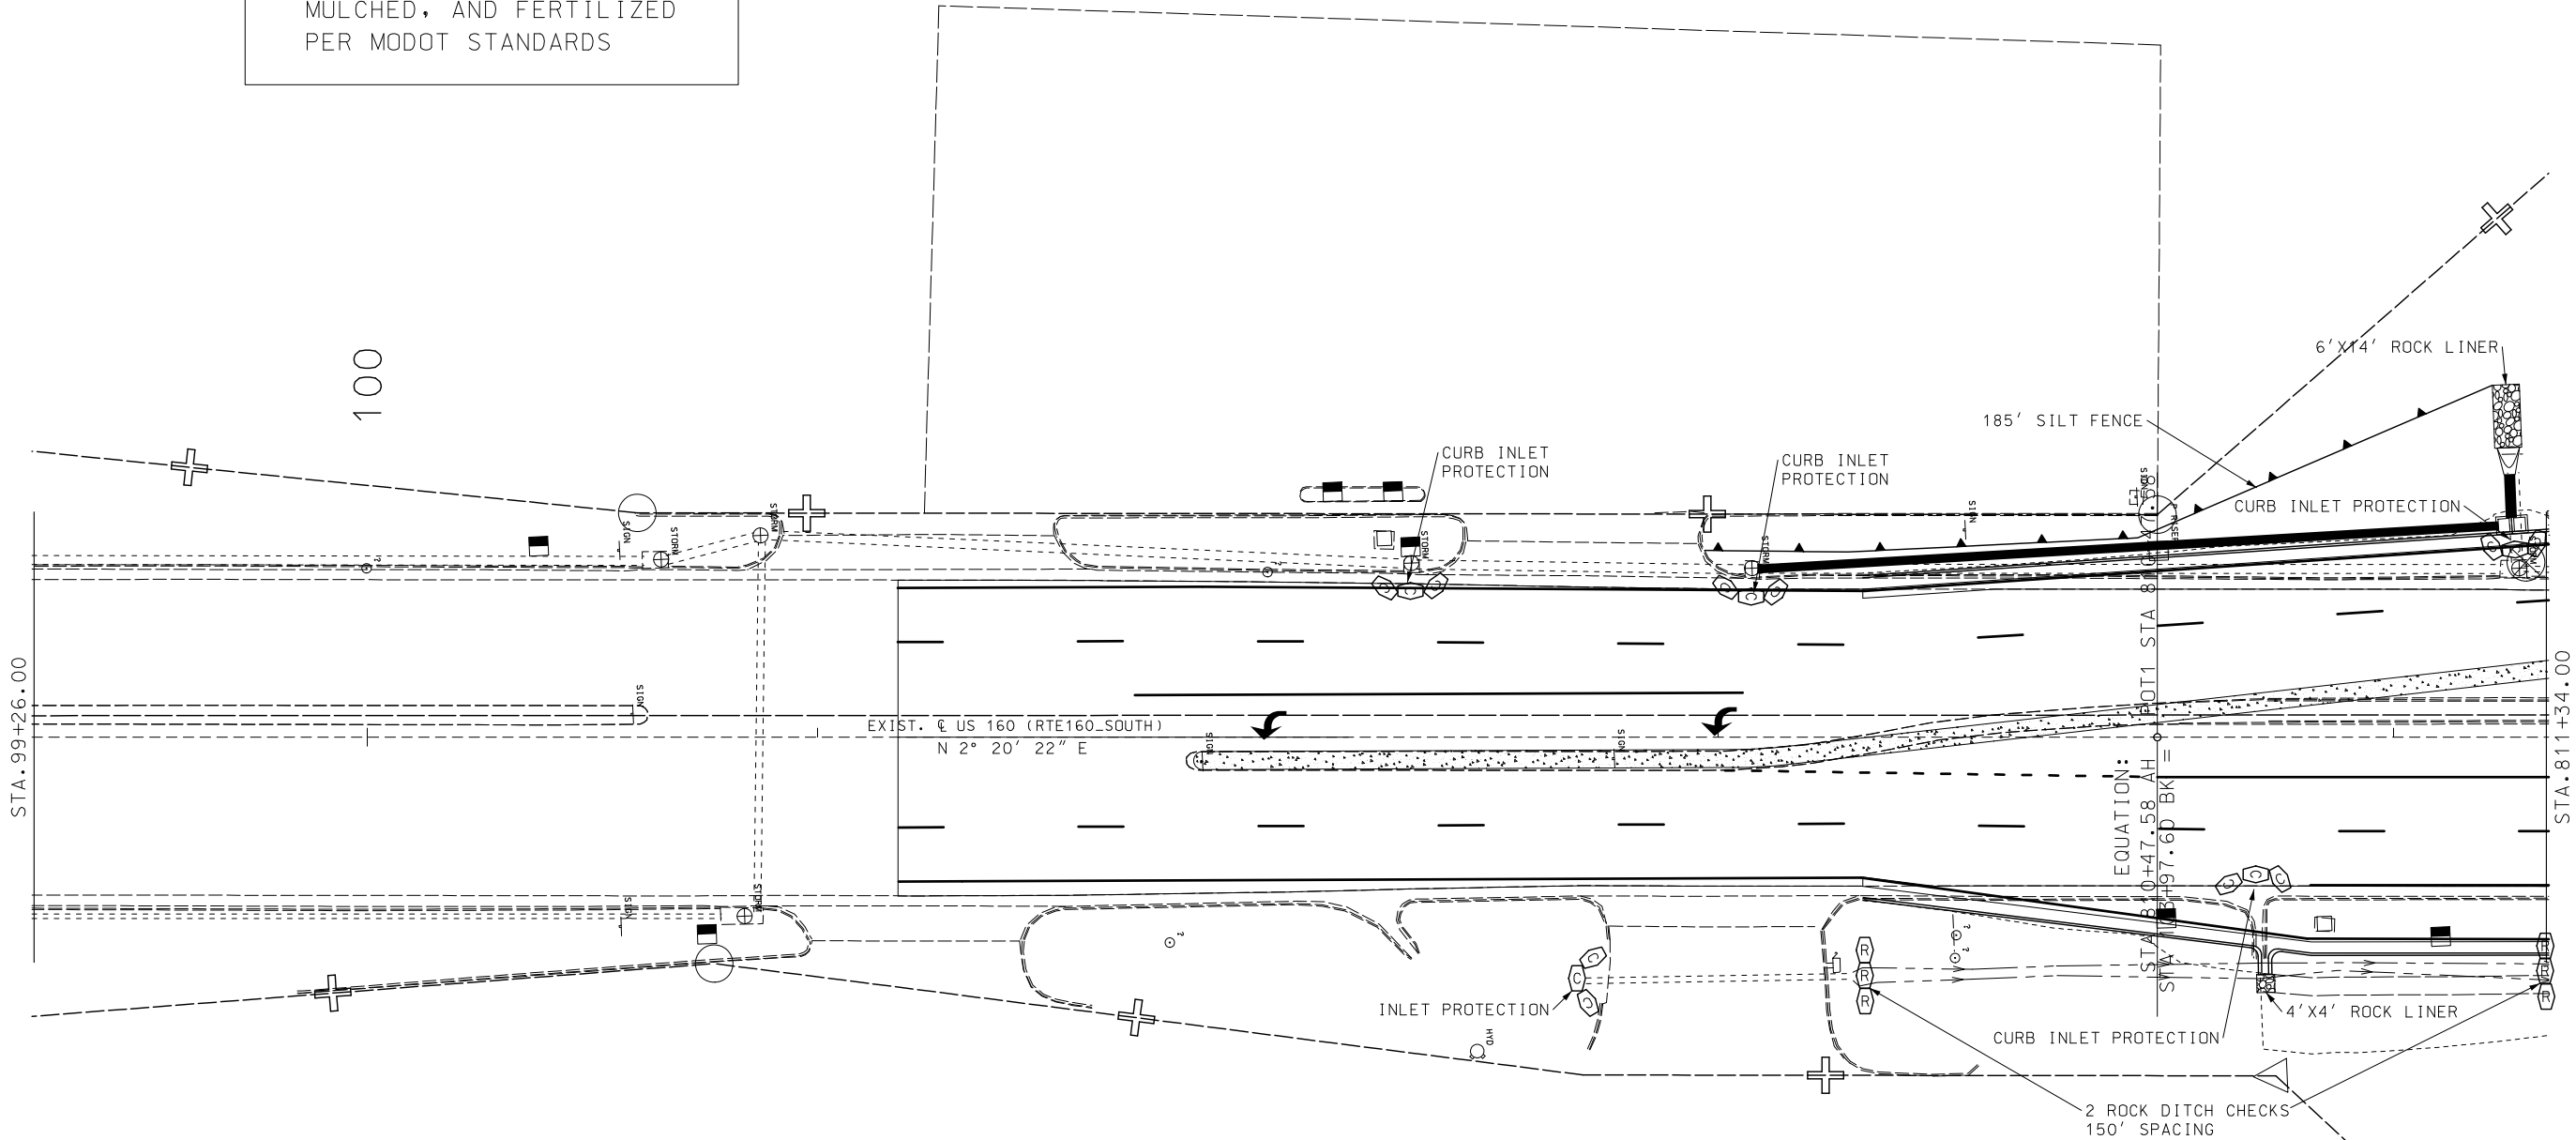

TEMPORARY EROSION CONTROL LEGEND

 - (A) ALTERNATE DITCH CHECK
- (C) CURB INLET CHECK
- (R) ROCK DITCH CHECK
- (S) SEDIMENT TRAP
- SILT FENCE

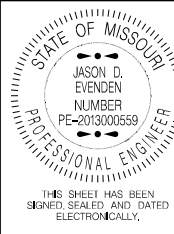

DATE PREPARED 8/8/2021	
ROUTE MO744	STATE MO
DISTRICT SW	SHEET NO. 37
COUNTY GREENE	
JOB NO. J8P3087D	
CONTRACT ID.	
PROJECT NO.	
BRIDGE NO.	

DATE	DESCRIPTION

MISSOURI HIGHWAYS AND TRANSPORTATION
COMMISSION

105 WEST CAPITOL
JEFFERSON CITY, MO 65102
1-888-ASK-MODOT (1-888-275-6636)

IF A SEAL IS PRESENT ON THIS SHEET IT HAS BEEN ELECTRONICALLY SEALED AND DATED.

EFFECTIVE: 07/01/2018	STATE OF MISSOURI JASON D. EVENDEN NUMBER PE-2013000559 PROFESSIONAL ENGINEER THIS SHEET HAS BEEN SIGNED, SEALED AND DATED ELECTRONICALLY.		
	DATE PREPARED 8/26/2021		
	ROUTE 744/160	STATE MO	
	DISTRICT SW	SHEET NO. 40	
	COUNTY GREENE		
	JOB NO. J8P3087D		
	CONTRACT ID.		
	PROJECT NO.		
	BRIDGE NO.		
	DESCRIPTION		
	DATE		
	MISSOURI HIGHWAYS AND TRANSPORTATION COMMISSION		
MODOT 105 WEST CAPITOL JEFFERSON CITY, MO 65102 1-888-ASK-MODOT (1-888-275-6636)			

SIGNAL SHEET
SHEET 3 OF 8

D-37A

REMARKS

ALL LENGTHS AND SPACINGS ARE IN FEET UNLESS OTHERWISE INDICATED.

* ITEMS FOR WHICH SEPARATE PAYMENT WILL NOT BE MADE.

** SEE STANDARD PLANS 902.10 AND 902.30 FOR CONCRETE REQUIREMENTS ON BASES.

*** USE D3-16 FOR ONE LINE. USE D3-18 FOR TWO LINE.

SIGNAL STRUCTURES WHICH WILL EXCEED THE DIMENSION LIMITS SHOWN ON STANDARD PLAN SHEETS IN SECTION 902 AND ANY OTHER INSTALLATION WHERE THE DETAILS OF CONSTRUCTION ARE NOT FURNISHED IN THE CONTRACT PLANS, SHALL BE DESIGNED BY A PROFESSIONAL ENGINEER IN ACCORDANCE WITH THE 2001 AASHTO STANDARD SPECIFICATIONS FOR STRUCTURAL SUPPORTS FOR HIGHWAY SIGNS, LUMINAIRES AND TRAFFIC SIGNALS, 4TH EDITION, AND LATEST INTERIMS. THE STRUCTURE SHALL BE DESIGNED AS IMPORTANCE CATEGORY I FOR FATIGUE WITH A 50-YEAR DESIGN LIFE. THE CONTRACTOR SHALL SUBMIT A SET OF SHOP DETAIL DRAWINGS INCLUDING WELD PROCEDURE SPECIFICATIONS AND DESIGN COMPUTATIONS FOR MODOT RECORDS AND REFERENCE. THE SUBMITTED DRAWINGS AND CALCULATIONS SHALL BE SIGNED AND SEALED IN ACCORDANCE WITH THE LAWS RELATING TO ARCHITECTS AND PROFESSIONAL ENGINEERS (CHAPTER 327, RSMO.), AND SHALL INCLUDE A TITLE BLOCK OR SUMMARY SHEET WHICH LISTS AND CERTIFIES THAT THE PRODUCT MEETS ALL OF THE SPECIFIED DESIGN CRITERIA.

LEGEND

T - TOP MOUNT
S - SIDE MOUNT
C - SPANWIRE MOUNT
B - MAST ARM MOUNT

SIGNAL SHEET
SHEET 3 OF 8

CONDUIT (WITH #14 TRACER WIRE)																	CABLE																		
FROM	TO	CENTER TO CENTER DISTANCE	LOOP DET. 1"	TRENCH				PUSHED			MEDIAN			ON STRUCTURE			REMARKS	FROM	TO	CENTER TO CENTER DISTANCE	POWER		CONTROL				RADAR DETECTION SENSOR 6c	LUMINAIRE		DETECTOR		FIBER 24 COUNT	EX. FIBER RELOCATION	ETHERNET	REMARKS
				2"	3"	4"	2"	3"	4"	2"	3"	4"	2"	3"	1c #1/0	1c #8					2c #16	5c #16	7c #16	3c #16	CONTROL	POLE & BRACKET		1c #14 IN DUCT	2c #14 LEAD-IN CABLE	6 MULT-MODE 18 SINGLE-MODE					
																															2c #12	1c #10			
source	Ø ₁	10		14													source	Ø ₁	10	54															
Ø ₁	☒	6		14													Ø ₁	☒	6		66													3 POWER CABLES	
Ø ₁	☒	13		21													Ø ₁	☒	13		87													3 POWER CABLES	
☒	☒	7		15													☒	☒	7														118	CAT 6e	
☒	1	18			42												☒	▽41	122					181										ON POST 1	
1	2	66			128												▽41	▽42	12					18										JUMPER ON POST 1	
2	①	14			17												☒	▽70	143					230										ON POST 1	
																	▽70	▽71	12					18										JUMPER ON POST 1	
2	3	105															☒	▽21	256					328										ON POST 4	
3	②	15							18								▽21	▽22	12					18										JUMPER ON POST 4	
																	☒	▽50	278					372										ON POST 4	
3	4	92							90								▽50	▽51	12					18										JUMPER ON POST 4	
4	③	15							18								☒	▽81	349					429										ON POST 3	
																	▽81	▽82	12					18										JUMPER ON POST 3	
4	5	115			9				104								☒	▽30	342					443											ON POST 3
5	④	30			33												▽30	▽31	12					18										JUMPER ON POST 3	
																	☒	▽61	484					568										ON POST 2	
☒	6	18		21													▽61	▽62	12					18										JUMPER ON POST 2	
6	7	133		59				72									☒	▽10	469					574										ON POST 2	
7	8	58		56													▽10	▽11	12					18										JUMPER ON POST 2	
8	9	244															☒	△1	116					175										SENSOR ON POST 1	
																	☒	△2	220					286										SENSOR ON POST 4	
																	☒	△3	314					388										SENSOR ON POST 3	
6	1	8		6													☒	△4	445					522										SENSOR ON POST 2	
3	12	65		62																															
12	13	200		168				30																											
source	Ø ₂	214		218																															
Ø ₂	11	9		12																															
11	EX3	275		273														Ø ₁	☒	143					168	76								ON POST 1	
																		☒	☒	179					190	76								ON POST 2	
6	10	254		257														☒	☒	162					173	76								ON POST 3	
10	EX2	273		271														☒	☒	200					211	76								ON POST 4	
																		source	Ø ₂	214	666														
																		EX2	☒	540														614	RELOC. EX.
																	☒	☒	531															654	RELOC. EX.
																	☒	13	462															520	RELOC. EX.

POWER SUPPLY														
LOCATION			POWER SUPPLY ASSEMBLY		CIRCUIT BREAKER TRIP RATING*				LIGHTING CONTROL * (ON POWER SUPPLY)			SERVICE POLE		
APPROACH	STATION	OFFSET	DRAWING 902.15	DRAWING	CONTROLLER		POWER SUPPLY DISCONNECT		120 VOLT CONTROL CABINET		MAIN BREAKER	CONTRACT FURNISH	UTILITY COMPANY	
					AUXILIARY BREAKER	CONT & SIGNAL LAMPS	MAIN BREAKER							
									SIGNALS	LIGHTING				
ROUTE 744	965+87.03	80.7' RT	Type 2		15 Amps	50 Amps	50 Amps	20 Amps	1		20 Amps	Cl.	Ft.	
ROUTE 160 N	981+49.46	88.1' RT	Type 2		15 Amps	50 Amps	100 Amps	Amps			Amps	Cl.	Ft.	
		TOTAL	2											

[illegible]

CONTRACTOR FURNISHED, CONTRACTOR INSTALLED RADAR DETECTION SYSTEM
1 EACH

UNINTERRUPTIBLE POWER SUPPLY				
LOCATION			QUANTITY 902-99.02 EACH	REMARKS
APPROACH	STATION	OFFSET		
ROUTE 744	965+87.03	80.7' LT	1	MOUNT TO TYPE 2 POWER SUPPLY
SEE JOB SPECIAL PROVISIONS FOR MORE DETAIL				

SIGNAL SIGNS					
QUANTITY	MUTCD SIGN NUMBER	SIZE	AREA	SIGN TOTAL AREA	SIGNAL SIGN MOUNTING HARDWARE
		INCHES	SQ.FT.	SQ.FT.	EA.
	R10-10L	24 X 30	5.0		
	R10-10R	24 X 30	5.0		
	R3-5L	30 X 36	7.5		
	R3-5R	30 X 36	7.5		
	R3-5A	30 X 36	7.5		
	R3-6L	30 X 36	7.5		
	R3-6R	30 X 36	7.5		
	R3-2	24 X 24	4.0		
	R3-1	24 X 24	4.0		
	R3-3	24 X 24	4.0		
	D3-1 ***	VAR. X 18	9.0	18.0	2
	D3-1B ***	VAR. X 18	10.5	21.0	2
	R10-3E	9 X 15	0.9		
	R10-11A	24 X 30	5.0		
	R10-13	36 X 24	6.0		
	R10-27A	30 X 36	7.5		
			SUBTOTAL	39.0	4
			TOTAL	39	4

*** SEE SIGNING SHEET D-31 FOR
STREET SIGN DETAILS. KEARNEY ST
USED ON POSTS 2 & 4, WEST BYPASS
USED ON POSTS 1 & 3.

[illegible][illegible]

TOTAL NUMBER OF DETECTOR CARDS(2-CHANNEL) = 8

2070 OUTPUT FILE ASSIGNMENTS							MONITOR
FR1	10	21		30	41		
FR2	11	22		31	42		
FR3	50	61		70	81		
FR4	51	62		71	82		


* ITEMS FOR WHICH SEPARATE PAYMENT WILL NOT BE MADE.

SIGNAL SHEET
SHEET 5 OF 8

RTE. 744 (KEARNEY ST) & ROUTE 160 (WEST BY-PASS)

INTERSECTION

D-37C

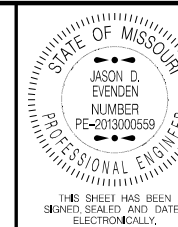

DATE PREPARED
8/26/2021

ROUTE 744/160	STATE MO
DISTRICT SW	SHEET NO. 42

COUNTY

GREENE

JOB NO.


J8P3087D

CONTRACT ID.

1. *Journal of Management Studies*, 1996, 33, 1, 1-14.

PROJECT NO.

 1. *Journal of Management Studies*, 1996, 33, 1, 1-14.



--	--	--	--

[illegible][illegible]

[illegible]


SIGNING SHEET
SHEET 3 OF 9

DATE PREPARED 8/6/2021	
ROUTE 744/160	STATE MO
DISTRICT SW	SHEET NO. 48
COUNTY GREENE	
JOB NO. J8P3087D	
CONTRACT ID.	
PROJECT NO.	
BRIDGE NO.	

[illegible]MISSOURI HIGHWAYS AND TRANSPORTATION
COMMISSION

105 WEST CAPITOL
JEFFERSON CITY, MO 65102
1-888-ASK-MODOT (1-888-275-6636)


SIGNS TO BE MOUNTED ON SIGNAL MAST ARMS.
SEE SIGNAL SHEETS FOR DETAILS.

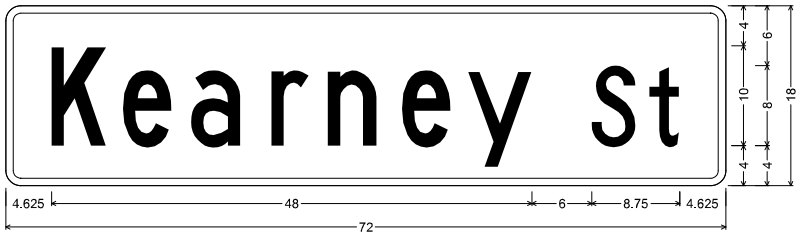

D3-1 SH-FLAT SHEET;
1,500" Radius, 0,750" Border, White on, Green;
"Kearney", C; "St", C;
Table of letter and object lefts

K	e	a	r	n	e	y	S	t
4.625	11.750	18.500	26.625	32.250	39.625	46.250	58.625	64.375

SIGN NO.	30	LOCATION
STATION	966+59.07 RT	ON MAST ARM
STATION	967+38.58 LT	ON MAST ARM
ROADWAY	RTE. 744	

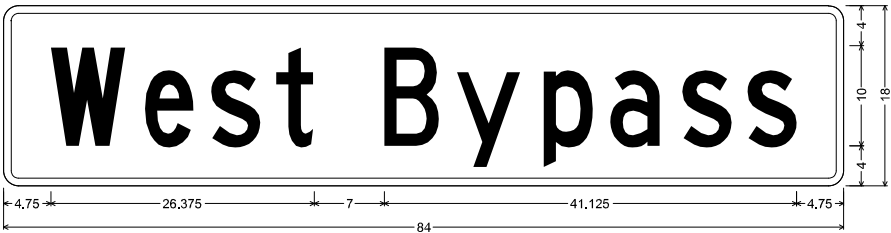

D3-1 SH-FLAT SHEET;
1,500" Radius, 0,750" Border, White on, Green;
"West Bypass", C;
Table of letter and object lefts

W	e	s	t	B	y	p	a	s	s
4.750	14.125	20.750	27.250	38.125	45.375	54.000	60.625	67.875	74.375

SIGN NO.	31	ROADWAY	LOCATION
STATION	983+96.56 RT	RTE. 160 N	ON MAST ARM
STATION	812+79.28	RTE. 160 S	ON MAST ARM

STATE OF MISSOURI

JASON D. EVENDEN

NUMBER

PE-2013000659

PROFESSIONAL ENGINEER

THIS SHEET HAS BEEN
SIGNED, SEALED AND DATED
ELECTRONICALLY.

DATE PREPARED

8/5/2021

ROUTE

744/160

STATE

MO

DISTRICT

SW

SHEET NO.

49

COUNTY

GREENE

JOB NO.

J8P3087D

CONTRACT ID.

PROJECT NO.

BRIDGE NO.

DESCRIPTION



DATE

MISSOURI HIGHWAYS AND TRANSPORTATION
COMMISSION

MoDOT

105 WEST CAPITOL
JEFFERSON CITY, MO 65102
1-888-ASK-MODOT (1-888-275-6636)

IF A SEAL IS PRESENT ON THIS SHEET IT HAS BEEN ELECTRONICALLY SEALED AND DATED.

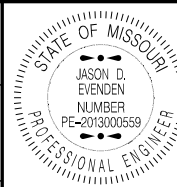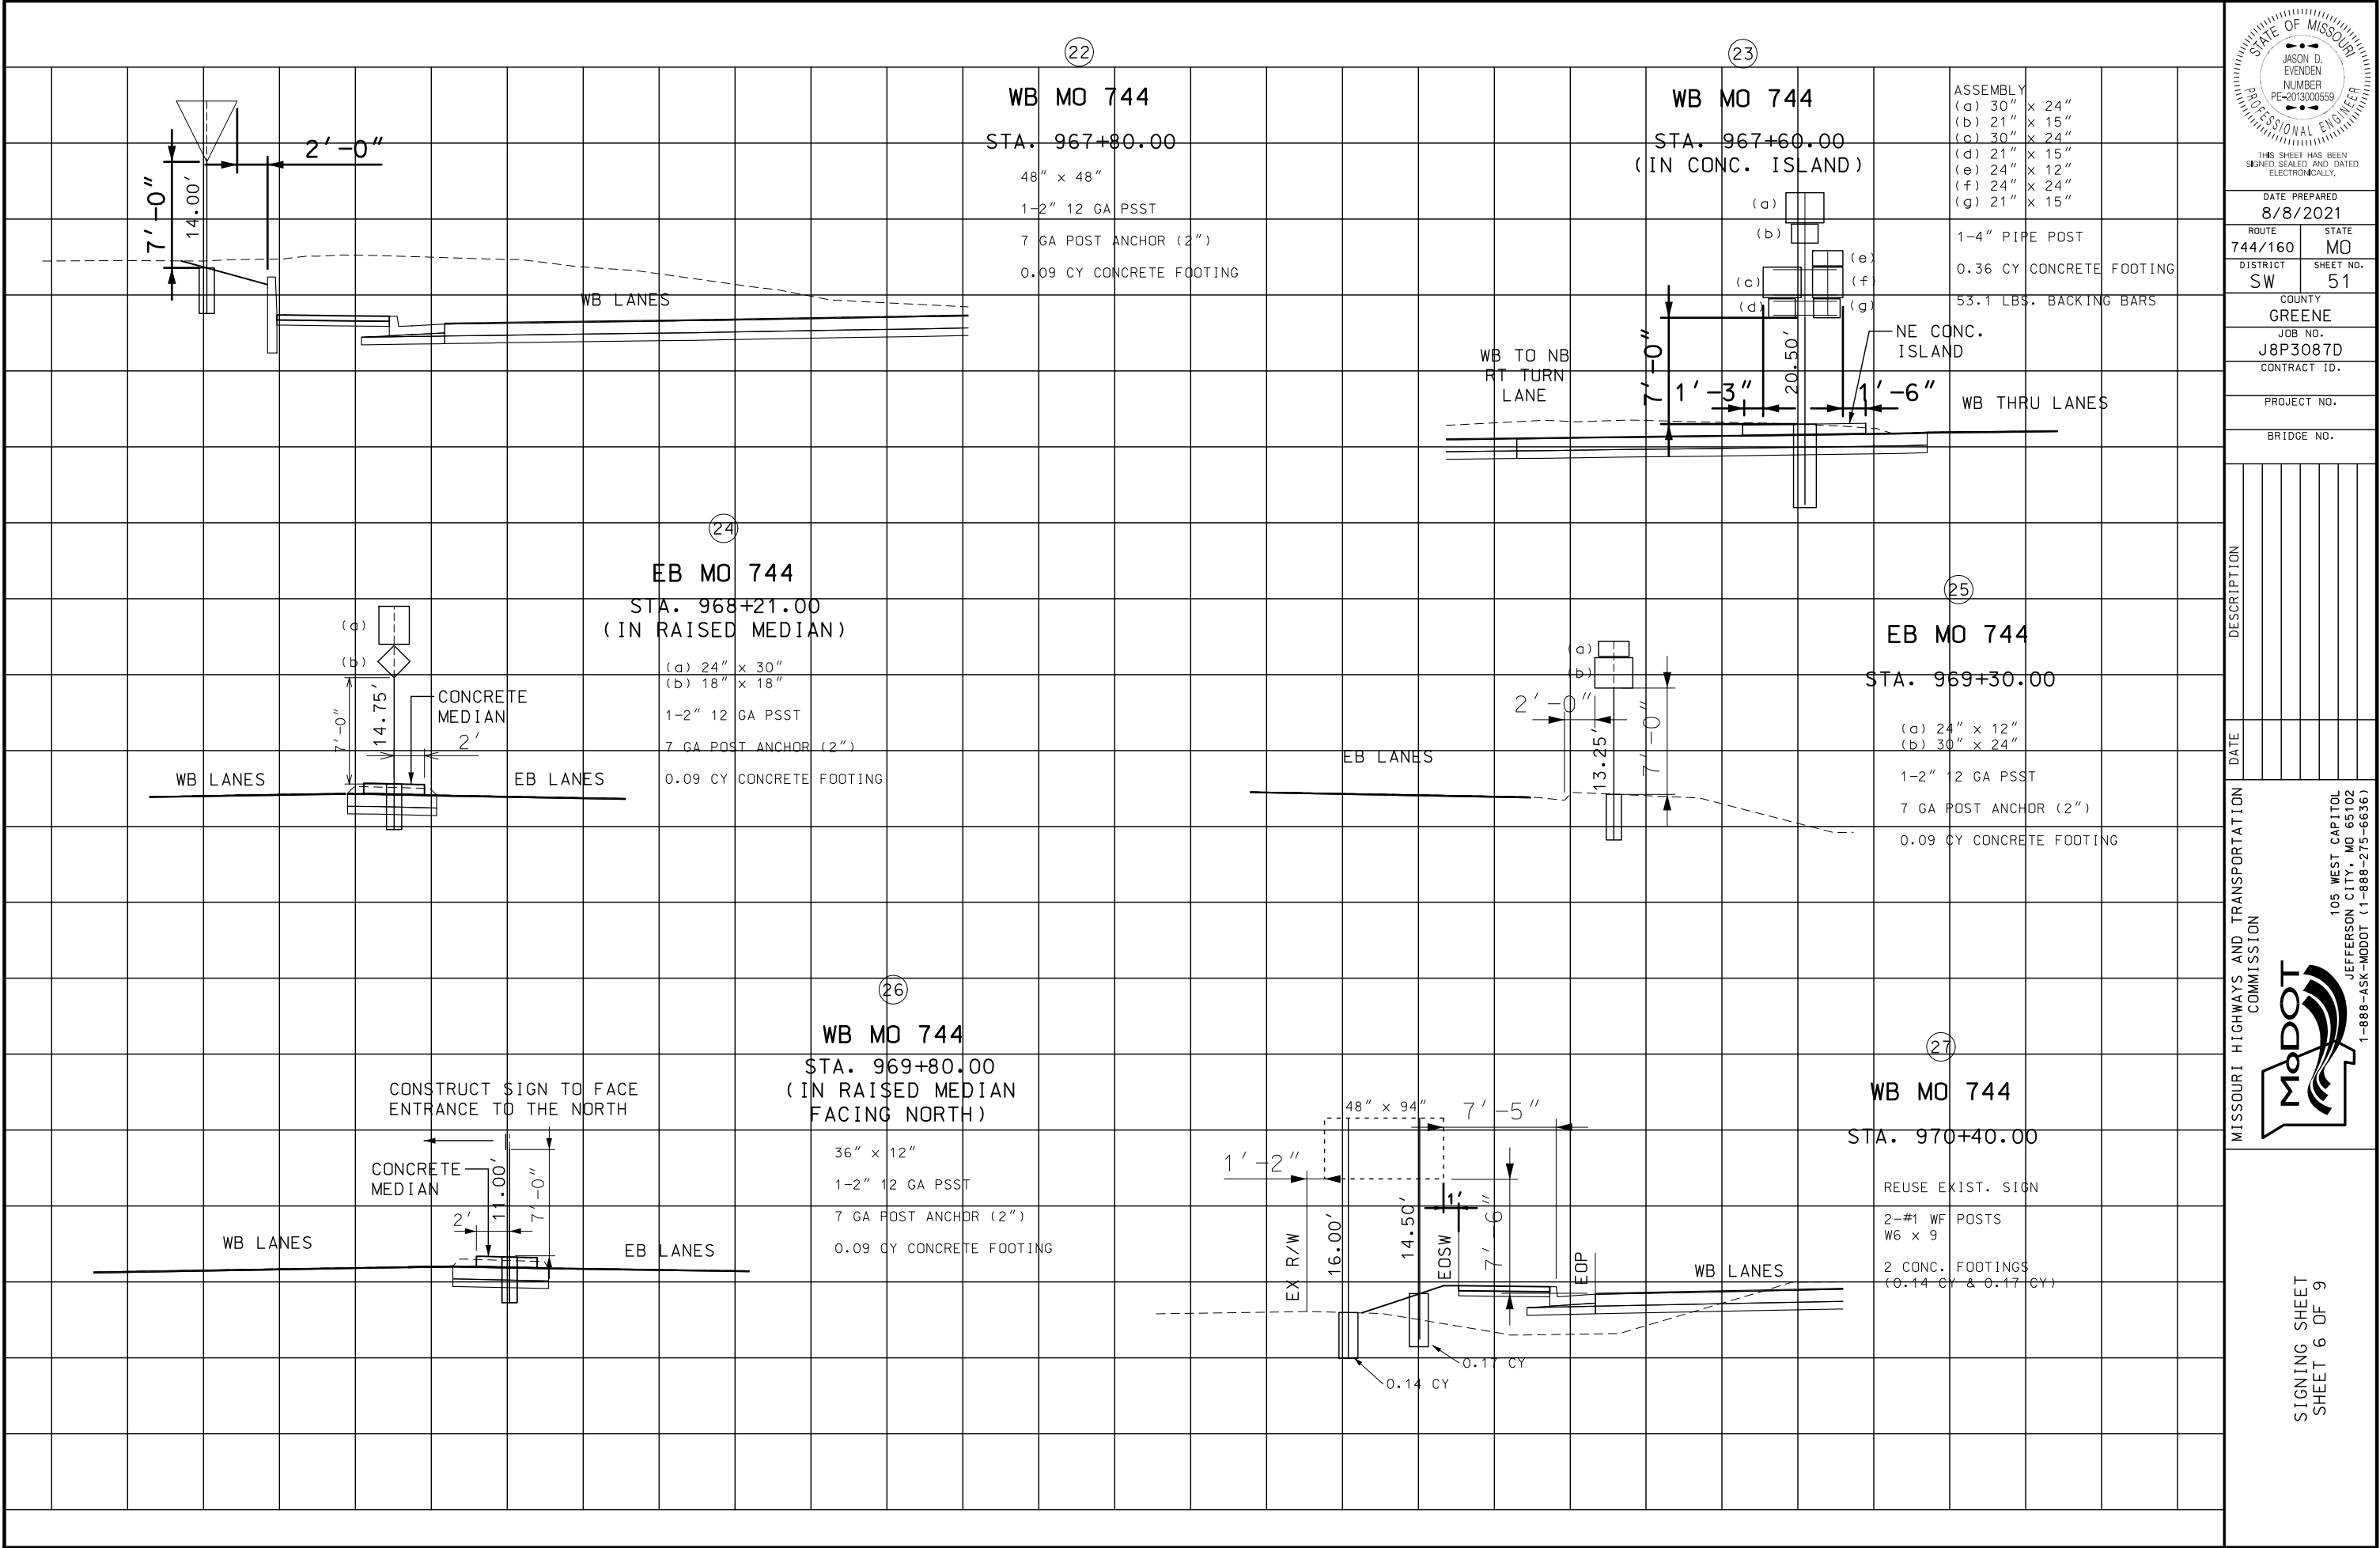

THIS SHEET HAS BEEN
SIGNED, SEALED AND DATED
ELECTRONICALLY.

DATE PREPARED
8/8/2021

ROUTE STATE
744/160 MO

DISTRICT SHEET NO.
SW 51

COUNTY
GREENE

JOB NO.
J8P3087D

CONTRACT ID.

PROJECT NO.

BRIDGE NO.

DESCRIPTION

DATE


MISSOURI HIGHWAYS AND TRANSPORTATION
COMMISSION









105 WEST CAPITAL
JEFFERSON CITY, MO 65102
1-888-ASK-MODOT (1-888-275-6636)

MoDOT

SIGNING SHEET
SHEET 6 OF 9

IF A SEAL IS PRESENT ON THIS SHEET IT HAS BEEN ELECTRONICALLY SEALED AND DATED.

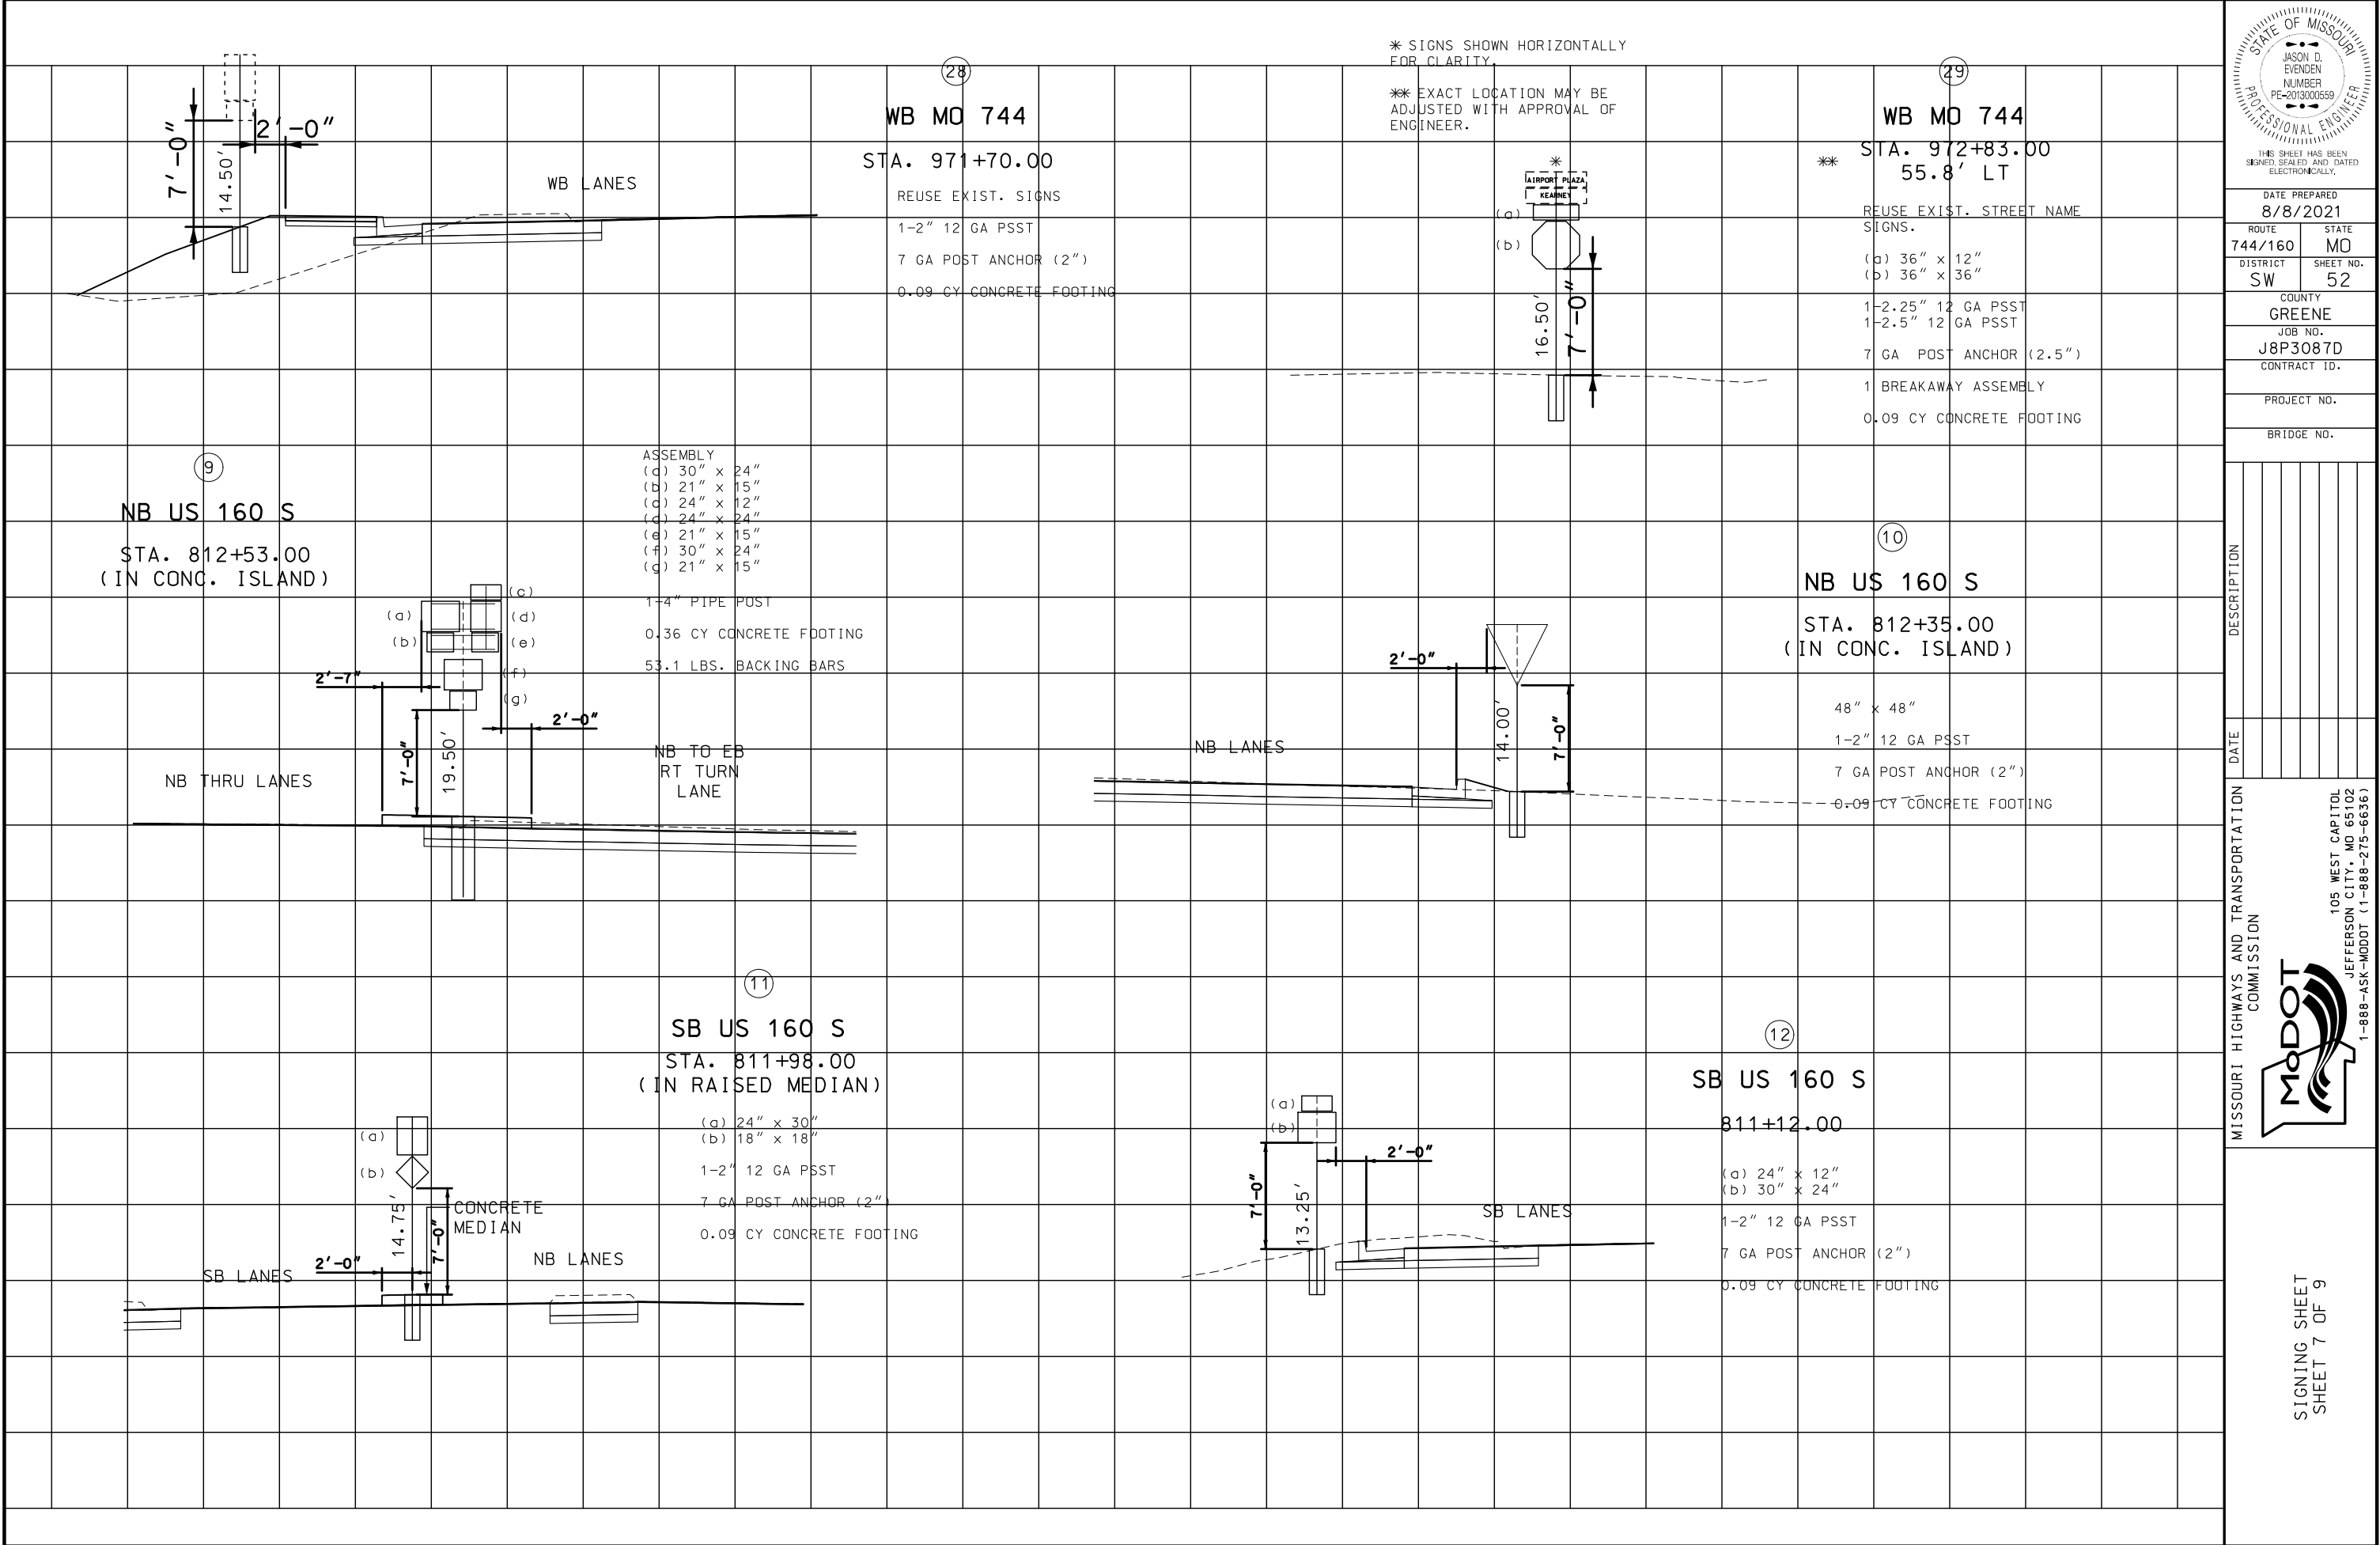

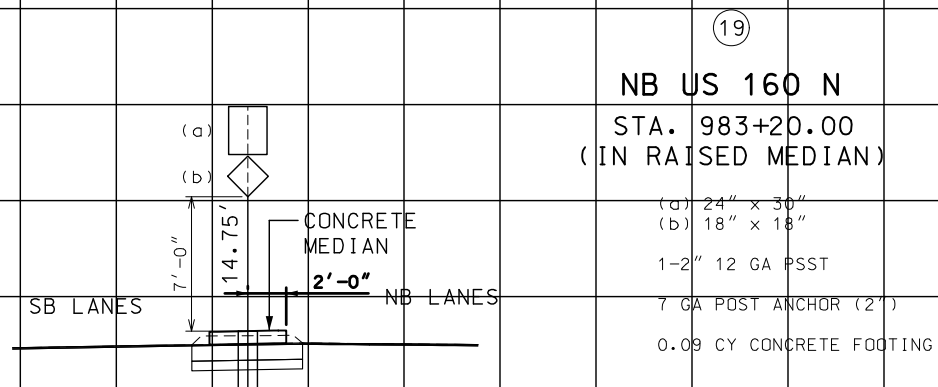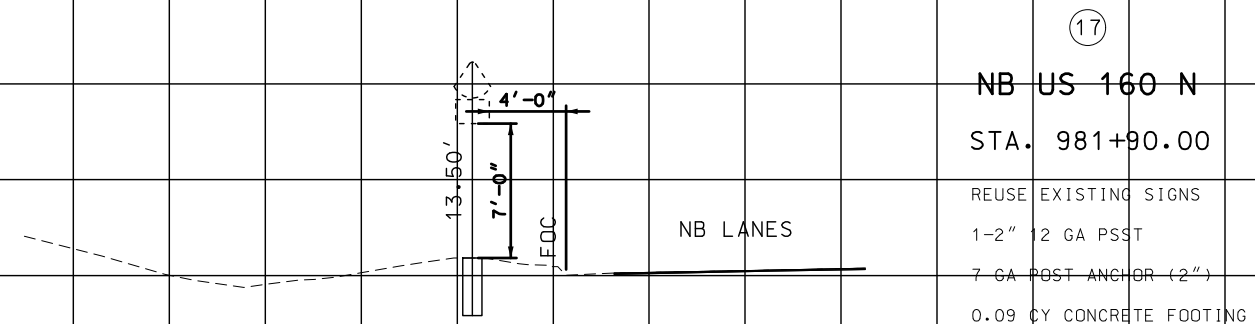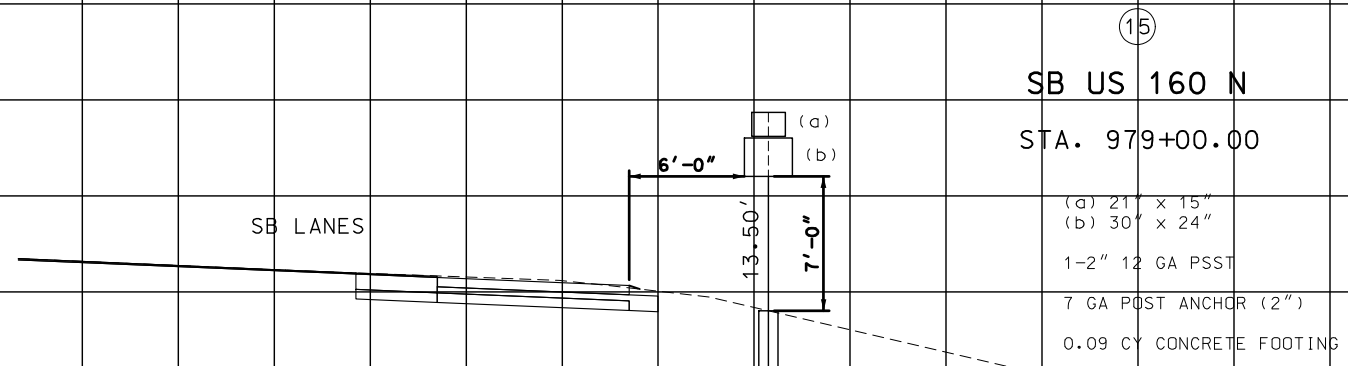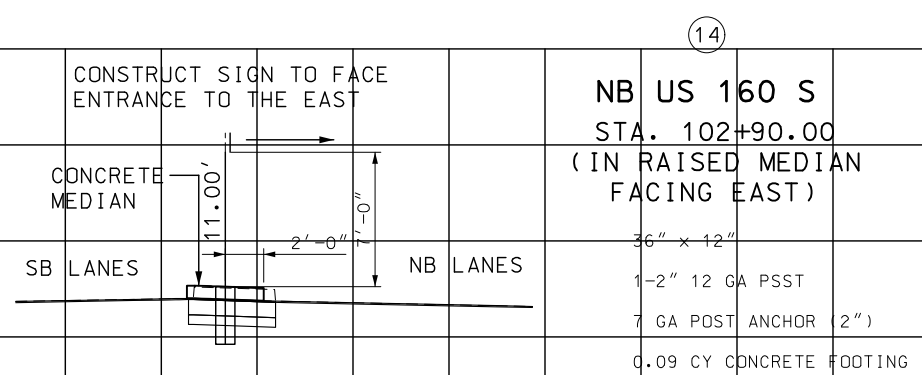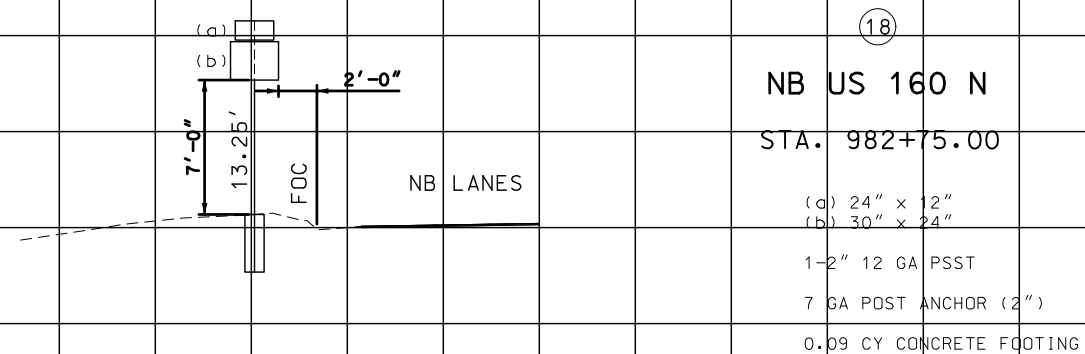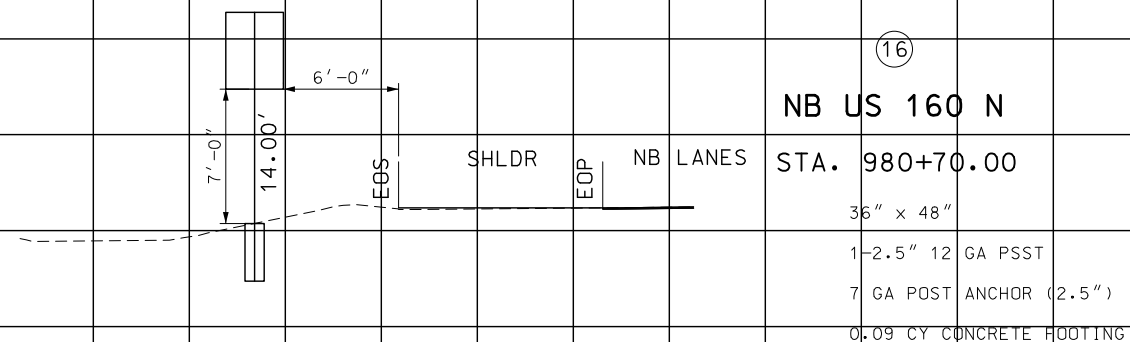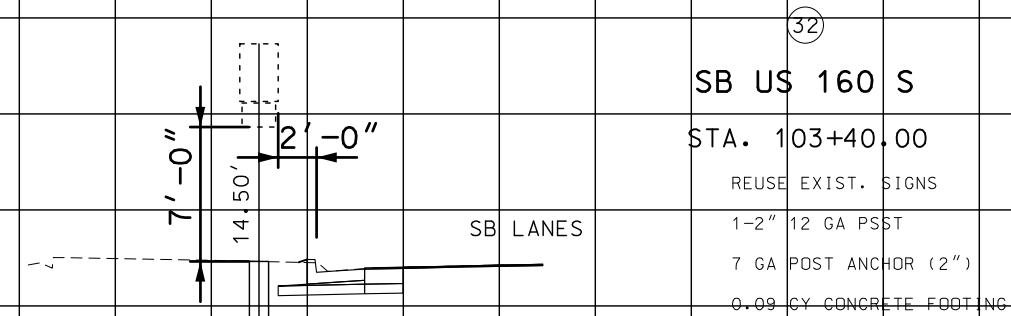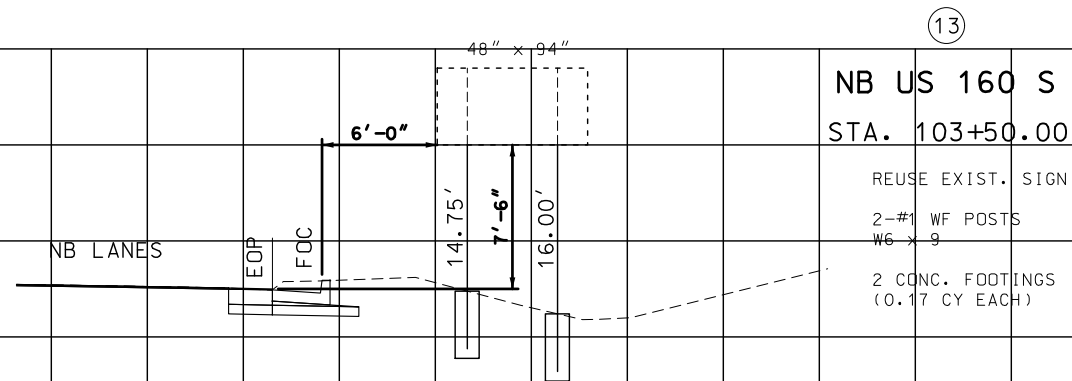

DATE PREPARED

ROUTE	STATE
744/160	MO
DISTRICT	SHEET NO.
SW	53

COUNTY
GREENE
JOB NO.
J8P3087D
CONTRACT ID.



PROJECT NO.

BRIDGE NO.

[illegible]MISSOURI HIGHWAYS AND TRANSPORTATION
COMMISSION

SIGNING SHEET
SHEET 8 OF 9

IF A SEAL IS PRESENT ON THIS SHEET IT HAS BEEN ELECTRONICALLY SEALED AND DATED.

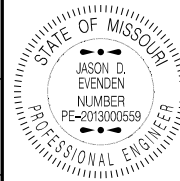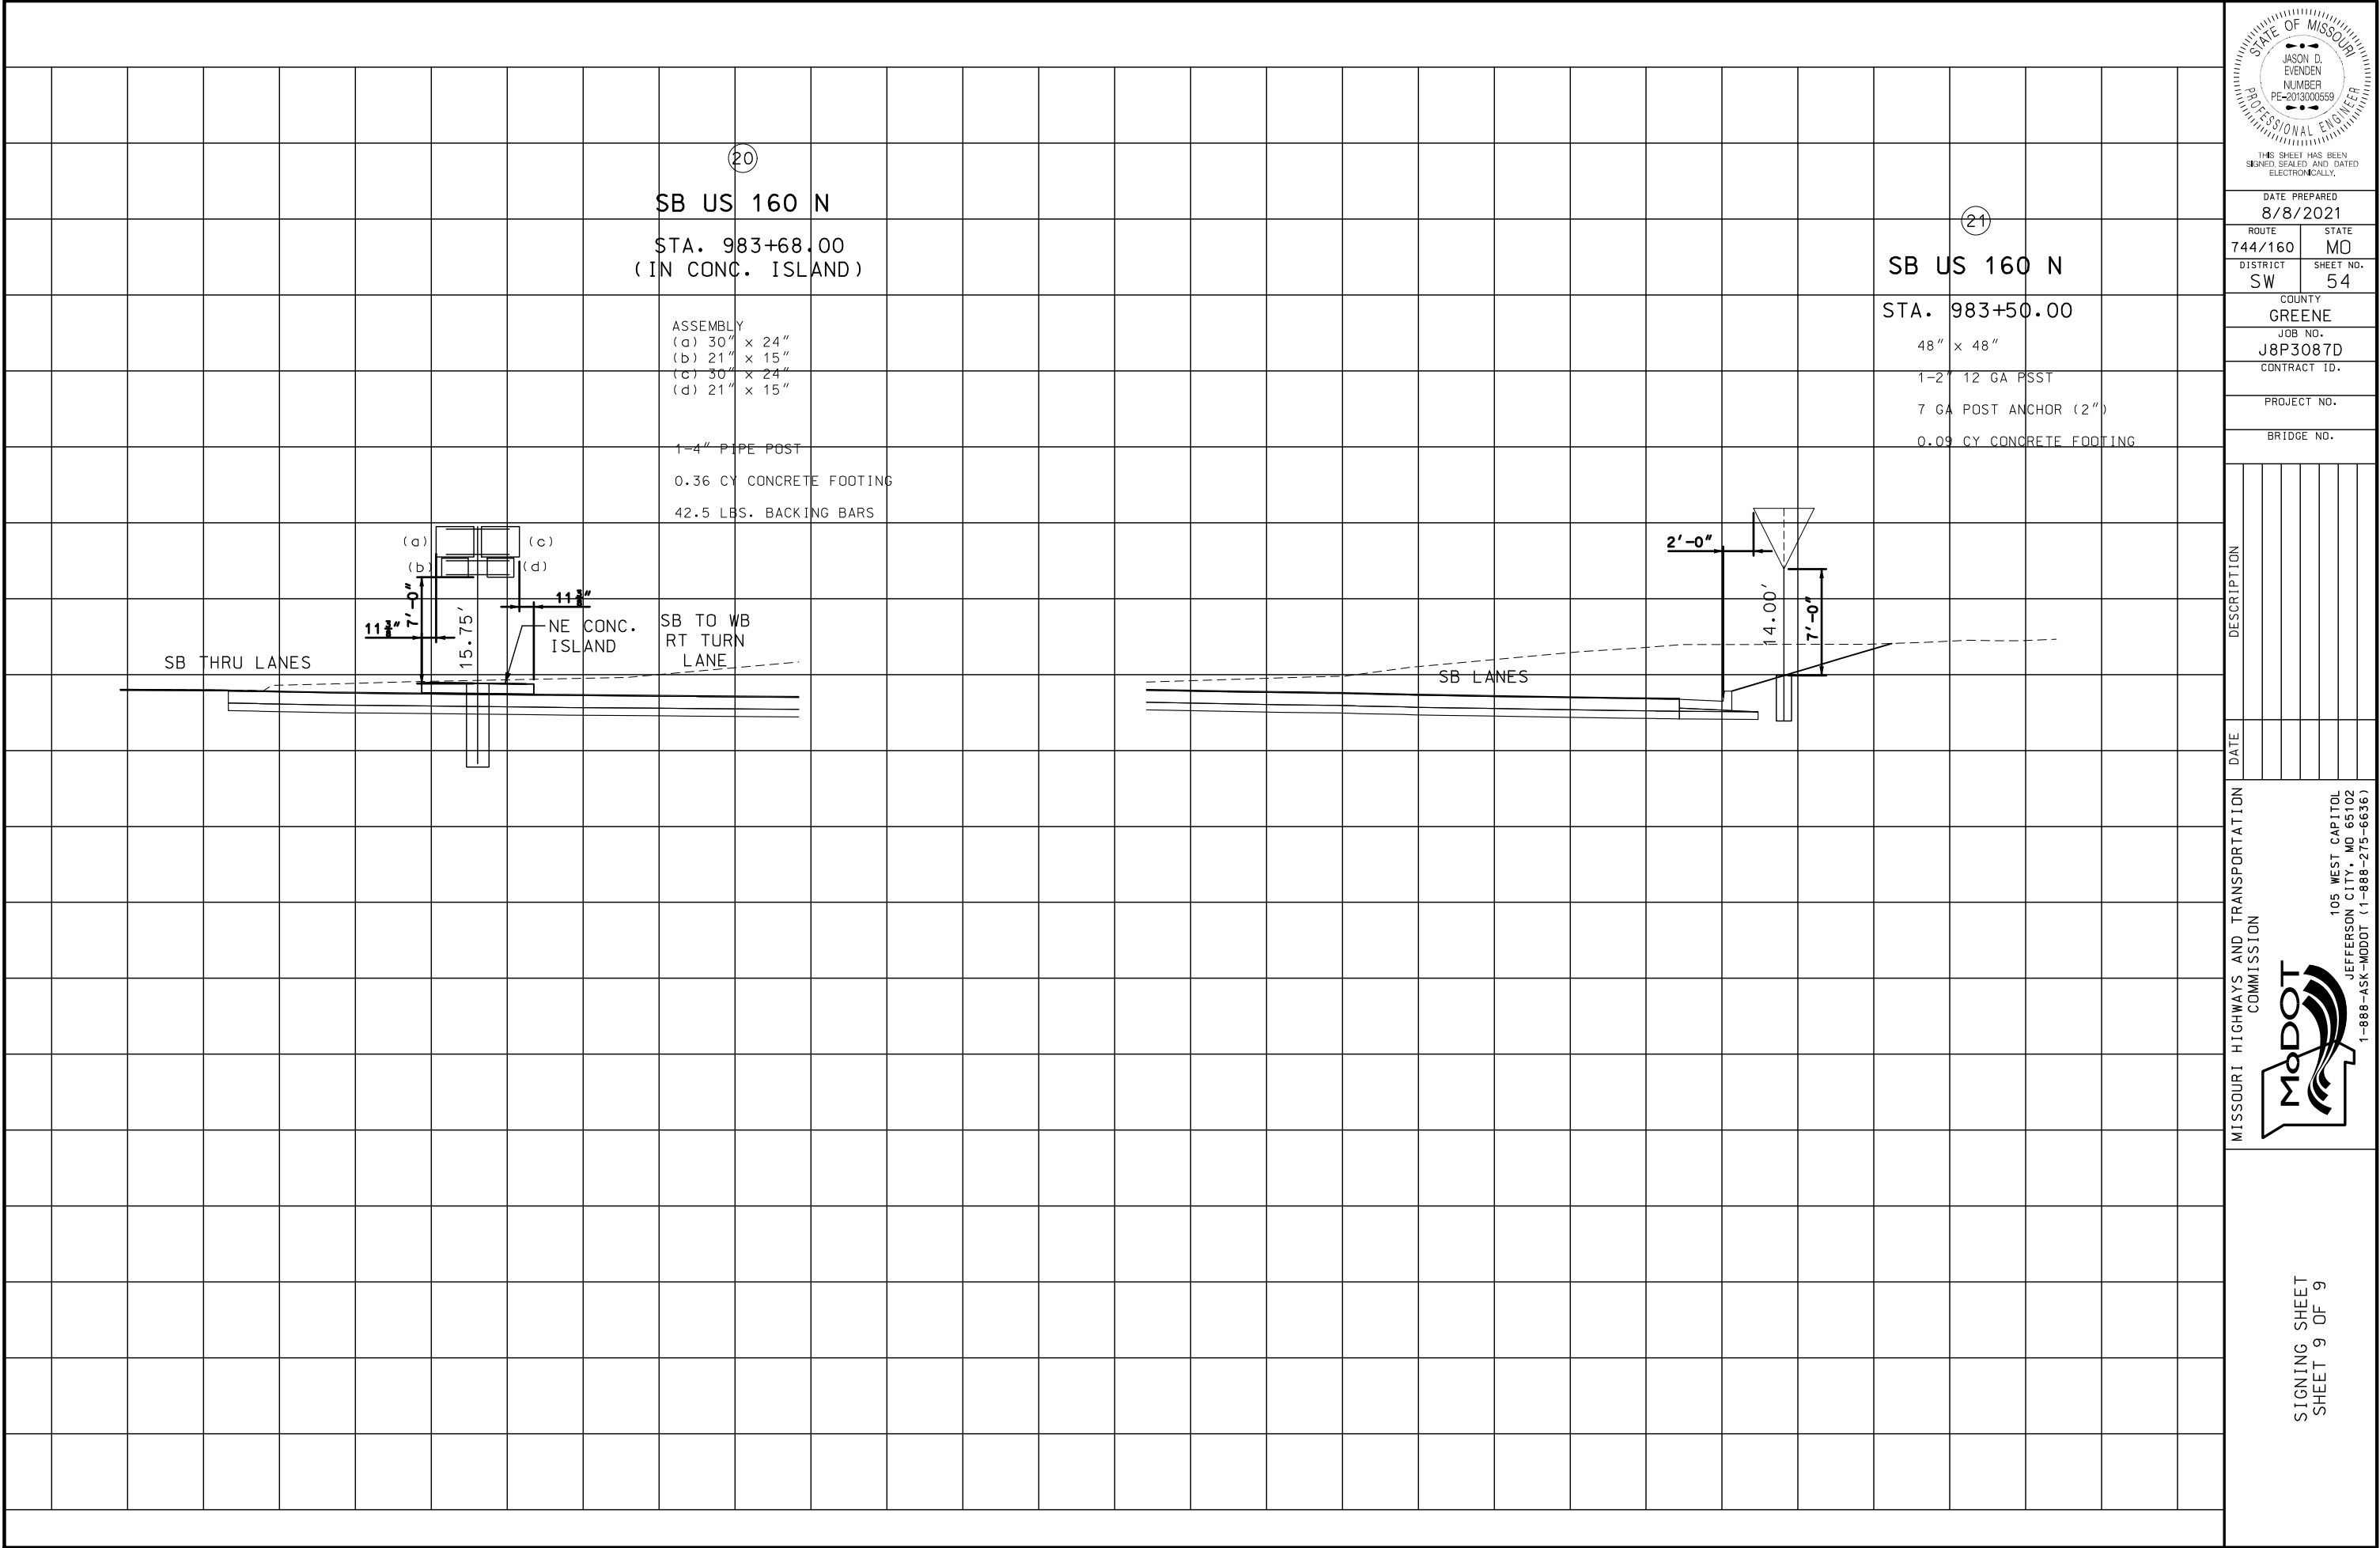

THIS SHEET HAS BEEN
SIGNED, SEALED AND DATED
ELECTRONICALLY.

DATE PREPARED
8/8/2021

ROUTE STATE
744/160 MO

DISTRICT SHEET NO.
SW 54

COUNTY
GREENE

JOB NO.
J8P3087D

CONTRACT ID.

PROJECT NO.

BRIDGE NO.

DESCRIPTION

DATE

MISSOURI HIGHWAYS AND TRANSPORTATION
COMMISSION

105 WEST CAPITOL
JEFFERSON CITY, MO 65102
1-888-ASK-MODOT (1-888-275-6636)

MoDOT

SIGNING SHEET
SHEET 9 OF 9

IF A SEAL IS PRESENT ON THIS SHEET IT HAS BEEN ELECTRONICALLY SEALED AND DATED.

STRIPING LEGEND


4" I.W	4" INTERMITTENT WHITE
4" S.W	4" SOLID WHITE
6" I.W	6" INTERMITTENT WHITE
6" S.W	6" SOLID WHITE
24" HATCH LINES	24" SOLID WHITE HATCH LINES
6" I.Y	6" INTERMITTENT YELLOW
6" S.Y	6" SOLID YELLOW
6" D.S.Y	6" DOUBLE SOLID YELLOW

STA. 960+00.00 Ext. -50.00

PAINTED BARRIER CURB



DETAIL 1

NOT TO SCALE

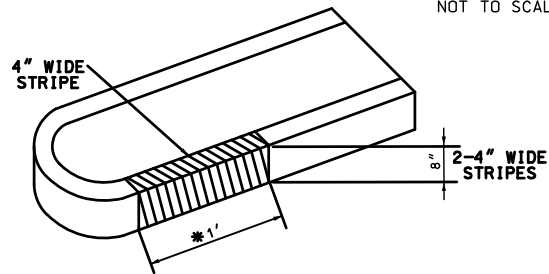

NOTE:
* ONE LINEAR FOOT OF CURB INCLUDES 4" WIDE STRIPE ON TOP OF CURB (MEDIAN OR ISLAND) AND THE HEIGHT OF VERTICAL FACE OF CURB.

SCALE

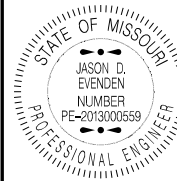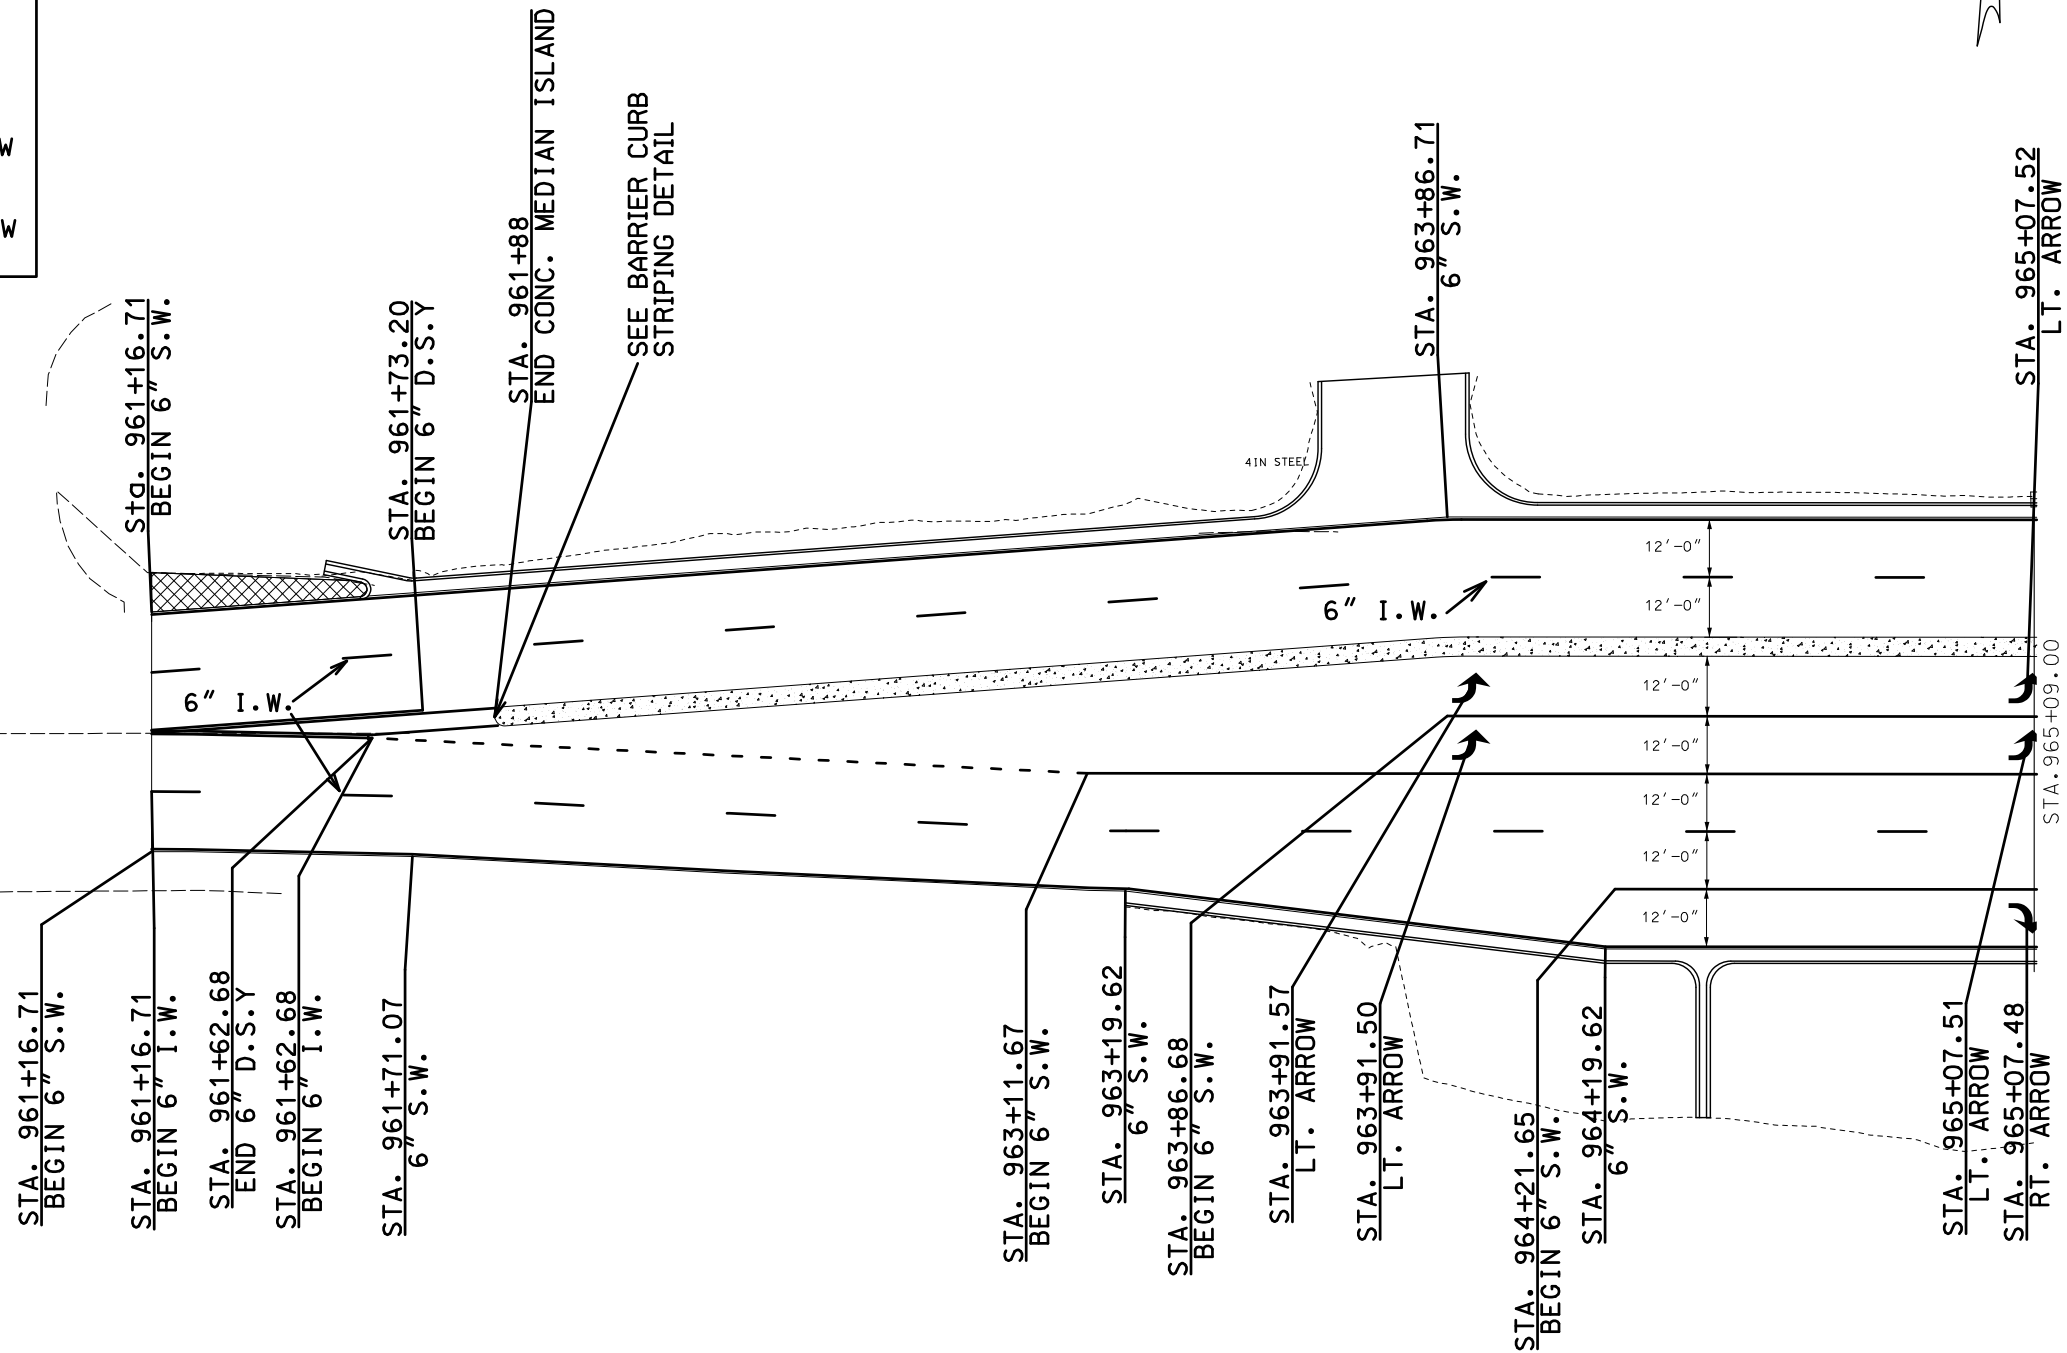

THIS SHEET HAS BEEN
SIGNED, SEALED AND DATED
ELECTRONICALLY.

DATE PREPARED
8/5/2021

ROUTE STATE

744/160 MO

DISTRICT SHEET NO.

SW 55

COUNTY

GREENE

JOB NO.

J8P3087D

CONTRACT ID.

PROJECT NO.

BRIDGE NO.

DESCRIPTION

DATE

DATE


DATE

MISSOURI HIGHWAYS AND TRANSPORTATION
COMMISSION

MoDOT

105 WEST CAPITOL
JEFFERSON CITY, MO 65102
1-888-ASK-MODOT (1-888-275-6636)

IF A SEAL IS PRESENT ON THIS SHEET IT HAS BEEN ELECTRONICALLY SEALED AND DATED.

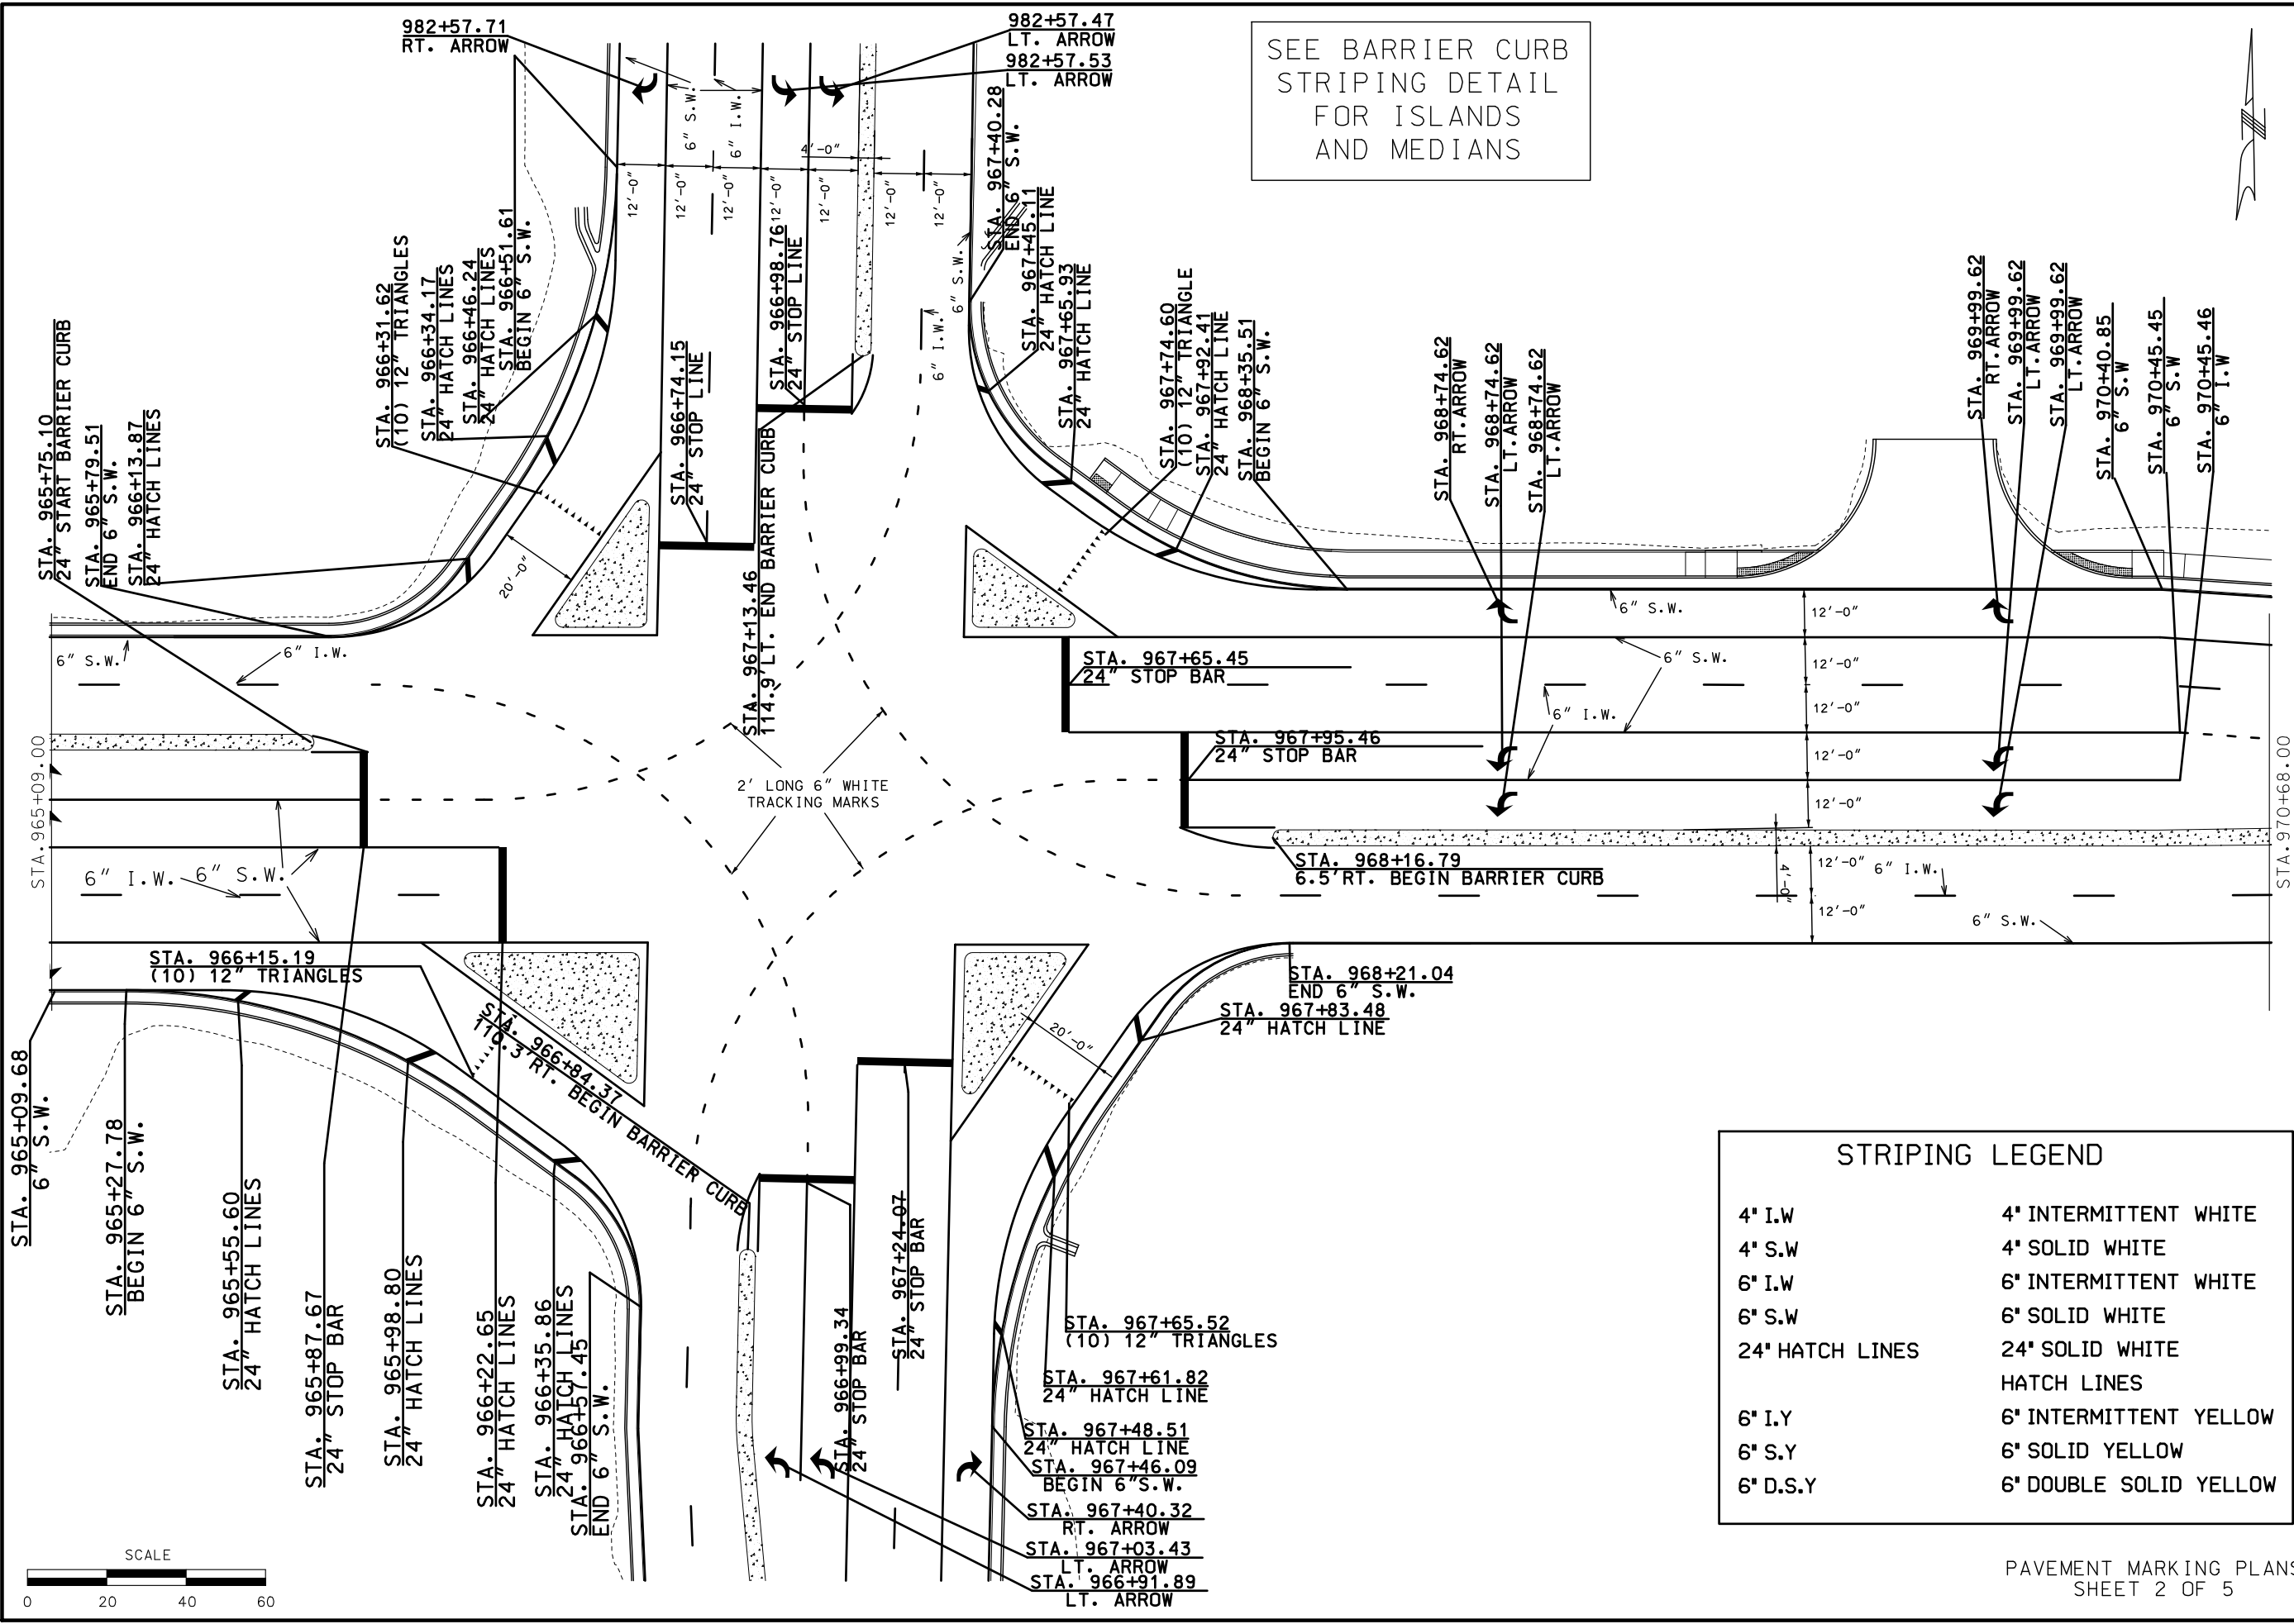

SEE BARRIER CURB
STRIPING DETAIL
FOR ISLANDS
AND MEDIANS

STRIPING LEGEND	
4" I.W	4" INTERMITTENT WHITE
4" S.W	4" SOLID WHITE
6" I.W	6" INTERMITTENT WHITE
6" S.W	6" SOLID WHITE
24" HATCH LINES	24" SOLID WHITE HATCH LINES
6" I.Y	6" INTERMITTENT YELLOW
6" S.Y	6" SOLID YELLOW
6" D.S.Y	6" DOUBLE SOLID YELLOW

PAVEMENT MARKING PLANS
SHEET 2 OF 5

STATE OF MISSOURI

JASON D. EVENDEN

NUMBER

PE-2013000659

PROFESSIONAL ENGINEER

THIS SHEET HAS BEEN

SIGNED, SEALED AND DATED

ELECTRONICALLY.

DATE PREPARED

8/5/2021

ROUTE

744/160

STATE

MO

DISTRICT

SW

SHEET NO.

56

COUNTY

GREENE

JOB NO.

J8P3087D

CONTRACT ID.

PROJECT NO.

BRIDGE NO.

DATE

DESCRIPTION

MISSOURI HIGHWAYS AND TRANSPORTATION

COMMISSION


 
MoDOT

105 WEST CAPITOL

JEFFERSON CITY, MO 65102


1-888-ASK-MODOT (1-888-275-6636)

IF A SEAL IS PRESENT ON THIS SHEET IT HAS BEEN ELECTRONICALLY SEALED AND DATED.

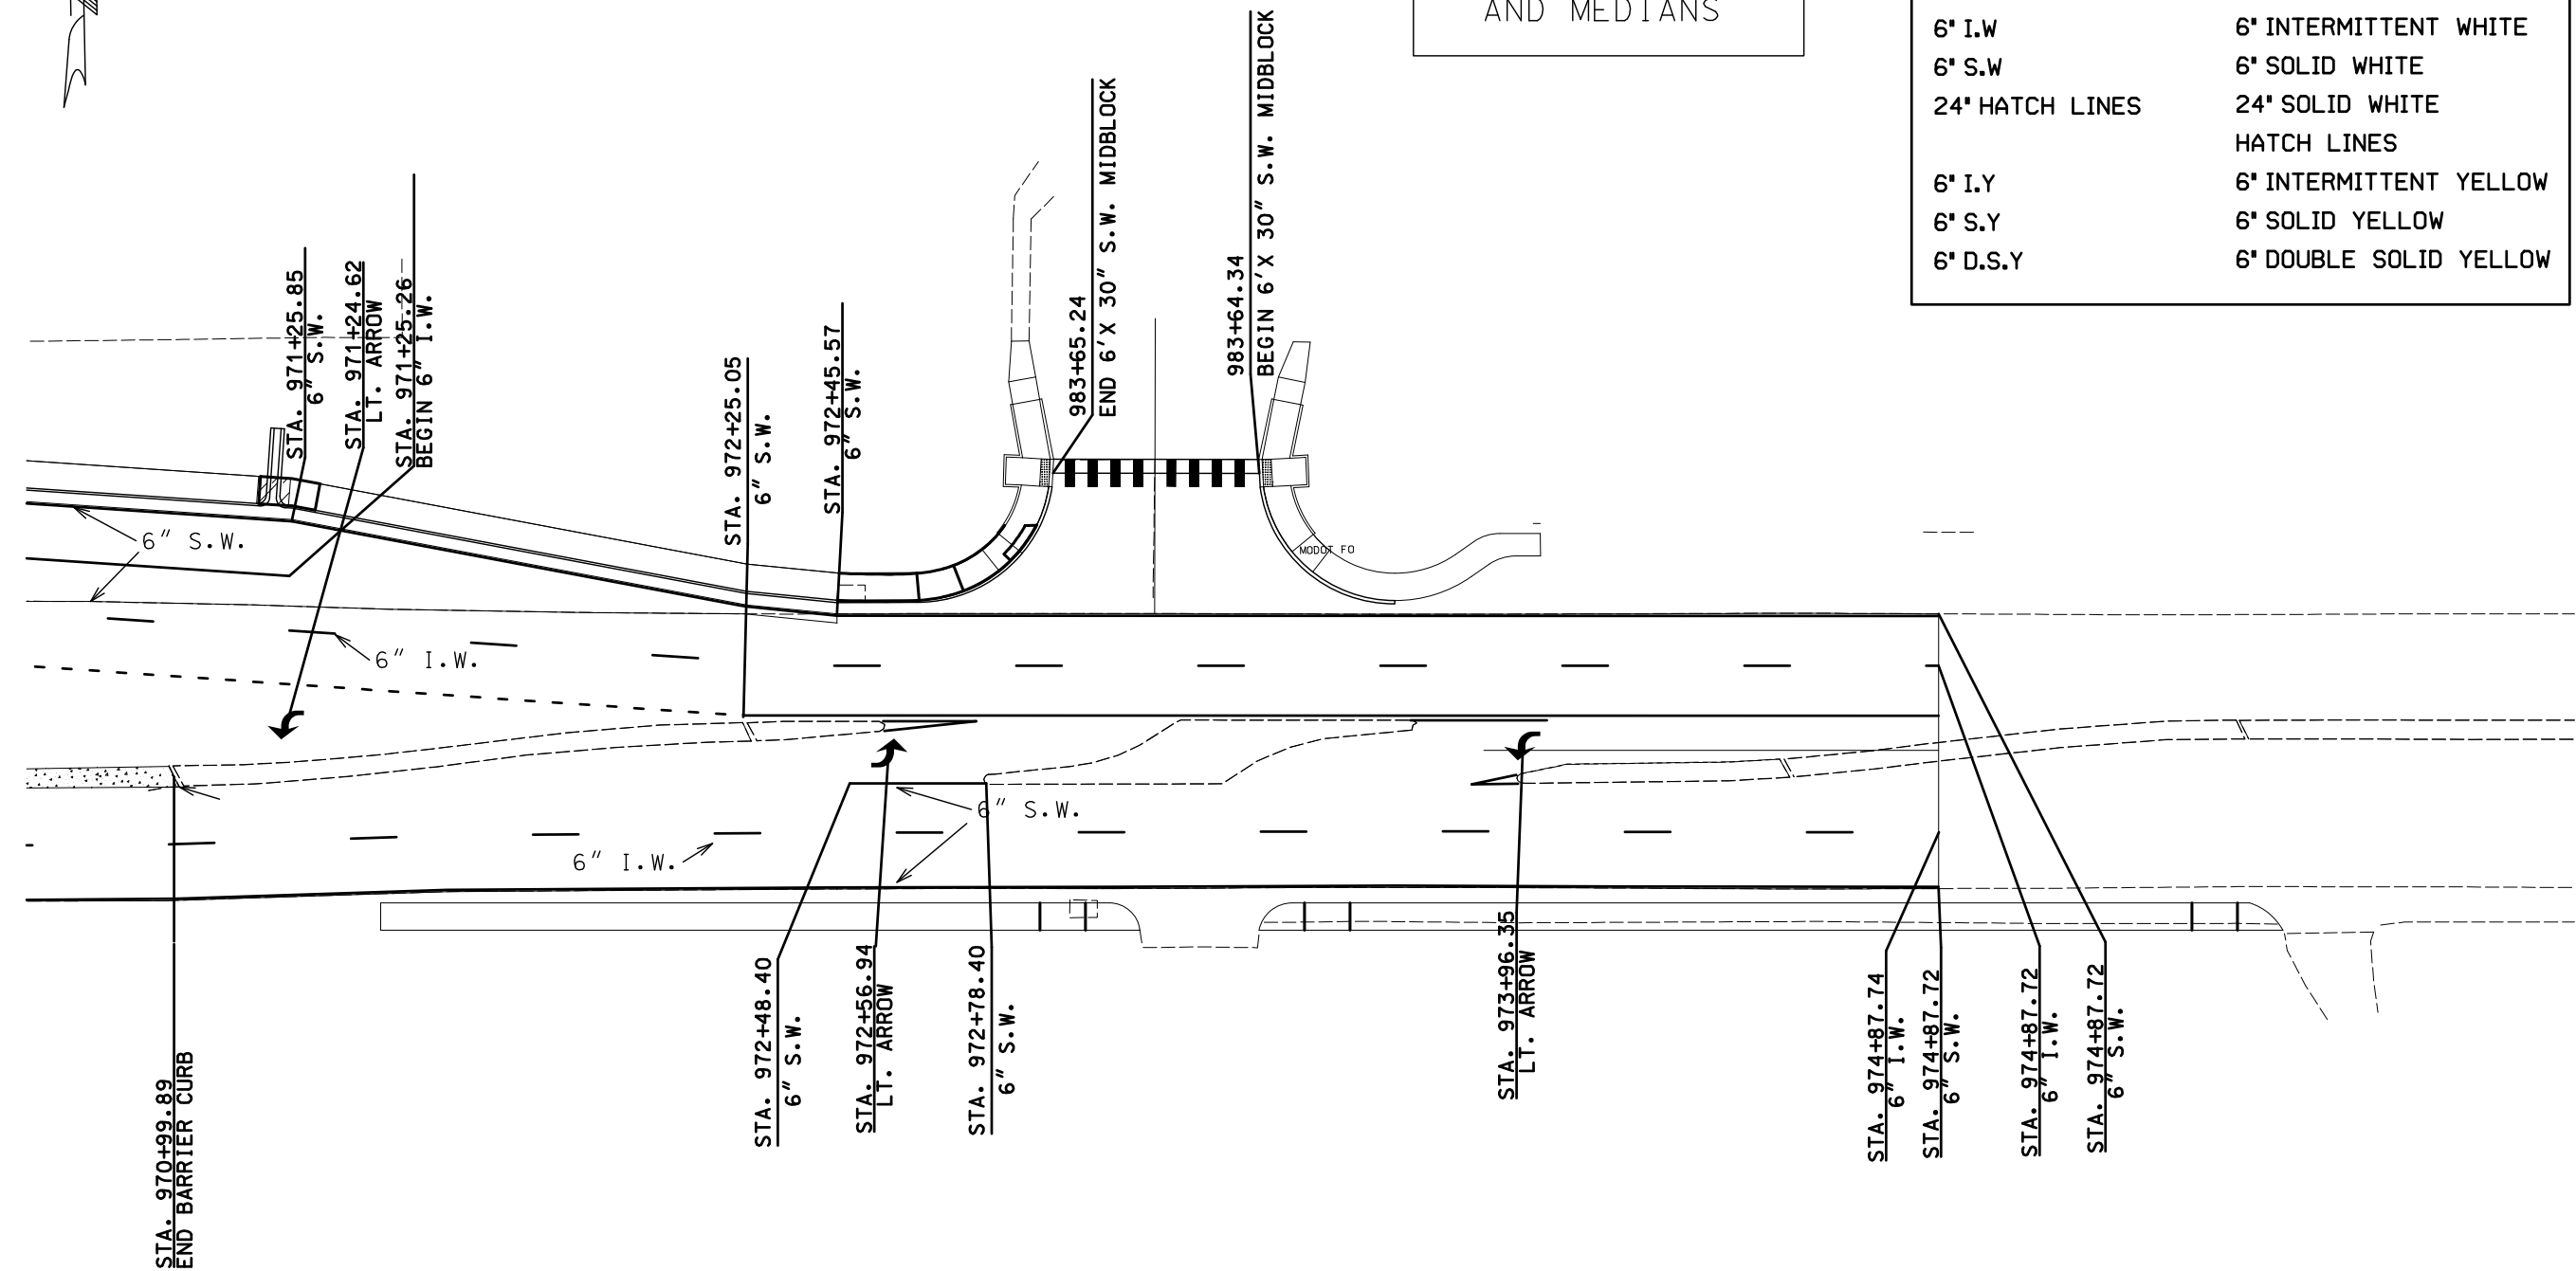

SEE BARRIER CURB
STRIPING DETAIL
FOR ISLANDS
AND MEDIANS

STRIPING LEGEND	
4" I.W	4" INTERMITTENT WHITE
4" S.W	4" SOLID WHITE
6" I.W	6" INTERMITTENT WHITE
6" S.W	6" SOLID WHITE
24" HATCH LINES	24" SOLID WHITE HATCH LINES
6" I.Y	6" INTERMITTENT YELLOW
6" S.Y	6" SOLID YELLOW
6" D.S.Y	6" DOUBLE SOLID YELLOW

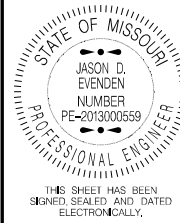


DATE PREPARED 8/5/2021	
ROUTE 744/160	STATE MO
DISTRICT SW	SHEET NO. 57
COUNTY GREENE	
JOB NO. J8P3087D	
CONTRACT ID.	
PROJECT NO.	
BRIDGE NO.	

DATE	DESCRIPTION

MISSOURI HIGHWAYS AND TRANSPORTATION
COMMISSION



105 WEST CAPITOL
JEFFERSON CITY, MO 65102
1-888-ASK-MODOT (1-888-275-6636)

 IF A SEAL IS PRESENT ON THIS SHEET IT HAS BEEN ELECTRONICALLY SEALED AND DATED.



SEE BARRIER CURB
STRIPING DETAIL
FOR ISLANDS
AND MEDIANS

STRIPING LEGEND	
4" I.W	4" INTERMITTENT WHITE
4" S.W	4" SOLID WHITE
6" I.W	6" INTERMITTENT WHITE
6" S.W	6" SOLID WHITE
24" HATCH LINES	24" SOLID WHITE HATCH LINES
6" I.Y	6" INTERMITTENT YELLOW
6" S.Y	6" SOLID YELLOW
6" D.S.Y	6" DOUBLE SOLID YELLOW

 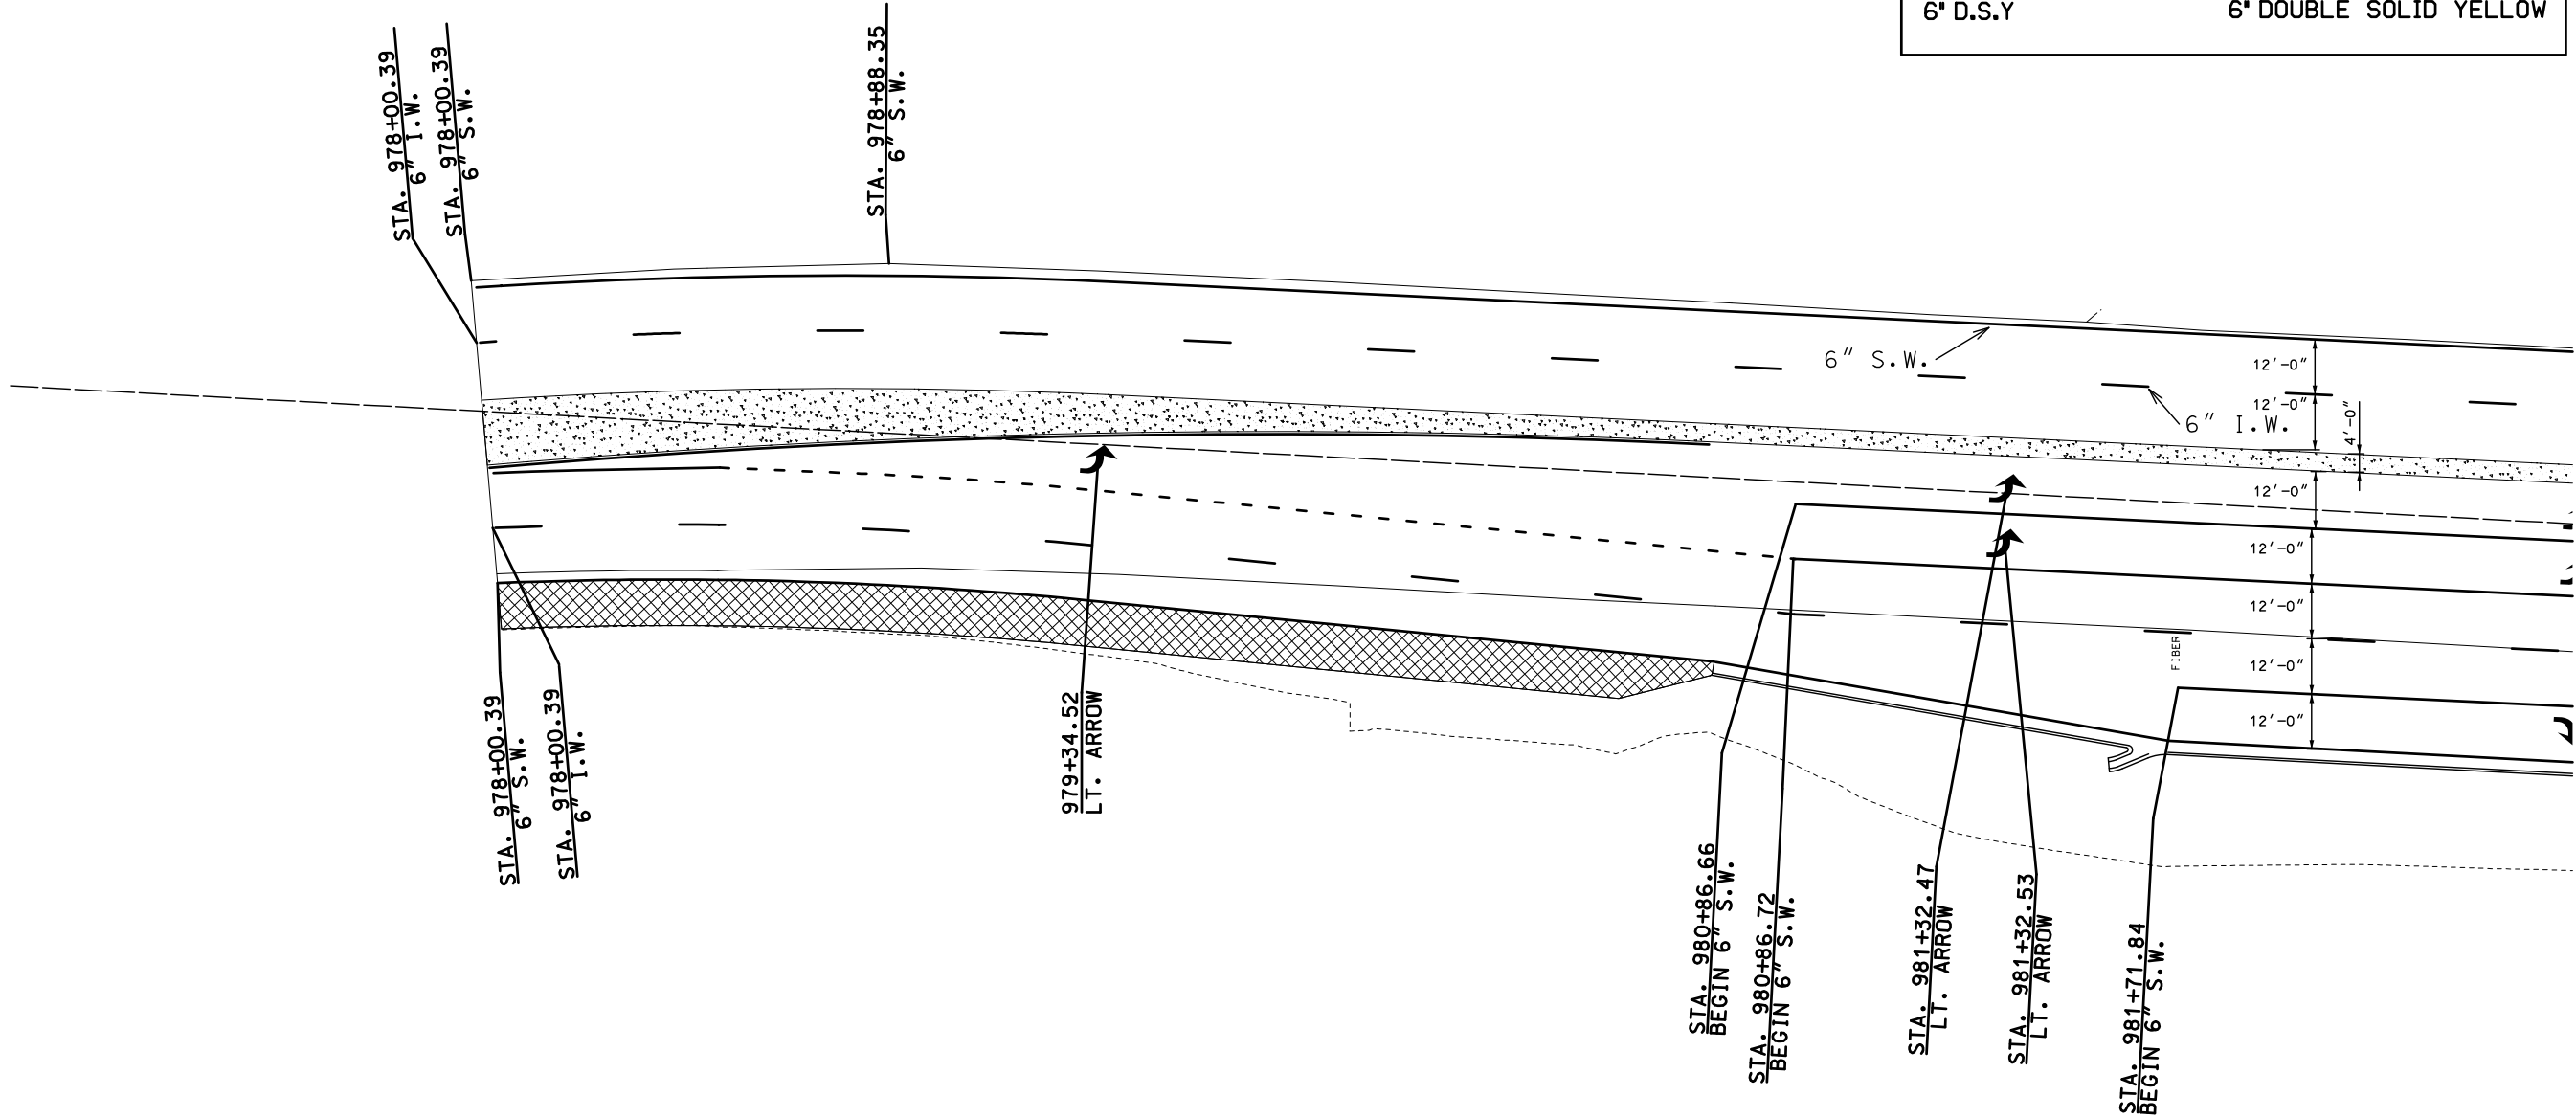

STATE OF MISSOURI

JASON D. EVENDEN

NUMBER

PE-2013000659

PROFESSIONAL ENGINEER

THIS SHEET HAS BEEN

SIGNED, SEALED AND DATED

ELECTRONICALLY.

DATE PREPARED

8/5/2021

ROUTE

744/160

STATE

MO

DISTRICT

SW

SHEET NO.

58

COUNTY

GREENE

JOB NO.

J8P3087D

CONTRACT ID.

PROJECT NO.

BRIDGE NO.

DATE

DESCRIPTION

MISSOURI HIGHWAYS AND TRANSPORTATION

COMMISSION

MoDOT

105 WEST CAPITOL

JEFFERSON CITY, MO 65102




1-888-ASK-MODOT (1-888-275-6636)

IF A SEAL IS PRESENT ON THIS SHEET IT HAS BEEN ELECTRONICALLY SEALED AND DATED.

STRIPING LEGEND

- | | |
|-----------------|--------------------------------|
| 4" I.W | 4" INTERMITTENT WHITE |
| 4" S.W | 4" SOLID WHITE |
| 6" I.W | 6" INTERMITTENT WHITE |
| 6" S.W | 6" SOLID WHITE |
| 24" HATCH LINES | 24" SOLID WHITE
HATCH LINES |
| 6" I.Y | 6" INTERMITTENT YELLOW |
| 6" S.Y | 6" SOLID YELLOW |
| 6" D.S.Y | 6" DOUBLE SOLID YELLOW |

 SEE BARRIER CURB
STRIPING DETAIL
FOR ISLANDS
AND MEDIANS

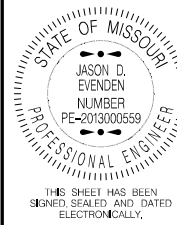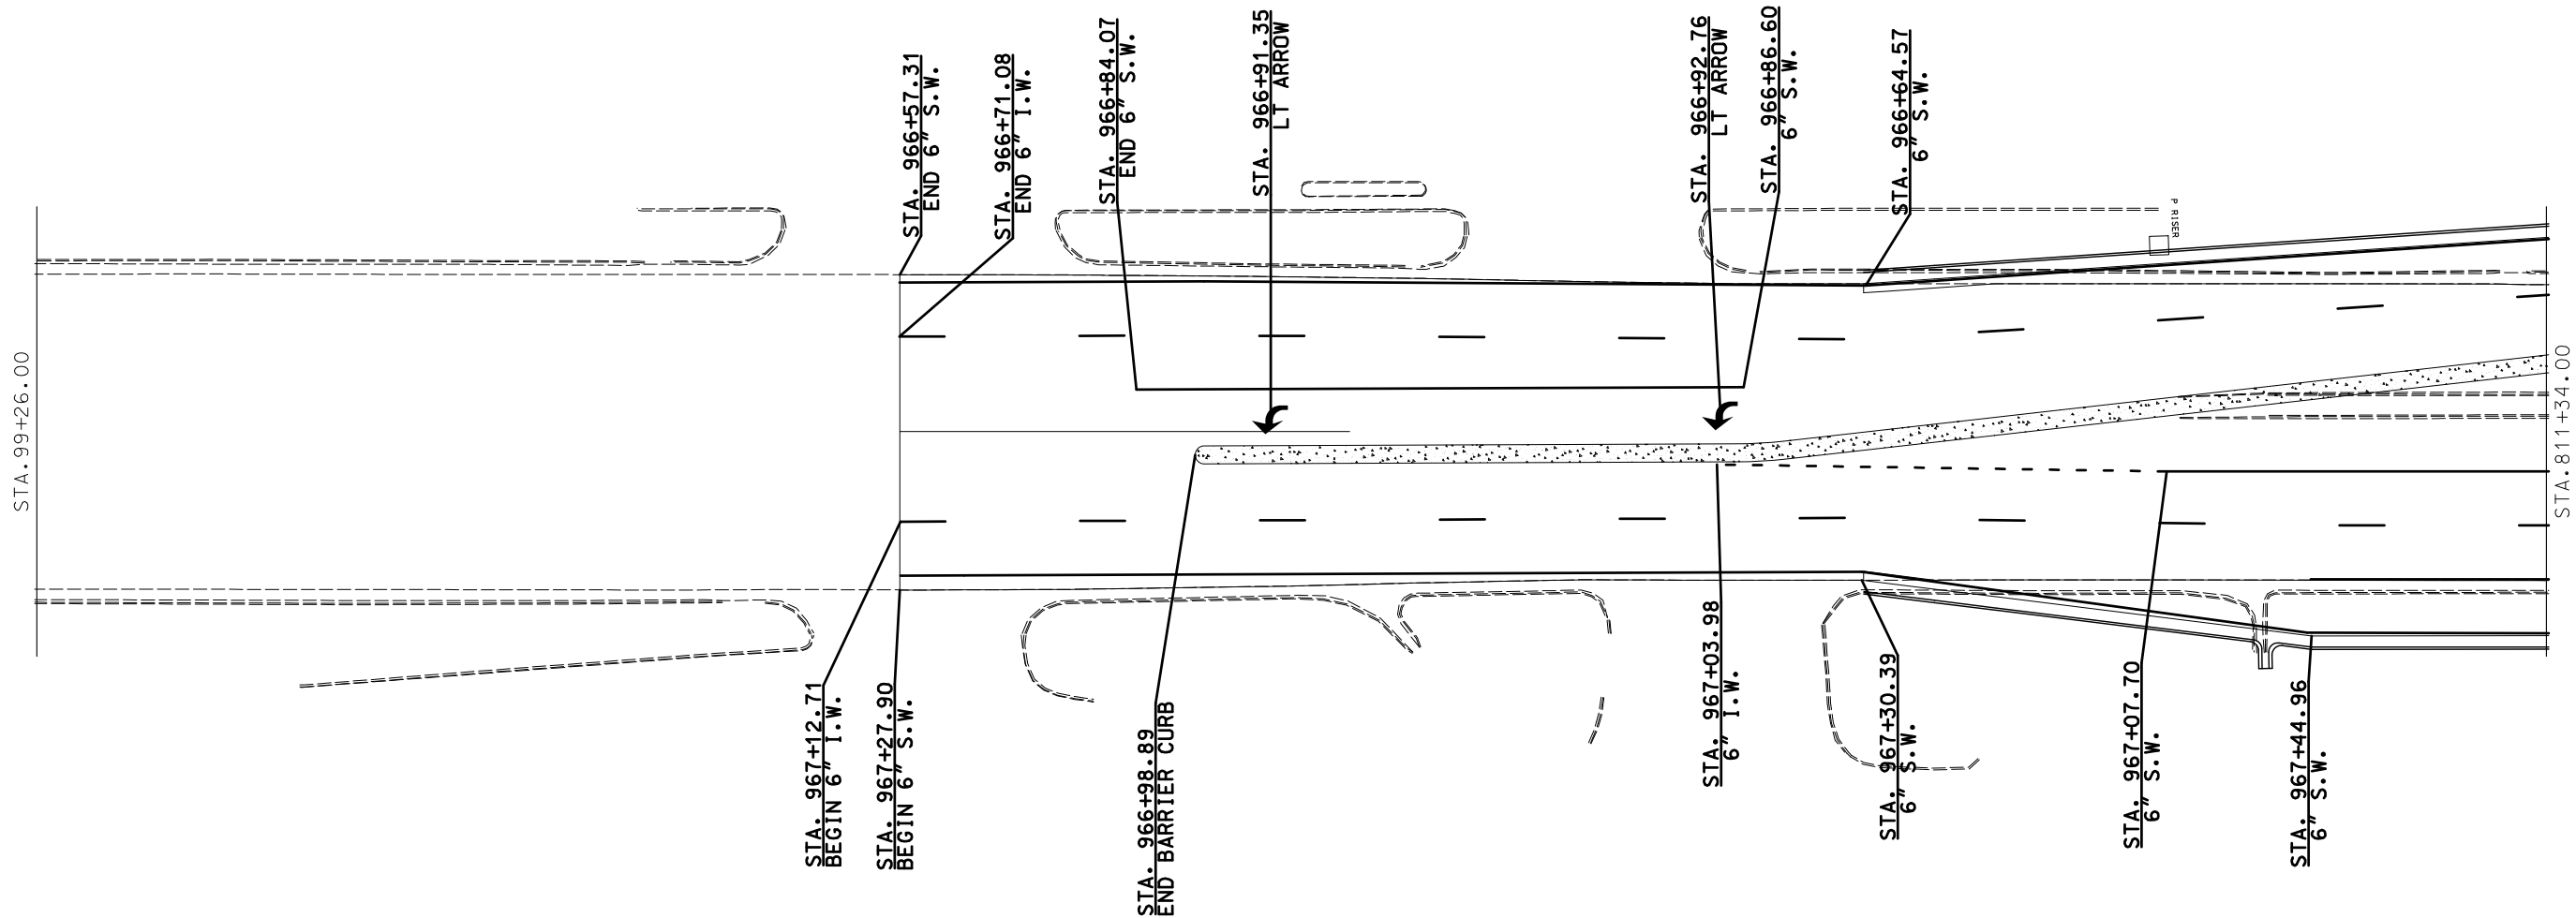

DATE PREPARED 8/5/2021	
ROUTE 744/160	STATE MO
DISTRICT SW	SHEET NO. 59
COUNTY GREENE	
JOB NO. J8P3087D	
CONTRACT ID.	



PROJECT NO.
BRIDGE NO.

DATE	DESCRIPTION

MISSOURI HIGHWAYS AND TRANSPORTATION
COMMISSION

105 WEST CAPITOL
JEFFERSON CITY, MO 65102
1-888-ASK-MODOT (1-888-275-6636)

IF A SEAL IS PRESENT ON THIS SHEET IT HAS BEEN ELECTRONICALLY SEALED AND DATED.

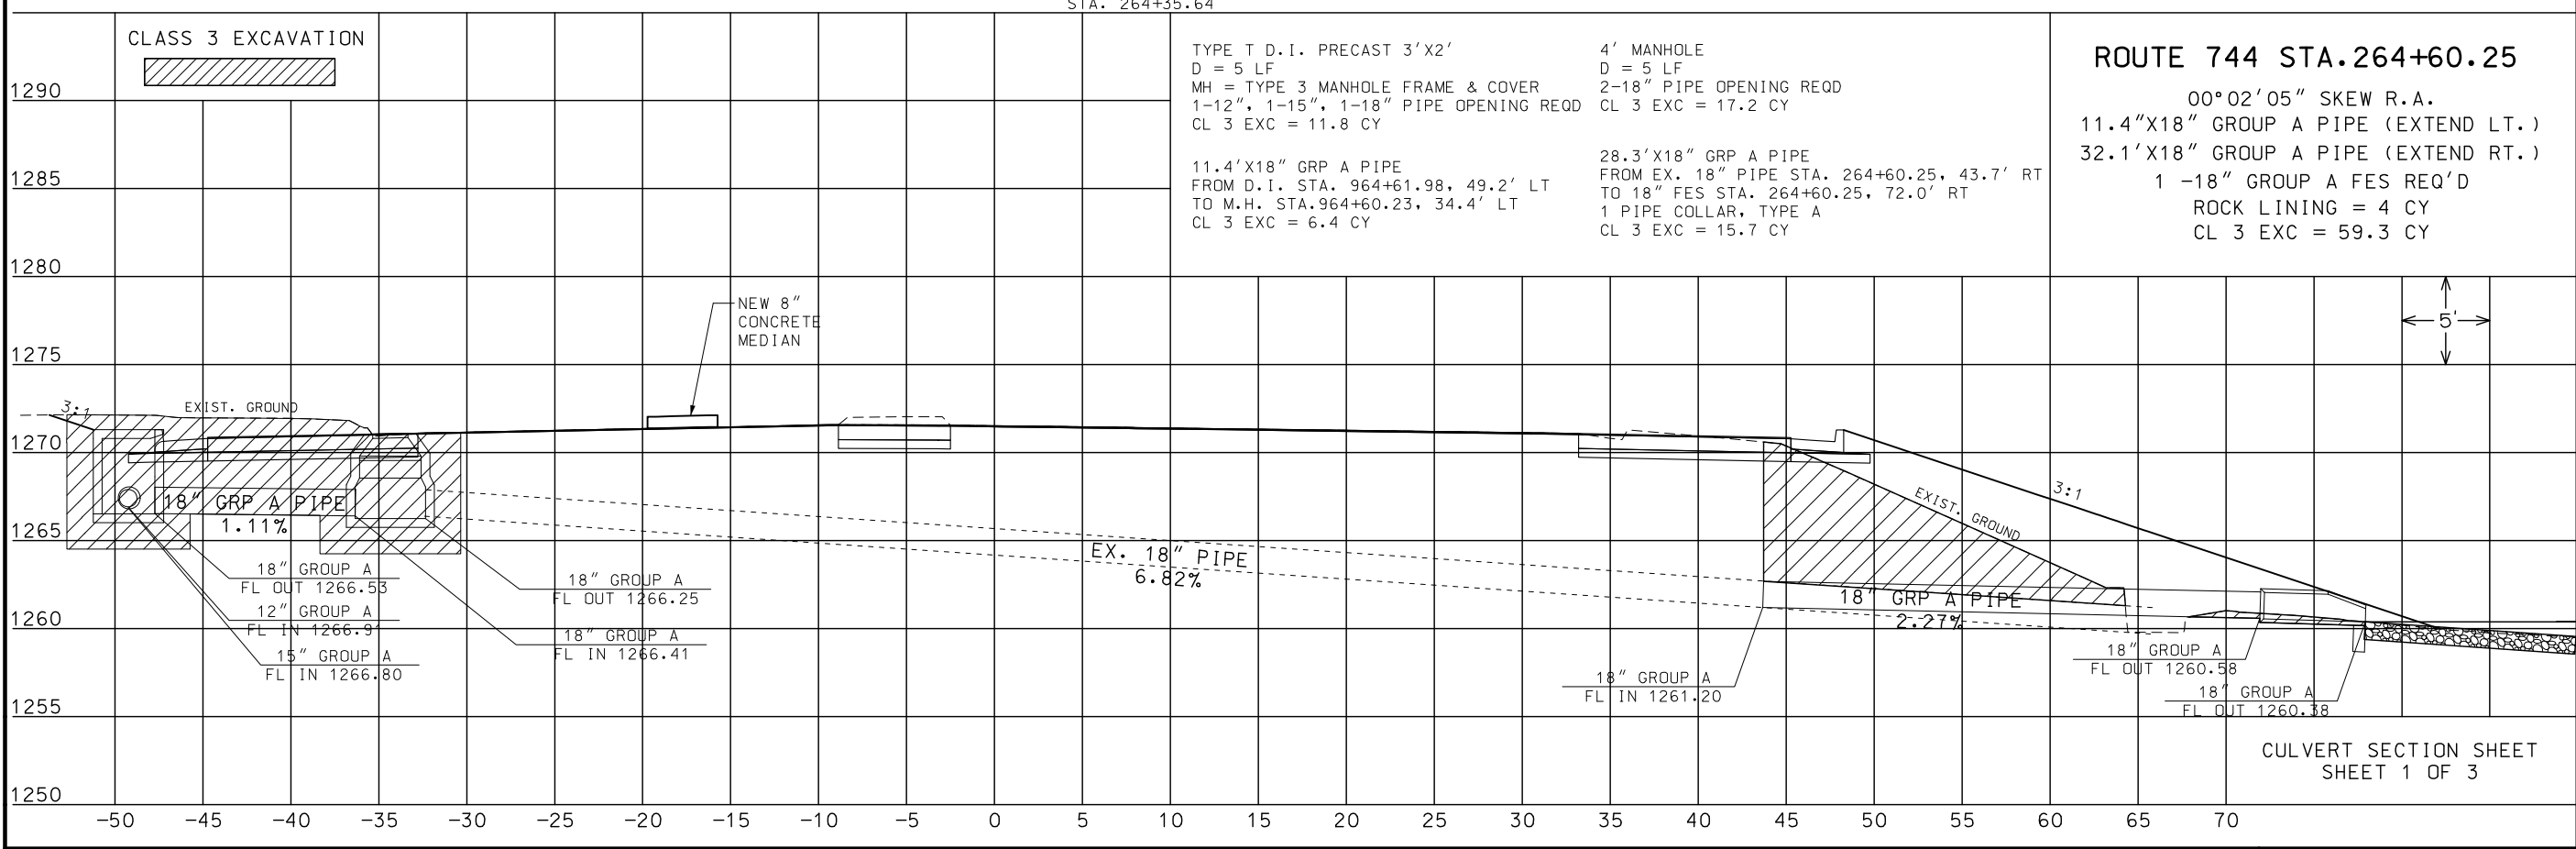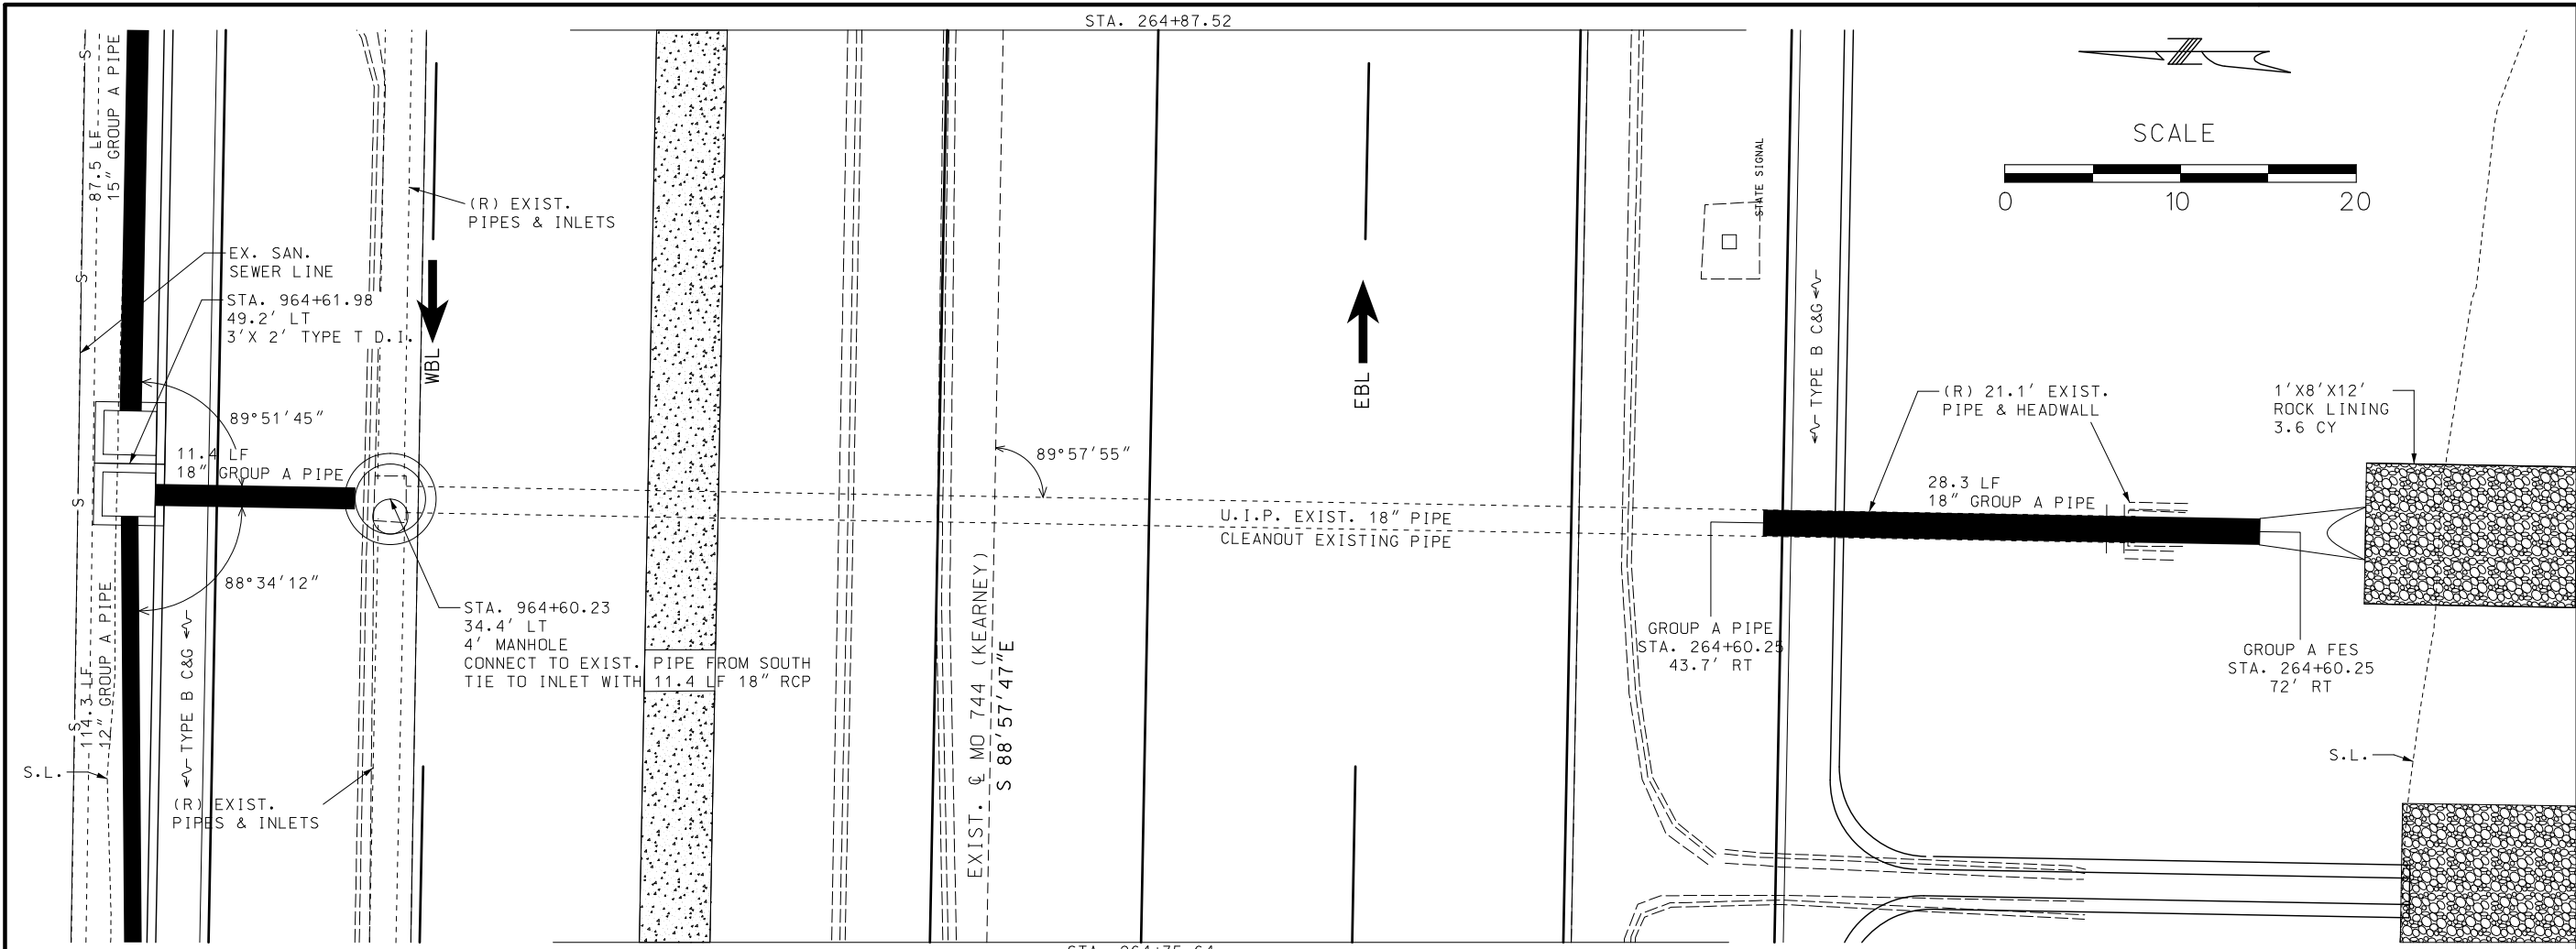

STATE OF MISSOURI

JASON D. EVENDEN

NUMBER

PE-2013000659

PROFESSIONAL ENGINEER

THIS SHEET HAS BEEN

SIGNED, SEALED AND DATED

ELECTRONICALLY.

DATE PREPARED

8/5/2021

ROUTE

744/160

STATE

MO

DISTRICT

SW

SHEET NO.

60

COUNTY

GREENE

JOB NO.

J8P3087D

CONTRACT ID.

PROJECT NO.

BRIDGE NO.

DESCRIPTION

DATE

MISSOURI HIGHWAYS AND TRANSPORTATION

COMMISSION

105 WEST CAPITOL

JEFFERSON CITY, MO 65102

1-888-ASK-MODOT (1-888-275-6636)

ROUTE 744 STA. 264+60.25

00°02'05" SKEW R.A.

11.4'X18" GROUP A PIPE (EXTEND LT.)

32.1'X18" GROUP A PIPE (EXTEND RT.)

1 -18" GROUP A FES REQ'D


ROCK LINING = 4 CY

CL 3 EXC = 59.3 CY

CULVERT SECTION SHEET


SHEET 1 OF 3

IF A SEAL IS PRESENT ON THIS SHEET IT HAS BEEN ELECTRONICALLY SEALED AND DATED.

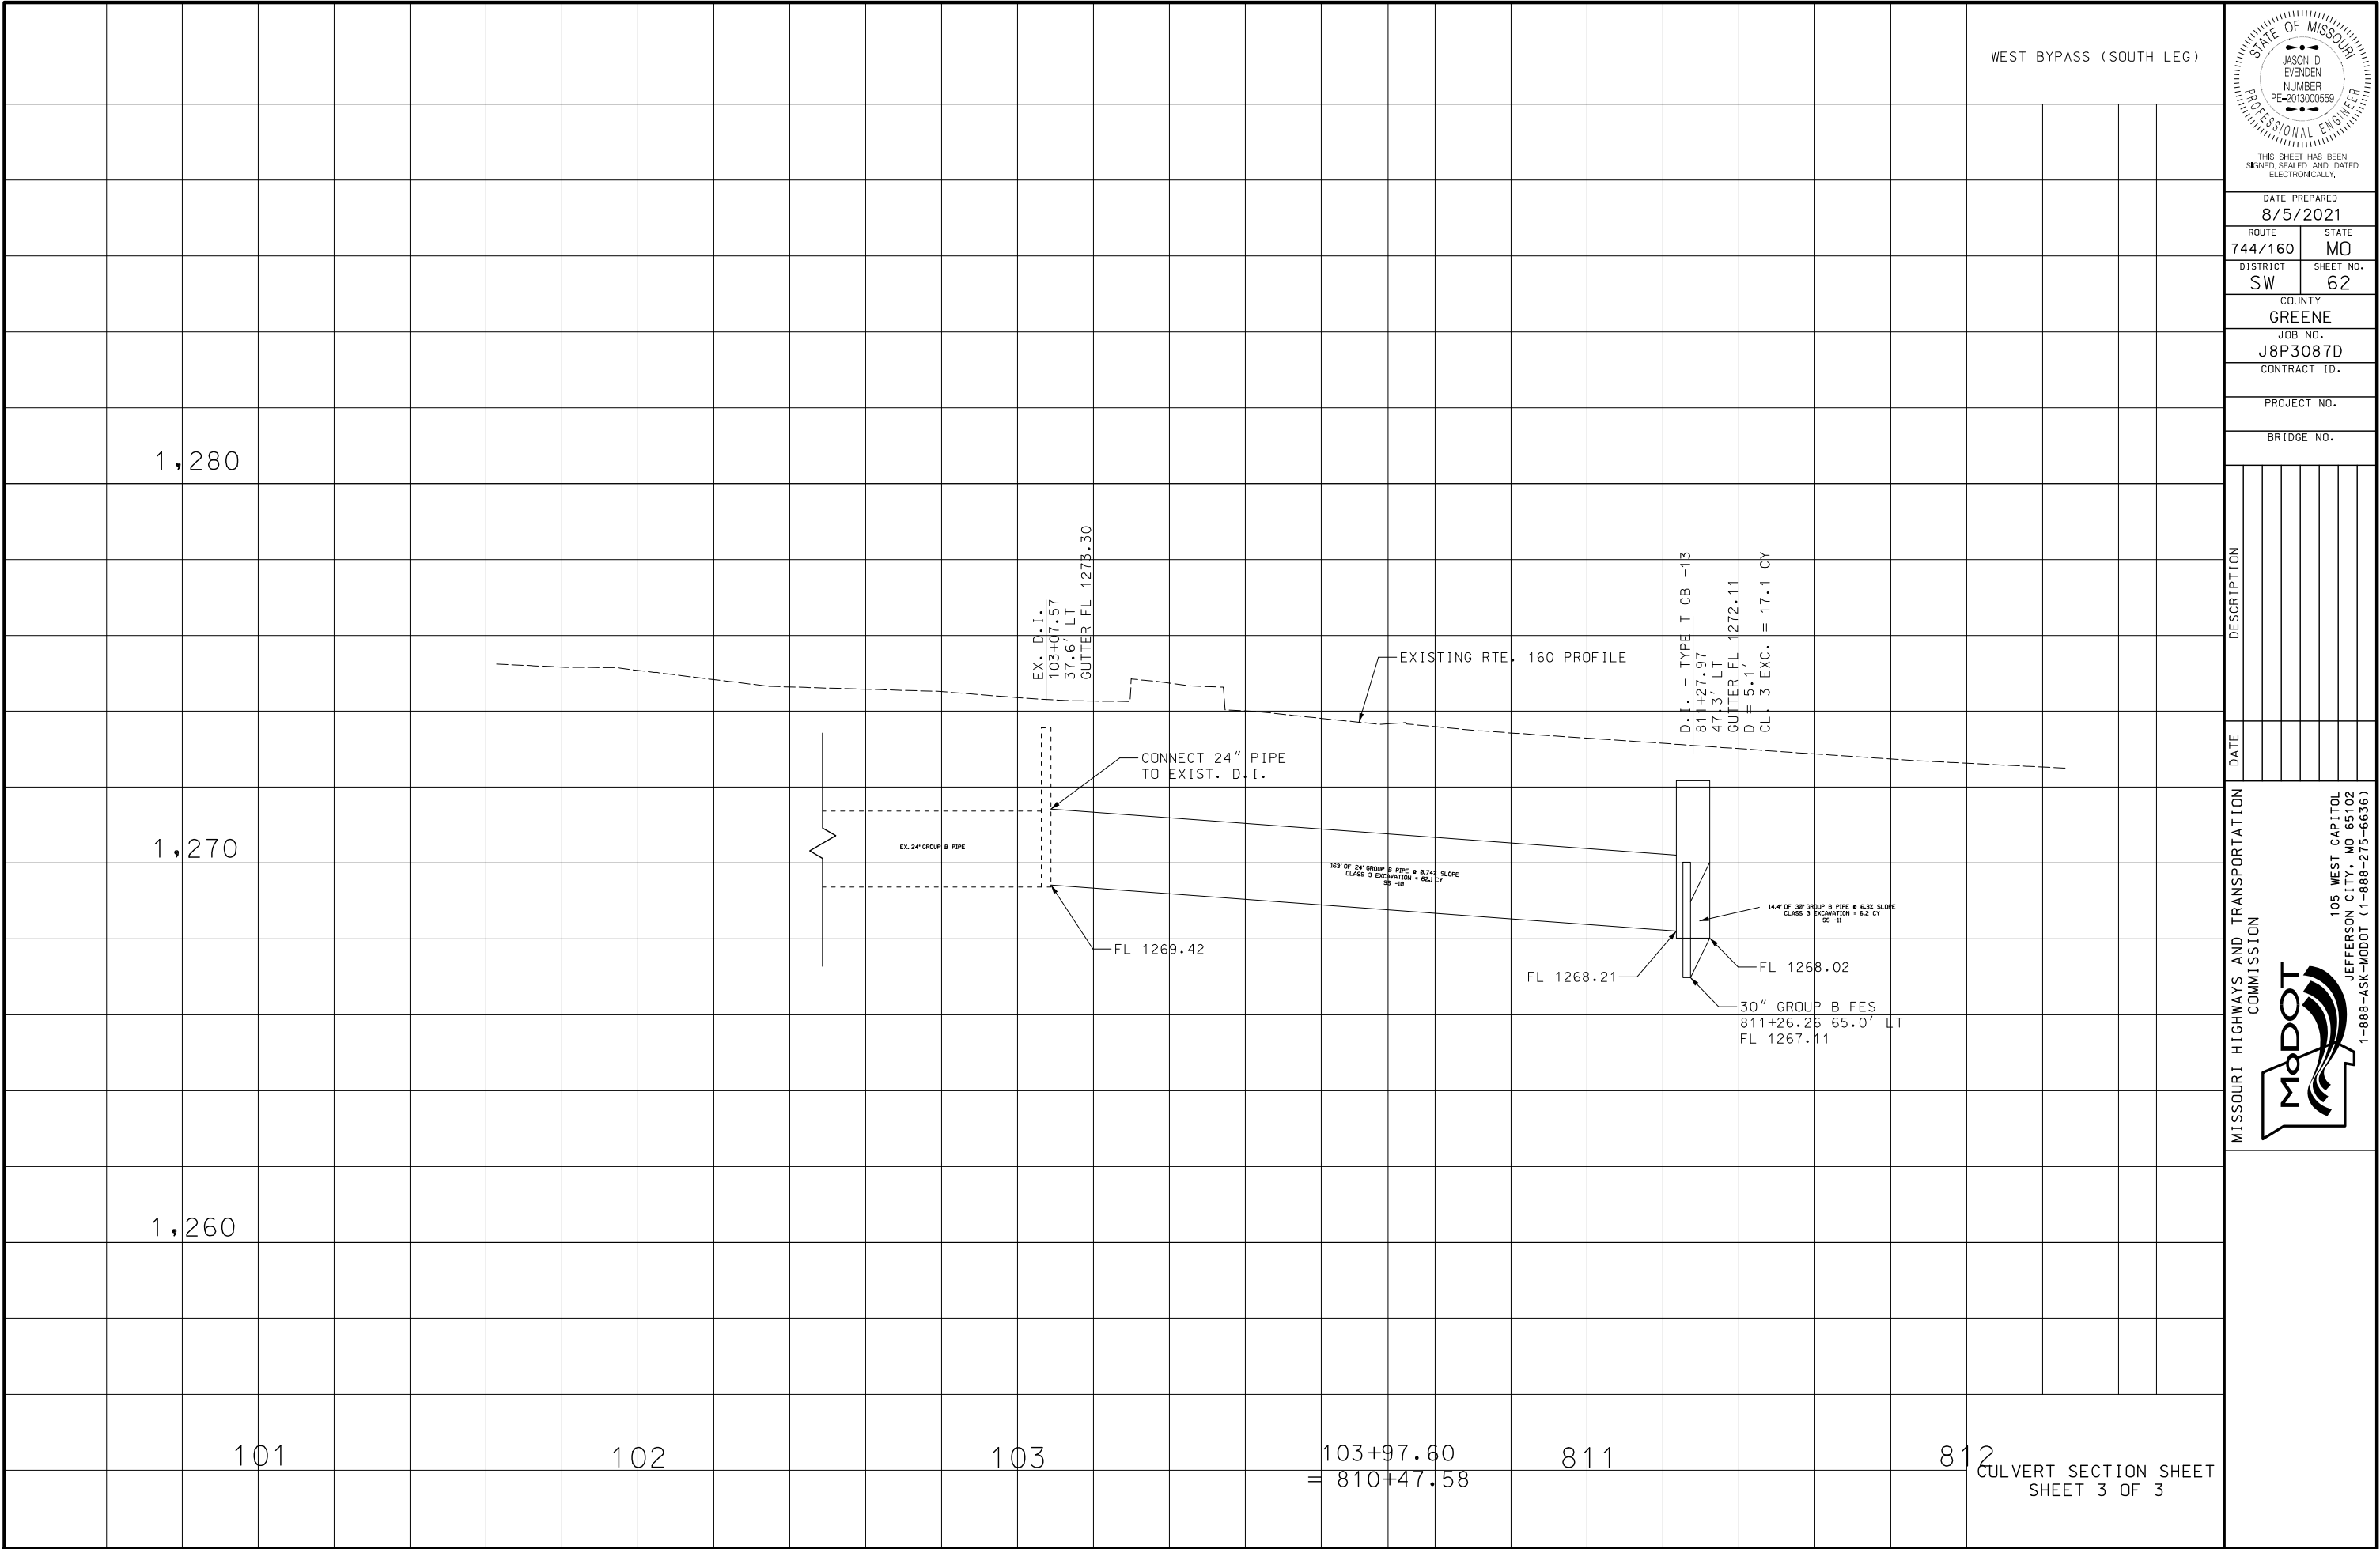

CONTRACTOR UNDERGROUND DISTRIBUTION CONSTRUCTION

1	INSTALL:	1 EACH LED-B3
	NOTE:	C.U. FURNISHED, CONTRACTOR INSTALLED STREETLIGHT
2	INSTALL:	1 EACH LED-B3
	NOTE:	C.U. FURNISHED, CONTRACTOR INSTALLED STREETLIGHT
3	INSTALL:	1 EACH LED-B3
	NOTE:	C.U. FURNISHED, CONTRACTOR INSTALLED STREETLIGHT
4	INSTALL:	1 EACH LED-B3
	NOTE:	C.U. FURNISHED, CONTRACTOR INSTALLED STREETLIGHT
5	REMOVE:	1 EACH STREETLIGHT FOUNDATION
	INSTALL:	1 EACH CF24-120
	INSTALL:	2 EACH P224-90V
	NOTE:	INTERCEPT EXISTING CONDUIT
5A	INSTALL:	1 EACH 2PVG
5B	INSTALL:	1 EACH 2PVG
6	REMOVE:	1 EACH STREETLIGHT FOUNDATION
7	INSTALL:	1 EACH CF24-120
	INSTALL:	2 EACH P224-90V
7A	INSTALL:	1 EACH 2PVG
7B	INSTALL:	1 EACH 2PVG
8	REMOVE:	1 EACH STREETLIGHT FOUNDATION
9	INSTALL:	1 EACH CF24-120
	INSTALL:	2 EACH P224-90V
10	INSTALL:	1 EACH SR-2CP
11	INSTALL:	1 EACH SP-SW
	INSTALL:	3 EACH P218-45V
	NOTE:	INSTALL SERVICE ELBOWS AS REQUIRED
12	REMOVE:	1 EACH STREETLIGHT FOUNDATION
13	INSTALL:	1 EACH CF24-150
	INSTALL:	2 EACH P224-90V
	INSTALL:	1 EACH 2P
	NOTE:	CAP AND FACE SPARE ELBOW NORTH
14	REMOVE:	1 EACH SP-2C
15	REMOVE:	1 EACH STREETLIGHT FOUNDATION
16	REMOVE:	1 EACH STREETLIGHT FOUNDATION
17	REMOVE:	1 EACH JC3-2C
	NOTE:	COORDINATE WITH INSPECTOR PRIOR TO WORK
18	INSTALL:	1 EACH JC3-2C
	INSTALL:	1 EACH G424-90V
	INSTALL:	3 EACH G224-90V
	NOTE:	COORDINATE WITH INSPECTOR PRIOR TO WORK
19	REMOVE:	1 EACH STREETLIGHT FOUNDATION
20	REMOVE:	1 EACH STREETLIGHT FOUNDATION
	INSTALL:	1 EACH CF24-120
	INSTALL:	2 EACH P224-90V
	INSTALL:	1 EACH 2P
	NOTE:	CAP AND FACE SPARE ELBOW EAST
20A	REMOVE:	1 EACH STREETLIGHT FOUNDATION
	INSTALL:	1 EACH CF24-120
	INSTALL:	2 EACH P224-90V
21	INSTALL:	1 EACH CF24-120
	INSTALL:	3 EACH P224-90V
22	REMOVE:	1 EACH STREETLIGHT FOUNDATION
23	INSTALL:	1 EACH CF24-150
	INSTALL:	2 EACH P224-90V
25	REMOVE:	1 EACH STREETLIGHT FOUNDATION
26	REMOVE:	1 EACH STREETLIGHT FOUNDATION
27	INSTALL:	1 EACH CF24-120
	INSTALL:	3 EACH P224-90V
27A	INSTALL:	1 EACH 2PVG
27B	INSTALL:	1 EACH 2PVG
28A	INSTALL:	1 EACH 2PVG
28B	INSTALL:	1 EACH 2PVG
29A	INSTALL:	1 EACH 2PVG
29B	INSTALL:	1 EACH 2PVG
30	REMOVE:	1 EACH SP-2C
31	INSTALL:	1 EACH SP-SW
	INSTALL:	3 EACH P218-45V
32	INSTALL:	1 EACH CF24-120
	INSTALL:	2 EACH P224-90V
33	REMOVE:	1 EACH STREETLIGHT FOUNDATION
34	INSTALL:	1 EACH CF24-150
	INSTALL:	2 EACH P224-90V
35	REMOVE:	1 EACH STREETLIGHT FOUNDATION
36	INSTALL:	1 EACH CF24-120
	INSTALL:	2 EACH P224-90V
37	REMOVE:	1 EACH STREETLIGHT FOUNDATION
	INSTALL:	1 EACH CF24-120
	INSTALL:	2 EACH P224-90V
	INSTALL:	1 EACH 2P
	NOTE:	CAP AND FACE SPARE ELBOW WEST

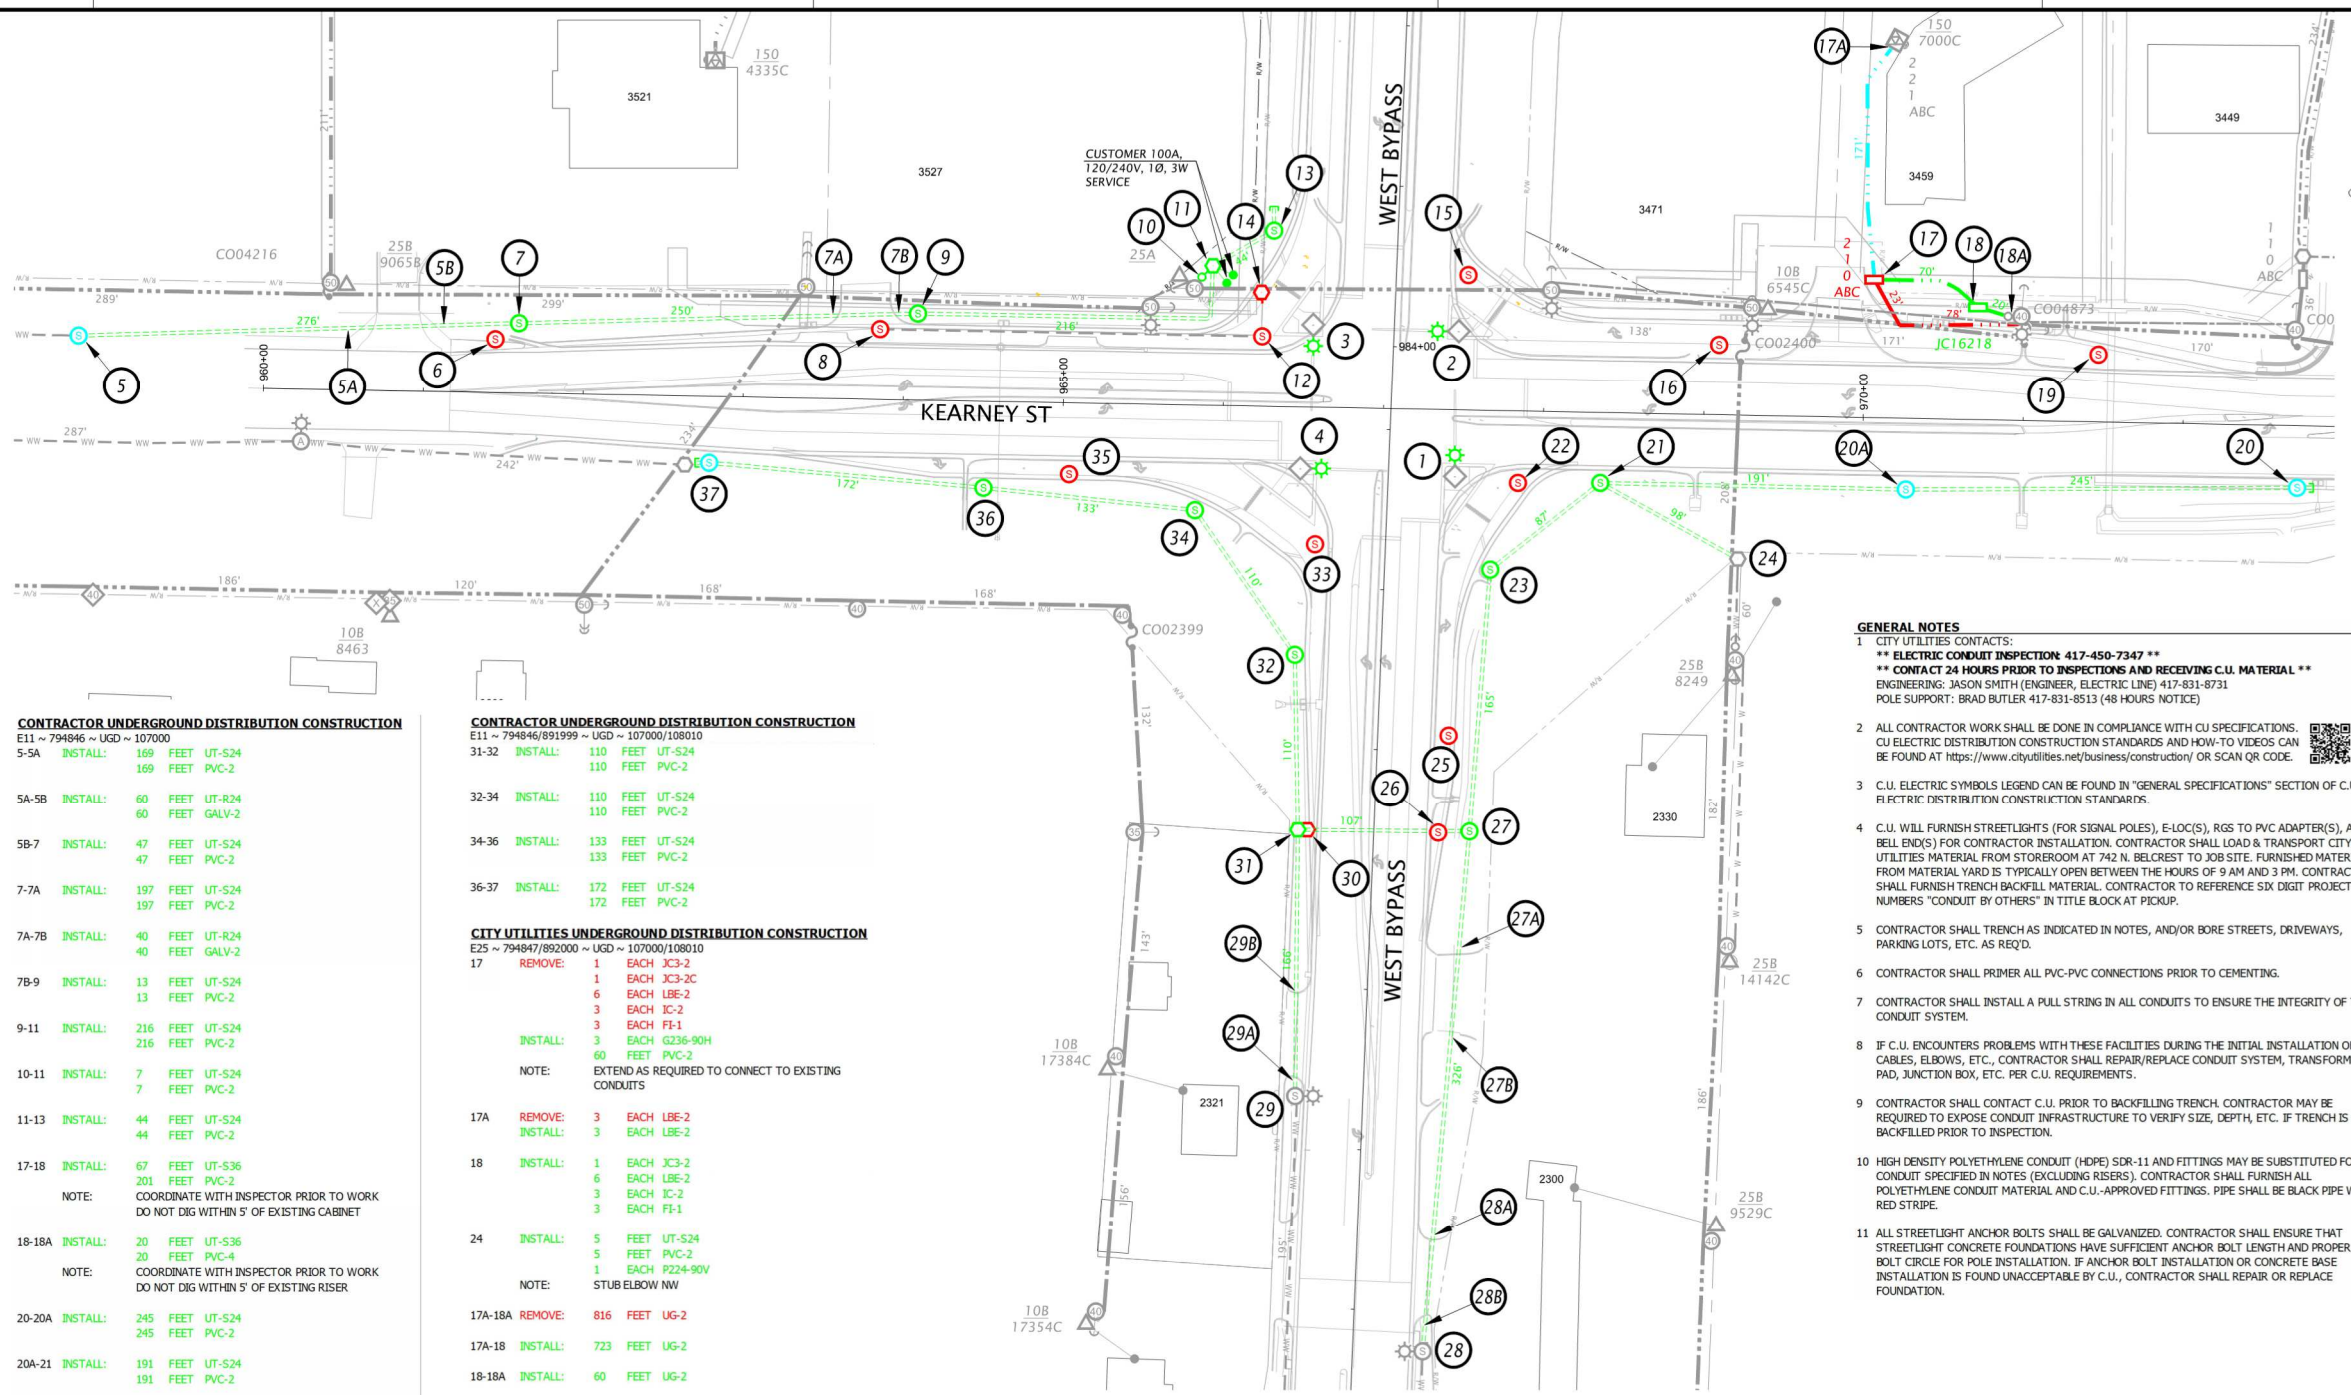

CONTRACTOR UNDERGROUND DISTRIBUTION CONSTRUCTION

E11 ~ 794846 ~ UGD ~ 107000			
5-5A	INSTALL:	169 FEET 169 FEET	UT-S24 PVC-2
5A-5B	INSTALL:	60 FEET 60 FEET	UT-R24 GALV-2
5B-7	INSTALL:	47 FEET 47 FEET	UT-S24 PVC-2
7-7A	INSTALL:	197 FEET 197 FEET	UT-S24 PVC-2
7A-7B	INSTALL:	40 FEET 40 FEET	UT-R24 GALV-2
7B-9	INSTALL:	13 FEET 13 FEET	UT-S24 PVC-2
9-11	INSTALL:	216 FEET 216 FEET	UT-S24 PVC-2
10-11	INSTALL:	7 FEET 7 FEET	UT-S24 PVC-2
11-13	INSTALL:	44 FEET 44 FEET	UT-S24 PVC-2
17-18	INSTALL:	67 FEET 201 FEET	UT-S36 PVC-2
	NOTE:	COORDINATE WITH INSPECTOR PRIOR TO WORK DO NOT DIG WITHIN 5' OF EXISTING CABINET	
18-18A	INSTALL:	20 FEET 20 FEET	UT-S36 PVC-4
	NOTE:	COORDINATE WITH INSPECTOR PRIOR TO WORK DO NOT DIG WITHIN 5' OF EXISTING RISER	
20-20A	INSTALL:	245 FEET 245 FEET	UT-S24 PVC-2
20A-21	INSTALL:	191 FEET 191 FEET	UT-S24 PVC-2
21-23	INSTALL:	87 FEET 87 FEET	UT-S24 PVC-2
21-24	INSTALL:	93 FEET 93 FEET	UT-S24 PVC-2
	NOTE:	DO NOT DIG WITHIN 5' OF EXISTING PEDESTAL	
23-27	INSTALL:	165 FEET 165 FEET	UT-S24 PVC-2
27-27A	INSTALL:	75 FEET 75 FEET	UT-S24 PVC-2
27A-27B	INSTALL:	54 FEET 54 FEET	UT-R24 GALV-2
27B-28A	INSTALL:	124 FEET 124 FEET	UT-S24 PVC-2
28A-28B	INSTALL:	54 FEET 54 FEET	UT-R24 GALV-2
28B-28	INSTALL:	19 FEET 19 FEET	UT-S24 PVC-2
	NOTE:	CONNECT TO EXISTING ELBOW AT WL 28	
27-31	INSTALL:	107 FEET 107 FEET	UT-R24 PVC-2
29-29A	INSTALL:	8 FEET 8 FEET	UT-S24 PVC-2
	NOTE:	CONNECT TO EXISTING ELBOW AT WL 29	
29A-29B	INSTALL:	60 FEET 60 FEET	UT-R24 GALV-2
29B-31	INSTALL:	98 FEET 98 FEET	UT-S24 PVC-2

CONTRACTOR UNDERGROUND DISTRIBUTION CONSTRUCTION

E11 ~ 794846/891999 ~ UGD ~ 107000/108010			
31-32	INSTALL:	110 FEET	UT-S24
		110 FEET	PVC-2
32-34	INSTALL:	110 FEET	UT-S24
		110 FEET	PVC-2
34-36	INSTALL:	133 FEET	UT-S24
		133 FEET	PVC-2
36-37	INSTALL:	172 FEET	UT-S24
		172 FEET	PVC-2
CITY UTILITIES UNDERGROUND DISTRIBUTION CONSTRUCTION			
E25 ~ 794847/892000 ~ UGD ~ 107000/108010			
17	REMOVE:	1 EACH	JC3-2
		1 EACH	JC3-2C
		6 EACH	LBE-2
		3 EACH	IC-2
		3 EACH	FI-1
	INSTALL:	3 EACH	G236-90H
		60 FEET	PVC-2
	NOTE:	EXTEND AS REQUIRED TO CONNECT TO EXISTING CONDUITS	
17A	REMOVE:	3 EACH	LBE-2
	INSTALL:	3 EACH	LBE-2
18	INSTALL:	1 EACH	JC3-2
		6 EACH	LBE-2
		3 EACH	IC-2
		3 EACH	FI-1
24	INSTALL:	5 FEET	UT-S24
		5 FEET	PVC-2
		1 EACH	P224-90V
	NOTE:	STUB ELBOW NW	
17A-18A	REMOVE:	816 FEET	UG-2
17A-18	INSTALL:	723 FEET	UG-2
18-18A	INSTALL:	60 FEET	UG-2

J8P3087D - CITY UTILITIES ELECTRIC QUANTITIES		
DESCRIPTION OF BID ITEM*	UNIT	EST. QTY.
FURNISH/INSTALL 2" PVC RIGID CONDUIT (PVC-2)	FT	2524
FURNISH/INSTALL 2" GALVANIZED RIGID CONDUIT (GALV-2)	FT	375
INSTALL THREE PHASE JUNCTION CABINET AND SLEEVE (JC3-2C)	EA	1
INSTALL SECONDARY PEDESTAL W/TRAFFIC-RATED COVER (SP-SW)	EA	2
FURNISH/INSTALL SECONDARY RISER START (SR-2CP)	EA	1
DISPOSE/REMOVE STREETLIGHT FOUNDATION	EA	15
FURNISH/INSTALL STREETLIGHT CONCRETE FOUNDATION	EA	13

*SPECIAL NOTE: CONDUIT ELBOW(S), CONDUIT COUPLINGS AND CONDUIT PLUGS ARE NOT INCLUDED IN THE ELECTRIC QUANTITIES BID ITEM ESTIMATE. THESE ITEMS SHALL BE CONSIDERED INCIDENTAL TO OTHER BID ITEMS. ADJUST CORRESPONDING BID PRICES FOR PEDESTAL(S), JUNCTION CABINET(S), CONDUIT OR ETC. AS NECESSARY TO COVER COST OF INCIDENTAL ITEMS.

EQUIPMENT INSTALLATION LOCATIONS						
WORK LOCATION	ROUTE**	STATION	OFFSET	DESCRIPTION	GENERAL LOCATION	REMARK
5	KEARNEY	958+84.1	31.0' LT	STREETLIGHT FOUNDATION	WB KEARNEY	
7	KEARNEY	961+59.0	43.8' LT	STREETLIGHT FOUNDATION	WB KEARNEY	
9	KEARNEY	964+8.3	54.3' LT	STREETLIGHT FOUNDATION	WB KEARNEY	ENSURE NESC CLEARANCES FROM OVERHEAD ELECTRIC LINE
11	KEARNEY	965+91.9	87.4' LT	SECONDARY PEDESTAL (SP-SW)	WB KEARNEY	FLUSH WITH FINISHED GRADE
13	160	983+30.8	77.4' RT	STREETLIGHT FOUNDATION	SB WEST BYPASS(160)	
18	KEARNEY	970+70.7	70.5' LT	PRIMARY CABINET (JC3-2)	WB KEARNEY	
20	KEARNEY	972+72.1	38.8' RT	STREETLIGHT FOUNDATION	EB KEARNEY	
20A	KEARNEY	970+27.5	44.4' RT	STREETLIGHT FOUNDATION	EB KEARNEY	
21	KEARNEY	968+36.1	44.0' RT	STREETLIGHT FOUNDATION	EB KEARNEY	
23	KEARNEY	967+68.5	99.4' RT	STREETLIGHT FOUNDATION	NB WEST BYPASS(160)	
27	160 SOUTH	810+47.6	59.8' RT	STREETLIGHT FOUNDATION	NB WEST BYPASS(160)	
31	160 SOUTH	810+47.6	47.4' LT	SECONDARY PEDESTAL (SP-SW)	SB WEST BYPASS(160)	FLUSH WITH FINISHED GRADE
32	160	966+47.4	154.9' RT	STREETLIGHT FOUNDATION	SB WEST BYPASS(160)	
34	KEARNEY	965+83.4	65.7' RT	STREETLIGHT FOUNDATION	EB KEARNEY	
36	KEARNEY	964+51.1	54.1' RT	STREETLIGHT FOUNDATION	EB KEARNEY	
37	KEARNEY	962+79.5	41.5' RT	STREETLIGHT FOUNDATION	EB KEARNEY	

** CHECK GENERAL LOCATION COLUMN TO ALIGN ANCHOR BOLT SQUARE WITH EDGE OF SHOULDER.



EXISTING
INSTALL
REMOVE
REPLACE
or TRANSFER
NOTE TO
G.I.S. DEPT.

ELECTRIC LINE CONSTRUCTION		PROJECT NUMBERS		
1/4 SEC. SEC-TYPING: SE, 5-29-22/SW, 4-29-22 NE, 8-29-22/NW, 9-29-22	☒ LOCATES REQD	WORK TYPE	OH	UG
CONSTRUCTION: ☐ OVERHEAD ☒ UNDERGROUND	☐ CUSTOMER TREE TRIM	TRANSMISSION		
MAXIMUM VOLTAGE: ☒ 0.4V ☐ 120V ☐ 240V ☐ 7.62KV	☐ CU TREE TRIM	DISTRIBUTION		
☒ 3.2KV ☐ 69KV ☐ 161KV ☐ 345KV	☐ CATV - WORK REQD			
SUBFEEDER(S): JUN-5	HOT LINE TAG AVAILABLE: ☐	CONDUIT (BY OTHERS)		
SUBFEEDER(S): -	HOT LINE TAG AVAILABLE: ☐	CONDUIT (BY OTHERS)		
CREW LEADER:	☒ MoDOT PERMIT REQD	CONDUIT (BY OTHERS)		
COMPLETION DATE:	☐ EASEMENT REQD	OTHER		

ENGINEER: JASON SMITH
LICENSE NO.: PE-2005022158

DATE: 8/5/2021

ROUTE: 744/160
DISTRICT: SW
COUNTY: GREENE
JOB NO.: J8P3087D
CONTRACT ID.:

PROJECT NO.:

BRIDGE NO.:

DESCRIPTION:

DATE:

MISSOURI HIGHWAYS AND TRANSPORTATION COMMISSION

MoDOT

105 WEST CAPITOL
JEFFERSON CITY, MO 65102
1-888-ASK-MODOT (1-888-275-8636)

J8P3087D KEARNEY/W BYPASS STREETLIGHT INFRASTRUCTURE PLAN

SCALE: 1" = 60'

DATE: 8-5-21

BY: SMITH

CHECKED: LINDSEY

NO. OF SHEETS: 1 OF 1

CITY UTILITIES ELECTRIC PLAN SHEET 1 OF 1

DESIGN DESIGNATION

A.A.D.T. - 2022 = 30847
A.A.D.T. - 2042 = 38560
D.H.V. = 8.39%
T = 7.96%
V = 45, 50 M.P.H.
D = EB 51% / WB 49%

FUNCTIONAL CLASSIFICATION - FREEWAY


NO NEW RIGHT OF WAY

CONVENTIONAL SYMBOLS
(USED IN PLANS)

	EXISTING	NEW
BUILDINGS AND STRUCTURES		
GUARD RAIL		
GUARD CABLE		
CONCRETE RIGHT-OF-WAY MARKER		
STEEL RIGHT-OF-WAY MARKER		
LOCATION SURVEY MARKER		
UTILITIES		
FIBER OPTICS	-FO-	-FO-
OVERHEAD CABLE TV	-OTV-	-OTV-
UNDERGROUND CABLE TV	-UTV-	-UTV-
OVERHEAD TELEPHONE	-OT-	-OT-
UNDERGROUND TELEPHONE	-UT-	-UT-
OVERHEAD POWER	-OE-	-OE-
UNDERGROUND POWER	-UE-	-UE-
SANITARY SEWER	-S-	-S-
STORM SEWER	-SS-	-SS-
GAS	-G-	-G-
WATER	-W-	-W-
MANHOLE		
FIRE HYDRANT		
WATER VALVE		
WATER METER		
DROP INLET		
DITCH BLOCK		
GROUND MOUNTED SIGN		
LIGHT POLE		
H-FRAME POWER POLE		
TELEPHONE PEDESTAL		
FENCE		
CHAIN LINK		
WOVEN WIRE		
GATE POST		
BENCHMARK		

NOTE: DASHED OR OPEN SYMBOLS INDICATE EXISTING FEATURES

MISSOURI HIGHWAYS AND TRANSPORTATION COMMISSION
FINAL PLANS FOR PROPOSED
STATE HIGHWAY
GREENE COUNTY
CITY OF SPRINGFIELD

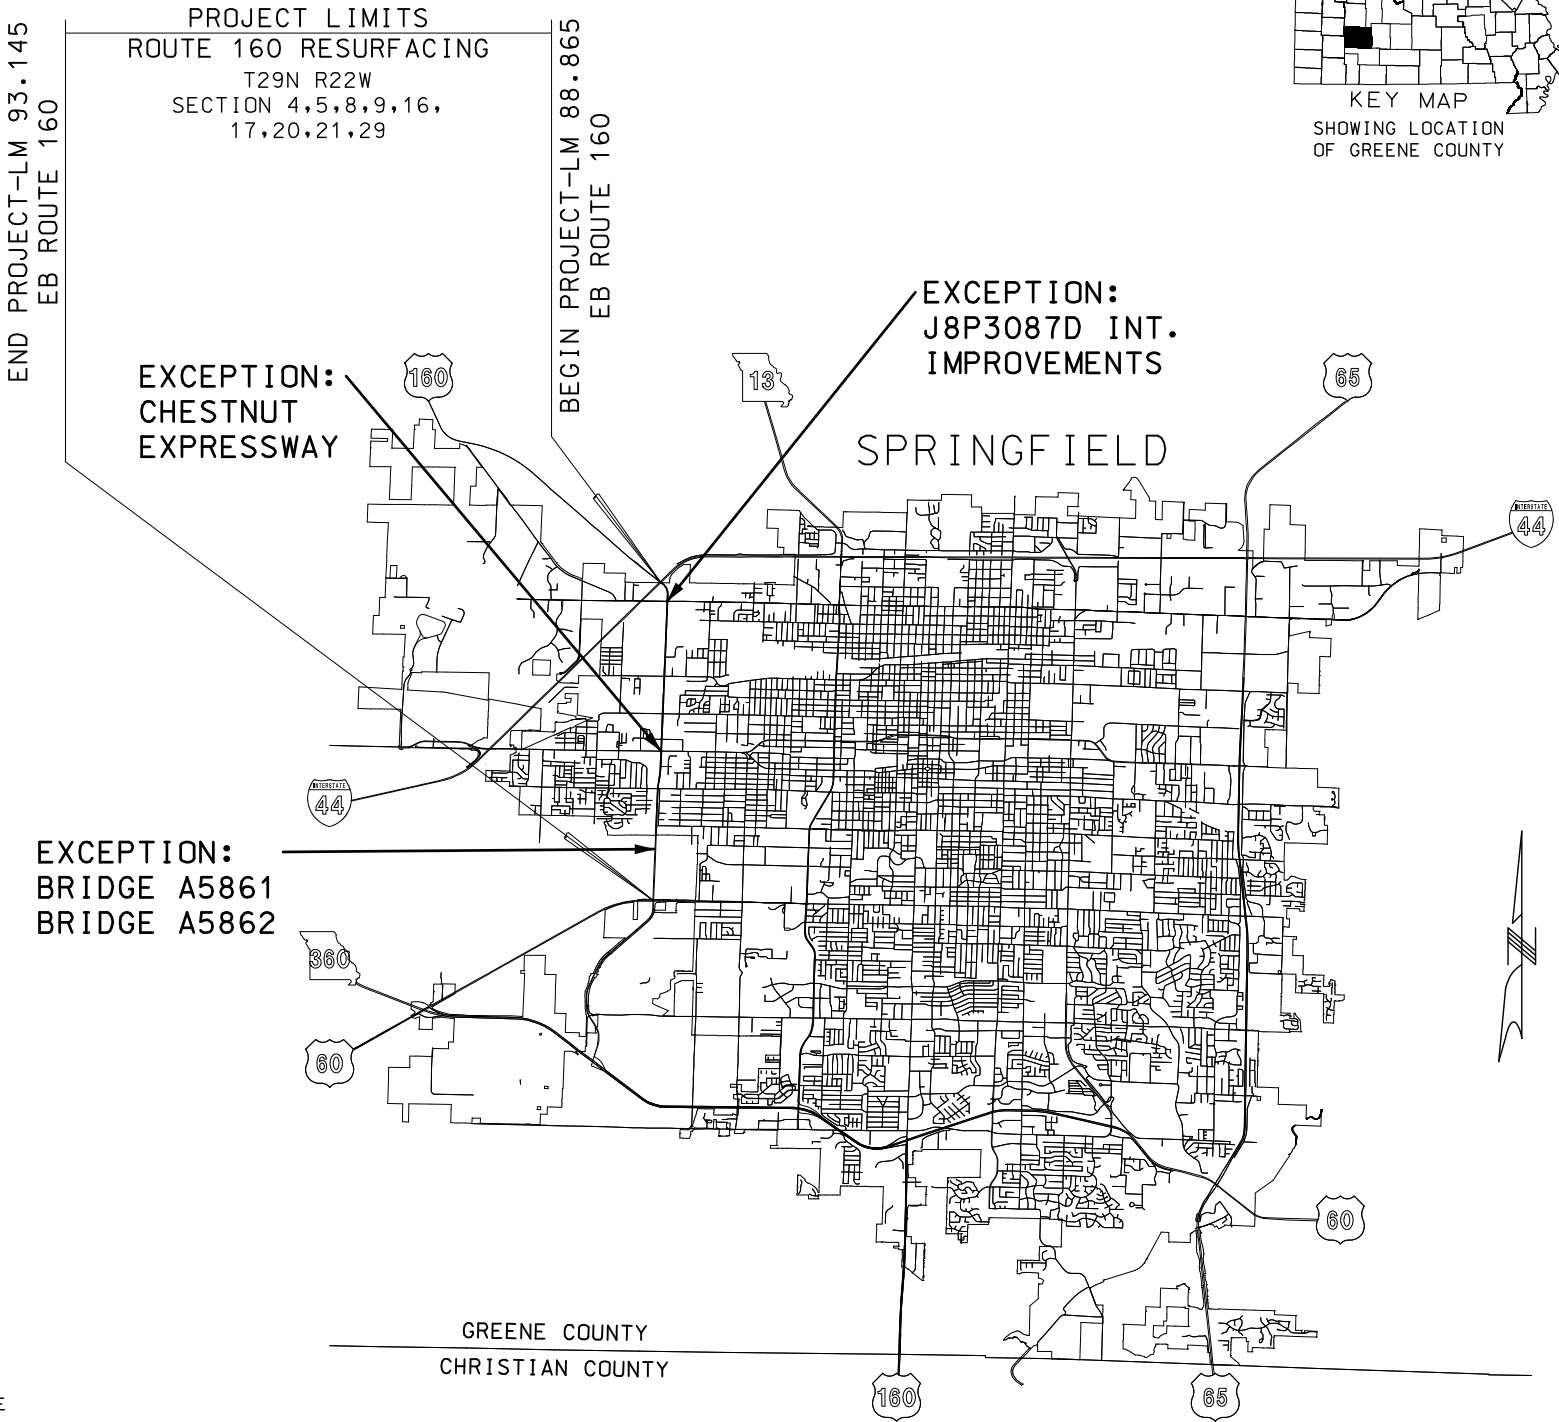

NOT TO SCALE

THE EXISTENCE AND APPROXIMATE LOCATION OF UTILITY FACILITIES KNOWN TO EXIST, AS SHOWN ON THE PLANS, ARE BASED ON THE BEST INFORMATION AVAILABLE TO THE COMMISSION AT THIS TIME. THIS INFORMATION IS PROVIDED BY THE COMMISSION "AS-IS" AND THE COMMISSION EXPRESSLY DISCLAIMS ANY REPRESENTATION OR WARRANTY AS TO THE COMPLETENESS, ACCURACY, OR SUITABILITY OF THE INFORMATION FOR ANY USE. RELIANCE UPON THIS INFORMATION IS DONE AT THE RISK AND PERIL OF THE USER, AND THE COMMISSION SHALL NOT BE LIABLE FOR ANY DAMAGES THAT MAY ARISE FROM ANY ERROR IN THE INFORMATION. IT IS, THEREFORE, THE RESPONSIBILITY OF THE CONTRACTOR TO VERIFY THE EXISTENCE, LOCATION AND STATUS OF ANY FACILITY. SUCH VERIFICATION INCLUDES DIRECT CONTACT WITH THE LISTED UTILITIES.

INDEX OF SHEETS

DESCRIPTION	SHEET NUMBER
TITLE SHEET -----	1
TYPICAL SECTIONS (TS) (2 SHEETS)---	2
QUANTITIES (QU) (4 SHEETS)-----	3
TRAFFIC CONTROL SHEETS (TC)-----	4-6
SPECIAL SHEETS (SS)-----	7



DATE PREPARED	8/3/2021
ROUTE	160
DISTRICT	SW
STATE	MO
SHEET NO.	1
COUNTY	GREENE
JOB NO.	J8P3170
CONTRACT ID.	
PROJECT NO.	
BRIDGE NO.	

DESCRIPTION	DATE

LENGTH OF PROJECT

2020 ARAN LOG MILES	
BEGINNING OF PROJECT	EB LM 88.865 WB LM 234.626
END OF PROJECT	EB LM 93.145 WB LM 230.352
APPARENT LENGTH	45165 FEET

EQUATIONS AND EXCEPTIONS:

J8P3087D INTERSECTION IMPROVEMENTS	
-EB LM 88.996 - 89.220	1183 FEET
-WB LM 234.279 - 234.503	1183 FEET
CHESTNUT EXPRESSWAY PAVEMENT	
-EB LM 91.128 - 91.143	79 FEET
-WB LM 232.354 - 232.369	79 FEET
BRIDGE A5862	
-EB LM 92.235 - 92.292	301 FEET
BRIDGE A5861	
-WB LM 231.204 - 231.261	301 FEET

TOTAL EXCEPTIONS	3126 FEET
NET LENGTH OF PROJECT	42039 FEET
STATE LENGTH	7.962 MILES

FOR INFORMATION ONLY ESTIMATED DISTURBED ACRES	0 ACRES
---	---------

MISSOURI HIGHWAYS AND TRANSPORTATION COMMISSION


105 WEST CAPITOL
JEFFERSON CITY, MO 65102
1-888-ASK-MODOT (1-888-275-6636)

IF A SEAL IS PRESENT ON THIS SHEET IT HAS BEEN ELECTRONICALLY SEALED AND DATED.

NOTE: NO ADDITIONAL PAYMENT WILL BE MADE FOR ADDITIONAL COLDMILLING (UP TO 3") REQUIRED TO REMOVE ENTIRE TOP LIFT DUE TO DELAMINATION. THIS APPLIES TO ENTIRE PROJECT LIMITS.

SURFACE PLACEMENT - ONE PASS PER LANE
NO S.E. CORRECTION

ASPHALT FACTORS		
	COMBINED FACTOR	% AC
SP125C (PG76-22)	1.995 TONS/CY	5.2
TACK COAT		
MILLING		0.10 GAL/SY

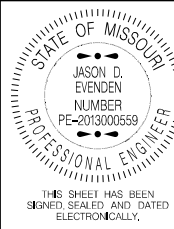



DATE PREPARED 8/3/2021	
ROUTE 160	STATE MO
DISTRICT SW	SHEET NO. 2
COUNTY GREENE	
JOB NO. J8P3170	
CONTRACT ID.	
PROJECT NO.	
BRIDGE NO.	

DESCRIPTION	DATE


MISSOURI HIGHWAYS AND TRANSPORTATION COMMISSION



105 WEST CAPITOL
JEFFERSON CITY, MO 65102
1-888-ASK-MODOT (1-888-275-6636)

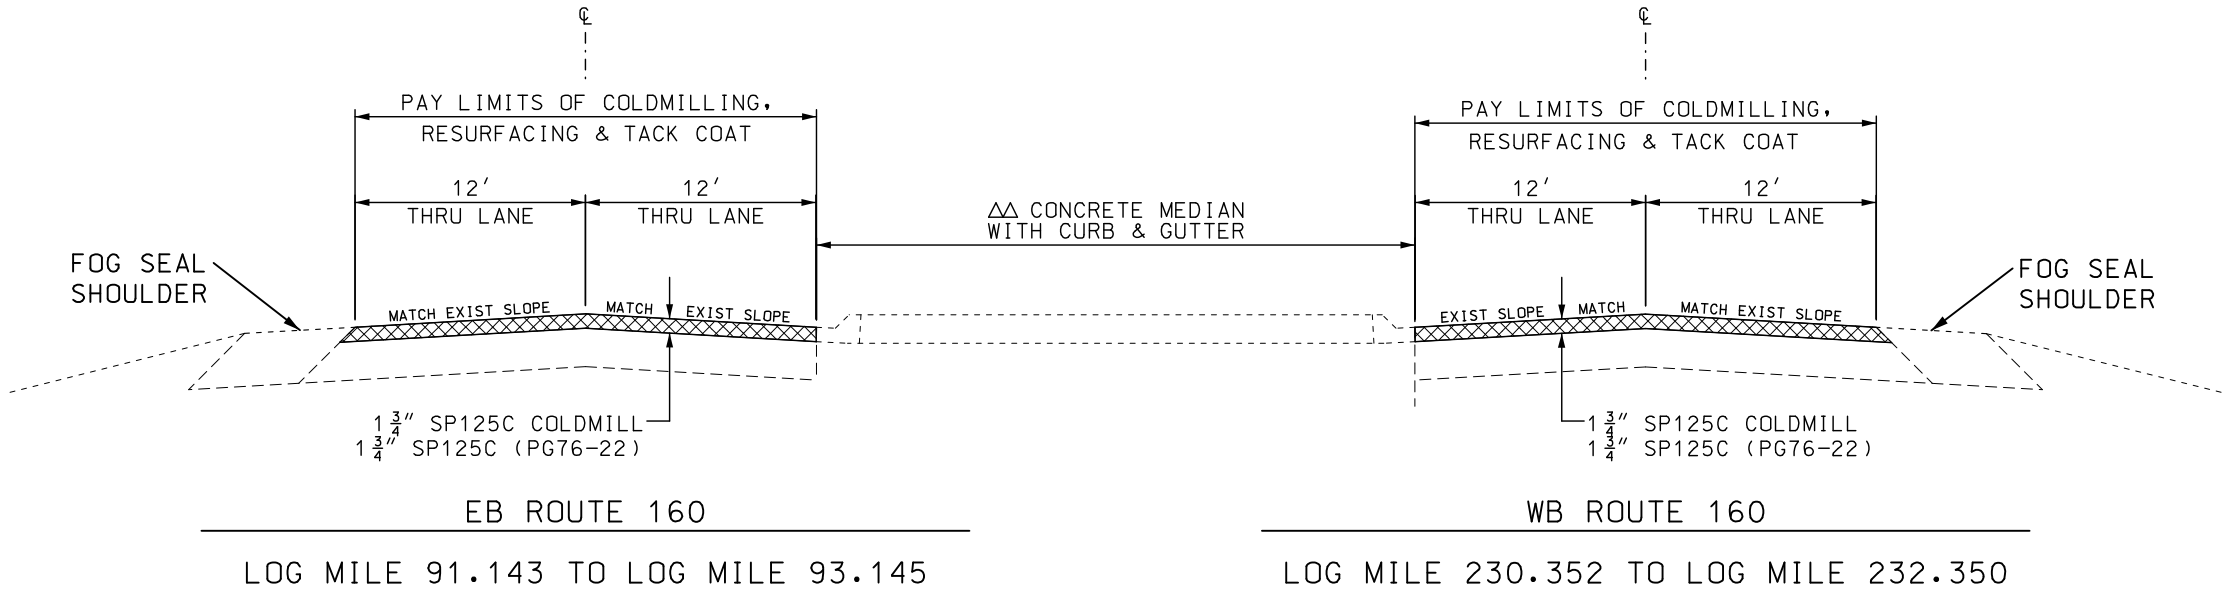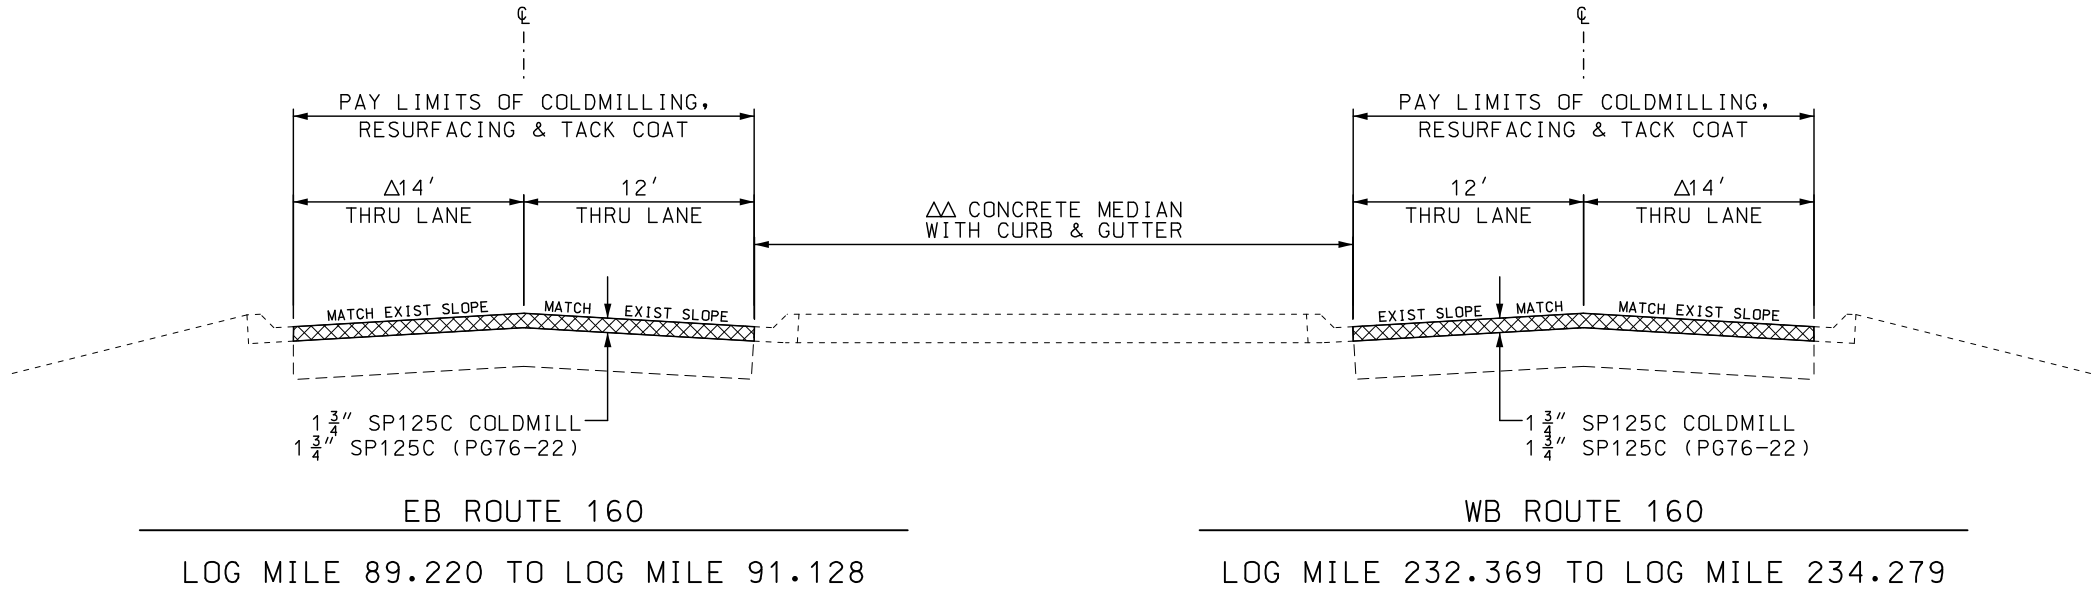

Δ 14' SHARED LANE FOR TRUCKS
ΔΔ VARIABLE WIDTH 9.75" RAISED MEDIAN
STRIP TRANSITIONS FROM 14' TO 4' AT
TURN LANES W/ CURB & GUTTER

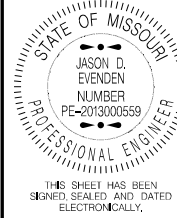


DATE PREPARED 8/3/2021	
ROUTE 160	STATE MO
DISTRICT SW	SHEET NO. 2
COUNTY GREENE	
JOB NO. J8P3170	
CONTRACT ID.	
PROJECT NO.	
BRIDGE NO.	

DATE	DESCRIPTION

MISSOURI HIGHWAYS AND TRANSPORTATION COMMISSION

MoDOT


105 WEST CAPITOL
JEFFERSON CITY, MO 65102
1-888-ASK-MODOT (1-888-275-6636)

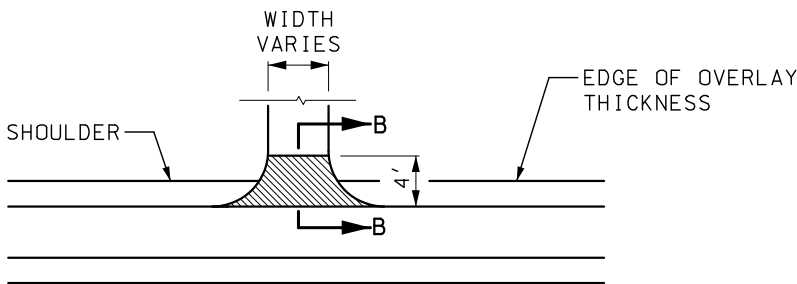

ASPHALT & CONCRETE ENTRANCES

SECTION B-B

TYPICAL ENTRANCE - EXIST/NEW SHOULDER
(FIELD, PRIVATE OR COUNTY ROAD)
*TAPER AT 1:1 FOR FIELD ENTRANCE

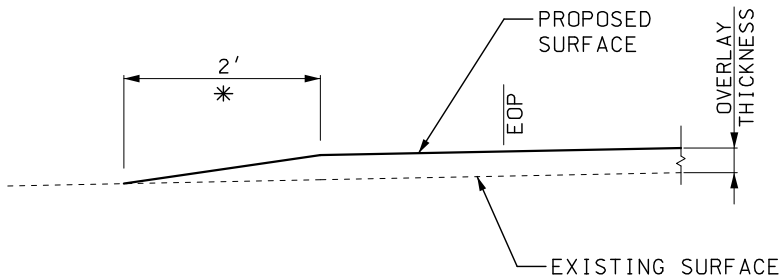

NOTES: DO NOT BUILD 2' MODIFIED A3 SHOULDERS
ACROSS CONCRETE OR ASPHALT ENTRANCES,
STREETS OR ROADS.

4 TONS GRAVEL A OR CRUSHED STONE B
CALCULATED PER ENTRANCE.


6 TONS CALCULATED PER COUNTY ROAD.

NOTE: NO ADDITIONAL PAYMENT WILL BE MADE FOR ADDITIONAL
COLDMILLING (UP TO 3") REQUIRED TO REMOVE ENTIRE
TOP LIFT DUE TO DELAMINATION. THIS APPLIES TO
ENTIRE PROJECT LIMITS.

SURFACE PLACEMENT - ONE PASS PER LANE

NO S.E. CORRECTION

ASPHALT FACTORS		
	COMBINED FACTOR	% AC
SP125C (PG76-22)	1.995 TONS/CY	5.2
TACK COAT		
MILLING	0.10 GAL/SY	

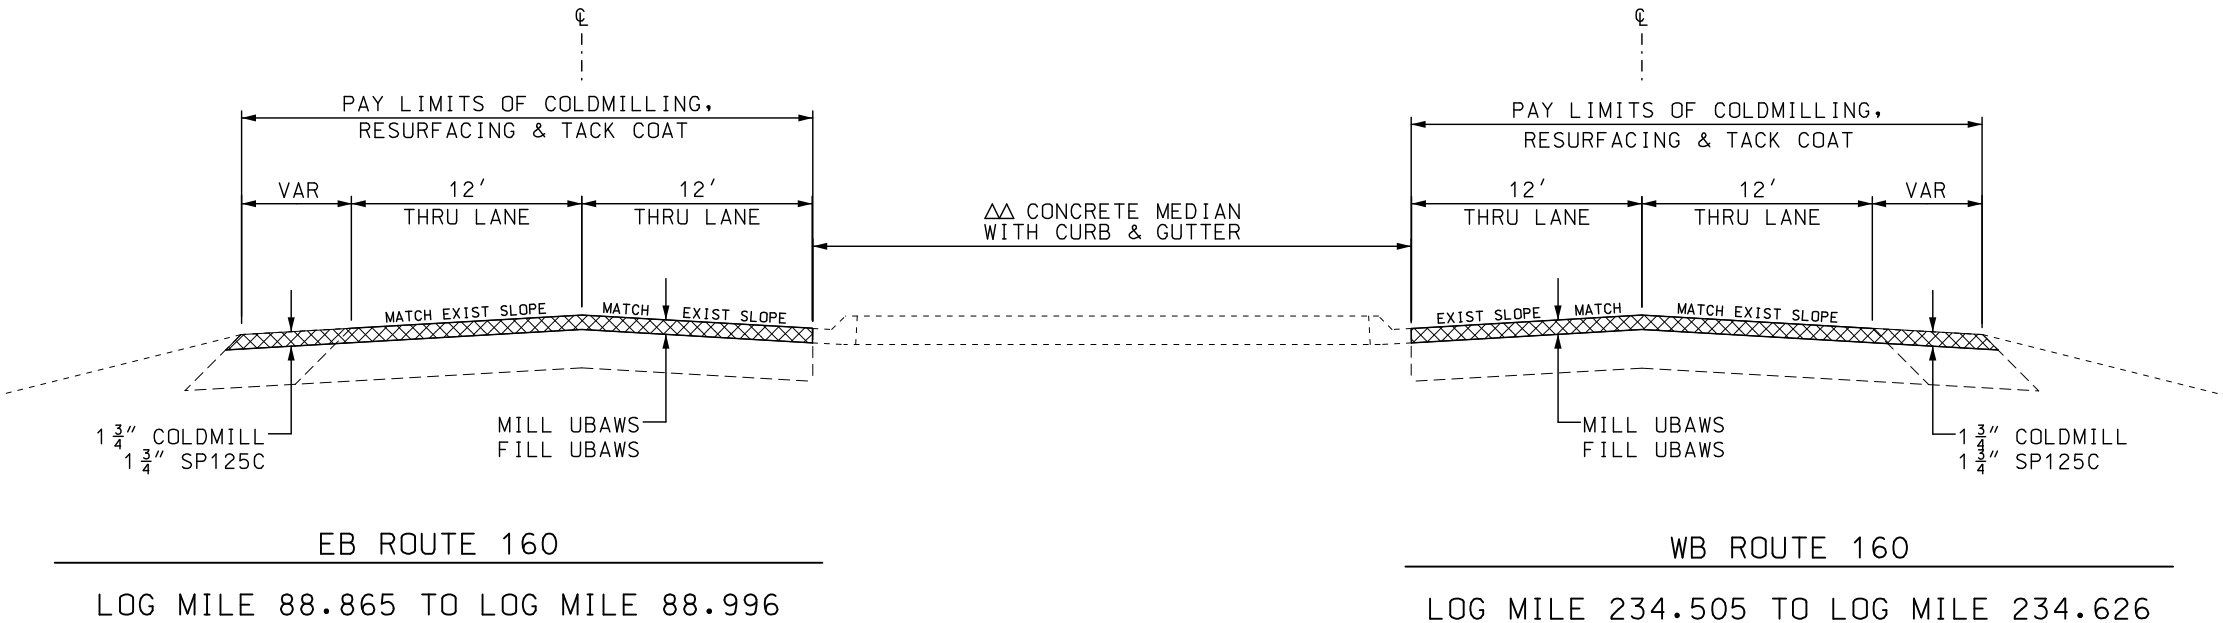

BEGIN LOG MILE	END LOG MILE	LENGTH (FT)	LT TURN LANE WIDTH (FT)	MAINLINE WIDTH (FT)	RT TURN LANE WIDTH (FT)	OT SHLDR WIDTH (FT)	COLD MILLING 3" THICK OR LESS (SQYD)	TACK 0.1 GAL/SY (GAL)	1.75"SP125C (PG76-22) 1.995 TONS/CY (TONS)	FOG SEAL SHLDR 0.1 GAL/SY** (GAL)	TYPE-C UBAWS (SY)	REMARKS
88.865	88.996	692		24		10	1845.33	185	24.50		1501.0	UBAWS MAINLINE & SP125C SHOULDER
88.996	89.220	1183										EXCEPT OUT INTERSECTION IMPROVEMENTS ON J8P3087D
89.220	91.128	10074		26			29102.67	2910	2822.35			MAINLINE RESURFACE
91.128	91.143	79										EXCEPT OUT CHESTNUT EXPRESSWAY
91.143	92.235	5766		24		10	15376.00	1538	1491.15	640.7		MAINLINE & SHOULDER RESURFACE
92.235	92.292	301										EXCEPT OUT BRIDGE A5862
92.292	93.145	4504		24		10	12010.67	1201	1164.78	500.4		MAINLINE & SHOULDER RESURFACE
US 160 EASTBOUND TURN LANE QUANTITIES												
88.870	88.920	264			12		352.00	35.2			352.0	I-44 RAMP TO US160 ACCEL LANE
88.920	88.939	100			VAR		7.41	0.7			7.4	I-44 RAMP TO US160 ACCEL LANE TAPER
89.408	89.424	84	VAR				6.22	0.6	0.60			BERRY TRACTOR DECEL LANE TAPER
89.424	89.485	322	12				429.33	42.9	41.64			BERRY TRACTOR DECEL LANE
89.523	89.551	148	VAR				10.96	1.1	1.06			CALHOUN TRUCKING DECEL LANE TAPER
89.551	89.618	354	12				472.00	47.2	45.77			CALHOUN TRUCKING DECEL LANE
89.660	89.683	121	VAR				8.96	0.9	0.87			TRANSPORT GRAPHICS DECEL LANE TAPER
89.683	89.741	306	12				408.00	40.8	39.57			TRANSPORT GRAPHICS DECEL LANE
89.780	89.805	132	VAR				9.78	1.0	0.95			COMMERCIAL ST DECEL LANE TAPER
89.805	89.865	317	12				422.67	42.3	40.99			COMMERCIAL ST DECEL LANE
89.909	89.934	132	VAR				9.78	1.0	0.95			BAYLESS SALVAGE DECEL LANE TAPER
89.934	89.995	322	12				429.33	42.9	41.64			BAYLESS SALVAGE DECEL LANE
90.032	90.060	148	VAR				10.96	1.1	1.06			EB DIVISION ST DECEL LANE TAPER
90.060	90.125	343	12				457.33	45.7	44.35			EB DIVISION ST DECEL LANE
90.055	90.076	111			VAR		8.22	0.8	0.80			WB DIVISION ST DECEL LANE TAPER
90.076	90.112	190			12		253.33	25.3	24.57			WB DIVISION ST DECEL LANE
90.126	90.145	100			VAR		7.41	0.7	0.72			EB DIVISION ST TO US160 ACCEL LANE
90.184	90.209	132	VAR				9.78	1.0	0.95			DEMORE ENT. DECEL LANE TAPER
90.209	90.263	285	12				380.00	38.0	36.85			DEMORE ENT. DECEL LANE
90.435	90.458	121	VAR				8.96	0.9	0.87			P&E ENT. DECEL LANE TAPER
90.458	90.517	312	12				416.00	41.6	40.34			P&E ENT. DECEL LANE
90.546	90.569	121	VAR				8.96	0.9	0.87			EB NICHOLS ST DECEL LANE TAPER
90.569	90.628	312	12				416.00	41.6	40.34			EB NICHOLS ST DECEL LANE
90.732	90.750	95	VAR				7.04	0.7	0.68			SAFETY-KLEEN DECEL LANE TAPER
90.750	90.811	322	12				429.33	42.9	41.64			SAFETY-KLEEN DECEL LANE
90.893	90.913	106	VAR				7.85	0.8	0.76			EB WADDILL ST DECEL LANE TAPER
90.913	90.975	327	12				436.00	43.6	42.28			EB WADDILL ST DECEL LANE
91.012	91.063	269	VAR				19.93	2.0	1.93			EB CHESTNUT EXPY DECEL LANE TAPER
91.063	91.137	391	24				1042.67	104.3	101.12			EB CHESTNUT EXPY DECEL LANES
91.073	91.083	53			VAR		3.93	0.4	0.38			WB CHESTNUT EXPY DECEL LANE TAPER
91.083	91.115	169			12		225.33	22.5	21.85			WB CHESTNUT EXPY DECEL LANE
91.139	91.158	100	VAR				7.41	0.7	0.72			EB CHESTNUT TO US160 ACCEL LANE
91.262	91.281	100	VAR				7.41	0.7	0.72			EB COLLEGE ST DECEL LANE TAPER
91.281	91.338	301	12				401.33	40.1	38.92			EB COLLEGE ST DECEL LANE
91.561	91.585	127	VAR				9.41	0.9	0.91			EB MOUNT VERNON ST DECEL LANE TAPER
91.585	91.637	275	12				366.67	36.7	35.56			EB MOUNT VERNON ST DECEL LANE
91.718	91.742	127			VAR		9.41	0.9	0.91			WB STATE ST DECEL LANE TAPER
91.742	91.779	195			12		260.00	26.0	25.21			WB STATE ST DECEL LANE
92.060	92.081	111	VAR				8.22	0.8	0.80			EB GRAND ST DECEL LANE TAPER
92.081	92.137	296	12				394.67	39.5	38.27			EB GRAND ST DECEL LANE
92.315	92.333	95	VAR				7.04	0.7	0.68			EB FR142 DECEL LANE TAPER
92.333	92.389	296	12				394.67	39.5	38.27			EB FR142 DECEL LANE
92.568	92.593	132	VAR				9.78	1.0	0.95			EB FR146 DECEL LANE TAPER
92.593	92.649	296	12				394.67	39.5	38.27			EB FR146 DECEL LANE
92.993	93.040	248	VAR				18.37	1.8	1.78			EB SUNSHINE ST DECEL LANE TAPER
93.040	93.132	486	24				1296.00	129.6	125.69			EB SUNSHINE ST DECEL LANES
93.040	93.069	153			VAR		11.33	1.1	1.10			WB SUNSHINE ST DECEL LANE TAPER
93.069	93.131	327			12		436.00	43.6	42.28			WB SUNSHINE ST DECEL LANE
88.865	93.145	22598							320.99			75 TONS/MILE FOR IRREGULARITIES
**APPLY SHOULDER FOG SEAL AT 0.2 GAL/SY DILLUTED TO 50%						SUBTOTAL	69082.53	6908.50	6831.2	1141.1	1860.40	
SEE WB PAVING FOR PROJECT PAVING TOTALS												

SUMMARY OF QUANT
SHEET 1 OF 4

MGS GUARDRAIL									
BEGIN LOG MILE	END LOG MILE	LOCATION	REMOVALS (FT)	SHAPING SLOPES CLASS III (STA)	MASH END TERMINAL (EA)	MGS END ANCHOR (EA)	BRIDGE APPROACH TRANSITION (EA)	MGS GUARDRAIL 8' POSTS 6'3" SPACING (LF)	REMARKS
EASTBOUND									
91.280	91.320	RT	211	2.1	1	1		162.5	SLOPE PROTECTION AFTER MCDONALD'S ENTRANCE
91.516	91.615	RT	523	5.2	1	1		475	SLOPE PROTECTION BEFORE MOUNT VERNON ST
92.135	92.231	RT	507	5.1	1		1	425	BEFORE BRIDGE A5861
92.266	92.287	RT	111	1.1	1		1	25	AFTER BRIDGE A5861
WESTBOUND									
231.169	231.219	RT	264	2.6	1		1	187.5	BEFORE BRIDGE A5862
231.258	231.360	RT	539	5.4	1		1	462.5	AFTER BRIDGE A5862
231.874	231.935	RT	322	3.2	1	1		275	SLOPE PROTECTION AFTER MOUNT VERNON ST
232.823	232.850	RT	143	1.4	1	1		87.5	DITCH PROTECTION BEFORE NICHOLS ST
			TOTAL	2,620	26.1	8	4	2,100.0	
			USE	SEE REMOVALS	26	8	4	2,100	
REMOVAL OF IMPROVEMENTS PAID AS LUMP SUM, BUT SHOWN IN LINEAR FEET FOR CLARITY EROSION CONTROL AND SEEDING INCIDENTAL TO SHAPING SLOPES CLASS III									

CONTRACTOR FURNISHED SURVEYING AND STAKING
1 LUMP SUM


MOBILIZATION
1 LUMP SUM

REMOVAL OF IMPROVEMENTS
REMARKS
2620 LF GUARDRAIL
1 LUMP SUM

RADAR DETECTION		
LOG MILE	INTERSECTION (LUMP SUM)	REMARKS/LOCATION
EASTBOUND		
90.628	1	US160 @ NICHOLS STREET
91.128	1	US160 @ CHESTNUT EXPRESSWAY
91.633	1	US160 @ MOUNT VERNON STREET
93.143	1	US160 @ SUNSHINE STREET
TOTAL	4	

PERMANENT AGGREGATE EDGE TREATMENT					
BEGIN LOG MILE	END LOG MILE	LOCATION	PAVEMENT EDGE TREATMENT (LF)	MC-800 PRIME 0.1 GAL/SY (GAL)	REMARKS
88.865	88.996	EASTBOUND	691.7	15.0	TRIANGLE 2' WIDE 4" TALL
91.143	92.235	EASTBOUND	5765.8	128.0	TRIANGLE 2' WIDE 4" TALL
92.292	93.145	EASTBOUND	4503.8	100.0	TRIANGLE 2' WIDE 4" TALL
230.352	231.204	WESTBOUND	4498.6	100.0	TRIANGLE 2' WIDE 4" TALL
231.261	232.350	WESTBOUND	5749.9	128.0	TRIANGLE 2' WIDE 4" TALL
234.505	234.626	WESTBOUND	638.9	14.0	TRIANGLE 2' WIDE 4" TALL
			TOTAL	21848.7	485.0
			USE	21849	485
SEE PERMANENT AGGREGATE EDGE TREATMENT JSP AGGREGATE ESTIMATED AT 1.84 TONS PER CUBIC YARD					

HIGH BUILD WATERBORNE PAVEMENT MARKING PAINT, TYPE L BEADS							
BEGIN LOG MILE	END LOG MILE	LENGTH (FT)	6" WHITE TYPE L (LF)	6" YELLOW TYPE L (LF)	TYPE 2 LT/RT ARROW (EA)	12" STOP BAR (LF)	REMARKS
88.865	88.996	692	865.0	692.0		24	EASTBOUND MAINLINE STRIPING
89.220	91.128	10074	2518.5	180.0		72	EASTBOUND MAINLINE STRIPING
91.143	93.145	10571	13213.8			48	EASTBOUND MAINLINE STRIPING
230.350	232.350	10560	13200.0			48	WESTBOUND MAINLINE STRIPING
232.369	234.279	10085	2521.3	180.0		48	WESTBOUND MAINLINE STRIPING
234.505	234.626	639	639.0	639.0		24	WESTBOUND MAINLINE STRIPING
VAR	VAR	6167	6167.0		51	84	EASTBOUND TURN LANES
VAR	VAR	4954	4954.0		47	60	WESTBOUND TURN LANES
			TOTAL	44078.6	1691.0	98	408
			USE	44079	1691	98	408

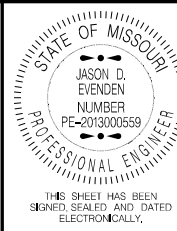

DATE PREPARED 8/5/2021	
ROUTE 160	STATE MO
DISTRICT SW	SHEET NO. 3

COUNTY GREENE
JOB NO. J8P3170
CONTRACT ID.

PROJECT NO.

BRIDGE NO.

DESCRIPTION	DATE						

MISSOURI HIGHWAYS AND TRANSPORTATION COMMISSION



105 WEST CAPITOL
JEFFERSON CITY, MO 65102
1-888-ASK-MODOT (1-888-275-6636)

IF A SEAL IS PRESENT ON THIS SHEET IT HAS BEEN ELECTRONICALLY SEALED AND DATED.


ROUTE 160	STATE MO
DISTRICT SW	SHEET NO. 3

JOB NO.
J8P3170

CONTRACT ID.

PROJECT NO.

 BRIDGE NO.

[illegible]


MISSOURI HIGHWAYS AND TRANSPORTATION
COMMISSION

105 WEST CAPITAL
JEFFERSON CITY, MO 65102
TEL: 1-888-ASK-MOHDOT / 1-888-275-6363

SIGN	SIZE IN.	AREA SQ.FT.	QTY EACH	TOTAL SQ.FT.	QTY EACH	TOTAL SQ.FT.	SIGN NUM.	
GUIDE SIGNS								DESCRIPTION
E05-1	36X48	12.00						GORE EXIT
E05-2	48X36	12.00						EXIT OPEN
E05-2a	48X36	12.00						EXIT CLOSED
G020-1	60X24	10.00	4	40.00				ROAD WORK NEXT XX MILES
G020-2	48X24	8.00	2	16.00				END ROAD WORK
G020-4	36X18	4.50						PILOT CAR FOLLOW ME
G020-4a	42X30	8.75						PILOT CAR IN USE WAIT & FOLLOW
G020-4a	18X12	1.50						PILOT CAR IN USE WAIT & FOLLOW
G020-5aP	36X24	6.00						WORK ZONE (PLAQUE)
M04-8a	24X18	3.00						END DETOUR
M04-9L	48X36	12.00						DETOUR (LEFT ARROW)
M04-9R	48X36	12.00						DETOUR (RIGHT ARROW)
M04-9P	48X12	4.00						STREET NAME (PLAQUE)
M04-10L	48X18	6.00						DETOUR (ARROW LEFT)
M04-10R	48X18	6.00						DETOUR (ARROW RIGHT)
REGULATORY SIGNS								
R1-1	48X48	13.25						STOP
R1-2	48TRI.	6.93						YIELD
R1-2a	36X36	9.00						TO ONCOMING TRAFFIC (PLAQUE)
R1-3P	30X12	2.50						ALL WAY (PLAQUE)
R2-1	36X48	12.00	2	24.00				SPEED LIMIT 50
R3-1	48X48	16.00						NO RIGHT TURN (SYMBOL)
R3-2	48X48	16.00						NO LEFT TURN (SYMBOL)
R3-3	36X36	9.00						NO TURNS
R3-4	48X48	16.00						NO U-TURN (SYMBOL)
R3-7L	30X30	6.25	8	50.00				LEFT LANE MUST TURN LEFT
R3-7R	30X30	6.25						RIGHT LANE MUST TURN RIGHT
R4-1	36X48	12.00						DO NOT PASS
R4-2	36X48	12.00						PASS WITH CARE
R4-8a	36X48	12.00						KEEP LEFT (HORIZONTAL ARROW)
R4-7a	36X48	12.00						KEEP RIGHT (HORIZONTAL ARROW)
R5-1	30X30	6.25						DO NOT ENTER
R5-1a	36X24	6.00						WRONG WAY
R6-1L	54X18	6.75						ONE WAY ARROW (LEFT)
R6-1R	54X18	6.75						ONE WAY ARROW (RIGHT)
R6-2L	24X30	5.00						ONE WAY (LEFT)
R6-2R	24X30	5.00						ONE WAY (RIGHT)
R9-9	24X12	2.00						SIDEWALK CLOSED
R9-11L	24X18	3.00						SIDEWALK CLOSED AHEAD, (ARROW LEFT) CROSS HERE
R9-11R	24X18	3.00						SIDEWALK CLOSED AHEAD, (ARROW RIGHT) CROSS HERE
R10-6	24X36	6.00						STOP HERE ON RED (45° ARROW)
R11-2	48X30	10.00						ROAD CLOSED
R11-3a	60X30	12.50						ROAD CLOSED XX MILES AHEAD LOCAL TRAFFIC ONLY
R11-4	60X30	12.50						ROAD CLOSED TO THRU TRAFFIC
CONST-3A	60X48	20.00						FINE SIGN
CONST-3X	56X12	4.67						SPEEDING/PASSING (PLATE)
MISCELLANEOUS SIGNS								
CONST-5	48X36	12.00						POINT OF PRESENCE
CONST-5	96X48	32.00	2	64.00				POINT OF PRESENCE
CONST-7	48X24	8.00						RATE OUR WORK ZONE
CONST-7	72X36	18.00	2	36.00				RATE OUR WORK ZONE
CONST-8	48X36	12.00	4	48.00				WORK ZONE NO PHONE ZONE
616-10.05 CONSTRUCTION SIGNS				TOTAL 1251				
616-10.10 RELOCATED SIGNS					TOTAL 0			

ITEM NUMBER	TOTAL QTY	DESCRIPTION
6122008		IMPACT ATTENUATOR 40 MPH (SAND BARRELS)
6122009		IMPACT ATTENUATOR 45 MPH (SAND BARRELS)
6122010		IMPACT ATTENUATOR 50 MPH (SAND BARRELS)
6122012		IMPACT ATTENUATOR 55 MPH (SAND BARRELS)
6122014		IMPACT ATTENUATOR 60 MPH (SAND BARRELS)
6122017		IMPACT ATTENUATOR 65 MPH (SAND BARRELS)
6122019		IMPACT ATTENUATOR 70 MPH (SAND BARRELS)
6122020		REPLACEMENT SAND BARREL
6122030		IMPACT ATTENUATOR (RELOCATION)
6123000A	2	TRUCK OR TRAILER MOUNTED ATTENUATOR (TMA)
6161008	4	ADVANCED WARNING RAIL SYSTEM
6161012		BUOYS (BOATS KEEP OUT)
6161013		BUOYS (NO WAKE)
6161014		SPECIAL SIGN ASSEMBLY (BOATS KEEP OUT)
6161025	100	CHANNELIZER (TRIM LINE)
6161030	2	TYPE III MOVEABLE BARRICADE
6161033		DIRECTION INDICATOR BARRICADE
6161040	2	FLASHING ARROW PANEL
6161047		TYPE III OBJECT MARKER
6161051		WARNING LIGHT, TYPE A
6161052		WARNING LIGHT, TYPE B
6161053		WARNING LIGHT, TYPE C
6161055		SEQUENTIAL FLASHING WARNING LIGHT
6161070		TUBULAR MARKER
6161095		RADAR SPEED ADVISORY SYSTEM
6161096		CHANGEABLE MESSAGE SIGN, COMMISSION FURNISHED/RETAINED
6161098A		CHANGEABLE MESSAGE SIGN W/O COMM. INTERFACE, CONTRACTOR FURNISHED/RETAINED
6161099	2	CHANGEABLE MESSAGE SIGN WITH COMM. INTERFACE, CONTRACTOR FURNISHED/RETAINED
6162000A		WORK ZONE TRAFFIC SIGNAL SYSTEM
6162002		TEMPORARY LONG-TERM RUMBLE STRIPS
6162004		TEMPORARY SHORT-TERM RUMBLE STRIPS
6173600D		TEMPORARY TRAFFIC BARRIER CONTRACTOR FURNISHED/RETAINED
6173602B		TEMPORARY TRAFFIC BARRIER CONTRACTOR FURNISHED/COMMISSION RETAINED
6174000A		TEMP. TRAFFIC BARRIER HEIGHT TRANSITION
6175010A		RELOCATING TEMPORARY TRAFFIC BARRIER
6176000B		TEMPORARY TRAFFIC BARRIER COMMISSION FURNISHED/RETAINED
6177000B		TEMP. TRAFFIC BARRIER HEIGHT TRANSITION COMMISSION FURNISHED/RETAINED
6208064A		TEMPORARY RAISED PAVEMENT MARKER
9029400		

SUMMARY OF QUANTITIES
SHEET 4 OF 4

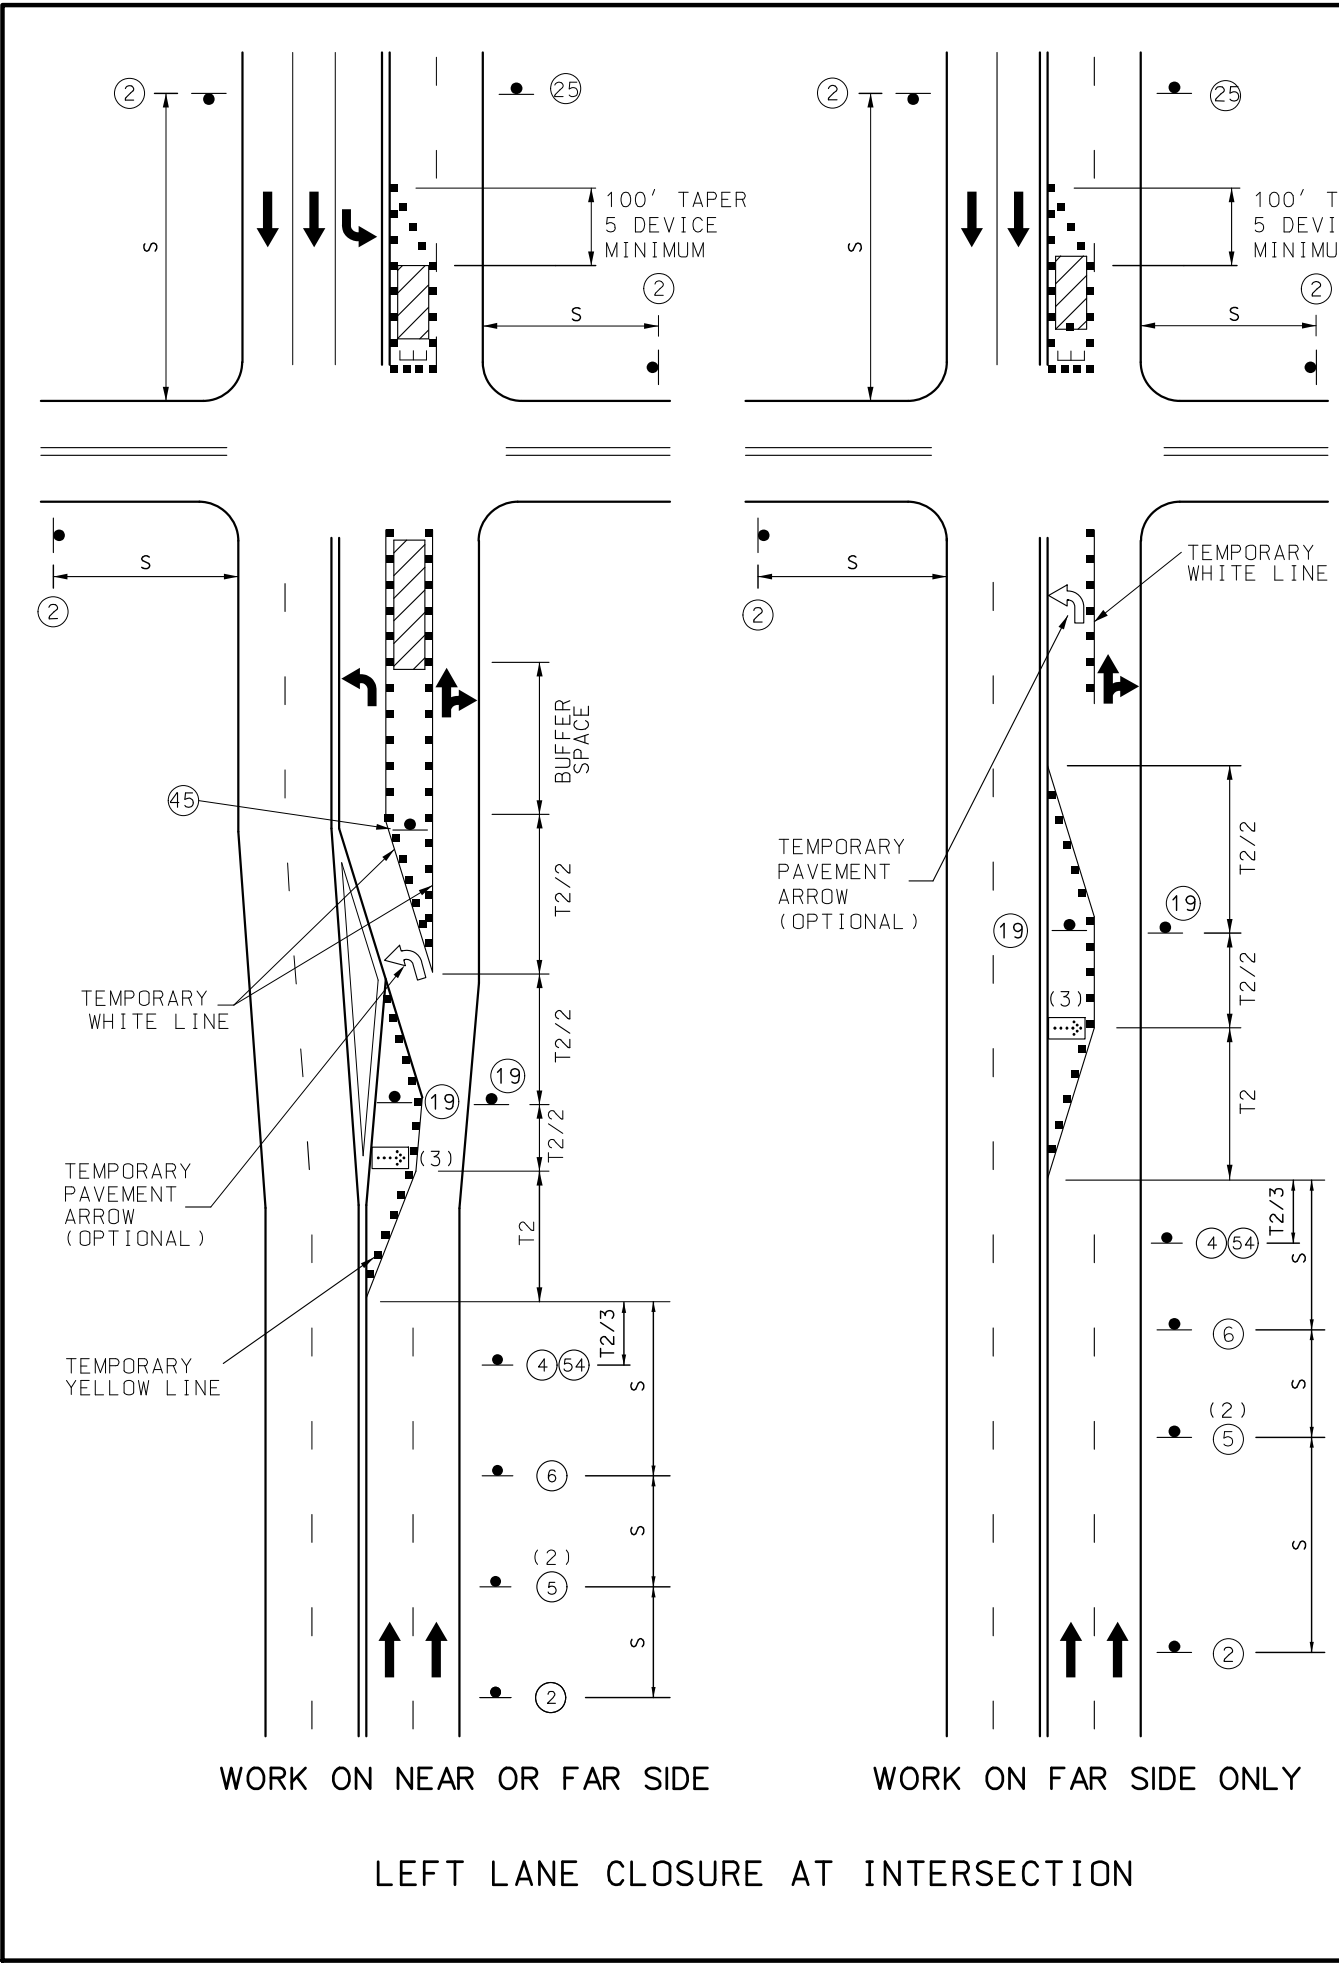

ROAD WORK AHEAD
W020-1
(2)

SPEED LIMIT 40 OR **SPEED LIMIT 40**
R2-1
(4)

CENTER LANE CLOSED AHEAD
W020-5
(5)

RIGHT LANE CLOSED
W020-6a
(6)

LEFT LANE MUST TURN LEFT
R3-7L
(19)

SPEED LIMIT 45 OR **SPEED LIMIT 50**
(NORMAL SPEED)
R2-1
(25)

LEFT LANE CLOSED AHEAD
W012-1
(45)

WORK ZONE
G020-5aP
(54)

SPEED LIMIT ¹ , MPH	TAPER LENGTH ² , FT		CHANNELIZING SPACING ³ , FT		BUFFER LENGTH, FT
	SHOULDER ⁴ (T1)	LANE ⁵ (T2)	TAPERS	BUFFER/WORK AREA	
0-35	70	245	35 ⁶	40 ⁶	280
40-45	150	540	40 ⁶	80 ⁶	400
50-55	185	660	50 ⁷	80 ⁷	560
60-70	235	840	60 ⁷	120 ⁷	840

SPEED LIMIT ¹ , MPH	SIGN SPACING ² , FT (S)	
	UNDIVIDED HIGHWAY	DIVIDED HIGHWAY
0-35	200 ³	200 ³
40-45	350	500
50-55	500	1000
60-70	1000	SA-1000 SB-1500 SC-2640

NOTES:

REVISED: 5-19-2020

FOR SIGNALIZED INTERSECTIONS, ADJUSTMENTS MAY NEED TO BE MADE TO SIGNAL PHASING, TIMING, INDICATIONS OR DETECTOR SETTINGS.

REMOVE AND/OR MODIFY EXISTING PAVEMENT MARKING AS NEEDED.

PAVEMENT MARKING AND BARRICADES OPTIONAL FOR SHORT TERM OPERATIONS.

TEMPORARY PAVEMENT MARKING REQUIRED WITH LONG TERM LANE CLOSURES.

FOR SHORT TERM OPERATIONS, WHERE IT IS NOT FEASIBLE TO MODIFY PAVEMENT MARKING, A 10' DEVICE SPACING IS USED WHERE TRAFFIC IS GUIDED ACROSS DOUBLE YELLOW LINES OR OTHER CONFLICTING PAVEMENT MARKING. ALL OTHER SPACINGS ARE ONE HALF OF THE SPACING SHOWN IN TABLE.

(1) CONES ALLOWABLE FOR DAYLIGHT OPERATIONS ONLY.

(2) SIGN 5 MAY BE OMITTED IN LOW SPEED URBAN AREAS WHERE THERE IS NOT SUFFICIENT SPACE FOR THE FULL SIGN SERIES.

(3) THE FLASHING ARROW BOARD SHOULD BE LOCATED AT THE BEGINNING OF THE MERGING TAPER WHEN MEDIAN WIDTH ALLOWS ROOM.

LEGEND

- SIGN (SINGLE SIDED)
- SIGN (DOUBLE SIDED)
- FLAGGER
- CHANNELIZER (TRIM-LINE)
- FLASHING ARROW PANEL
- OPTIONAL - ATTENUATOR TRUCK WITH FLASHING ARROW PANEL IN CAUTION MODE W/ 150' ROLL AHEAD SPACE
- ▲ DIRECTIONAL BARRICADE
- TYPE 3 MOVEABLE BARRICADE

¹POSTED SPEED LIMIT.

²TAPER LENGTHS MAY BE ADJUSTED.

³SPACING MAY BE ADJUSTED FOR FIELD CONDITIONS.

⁴BASED ON 10 FT SHOULDER WIDTH.

⁵BASED ON 12 FT LANE WIDTH.

⁶SPACING REDUCED TO 1/2 AT INTERSECTIONS.

⁷SPACING MAY BE REDUCED TO 1/2 AT INTERSECTIONS.

STATE OF MISSOURI
JASON D. EVENDEN
NUMBER
PE-2013000659
PROFESSIONAL ENGINEER

THIS SHEET HAS BEEN
SIGNED, SEALED AND DATED
ELECTRONICALLY.

DATE PREPARED
8/3/2021

ROUTE
160

STATE
MO

DISTRICT
SW

SHEET NO.
6

COUNTY
GREENE

JOB NO.
J8P3170

CONTRACT ID.

PROJECT NO.

 

BRIDGE NO.

DESCRIPTION


DATE

MISSOURI HIGHWAYS AND TRANSPORTATION
COMMISSION



105 WEST CAPITOL
JEFFERSON CITY, MO 65102
1-888-ASK-MODOT (1-888-275-6636)

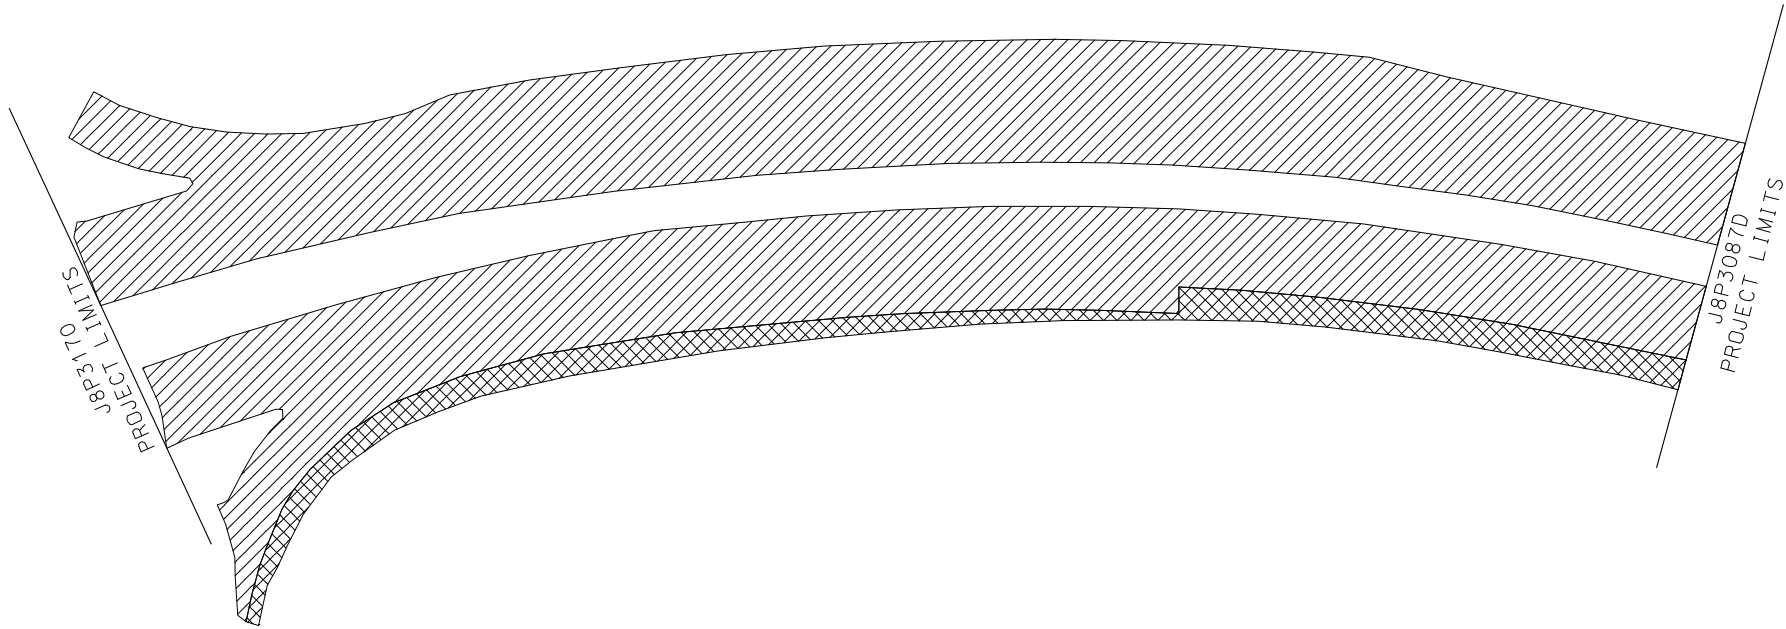

- MILL & FILL UBAWS

 

- MILL & FILL 1.75" SP125C

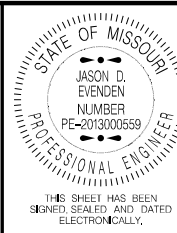 

DATE PREPARED 8/3/2021	
ROUTE 160	STATE MO
DISTRICT SW	SHEET NO. 7
COUNTY GREENE	
JOB NO. J8P3170	
CONTRACT ID.	
PROJECT NO.	
BRIDGE NO.	

DATE	DESCRIPTION

MISSOURI HIGHWAYS AND TRANSPORTATION
COMMISSION



105 WEST CAPITOL
JEFFERSON CITY, MO 65102
1-888-ASK-MODOT (1-888-275-6636)

IF A SEAL IS PRESENT ON THIS SHEET IT HAS BEEN ELECTRONICALLY SEALED AND DATED.

DESIGN DESIGNATION

A.A.D.T. - 2022 = 9,277 (EB)
9,276 (WB)
T = 9.06%
V = 50 M.P.H.

FUNCTIONAL CLASSIFICATION- EXPRESSWAY

NO NEW R/W REQUIRED

CONVENTIONAL SYMBOLS
(USED IN PLANS)

	EXISTING	NEW
BUILDINGS AND STRUCTURES		
GUARD RAIL		
GUARD CABLE		
CONCRETE RIGHT-OF-WAY MARKER		
STEEL RIGHT-OF-WAY MARKER		
LOCATION SURVEY MARKER		
UTILITIES		
FIBER OPTICS	-FO-	-FO-
OVERHEAD CABLE TV	-OTV-	-OTV-
UNDERGROUND CABLE TV	-UTV-	-UTV-
OVERHEAD TELEPHONE	-OT-	-OT-
UNDERGROUND TELEPHONE	-UT-	-UT-
OVERHEAD POWER	-OE-	-OE-
UNDERGROUND POWER	-UE-	-UE-
SANITARY SEWER	-S-	-S-
STORM SEWER	-SS-	-SS-
GAS	-G-	-G-
WATER	-W-	-W-
MANHOLE		
FIRE HYDRANT		
WATER VALVE		
WATER METER		
DROP INLET		
DITCH BLOCK		
GROUND MOUNTED SIGN		
LIGHT POLE		
H-FRAME POWER POLE		
TELEPHONE PEDESTAL		
FENCE		
CHAIN LINK		
WOVEN WIRE		
GATE POST		
BENCHMARK		

NOTE: DASHED OR OPEN SYMBOLS INDICATE EXISTING FEATURES

MISSOURI HIGHWAYS AND TRANSPORTATION COMMISSION
PLANS FOR PROPOSED
STATE HIGHWAY
GREENE COUNTY

REVISED: 4-16-2020



KEY MAP
SHOWING LOCATION OF GREENE COUNTY

1 3/4" SP125C MILL AND FILL

& FOG SEAL
SHOULDER


BEGINNING OF
PROJECT

EB LOG MILE
93.163

END OF PROJECT

EB LOG MILE
95.336

RADAR DETECTORS AT
BATTLEFIELD RD. AND
FARM ROAD 156

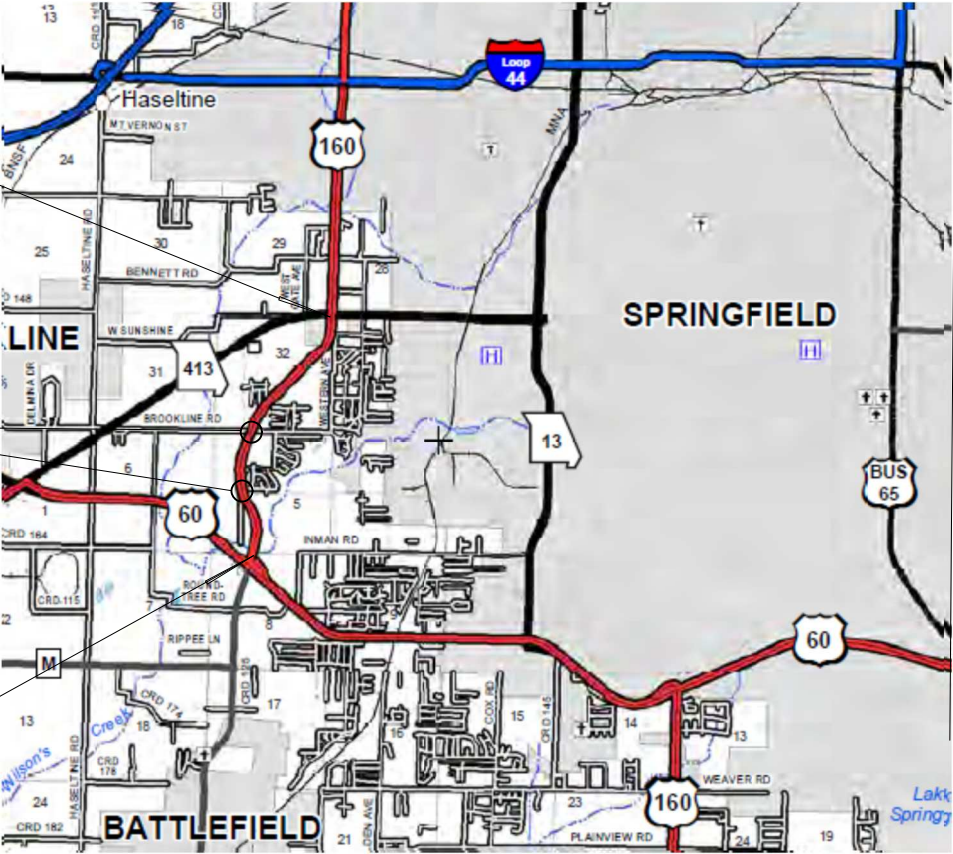

NOT TO SCALE

THE EXISTENCE AND APPROXIMATE LOCATION OF UTILITY FACILITIES KNOWN TO EXIST, AS SHOWN ON THE PLANS, ARE BASED ON THE BEST INFORMATION AVAILABLE TO THE COMMISSION AT THIS TIME. THIS INFORMATION IS PROVIDED BY THE COMMISSION "AS-IS" AND THE COMMISSION EXPRESSLY DISCLAIMS ANY REPRESENTATION OR WARRANTY AS TO THE COMPLETENESS, ACCURACY, OR SUITABILITY OF THE INFORMATION FOR ANY USE. RELIANCE UPON THIS INFORMATION IS DONE AT THE RISK AND PERIL OF THE USER, AND THE COMMISSION SHALL NOT BE LIABLE FOR ANY DAMAGES THAT MAY ARISE FROM ANY ERROR IN THE INFORMATION. IT IS, THEREFORE, THE RESPONSIBILITY OF THE CONTRACTOR TO VERIFY THE EXISTENCE, LOCATION AND STATUS OF ANY FACILITY. SUCH VERIFICATION INCLUDES DIRECT CONTACT WITH THE LISTED UTILITIES.

INDEX OF SHEETS

DESCRIPTION	SHEET NUMBER
TITLE SHEET -----	1
TYPICAL SECTIONS (TS) (2 SHEETS)---	2
QUANTITIES (QU) (3 SHEETS)-----	3
SPECIAL SHEETS (SS)-----	4-6
TRAFFIC CONTROL SHEETS (TC)-----	7-11



DATE PREPARED 8/5/2021	STATE MO
ROUTE 160	DISTRICT SW
JOB NO. J8S3168	SHEET NO. 1
CONTRACT ID.	

PROJECT NO.
BRIDGE NO.

DESCRIPTION	DATE

LENGTH OF PROJECT

LOG MILES FROM 2019 ARAN

BEGINNING OF PROJECT	LM 93.163
END OF PROJECT	LM 95.336
APPARENT LENGTH	11473 FEET
EQUATIONS AND EXCEPTIONS:	NONE


TOTAL CORRECTIONS	0.000 FEET
NET LENGTH OF PROJECT	11473 FEET
STATE LENGTH	2.173 MILES

FOR INFORMATION ONLY
ESTIMATED DISTURBED ACRES 0.0 ACRES

MISSOURI HIGHWAYS AND TRANSPORTATION COMMISSION

105 WEST CAPITOL
JEFFERSON CITY, MO 65102
1-888-ASK-MODOT (1-888-275-6636)

IF A SEAL IS PRESENT ON THIS SHEET IT HAS BEEN ELECTRONICALLY SEALED AND DATED.

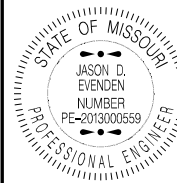

THIS SHEET HAS BEEN
SIGNED, SEALED AND DATED
ELECTRONICALLY.

DATE PREPARED
8/5/2021

ROUTE 160 STATE MO

DISTRICT SW SHEET NO. 2

COUNTY GREENE


JOB NO. J8S3168

CONTRACT ID.

PROJECT NO.

BRIDGE NO.

IF A SEAL IS PRESENT ON THIS SHEET IT HAS BEEN ELECTRONICALLY SEALED AND DATED.

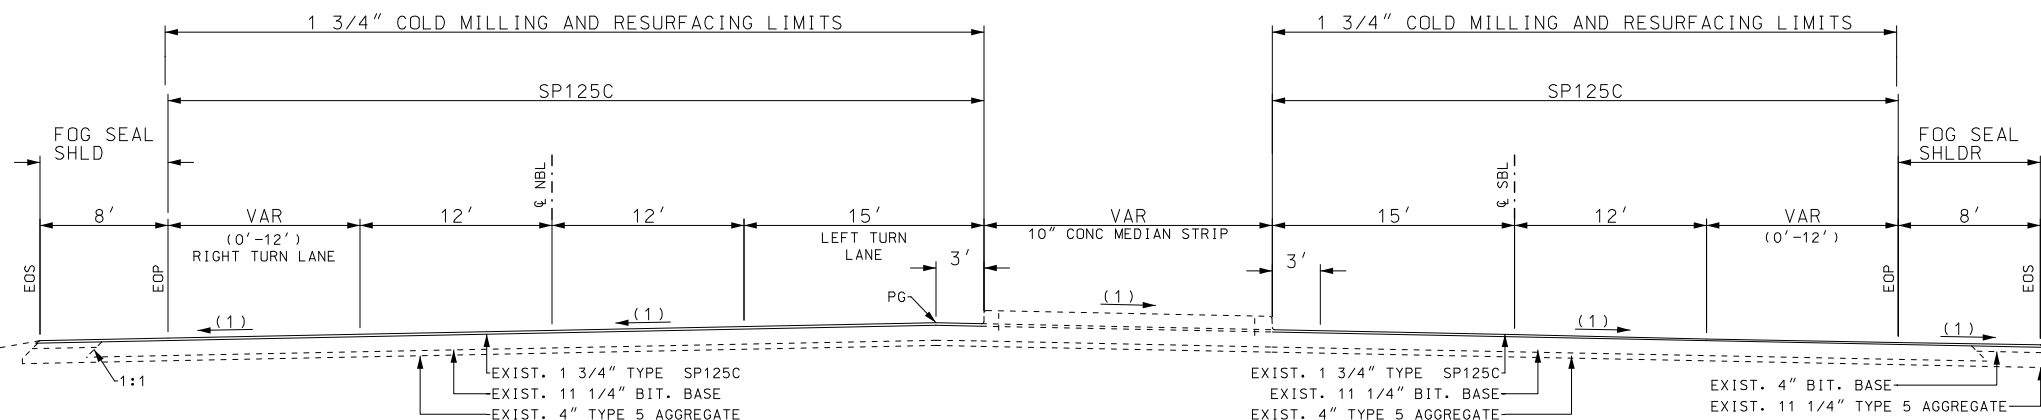


SECTION ON TANGENT
TYPICAL SECTION ROUTE 160

WESTBOUND LANES
LOG MILE 230.336 - LOG MILE 229.939

EASTBOUND LANES
LOG MILE 93.163 - LOG MILE 93.215

ESTIMATE FACTORS		
	ASPH. FACTOR	% AC
SP125C (PG 70-22)	1.975 TONS/C.Y.	4.8
FOG SEAL	0.2 GAL/SY	
TACK EST. @	0.10 GAL/SY	
IRREGULARITIES: 75 TONS/MI		

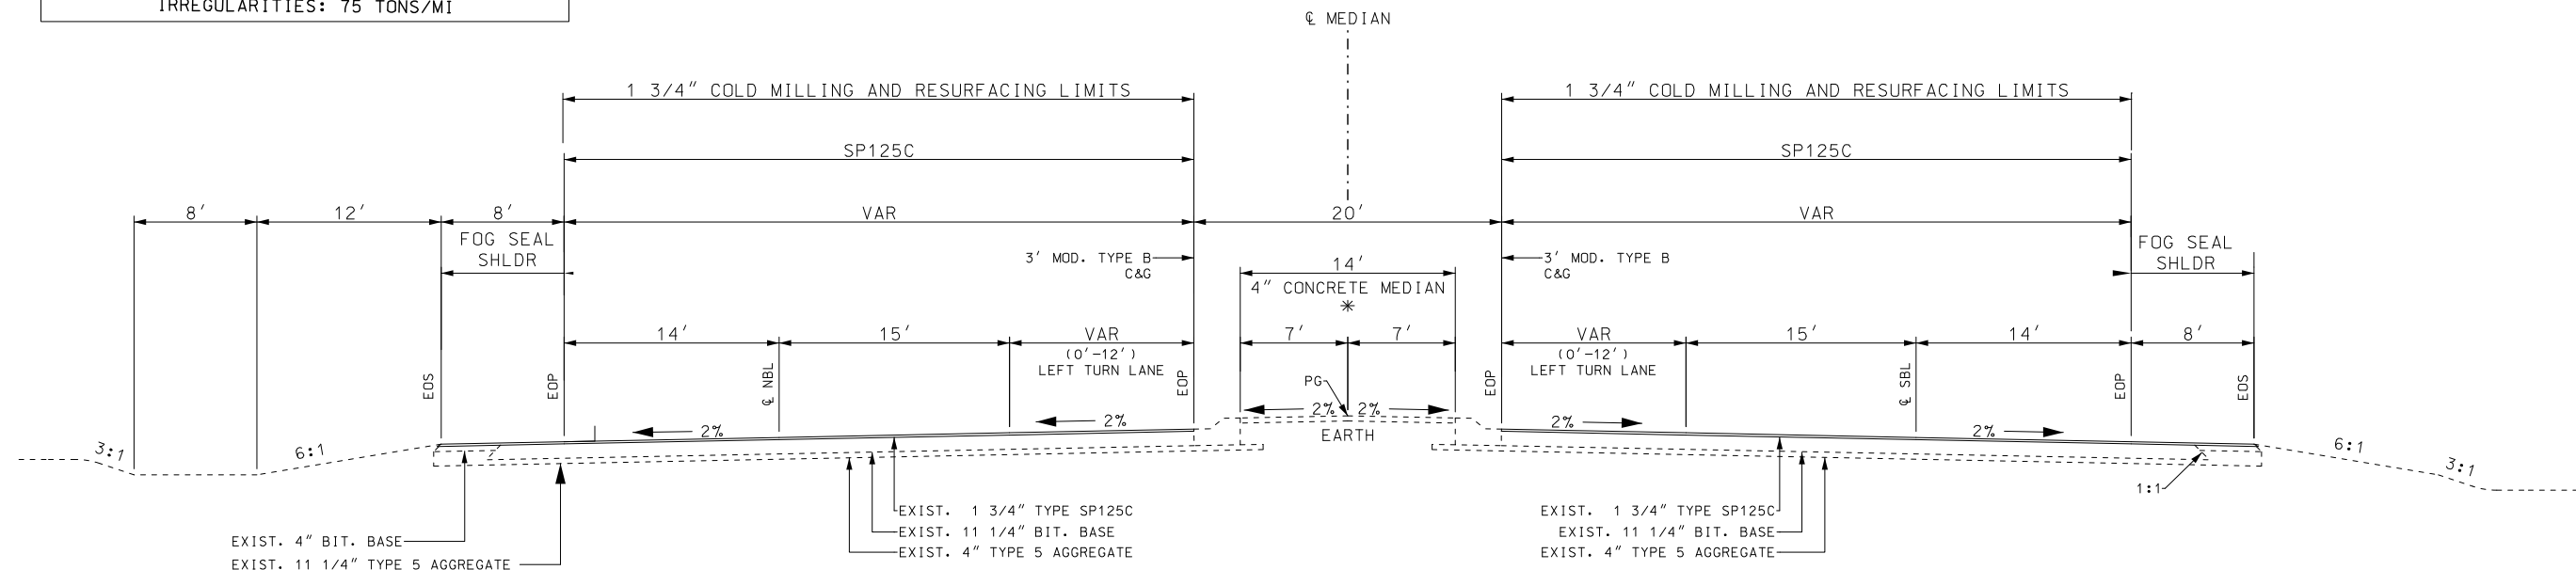

SECTION ON TANGENT
TYPICAL SECTION ROUTE 160

WESTBOUND LANES
LOG MILE 229.939 - LOG MILE 228.260

EASTBOUND LANES
LOG MILE 93.215 - LOG MILE 94.892

* VARIABLE WIDTH MEDIAN
EB LOG MILE 93.175 - 93.327
WB LOG MILE 229.930 - 229.778

NOT TO SCALE


ROUTE 160
TYPICAL SECTION
SHEET 1 OF 2

MISSOURI HIGHWAYS AND TRANSPORTATION
COMMISSION



105 WEST CAPITOL
JEFFERSON CITY, MO 65102
1-888-ASK-MODOT (1-888-275-6636)


Δ VARIABLE WIDTH MEDIAN
EB LOG MILE 94.890 - 95.009
EB LOG MILE 95.296 - 95.316
WB LOG MILE 227.850 - 227.836
WB LOG MILE 228.260 - 228.136

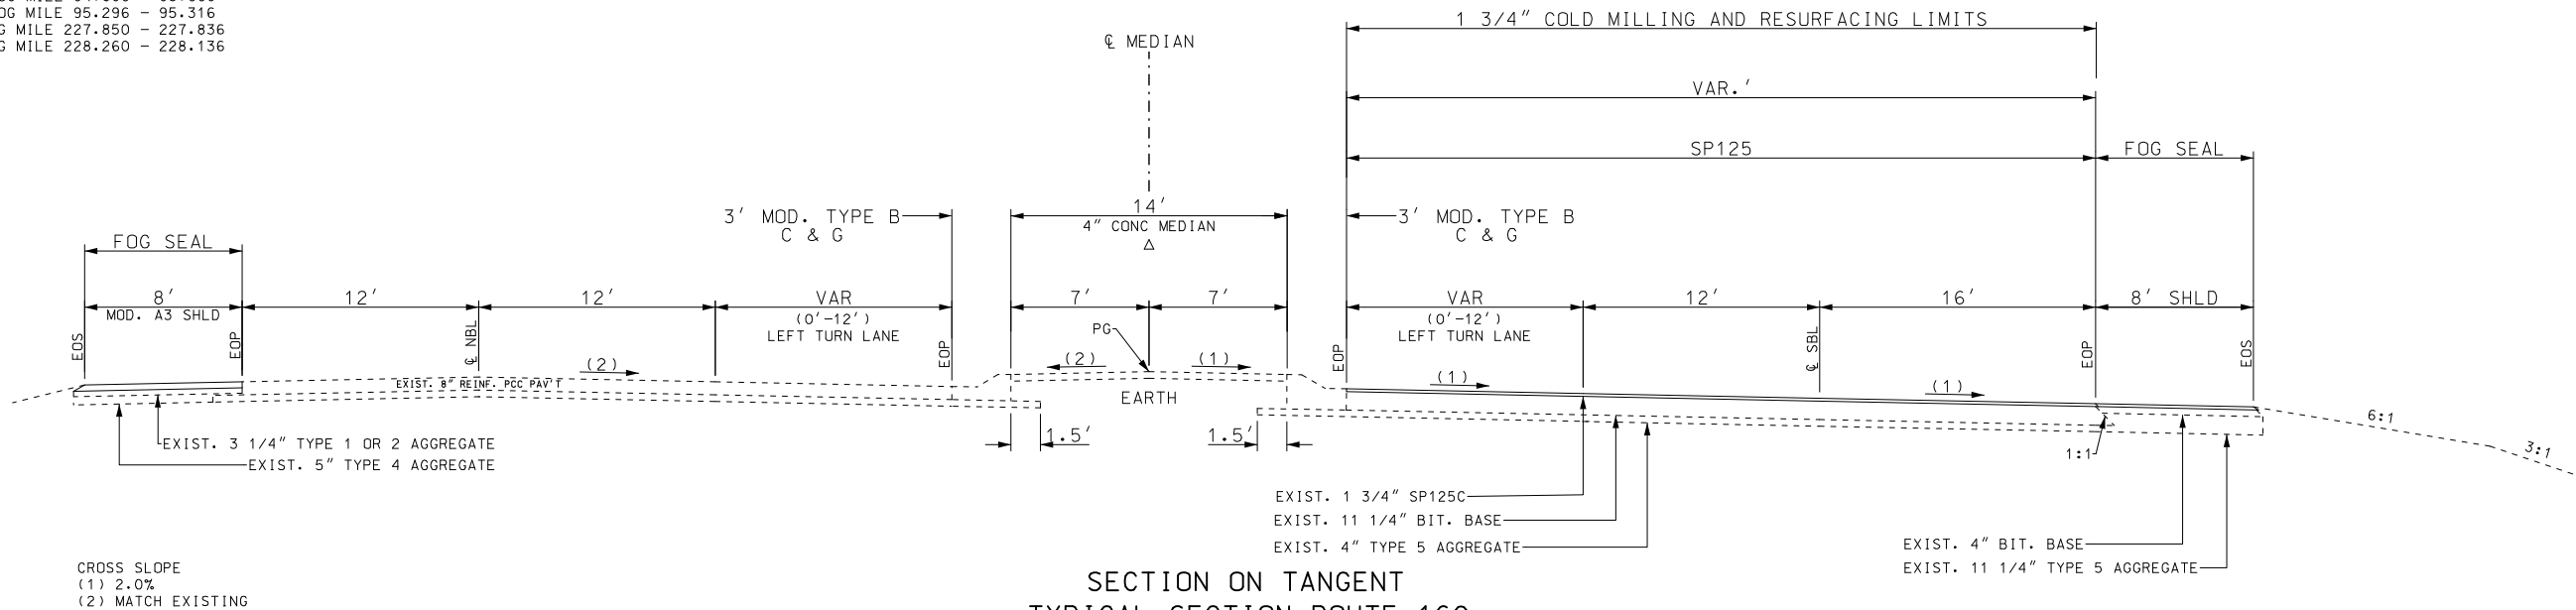

WESTBOUND LANES
LOG MILE 228.260 - LOG MILE 227.836

EASTBOUND LANES
LOG MILE 94.892 - LOG MILE 95.316

ESTIMATE FACTORS		
	ASPH. FACTOR	% AC
SP125C (PG 70-22)	1.975 TONS/C.Y.	4.8
FOG SEAL	0.2 GAL/SY	
TACK EST. @	0.10 GAL/SY	
IRREGULARITIES: 75 TONS/MI		

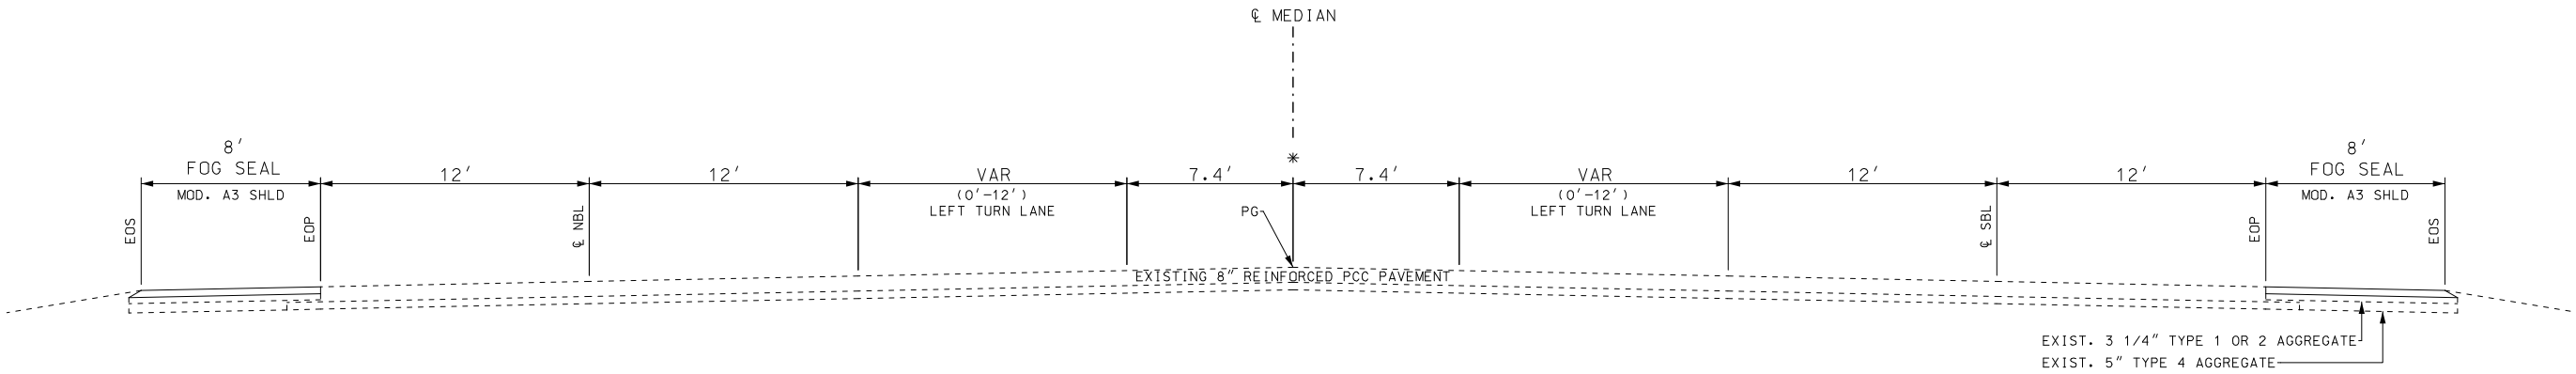


WESTBOUND LANES
LOG MILE 227.836 - LOG MILE 228.161

EASTBOUND LANES
LOG MILE 95.316 - LOG MILE 95.336

* 8" RAISED MEDIAN FROM
EB LOG MILE 95.310 - 95.338
WB LOG MILE 227.836 - 227.809

NOT TO SCALE

ROUTE 160
TYPICAL SECTION
SHEET 2 OF 2

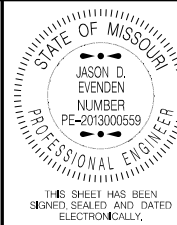

DATE PREPARED
8/5/2021
ROUTE 160 STATE MO
DISTRICT SW SHEET NO. 2

COUNTY GREENE
JOB NO. J8S3168
CONTRACT ID.

PROJECT NO.
BRIDGE NO.

DATE	DESCRIPTION

MISSOURI HIGHWAYS AND TRANSPORTATION COMMISSION

105 WEST CAPITOL
JEFFERSON CITY, MO 65102
1-888-ASK-MODOT (1-888-275-6636)

IF A SEAL IS PRESENT ON THIS SHEET IT HAS BEEN ELECTRONICALLY SEALED AND DATED.


CONTRACTOR FURNISHED SURVEYING AND STAKING
1 LUMP SUM

PAVEMENT QUANTITIES										
LOG MILE	LOG MILE	LENGTH (FT)	LOCATION	AVERAGE WIDTH		COLD MILLING LESS 3" THICK (SY)	1.75" SP125C (PG 70-22)	FOG SEAL	NON OR LOW TRACKING TACK .10 GAL/SY (GAL)	REMARKS
				ROADWAY (FT)	SHLDR OUTSIDE (FT)		ROADWAY (TONS)	SHOULDER (GAL)		
EASTBOUND PAVEMENT QUANTITIES										
93.163	93.203	211.2	EB US 160	VAR	8.00	1283.1	123.18	37.55	128.3	INTERSECTION OF EB US 160 & 413 (INCLUDES TURN LANE)
93.203	93.215	63.4	EB US 160	27.00	8.00	190.1	18.25	11.26	19.0	
93.215	94.341	5945.3	EB US 160	29.00	8.00	19157.0	1839.21	1056.94	1915.7	
94.341	94.420	417.1	EB US 160	VAR	8.00	2762.6	265.23	74.15	276.3	INTERSECTION OF EB US 160 & FARM ROAD 156 (ONLY EB HALF, INCLUDES APRON ON FR 156)
94.420	94.892	2492.2	EB US 160	29.00	8.00	8030.3	770.96	443.05	803.0	
94.892	94.976	443.5	EB US 160	VAR	8.00	1575.3	151.24	78.85	157.5	
94.976	95.300	1710.7	EB US 160	28.00	8.00	5322.2	510.97	304.13	532.2	INTERSECTION OF W BATTLEFIELD ROAD & S. KAUFFMAN ROAD (ONLY EB HALF)
95.300	95.336	190.1	EB US 160	VAR	8.00	452.0	43.40	33.79	45.2	
93.146	95.336	11563.2	EB US 160	VAR	VAR		328.50	328.50		
WESTBOUND PAVEMENT QUANTITIES										
228.187	228.602	2191.20	WB US 160		8.00			389.55		EXEMPT OUT CONCRETE MAINLINE, FOG SEAL SHOULDERS
228.602	229.034	2280.96	WB US 160	29.00	8.00	7349.8	705.63	405.50	735.0	
228.970	229.034	337.92	WB US 161		8.00	300.4	28.84		30.0	
229.034	229.134	528.00	WB US 160	VAR	8.00	2679.6	257.26	93.87	268.0	NB SHOULDER FULL DEPTH PAVEMENT --MILL AND FILL --STRIPED AS TURN LANE INTERSECTION OF WB 160 & FARM ROAD 156 (ONLY WB HALF, INCLUDES APRON ON FR156)
229.134	230.294	6124.80	WB US 160	29.00	8.00	19735.5	1894.74	1088.85	1973.6	
230.294	230.336	221.76	WB US 160	VAR	8.00	2097.9	201.41	39.42	209.8	
228.187	230.336	11346.72	WB US 160	VAR	VAR		322.35	322.35		INTERSECTION OF WB US 160 & RTE 413 IRREGULARITIES (75 TONS/MILE)
TOTAL USE						70935.7	7461.17	4707.76	7093.6	
						70936	7461.2	4708.0	7094	
SP125C (PG 70-22) ESTIMATED AT 1.975 TONS/CY FOG SEAL ESTIMATED AT 0.2 GAL/SY										
ANY AND ALL IRREGULARITIES MAY BE UNDERRUN AND NO ADJUSTMENT TO ANY BID COST WILL BE MADE										

RADAR DETECTION		
LOG MILE	INTERSECTION (LUMP SUM)	REMARKS/LOCATION
EASTBOUND		
94.341	1	INTERSECTION AT FARM ROAD 156
94.892	1	INTERSECTION AT BATTLEFIELD RD.
TOTAL	2	

MOBILIZATION
1 LUMP SUM

SUMMARY OF QUANTITIES
SHEET 1 OF 3

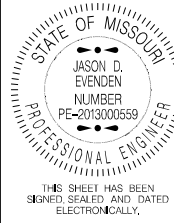

DATE PREPARED 9/22/2021	
ROUTE 160	STATE MO
DISTRICT SW	SHEET NO. 3
COUNTY GREENE	
JOB NO. J8S3168	
CONTRACT ID.	

PROJECT NO.
BRIDGE NO.

DESCRIPTION	DATE


MISSOURI HIGHWAYS AND TRANSPORTATION COMMISSION



105 WEST CAPITOL
JEFFERSON CITY, MO 65102
1-888-ASK-MODOT (1-888-275-6636)

IF A SEAL IS PRESENT ON THIS SHEET IT HAS BEEN ELECTRONICALLY SEALED AND DATED.

PAVEMENT MARKING										
ACRYLIC WATERBORNE PAVEMENT MARKING PAINT-TYPE L BEADS						PREFORMED THERMOPLASTIC PAVEMENT MARKING				
BEGIN LOG MILE	END LOG MILE	LOC	LENGTH (FT)	4" YELLOW (LF)	6" WHITE (LF)	24" STOP BAR WHITE (LF)	12' PED WHITE CROSSING (LF)	LT. TURN ARROW (EA)	RT. TURN ARROW (EA)	REMARKS
EASTBOUND PAVEMENT MARKING										
93.146	93.155	RT	47.5		47.5					MARKING NEXT TO ISLAND
93.146	94.386	CL	6547.2							INT. WHITE
93.215	94.386	RT	6182.9		6182.9					EDGE LINE
94.346	94.384	LT	200.6							LEFT TURN LANE
94.397	94.405	RT	42.2		42.2					MARKING NEXT TO ISLAND
94.405	94.949	CL	2872.3							INT. WHITE
94.415	94.949	RT	2819.5		2819.5					EDGE LINE
94.911	94.949	LT	200.6							LEFT TURN LANE
94.969	95.310	CL	1800.5							INT. WHITE
94.969	95.310	RT	1800.5		1800.5					EDGE LINE
95.310	95.329	LT	100.3							LEFT TURN LANE
95.310	95.542	RT	1225.0		1225.0					EDGE LINE
95.310	95.542	CL	1225.0							INT. WHITE
95.364	95.542	RT	939.8	1879.7						DOUBLE YELLOW
94.336	94.384	LT						2.0		LEFT TURN LANE
94.384						12.0				STOP BARS
94.386						24.0				STOP BARS
94.917	94.949	LT						2.0		LEFT TURN LANE
94.948						12.0				STOP BARS
94.949						24.0				STOP BARS
94.950							145.0			CROSS WALK
WESTBOUND PAVEMENT MARKING										
228.187	228.190	RT	15.8		15.8					
228.217	228.260	RT	227.0		227.0					
228.217	228.260	CL	227.0							
228.260	228.737	CL	2518.6							
228.260	228.737	RT	2518.6		2518.6					
228.701	228.735	LT	179.5							
228.748	228.756	RT	42.2		42.2					
228.756	230.004	CL	6589.4							
228.763	230.021	RT	6642.2		6642.2					
229.959	230.004	LT	237.6							
229.959	230.002	RT	227.0							
228.174						12.0				STOP BARS
228.176						24.0				STOP BARS
228.191							80.0			CROSS WALK
228.675	228.737	LT/RT			200.0			2.0	2.0	LEFT AND RIGHT TURN LANE F.R. 156
228.735						12.0				STOP BARS
228.737						24.0				STOP BARS
229.939	230.021	LT						2.0		LEFT TURN LANE
229.939	230.021	RT							2.0	RIGHT TURN LANE
230.002						12.0				STOP BARS
230.004						24.0				STOP BARS
TOTAL				1879.7	21763.5	180.0	225.0	8.0	4.0	
USE				1880	21764	180	225	12		
NOTE: QUANTITIES SHOWN ARE APPROXIMATE. FINAL PAY QUANTITY SHALL BE BASED ON FINAL MEASUREMENT IN ACCORDANCE WITH PAVEMENT MARKING LOG JSP.										

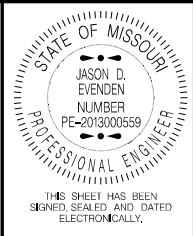

DATE PREPARED 9/22/2021	
ROUTE 160	STATE MO
DISTRICT SW	SHEET NO. 3
COUNTY GREENE	
JOB NO. J8S3168	
CONTRACT ID.	
PROJECT NO.	
BRIDGE NO.	

DESCRIPTION	DATE								

MISSOURI HIGHWAYS AND TRANSPORTATION COMMISSION




105 WEST CAPITOL
JEFFERSON CITY, MO 65102
1-888-ASK-MODOT (1-888-275-6636)

IF A SEAL IS PRESENT ON THIS SHEET IT HAS BEEN ELECTRONICALLY SEALED AND DATED.

																EFFECTIVE: 04-01-2021				STATE OF MISSOURI JASON D. EVENDEN NUMBER PE-2013000559 PROFESSIONAL ENGINEER THIS SHEET HAS BEEN SIGNED, SEALED AND DATED ELECTRONICALLY. DATE PREPARED 9/22/2021 ROUTE 160 STATE MO DISTRICT SW SHEET NO. 3 COUNTY GREENE JOB NO. J8S3168 CONTRACT ID. PROJECT NO. BRIDGE NO. DESCRIPTION DATE MISSOURI HIGHWAYS AND TRANSPORTATION COMMISSION 105 WEST CAPITAL JEFFERSON CITY, MO 65102 1-888-ASK-MODOT (1-888-275-6636) MODOT																
SIGN	SIZE IN.	AREA SQ.FT.	QTY EACH	TOTAL AREA SQ.FT.	QTY RELOC EACH	TOTAL RELOC SQ.FT.	SIGN NUM.									SIGN	SIZE IN.	AREA SQ.FT.	QTY EACH						TOTAL SQ.FT.	QTY RELOC EACH	TOTAL RELOC SQ.FT.	SIGN NUM.					ITEM NUMBER	TOTAL QTY	DESCRIPTION	
WARNING SIGNS								DESCRIPTION								GUIDE SIGNS									DESCRIPTION											
W01-1L	48X48	16.00						TURN (SYMBOL LEFT ARROW)	E05-1	36X48	12.00							GORE EXIT	6122008							IMPACT ATTENUATOR 40 MPH (SAND BARRELS)										
W01-1R	48X48	16.00						TURN (SYMBOL RIGHT ARROW)	E05-2	48X36	12.00							EXIT OPEN	6122009							IMPACT ATTENUATOR 45 MPH (SAND BARRELS)										
W01-2L	48X48	16.00						CURVE (SYMBOL LEFT ARROW)	E05-2a	48X36	12.00							EXIT CLOSED	6122010		IMPACT ATTENUATOR 50 MPH (SAND BARRELS)															
W01-2R	48X48	16.00						CURVE (SYMBOL RIGHT ARROW)	G020-1	60X24	10.00	4	40.00					ROAD WORK NEXT XX MILES	6122012		IMPACT ATTENUATOR 55 MPH (SAND BARRELS)															
W01-3L	48X48	16.00						REVERSE TURN (SYMBOL LEFT ARROW)	G020-2	48X24	8.00	4	32.00					END ROAD WORK	6122014		IMPACT ATTENUATOR 60 MPH (SAND BARRELS)															
W01-3R	48X48	16.00						REVERSE TURN (SYMBOL RIGHT ARROW)	G020-4	36X18	4.50							PILOT CAR FOLLOW ME	6122017		IMPACT ATTENUATOR 65 MPH (SAND BARRELS)															
W01-4L	48X48	16.00						REVERSE CURVE (SYMBOL LEFT ARROW)	G020-4a	42X30	8.75							PILOT CAR IN USE WAIT & FOLLOW	6122019		IMPACT ATTENUATOR 70 MPH (SAND BARRELS)															
W01-4R	48X48	16.00						REVERSE CURVE (SYMBOL RIGHT ARROW)	G020-4a	18X12	1.50							PILOT CAR IN USE WAIT & FOLLOW	6122020		REPLACEMENT SAND BARREL															
W01-4bL	48X48	16.00						DOUBLE ARROW REVERSE CURVE (SYMBOL LT ARROWS)	G020-5aP	36X24	6.00	5	30.00					WORK ZONE (PLAQUE)	6122030		IMPACT ATTENUATOR (RELOCATION)															
W01-4bR	48X48	16.00						DOUBLE ARROW REVERSE CURVE (SYMBOL RT ARROWS)	M04-8a	24X18	3.00							END DETOUR	6123000A	3	TRUCK OR TRAILER MOUNTED ATTENUATOR (TMA)															
W01-4cL	48X48	16.00						TRIPLE ARROW REVERSE CURVE (SYMBOL LT ARROWS)	M04-9L	48X36	12.00							DETOUR (LEFT ARROW)	6161008		ADVANCED WARNING RAIL SYSTEM															
W01-4cR	48X48	16.00						TRIPLE ARROW REVERSE CURVE (SYMBOL RT ARROWS)	M04-9R	48X36	12.00							DETOUR (RIGHT ARROW)	6161012		BUOYS (BOATS KEEP OUT)															
W01-6	60X30	12.50						HORIZONTAL ARROW (SYMBOL)	M04-9P	48X12	4.00							STREET NAME (PLAQUE)	6161013		BUOYS (NO WAKE)															
W01-6a	72X36	18.00						HORIZ. ARROW (SYMBOL ON PERMANENT BARRICADE)	M04-10L	48X18	6.00							DETOUR (ARROW LEFT)	6161014		SPECIAL SIGN ASSEMBLY (BOATS KEEP OUT)															
W01-7	60X30	12.50						DOUBLE HEAD HORIZONTAL ARROW (SYMBOL)	M04-10R	48X18	6.00							DETOUR (ARROW RIGHT)	6161025	150	CHANNELIZER (TRIM LINE)															
W01-7a	72X36	18.00						DOUBLE HEAD HORIZ. ARROW (SYMBOL ON PERM. BARR.)	REGULATORY SIGNS										6161030	2	TYPE III MOVEABLE BARRICADE															
W01-8	18X24	3.00						CHEVRON (SYMBOL)	R1-1	48X48	13.25							STOP	6161033		DIRECTION INDICATOR BARRICADE															
W01-8a	30X36	7.50						CHEVRON (SYMBOL FOR DIVIDED HIGHWAYS)	R1-2	48TRI.	6.93							YIELD	6161040	3	FLASHING ARROW PANEL															
W03-1	48X48	16.00						STOP AHEAD (SYMBOL)	R1-2a	36X36	9.00							TO ONCOMING TRAFFIC (PLAQUE)	6161047		TYPE III OBJECT MARKER															
W03-2	48X48	16.00						YIELD AHEAD (SYMBOL)	R1-3P	30X12	2.50							ALL WAY (PLAQUE)	6161051		WARNING LIGHT, TYPE A															
W03-3	48X48	16.00						SIGNAL AHEAD (SYMBOL)	R2-1	36X48	12.00	10	120.00					SPEED LIMIT XX	6161052		WARNING LIGHT, TYPE B															
W03-4	48X48	16.00						BE PREPARED TO STOP	R3-1	48X48	16.00							NO RIGHT TURN (SYMBOL)	6161053		WARNING LIGHT, TYPE C															
W03-5	48X48	16.00	2	32.00				SPEED LIMIT AHEAD	R3-2	48X48	16.00							NO LEFT TURN (SYMBOL)	6161070		TUBULAR MARKER															
W04-1L	48X48	16.00						MERGE (SYMBOL FROM LEFT)	R3-3	36X36	9.00							NO TURNS	6161095		RADAR SPEED ADVISORY SYSTEM															
W04-1R	48X48	16.00						MERGE (SYMBOL FROM RIGHT)	R3-4	48X48	16.00							NO U-TURN (SYMBOL)	6161096		CHANGEABLE MESSAGE SIGN, COMMISSION FURNISHED/RETAINED															
W04-1aL	48X48	16.00	1	16.00				MERGE (ARROW SYMBOL)	R3-7L	30X30	6.25	4	25.00					LEFT LANE MUST TURN LEFT			COMMISSION FURNISHED/RETAINED															
W04-1aR	48X48	16.00	1	16.00				MERGE (ARROW SYMBOL)	R3-7R	30X30	6.25	4	25.00					RIGHT LANE MUST TURN RIGHT	6161098A	2	CHANGEABLE MESSAGE SIGN W/O COMM. INTERFACE, CONTRACTOR FURNISHED/RETAINED															
W05-1	48X48	16.00						ROAD/BRIDGE/RAMP NARROWS	R4-1	36X48	12.00							DO NOT PASS			CHANGEABLE MESSAGE SIGN WITH COMM. INTERFACE, CONTRACTOR FURNISHED/RETAINED															
W05-3	48X48	16.00						ONE LANE BRIDGE	R4-2	36X48	12.00							PASS WITH CARE	6161099		CHANGEABLE MESSAGE SIGN WITH COMM. INTERFACE, CONTRACTOR FURNISHED/RETAINED															
W05-5	48X48	16.00						NARROW LANES	R4-8a	36X48	12.00							KEEP LEFT (HORIZONTAL ARROW)			WORK ZONE TRAFFIC SIGNAL SYSTEM															
W06-1	48X48	16.00						DIVIDED HIGHWAY (SYMBOL)	R4-7a	36X48	12.00							KEEP RIGHT (HORIZONTAL ARROW)	6162000A		TEMPORARY LONG-TERM RUMBLE STRIPS															
W06-2	48X48	16.00						DIVIDED HIGHWAY END (SYMBOL)	R5-1	30X30	6.25							DO NOT ENTER	6162002		TEMPORARY SHORT-TERM RUMBLE STRIPS															
W06-3	48X48	16.00						TWO WAY TRAFFIC (SYMBOL)	R5-1a	36X24	6.00							WRONG WAY	6162004	4	TEMPORARY TRAFFIC BARRIER CONTRACTOR FURNISHED/RETAINED															
W07-3a	30X24	5.00						NEXT XX MILES (PLAQUE)	R6-1L	54X18	6.75							ONE WAY ARROW (LEFT)	6173600D		TEMPORARY TRAFFIC BARRIER CONTRACTOR FURNISHED/RETAINED															
W08-1	48X48	16.00						BUMP	R6-1R	54X18	6.75							ONE WAY ARROW (RIGHT)			TEMPORARY TRAFFIC BARRIER CONTRACTOR FURNISHED/COMMISSION RETAINED															
W08-2	48X48	16.00						DIP	R6-2L	24X30	5.00							ONE WAY (LEFT)	6173602B		TEMP. TRAFFIC BARRIER HEIGHT TRANSITION															
W08-3	48X48	16.00						PAVEMENT ENDS	R6-2R	24X30	5.00							ONE WAY (RIGHT)	6175010A		RELOCATING TEMPORARY TRAFFIC BARRIER															
W08-4	48X48	16.00						SOFT SHOULDER	R9-9	24X12	2.00							SIDEWALK CLOSED	6176000B		TEMPORARY TRAFFIC BARRIER COMMISSION FURNISHED/RETAINED															
W08-5	48X48	16.00						SLIPPERY WHEN WET (SYMBOL)	R9-11L	24X18	3.00							SIDEWALK CLOSED AHEAD, (ARROW LEFT) CROSS HERE			TEMP. TRAFFIC BARRIER HEIGHT TRANSITION															
W08-6	48X48	16.00						TRUCK CROSSING (WITH FLAGS)	R9-11R	24X18	3.00							SIDEWALK CLOSED AHEAD, (ARROW RIGHT) CROSS HERE	6177000B		COMMISSION FURNISHED/RETAINED															
W08-6c	48X48	16.00						TRUCK ENTRANCE	R10-6	24X36	6.00							STOP HERE ON RED (45° ARROW)			TEMP. TRAFFIC BARRIER HEIGHT TRANSITION															
W08-7	36X36	9.00						LOOSE GRAVEL	R11-2	48X30	10.00							ROAD CLOSED	6208064A		COMMISSION FURNISHED/RETAINED															
W08-7a	36X36	9.00						FRESH OIL/LOOSE GRAVEL	R11-3a	60X30	12.50							ROAD CLOSED XX MILES AHEAD LOCAL TRAFFIC ONLY	9029400		TEMPORARY RAISED PAVEMENT MARKER															
W08-9	48X48	16.00						LOW SHOULDER	R11-4	60X30	12.50							ROAD CLOSED TO THRU TRAFFIC	9029401		TEMPORARY TRAFFIC SIGNALS															
W08-11	48X48	16.00						UNEVEN LANES	CONST-3A	60X48	20.00							FINE SIGN			TEMPORARY TRAFFIC SIGNALS AND LIGHTING															
W08-12	48X48	16.00						NO CENTER LINE	CONST-3X	56X12	4.67							SPEEDING/PASSING (PLATE)																		
W08-15	48X48	16.00						GROOVED PAVEMENT	MISCELLANEOUS SIGNS																											
W08-15P	30X24	5.00						MOTORCYCLE (PLAQUE)	CONST-5	48X36	12.00								POINT OF PRESENCE																	
W08-17	48X48	16.00						SHOULDER DROP-OFF (SYMBOL)	CONST-5	96X48	32.00	1	32.00						POINT OF PRESENCE																	
W08-17P	30X24	5.00						SHOULDER DROP-OFF (PLAQUE)	CONST-7	48X24	8.00								RATE OUR WORK ZONE																	
W10-1	42RND.	9.62						RAILROAD CROSSING	CONST-7	72X36	18.00	2	36.00						RATE OUR WORK ZONE																	
W12-1	24X24	4.00	2	8.00				DOUBLE DOWN ARROW (SYMBOL)	CONST-8	48X36	12.00	4	48.00						WORK ZONE NO PHONE ZONE																	
W12-2	48X48	16.00						LOW CLEARANCE (SYMBOL)																												
W12-2X	24X18	3.00						LOW CLEARANCE (PLAQUE)																												
W12-2a	84X24	14.00						OVERHEAD LOW CLEARANCE (FEET AND INCHES)																												
W12-4	120X60	50.00						LOW CLEARANCE XX FT XX IN XX MILES AHEAD																												
W12-5	120X60	50.00						WIDTH RESTRICTION XX FT XX IN XX MILES AHEAD																												
W13-1	30X30	6.25						ADVISORY SPEED (PLAQUE)																												
W16-2	30X24	5.00						XXX FEET (PLAQUE)																												
W16-3	30X24	5.00						X MILE (PLAQUE)																												
W20-1	48X48	16.00	23	368.00				ROAD/BRIDGE/RAMP WORK AHEAD	616-10.05										TOTAL																	
W20-2	48X48	16.00						DETOUR AHEAD	CONSTRUCTION SIGNS										1004																	
W20-3	48X48	16.00						ROAD CLOSED AHEAD	616-10.10										TOTAL																	
W20-4	48X48	16.00						ONE LANE ROAD AHEAD	RELOCATED SIGNS										0																	
W20-5	48X48	16.00	5	80.00				RIGHT/CENTER/LEFT LANE CLOSED AHEAD																												
W20-5a	48X48	16.00						2 RIGHT/CENTER/LEFT LANES CLOSED AHEAD																												
W20-6a	48X48	16.00	6	96.00				RIGHT/CENTER/LEFT LANE CLOSED																												
W20-7a	48X48	16.00						FLAGGER (SYMBOL, WITH FLAGS)																												
W21-2	36X36	9.00						FRESH OIL																												
W21-5	48X48	16.00						SHOULDER WORK AHEAD																												
W22-1	48X48	16.00						BLASTING ZONE AHEAD																												
W22-2	42X36	10.50						TURN OFF 2-WAY RADIO																												



BEGINNING OF PROJECT

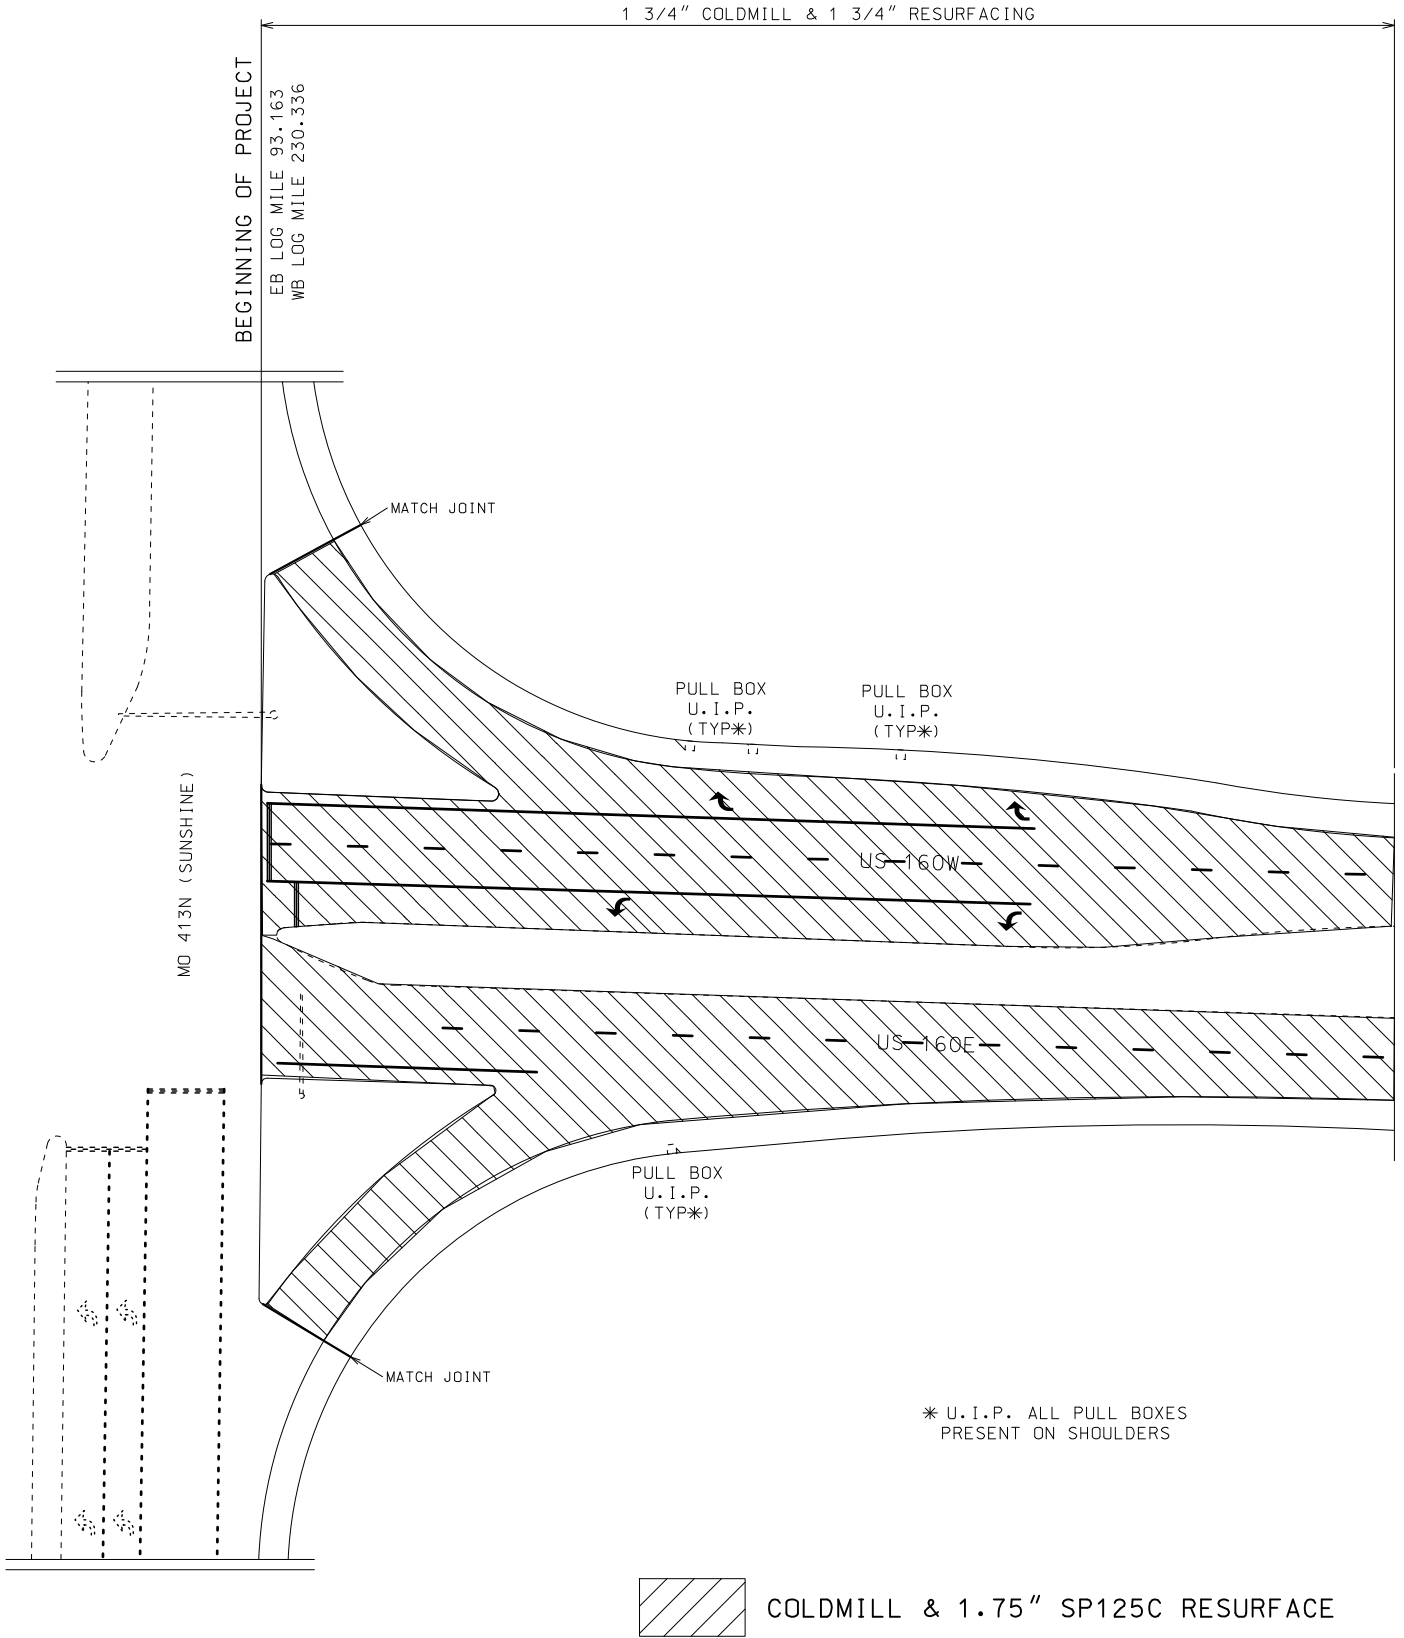


NOT TO SCALE

NOTES: FOG SEAL SHOULDERS




INT. US 160 AND FARM ROAD 156

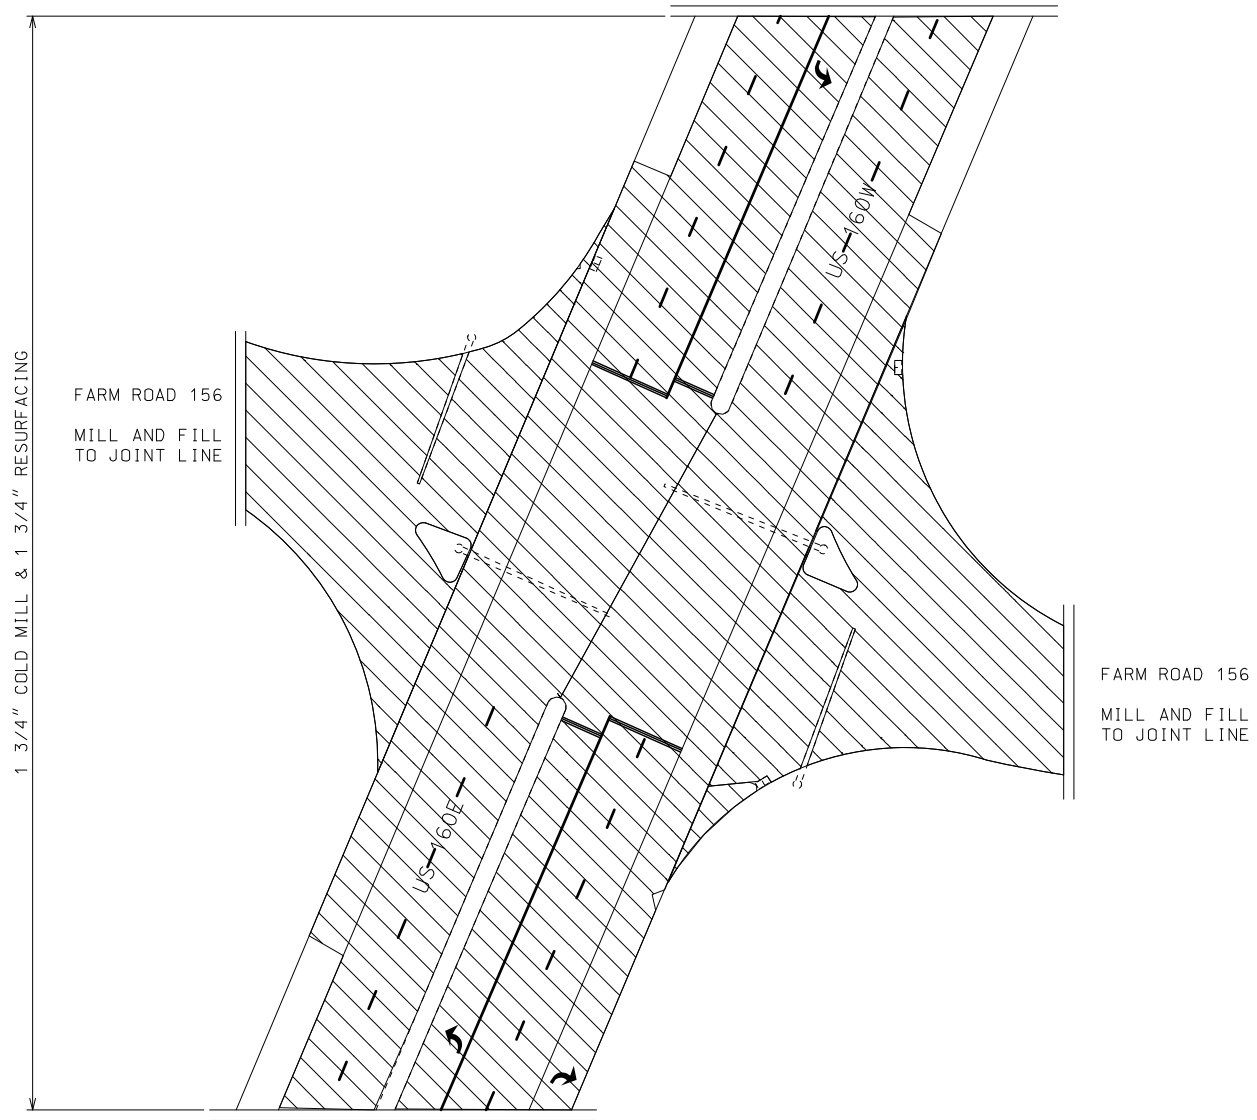


NOT TO SCALE

 NOTE: INSTALL RADAR DETECTOR AT INTERSECTION

 COLDMILL & 1.75" SP125C RESURFACE

NOTES: FOG SEAL SHOULDERS

SPECIAL SHEET
SHEET 1 OF 3

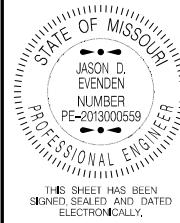

DATE PREPARED 8/5/2021	
ROUTE 160	STATE MO
DISTRICT SW	SHEET NO. 4
COUNTY GREENE	
JOB NO. J8S3168	
CONTRACT ID.	
PROJECT NO.	
BRIDGE NO.	

DATE	DESCRIPTION


MISSOURI HIGHWAYS AND TRANSPORTATION COMMISSION



105 WEST CAPITOL
JEFFERSON CITY, MO 65102
1-888-ASK-MODOT (1-888-275-6636)

IF A SEAL IS PRESENT ON THIS SHEET IT HAS BEEN ELECTRONICALLY SEALED AND DATED.

INT. US 160 & BATTLEFIELD RD

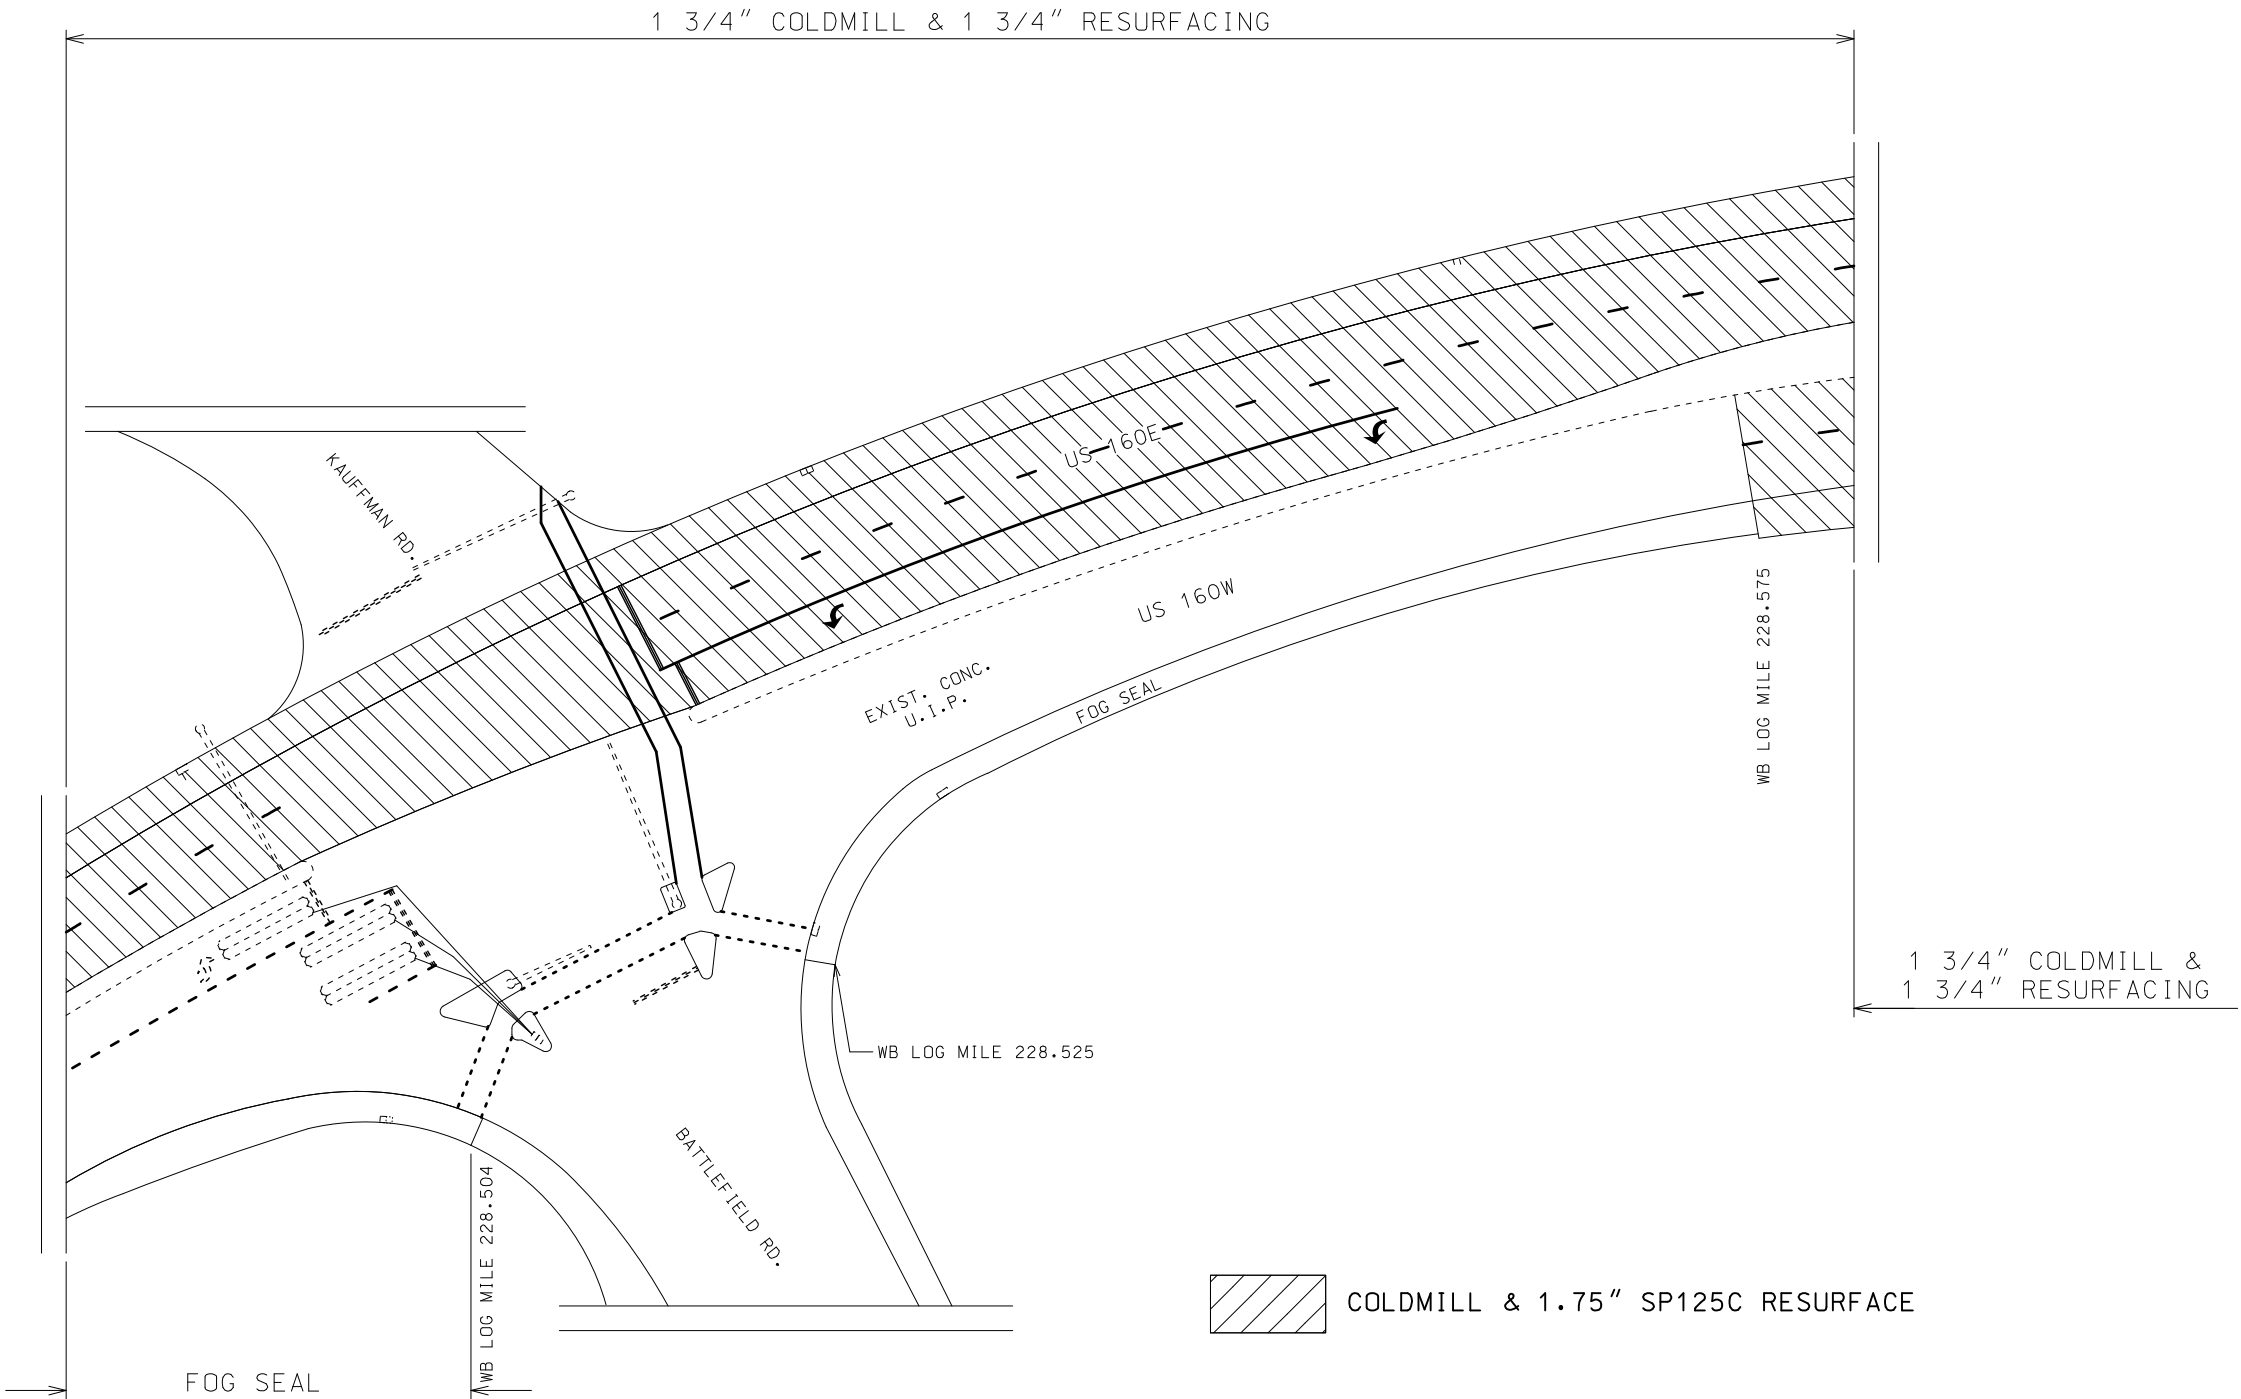


 COLDMILL & 1.75" SP125C RESURFACE

NOTE: INSTALL RADAR DETECTORS AT INTERSECTION

NOT TO SCALE

SPECIAL SHEET
SHEET 2 OF 3

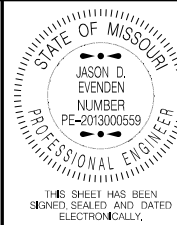

DATE PREPARED 8/5/2021	
ROUTE 160	STATE MO
DISTRICT SW	SHEET NO. 5
COUNTY GREENE	
JOB NO. J8S3168	
CONTRACT ID.	
PROJECT NO.	
BRIDGE NO.	



DATE	DESCRIPTION

MISSOURI HIGHWAYS AND TRANSPORTATION COMMISSION



105 WEST CAPITOL
JEFFERSON CITY, MO 65102
1-888-ASK-MODOT (1-888-275-6636)

IF A SEAL IS PRESENT ON THIS SHEET IT HAS BEEN ELECTRONICALLY SEALED AND DATED.

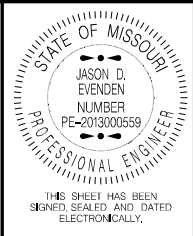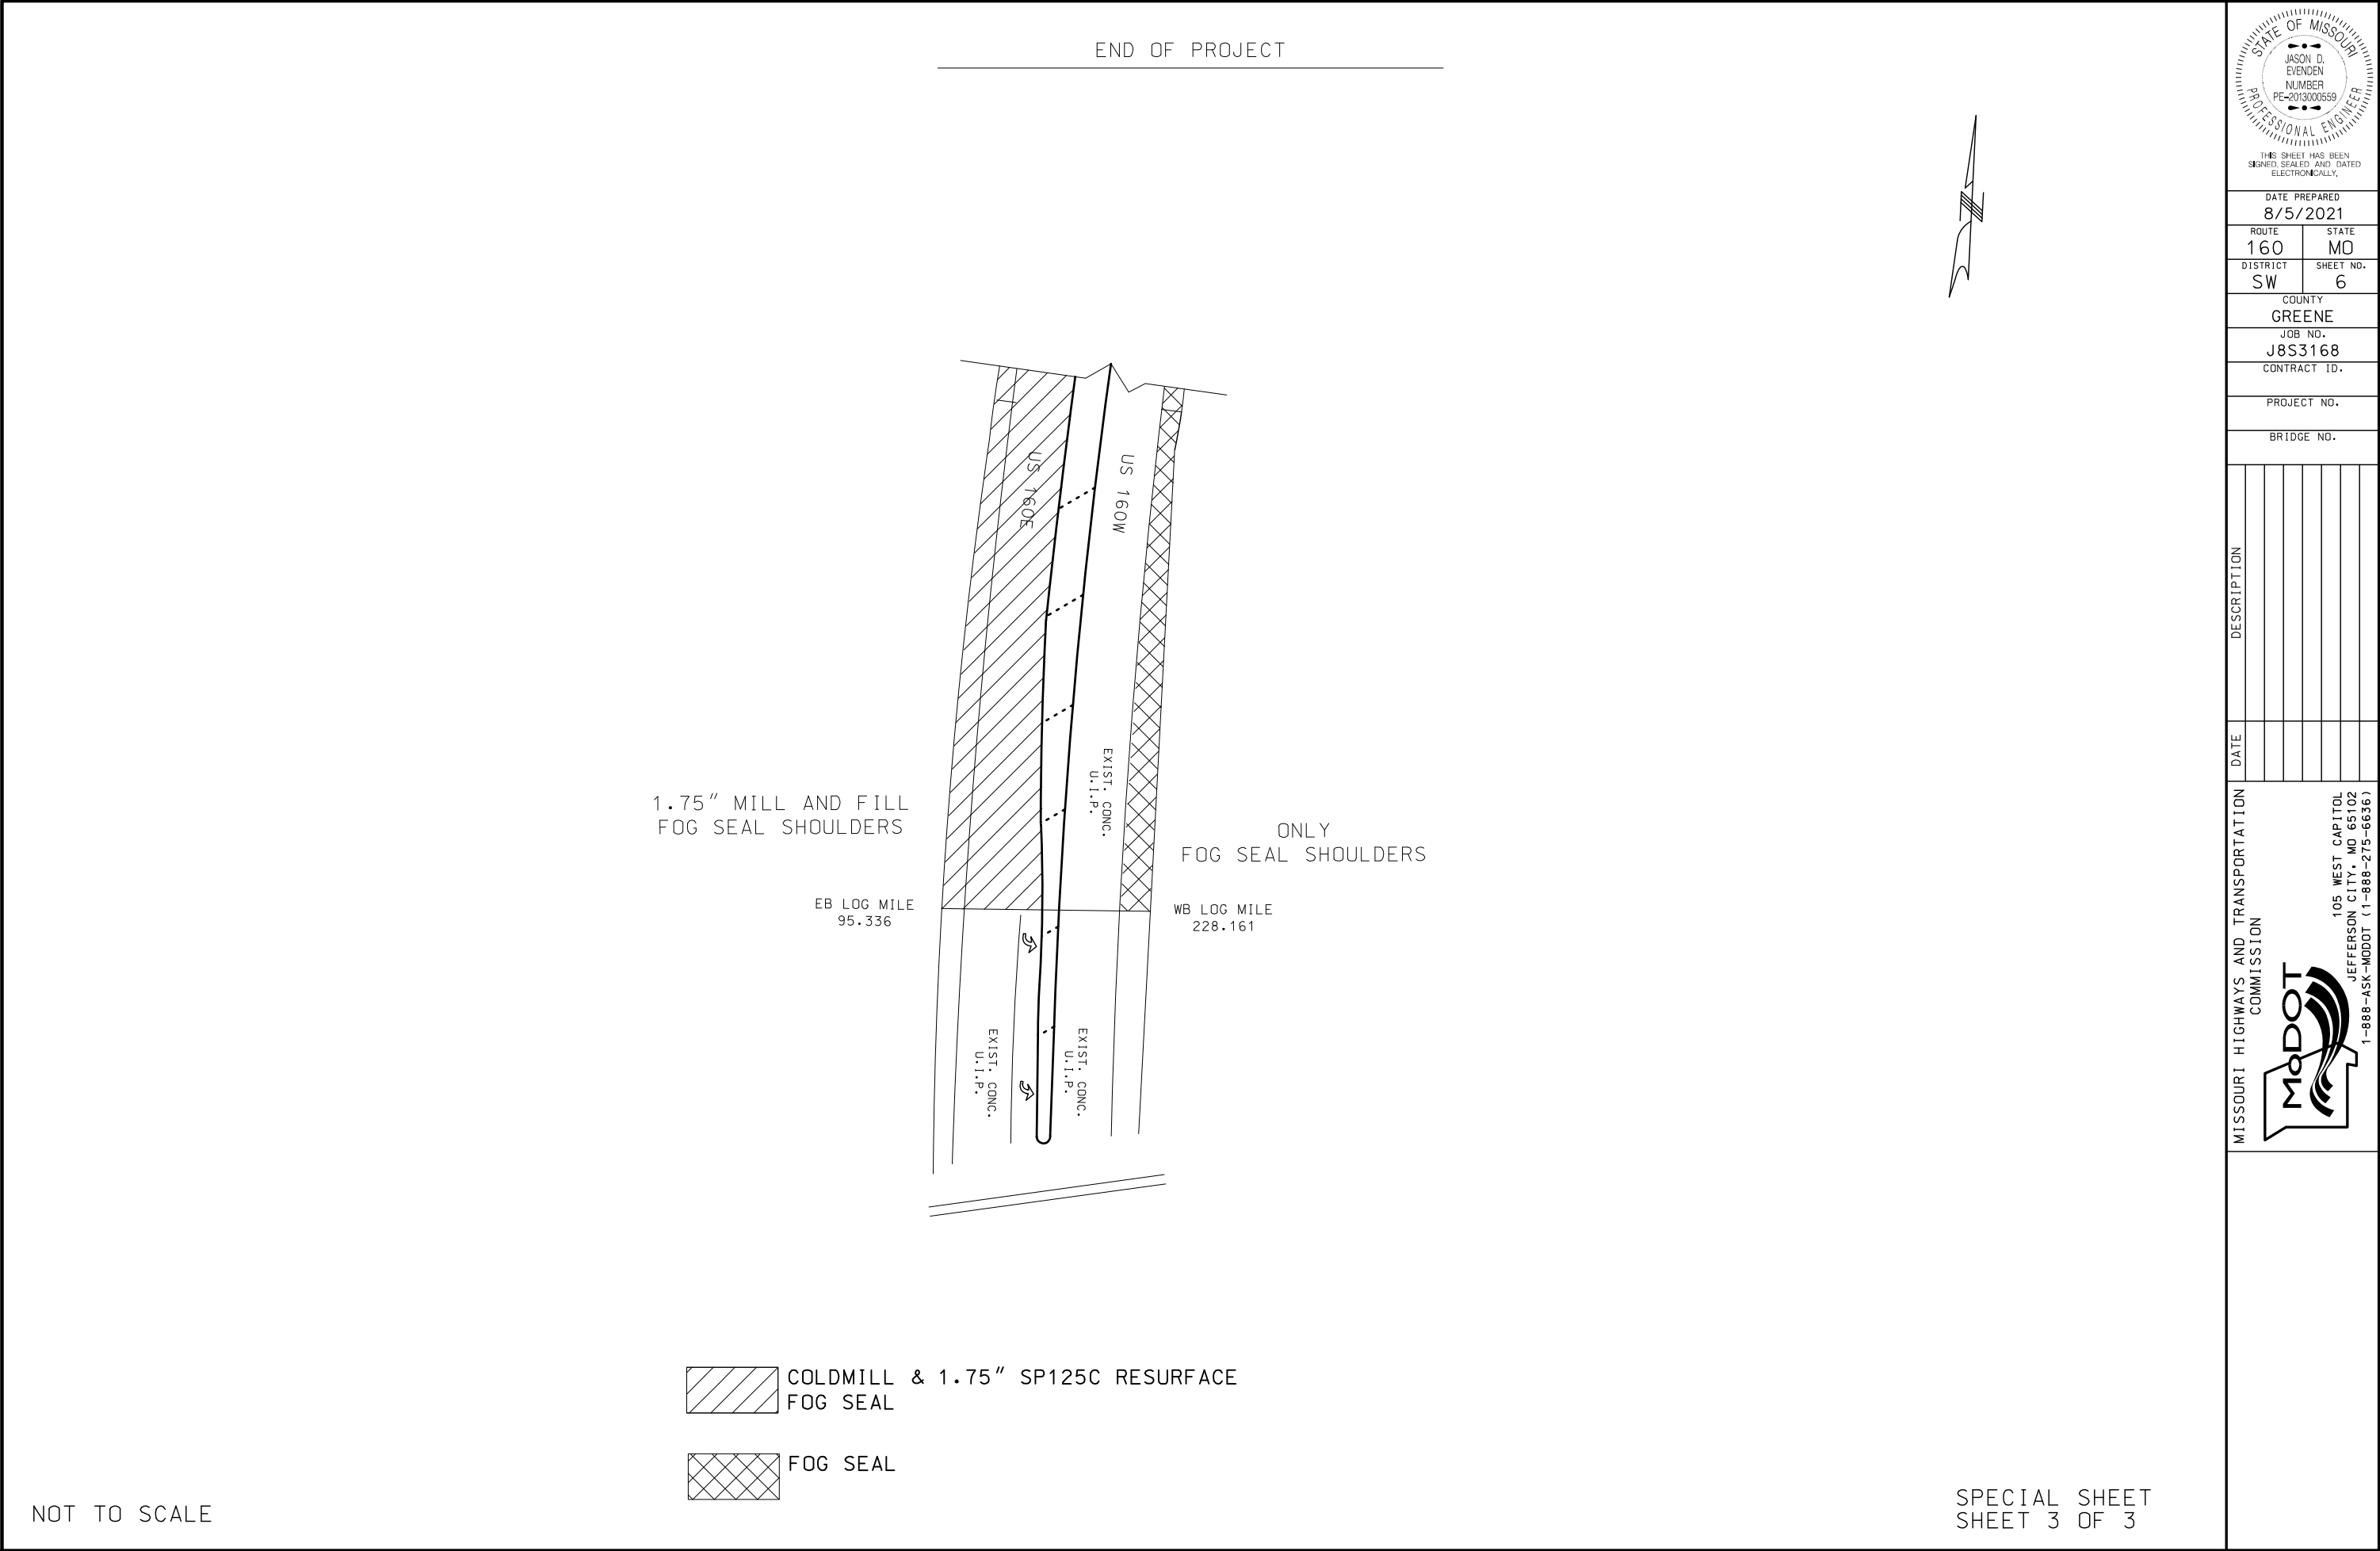

DATE PREPARED 8/5/2021	
ROUTE 160	STATE MO
DISTRICT SW	SHEET NO. 6
COUNTY GREENE	
JOB NO. J8S3168	
CONTRACT ID.	
PROJECT NO.	
BRIDGE NO.	

DATE	DESCRIPTION

MISSOURI HIGHWAYS AND TRANSPORTATION COMMISSION



105 WEST CAPITOL
JEFFERSON CITY, MO 65102
1-888-ASK-MODOT (1-888-275-6636)

 
IF A SEAL IS PRESENT ON THIS SHEET IT HAS BEEN ELECTRONICALLY SEALED AND DATED.



-  COLDMILL & 1.75" SP125C RESURFACE
FOG SEAL
-  FOG SEAL

NOT TO SCALE

SPECIAL SHEET
SHEET 3 OF 3




NOT TO SCALE



LANE TAPER LENGTH BASED ON
12 FT. (STANDARD LANE WIDTH)
OFFSET.

SHALL BE COMPLETELY COVERED OR REMOVED.

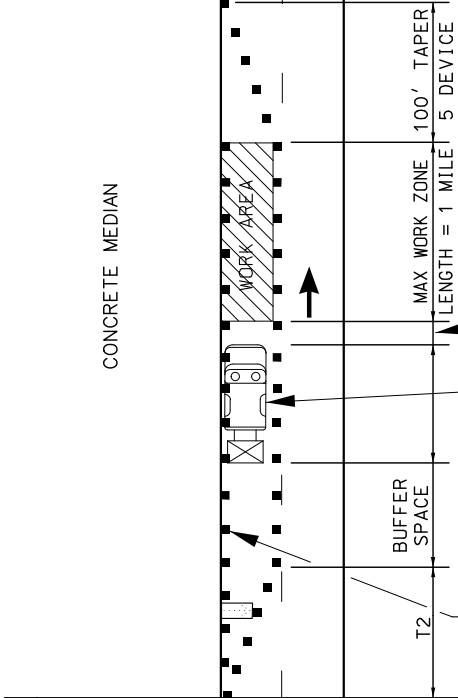

TRAFFIC CONTROL
SHEET 3 OF 6

SIGN SPACING FOR ADVANCE SIGN SERIES	
SPACING BETWEEN SIGNS AND SPACING BETWEEN LAST SIGN AND FLAGGER, BEGINNING OF TAPER, OR SIGNED CONDITION.	
SPACING MAY BE ADJUSTED AS NECESSARY TO MEET FIELD CONDITIONS.	
SPEED	SIGN SPACING (FT)
PERMANENT POSTED (mph)	DIVIDED (S)
0-35	200
40-45	500
50-55	1000
60-70	SA-1000 SB-1500 SC-2640

SHOULDER TAPER LENGTH BASED
ON 10 FT. (STANDARD SHOULDER
WIDTH) OFFSET.

LANE TAPER LENGTH BASED ON
12 FT. (STANDARD LANE WIDTH)
OFFSET.

NOTES:

SEE BEGINNING OF PROJECT SIGNING SHEET FOR ADDITIONAL SIGNS.

TEMPORARY PAVEMENT MARKING REQUIRED WITH LONG TERM LANE CLOSURES, NO DIRECT PAY.

NO DIRECT PAYMENT WILL BE MADE FOR THE RELOCATION OF CHANNELIZERS, CONSTRUCTION SIGNS, OR FLASHING ARROW PANEL.

FOR SHORT TERM OPERATIONS WHERE IT IS NOT FEASIBLE TO MODIFY PAVEMENT MARKING, DEVICE SPACING ARE ONE-HALF OF THE SPACING SHOWN IN THE TABLE.

SPEED LIMIT SIGNS INDICATING THE NORMAL SPEED LIMIT SHALL BE INSTALLED AT THE END OF THE WORK ZONE, PROVIDED NO FURTHER WORK ZONES WILL BE ENCOUNTERED WITHIN THE NEXT 1/2 MILE.

ALL SIGNS, EXCEPT "RATE OUR WORK ZONE" AND "POINT OF PRESENCE", SHALL BE PORTABLE MOUNT AND ARE TO BE MOVED AS WORK PROGRESSES, UNLESS OTHERWISE NOTED. ALL TRAFFIC CONTROL ITEMS SHALL BE REMOVED FROM THE ROADWAY DURING NON-WORKING HOURS.

WORK WILL REQUIRE LANE CLOSURES UNLESS OTHERWISE APPROVED BY THE ENGINEER.

LAYOUT IS TYPICAL FOR EITHER DIRECTION OF TRAFFIC.


SEE STANDARD DRAWING 616.10 FOR ADDITIONAL DETAILS.

ANY EXISTING SIGNING THAT CONFLICTS WITH THE TRAFFIC CONTROL SIGNING SHALL BE COMPLETELY COVERED OR REMOVED.




MISSOURI HIGHWAYS AND TRANSPORTATION
COMMISSION

105 WEST CAPITOL
JEFFERSON CITY, MO 65102

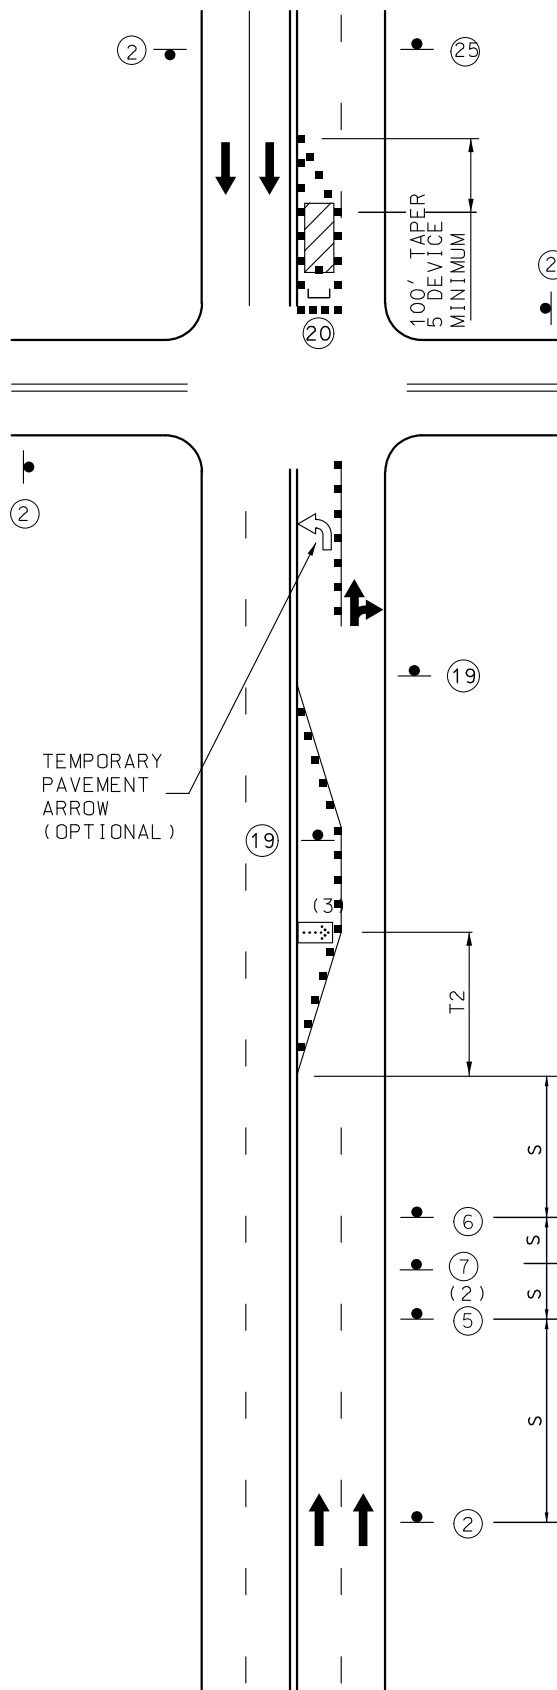

LEFT LANE CLOSURE AT INTERSECTION - NOT TO SCALE

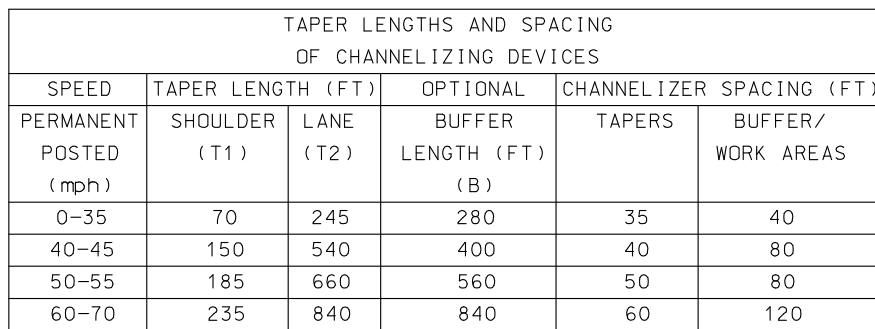


SIGN SPACING FOR ADVANCE SIGN SERIES	
SPACING BETWEEN SIGNS AND SPACING BETWEEN LAST SIGN AND FLAGGER, BEGINNING OF TAPER, OR SIGNED CONDITION.	
SPACING MAY BE ADJUSTED AS NECESSARY TO MEET FIELD CONDITIONS.	
SPEED	SIGN SPACING (FT)
PERMANENT POSTED (mph)	DIVIDED (S)
0-35	200
40-45	500
50-55	1000
60-70	SA-1000 SB-1500 SC-2640



MISSOURI HIGHWAYS AND TRANSPORTATION
COMMISSION

105 WEST CAPITOL
JEFFERSON CITY, MO 65102
1-888-ASK-MDOT (1-888-275-6636)

IF A SEAL IS PRESENT ON THIS SHEET IT HAS BEEN ELECTRONICALLY SEALED AND DATED:

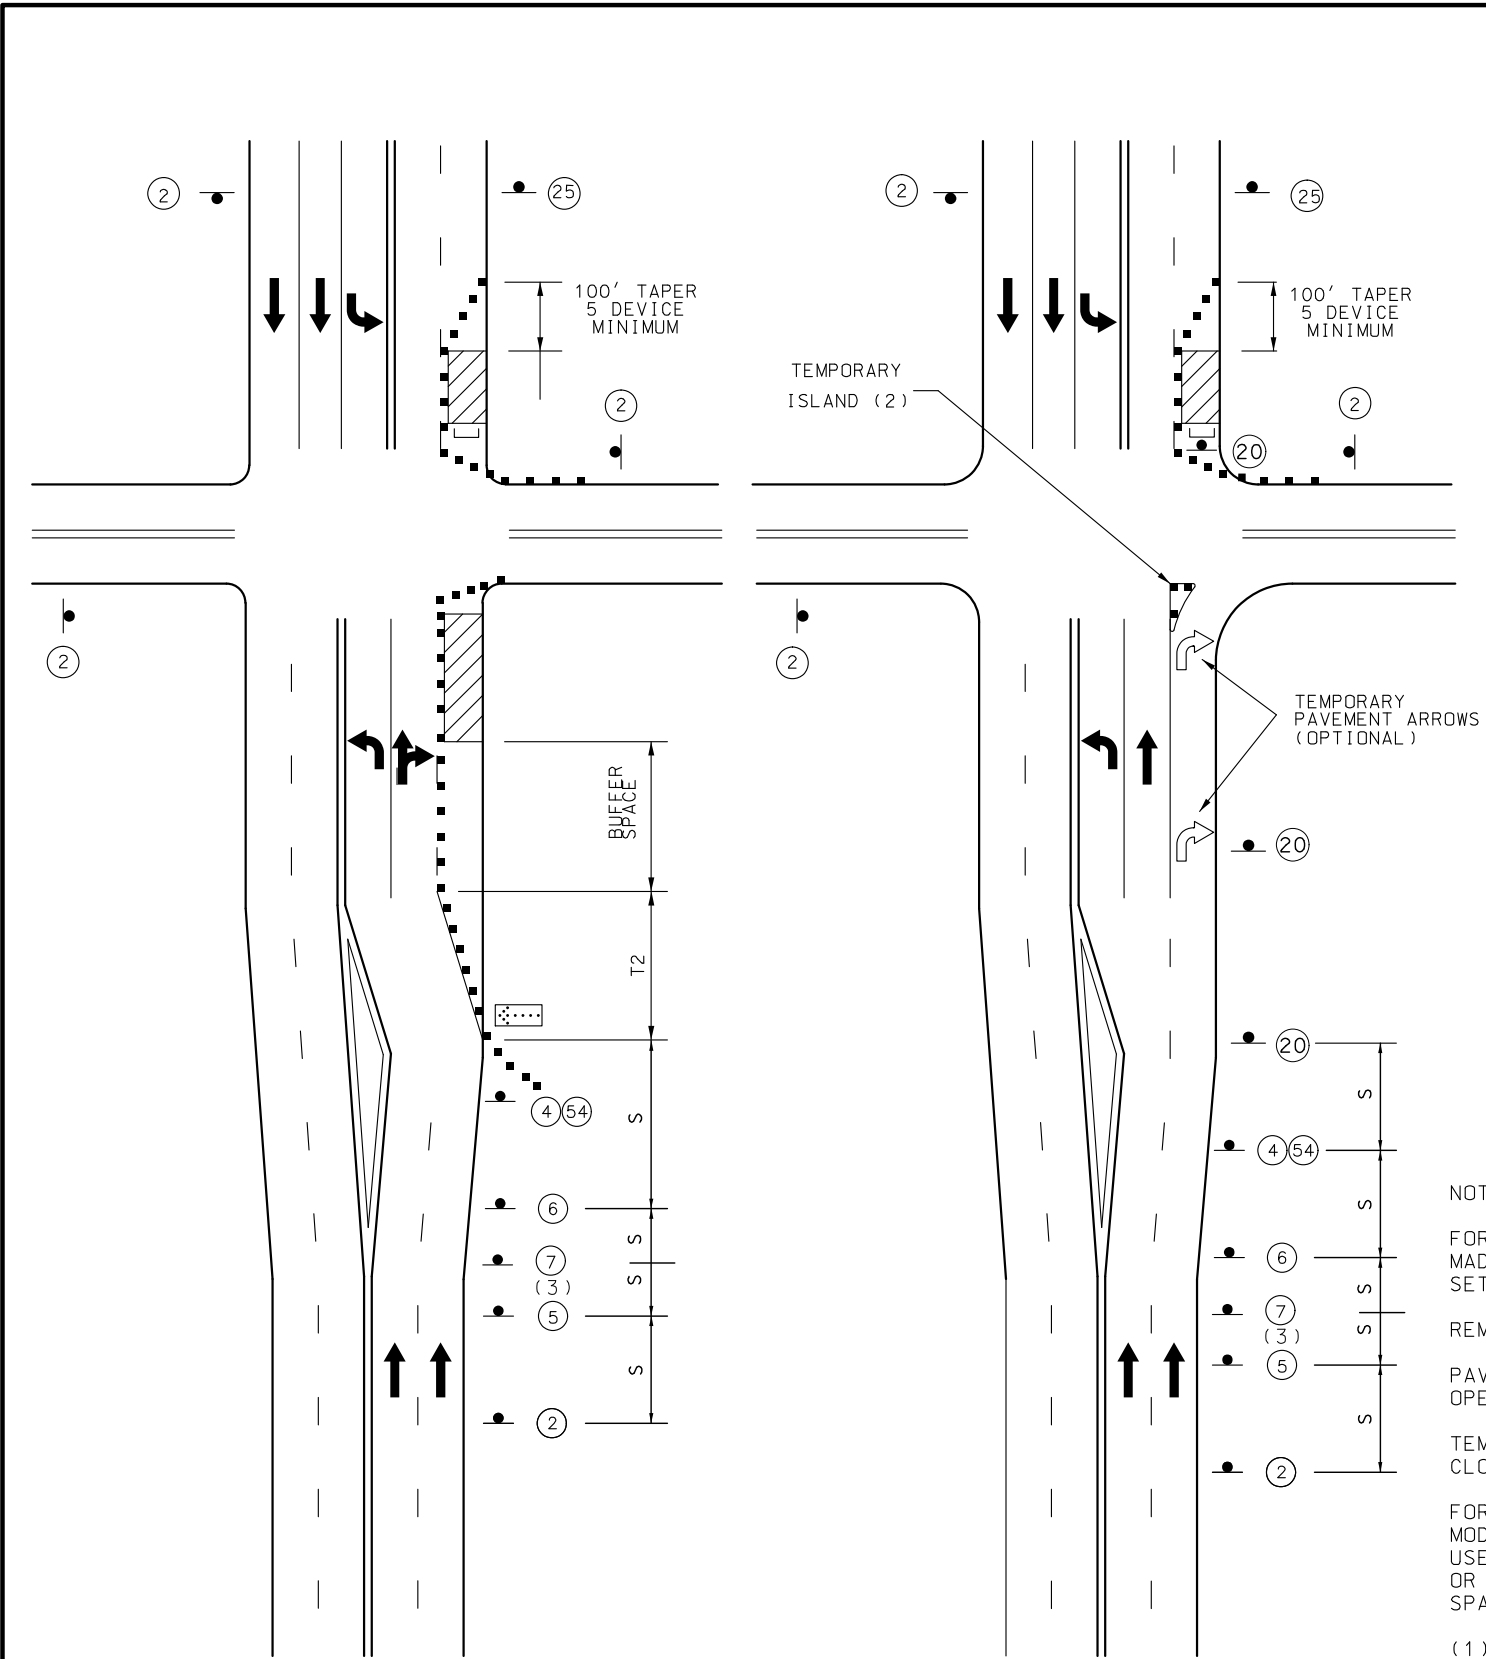


Work On Near Or Far Side

Work On Far Side Only (1)

RIGHT LANE CLOSURE AT INTERSECTION – NOT TO SCALE

TAPER LENGTHS AND SPACING OF CHANNELIZING DEVICES					
SPEED	TAPER LENGTH (FT)		OPTIONAL	CHANNELIZER SPACING (FT)	
PERMANENT POSTED (mph)	SHOULDER (T1)	LANE (T2)	BUFFER LENGTH (FT) (B)	TAPERS	BUFFER/ WORK AREAS
0-35	70	245	280	35	40
40-45	150	540	400	40	80
50-55	185	660	560	50	80
60-70	235	840	840	60	120

SIGN SPACING FOR ADVANCE SIGN SERIES	
SPACING BETWEEN SIGNS AND SPACING BETWEEN LAST SIGN AND FLAGGER, BEGINNING OF TAPER, OR SIGNED CONDITION.	
SPACING MAY BE ADJUSTED AS NECESSARY TO MEET FIELD CONDITIONS.	
SPEED	SIGN SPACING (FT)
PERMANENT POSTED (mph)	DIVIDED (S)
0-35	200
40-45	500
50-55	1000
60-70	SA-1000
	SB-1500
	SC-2640

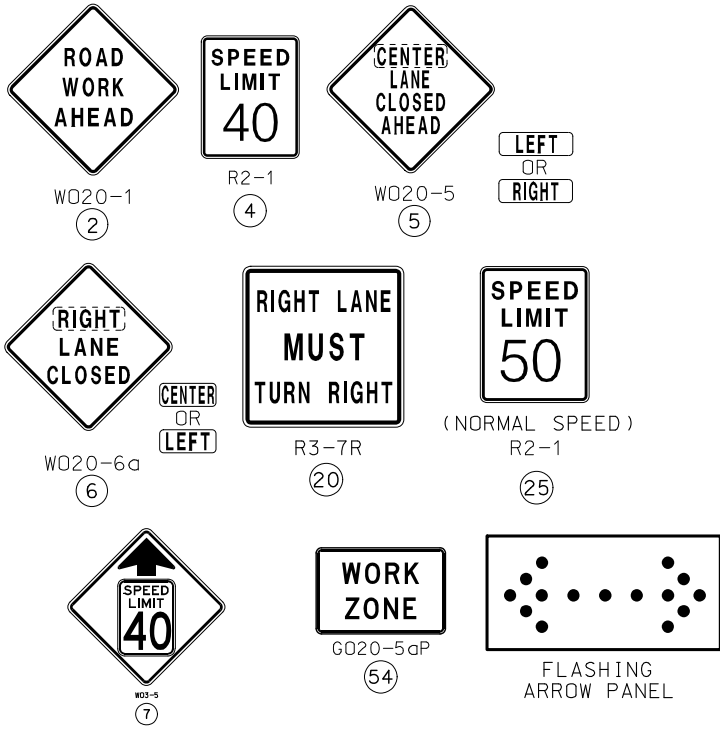

SHOULDER TAPER LENGTH BASED
ON 10 FT. (STANDARD SHOULDER
WIDTH) OFFSET.

LANE TAPER LENGTH BASED ON
12 FT. (STANDARD LANE WIDTH)
OFFSET.



CHANNELIZERS



TYPE 3 MOVEABLE BARRICADE

NOTES:

FOR SIGNALIZED INTERSECTIONS, ADJUSTMENTS MAY NEED TO BE
MADE TO SIGNAL PHASING, TIMING, INDICATIONS OR DETECTOR
SETTINGS.

REMOVE AND/OR MODIFY EXISTING PAVEMENT MARKING AS NEEDED.

PAVEMENT MARKING AND BARRICADES OPTIONAL FOR SHORT TERM
OPERATIONS.

TEMPORARY PAVEMENT MARKING REQUIRED WITH LONG TERM LANE
CLOSURES.

FOR SHORT TERM OPERATIONS, WHERE IT IS NOT FEASIBLE TO
MODIFY PAVEMENT MARKING, A 10' [3 m] DEVICE SPACING IS
USED WHERE TRAFFIC IS GUIDED ACROSS DOUBLE YELLOW LINES
OR OTHER CONFLICTING PAVEMENT MARKING. ALL OTHER
SPACINGS ARE ONE HALF OF THE SPACING SHOWN IN TABLE.

- (1) THIS FIGURE ONLY APPLIES WHERE A SIGNIFICANT
PERCENTAGE OF THE APPROACH VOLUME TURNS RIGHT.
- (2) TEMPORARY ISLAND MAY BE USED TO EMPHASIZE THE
MANDATORY RIGHT TURN MOVEMENT WHERE THERE IS A
SUFFICIENT RIGHT TURN RADIUS.
- (3) SIGN 5 MAY BE OMITTED IN LOW SPEED URBAN AREAS
WHERE THERE IS NOT SUFFICIENT SPACE FOR THE FULL
SIGN SERIES.

STATE OF MISSOURI
JASON D. EVENDEN
NUMBER
PE-2013000659
PROFESSIONAL ENGINEER

THIS SHEET HAS BEEN
SIGNED, SEALED AND DATED
ELECTRONICALLY.

DATE PREPARED
8/5/2021

ROUTE
160

DISTRICT
SW

STATE
MO

SHEET NO.
11

COUNTY
GREENE

JOB NO.
J8S3168

CONTRACT ID.

PROJECT NO.

BRIDGE NO.


DESCRIPTION

DATE

MISSOURI HIGHWAYS AND TRANSPORTATION
COMMISSION

105 WEST CAPITOL
JEFFERSON CITY, MO 65102
1-888-ASK-MODOT (1-888-275-6636)

IF A SEAL IS PRESENT ON THIS SHEET IT HAS BEEN ELECTRONICALLY SEALED AND DATED.

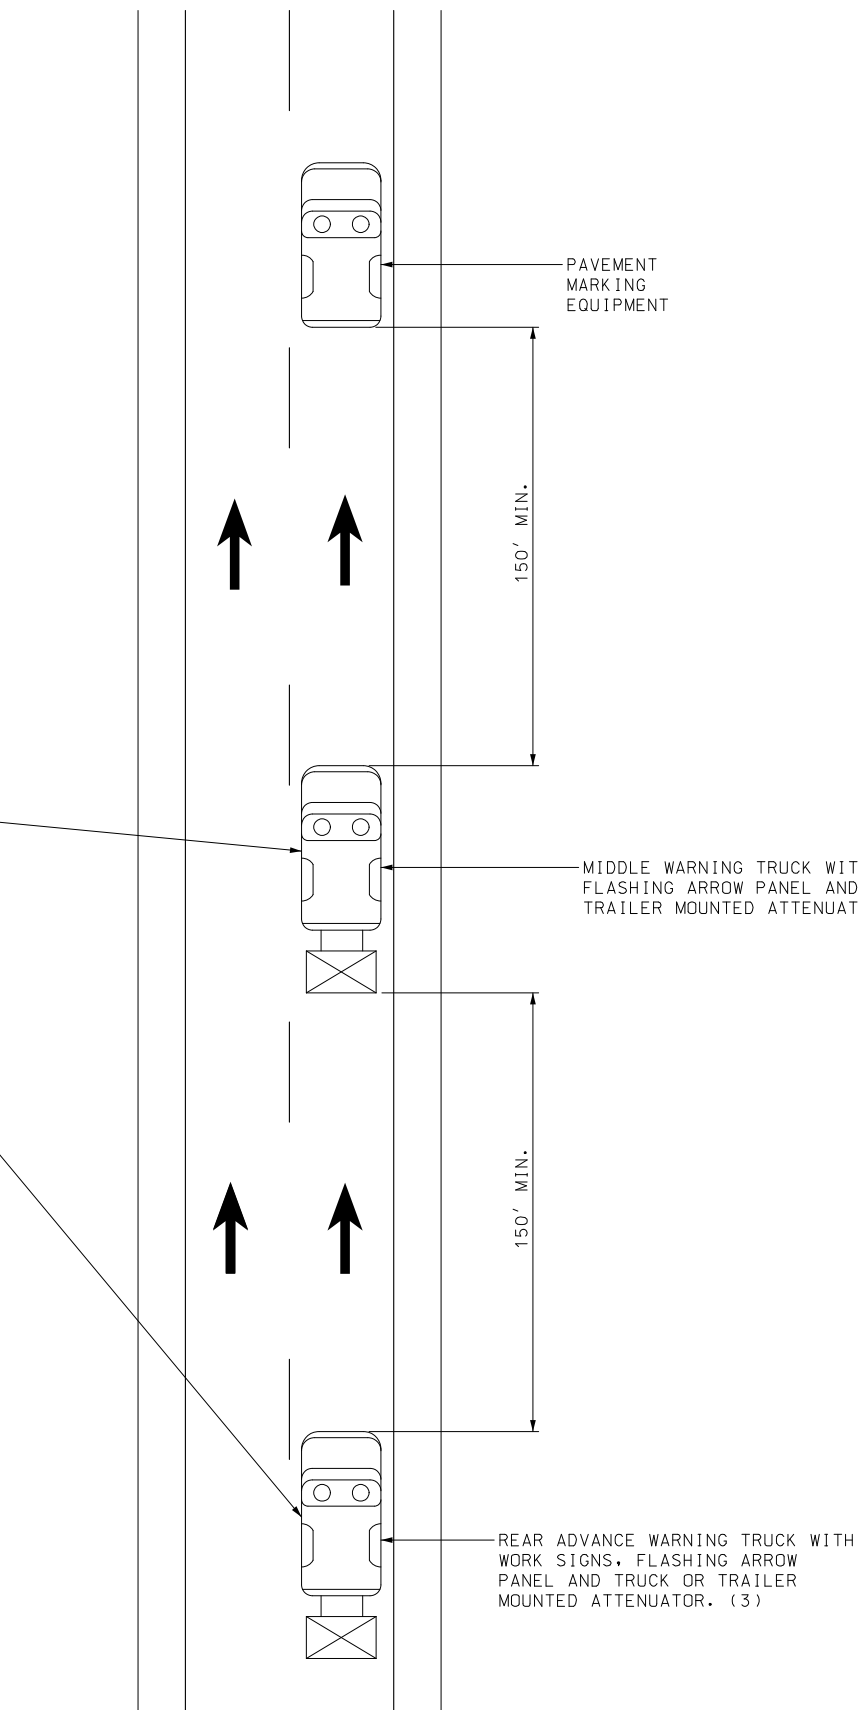

(3) REAR ADVANCE WARNING TRUCK IS POSITIONED AT THE NO TRACK POINT OF THE PAVEMENT MARKING MATERIAL, OR VERTICAL OR HORIZONTAL CURVES THAT RESTRICT SIGHT DISTANCE, OR SPACING SHOWN.

TRAFFIC CONTROL
SHEET 6 OF 6