

DESIGN DESIGNATION

A.A.D.T. - 2025 = 20187
A.A.D.T. - 2045 = 22300
V = 65 M.P.H.

FUNCTIONAL CLASSIFICATION- FREEWAY

MISSOURI HIGHWAYS AND TRANSPORTATION COMMISSION
PLANS FOR PROPOSED
STATE HIGHWAY
JOHNSON COUNTY



BEGIN PROJECT
US 50 WB STA 491+34.54

WB BRIDGE REDECK
GUARDRAIL
APPROACH PAVEMENT

END PROJECT
US 50 WB STA 495+73.72

26W
25W


25W
24W

NOT TO SCALE

CONVENTIONAL SYMBOLS
(USED IN PLANS)

	EXISTING	NEW
BUILDINGS AND STRUCTURES		
GUARD RAIL		
GUARD CABLE		
CONCRETE RIGHT-OF-WAY MARKER		
STEEL RIGHT-OF-WAY MARKER		
LOCATION SURVEY MARKER		
UTILITIES		
FIBER OPTICS	-FO-	-FO-
OVERHEAD CABLE TV	-OTV-	-OTV-
UNDERGROUND CABLE TV	-UTV-	-UTV-
OVERHEAD TELEPHONE	-OT-	-OT-
UNDERGROUND TELEPHONE	-UT-	-UT-
OVERHEAD POWER	-OE-	-OE-
UNDERGROUND POWER	-UE-	-UE-
SANITARY SEWER	-S-	-S-
STORM SEWER	-SS-	-SS-
GAS	-G-	-G-
WATER	-W-	-W-
MANHOLE		
FIRE HYDRANT		
WATER VALVE		
WATER METER		
DROP INLET		
DITCH BLOCK		
GROUND MOUNTED SIGN		
LIGHT POLE		
H-FRAME POWER POLE		
TELEPHONE PEDESTAL		
FENCE		
CHAIN LINK	-V-	-V-
WOVEN WIRE	-X-	-X-
GATE POST		
BENCHMARK		


NOTE: DASHED OR OPEN SYMBOLS INDICATE
EXISTING FEATURES

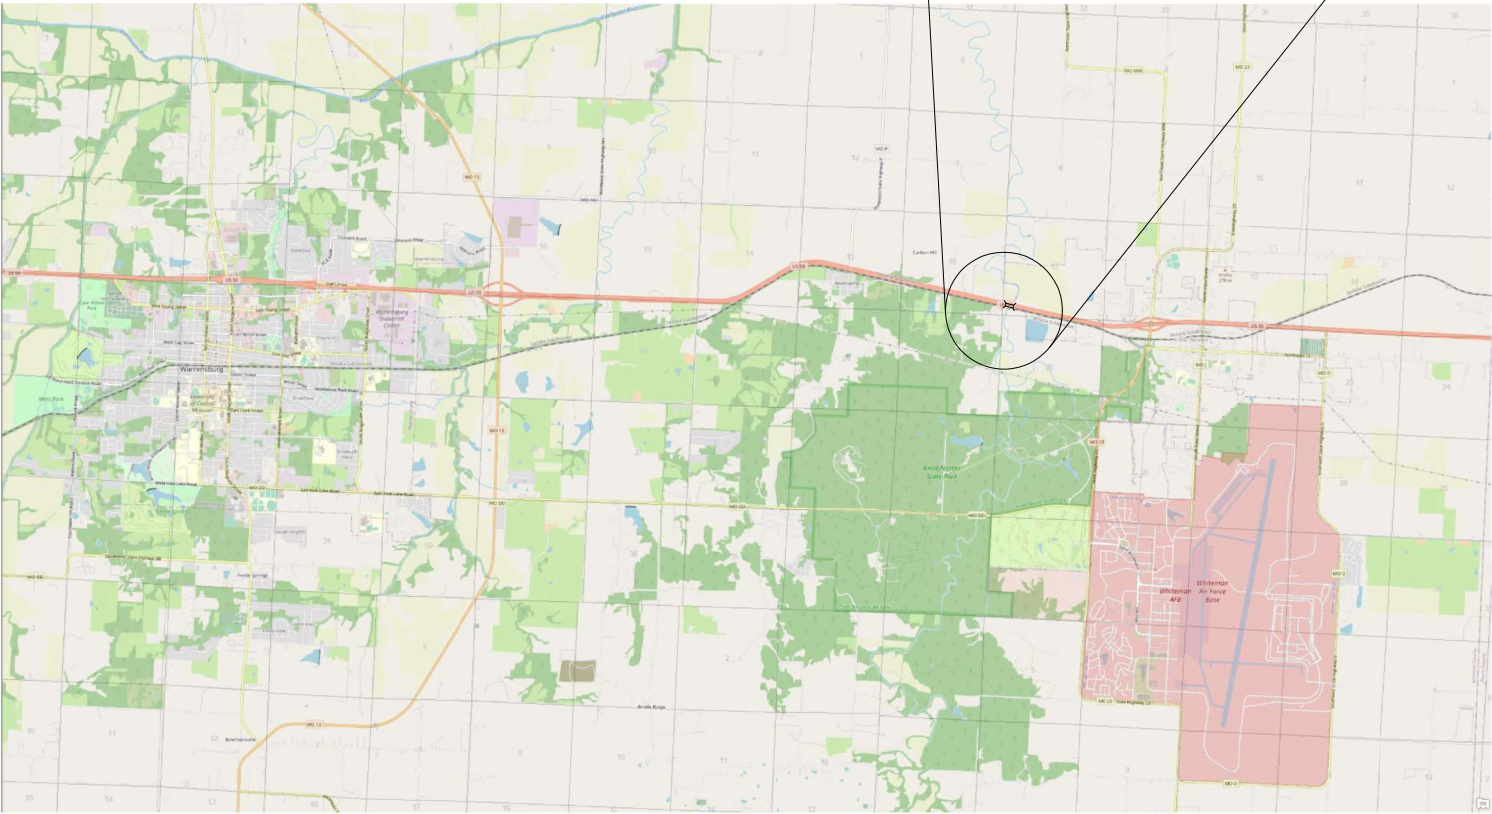

THE EXISTENCE AND APPROXIMATE LOCATION OF UTILITY FACILITIES KNOWN TO EXIST, AS SHOWN ON THE PLANS, ARE BASED ON THE BEST INFORMATION AVAILABLE TO THE COMMISSION AT THIS TIME. THIS INFORMATION IS PROVIDED BY THE COMMISSION "AS-IS" AND THE COMMISSION EXPRESSLY DISCLAIMS ANY REPRESENTATION OR WARRANTY AS TO THE COMPLETENESS, ACCURACY, OR SUITABILITY OF THE INFORMATION FOR ANY USE. RELIANCE UPON THIS INFORMATION IS DONE AT THE RISK AND PERIL OF THE USER, AND THE COMMISSION SHALL NOT BE LIABLE FOR ANY DAMAGES THAT MAY ARISE FROM ANY ERROR IN THE INFORMATION. IT IS, THEREFORE, THE RESPONSIBILITY OF THE CONTRACTOR TO VERIFY THE EXISTENCE, LOCATION AND STATUS OF ANY FACILITY. SUCH VERIFICATION INCLUDES DIRECT CONTACT WITH THE LISTED UTILITIES.

INDEX OF SHEETS

DESCRIPTION	SHEET NUMBER
TITLE SHEET -----	1
TYPICAL SECTIONS (TS) (1 SHEETS)---	2
QUANTITIES (QU) (4 SHEETS)-----	3
PLAN-PROFILE (PP)-----	4-5
REFERENCE POINTS (RP)-----	6
COORDINATE POINTS (CP)-----	7
TRAFFIC CONTROL SHEETS (TC)-----	8-30
EROSION CONTROL SHEETS (EC)-----	31-34
CULVERT SECTIONS (CS)-----	35
BRIDGE DRAWINGS (B)	
L0901-----	1-10
CROSS SECTIONS (XS)-----	1-18

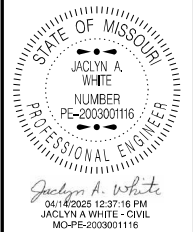

DATE PREPARED
4/14/2025

ROUTE	STATE
50	MO
DISTRICT	SHEET NO.
KC	01

COUNTY
JOHNSON

JOB NO.
JKR0102

CONTRACT ID.

PROJECT NO.

BRIDGE NO.
L0901


DESCRIPTION	DATE

LENGTH OF PROJECT

BEGINNING OF PROJECT	STA. 491 + 34.54
END OF PROJECT	STA. 495 + 73.72
APPARENT LENGTH	439.18 FEET
EQUATIONS AND EXCEPTIONS:	NONE

TOTAL CORRECTIONS	0.0 FEET
NET LENGTH OF PROJECT	439.18 FEET
STATE LENGTH	0.08 MILES
FOR INFORMATION ONLY ESTIMATED DISTURBED ACRES	1.4 ACRES



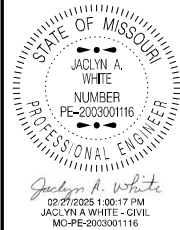


DATE PREPARED 12/31/2024	
ROUTE 50	STATE MO
DISTRICT KC	SHEET NO. 2
COUNTY JOHNSON	
JOB NO. JKR0102	
CONTRACT ID.	
PROJECT NO.	
BRIDGE NO. L0901	

DESCRIPTION	DATE


MISSOURI HIGHWAYS AND TRANSPORTATION COMMISSION



105 WEST CAPITOL
JEFFERSON CITY, MO 65102
1-888-ASK-MODOT (1-888-275-6636)

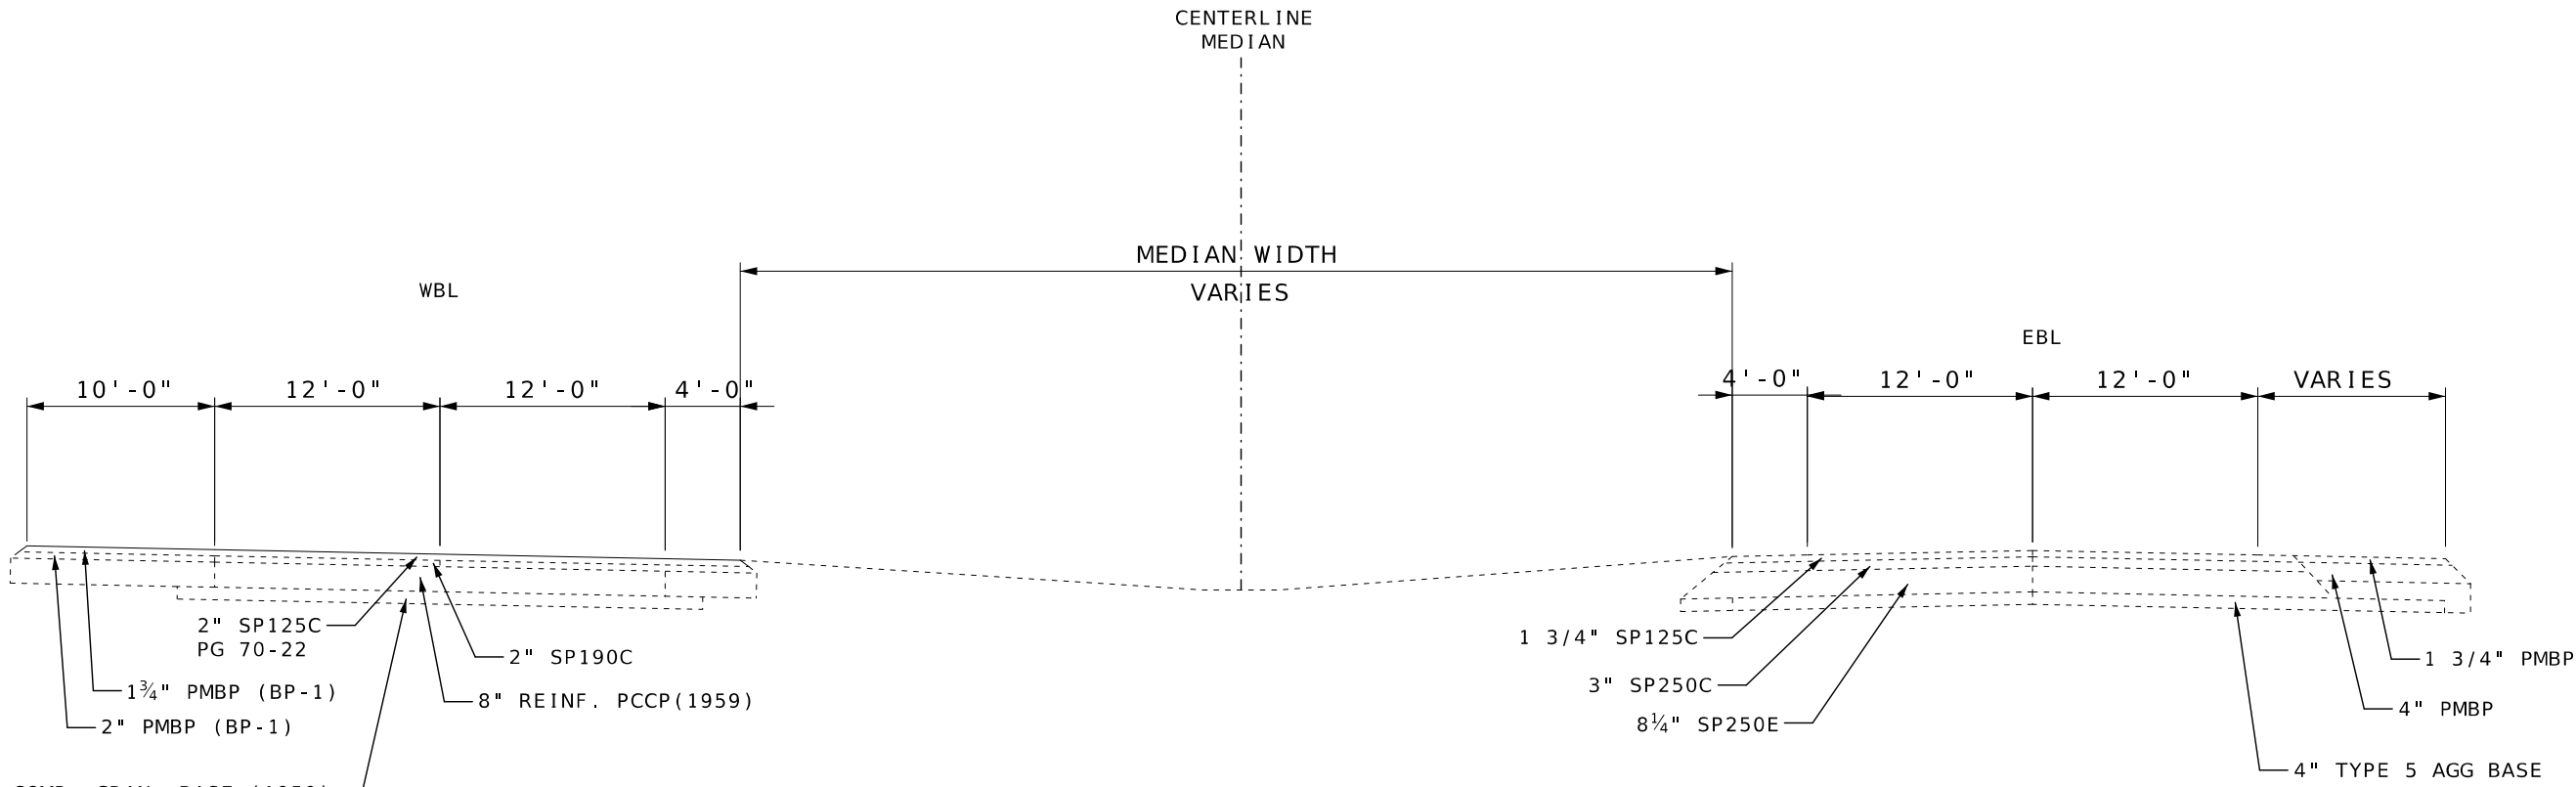

US 50 EXISTING TYPICAL
STA 491+34.54 TO 491+84.54
STA 495+23.72 TO 495+73.72

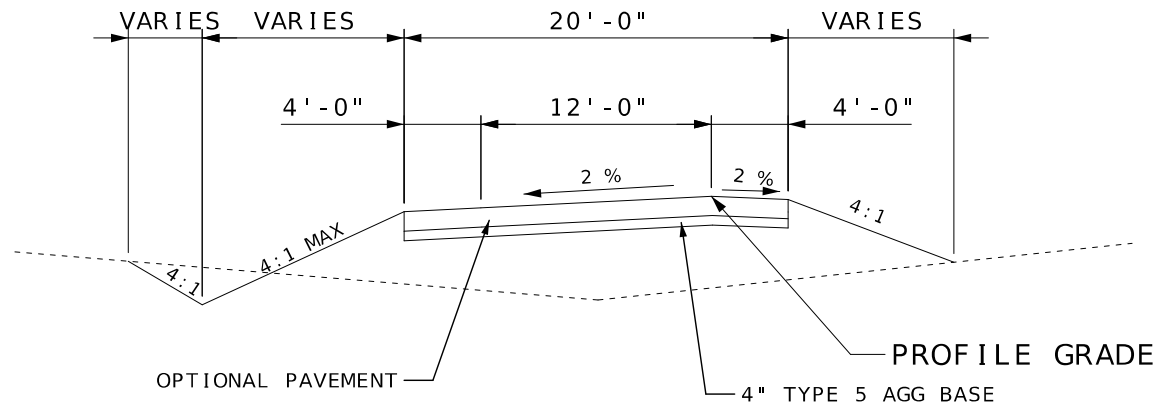

EB AND WB CROSSEVERS
STA 475+72.63 TO 485+18.03
STA 508+47.69 TO 519+33.70

FOR INFORMATION PURPOSES ONLY	
ASPHALTIC CONCRETE MIXTURE PG 70-22 (SP125C)	1.99 TONS/YD ³
TACK COAT	0.10 GAL/YD ³

OPTIONAL PAVEMENT

BITUMINOUS OPTION:
2" BITUMINOUS PAVEMENT MIXTURE PG 64-22 (BP-1)
OVER
5.5" BITUMINOUS PAVEMENT MIXTURE PG 64-22 (BASE)

CONCRETE OPTION:
8" JPCP WIDENED SLAB (15' JOINTS, 1 1/4" DOWELS)


NOT TO SCALE

REMOVAL OF IMPROVEMENTS							
ROADWAY	STATION BEGIN	STATION END	SIDE	DESCRIPTION	QUANTITY	UNITS	REMARKS
WEST CROSSOVER	476+07.70	478+74+89	LT	SAW CUT	306	LF	PHASE 1
WEST CROSSOVER	481+39.72	485+18.03	RT	SAW CUT	384	LF	PHASE 1
EAST CROSSOVER	508+47.69	512+01.92	RT	SAW CUT	357	LF	PHASE 1
EAST CROSSOVER	516+05.26	519+33.70	LT	SAW CUT	333	LF	PHASE 1
WEST CROSSOVER	476+07.70	478+74+89	LT	WB INSIDE SHOULDER	118	SY	PHASE 1
WEST CROSSOVER	481+39.72	485+18.03	RT	EB INSIDE SHOULDER	148	SY	PHASE 1
EAST CROSSOVER	508+47.69	512+01.92	RT	EB INSIDE SHOULDER	138	SY	PHASE 1
EAST CROSSOVER	516+05.26	519+33.70	LT	WB INSIDE SHOULDER	129	SY	PHASE 1
CR 791			RT	ONE WAY	1	EA	PHASE 2
CR 791			LT	STOP SIGN AND ONE WAY	2	EA	PHASE 2
WB US 50	494+41.00		RT	GUARDRAIL	37.5	LF	BRIDGE APROACH TRANSITION REMOVAL
WB US 50	494+58.84		LT	GUARDRAIL	37.5	LF	BRIDGE APROACH TRANSITION REMOVAL
WB US 50	491+84.54		LT/RT	SAW CUT	31.58	LF	PHASE 2
WB US 50	495+23.72		LT/RT	SAW CUT	31.58	LF	PHASE 2
WB US 50	491+84.54	492+10.5		APPROACH PAVEMENT	91.1	SY	PHASE 2
WB US 50	494+74.92	495+23.72		APPROACH PAVEMENT	171.2	SY	PHASE 2
EAST CROSSOVER	512+92.99		LT/RT	TEMP PIPES	580	LF	PHASE 3
WEST CROSSOVER	475+72.63	485+18.03	LT/RT	TEMPORARY PAVEMENT	1052.6	SY	PHASE 3
EAST CROSSOVER	508+47.69	519+33.70	LT/RT	TEMPORARY PAVEMENT	1401.7	SY	PHASE 3
WEST CROSSOVER	476+07.70	478+74+89	LT	SAW CUT	303	LF	PHASE 3
WEST CROSSOVER	481+39.72	485+18.03	RT	SAW CUT	379	LF	PHASE 3
EAST CROSSOVER	508+47.69	512+01.92	RT	SAW CUT	354	LF	PHASE 3
EAST CROSSOVER	516+05.26	519+33.70	LT	SAW CUT	330	LF	PHASE 3
EB US 50	494+32.51	497+45.26	RT	TEMPORARY GUARDRAIL	312.75	LF	PHASE 3
EB US 50	494+08.25	496+08.50	RT	TEMPORARY GUARDRAIL	200.25	LF	PHASE 3
PROJECT TOTAL					1	LUMP SUM	

EARTHWORK							
ROADWAY	STATION BEGIN	STATION END	CONSTR. PHASE	CLASS A EXCAVATION (CY)	COMPACTING EMBANKMENT (CY)	EMBANKMENT IN PLACE (CY)	REMARKS
WEST CROSSOVER	475+72.63	485+18.03	1	201	160	564	
EAST CROSSOVER	508+47.69	519+33.70	1	322	257	136	
			PHASE 1 SUBTOTAL	523	417	700	
WEST CROSSOVER	475+72.63	485+18.03	3	724	201		
EAST CROSSOVER	508+47.69	519+33.70	3	393	322		
			PHASE 3 SUBTOTAL	1117	523	0	
			PAY TOTAL	1640	940	700	

OPTIONAL PAVEMENT					
ROADWAY	STATION BEGIN	STATION END	SIDE	OPTIONAL PAVEMENT (SY)	REMARKS
WEST CROSSOVER	475+72.63	485+18.03	LT/RT	1318.6	CROSSOVER PAVEMENT AND SHOULDER
EAST CROSSOVER	508+47.69	519+33.70	LT/RT	1668.7	CROSSOVER PAVEMENT AND SHOULDER
			PAY TOTAL	2987.3	

AGGREGATE					
ROADWAY	STATION BEGIN	STATION END	SIDE	TYPE 5 AGGREGATE FOR BASE (4") (SY)	REMARKS
WEST CROSSOVER	475+72.63	485+18.03	LT/RT	1319	
EAST CROSSOVER	508+47.69	519+33.70	LT/RT	1669	
WEST CROSSOVER	476+07.70	478+74+89	LT		WB US 50 SHLDR
WEST CROSSOVER	481+39.72	485+18.03	RT		EB US 50 SHLDR
EAST CROSSOVER	508+47.69	512+01.92	RT		EB US 50 SHLDR
EAST CROSSOVER	516+05.26	519+33.70	LT		WB US 50 SHLDR
			PAY TOTAL	2988	

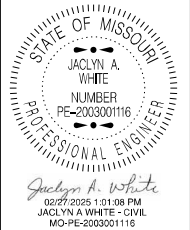

DATE PREPARED 1/7/2025	
ROUTE 50	STATE MO
DISTRICT KC	SHEET NO. 3
COUNTY JOHNSON	
JOB NO. JKR0102	
CONTRACT ID.	

PROJECT NO.
BRIDGE NO. L0901

DESCRIPTION							
DATE							

MISSOURI HIGHWAYS AND TRANSPORTATION COMMISSION

105 WEST CAPITOL
JEFFERSON CITY, MO 65102
1-888-ASK-MODOT (1-888-275-6636)


DRAINAGE								
ROADWAY	STATION BEGIN	OFFSET	STATION END	OFFSET	GROUP A PIPE 12" (LF)	CLASS 3 EXCAVATION (CY)	ROCK LINING (CY)	REMARKS
EAST CROSSOVER	510+87.42	-27.56	513+75	15.3	580	39	4	PARALLEL PIPES 290' EACH

SEEDING				
ROADWAY	STATION BEGIN	STATION END	SIDE	SEEDING COOL SEASON MIXTURES (ACRES)
WEST CROSSOVER	475+72.63	485+18.03	LT/RT	0.7
EAST CROSSOVER	508+47.69	519+33.70	LT/RT	0.7
PAY TOTAL				1.4

TEMPORARY EROSION CONTROL										
ROADWAY	STATION BEGIN	OFFSET	STATION END	OFFSET	CONSTR. PHASE	SEDIMENT TRAP ROCK (CY)	ROCK DITCH CHECK (LF)	TEMPORARY SEEDING & MULCHING (ACRES)	SEDIMENT REMOVAL (CY)	REMARKS
WB US 50 CL	473+96.55	87.11	477+75.01	59.86	2		109		7	WEST CROSSOVER
WB US 50 CL	485+26.92	27.43	488+37.98	32.64	2		23		2	WEST CROSSOVER
WB US 50 CL	475+72.63		481+62.63		2			0.19		WEST CROSSOVER
WB US 50 CL	478+75.75		485+15.87		2			0.21		WEST CROSSOVER
WB US 50 CL	473+96.55	RIGHT			2	12			1	WEST CROSSOVER AT CULVERT OUTLET
WB US 50 CL	476+	LEFT			2	12			1	WEST CROSSOVER AT CULVERT OUTLET
WB US 50 CL	488+37.98	LEFT			2	12			1	WEST CROSSOVER AT CULVERT OUTLET
WB US 50 CL	505+58.10	60.84	507+76.38	66.35	2		46		4	EAST CROSSOVER
WB US 50 CL	505+58.70	-62.62			2	12			1	EAST CROSSOVER AT CULVERT OUTLET
WB US 50 CL	508+48.35		515+98.86		2			0.24		EAST CROSSOVER
WB US 50 CL	512+02.16		519+28.40		2			0.15		EAST CROSSOVER
PAY TOTAL						48	178	0.8	17	

GUARDRAIL							
ROADWAY	STATION BEGIN	STATION END	MGS GUARDRAIL (LF)	MGS BRIDGE APPROACH TRANSITION SECTION (REGULAR/NO CURB) (EACH)	(MASH) TYPE A CRASHWORTHY END TERMINAL (EACH)	SHAPING SLOPES CLASS III (100FT)	REMARKS
EB US 50	494+32.51	497+45.26	225	1	1	0.75	NE CORNER OF BRIDGE A4194 FOR H2H TRAFFIC ON EB US 50
EB US 50	494+08.25	496+08.50	112.5	1	1	0.75	SE CORNER OF BRIDGE A4194 FOR H2H TRAFFIC ON EB US 50
WB US 50	494+41.00			1			SE CORNER OF BRIDGE L0901
WB US 50	494+58.84			1			NE CORNER OF BRIDGE L0901
PAY TOTAL			338	4	2	2	

PERMANENT PAVEMENT MARKING						
LOCATION	STA BEGIN	STA END	LENGTH	6" WHITE HIGH BUILD PAVEMENT MARKING PAINT TYPE L BEADS (LF)	6" YELLOW HIGH BUILD PAVEMENT MARKING PAINT TYPE L BEADS (LF)	REMARKS
US 50 WB CL	468+96.69	521+11.11	5218	1305		WHITE INTERMITTENT LANE LINE
US 50 WB CL	481+39.72	485+18.03	379		379	EDGE LINE
US 50 WB CL	508+47.69	512+01.92	354		354	EDGE LINE
US 50 WB CL	519+29.94	536+09.95	1680	420		WHITE INTERMITTENT LANE LINE
US 50 WB CL	476+07.70	478+74.89	303		303	EDGE LINE
US 50 WB CL	516+05.26	519+33.70	330		330	EDGE LINE
PAY TOTAL				1725	1366	

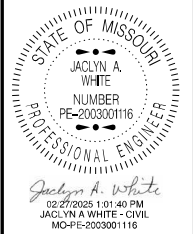

DATE PREPARED	
1/7/2025	
ROUTE	STATE
50	MO
DISTRICT	SHEET NO.
KC	3
COUNTY	
JOHNSON	
JOB NO.	
JKR0102	
CONTRACT ID.	
PROJECT NO.	
BRIDGE NO.	
L0901	

DESCRIPTION										
DATE										

MISSOURI HIGHWAYS AND TRANSPORTATION COMMISSION

105 WEST CAPITOL
JEFFERSON CITY, MO 65102
1-888-ASK-MODOT (1-888-275-6636)

TEMPORARY PAVEMENT MARKING						
LOCATION	STA BEGIN	STA END	LENGTH	4" WHITE (LF)	4" YELLOW (LF)	REMARKS
US 50 WB CL	469+82.10	478+19.38	840			EB LANE - LANE TAPER
US 50 WB CL	478+19.38	483+41.62	523		523	EB LANE
WEST CROSSOVER	475+72.64	483+43.56	771		771	EDGE LINE
WEST CROSSOVER	478+01.84	485+18.03	716	716		EDGE LINE
US 50 WB CL	475+44.48	478+02.28	260	260		WB LANE - LANE TAPER
US 50 WB CL	483+41.62	508+43.96	2504		5008	EB LANE - DOUBLE YELLOW
EAST CROSSOVER	508+43.53	519+33.70	1090		1090	EDGE LINE
EAST CROSSOVER	508+47.69	516+72.98	825	825		EDGE LINE
US 50 WB CL	516+66.96	519+29.94	265	265		WB LANE
US 50 WB CL	519+29.94	527+69.95	840	840		WB LANE
US 50 WB CL	527+69.95	536+09.95	840	840		WB LANE-LANE TAPER
US 50 WB CL	508+43.96	520+09.91	1166		1166	EB LANE
US 50 WB CL	520+09.91	521+10.31	101		101	EB LANE - LANE TAPER
TYPE TOTAL				3746	9499	
TEMPORARY PAVEMENT MARKING TOTAL				13245		


PAVEMENT MARKING REMOVAL		
PHASE	EXISTING PAVEMENT MARKING REMOVAL (LF)	TEMPORARY PAVEMENT MARKING REMOVAL (LF)
1		
2	3091	
3		13245
SUB TOTAL	3091	13245
PAY TOTAL	16336	

MOBILIZATION
1 LUMP SUM

ADDITIONAL MOBILIZATION FOR SEEDING
1 EACH

CONTRACTOR FURNISHED SURVEY & STAKING
1 LUMP SUM

MAINLINE PAVEMENT										
ROADWAY	STATION BEGIN	STATION END	SIDE	LENGTH FT	WIDTH FT	CONCRETE APPROACH PAVEMENT (SY)	2" SP125C PG 70-22 PAVEMENT (TONS)	TACK COAT (GAL)	COLD MILLING 3" OR LESS (SY)	REMARKS
WB US 50	491+34.54	491+84.54	LT/RT	50	31.58		19.5	17.5	175	
WB US 50	491+84.54	492+10.5	LT/RT	25.96	31.58	91.1				
WB US 50	494+74.92	495+23.72	LT/RT	48.8	31.58	171.2				
WB US 50	495+23.72	495+73.72	LT/RT	50	31.58		19.5	17.5	175	
PAY TOTAL						262.3	39	35	350	

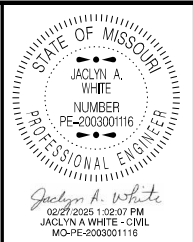

DATE PREPARED	
1/7/2025	
ROUTE	STATE
50	MO
DISTRICT	SHEET NO.
KC	3
COUNTY	
JOHNSON	
JOB NO.	
JKR0102	
CONTRACT ID.	
PROJECT NO.	
BRIDGE NO.	
L0901	

DESCRIPTION	DATE									



MISSOURI HIGHWAYS AND TRANSPORTATION COMMISSION


105 WEST CAPITOL
JEFFERSON CITY, MO 65102
1-888-ASK-MODOT (1-888-275-6636)



STATE OF MISSOURI JACLYN A. WHITE NUMBER PE-200300116 PROFESSIONAL ENGINEER Jacylyn A. White 02/21/2025 1:02:37 PM JACLYN A WHITE - CIVIL MO-PE-200300116									EFFECTIVE: 07-01-2024			
DATE PREPARED 1/7/2025									ROUTE 50		STATE MO	
DISTRICT KC									SHEET NO. 3			
COUNTY JOHNSON									JOB NO. JKR0102			
CONTRACT ID.									PROJECT NO.			
BRIDGE NO. L0901									DESCRIPTION			
DATE									MISSOURI HIGHWAYS AND TRANSPORTATION COMMISSION			
105 WEST CAPITOL JEFFERSON CITY, MO 65102 1-888-ASK-MODOT (1-888-275-6636)									MODOT			

SIGN	SIZE IN.	AREA SQ.FT.	QTY EACH	TOTAL AREA SQ.FT.	QTY RELOC EACH	TOTAL RELOC SQ.FT.	SIGN NUM.	DESCRIPTION	ITEM NUMBER	TOTAL QTY	DESCRIPTION
WARNING SIGNS									GUIDE SIGNS		
WO1-1L	48X48	16.00						TURN (SYMBOL LEFT)	E05-1		GORE EXIT
WO1-1R	48X48	16.00						TURN (SYMBOL RIGHT)	E05-2		EXIT OPEN
WO1-2L	48X48	16.00						CURVE (SYMBOL LEFT)	E05-2a		EXIT CLOSED
WO1-2R	48X48	16.00						CURVE (SYMBOL RIGHT)	GO20-1		ROAD WORK NEXT XX MILES
WO1-3L	48X48	16.00						REVERSE TURN (SYMBOL LEFT)	GO20-2	4	END ROAD WORK
WO1-3R	48X48	16.00						REVERSE TURN (SYMBOL RIGHT)	GO20-4		PILOT CAR FOLLOW ME
WO1-4L	48X48	16.00	2	32.00				REVERSE CURVE (SYMBOL LEFT)	GO20-4a		PILOT CAR IN USE WAIT & FOLLOW
WO1-4R	48X48	16.00	2	32.00				REVERSE CURVE (SYMBOL RIGHT)	GO20-4a		PILOT CAR IN USE WAIT & FOLLOW
WO1-4bL	48X48	16.00						DOUBLE ARROW REVERSE CURVE (SYMBOL LEFT)	GO20-5aP	4	WORK ZONE (PLAQUE)
WO1-4bR	48X48	16.00						DOUBLE ARROW REVERSE CURVE (SYMBOL RIGHT)	MO4-8a		END DETOUR
WO1-4cL	48X48	16.00						TRIPLE ARROW REVERSE CURVE (SYMBOL LEFT)	MO4-9L		DETOUR (LEFT)
WO1-4cR	48X48	16.00						TRIPLE ARROW REVERSE CURVE (SYMBOL RIGHT)	MO4-9R		DETOUR (RIGHT)
WO1-6	60X30	12.50	3	37.50				HORIZONTAL ARROW (SYMBOL)	MO4-9P		STREET NAME (PLAQUE)
WO1-6a	72X36	18.00						HORIZ. ARROW (SYMBOL ON PERMANENT BARRICADE)	MO4-10L		DETOUR ARROW (LEFT)
WO1-7	60X30	12.50						DOUBLE HEAD HORIZONTAL ARROW (SYMBOL)	MO4-10R		DETOUR ARROW (RIGHT)
WO1-7a	72X36	18.00						DOUBLE HEAD HORIZ. ARROW (SYMBOL ON PERM. BARR.)	REGULATORY SIGNS		
WO1-8	18X24	3.00						CHEVRON (SYMBOL)	R1-1		STOP
WO1-8a	30X36	7.50						CHEVRON (SYMBOL FOR DIVIDED HIGHWAYS)	R1-2		YIELD
WO3-1	48X48	16.00						STOP AHEAD (SYMBOL)	R1-2a		TO ONCOMING TRAFFIC (PLAQUE)
WO3-2	48X48	16.00						YIELD AHEAD (SYMBOL)	R1-3P		ALL WAY (PLAQUE)
WO3-3	48X48	16.00						SIGNAL AHEAD (SYMBOL)	R2-1	6	SPEED LIMIT XX
WO3-4	48X48	16.00						BE PREPARED TO STOP	R3-1		NO RIGHT TURN (SYMBOL)
WO3-5	48X48	16.00						SPEED LIMIT AHEAD	R3-2		NO LEFT TURN (SYMBOL)
WO4-1L	48X48	16.00						MERGE (SYMBOL FROM LEFT)	R3-3		NO TURNS
WO4-1R	48X48	16.00	2	32.00				MERGE (SYMBOL FROM RIGHT)	R3-4		NO U-TURN (SYMBOL)
WO4-1aL	48X48	16.00	1	16.00				MERGE (LEFT)	R3-7L		LEFT LANE MUST TURN LEFT
WO4-1aR	48X48	16.00	2	32.00				MERGE (RIGHT)	R3-7R		RIGHT LANE MUST TURN RIGHT
WO5-1	48X48	16.00						ROAD/BRIDGE/RAMP NARROWS	R4-1		DO NOT PASS
WO5-3	48X48	16.00						ONE LANE BRIDGE	R4-2		PASS WITH CARE
WO5-5	48X48	16.00						NARROW LANES	R4-7a		KEEP RIGHT (HORIZONTAL ARROW)
WO6-1	48X48	16.00						DIVIDED HIGHWAY (SYMBOL)	R4-8a		KEEP LEFT (HORIZONTAL ARROW)
WO6-2	48X48	16.00						DIVIDED HIGHWAY END (SYMBOL)	R5-1	2	DO NOT ENTER
WO6-3	48X48	16.00	4	64.00				TWO WAY TRAFFIC (SYMBOL)	R5-1a		WRONG WAY
WO7-3a	30X24	5.00						NEXT XX MILES (PLAQUE)	R6-1L		ONE WAY ARROW (LEFT)
WO8-1	48X48	16.00						BUMP	R6-1R		ONE WAY ARROW (RIGHT)
WO8-2	48X48	16.00						DIP	R6-2L		ONE WAY (LEFT)
WO8-3	48X48	16.00						PAVEMENT ENDS	R6-2R		ONE WAY (RIGHT)
WO8-4	48X48	16.00						SOFT SHOULDER	R9-9		SIDEWALK CLOSED
WO8-5	48X48	16.00						SLIPPERY WHEN WET (SYMBOL)	R9-11L		SIDEWALK CLOSED AHEAD, (ARROW LEFT) CROSS HERE
WO8-6	48X48	16.00						TRUCK CROSSING			SIDEWALK CLOSED AHEAD, (ARROW RIGHT) CROSS HERE
WO8-6c	48X48	16.00						TRUCK ENTRANCE	R9-11R		
WO8-7	36X36	9.00						LOOSE GRAVEL	R10-6		STOP HERE ON RED (45° ARROW)
WO8-7a	36X36	9.00						FRESH OIL / LOOSE GRAVEL	R11-2	6	ROAD CLOSED
WO8-9	48X48	16.00						LOW SHOULDER			
WO8-11	48X48	16.00						UNEVEN LANES	R11-3a		ROAD CLOSED XX MILES AHEAD
WO8-12	48X48	16.00						NO CENTER LINE	R11-4		LOCAL TRAFFIC ONLY
WO8-15	48X48	16.00						GROOVED PAVEMENT			ROAD CLOSED TO THRU TRAFFIC
WO8-15P	30X24	5.00						MOTORCYCLE (PLAQUE)	CONST-3A		FINE SIGN
WO8-17L	48X48	16.00						SHOULDER DROP-OFF (SYMBOL LEFT)	CONST-3X		SPEEDING/PASSING (PLATE)
WO8-17R	48X48	16.00						SHOULDER DROP-OFF (SYMBOL RIGHT)	MISCELLANEOUS SIGNS		
WO8-17P	30X24	5.00						SHOULDER DROP-OFF (PLAQUE)	CONST-5		POINT OF PRESENCE
W10-1	42RND.	9.62						RAILROAD CROSSING	CONST-5		POINT OF PRESENCE
WO12-1	24X24	4.00						DOUBLE DOWN ARROW (SYMBOL)	CONST-8		WORK ZONE NO PHONE ZONE
WO12-2	48X48	16.00						LOW CLEARANCE (SYMBOL)	SPECIAL		RUMBLE STRIP AHEAD
WO12-2x	24X18	3.00						LOW CLEARANCE (PLAQUE)			
WO12-2a	84X24	14.00						OVERHEAD LOW CLEARANCE (FEET AND INCHES)			
WO12-4	120X60	50.00						LOW CLEARANCE XX FT XX IN XX MILES AHEAD			
WO12-5	120X60	50.00						WIDTH RESTRICTION XX FT XX IN XX MILES AHEAD			
WO13-1	30X30	6.25						ADVISORY SPEED (PLAQUE)			
WO16-2	30X24	5.00						XXX FEET (PLAQUE)			
WO16-3	30X24	5.00						X MILE (PLAQUE)			
WO20-1	48X48	16.00	9	144.00				ROAD/BRIDGE/RAMP WORK AHEAD			
WO20-2	48X48	16.00						DETOUR AHEAD			
WO20-3	48X48	16.00						ROAD CLOSED AHEAD	616-10.05		
WO20-4	48X48	16.00						ONE LANE ROAD AHEAD	CONSTRUCTION SIGNS	876	
WO20-5	48X48	16.00	4	64.00				RIGHT/CENTER/LEFT LANE CLOSED AHEAD	616-10.10		
WO20-5a	48X48	16.00						2 RIGHT/CENTER/LEFT LANES CLOSED AHEAD	RELOCATED SIGNS		
WO20-6a	48X48	16.00	2	32.00				RIGHT/CENTER/LEFT LANE CLOSED			
WO20-7a	48X48	16.00						FLAGGER (SYMBOL)			
WO21-2	36X36	9.00						FRESH OIL			
WO21-5	48X48	16.00						SHOULDER WORK / SHOULDER WORK AHEAD			
WO22-1	48X48	16.00						BLASTING ZONE AHEAD			
WO22-2	42X36	10.50						TURN OFF 2-WAY RADIO AND PHONE			
WO22-3	42X36	10.50						END BLASTING ZONE			
GO22-1	21X15	2.19						WET PAINT (ARROW PIVOTS)			

   SUMMARY OF QUANTITIES
SHEET 4 OF 4



			
DATE PREPARED 12/31/2024		105 WEST CAPITOL JEFFERSON CITY, MO 65102 1-888-ASK-MODOT (1-888-275-6636)	
ROUTE 50	STATE MO		
DISTRICT KC	SHEET NO. 4		
COUNTY JOHNSON			
JOB NO. JKR0102			
CONTRACT ID.			
PROJECT NO.			
BRIDGE NO. L0901			
DESCRIPTION			
DATE			
MISSOURI HIGHWAYS AND TRANSPORTATION COMMISSION			

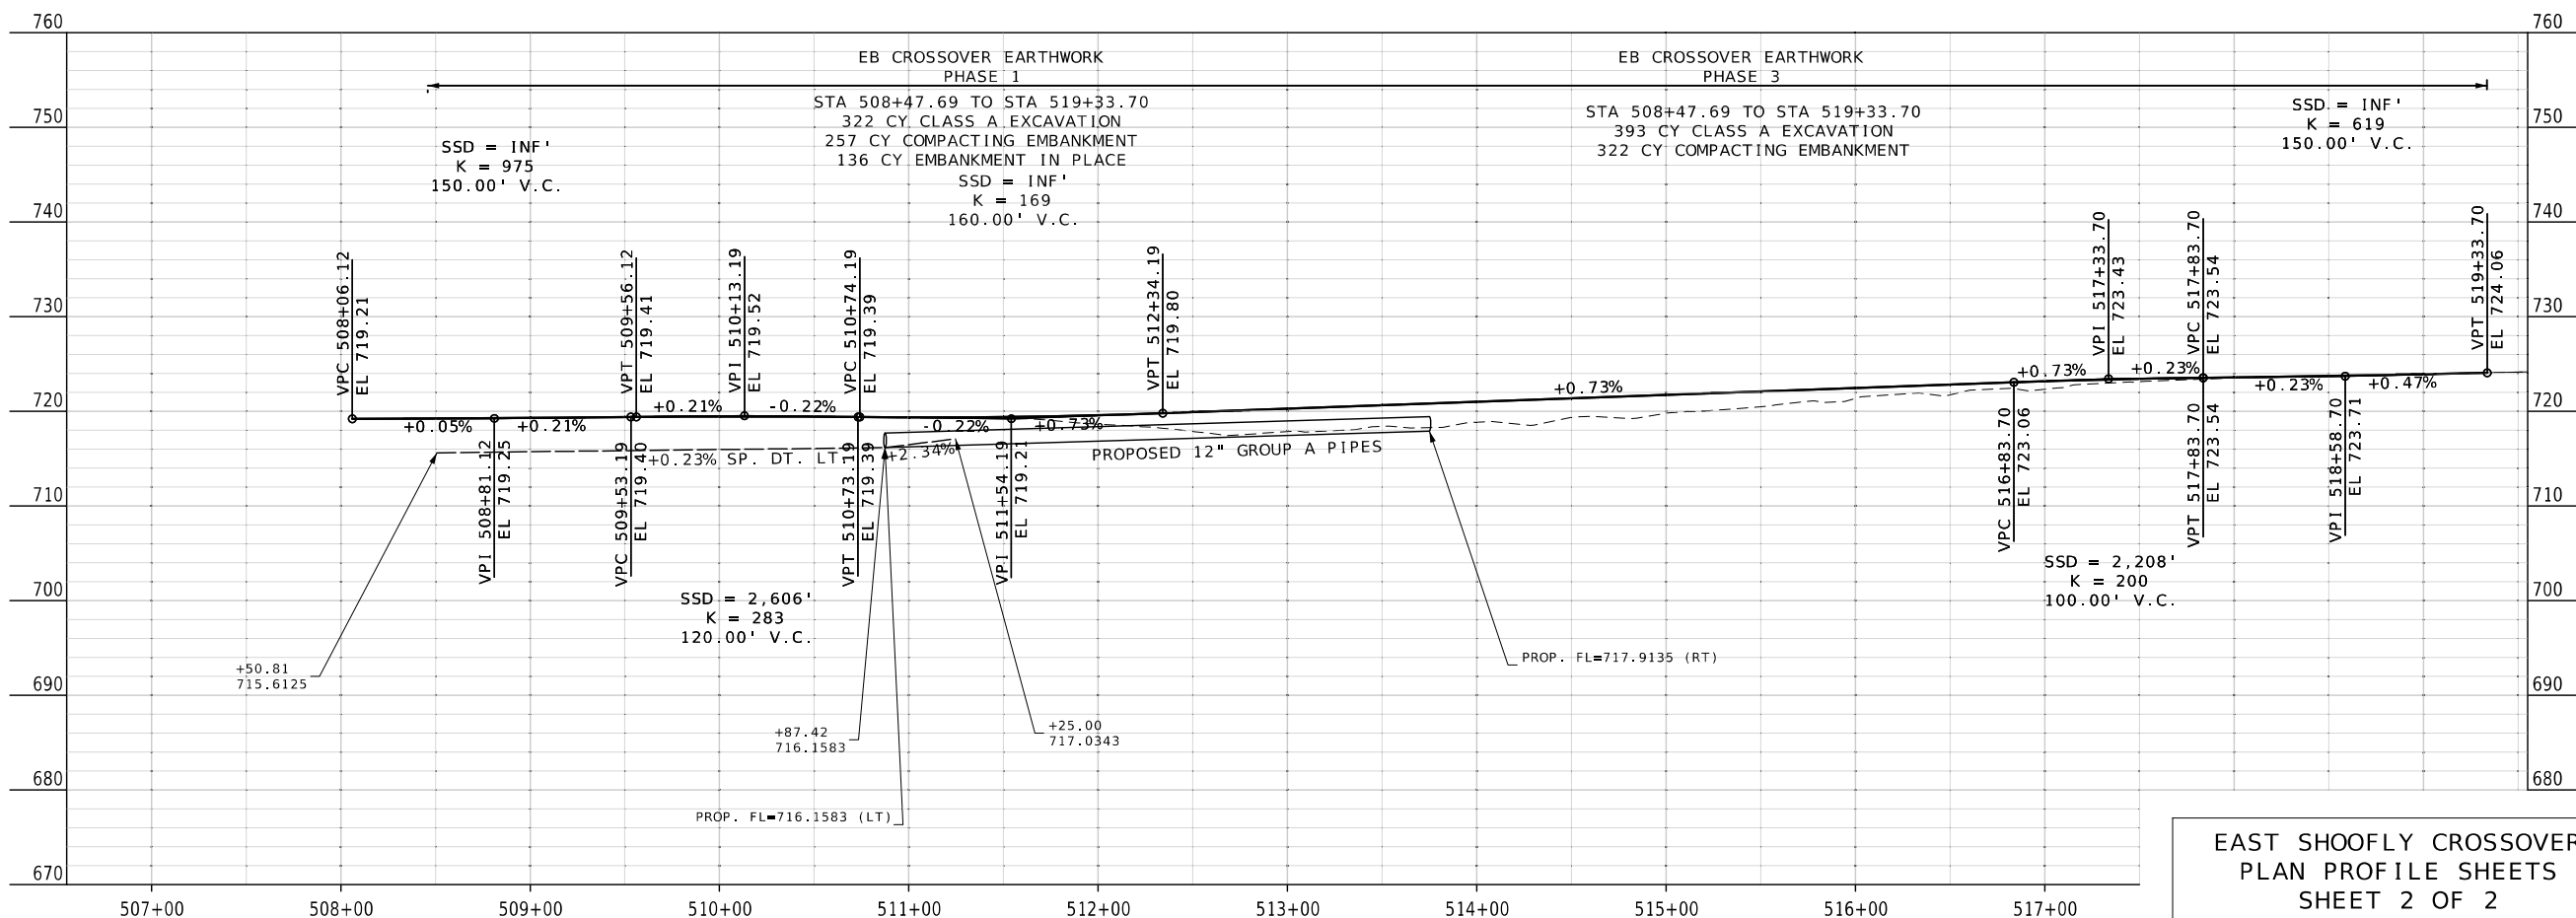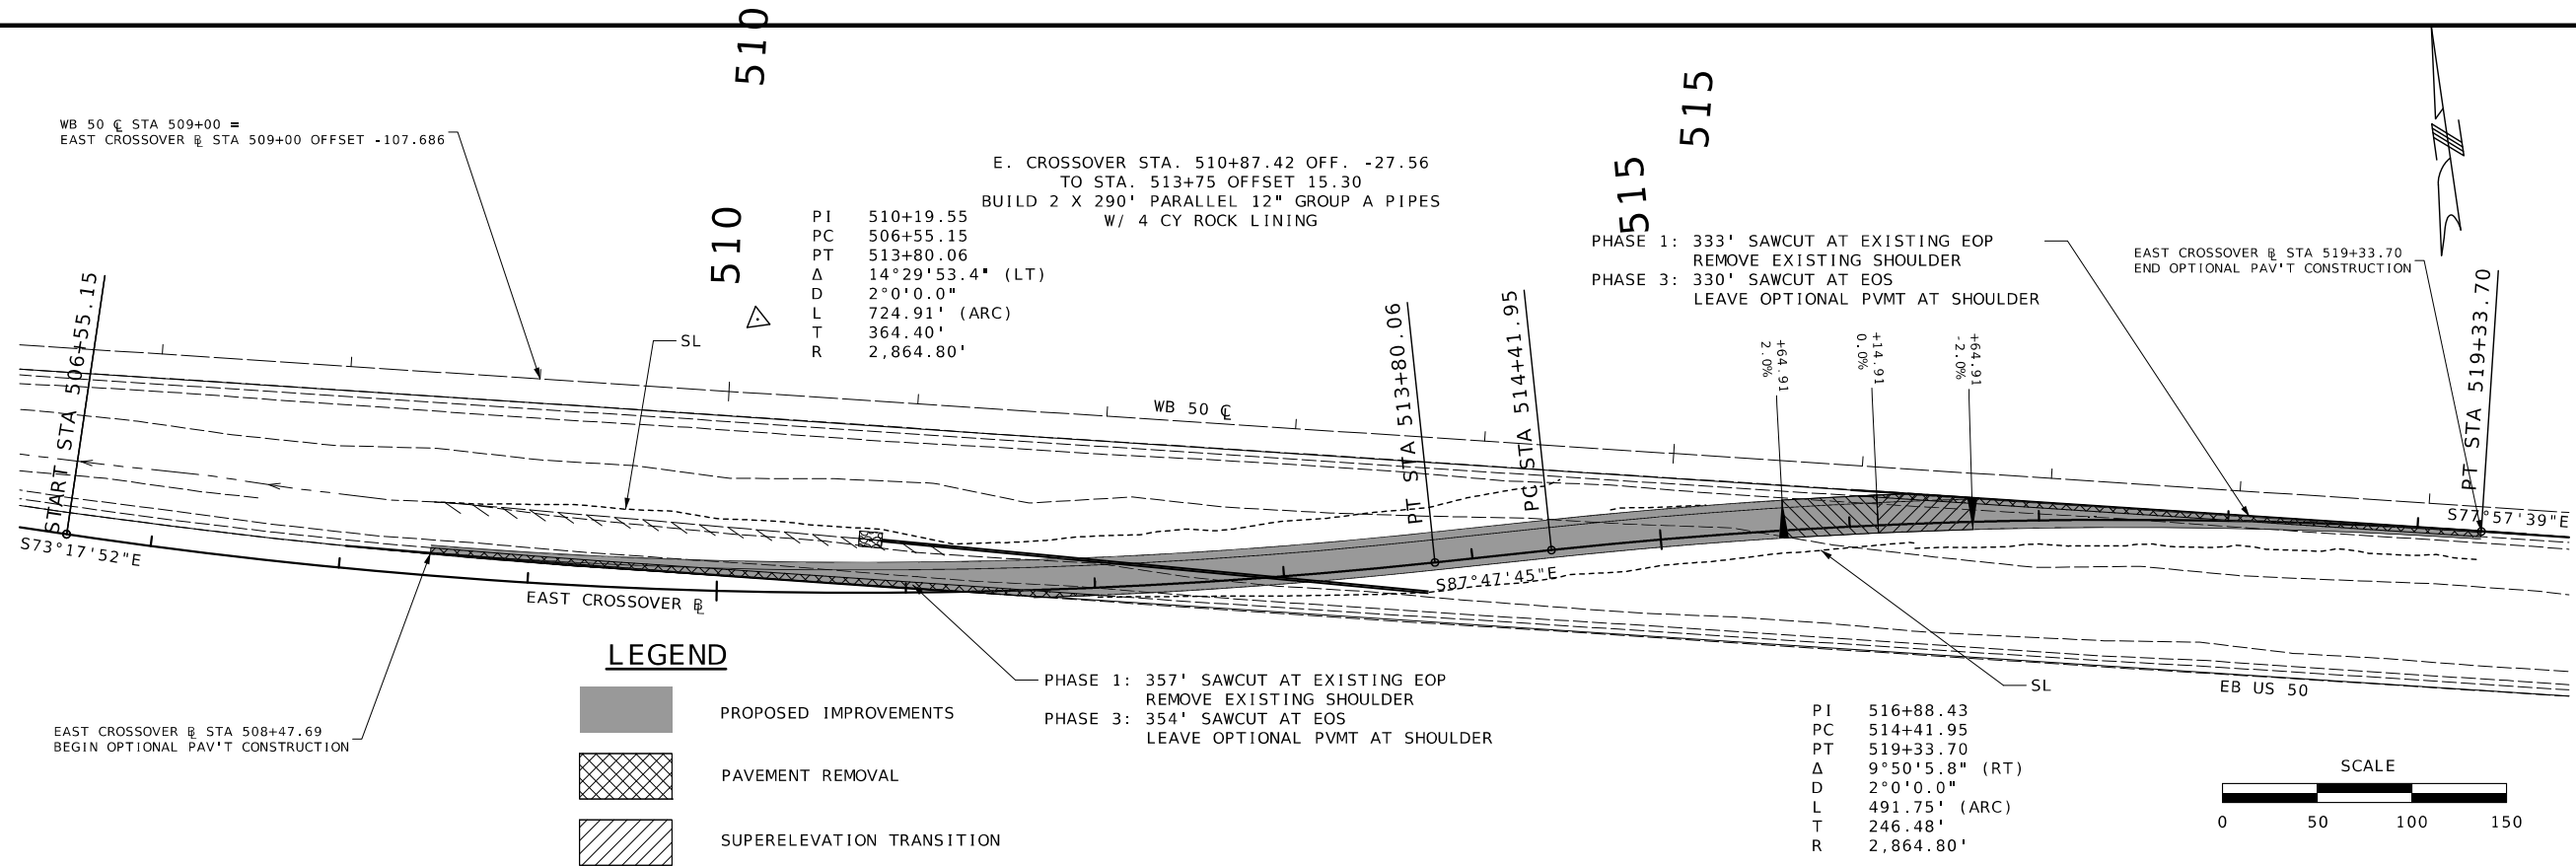

DATE PREPARED 12/31/2024	
ROUTE 50	STATE MO
DISTRICT KC	SHEET NO. 5
COUNTY JOHNSON	
JOB NO. JKR0102	
CONTRACT ID.	
PROJECT NO.	
BRIDGE NO. L0901	

DESCRIPTION	DATE

MISSOURI HIGHWAYS AND TRANSPORTATION
COMMISSION

MoDOT

105 WEST CAPITOL
JEFFERSON CITY, MO 65102
1-888-ASK-MODOT (1-888-275-6636)

POWER POLE
KCPL#1265541

48.82'

17.55'

16.71'

PK NAIL ON
WB US 50
EDGE OF SHOULDER

PK NAIL ON
WB US 50
EDGE OF SHOULDER

Diagram illustrating a circular road layout with dimensions and labels:


- POWER POLE** (KCPL#1265548) is located at the top center.
- WB US 50** is located at the bottom center, with the label **EDGE OF SHOULDER** below it.
- The diagram shows a circle with a central point.
- Dimensions from the center to the edge of the circle:
 - Top: 42.32'
 - Right: 65.78'
 - Bottom: 16.80'
 - Bottom-Right: 65.51'
- Labels on the right side of the circle:
 - MO RAIL SERVICE SIGN POST** (top right)
 - MO RAIL SERVICE SIGN POST** (bottom right)

Diagram illustrating the layout of a circular structure with three power poles (KCPL#1265630, KCPL#1265631, and WB US 50) and their distances from a central point (Edge of Shoulder).

- Distance to KCPL#1265630: 148.52'
- Distance to KCPL#1265631: 140.35'
- Distance to WB US 50: 23.65'

EDGE OF GRAVEL PARKING AREA
IN FRONT OF TAN BUILDING
WITH 3 GARAGE DOORS
773 US 50 HWY

REFERENCE POINTS
SHEET 1 OF 1

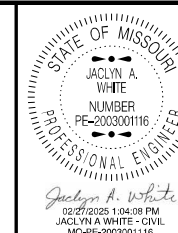

DATE PREPARED

12/31/20

ROUTE	ST
50	1

50	M
DISTRICT	SHEP

KC

COUNTY

JOHNSON

JOB NO.
IKR0102

JKR0102

CONTRACT ID

PROJECT NO. _____

BRIDGE NO.

L0901

[illegible]MISSOURI HIGHWAYS AND TRANSPORTATION
COMMISSION

105 WEST CAPITOL
JEFFERSON CITY, MO 65102

ALL PROJECT COORDINATES HAVE BEEN PROJECTED FROM THE MISSOURI STATE PLANE COORDINATE (SPC) SYSTEM OF 1983 USING AN AVERAGE PROJECT PROJECTION (GRID TO GROUND) FACTOR. TO GET BACK TO STATE PLANE COORDINATES MULTIPLY THE PROJECT COORDINATES BY THE AVERAGE GRID FACTOR AS SHOWN IN THE "REFERENCE CONTROL INFORMATION" PORTION OF THIS TABLE.

PROJECT COORDINATE INFORMATION

COORDINATE SYSTEM	MODIFIED STATE PLANE (GROUND)
HORIZONTAL DATUM	NAD83
VERTICAL DATUM	NAVD88
GEOID MODEL	GEOID18
ELEVATIONS DETERMINED BY	GPS OBSERVATION

PROJECT PROJECTION FACTOR	1.00001290
---------------------------	------------

REFERENCE CONTROL INFORMATION

COORDINATE SYSTEM	MO COORDINATE SYSTEM OF 1983
CONTROL STATION	MO GEOGRAPHIC REFERENCE SYSTEM

DESIGNATION	JO-40
CORS_ID	XX
P ID	101040
LATITUDE	38°45'29.04047"
LONGITUDE	093°34'26.98388"
NORTHING (M)	288000.5040
EASTING (M)	930470.4600
ZONE	WEST

PROJECT AVERAGE GRID FACTOR	0.99998710
-----------------------------	------------

EXAMPLE OF PROJECT COORDINATE TO S.P.C.

```
PROJECT NORTHING X AVERAGE GRID FACTOR
= STATE PLANE NORTHING
PROJECT EASTING X AVERAGE GRID FACTOR
= STATE PLANE EASTING


EXAMPLE: CONTROL POINT #_1_
N 949150.39__ X 0.99998710 = N 949138.15
E 3050910.83__ X 0.99998710 = E 3050517.26
```

LINEAR UNIT CONVERSION

1 METER = 3.280833333 US SURVEY FEET (USFT)

COORDINATE POINT LISTING

SHEET NO	STATION	LOCATION	OFFSET (USFT)	MODIFIED STATE PLANE (GROUND)			DESCRIPTION	GPK POINT ID
				NORTHING (US SURVEY FT)	EASTING (US SURVEY FT)	ELEVATION (US SURVEY FT)		
PROJECT CONTROL POINTS								
	468+99.06	☐ WB US 50	-47.2151	950,342.17	3,045,373.79	753.73	RP #4	
	490+43.65	☐ WB US 50	-44.8502	949,892.79	3,047,470.77	719.42	RP #3	
	510+12.63	☐ WB US 50	-38.9484	949,476.57	3,049,395.27	718.61	RP #2	
	525+62.93	☐ WB US 50	-35.879	949,150.39	3,050,910.87	725.51	RP #1	
ALIGNMENTS								
	435+00	☐ WB US 50	0	3,042,041.82	951,015.04		BEGIN CHAIN	
	450+68.10	☐ WB US 50	0	3,043,573.97	950,681.16		PC CURVE	
	458+51.37	☐ WB US 50		3,044,339.27	950,514.40		HPI CURVE	
	466+34.63	☐ WB US 50	0	3,045,105.33	950,351.12		PT CURVE	
	529+00	☐ WB US 50	0	3,051,233.05	949,045.04		END CHAIN	
	473+87.40	WEST XOVER	0	3,045,838.84	950,181.46		BEGIN CHAIN WEST CROSSOVER	
	476+07.70	WEST XOVER	0	3,046,054.29	950,135.46		PC CURVE 1	
	476+78.94	WEST XOVER		3,046,123.95	950,120.59		HPI CURVE 1	
	477+50.06	WEST XOVER	0	3,046,191.89	95,099.19		PT CURVE 1	
	481+14.62	WEST XOVER	0	3,046,539.60	949,989.64		PC CURVE 2	
	481+84.19	WEST XOVER		3,046,605.96	949,968.73		HPI CURVE 2	
	482.53.66	WEST XOVER	0	3,046,673.96	949,954.06		PT CURVE 2	
	486+01.72	WEST XOVER	0	3,047,014.19	9,498,800.65		END CHAIN WEST CROSSOVER	
	506+55.15	EAST XOVER	0	3,049,017.72	949,416.82		BEGIN CHAIN EAST CROSSOVER	
	506+55.15	EAST XOVER	0	3,049,017.72	949,416.82		PC CURVE 1	
	510+19.55	EAST XOVER		3,049,366.75	949,312.09		HPI CURVE 1	
	513+80.06	EAST XOVER	0	3,049,730.88	949,298.07		PT CURVE 1	
	514+41.95	EAST XOVER	0	3,049,792.72	949,295.69		PC CURVE 2	
	516+88.43	EAST XOVER		3,050,039.02	949,286.21		HPI CURVE 2	
	519+33.70	EAST XOVER	0	3,050,280.08	949,234.80		PT CURVE 2	
	527+47.69	EAST XOVER	0	3,051,076.17	949,065.02		END CHAIN EAST CROSSOVER	

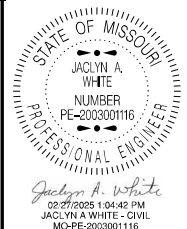

DATE PREPARED	
12/31/2024	
ROUTE	STATE
50	MO
DISTRICT	SHEET NO.
KC	7

COUNTY
JOHNSON

JOB NO.
JKR0102

CONTRACT ID.

PROJECT NO.

BRIDGE NO.	L0901
------------	-------

[illegible]MISSOURI HIGHWAYS AND TRANSPORTATION
COMMISSION

105 WEST CAPITOL
JEFFERSON CITY, MO 65102
1-888-ASK-MODOT (1-888-275-6636)

Sign Spacing, Device Spacing and Channelizing Taper Lengths


SIGN SPACING (S) FOR ADVANCE SIGN SERIES (1) (2)		
SPEED MPH	UNDIVIDED HIGHWAYS	DIVIDED HIGHWAYS
0-35	200	200
40-45	350	500
50-55	500	1000
60-70	1000	SA-1000 SB-1500 SC-2640

LONGITUDINAL BUFFER SPACE (B)	
SPEED MPH	BUFFER SPACE
0 - 35	250
40 - 45	360
50 - 55	495
60 - 70	730

TAPER LENGTHS AND SPACING OF CHANNELIZING DEVICES					
SPEED MPH	MINIMUM TAPER LENGTHS (L) FOR LANE WIDTHS (W)			MAXIMUM CHANNELIZER SPACING	
	10 FT	11 FT	12 FT	THROUGH TAPER	THROUGH WORK AREA
0-35	205	225	245	35	40
40-45	450	495	540	40	80
50-55	550	605	660	50	80
60-70	700	770	840	60	120

TAPER LENGTH (L):
 L = WS FOR 40 MPH OR MORE
 $L = \frac{WS^2}{60}$ FOR 35 MPH OR LESS
 FOR SHOULDER TAPER USE L/3

WHERE:
L = TAPER LENGTH IN FEET
W = LATERAL SHIFT IN FEET
S = POSTED SPEED IN MPH

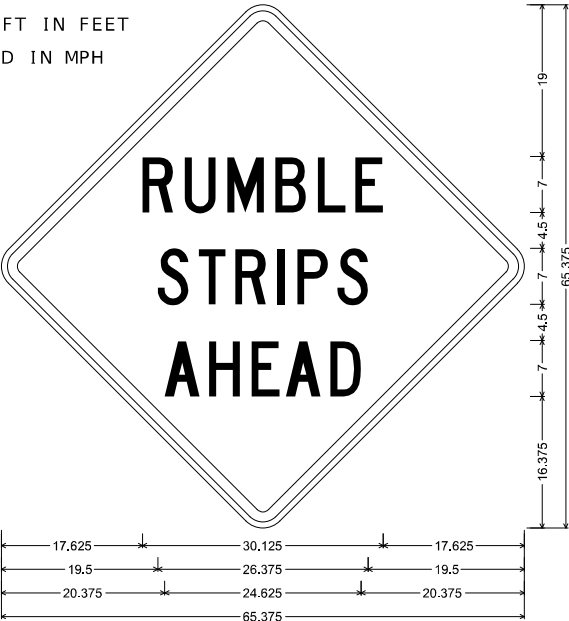

SPECIAL SHF-FLAT SHEET FLUORESCENT;
48.000" across sides 3.000" Radius, 1.250" Border, 0.750" Indent, Black on, Orange;
"RUMBLE", C; "STRIPS", C; "AHEAD", C;
Table of letter and object lefts

R 17.625	U 23.000	M 28.250	B 34.250	L 39.625	E 44.250
S 19.500	T 24.625	R 29.250	I 34.500	P 37.000	S 42.000
A 20.375	H 26.000	E 31.250	A 35.625	D 41.125	


TRAFFIC CONTROL DEVICES

GENERAL NOTES:

1. SEE STANDARD PLAN 616.10 FOR DETAILS AND ITEMS NOT SHOWN
2. EXISTING SIGNS SHALL BE COVERED DURING WORKING HOURS ONLY IF IN CONFLICT WITH TRAFFIC CONTROL PLANS.
3. NO DIRECT PAYMENT WILL BE MADE FOR RELOCATING, COVERING, UNCOVERING OR REMOVING SIGNS.
4. CONES ALLOWABLE FOR DAYTIME OPERATIONS ONLY.
6. LOCATE FLASHING ARROW PANEL AT BEGINNING OF TAPER WHEN FEASIBLE, ARROW PANELS ARE ALWAYS LOCATED BEHIND CHANNELIZERS OR CONES.

TRAFFIC CONTROL LEGEND

- | | |
|---|---|
|  | SIGN (SINGLE SIDED) |
|  | SIGN (DOUBLE SIDED) |
|  | FLAGGER |
|  | DIRECTIONAL INDICATOR BARRICADE |
|  | CHANNELIZER |
|  | BARRICADE |
|  | CHANGEABLE MESSAGE BOARD |
|  | TRUCK MOUNTED ATTENUATOR
W/ FLASHING ARROW |

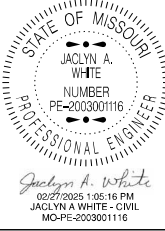

DATE PREPARED
12/31/2024

ROUTE	STATE
50	MO

DISTRICT	SHEET NO
KC	8

COUNTY
JOHNSON

JOB NO.
JKR0102

CONTRACT ID.

PROJECT NO.

BRIDGE NO.
L0901[illegible]



TEMPORARY TRAFFIC CONTROL

SHEET 1 OF 2


TRAFFIC CONTROL LEGEND

- SIGN (SINGLE SIDED)
- CHANNELIZER
- E BARRICADE
- IMPACT ATTENUATOR
- ➡ LANE USE ARROW
- ◆ TUBULAR MARKER
- ▶ DIRECTIONAL INDICATOR BARRICADE
- //// BARRIER HEIGHT TRANSITION
- ▤ WORK AREA
- ⋯ FLASHING ARROW PANELS



*NOTE: INCLUDE ADVANCED WARNING RAIL SYSTEM WITH W020-1

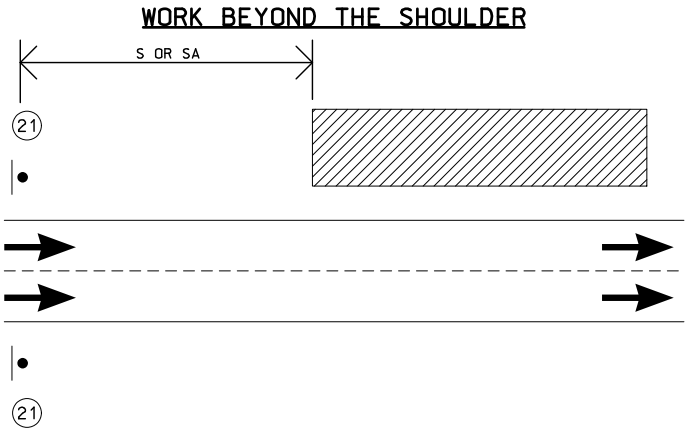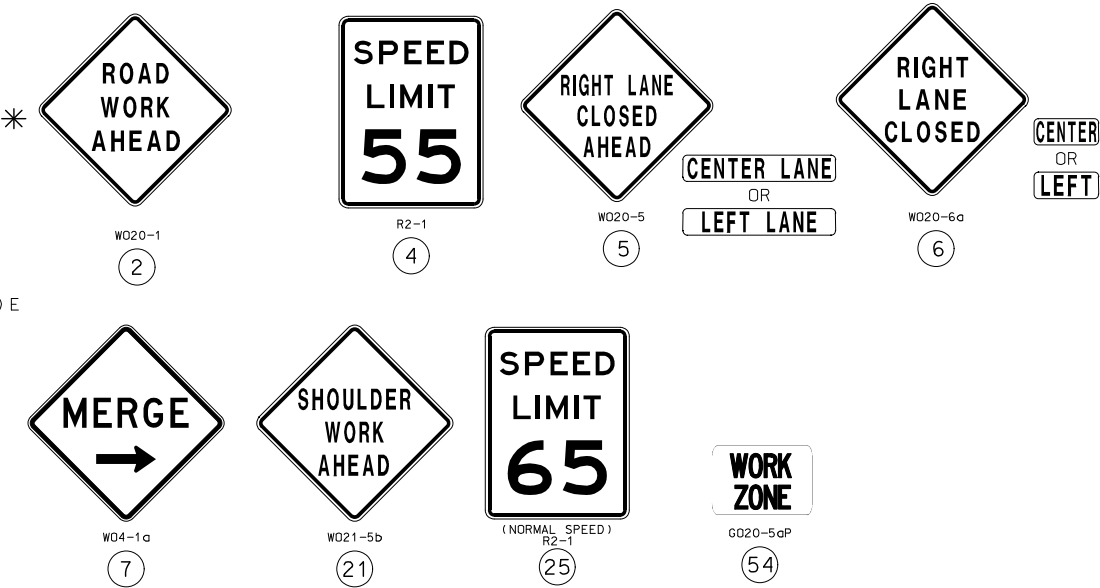

WORK ON SHOULDER WITH NO TRAVELWAY ENCROACHMENT

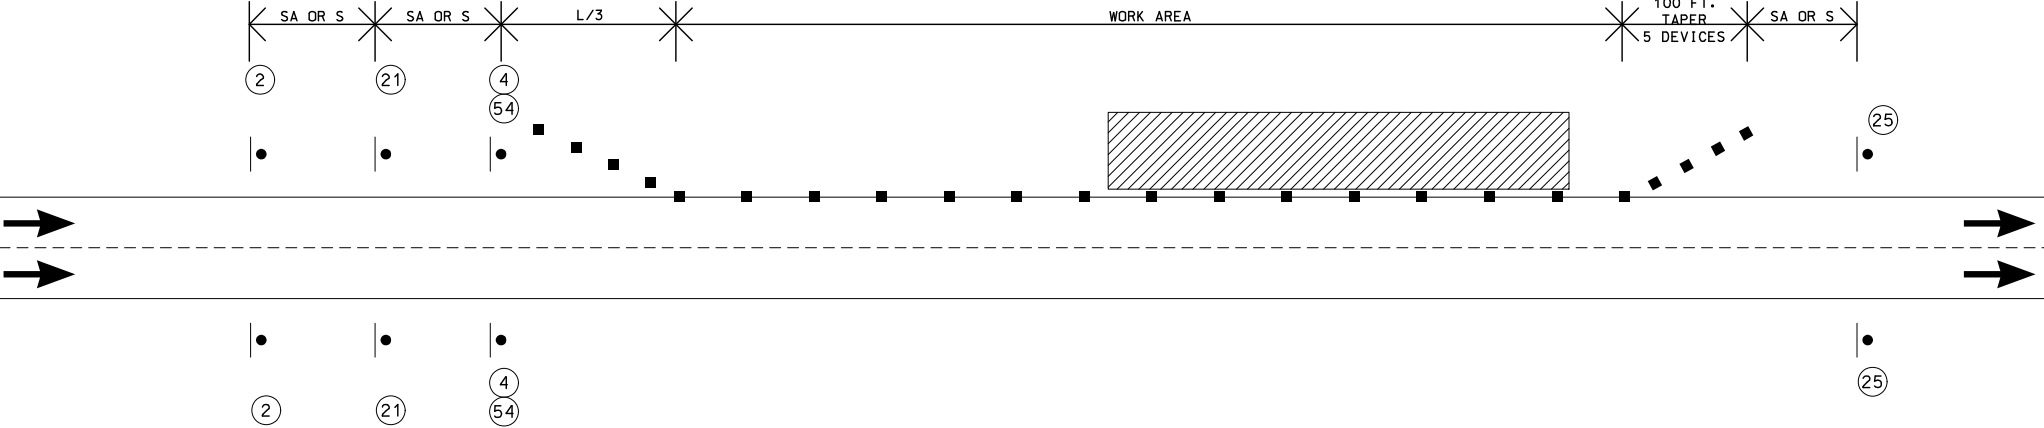

LANE CLOSURE

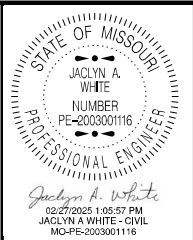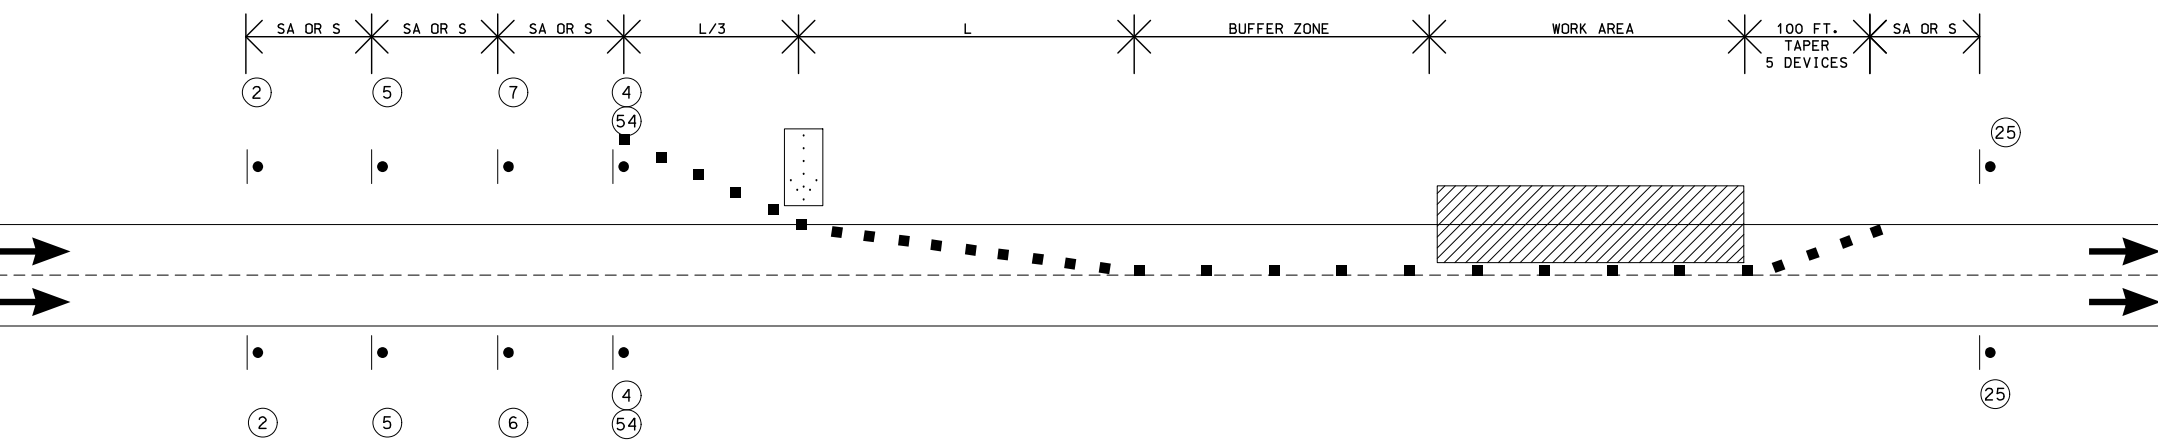

DATE PREPARED 12/31/2024	
ROUTE 50	STATE MO
DISTRICT KC	SHEET NO. 9
COUNTY JOHNSON	
JOB NO. JKR0102	
CONTRACT ID.	
PROJECT NO.	
BRIDGE NO. L0901	

DESCRIPTION	DATE


 
MISSOURI HIGHWAYS AND TRANSPORTATION COMMISSION

105 WEST CAPITOL
JEFFERSON CITY, MO 65102
1-888-ASK-MODOT (1-888-275-6636)

MoDOT

TRAFFIC CONTROL LEGEND

- SIGN (SINGLE SIDED)
- SIGN (DOUBLE SIDED)
- BARRICADE
- DIRECTION INDICATOR BARRICADE
- CHANNELIZER
- TUBULAR MARKER
- CHANGEABLE MESSAGE BOARD
- LANE USE ARROW
- FLASHING ARROW PANEL

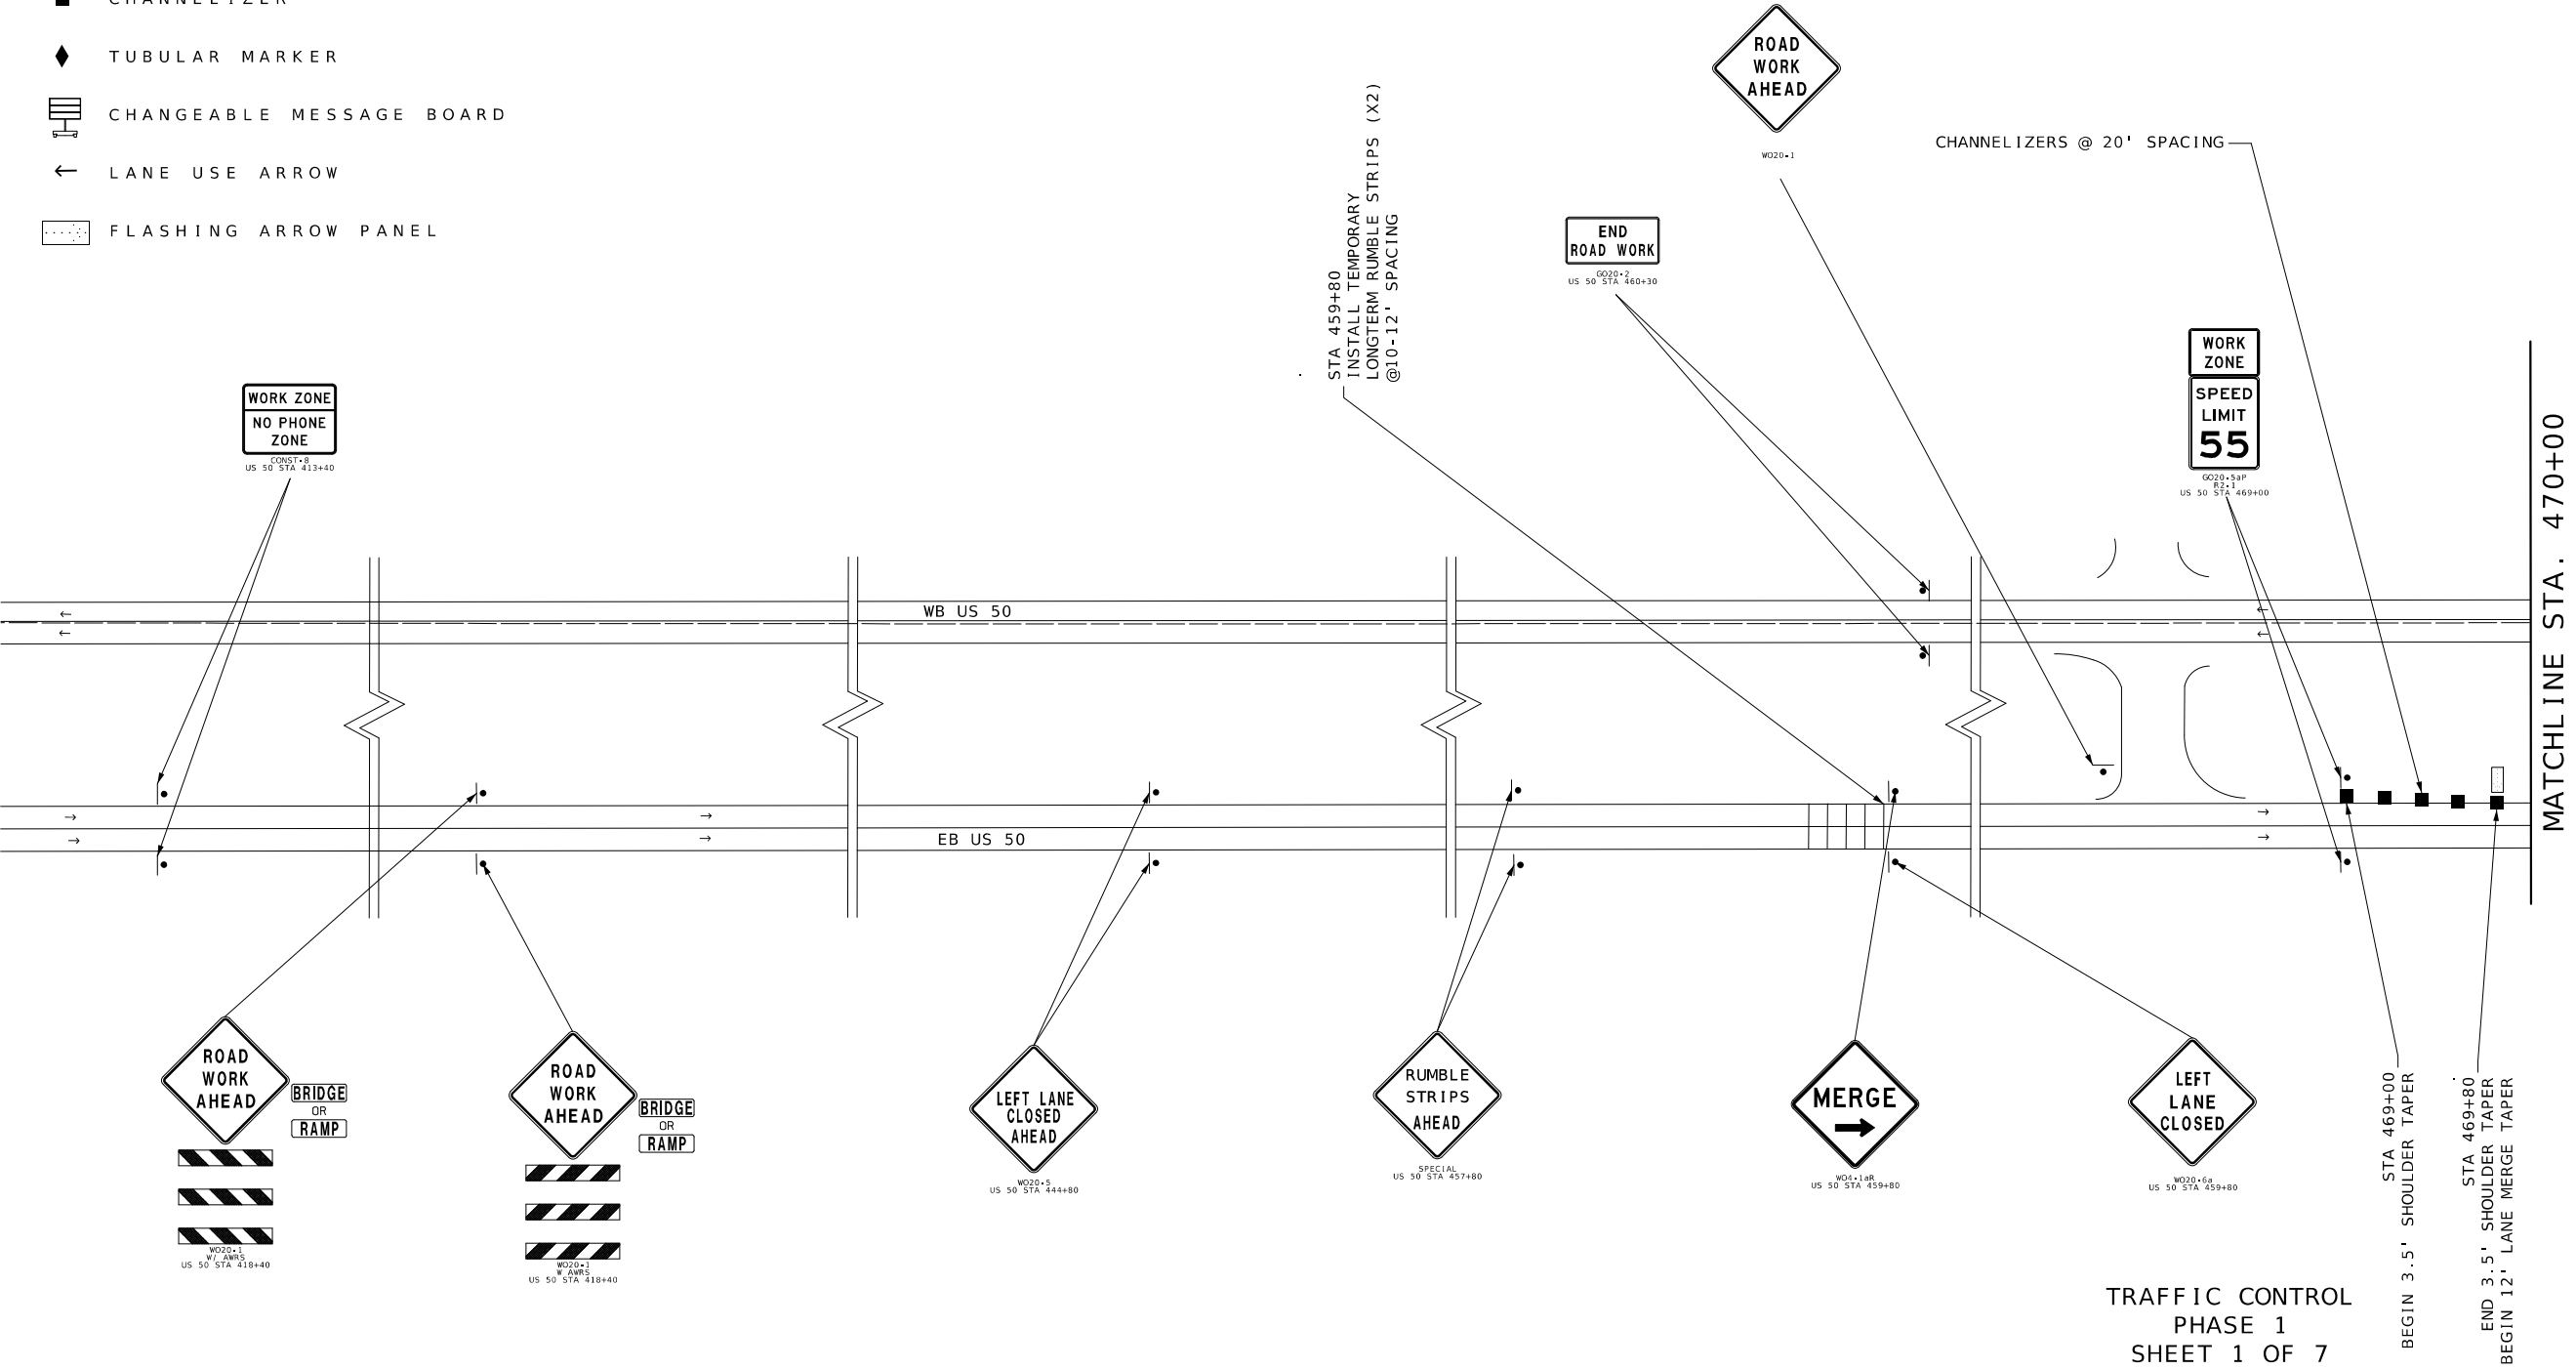

STATE OF MISSOURI

JACLYN A. WHITE

NUMBER

PE-2003001116

PROFESSIONAL ENGINEER

Jaclyn A. White

02/27/2025 1:06:24 PM

JACLYN A. WHITE - CIVIL

MO-PE-2003001116

DATE PREPARED

12/31/2024

ROUTE

50

DISTRICT

KC

STATE

MO

SHEET NO.

10

COUNTY

JOHNSON

JOB NO.

JKR0102

CONTRACT ID.

PROJECT NO.

BRIDGE NO.

L0901

DESCRIPTION

DATE

MISSOURI HIGHWAYS AND TRANSPORTATION COMMISSION


 
105 WEST CAPITOL

JEFFERSON CITY, MO 65102


1-888-ASK-MODOT (1-888-275-6636)

TRAFFIC CONTROL LEGEND

- SIGN (SINGLE SIDED)
- SIGN (DOUBLE SIDED)
- BARRICADE
- DIRECTION INDICATOR BARRICADE
- CHANNELIZER
- TUBULAR MARKER
- CHANGEABLE MESSAGE BOARD
- LANE USE ARROW
- FLASHING ARROW PANEL

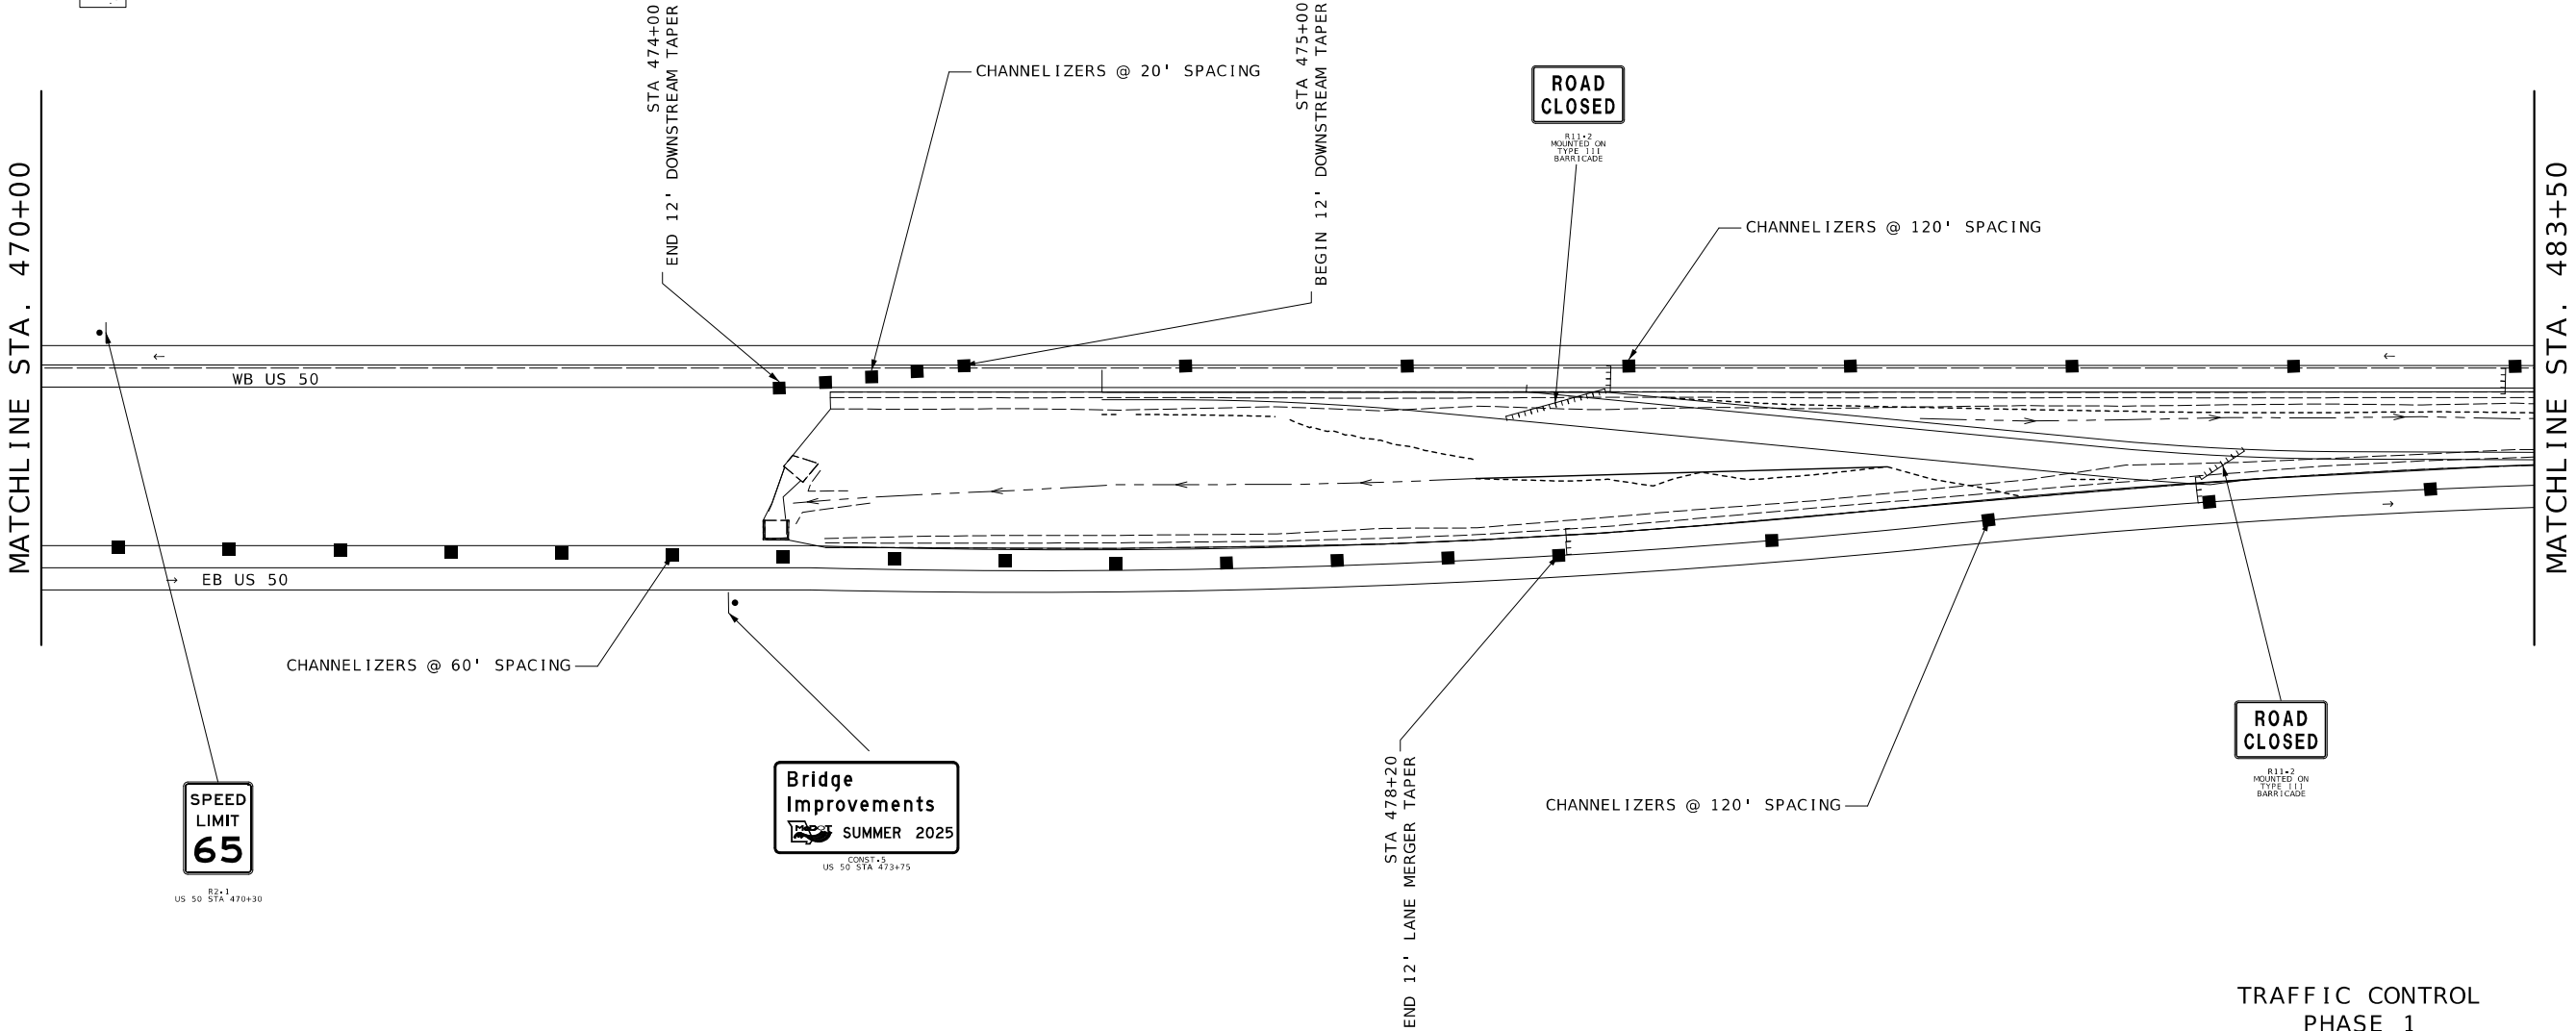

TRAFFIC CONTROL
PHASE 1
SHEET 2 OF 7

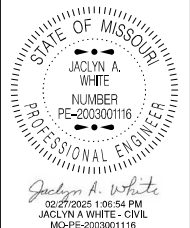


DATE PREPARED 12/31/2024	
ROUTE 50	STATE MO
DISTRICT KC	SHEET NO. 11
COUNTY JOHNSON	
JOB NO. JKR0102	
CONTRACT ID.	
PROJECT NO.	
BRIDGE NO. L0901	

DATE	DESCRIPTION

MISSOURI HIGHWAYS AND TRANSPORTATION
COMMISSION

105 WEST CAPITOL
JEFFERSON CITY, MO 65102
1-888-ASK-MODOT (1-888-275-6636)

-


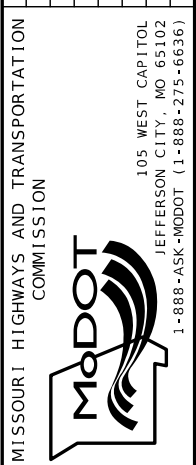


MISSOURI HIGHWAYS AND TRANSPORTATION
COMMISSION

105 WEST CAPITOL
JEFFERSON CITY, MO 65102
1-888-ASK-MODOT (1-888-275-6636)

TRAFFIC CONTROL LEGEND

 - SIGN (SINGLE SIDED)
- SIGN (DOUBLE SIDED)
- BARRICADE
- DIRECTION INDICATOR BARRICADE
- CHANNELIZER
- TUBULAR MARKER
- CHANGEABLE MESSAGE BOARD
- LANE USE ARROW
- FLASHING ARROW PANEL

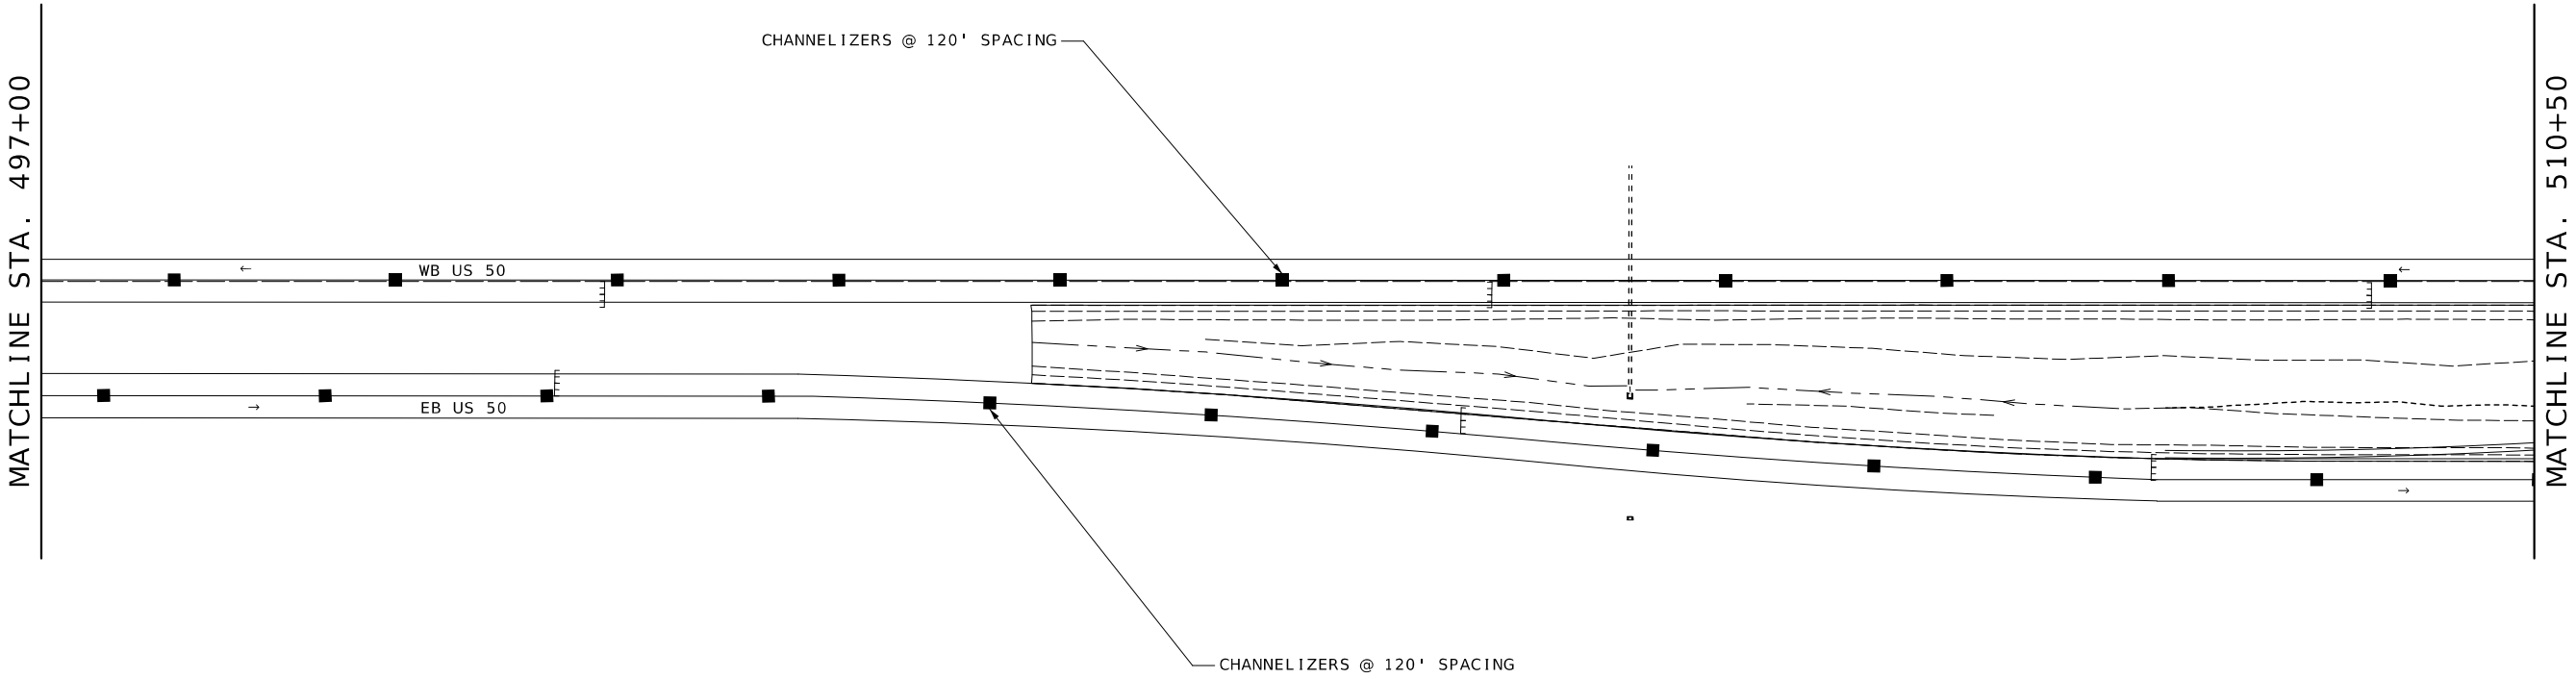

TRAFFIC CONTROL
PHASE 1
SHEET 4 OF 7

STATE OF MISSOURI
JACLYN A. WHITE
NUMBER
PE-2003001116
PROFESSIONAL ENGINEER
02/21/2025 1:07:52 PM
JACLYN A WHITE - CIVIL
MO-PE-2003001116

DATE PREPARED
12/31/2024

ROUTE 50	STATE MO
DISTRICT KC	SHEET NO. 13

COUNTY
JOHNSON

JOB NO.
JKR0102

CONTRACT ID.

PROJECT NO.

BRIDGE NO.
L0901



DATE	DESCRIPTION

MISSOURI HIGHWAYS AND TRANSPORTATION COMMISSION


105 WEST CAPITOL
JEFFERSON CITY, MO 65102
1-888-ASK-MODOT (1-888-275-6636)

TRAFFIC CONTROL LEGEND

 - SIGN (SINGLE SIDED)
- SIGN (DOUBLE SIDED)
- BARRICADE
- DIRECTION INDICATOR BARRICADE
- CHANNELIZER
- TUBULAR MARKER
- CHANGEABLE MESSAGE BOARD
- LANE USE ARROW
- FLASHING ARROW PANEL

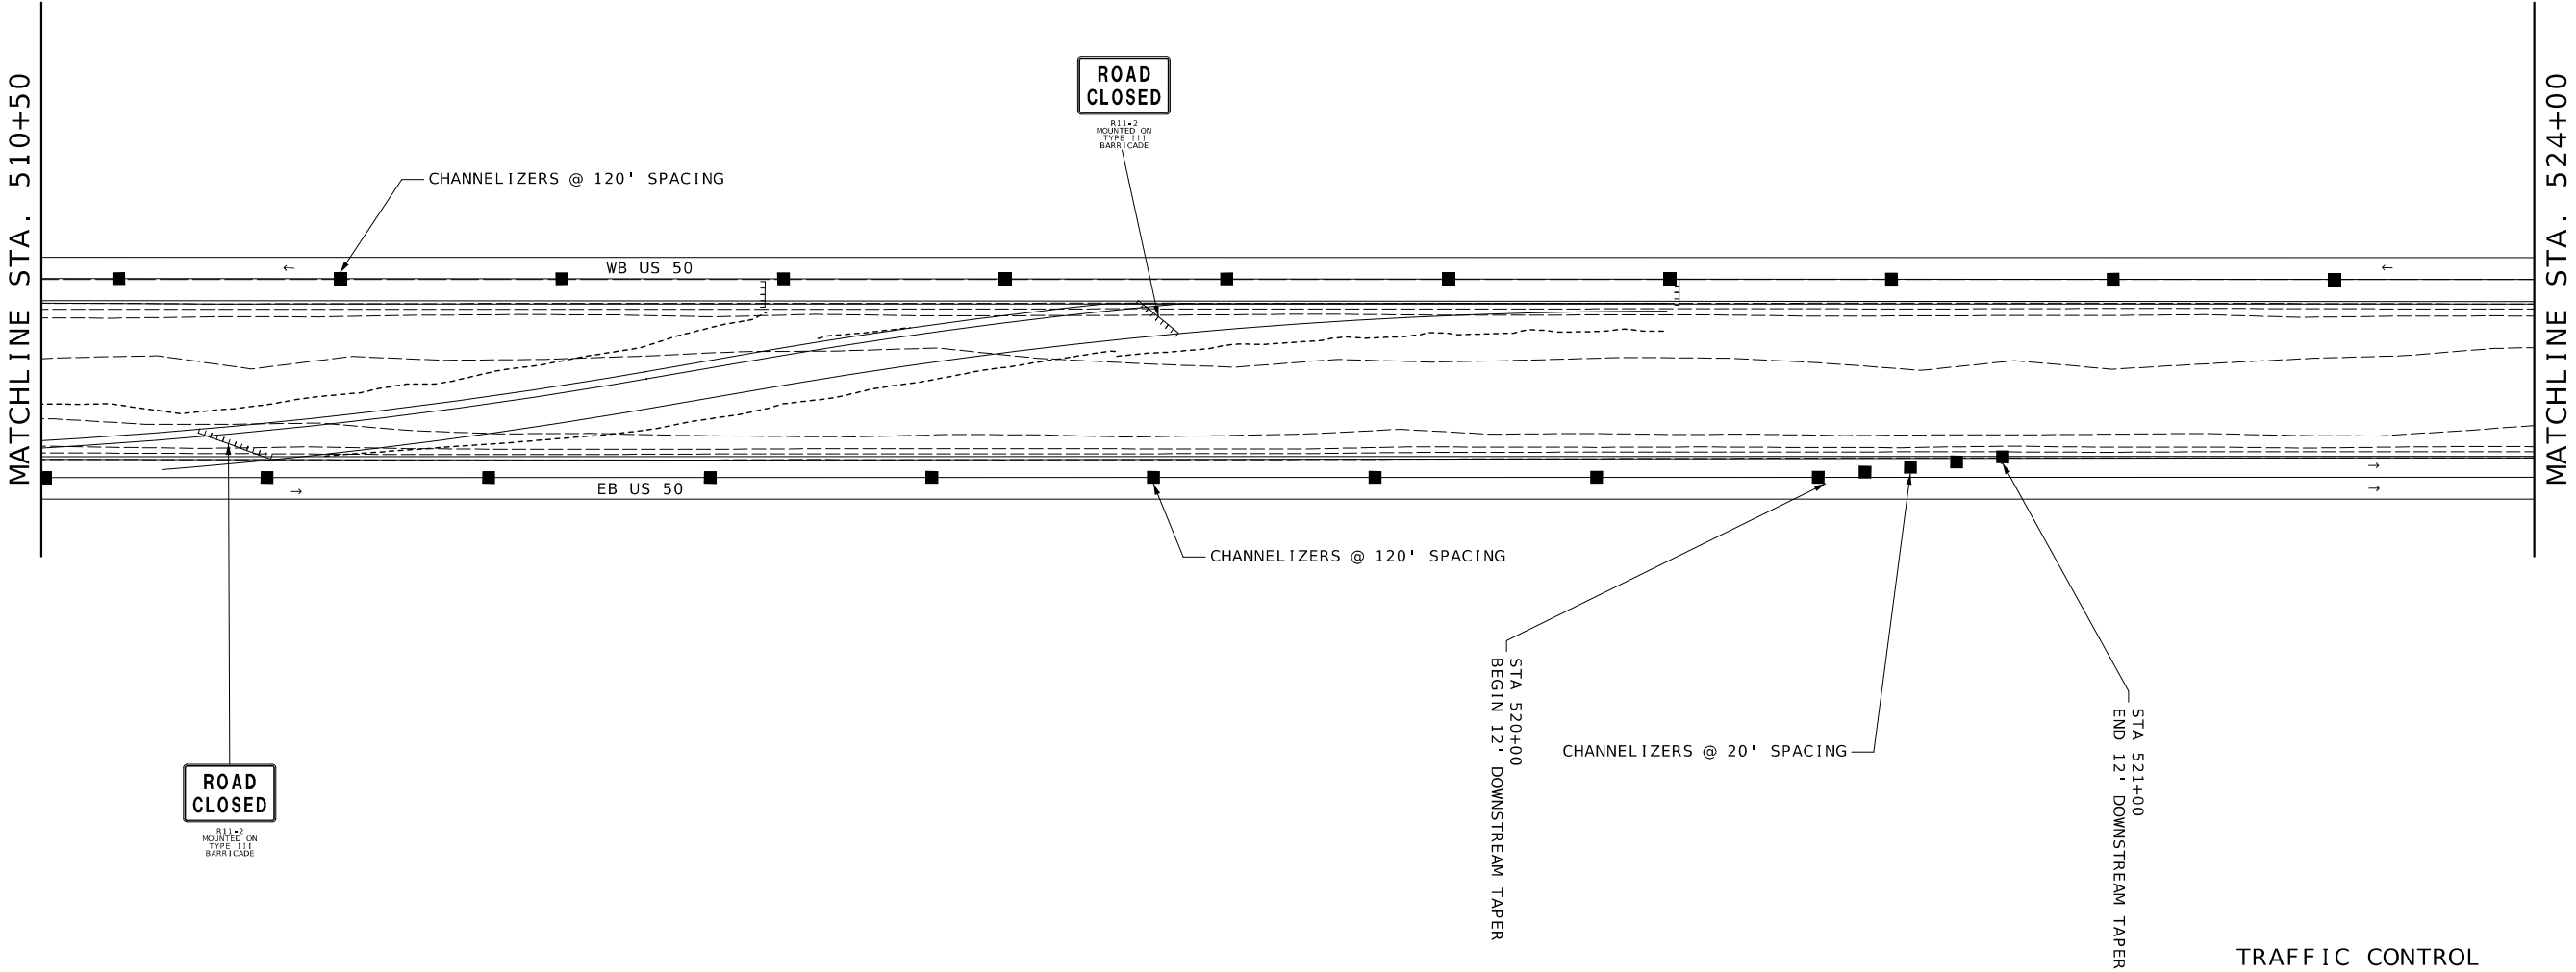

TRAFFIC CONTROL
PHASE 1
SHEET 5 OF 7

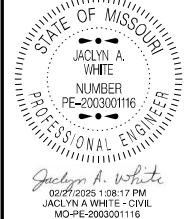

DATE PREPARED 12/31/2024	
ROUTE 50	STATE MO
DISTRICT KC	SHEET NO. 14
COUNTY JOHNSON	
JOB NO. JKR0102	
CONTRACT ID.	
PROJECT NO.	
BRIDGE NO. L0901	




DATE	DESCRIPTION

MISSOURI HIGHWAYS AND TRANSPORTATION
COMMISSION

105 WEST CAPITOL
JEFFERSON CITY, MO 65102
1-888-ASK-MODOT (1-888-275-6636)

TRAFFIC CONTROL LEGEND

 - SIGN (SINGLE SIDED)
- SIGN (DOUBLE SIDED)
- BARRICADE
- DIRECTION INDICATOR BARRICADE
- CHANNELIZER
- TUBULAR MARKER
- CHANGEABLE MESSAGE BOARD
- LANE USE ARROW
- FLASHING ARROW PANEL

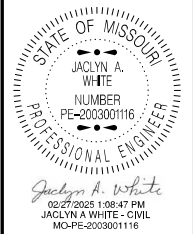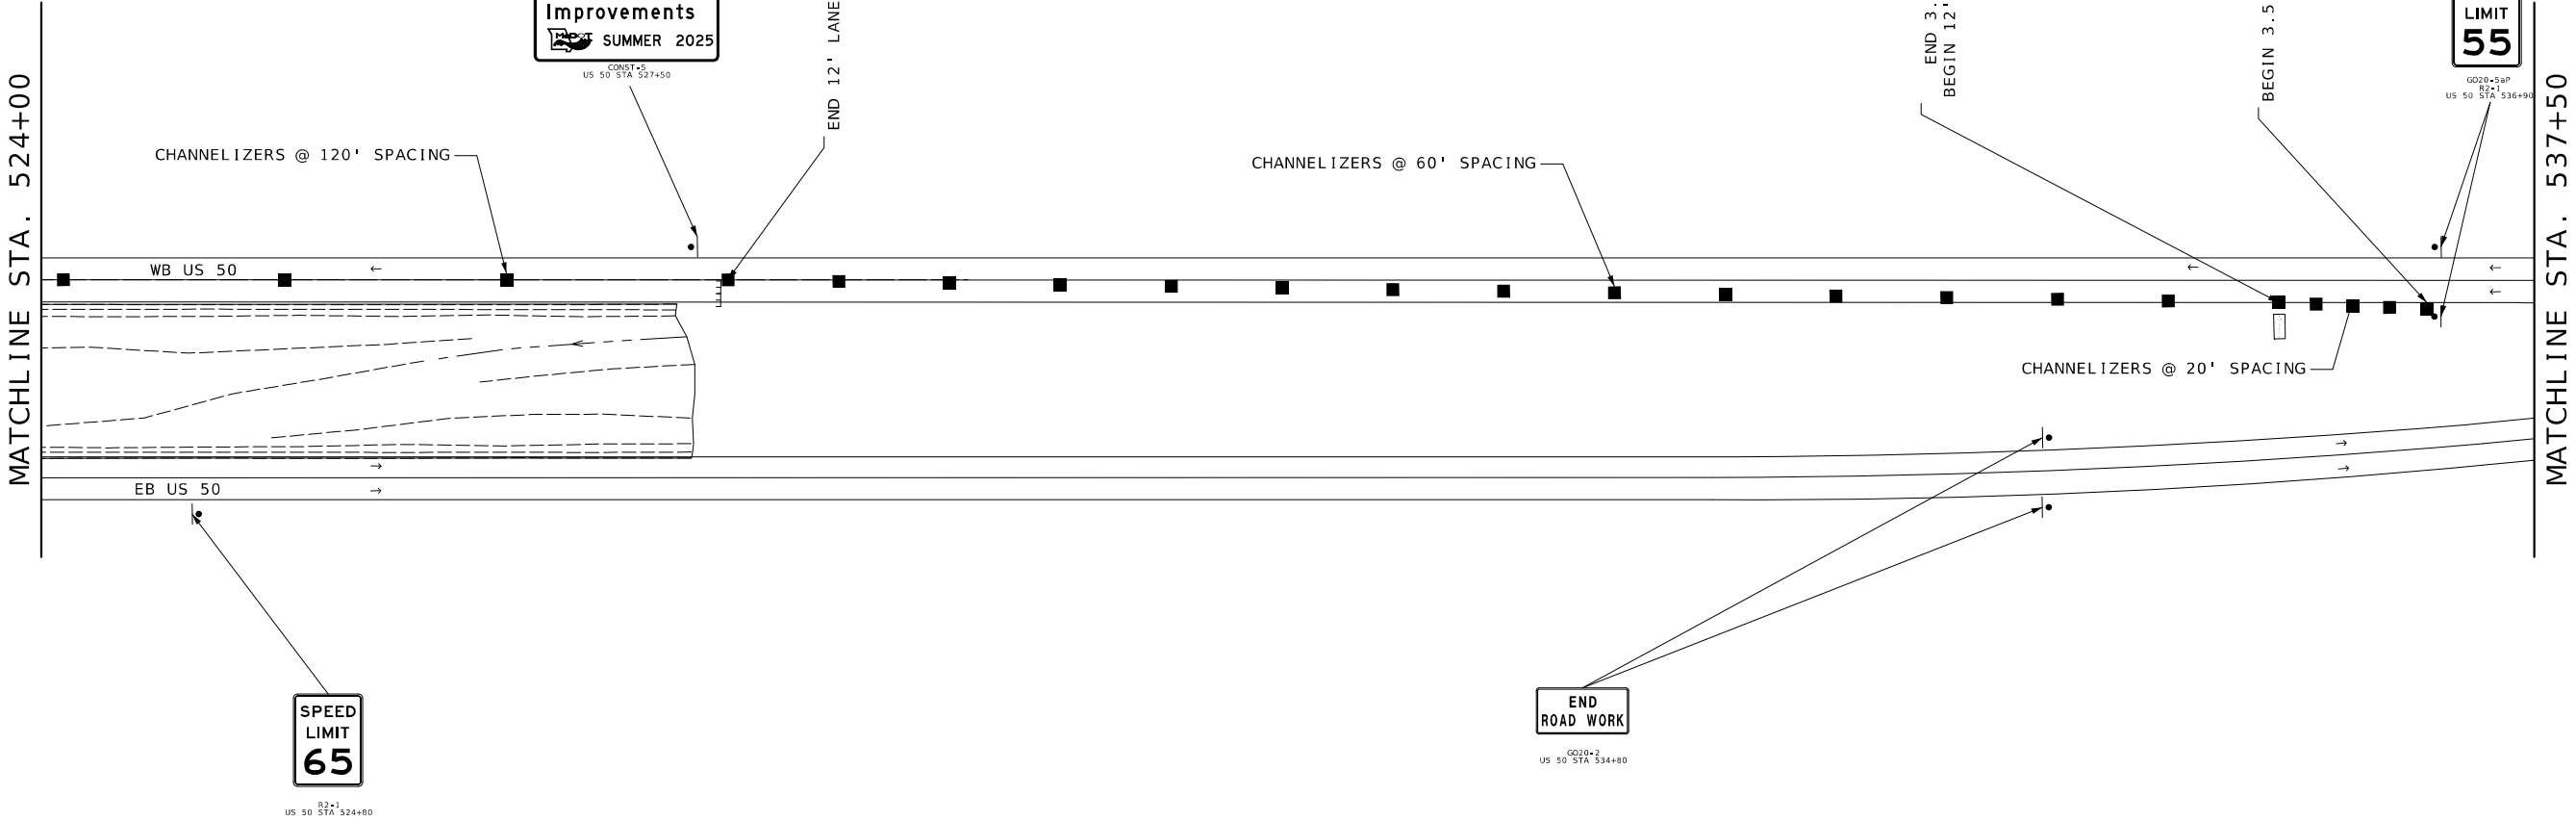


DATE PREPARED 12/31/2024	
ROUTE 50	STATE MO
DISTRICT KC	SHEET NO. 15
COUNTY JOHNSON	
JOB NO. JKR0102	
CONTRACT ID.	
PROJECT NO.	
BRIDGE NO. L0901	

DESCRIPTION	DATE


MISSOURI HIGHWAYS AND TRANSPORTATION
COMMISSION

105 WEST CAPITOL
JEFFERSON CITY, MO 65102
1-888-ASK-MODOT (1-888-275-6636)

- SIGN (SINGLE SIDED)
- SIGN (DOUBLE SIDED)
- BARRICADE
- DIRECTION INDICATOR BARRICADE
- CHANNELIZER
- TUBULAR MARKER
- CHANGEABLE MESSAGE BOARD
- LANE USE ARROW
- FLASHING ARROW PANEL

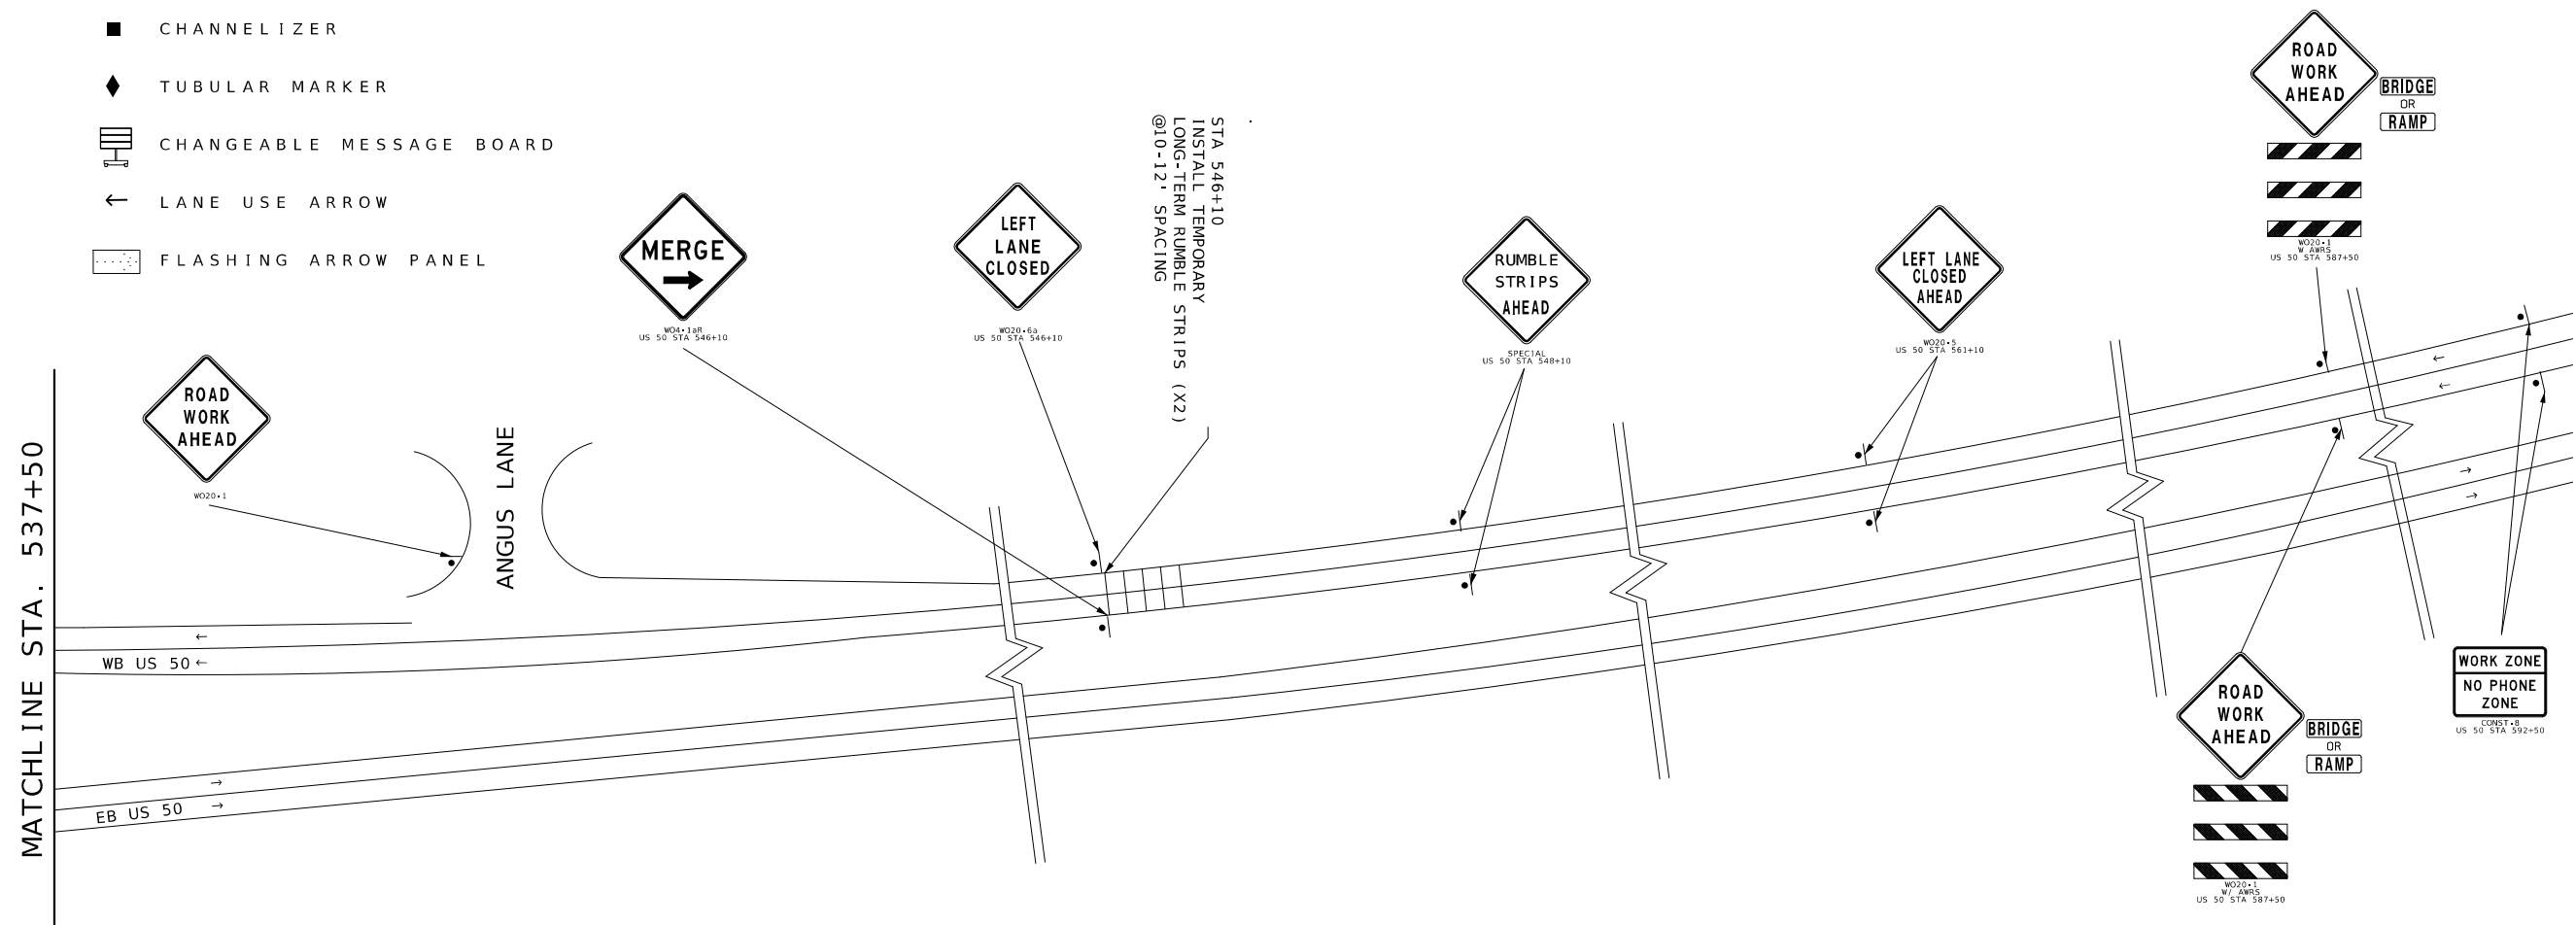

TRAFFIC CONTROL
PHASE 1
SHEET 7 OF 7

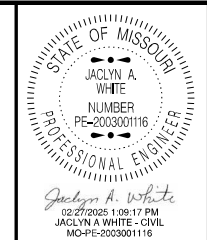



DATE PREPARED	
12/31/2024	
ROUTE	STATE
50	MO
DISTRICT	SHEET NO.
KC	16
COUNTY	
JOHNSON	
JOB NO.	
JKR0102	
CONTRACT ID.	
PROJECT NO.	

BRIDGE NO.
L0901

[illegible]MISSOURI HIGHWAYS AND TRANSPORTATION
COMMISSION

105 WEST CAPITOL
JEFFERSON CITY, MO 65102
1-888-ASK-MODOT (1-888-275-6636)

- SIGN (SINGLE SIDED)
- SIGN (DOUBLE SIDED)
- E BARRICADE
- DIRECTION INDICATOR BARRICADE
- CHANNELIZER
- ◆ TUBULAR MARKER
- CHANGEABLE MESSAGE BOARD
- ← LANE USE ARROW
- FLASHING ARROW PANEL

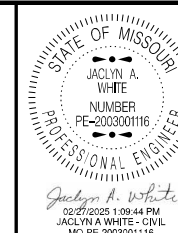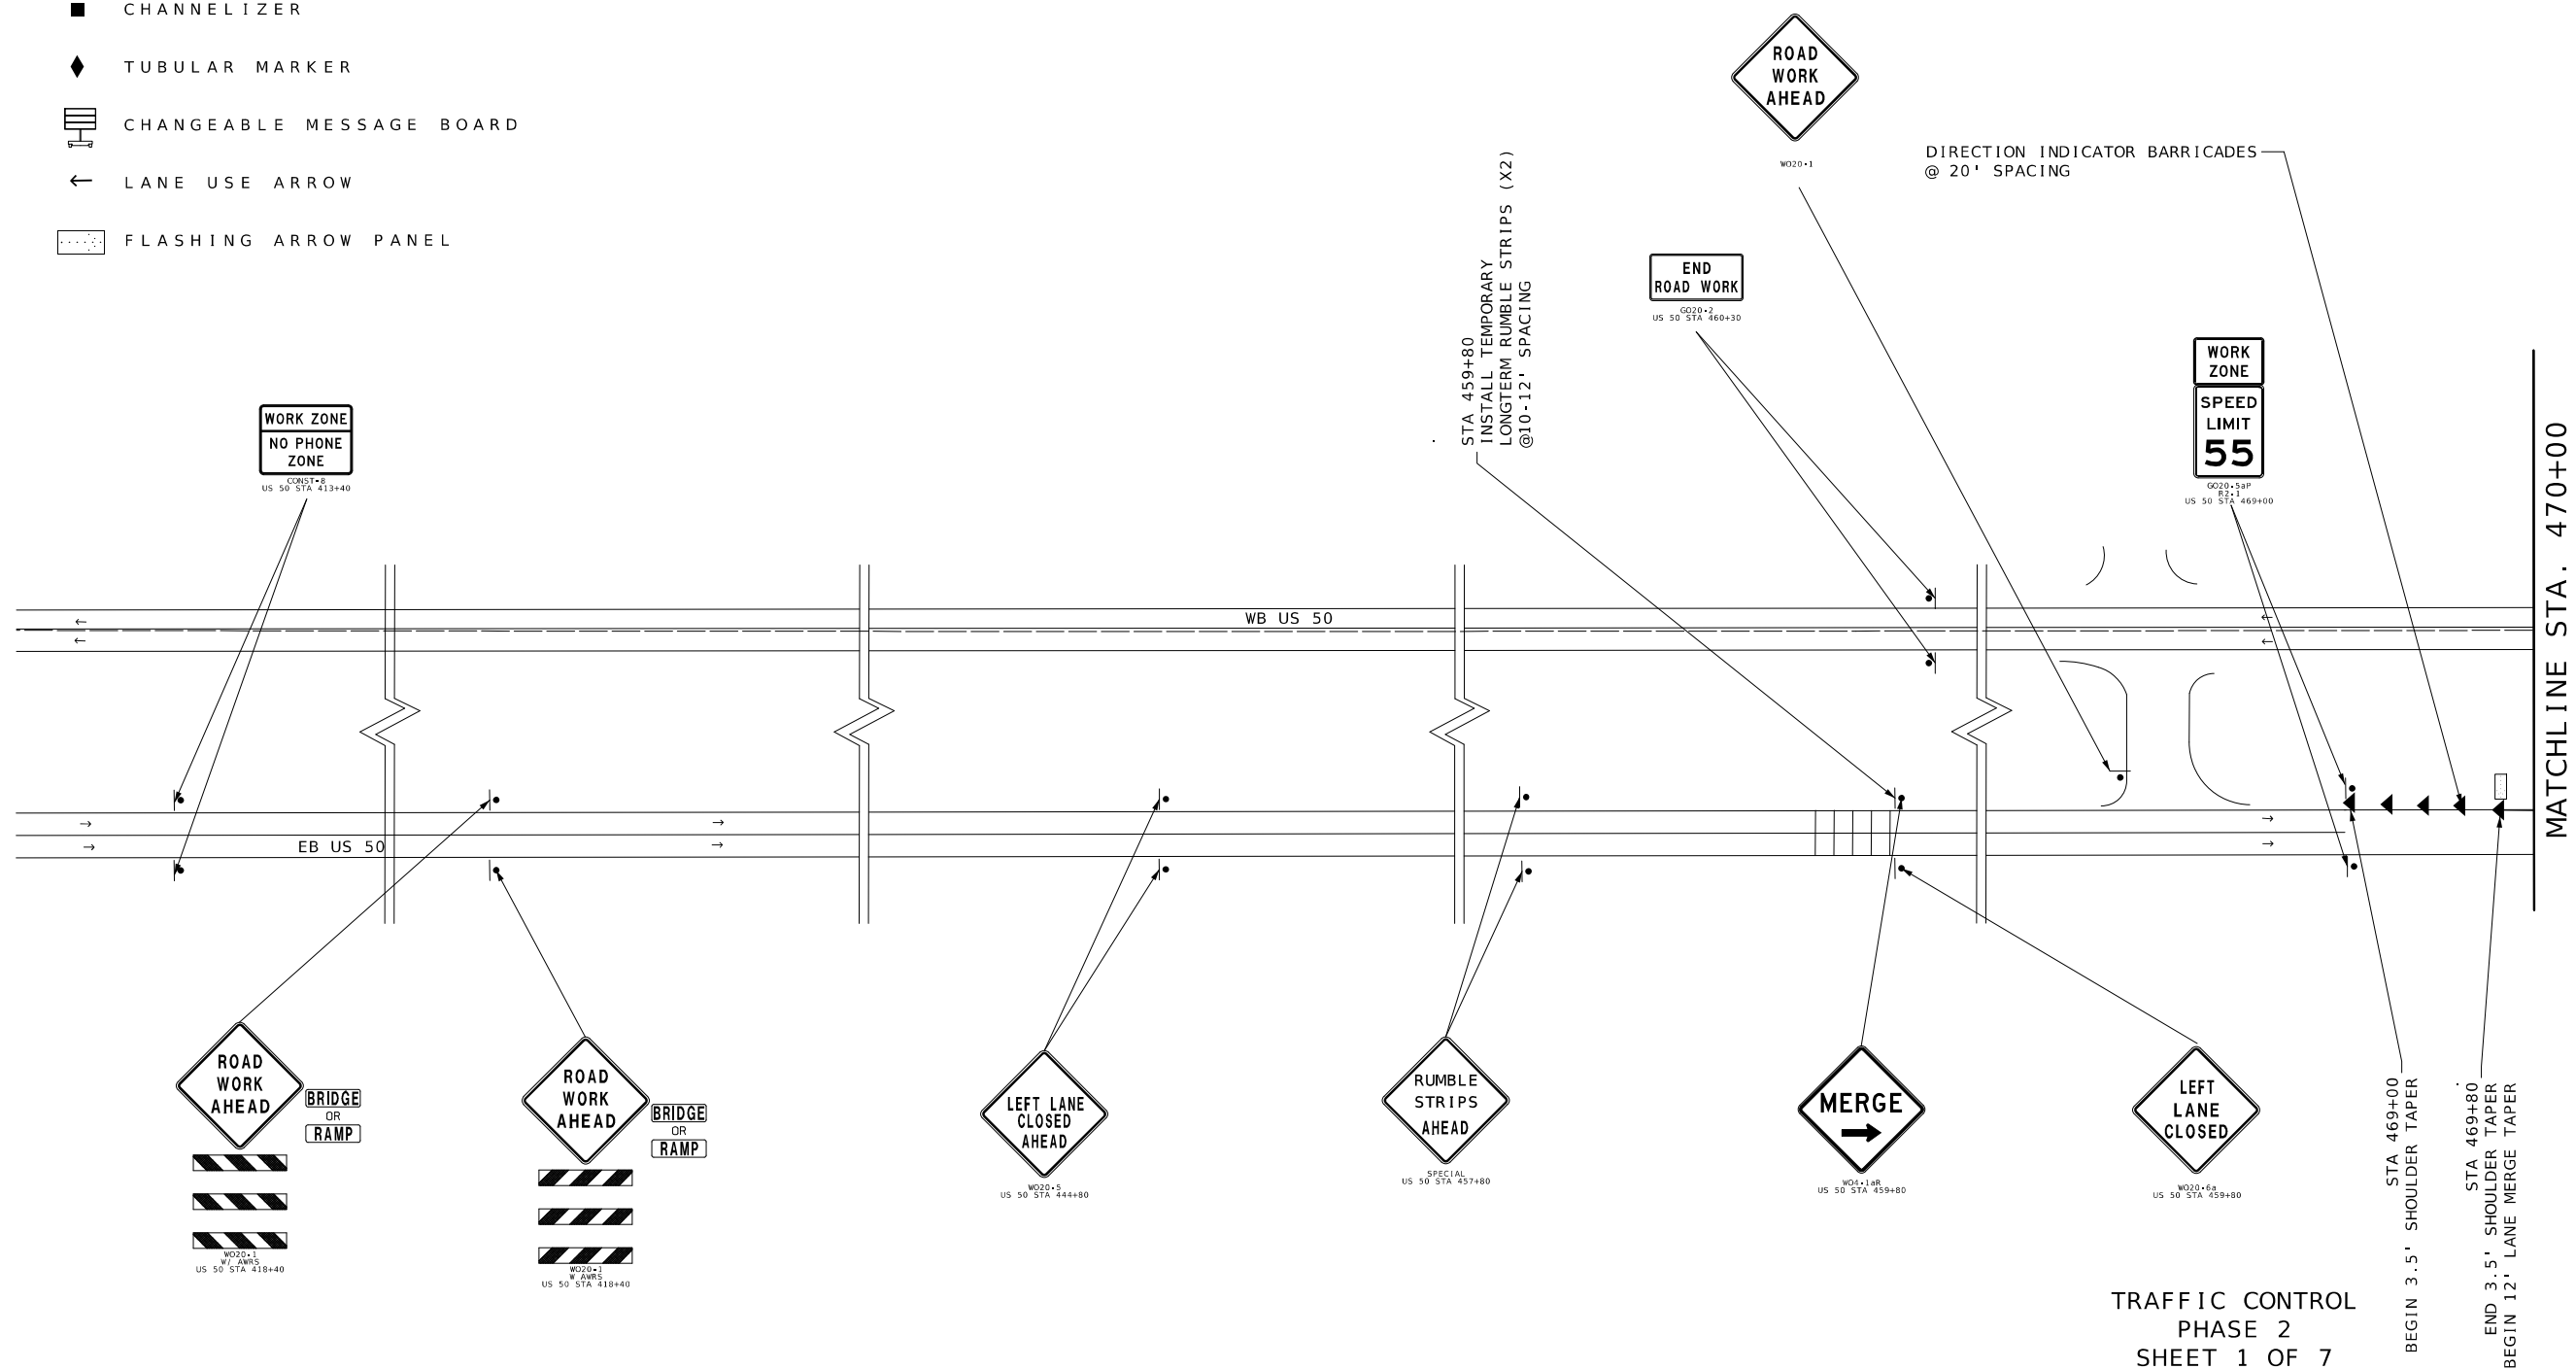

DATE PREPARED	
12/31/2024	
ROUTE	STATE
50	MO
DISTRICT	SHEET #
KC	17
COUNTY	
JOHNSON	
JOB NO.	
JKR0102	
CONTRACT ID.	

PROJECT NO.
BRIDGE NO. L0901

DATE	DESCRIPTION





MISSOURI HIGHWAYS AND TRANSPORTATION
COMMISSION

105 WEST CAPITOL
JEFFERSON CITY, MO 65102



TRAFFIC CONTROL LEGEND

- | | |
|---|-------------------------------|
|  | SIGN (SINGLE SIDED) |
|  | SIGN (DOUBLE SIDED) |
|  | BARRICADE |
|  | DIRECTION INDICATOR BARRICADE |
|  | CHANNELIZER |
|  | TUBULAR MARKER |
|  | CHANGEABLE MESSAGE BOARD |
|  | LANE USE ARROW |
|  | FLASHING ARROW PANEL |

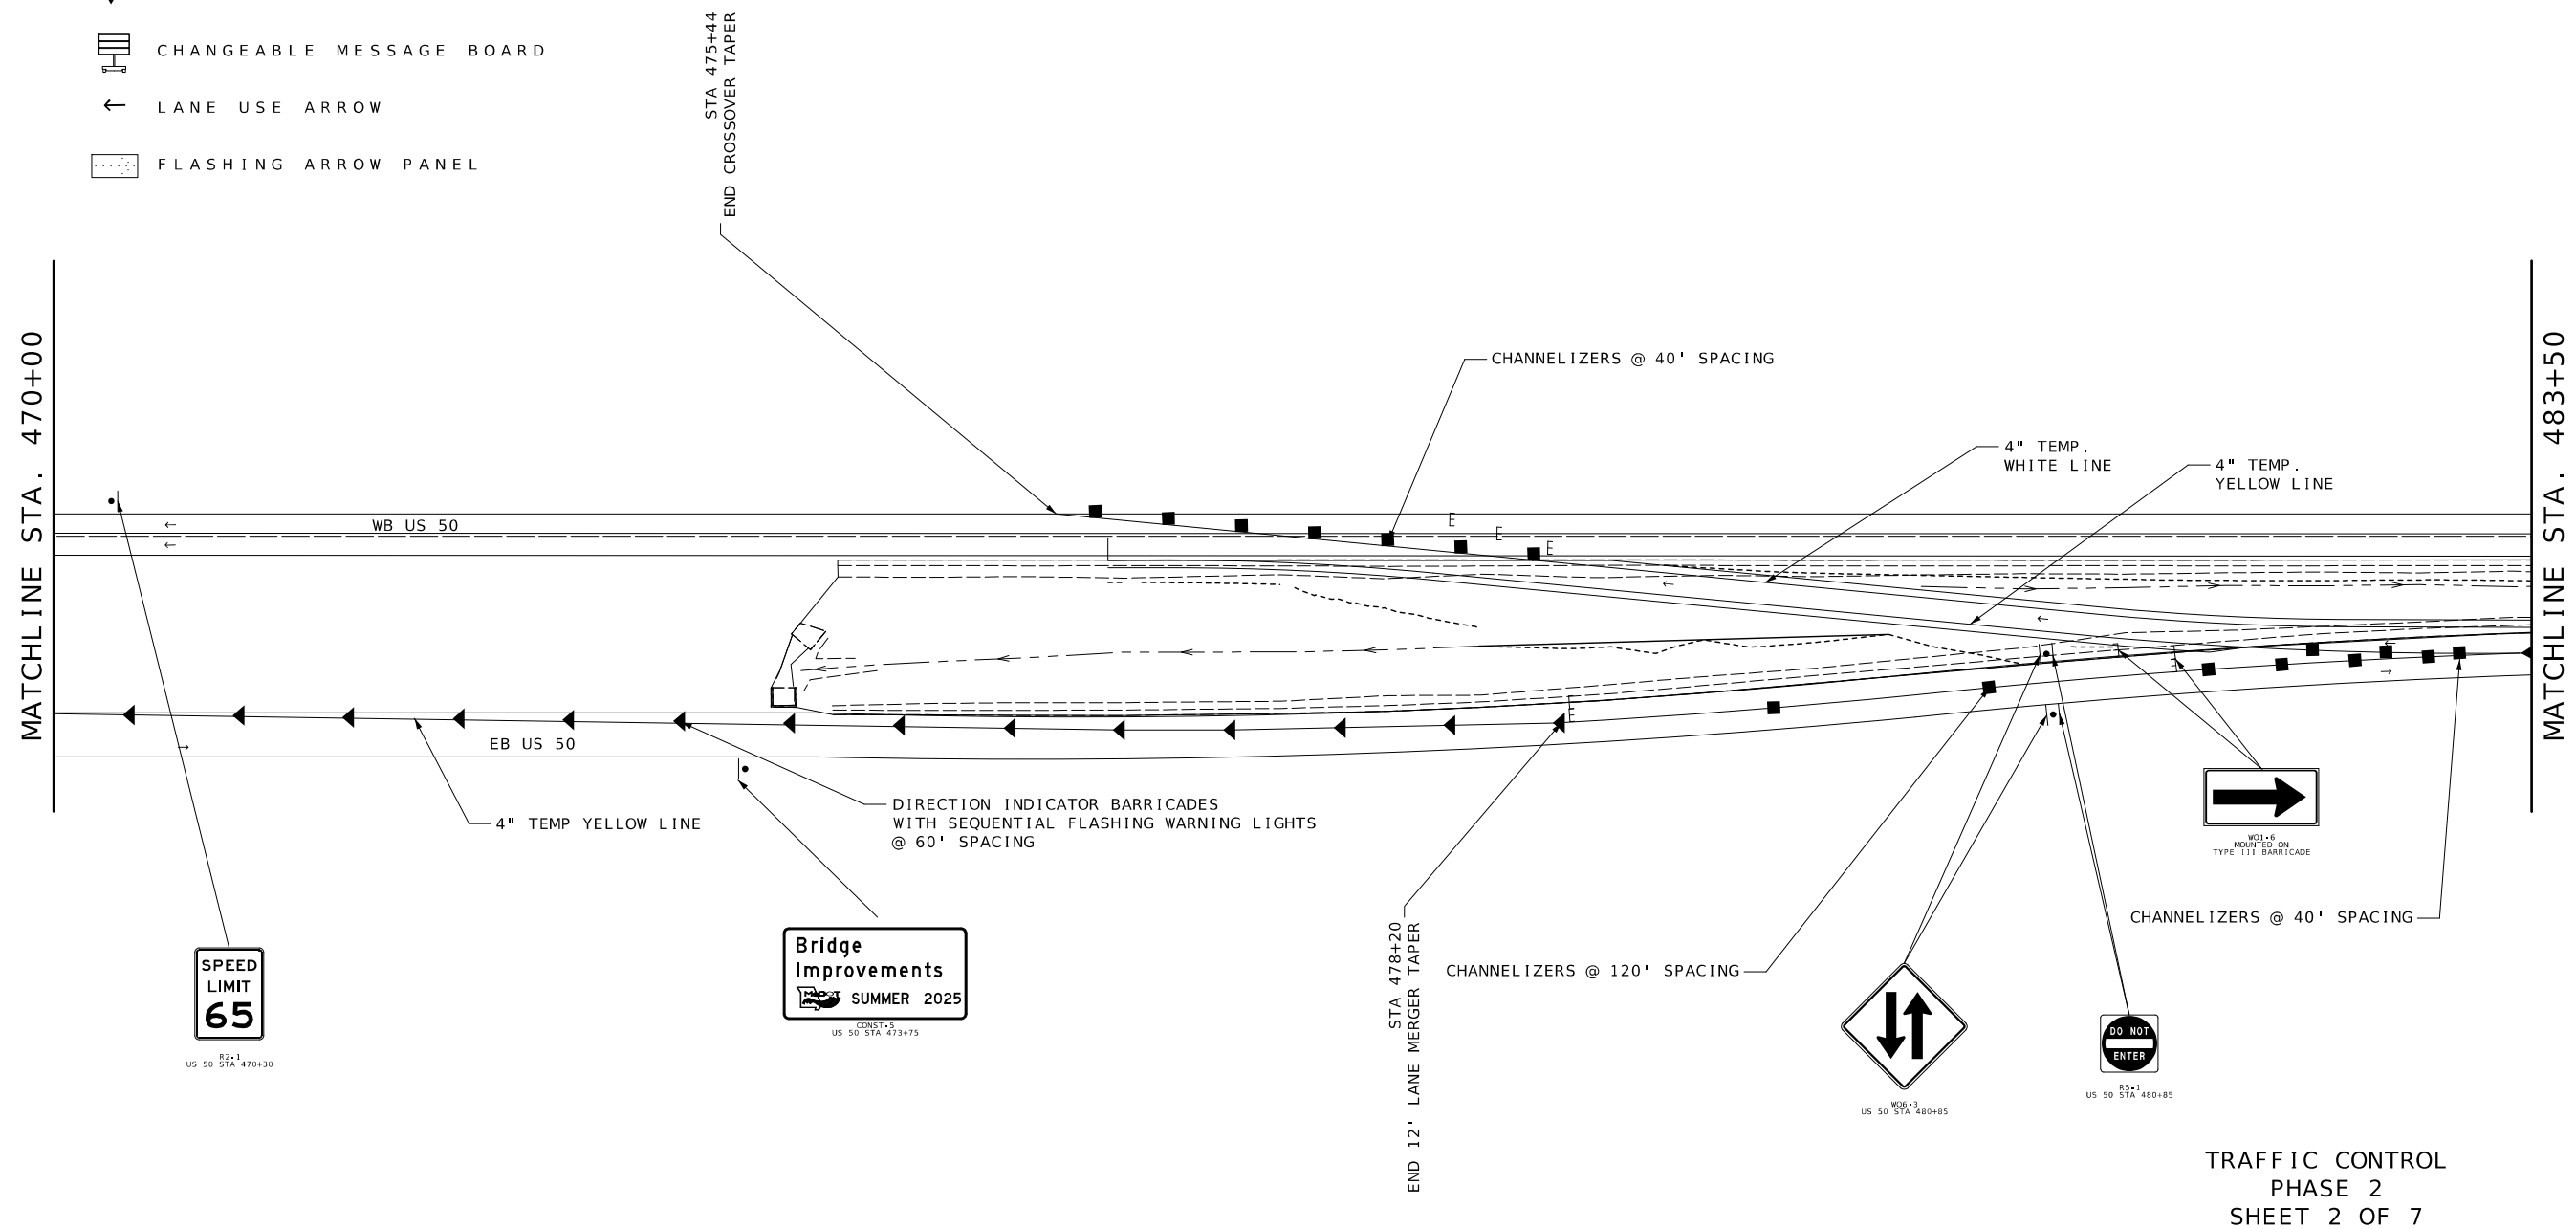 

DATE PREPARED
12/31/2024

ROUTE 50	STATE MO
-------------	-------------

DISTRICT KC	SHEET NO. 18
----------------	-----------------

COUNTY
JOHNSON

JOB NO.
JKR0102

CONTRACT ID.

PROJECT NO.

BRIDGE NO.
L0901


 
[illegible]

MISSOURI HIGHWAYS AND TRANSPORTATION COMMISSION

 105 WEST CAPITOL
JEFFERSON CITY, MO 65102
1-888-ASK-MODOT (1-888-275-6636)

TRAFFIC CONTROL LEGEND

- SIGN (SINGLE SIDED)
- ▬ SIGN (DOUBLE SIDED)
- [BARRICADE
- DIRECTION INDICATOR BARRICADE
- CHANNELIZER
- ◆ TUBULAR MARKER
- ▮ CHANGEABLE MESSAGE BOARD
- ← LANE USE ARROW
- ⬢ FLASHING ARROW PANEL

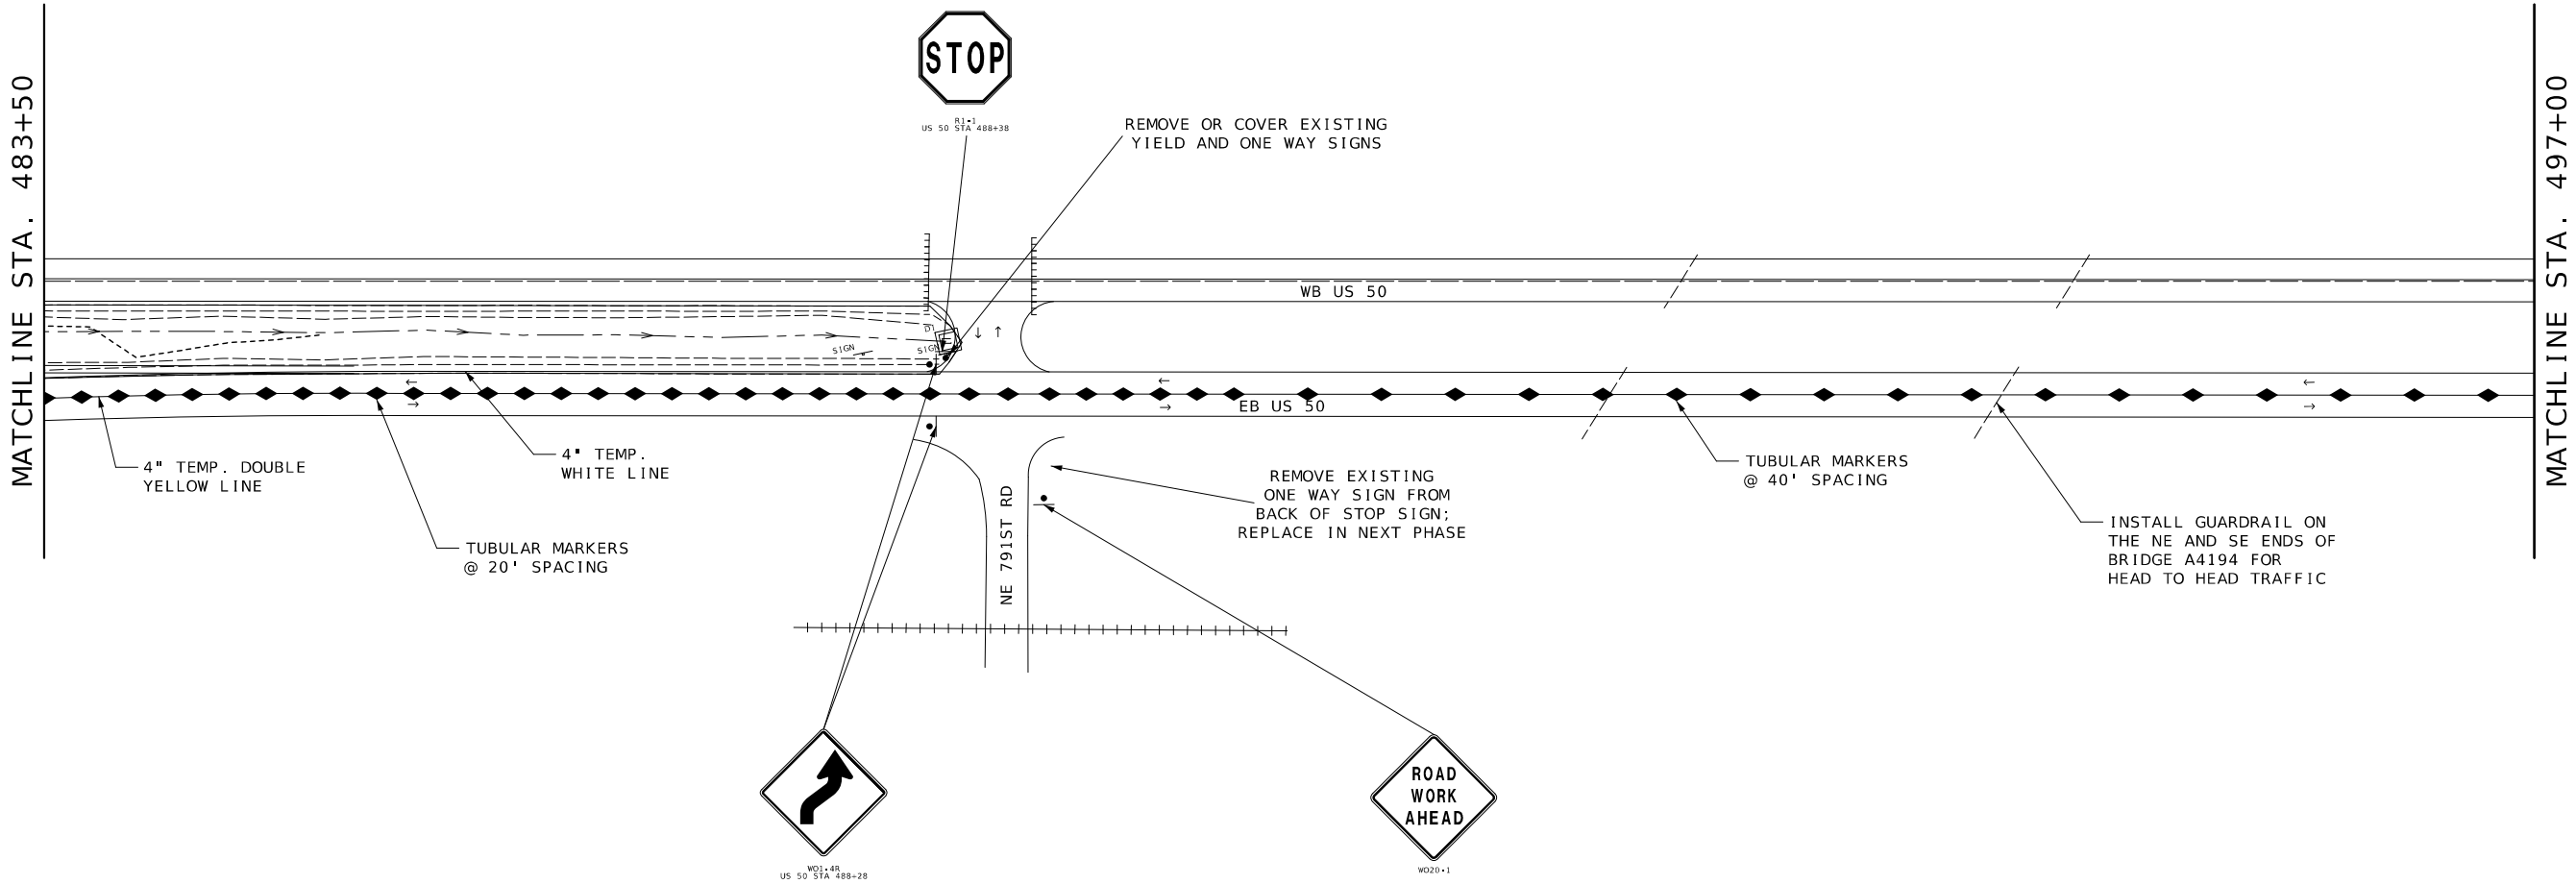

TRAFFIC CONTROL
PHASE 2
SHEET 3 OF 7

STATE OF MISSOURI

JACLYN A. WHITE

NUMBER

PE-2003001116

PROFESSIONAL ENGINEER

Jaclyn A. White

02/27/2025 1:10:41 PM

JACLYN A WHITE - CIVIL

MO-PE-2003001116

DATE PREPARED

12/31/2024

ROUTE

50

STATE

MO

DISTRICT

KC

SHEET NO.

19

COUNTY

JOHNSON

JOB NO.

JKR0102

CONTRACT ID.

PROJECT NO.

BRIDGE NO.

L0901

DATE	DESCRIPTION

MISSOURI HIGHWAYS AND TRANSPORTATION COMMISSION

MoDOT


 
105 WEST CAPITOL

JEFFERSON CITY, MO 65102


1-888-ASK-MODOT (1-888-275-6636)

TRAFFIC CONTROL LEGEND

-  SIGN (SINGLE SIDED)
-  SIGN (DOUBLE SIDED)
-  BARRICADE
-  DIRECTION INDICATOR BARRICADE
-  CHANNELIZER
-  TUBULAR MARKER
-  CHANGEABLE MESSAGE BOARD
-  LANE USE ARROW
-  FLASHING ARROW PANEL

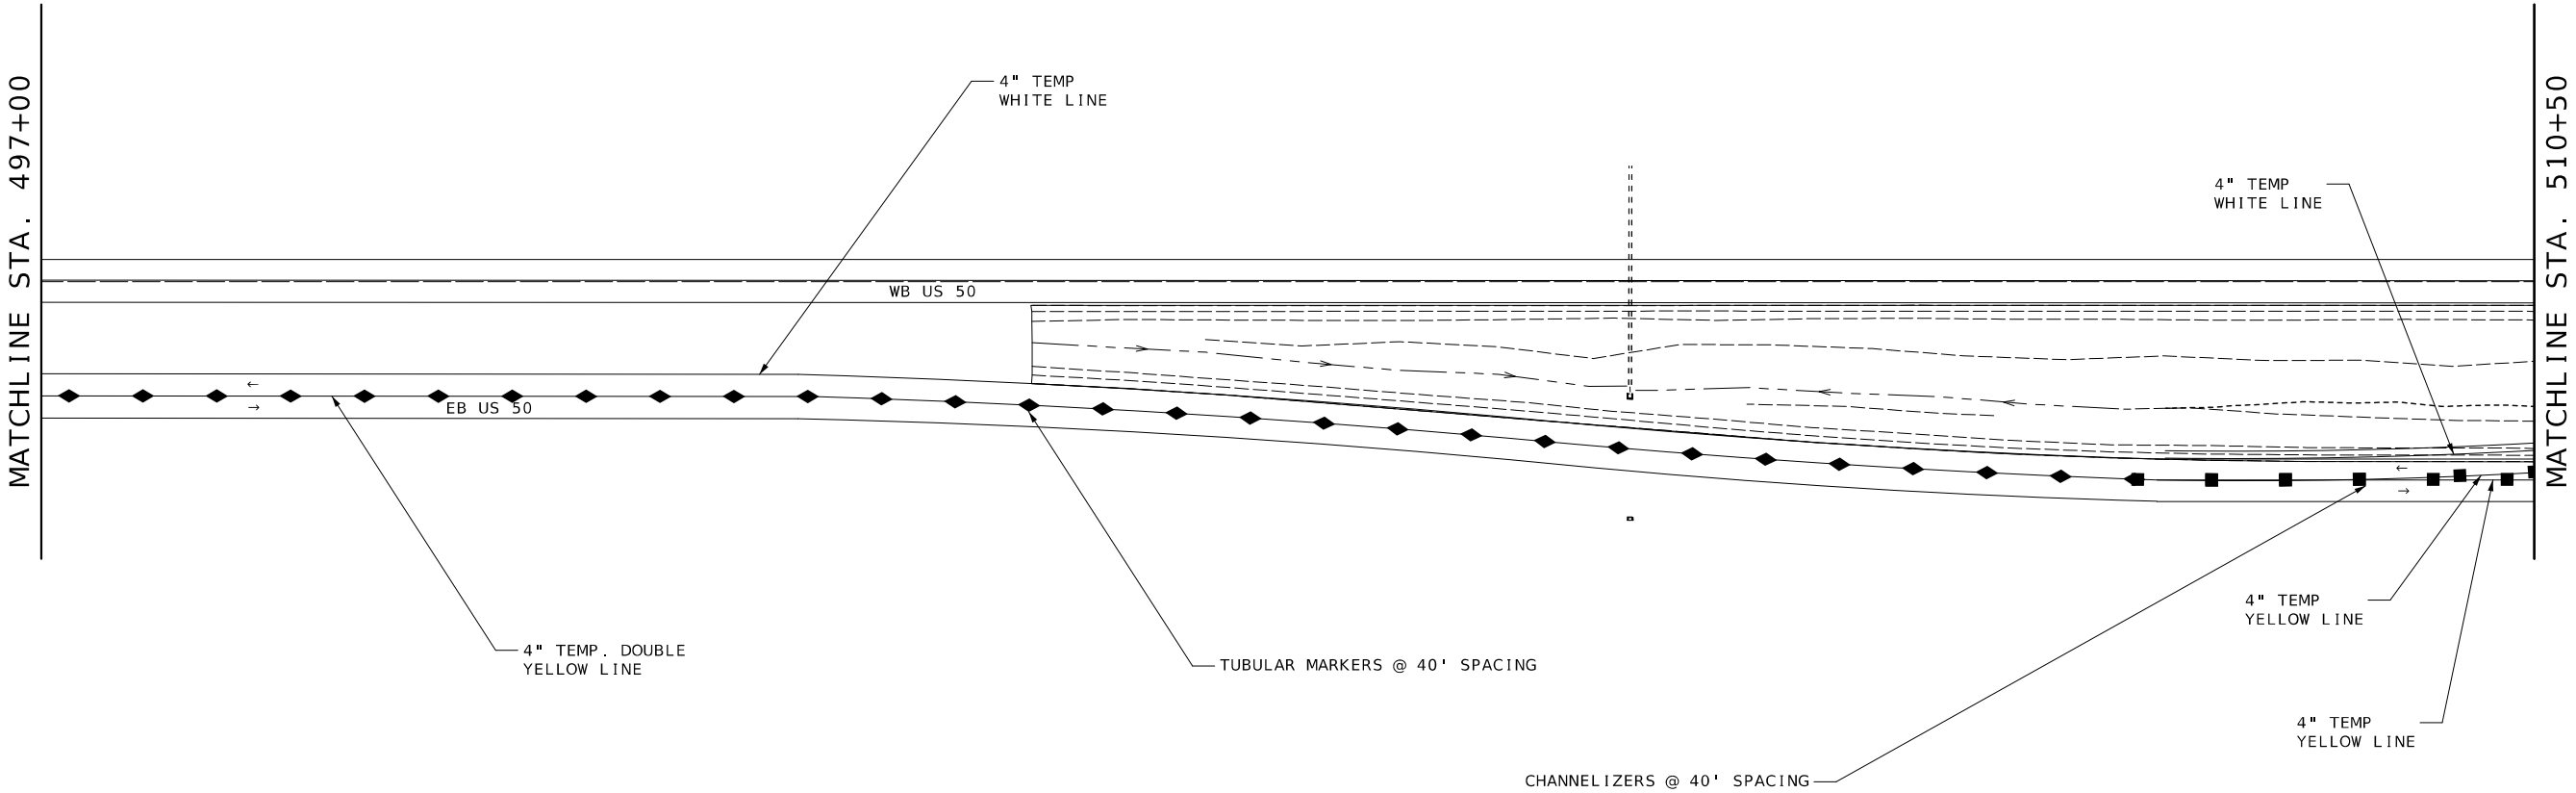

TRAFFIC CONTROL
PHASE 2
SHEET 4 OF 7

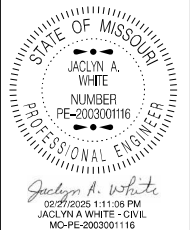

DATE PREPARED	
12/31/2024	
ROUTE	STATE
50	MO
DISTRICT	SHEET NO.
KC	20
COUNTY	
JOHNSON	
JOB NO.	
JKR0102	
CONTRACT ID.	
PROJECT NO.	
BRIDGE NO.	
L0901	

DATE	DESCRIPTION



 
MISSOURI HIGHWAYS AND TRANSPORTATION COMMISSION



105 WEST CAPITOL
JEFFERSON CITY, MO 65102
1-888-ASK-MODOT (1-888-275-6636)

TRAFFIC CONTROL LEGEND

- SIGN (SINGLE SIDED)
- SIGN (DOUBLE SIDED)
- BARRICADE
- DIRECTION INDICATOR BARRICADE
- CHANNELIZER
- TUBULAR MARKER
- CHANGEABLE MESSAGE BOARD
- LANE USE ARROW
- FLASHING ARROW PANEL

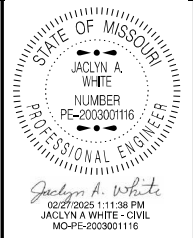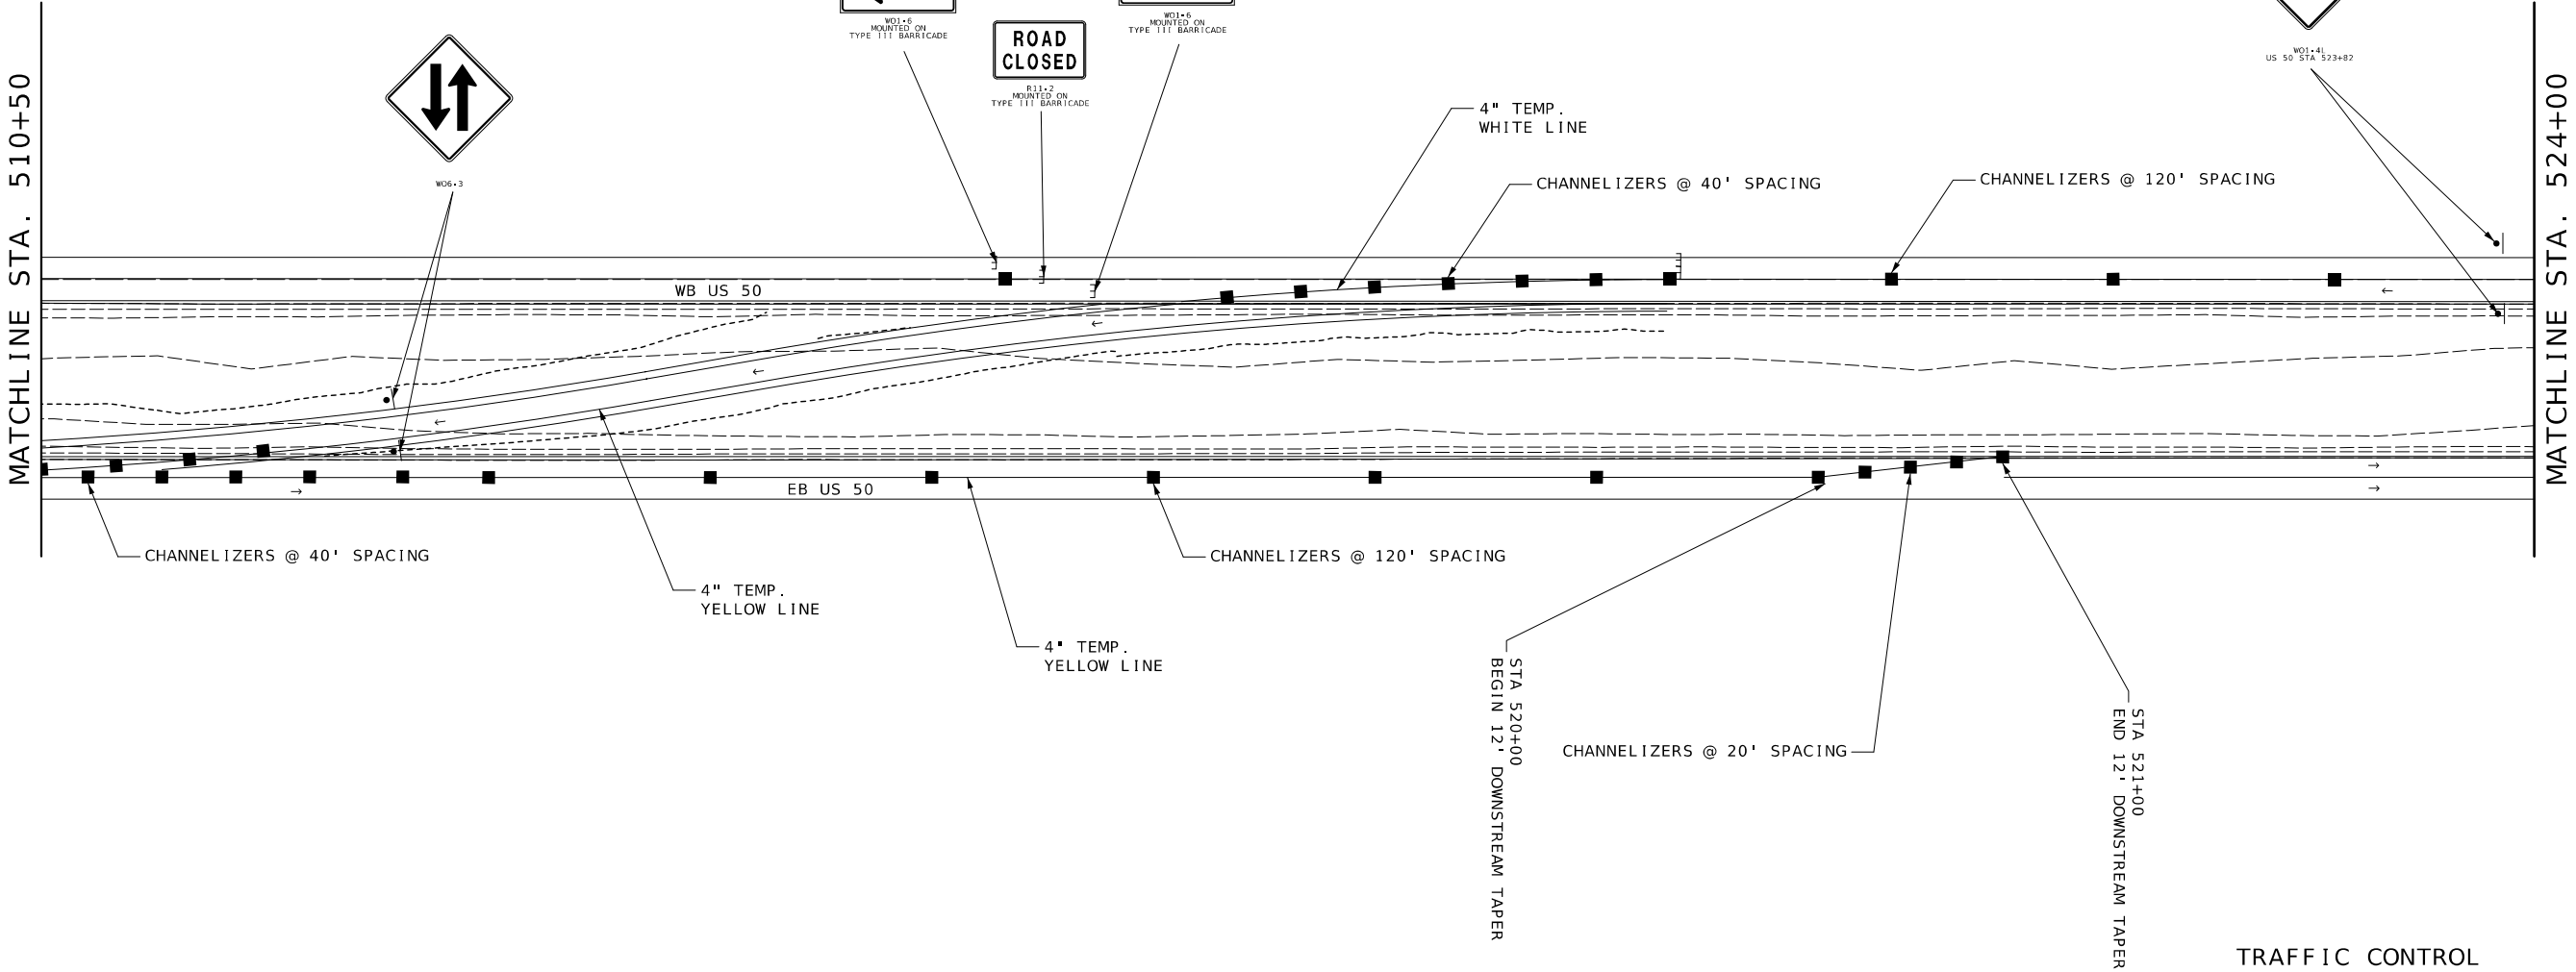

DATE PREPARED	
12/31/2024	
ROUTE	STATE
50	MO
DISTRICT	SHEET NO.
KC	21
COUNTY	
JOHNSON	
JOB NO.	
JKR0102	
CONTRACT ID.	
PROJECT NO.	
BRIDGE NO.	
L0901	



DESCRIPTION	DATE

MISSOURI HIGHWAYS AND TRANSPORTATION COMMISSION

105 WEST CAPITOL
JEFFERSON CITY, MO 65102
1-888-ASK-MODOT (1-888-275-6636)

TRAFFIC CONTROL LEGEND

 - SIGN (SINGLE SIDED)
- SIGN (DOUBLE SIDED)
- BARRICADE
- DIRECTION INDICATOR BARRICADE
- CHANNELIZER
- TUBULAR MARKER
- CHANGEABLE MESSAGE BOARD
- LANE USE ARROW
- FLASHING ARROW PANEL

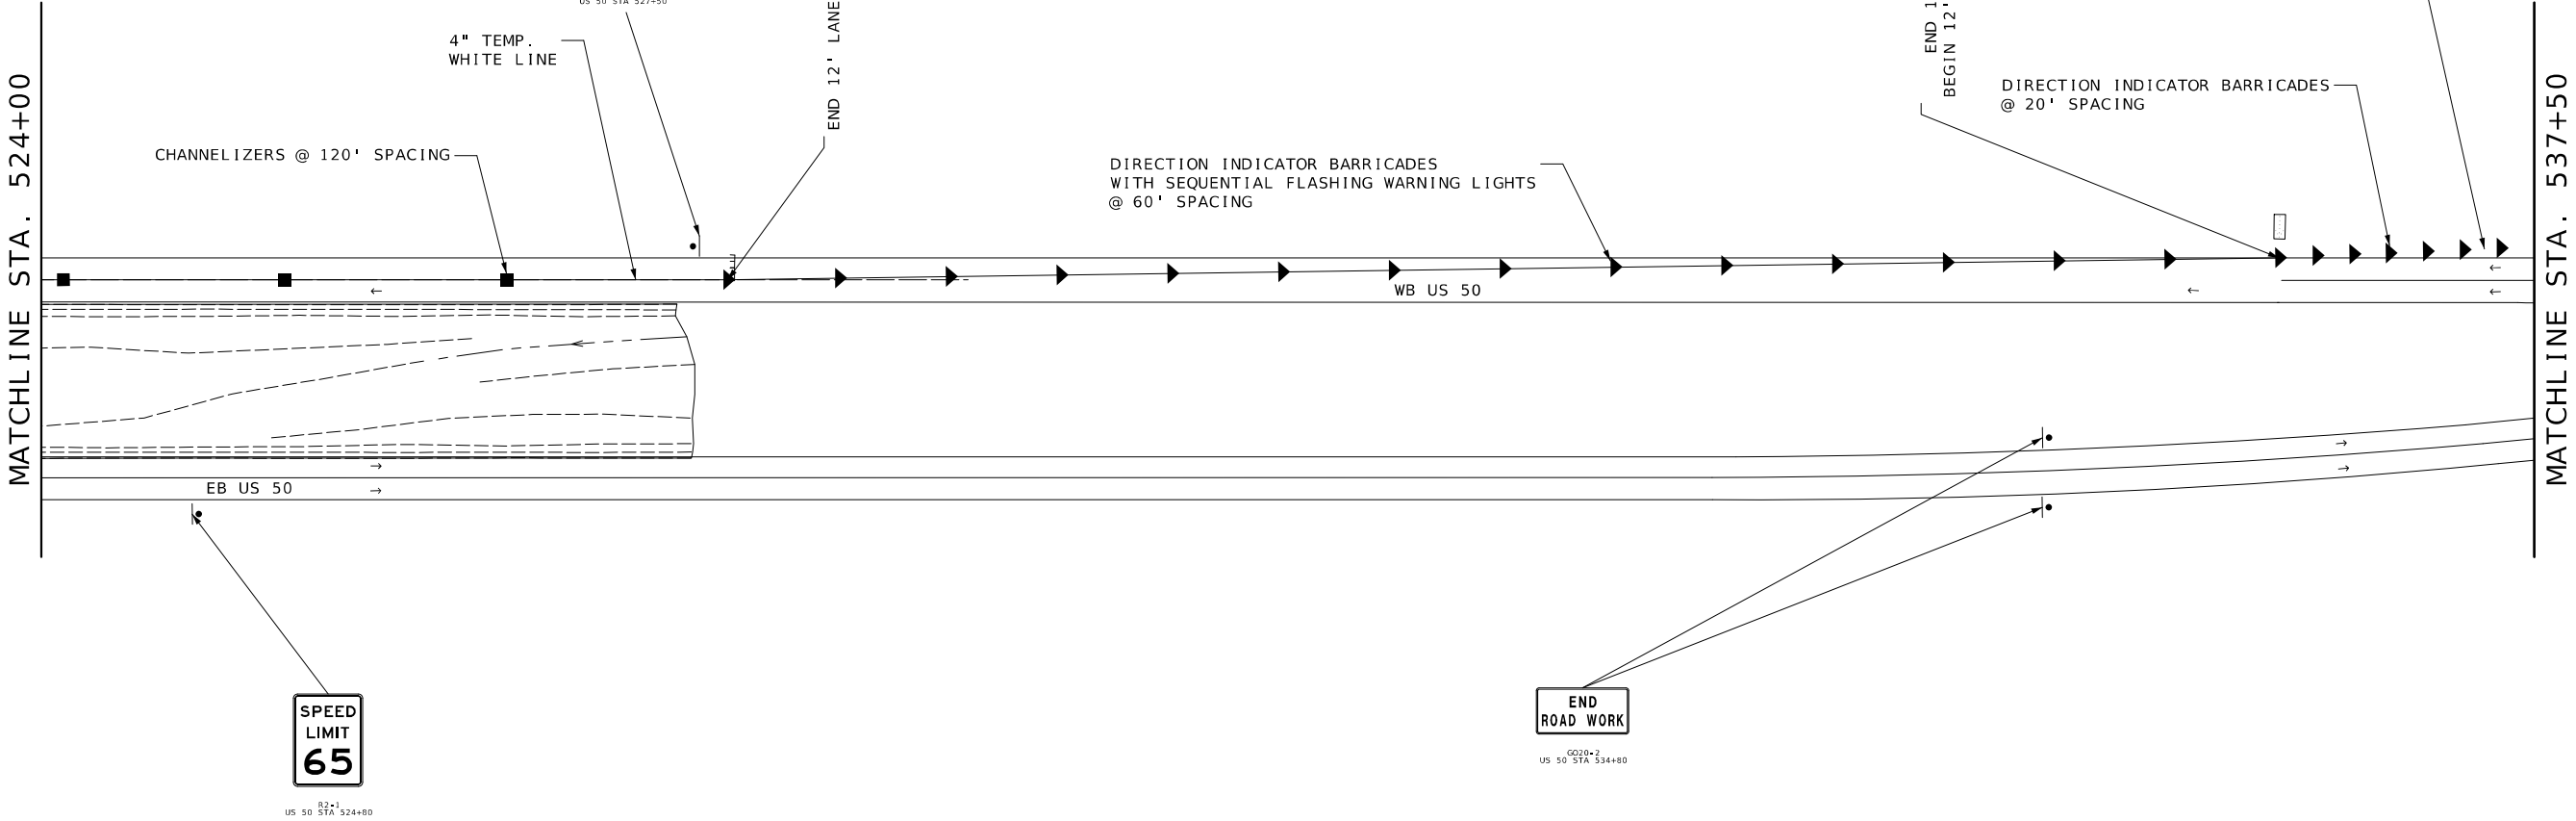

STATE OF MISSOURI

JACLYN A. WHITE

NUMBER

PE-2003001116

PROFESSIONAL ENGINEER

Jaclyn A. White

02/27/2025 1:12:14 PM

JACLYN A WHITE-CIVIL

MO-PE-2003001116

DATE PREPARED

12/31/2024

ROUTE

50

DISTRICT

KC

STATE

MO

SHEET NO.

22

COUNTY

JOHNSON

JOB NO.

JKR0102

CONTRACT ID.

PROJECT NO.

BRIDGE NO.

L0901

DESCRIPTION	DATE

MISSOURI HIGHWAYS AND TRANSPORTATION COMMISSION

MoDOT

 
105 WEST CAPITOL

JEFFERSON CITY, MO 65102



1-888-ASK-MODOT (1-888-275-6636)

TRAFFIC CONTROL LEGEND

- SIGN (SINGLE SIDED)
- ▬ SIGN (DOUBLE SIDED)
- ⌈ BARRICADE
- ▶ DIRECTION INDICATOR BARRICADE
- CHANNELIZER
- ◆ TUBULAR MARKER
- ⌈ CHANGEABLE MESSAGE BOARD
- ← LANE USE ARROW
- ⋯ FLASHING ARROW PANEL



MATCHLINE STA. 537+50

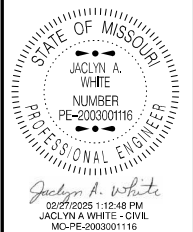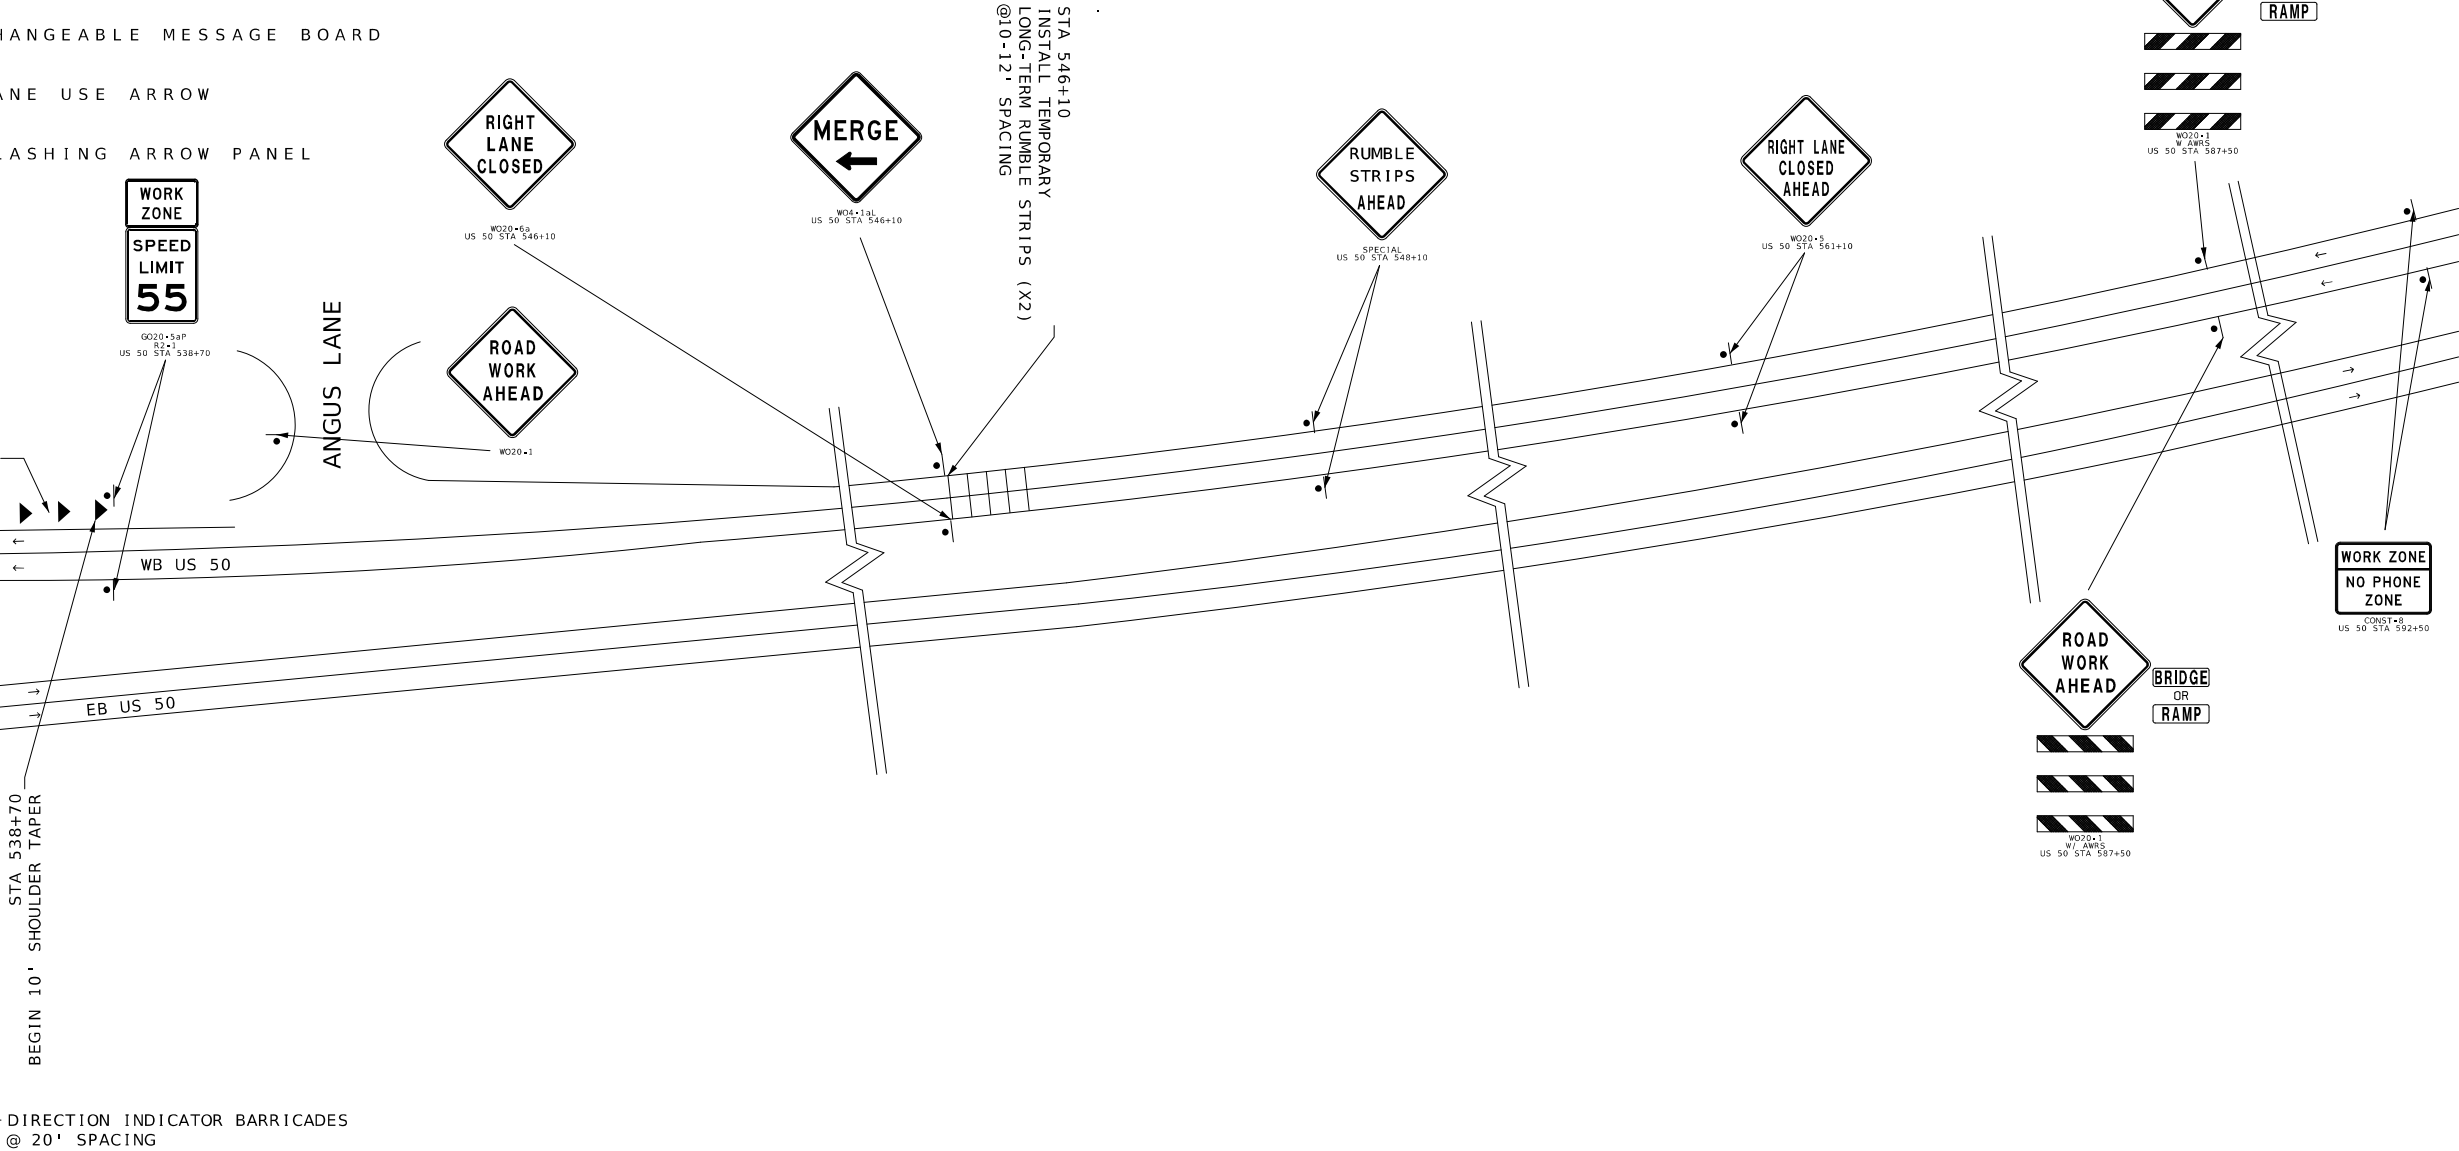

DATE PREPARED 12/31/2024	
ROUTE 50	STATE MO
DISTRICT KC	SHEET NO. 23
COUNTY JOHNSON	
JOB NO. JKR0102	
CONTRACT ID.	
PROJECT NO.	
BRIDGE NO. L0901	



DESCRIPTION	DATE

MISSOURI HIGHWAYS AND TRANSPORTATION
COMMISSION

105 WEST CAPITOL
JEFFERSON CITY, MO 65102
1-888-ASK-MODOT (1-888-275-6636)

TRAFFIC CONTROL LEGEND

 - SIGN (SINGLE SIDED)
- ▬ SIGN (DOUBLE SIDED)
- ┌ BARRICADE
- DIRECTION INDICATOR BARRICADE
- CHANNELIZER
- ◆ TUBULAR MARKER
- ▮ CHANGEABLE MESSAGE BOARD
- ← LANE USE ARROW
- ⬢ FLASHING ARROW PANEL

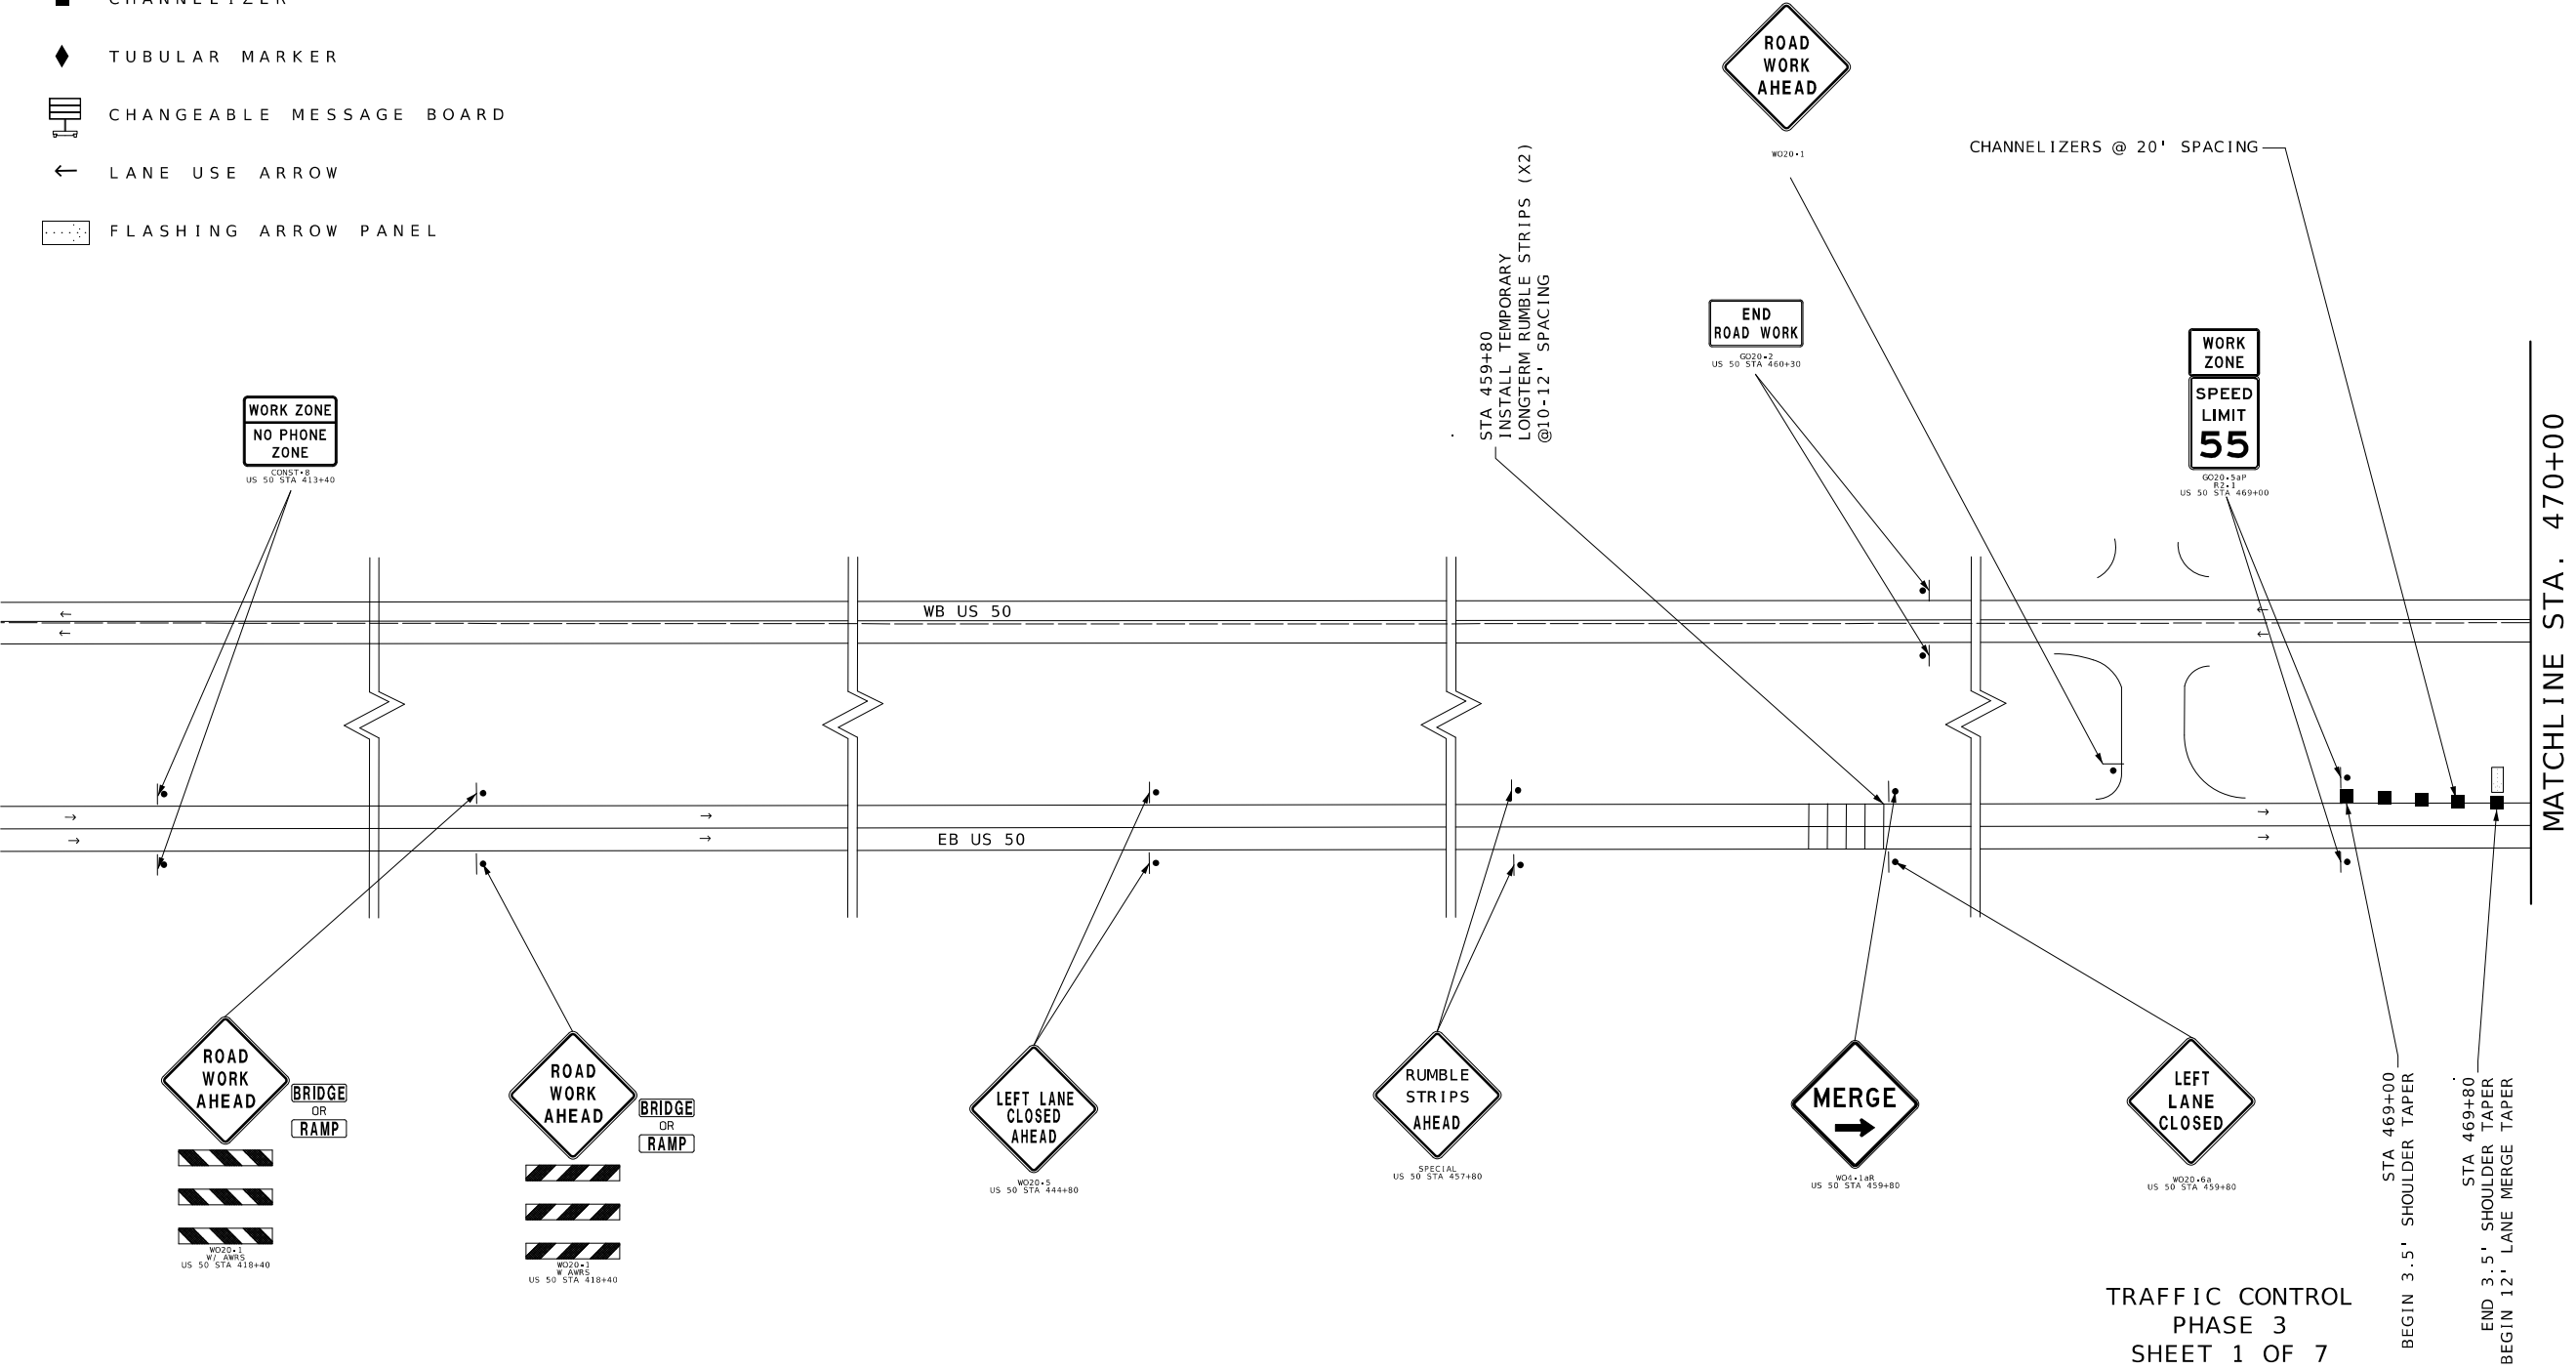

TRAFFIC CONTROL
PHASE 3
SHEET 1 OF 7

STATE OF MISSOURI

JACLYN A. WHITE

NUMBER

PE-2003001116

PROFESSIONAL ENGINEER

Jaclyn A. White

02/27/2025 1:13:20 PM

JACLYN A WHITE - CIVIL

MO-PE-2003001116

DATE PREPARED

12/31/2024

ROUTE

50

STATE

MO

DISTRICT

KC

SHEET NO.

24

COUNTY

JOHNSON

JOB NO.

JKR0102

CONTRACT ID.

PROJECT NO.

BRIDGE NO.

L0901

DESCRIPTION	DATE

MISSOURI HIGHWAYS AND TRANSPORTATION COMMISSION

MoDOT


 
105 WEST CAPITOL

JEFFERSON CITY, MO 65102


1-888-ASK-MODOT (1-888-275-6636)

TRAFFIC CONTROL LEGEND

- SIGN (SINGLE SIDED)
- SIGN (DOUBLE SIDED)
- BARRICADE
- DIRECTION INDICATOR BARRICADE
- CHANNELIZER
- TUBULAR MARKER
- CHANGEABLE MESSAGE BOARD
- LANE USE ARROW
- FLASHING ARROW PANEL

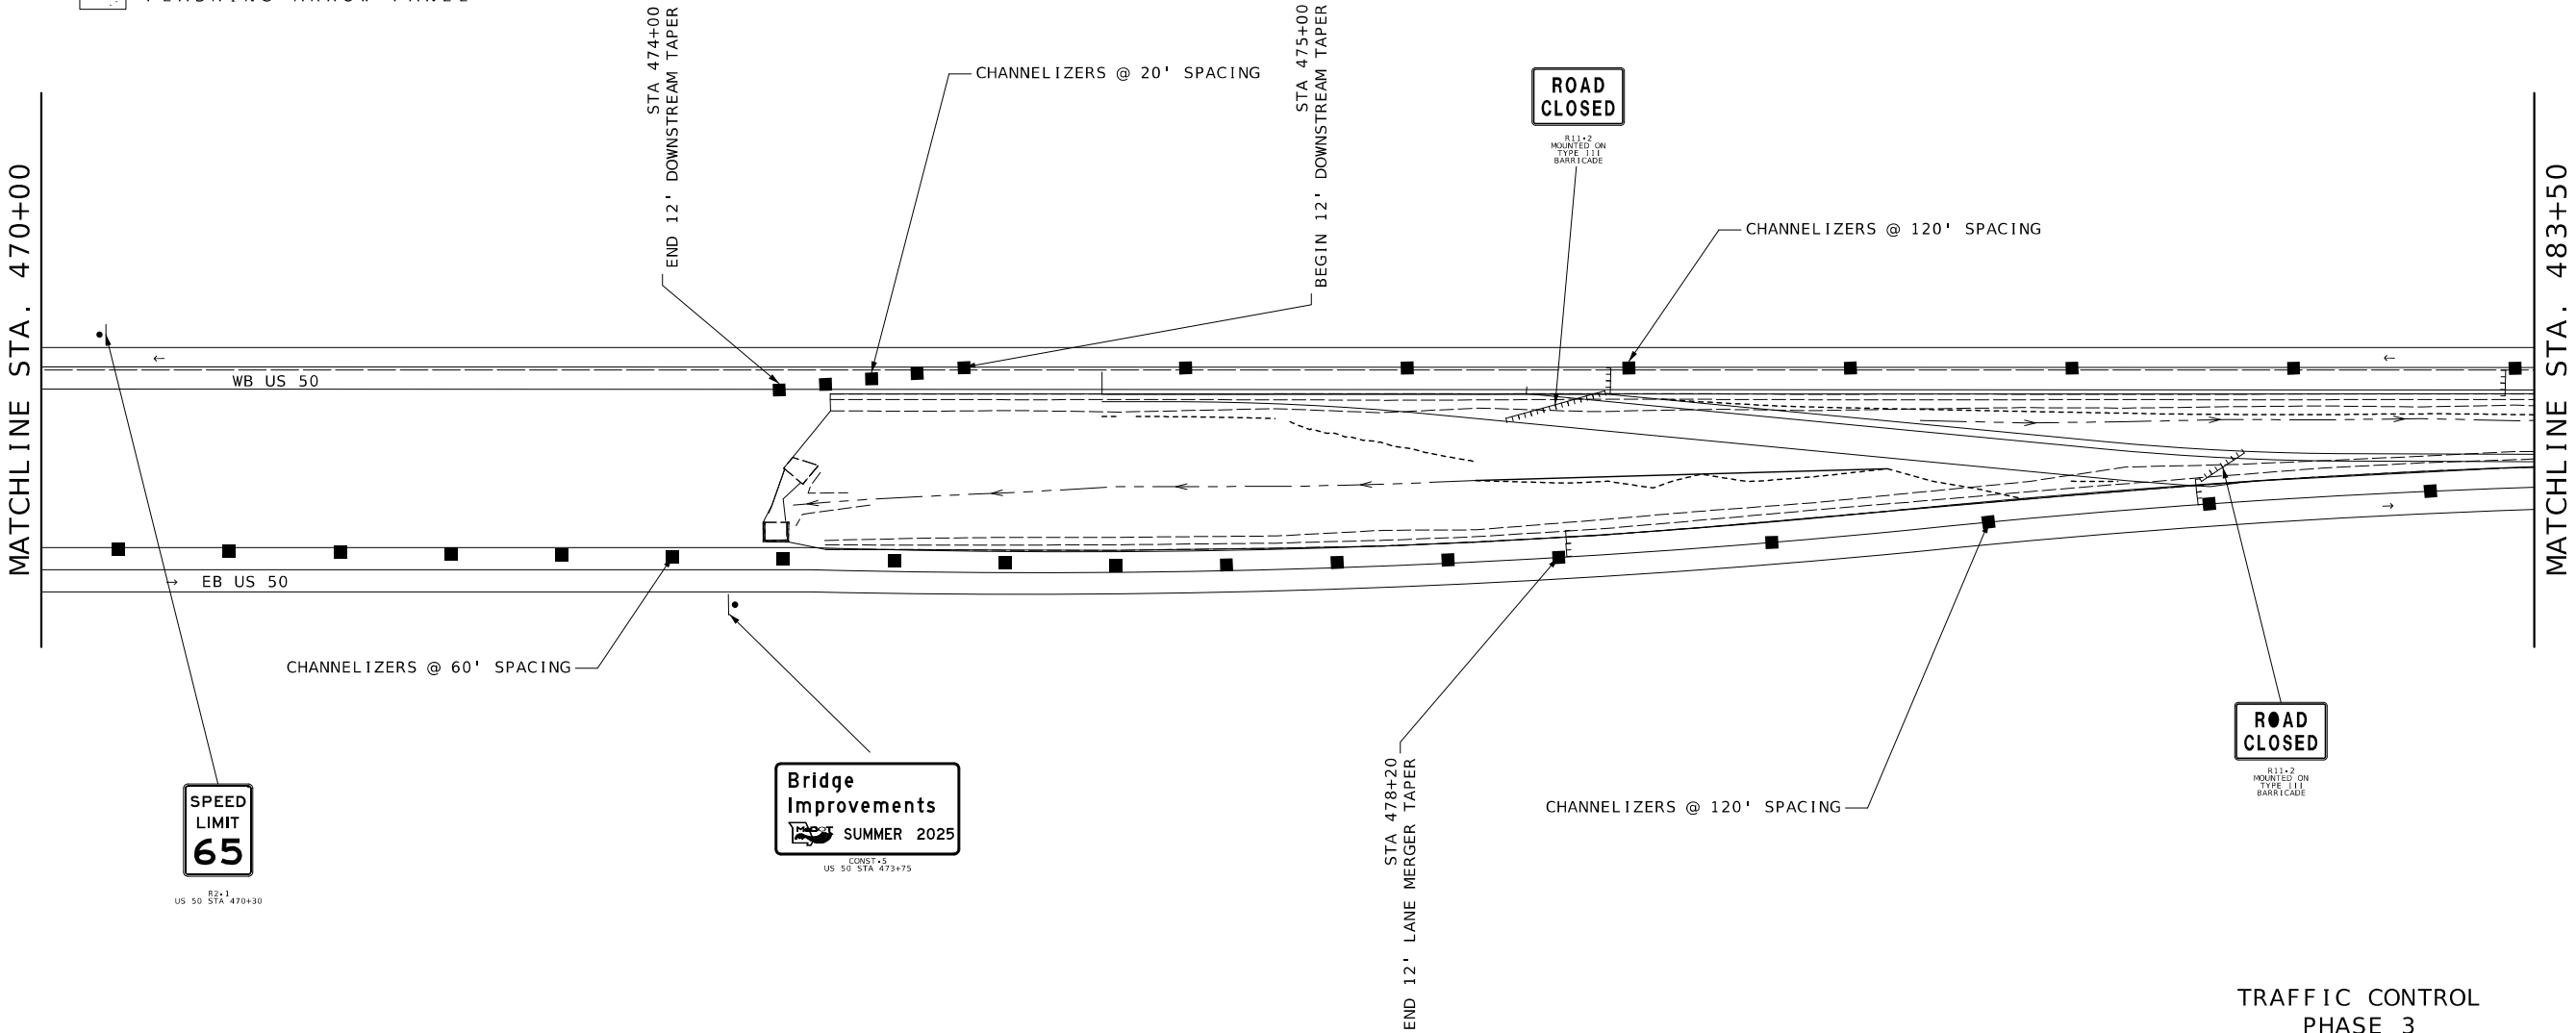

TRAFFIC CONTROL
PHASE 3
SHEET 2 OF 7

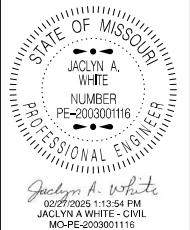

DATE PREPARED 12/31/2024	
ROUTE 50	STATE MO
DISTRICT KC	SHEET NO. 25
COUNTY JOHNSON	
JOB NO. JKR0102	
CONTRACT ID.	
PROJECT NO.	
BRIDGE NO. L0901	


DATE	DESCRIPTION

MISSOURI HIGHWAYS AND TRANSPORTATION
COMMISSION


105 WEST CAPITOL
JEFFERSON CITY, MO 65102
1-888-ASK-MODOT (1-888-275-6636)

TRAFFIC CONTROL LEGEND

 
- SIGN (SINGLE SIDED)
- SIGN (DOUBLE SIDED)
- BARRICADE
- DIRECTION INDICATOR BARRICADE
- CHANNELIZER
- TUBULAR MARKER
- CHANGEABLE MESSAGE BOARD
- LANE USE ARROW
- FLASHING ARROW PANEL



MATCHLINE STA. 483+50

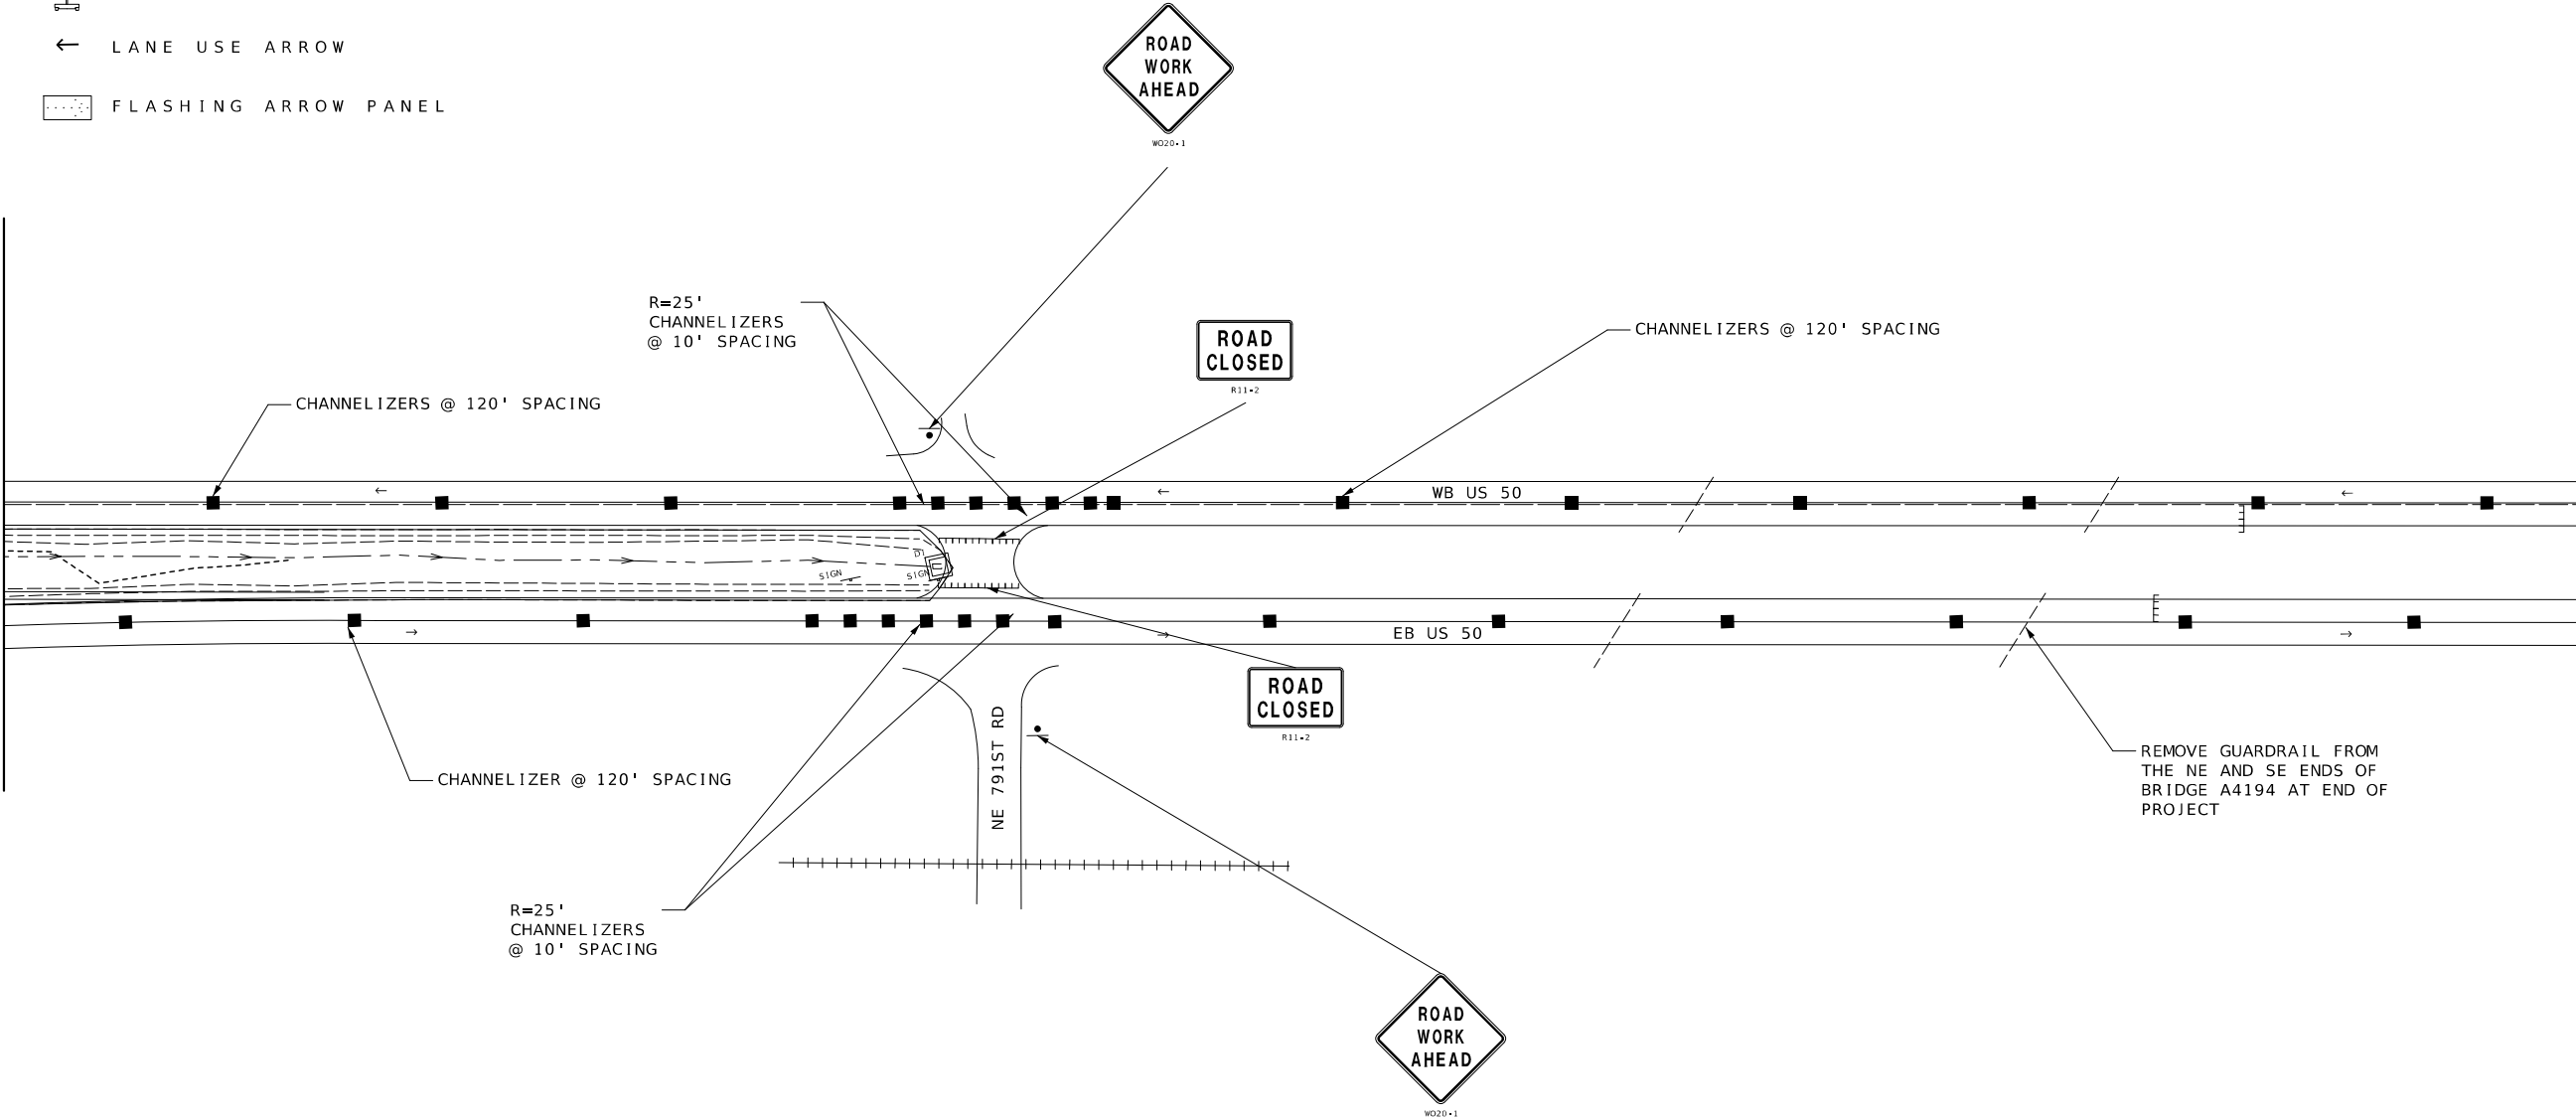

MATCHLINE STA. 497+00

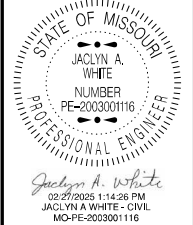

DATE PREPARED 12/31/2024	
ROUTE 50	STATE MO
DISTRICT KC	SHEET NO. 26
COUNTY JOHNSON	
JOB NO. JKR0102	
CONTRACT ID.	
PROJECT NO.	
BRIDGE NO. L0901	



DATE	DESCRIPTION

MISSOURI HIGHWAYS AND TRANSPORTATION COMMISSION


105 WEST CAPITOL
JEFFERSON CITY, MO 65102
1-888-ASK-MODOT (1-888-275-6636)

TRAFFIC CONTROL LEGEND

 -  SIGN (SINGLE SIDED)
-  SIGN (DOUBLE SIDED)
-  BARRICADE
-  DIRECTION INDICATOR BARRICADE
-  CHANNELIZER
-  TUBULAR MARKER
-  CHANGEABLE MESSAGE BOARD
-  LANE USE ARROW
-  FLASHING ARROW PANEL

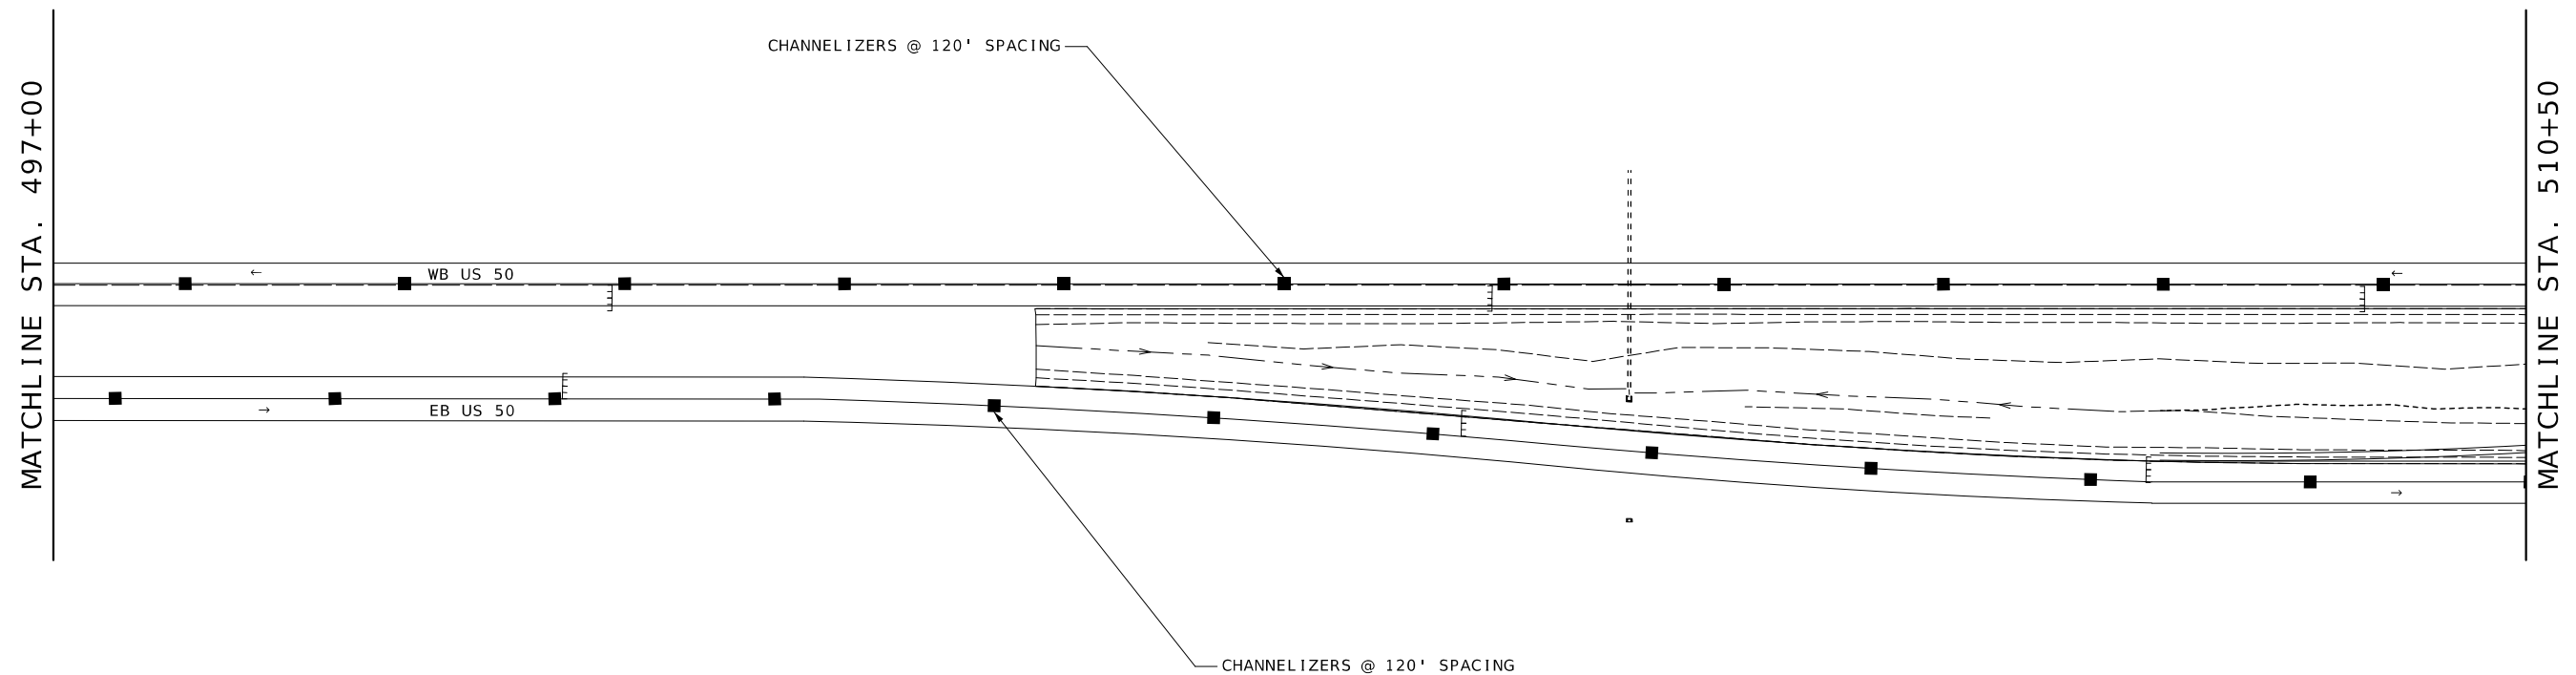

TRAFFIC CONTROL
PHASE 3
SHEET 4 OF 7

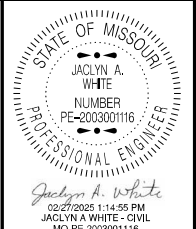

DATE PREPARED	
12/31/2024	
ROUTE	STATE
50	MO
DISTRICT	SHEET NO.
KC	27
COUNTY	
JOHNSON	
JOB NO.	
JKR0102	
CONTRACT ID.	
PROJECT NO.	
BRIDGE NO.	
L0901	


 
[illegible]

**MISSOURI HIGHWAYS AND TRANSPORTATION
COMMISSION**


 105 WEST CAPITOL
JEFFERSON CITY, MO 65102
1-888-ASK-MODOT (1-888-273-6636)

TRAFFIC CONTROL LEGEND

- SIGN (SINGLE SIDED)
- SIGN (DOUBLE SIDED)
- BARRICADE
- DIRECTION INDICATOR BARRICADE
- CHANNELIZER
- TUBULAR MARKER
- CHANGEABLE MESSAGE BOARD
- LANE USE ARROW
- FLASHING ARROW PANEL

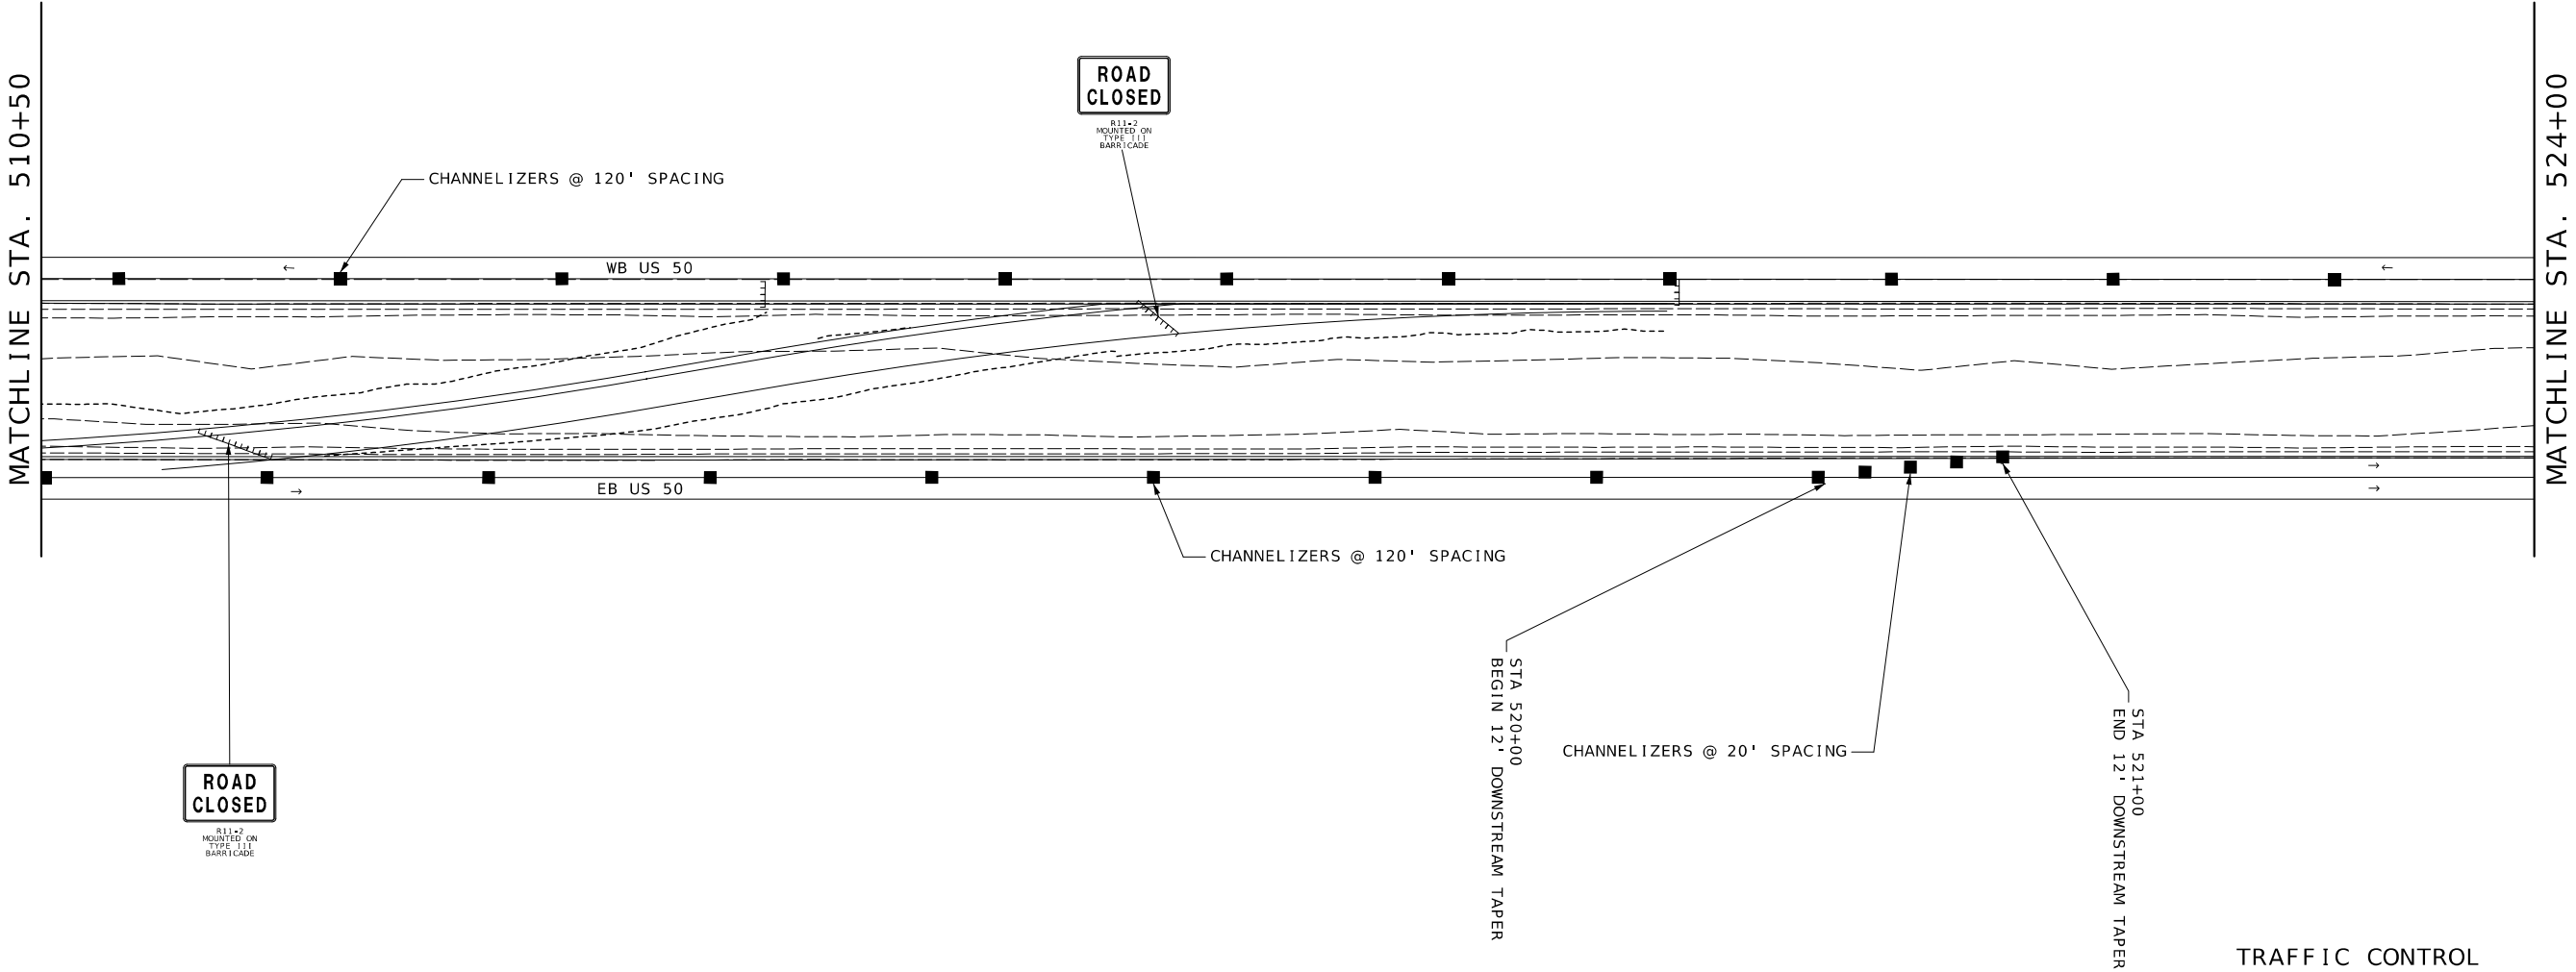

TRAFFIC CONTROL
PHASE 3
SHEET 5 OF 7

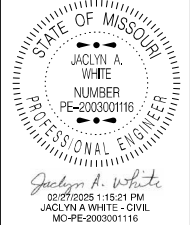



DATE PREPARED 12/31/2024	
ROUTE 50	STATE MO
DISTRICT KC	SHEET NO. 28
COUNTY JOHNSON	
JOB NO. JKR0102	
CONTRACT ID.	
PROJECT NO.	
BRIDGE NO. L0901	

DATE	DESCRIPTION


MISSOURI HIGHWAYS AND TRANSPORTATION
COMMISSION

105 WEST CAPITOL
JEFFERSON CITY, MO 65102
1-888-ASK-MODOT (1-888-275-6636)

	SIGN (SINGLE SIDED)
	SIGN (DOUBLE SIDED)
	BARRICADE
	DIRECTION INDICATOR BARRICADE
	CHANNELIZER
	TUBULAR MARKER
	CHANGEABLE MESSAGE BOARD
	LANE USE ARROW
	FLASHING ARROW PANEL

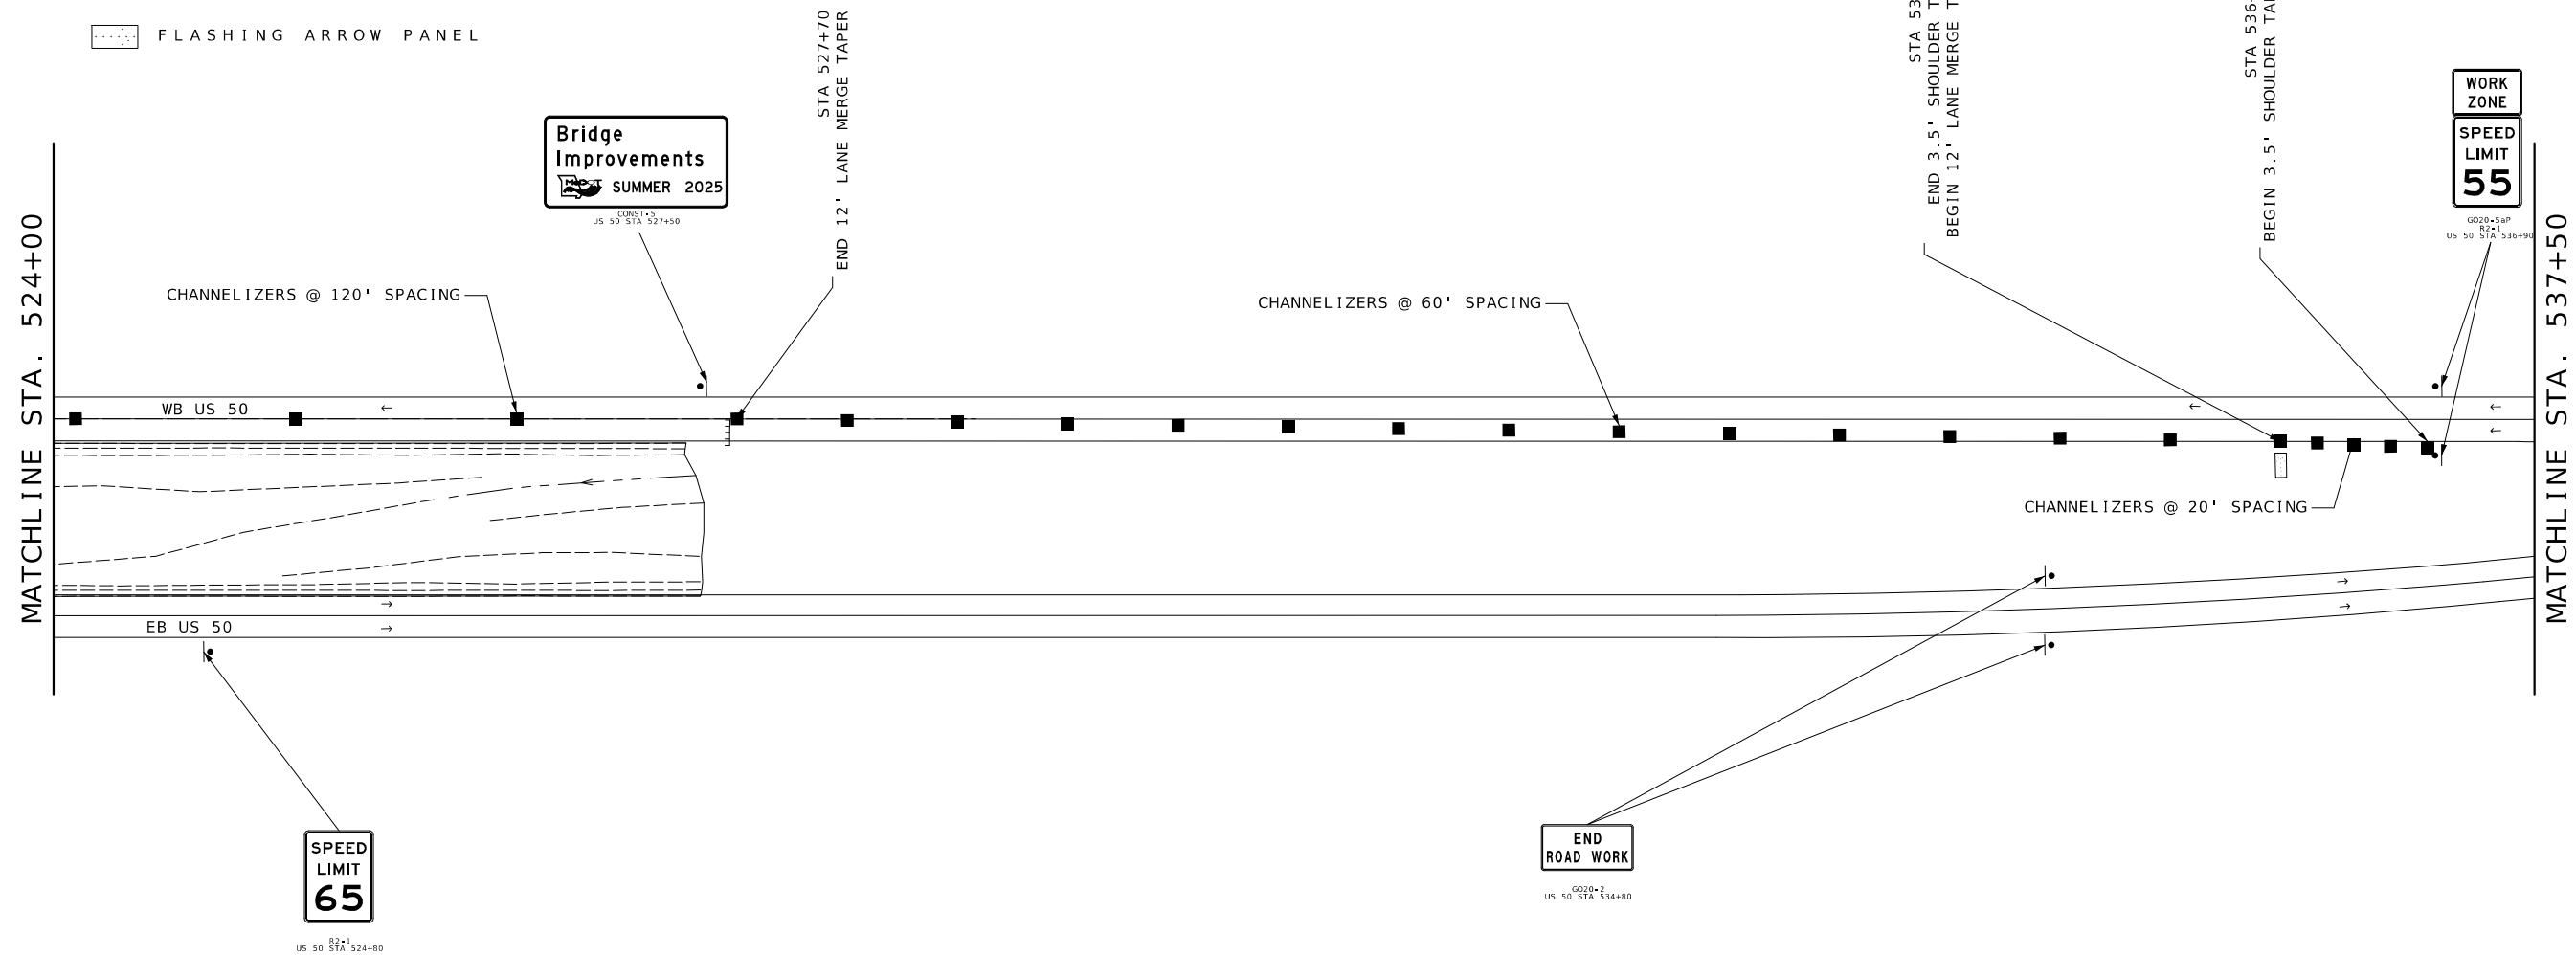 

TRAFFIC CONTROL
PHASE 3
SHEET 6 OF 7

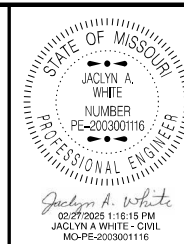


DATE PREPARED	
12/31/2024	
ROUTE	STATE
50	MO
DISTRICT	SHEET NO.
KC	29
COUNTY	
JOHNSON	
JOB NO.	
JKR0102	
CONTRACT ID.	
PROJECT NO.	

BRIDGE NO.
L0901


[illegible]MISSOURI HIGHWAYS AND TRANSPORTATION
COMMISSION

105 WEST CAPITOL
JEFFERSON CITY, MO 65102
1-888-ASK-MODOT (1-888-275-6636)

- SIGN (SINGLE SIDED)
- SIGN (DOUBLE SIDED)
- BARRICADE
- DIRECTION INDICATOR BARRICADE
- CHANNELIZER
- TUBULAR MARKER
- CHANGEABLE MESSAGE BOARD
- LANE USE ARROW
- FLASHING ARROW PANEL

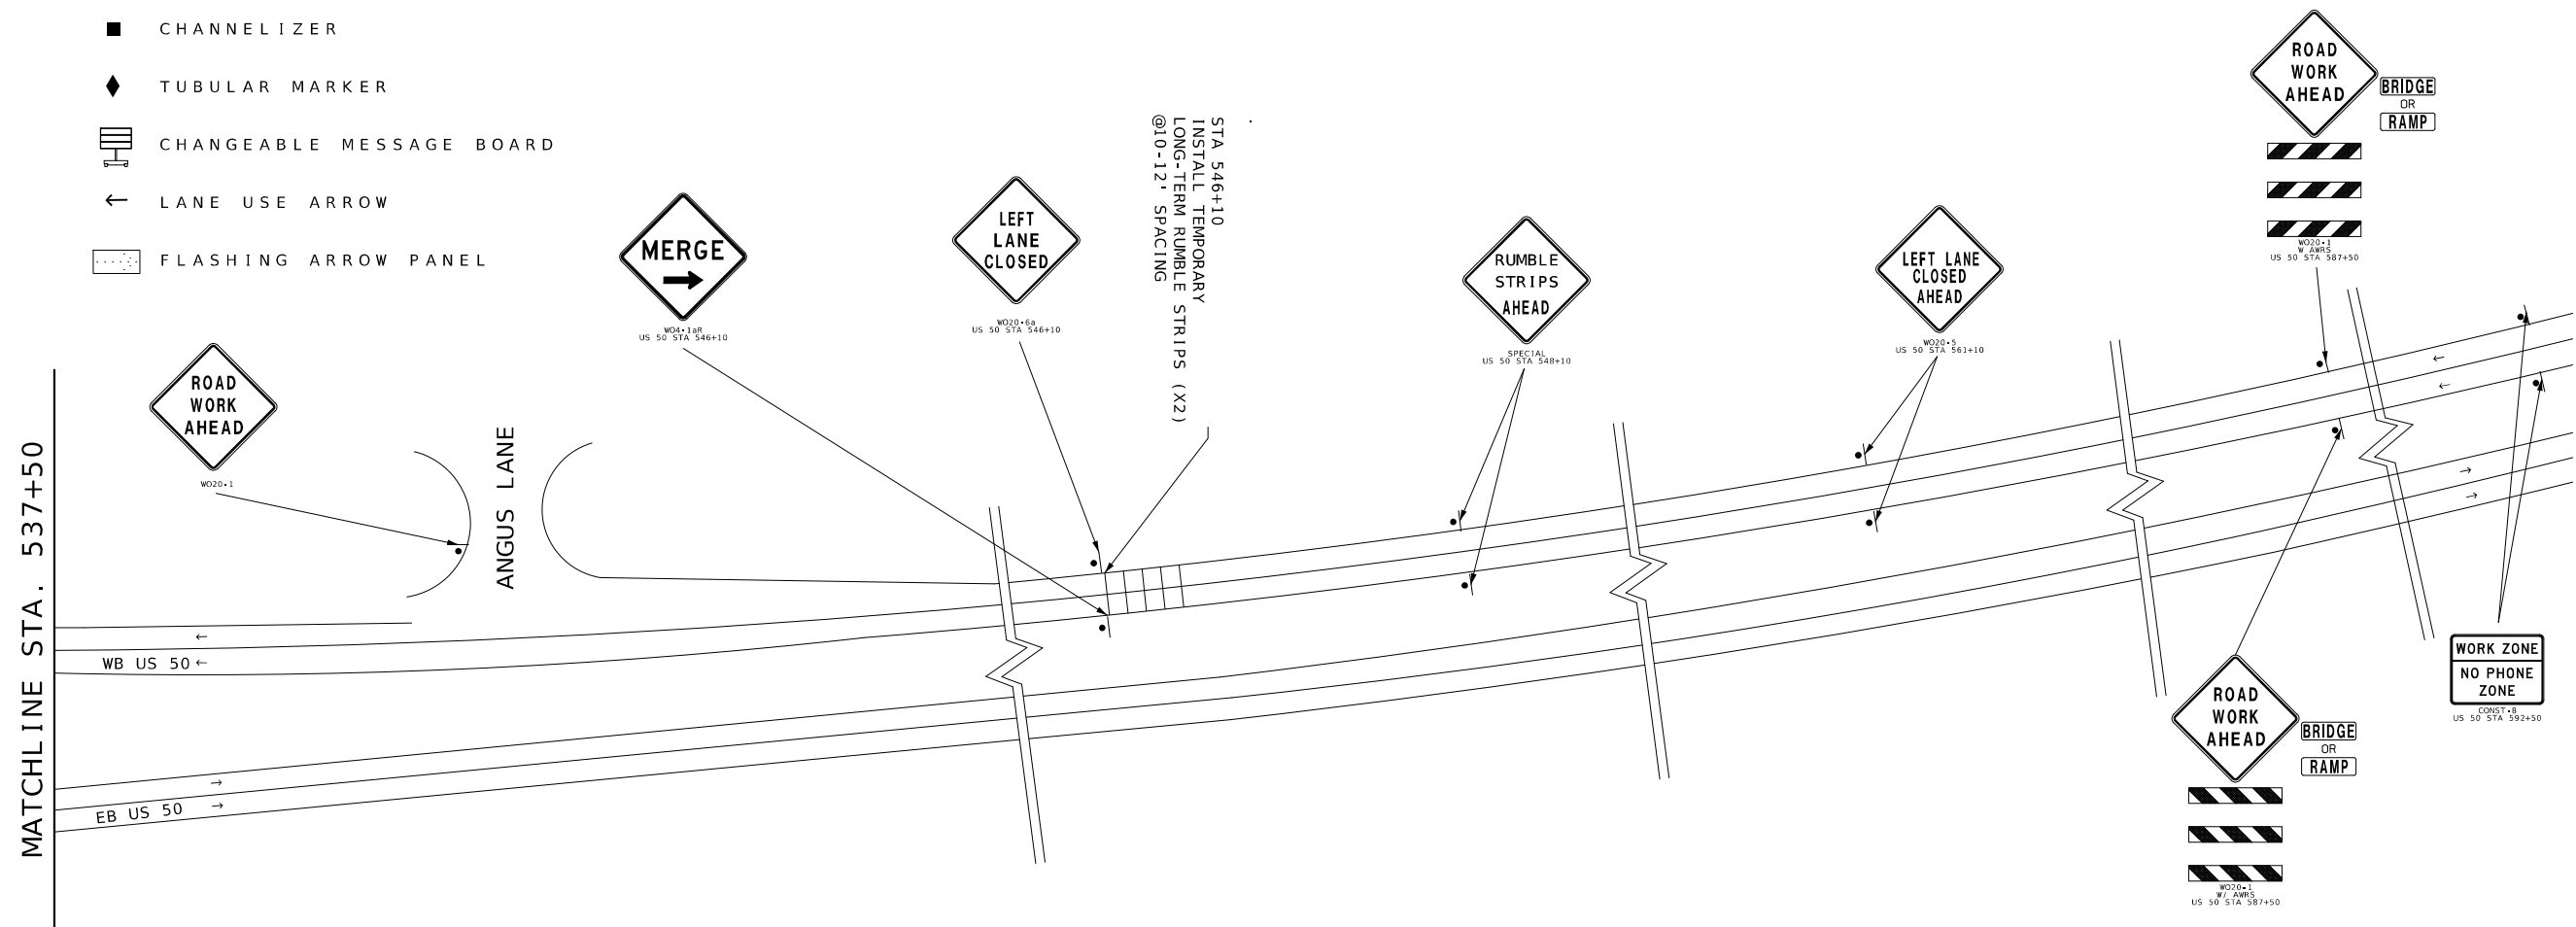

TRAFFIC CONTROL
PHASE 3
SHEET 7 OF 7

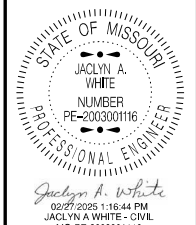

DATE PREPARED
12/31/2024

ROUTE	STATE
50	MO

DISTRICT	SHEET NO.
KC	30

COUNTY
JOHNSON

JOB NO.
JKR0102

CONTRACT ID.

PROJECT NO.

BRIDGE NO. _____

[illegible]

MISSOURI HIGHWAYS AND TRANSPORTATION
COMMISSION


105 WEST CAPITOL
JEFFERSON CITY, MO 65102
1-888-ASK-MODOT (1-888-275-6636)

TEMPORARY EROSION CONTROL LEGEND

- R

ROCK DITCH CHECK
- S
- SEDIMENT TRAP
-
- TEMPORARY SEEDING AND MULCHING

*NOTE - SEDIMENT TRAPS PLACED AT CULVERT OUTLETS
ROCK DITCH CHECKS ASSUMED 9" EFFECTIVE HEIGHT

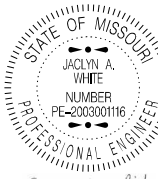

DATE PREPARED
11/26/2024

ROUTE	STATE
50	MO

DISTRICT	SHEET NO.
KC	31

COUNTY
JOHNSON

JOB NO.
JKR0102

CONTRACT ID.

PROJECT NO.



BRIDGE NO.
L0901

DATE	DESCRIPTION

MISSOURI HIGHWAYS AND TRANSPORTATION COMMISSION



 105 WEST CAPITOL
JEFFERSON CITY, MO 65102
1-888-ASK-MODOT (1-888-275-6636)

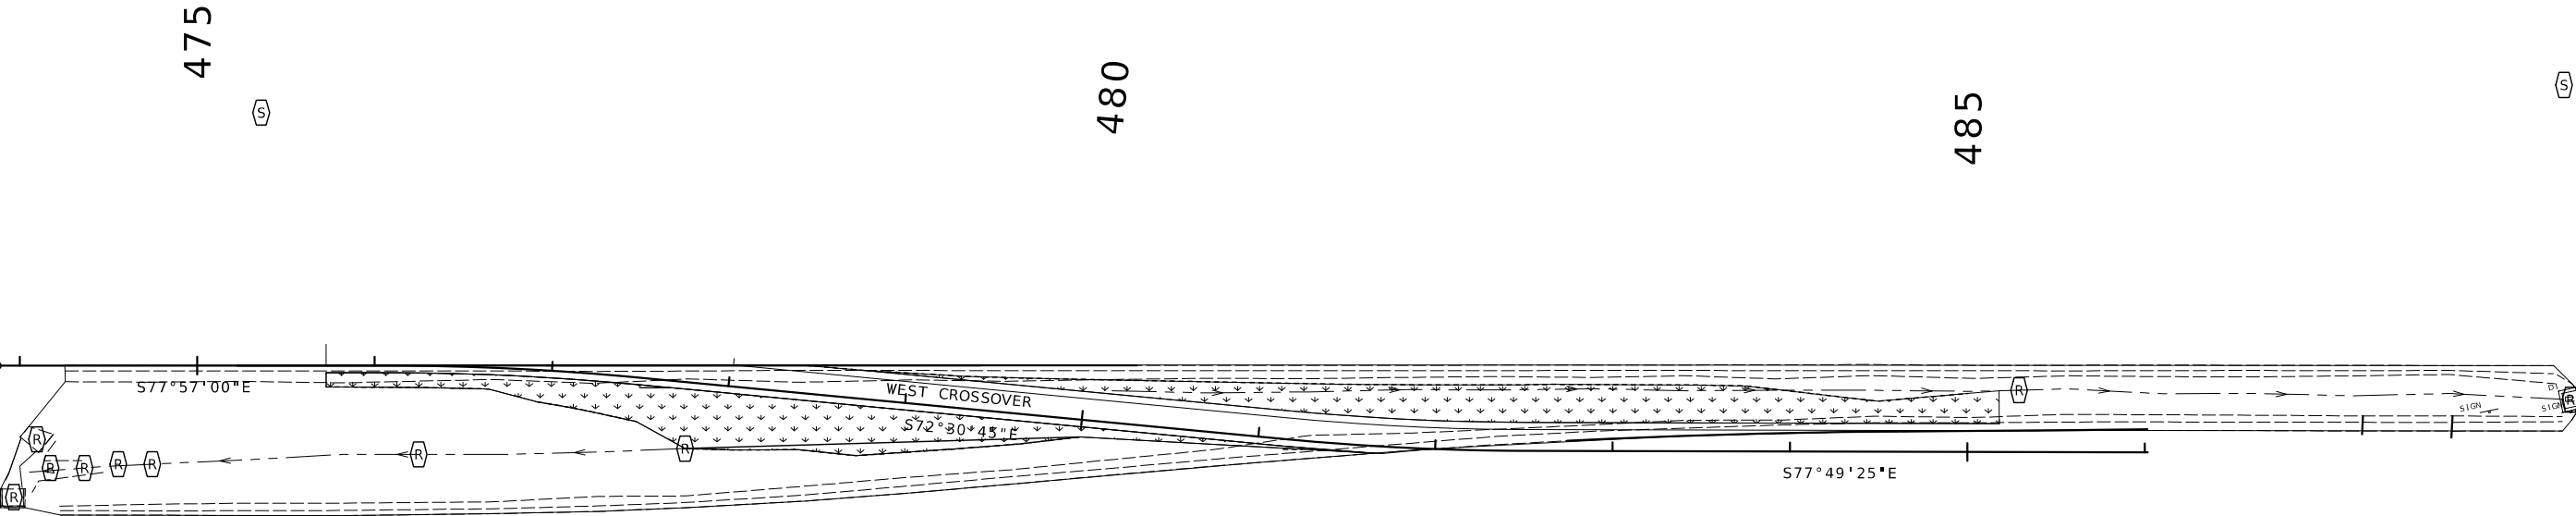

TEMPORARY EROSION CONTROL LEGEND

 

- 

ROCK DITCH CHECK
- 

SEDIMENT TRAP
- 

TEMPORARY SEEDING AND MULCHING

*NOTE - SEDIMENT TRAPS PLACED AT CULVERT OUTLETS
ROCK DITCH CHECKS ASSUMED 9" EFFECTIVE HEIGHT

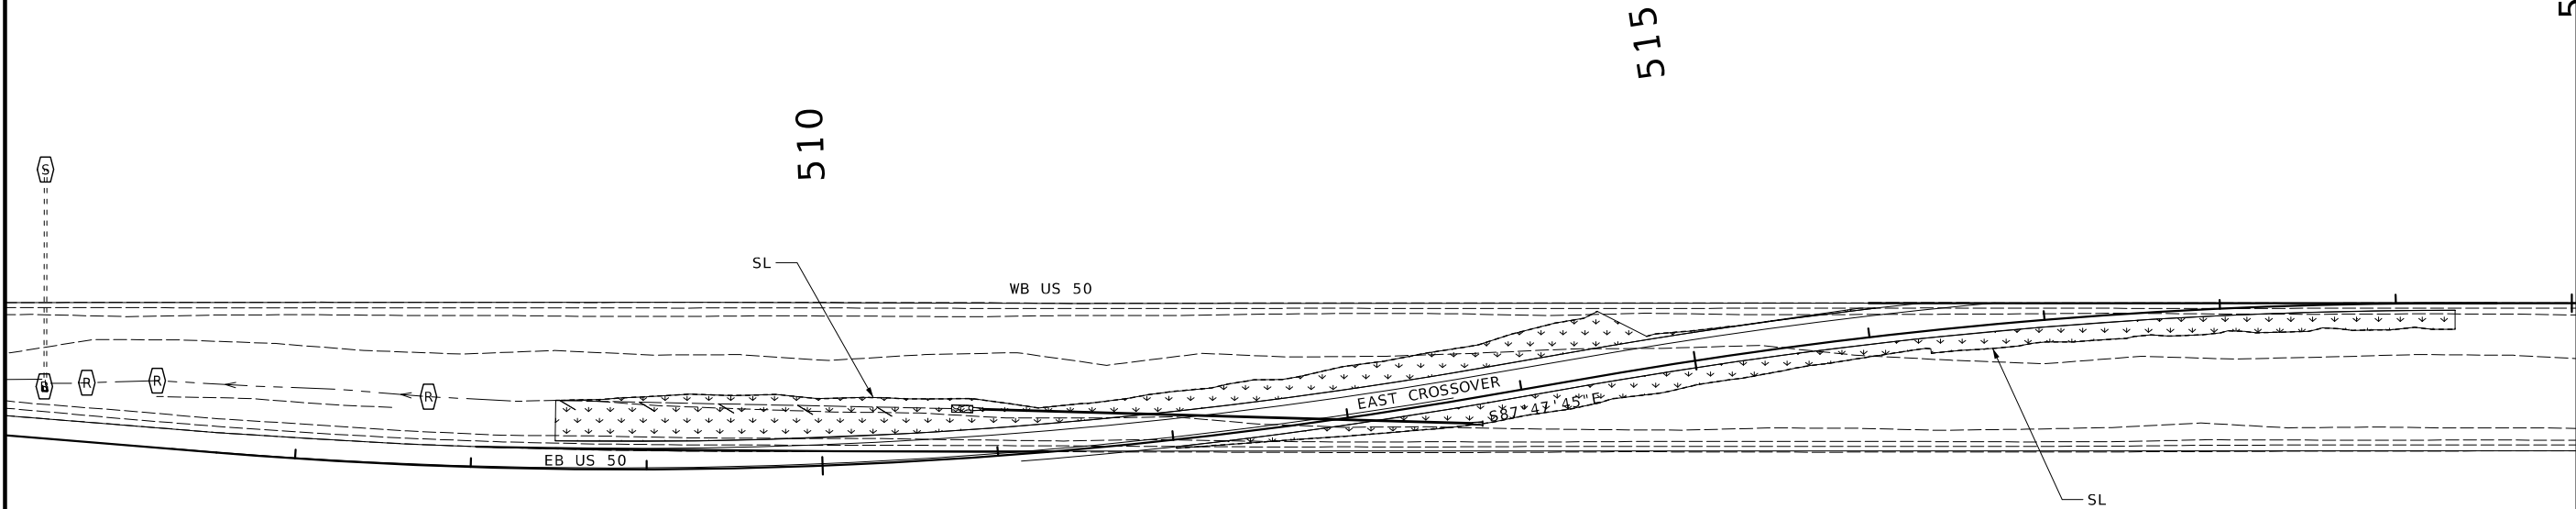



JACLYN A. WHITE
NUMBER
PE-2003001116
PROFESSIONAL ENGINEER

Jaclyn A. White
02/27/2025 1:17:47 PM
JACLYN A WHITE - CIVIL
MO-PE-2003001116

DATE PREPARED	
11/26/2024	
ROUTE	STATE
50	MO
DISTRICT	SHEET NO.
KC	32
COUNTY	
JOHNSON	
JOB NO.	
JKR0102	
CONTRACT ID.	
PROJECT NO.	
BRIDGE NO.	
L0901	

DESCRIPTION	DATE

MISSOURI HIGHWAYS AND TRANSPORTATION COMMISSION



105 WEST CAPITOL
JEFFERSON CITY, MO 65102
1-888-ASK-MODOT (1-888-275-6636)

PERMANENT EROSION CONTROL LEGEND



SEEDING - COOL SEASON MIXTURES



Jaclyn A. White
12/27/2025 1:18:14 PM
JACLYN A WHITE - CIVIL
MO-PE-2003001116

DATE PREPARED
11/26/2024

ROUTE 50 STATE MO

DISTRICT KC SHEET NO. 33

COUNTY JOHNSON

JOB NO.
JKR0102

CONTRACT ID.


 
PROJECT NO.


BRIDGE NO.
L0901

MISSOURI HIGHWAYS AND TRANSPORTATION COMMISSION



105 WEST CAPITOL
JEFFERSON CITY, MO 65102
1-888-ASK-MODOT (1-888-275-6636)

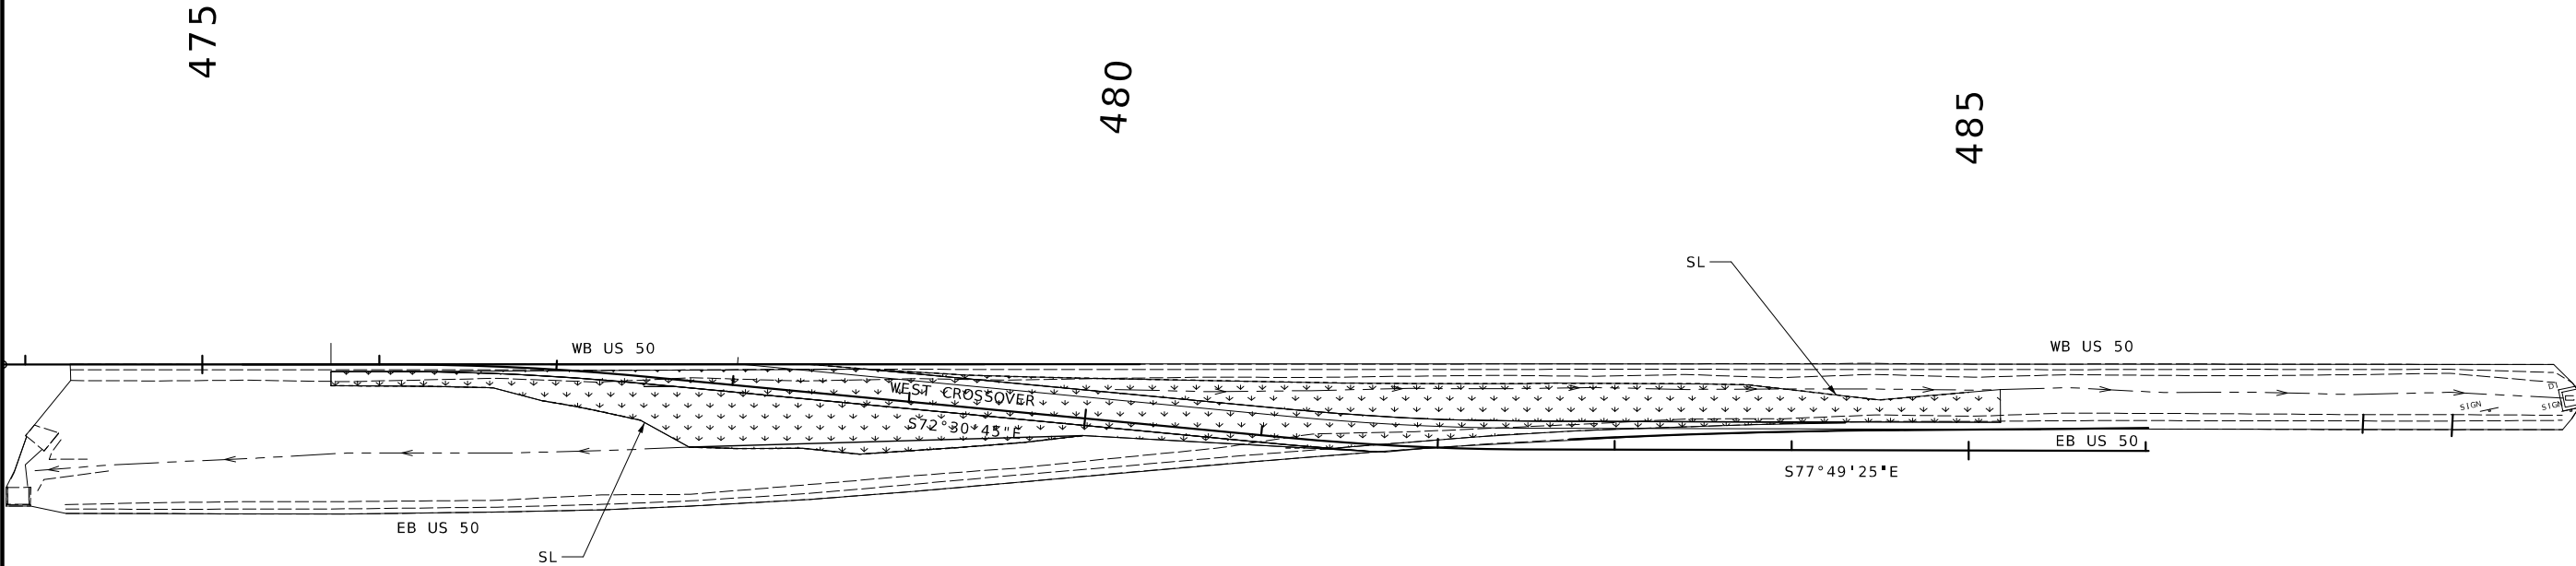

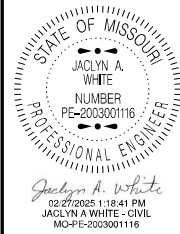 SEEDING - COOL SEASON MIXTURES

DATE PREPARED

11 / 26 / 2024

ROUTE 50	STATE MO
-------------	-------------

DISTRICT KC	SHEET NO. 34
----------------	-----------------

COUNTY
JOHNSON

JOB NO.
JKR0102

CONTRACT ID.

PROJECT NO.

BRIDGE NO.
L0901

520

DESCRIPTION

 
DATE _____


MISSOURI HIGHWAYS AND TRANSPORTATION



MISSOURI
DEPARTMENT OF
TRANSPORTATION

PERMANENT EROSION CONTROL
SHEET 2 OF 2



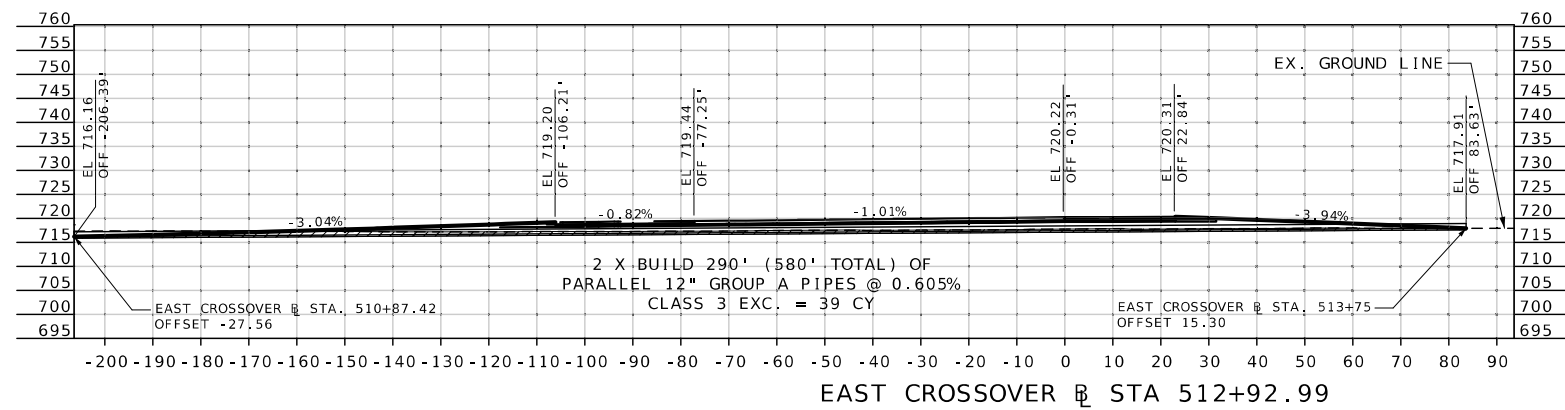

Jaclyn A. White
02/27/2025 1:19:09 PM
JACLYN A WHITE - CIVIL
MO-PE-2003001116

DATE PREPARED

12/31/2024

ROUTE	STATE
-------	-------

50	MO
----	----

DISTRICT	SHEET NO.
----------	-----------

KC	35
----	----

COUNTY

JOHNSON

JOB NO.

JKR0102

CONTRACT ID.

PROJECT NO.

BRIDGE NO.

L0901

[illegible]

MISSOURI HIGHWAYS AND TRANSPORTATION
COMMISSION

105 WEST CAPITOL
JEFFERSON CITY, MO 65102
1-888-ASK-MODOT (1-888-275-4636)


CULVERT SECTION
SHEET 1 OF 1

Table Showing S2 Bar Lengths			
Int. Bent No. 2		Int. Bent No. 3	
Span 1	Span 2	Span 2	Span 3
19'-0"	19'-0"	19'-0"	19'-0"

Required Lap Length
For Bar Splices **



Bar Size	Splice Length
4	2'-7"
5	3'-3"
6	3'-10"
7	4'-11"

** Unless otherwise shown.

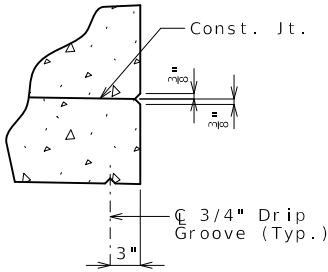


DETAIL B


U.I.P., REDECK AND MAKE COMPOSITE EXISTING (65'- 80'- 65') CONTINUOUS WIDE FLANGE BEAM SPANS
(SKEW: 32° L.A.)

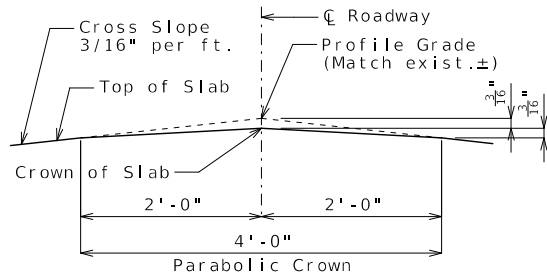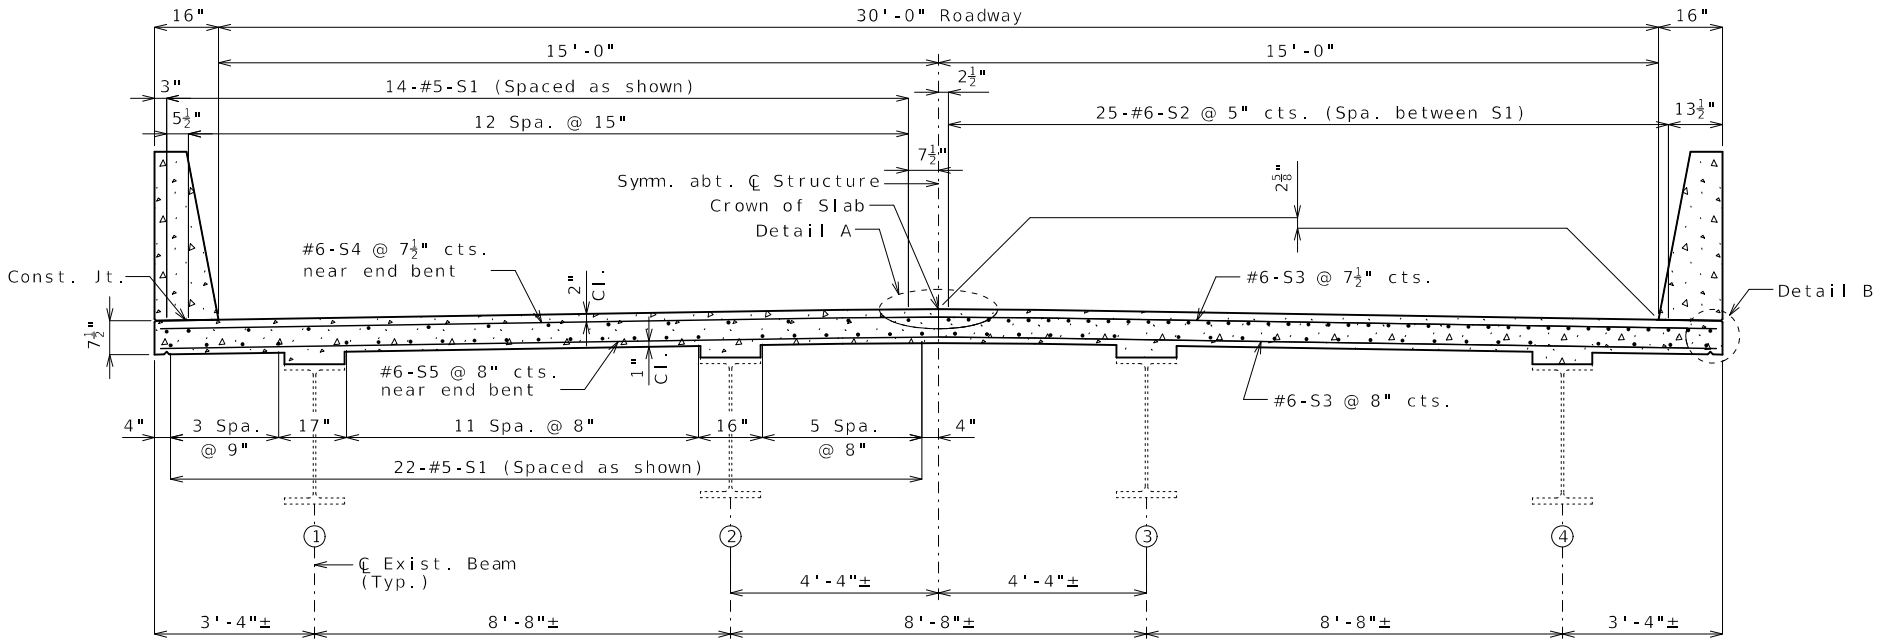

DETAIL A

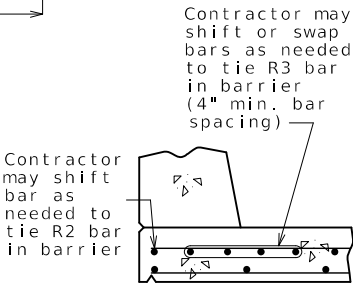

OPTIONAL SHIFTING
TOP BARS AT BARRIER

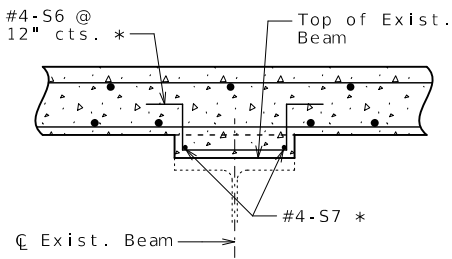

PART SECTION SHOWING HAIRPIN
BARS IN SLAB HAUNCH

Hairpin bars may be placed at an angle to meet clearances

* Int. Beam only

Estimated Quantities		
Item		Total
Removal of Existing Bridge Deck	sq. foot	6772
Removal of Existing Bridge Approach Slab	sq. foot	1584
Bridge Approach Slab (Major)	sq. yard	175
Slab on Steel	sq. yard	778
Type D Barrier	linear foot	427
Protective Coating - Concrete Bents and Piers (Epoxy)	lump sum	1
Shear Connectors	each	1632
Slab Drain	each	34
Non-Destructive Testing	linear foot	19
Open Cell Foam Joint Seal	linear foot	74

Cost of any required excavation for bridge will be considered completely covered by the contract unit price for other items.

Estimated Quantities for Slab on Steel		
Item		Total
Class B-2 Concrete	cu. yard	196
Reinforcing Steel (Epoxy Coated)	pound	60,410
Curing Material	gallon	36

The table of Estimated Quantities for Slab on Steel represents the quantities used by the State in preparing the cost estimate for concrete slabs. The area of the concrete slab will be measured to the nearest square yard longitudinally from end of slab to end of slab and transversely from out to out of bridge slab (or with the horizontal dimensions as shown on the plan of slab). Payment for stay-in-place corrugated steel forms, conventional forms, all concrete and epoxy coated reinforcing steel will be considered completely covered by the contract unit price for the slab. Variations may be encountered in the estimated quantities but the variations cannot be used for an adjustment in the contract unit price.

Method of forming the slab shall be in accordance with Sec 703. All hardware for forming the slab to be left in place as a permanent part of the structure shall be coated in accordance with ASTM A123 or ASTM B633 with a thickness Class SC 4 and a finish Type I, II or III.

Slab shall be cast-in-place with conventional forming or stay-in-place corrugated steel forms. Precast prestressed panels will not be permitted.

For Optional Stay-In-Place Form Details, see Sheet No. 2.

REPAIRS TO BRIDGE:
ROUTE 50 WB OVER CLEAR CREEK

ROUTE 50 WB FROM ROUTE 23 TO ROUTE P
ABOUT 1.4 MILES WEST OF ROUTE 23
BEGINNING STATION 492+35.50± (MATCH EXISTING)

General Notes:

Design Specifications:
2002 AASHTO LFD (17th Ed.) Standard Specifications
Seismic Performance Category A

Design Loading:
HS20-44 (1953) (Existing)
HS20-44 (New Construction)
35 lb/sf Future Wearing Surface
Earth - 120 lb/cf, Equivalent Fluid Pressure 45 lb/cf
Fatigue Stress - Case II

Design Unit Stresses:
Class B-1 Concrete (Barrier) f'c = 4,000 psi
Class B-2 Concrete (End Bents & Superstructure, except Barrier) f'c = 4,000 psi
Reinforcing Steel (ASTM A615 Grade 60) fy = 60,000 psi

Joint Filler:
All joint filler shall be in accordance with Sec 1057 for preformed sponge rubber expansion and partition joint filler, except as noted.

Reinforcing Steel:
Minimum clearance to reinforcing steel shall be 1 1/2", unless otherwise shown.

Miscellaneous:
Protective coating for concrete bents and piers (Epoxy) shall be applied as shown on the bridge plans and in accordance with Sec 711.

Bars bonded in existing concrete not removed shall be cleanly stripped and embedded into new concrete where possible. If length is available, existing bars shall extend into new concrete at least 40 diameters for plain bars and 30 diameters for deformed bars, unless otherwise noted.

Roadway surfacing adjacent to bridge ends shall match new bridge approach slab surface. (Roadway item)

Outline of existing work is indicated by light dashed lines. Heavy lines indicate new work.


Contractor shall verify all dimensions in field before finalizing the shop drawings.

The area exposed by the removal of concrete and not covered with new concrete shall be coated with an approved qualified special mortar in accordance with Sec 704.

Rubblized concrete from the existing bridge deck that qualifies as clean fill may be placed on spill slopes at end bents above ordinary high water line (Roadway item).

For adjusted girder deflection due to the weight of the new deck and barriers, see Bridge Electronic Deliverables.

Traffic Handling:
Structure to be closed during construction. Traffic to be maintained on other routes during construction. See roadway plans for traffic control.

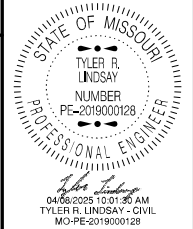

DATE PREPARED 4/8/2025	
ROUTE 50	STATE MO
DISTRICT BR	SHEET NO. 1
COUNTY JOHNSON	
JOB NO. JKR0102	
CONTRACT ID.	

PROJECT NO.	
BRIDGE NO. L09012	

DESCRIPTION	DATE





Notes:

Work this sheet with Sheet No. 3.

**** Full length of diaphragm.**

Cost of cutting existing anchor bolts and placing roofing felt will be considered completely covered by the contract unit price for Slab on Steel.

Cost of field drilling holes in existing wide flange beam webs will be considered completely covered by the contract unit price for Slab on Steel.


Required temporary support load of 20 kips at each bearing is a service load without a factor of safety. It includes the dead load (without the slab) and a construction load of 50 psf applied to the deck area. Live load is not included in the support load.

The contractor shall use one of the qualified resin anchor systems in accordance with Sec 1039.


Cost of furnishing and installing the resin anchor systems, complete in place, will be considered completely covered by the contract unit price for Slab on Steel.

The minimum embedment depth in concrete, $f'c = 4,000$ psi for the resin anchor system shall be that required to meet the minimum ultimate pullout strength in accordance with Sec 1039 but shall not be less than 5".


An epoxy coated #5 Grade 60 reinforcing shall be substituted for the 5/8"Ø threaded rod.

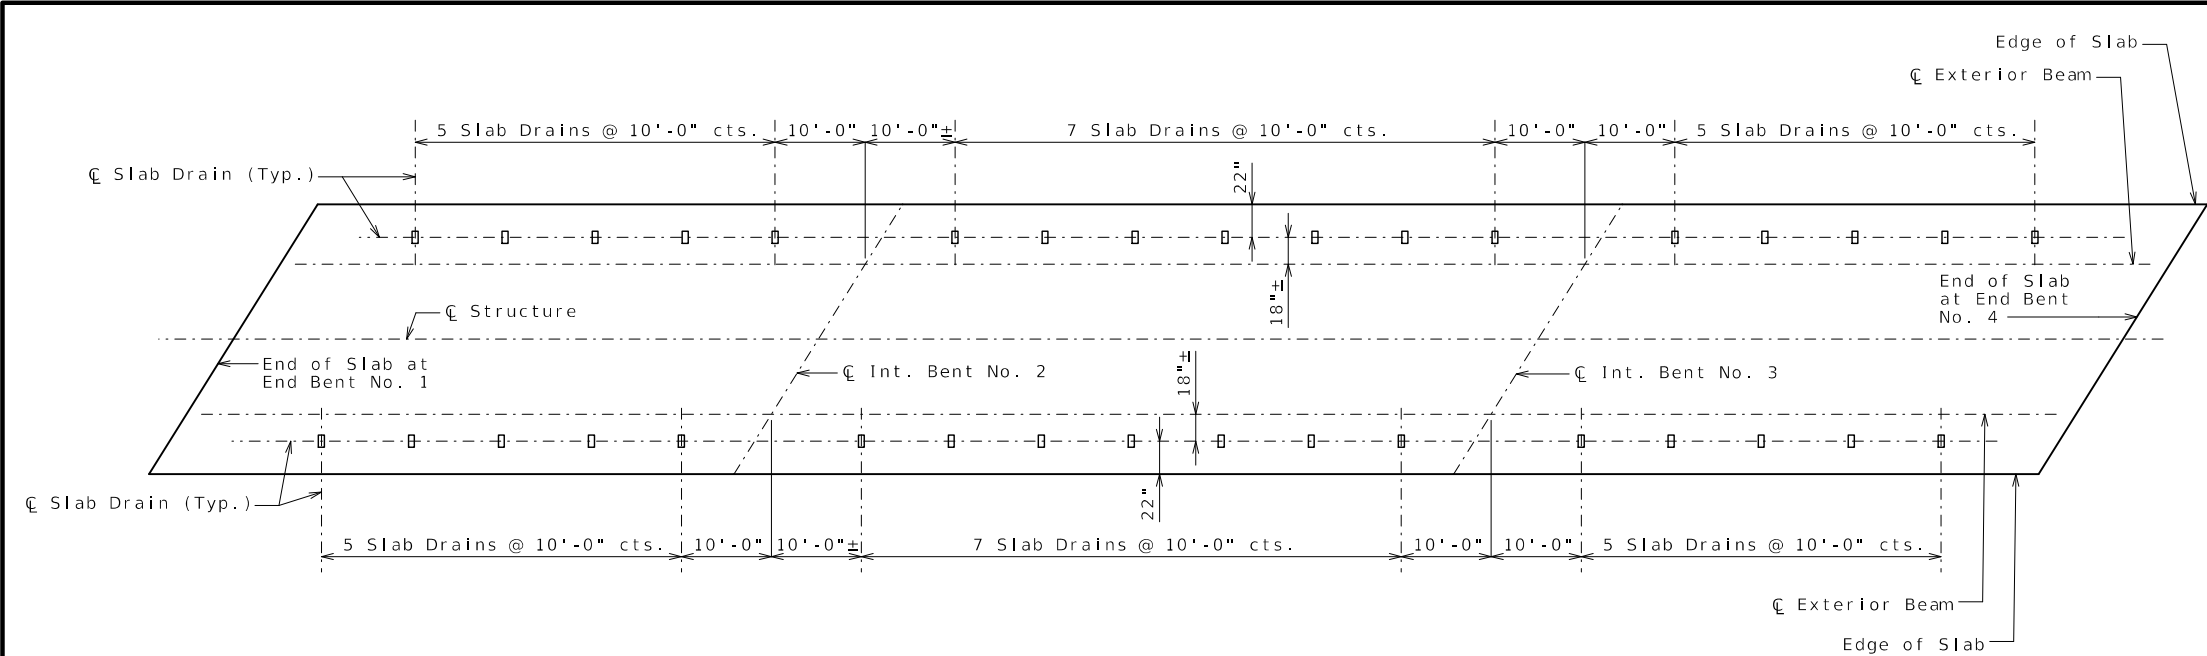


PLAN OF SLAB SHOWING SLAB DRAIN LOCATIONS

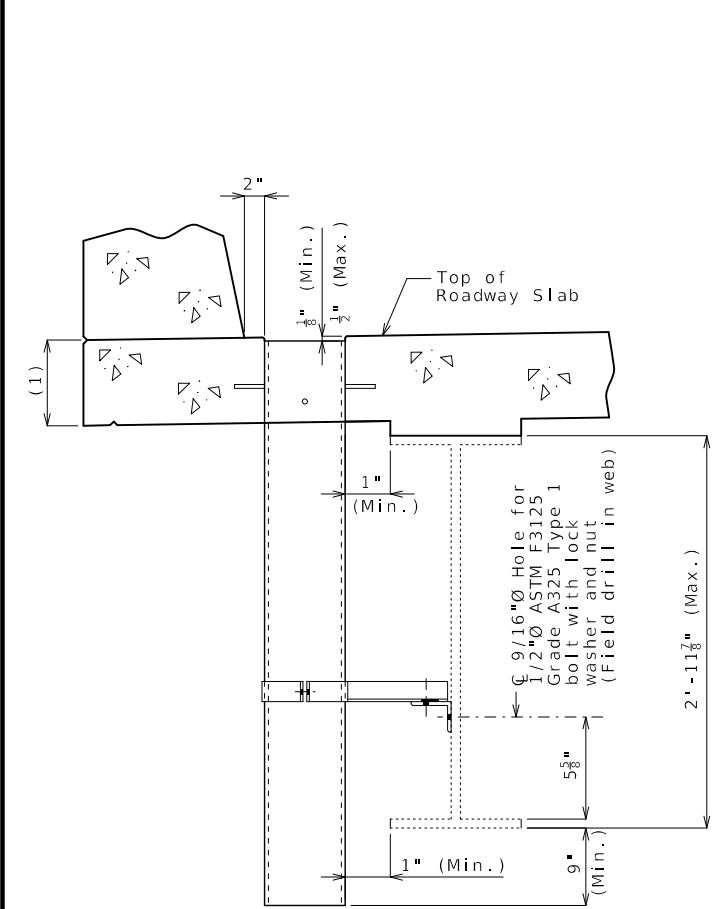

PART SECTION NEAR DRAIN

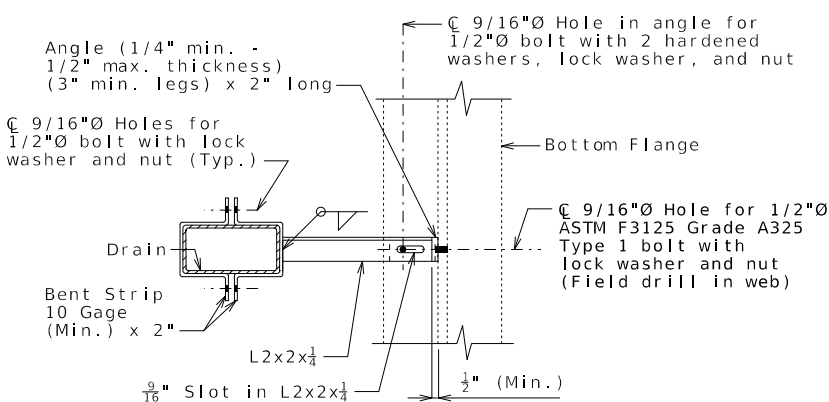


PART SECTION SHOWING BRACKET ASSEMBLY

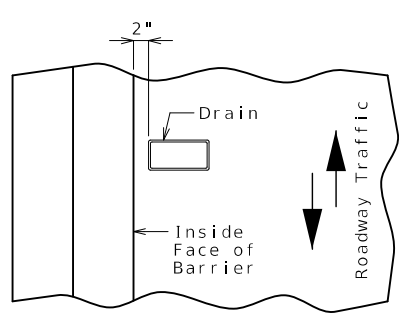


PART PLAN OF SLAB AT DRAIN


SLAB DRAINS

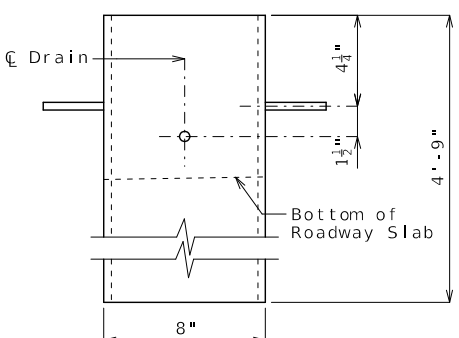

ELEVATION OF DRAIN

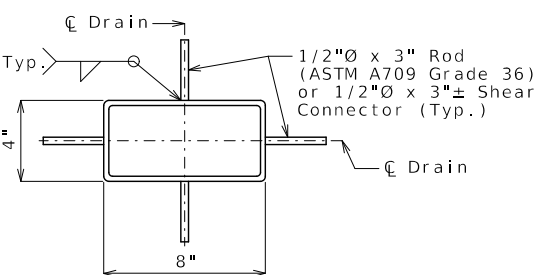

PLAN OF STEEL DRAIN OPTION

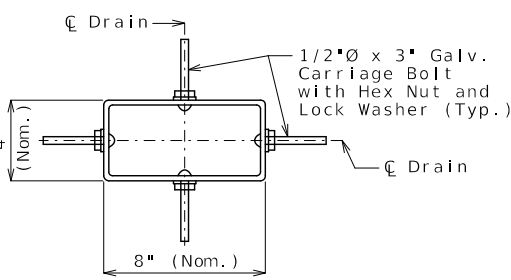

PLAN OF FRP DRAIN OPTION

General Notes:

Contractor shall have the option to construct either steel or FRP slab drains. All drains shall be of same type.

Slab drain bracket assembly shall be ASTM A709 Grade 36 steel.

Locate drains in slab by dimensions shown in Part Section Near Drain.

Reinforcing steel shall be shifted to clear drains.

The bracket assembly shall be galvanized in accordance with ASTM A123.

All bolts, hardened washers, lock washers and nuts shall be galvanized in accordance with AASHTO M 232 (ASTM A153), Class C.

All 1/2"Ø bolts shall be ASTM A307, except as shown.

Shop drawings will not be required for the slab drains and the bracket assembly.

The bolt hole for the bracket assembly attachment shall be shifted to the minimum extent necessary to field drill in the existing web.

(1) See front sheet for slab thickness.

Notes for Steel Drain:

Slab drains may be fabricated of either 1/4" welded sheets of ASTM A709 Grade 36 steel or from 1/4" structural steel tubing ASTM A500 or A501.

Outside dimensions of drains are 8" x 4".

The drains shall be galvanized in accordance with ASTM A123.

Notes for FRP Drain:

Drains shall be machine filament-wound thermosetting resin tubing meeting the requirements of ASTM D2996 with the following exceptions:

Shape of drains shall be rectangular with outside nominal dimensions of 8" x 4".

Minimum reinforced wall thickness shall be 1/4 inch.

The resin used shall be ultraviolet (UV) resistant and/or have UV inhibitors mixed throughout. Drains may have an exterior coating for additional UV resistance.

The color of the slab drain shall be gray (Federal Standard #26373). The color shall be uniform throughout the resin and any coating used.

The combination of materials used in the manufacture of the drains shall be tested for UV resistance in accordance with ASTM D4329 Cycle A. The representative material shall withstand at least 500 hours of testing with only minor discoloration and without any physical deterioration. The contractor shall furnish the results of the required ultraviolet testing prior to acceptance of the slab drains.

At the contractor's option, drains may be field cut. The method of cutting FRP slab drain shall be recommended by the manufacturer to ensure a smooth, chip free cut.

STATE OF MISSOURI
TYLER R. LINDSAY
NUMBER
PE-2019000128
PROFESSIONAL ENGINEER
04/08/2025 10:32:50 AM
TYLER R. LINDSAY - CIVIL
MO-PE-2019000128

DATE PREPARED
4/8/2025

ROUTE
50

DISTRICT
BR

COUNTY
JOHNSON

JOB NO.
JKR0102

CONTRACT ID.

PROJECT NO.










BRIDGE NO.
L09012

DESCRIPTION


DATE

MISSOURI HIGHWAYS AND TRANSPORTATION COMMISSION

105 WEST CAPITOL
JEFFERSON CITY, MO 65102
1-888-ASK-MODOT (1-888-275-6636)

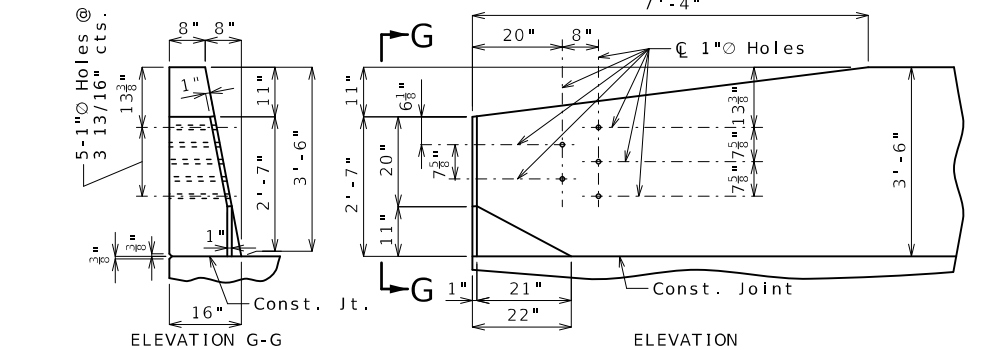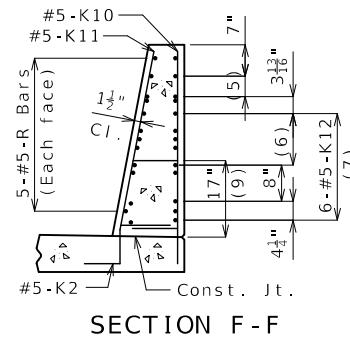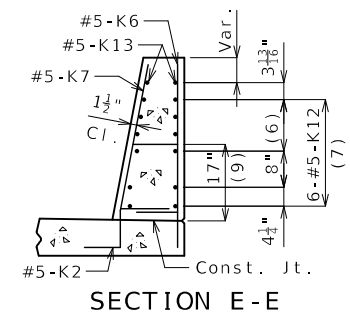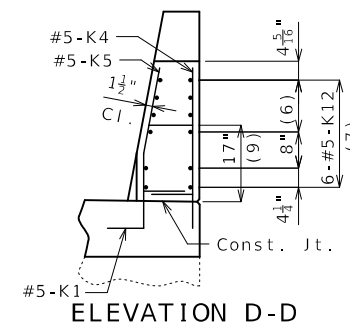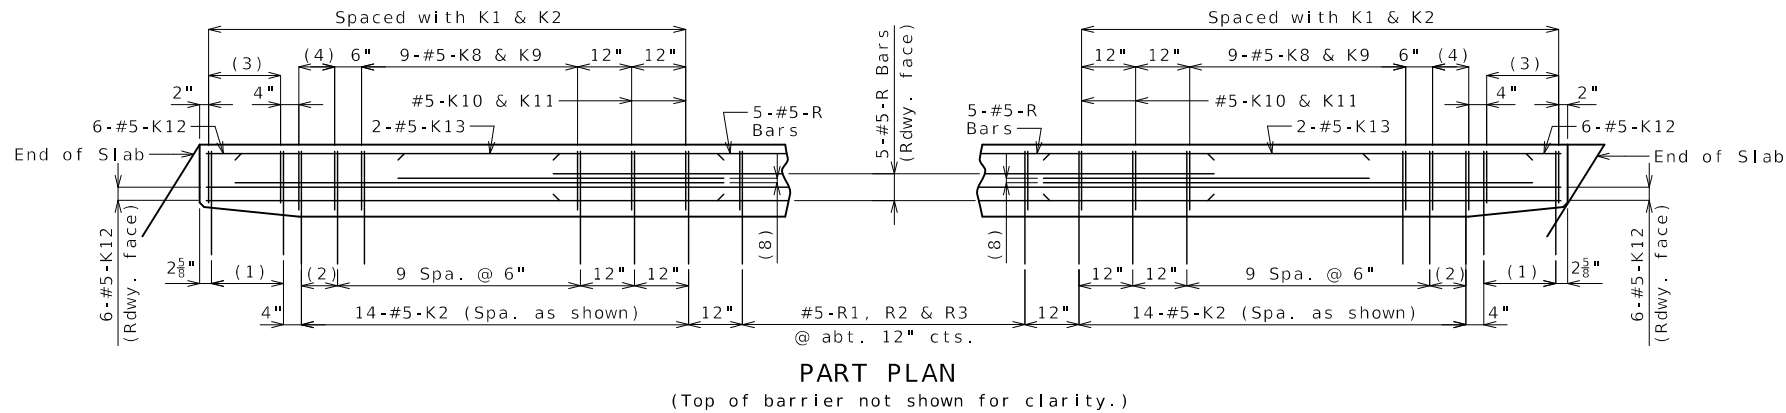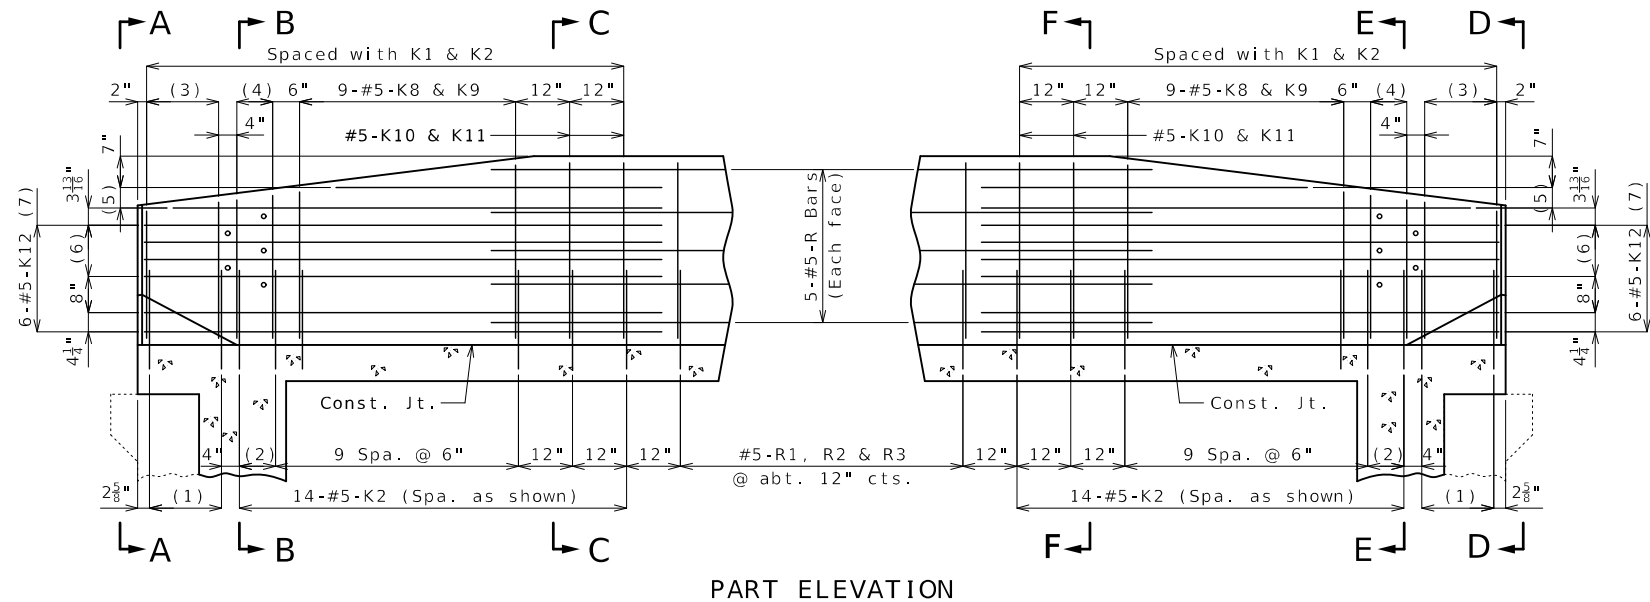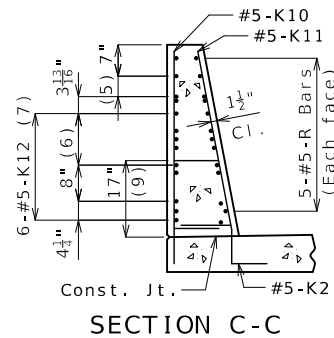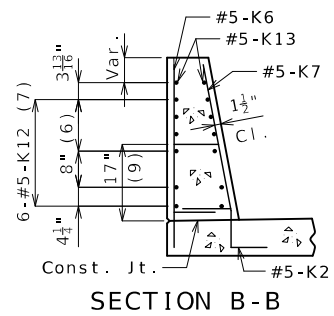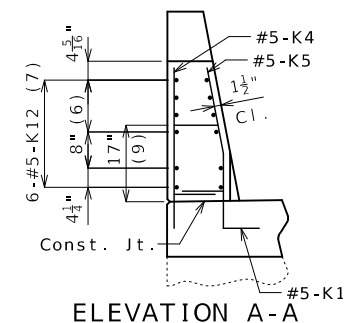

* Transition to zero at Type A curb for gutter lines to match.

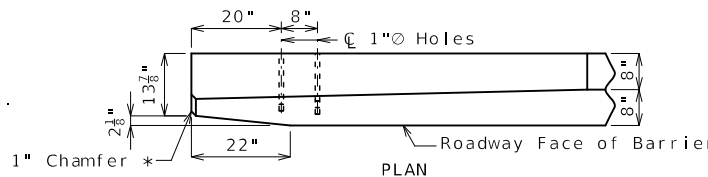

DETAILS OF GUARD RAIL ATTACHMENT

- (1) 5-#5-K1 @ 4" cts.
- (2) 2 spaces @ 4"
- (3) 5-#5-K4 & K5
- (4) 3-#5-K6 & K7
- (5) 2-#5-K13 @ 4 1/2" cts., each face
- (6) 3 spaces @ 3 1/2"
- (7) Spaced as shown, each face
- (8) 2-#5-K13 (Roadway face)
- (9) To top of bar


General Notes:

Concrete traffic barrier delineators shall be placed on top of the barrier as shown on Missouri Standard Plan 617.10 and in accordance with Sec 617. Delineators on bridges with two-lane, two-way traffic shall have retroreflective sheeting on both sides. Concrete traffic barrier delineators will be considered completely covered by the contract unit price for Type D Barrier.

Reinforcing Steel:

Minimum clearance to reinforcing steel shall be 1 1/2".

Use a minimum lap of 3'-1" between horizontal K bars and R bars.

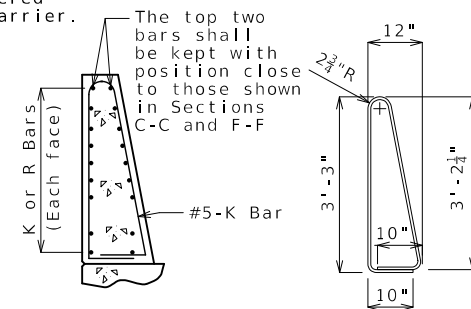

K10-K11 BAR PERMISSIBLE ALTERNATE SHAPE


(Other K bars not shown for clarity)

The K10-K11 bar combination may be furnished as one bar as shown, at the contractor's option.

All dimensions are out to out.

TYPE D BARRIER AT END BENTS

(Left barrier shown, right barrier similar)

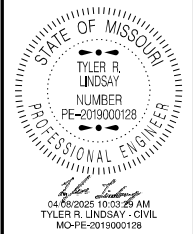

DATE PREPARED
4/8/2025

ROUTE 50 STATE MO

DISTRICT BR SHEET NO. 7

COUNTY JOHNSON

JOB NO. JKR0102

CONTRACT ID.

PROJECT NO.

BRIDGE NO. L09012

DESCRIPTION


DATE

MISSOURI HIGHWAYS AND TRANSPORTATION COMMISSION


105 WEST CAPITOL JEFFERSON CITY, MO 65102

1-888-ASK-MODOT (1-888-275-6636)


MoDOT

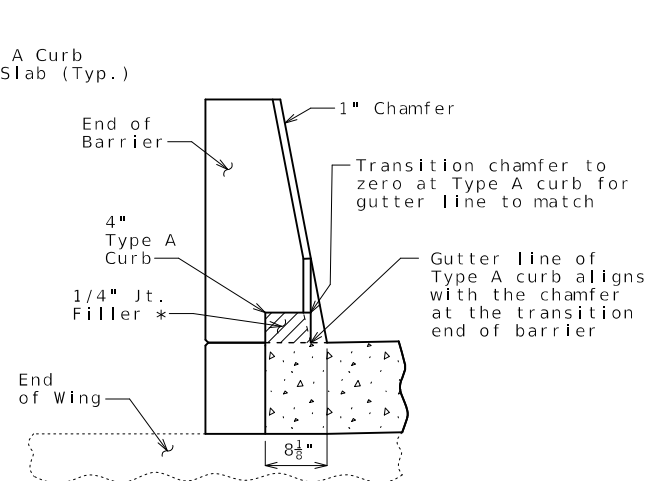

SECTION BETWEEN
CURB AND BARRIER

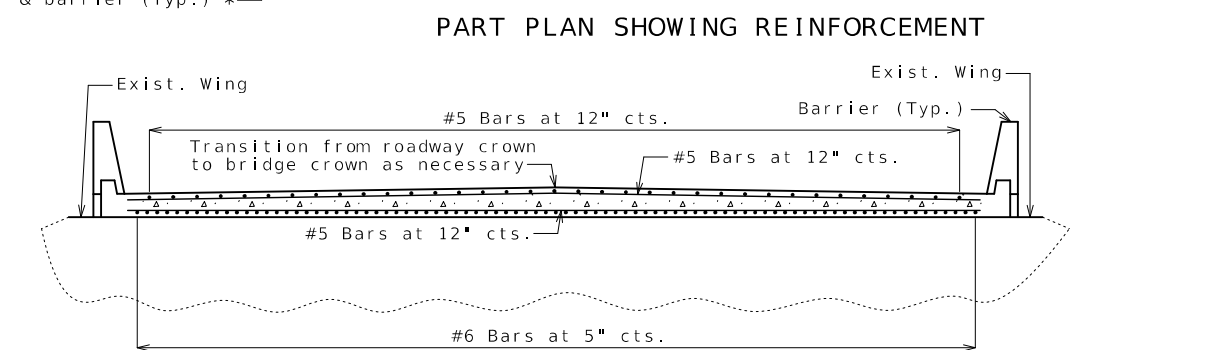


SECTION A-A

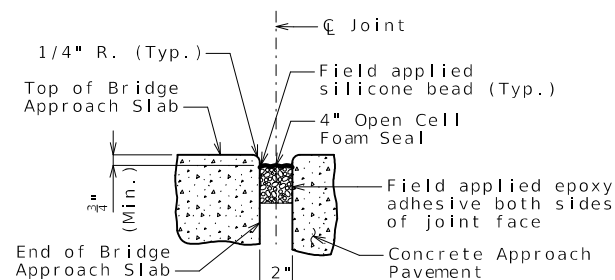


SECTION THRU JOINT AT END
OF BRIDGE APPROACH SLAB

Extend seal full width of approach slab.

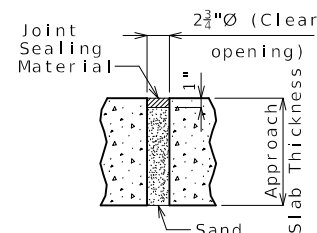


UNDERSEAL ACCESS HOLE DETAIL

(If required)

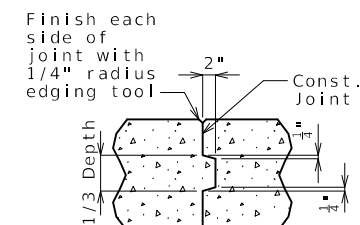


CONSTRUCTION JOINT DETAIL

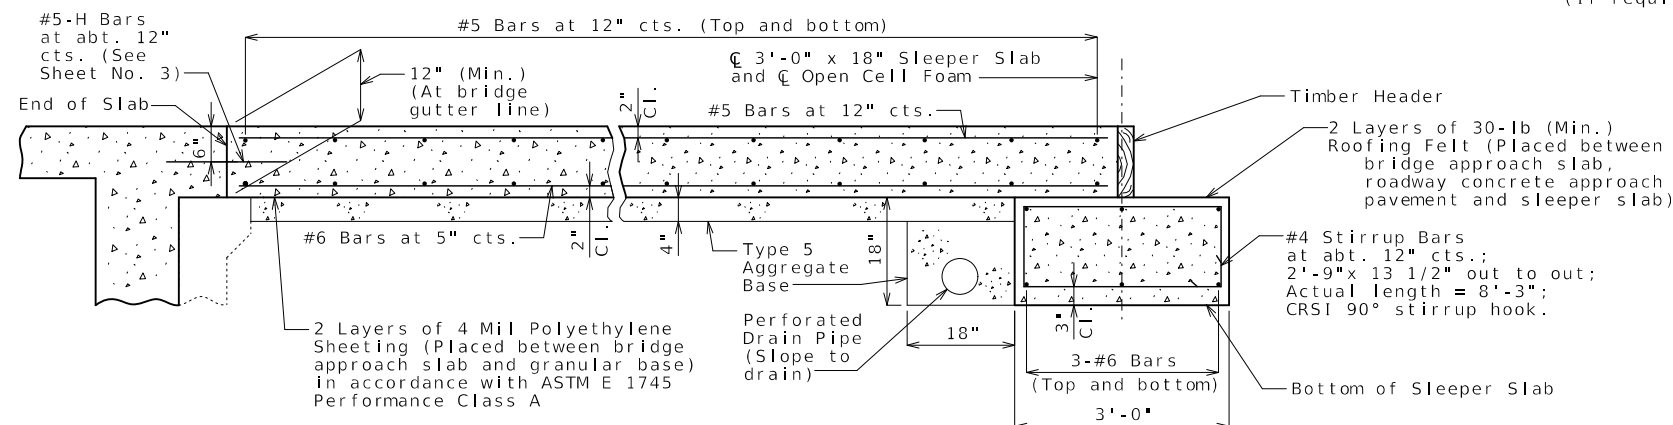

SECTION B-B

BRIDGE APPROACH SLAB (MAJOR)

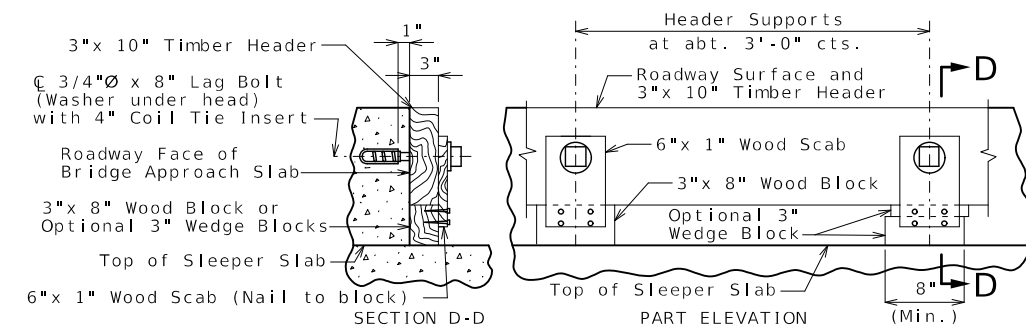

DETAILS OF TIMBER HEADER

Remove timber header when concrete pavement is placed.

General Notes:

All concrete for the bridge approach slab and sleeper slab shall be in accordance with Sec 503 ($f'c = 4,000$ psi).

The reinforcing steel in the bridge approach slab and the sleeper slab shall be epoxy coated Grade 60 with $f_y = 60,000$ psi.

Drain pipe may be either 6" diameter corrugated metallic-coated pipe underdrain, 4" diameter corrugated polyvinyl chloride (PVC) drain pipe, or 4" diameter corrugated polyethylene (PE) drain pipe.

Minimum clearance to reinforcing steel shall be 1 1/2",
unless otherwise shown.

The reinforcing steel in the bridge approach slab and the sleeper slab shall be continuous. The transverse reinforcing steel may be made continuous by providing a minimum lap splice of 29 inches for #5 bars and 44 inches for #6 bars, or by mechanical bar splice.

Mechanical bar splices shall be in accordance with Sec 710.

All joint filler shall be in accordance with Sec 1057 for preformed fiber expansion joint filler except as noted.

The contractor shall pour and satisfactorily finish the bridge slab before placing the bridge approach slab.

Longitudinal construction joints in approach slab and sleeper slab shall be aligned with longitudinal construction joints in bridge slab.


For concrete approach pavement details, see roadway plans.

See Missouri Standard Plan 609.00 for details of Type A curb.


Payment for furnishing all materials, labor and excavation necessary to construct the approach slab, including the timber header, sleeper slab, underdrain, Type 5 aggregate base, joint filler and all other appurtenances and incidental work as shown on this sheet, complete in place, will be considered completely covered by the contract unit price for Bridge Approach Slab (Major) per square yard.

* Seal joint between vertical face of Type A curb and end of barrier with sealant in accordance with Sec 717 for silicone joint sealant for saw cut and formed joints.

The open cell foam joint seal shall be installed according to the manufacturer's recommendations.

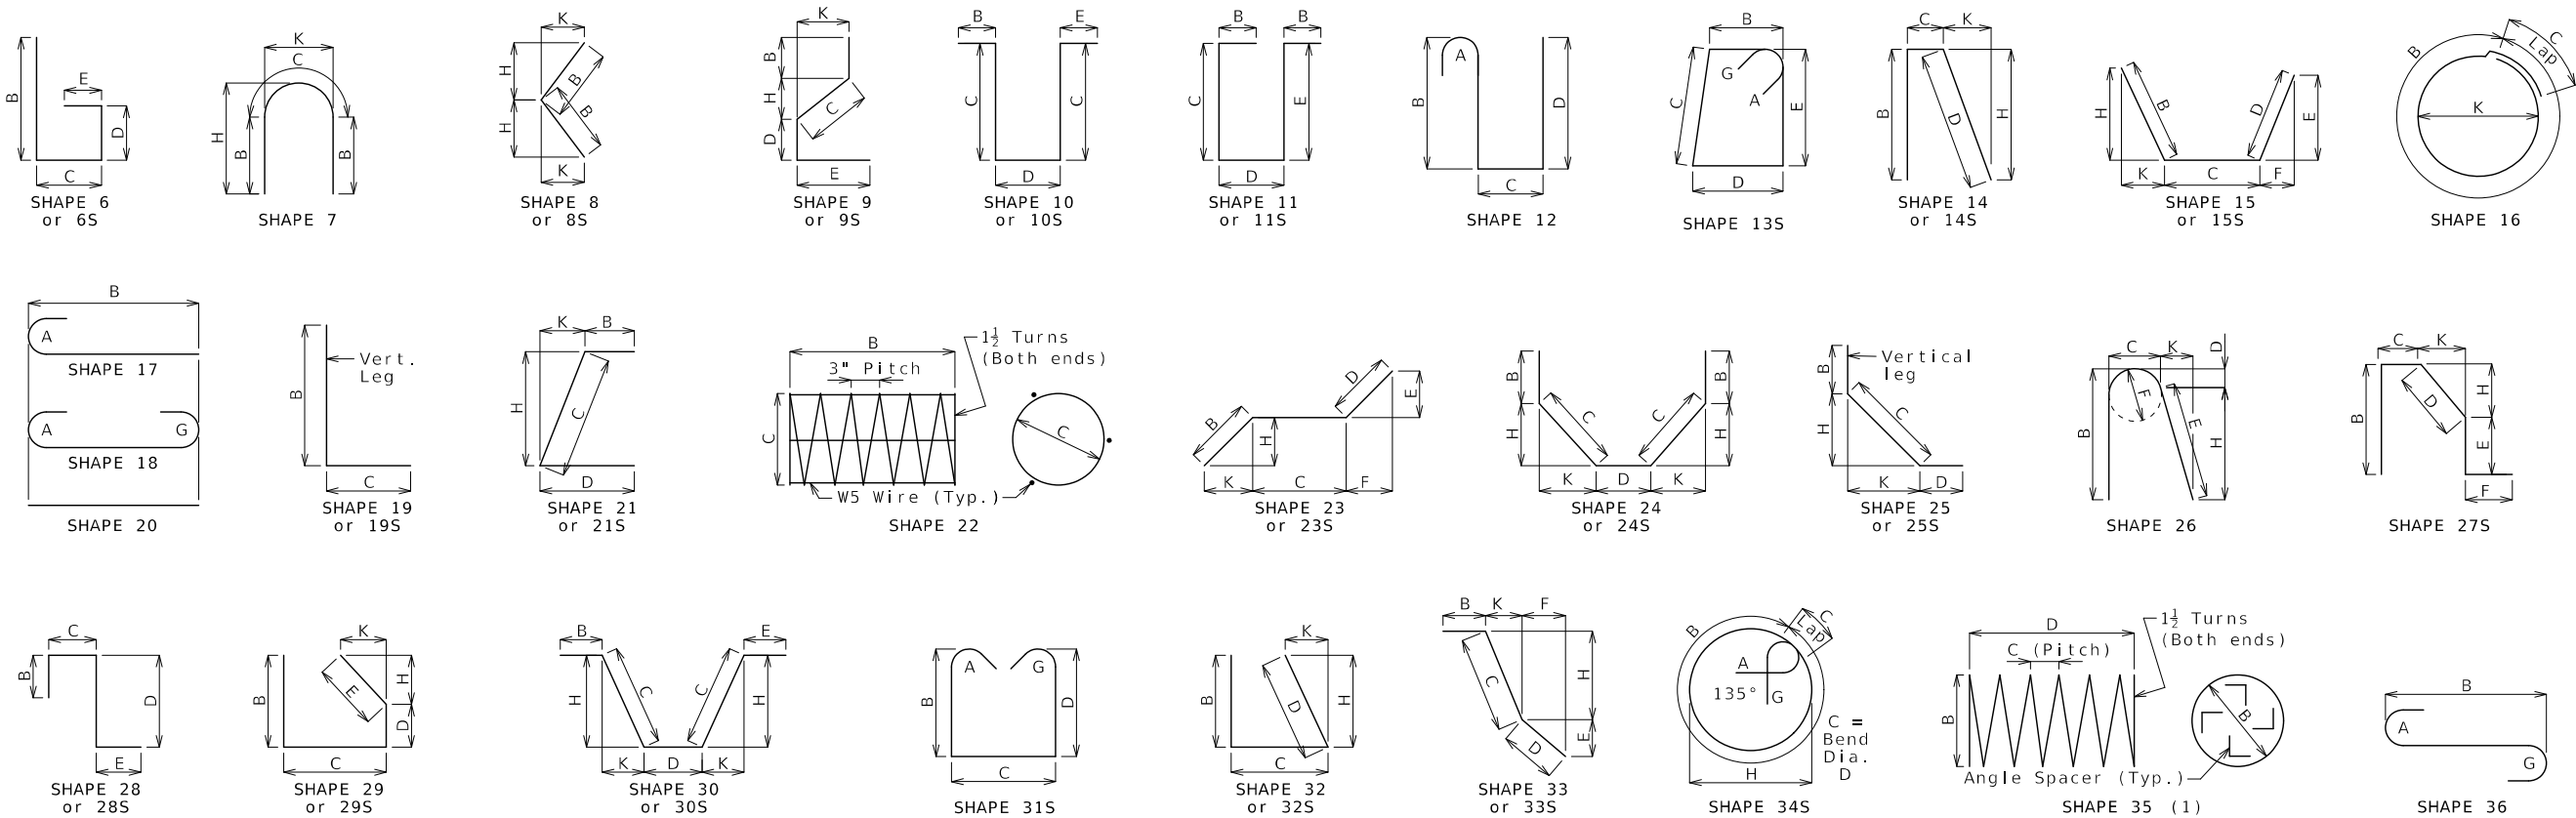

Finished Bend Dimensions D and Hook Dimensions						
Standard Pin Bend Shapes						
Size	Case	D	A or G		J	
			90°	180°	180°	
#4	1	3"	8"	6"	4"	
#5	1	3 ³ / ₄ "	10"	7"	5"	
#6	1	4 ¹ / ₂ "	12"	8 ¹ / ₄ "	6"	
#7	2	5 ¹ / ₄ "	14"	9 ³ / ₄ "	7"	
	3	7"	15"	11 ¹ / ₂ "	8 ³ / ₄ "	
#8	2	6"	16"	11"	8"	
	3	8"	17"	13 ¹ / ₄ "	10"	
#9	1	9 ¹ / ₂ "	19 ¹ / ₂ "	15 ¹ / ₂ "	11 ³ / ₄ "	
#10	1	10 ³ / ₄ "	22"	17 ¹ / ₂ "	13 ¹ / ₄ "	
#11	1	12"	24 ¹ / ₂ "	19 ¹ / ₂ "	14 ⁷ / ₈ "	
#14	1	18 ¹ / ₄ "	31 ¹ / ₄ "	27 ¹ / ₂ "	21 ⁵ / ₈ "	
#18	1	24"	41 ¹ / ₂ "	36 ¹ / ₄ "	28 ¹ / ₂ "	
Stirrup Pin Bend Shapes (S)						
Size	Case	D	A or G		H	J
			90°	135°	180°	135° 180°
#4	2	2"	4 ¹ / ₂ "	4 ¹ / ₂ "	5"	2 ⁷ / ₈ " 3"
	3	3"	5"	5 ¹ / ₄ "	6"	3" 4"
#5	2	2 ¹ / ₂ "	5 ³ / ₄ "	5 ³ / ₄ "	5 ³ / ₄ "	3 ³ / ₄ " 3 ³ / ₄ "
	3	3 ³ / ₄ "	6 ³ / ₄ "	6 ³ / ₄ "	7"	3 ³ / ₈ " 5"
#6	1	4 ¹ / ₂ "	12"	7 ³ / ₄ "	8 ¹ / ₄ "	4 ³ / ₈ " 6"
Applicable for all grades of steel. Case 1 applies to all reinforcement. Case 2 applies to all reinforcement except for galvanized bars. Case 3 applies to galvanized bars only.						

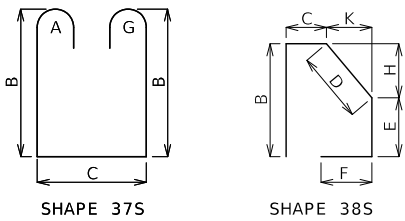

BENDING DIAGRAMS

All dimensions are out to out. (1) Shall be a deformed or plain spiral bar or wire.

Shapes ending with an S shall be bent in accordance with stirrup pin bend shapes.

Unless otherwise noted, finished bending diameter D is the same for all bends of a shape.

Four angle or channel spacers are required for each column spiral. Spacers are to be placed on inside of spirals. Length and weight of column spirals do not include splices or spacers.

Reinforcing Steel Totals (Pounds)							
Size	Substructure		Superstructure			Entire Bridge	
	Plain	Epoxy	Slab	Barrier	Slip Form	Plain	Epoxy
W5	0	0	0	0	0	0	0
4	0	0	1,308	0	0	0	1,308
5	0	0	18,231	10,911	501	0	29,643
6	0	0	40,871	0	0	0	40,871
7	0	0	0	0	0	0	0
8	0	0	0	0	0	0	0
9	0	0	0	0	0	0	0
10	0	0	0	0	0	0	0
11	0	0	0	0	0	0	0
14	0	0	0	0	0	0	0
18	0	0	0	0	0	0	0
By Type	0	0	60,410	10,911	501	0	71,822

All superstructure reinforcing steel shall be epoxy coated unless otherwise specified.

BENDING DIAGRAMS AND REINFORCING STEEL TOTALS

STATE OF MISSOURI
TYLER R. LINDSAY
NUMBER
PE-2019000128
PROFESSIONAL ENGINEER
04/08/2025 10:03:57 AM
TYLER R. LINDSAY - CIVIL
MO-PE-2019000128

DATE PREPARED
4/8/2025

ROUTE
50

DISTRICT
BR

STATE
MO

SHEET NO.
9

COUNTY
JOHNSON

JOB NO.
JKR0102

CONTRACT ID.

PROJECT NO.

BRIDGE NO.
L09012

DESCRIPTION

DATE

MISSOURI HIGHWAYS AND TRANSPORTATION COMMISSION

105 WEST CAPITOL
JEFFERSON CITY, MO 65102
1-888-ASK-MODOT (1-888-275-6636)

Bill of Reinforcing Steel																							
No. Req.	Size/ Mark	Location	Codes			Dimensions								Nom. Length	Actual Length	Weight							
						B		C		D		E					F		H		K		
			C	SH	V	ft	in.	ft	in.	ft	in.	ft	in.	ft	in.	ft	in.	ft	in.	ft	in.	lb	
		Superstructure																					
		End Bent 1 & 4																					
16	6 H100	DIAPHRAGM	E	20		36	8.00											36	8	36	8	881	
10	6 H101	DIAPHRAGM	E	20		38	2.00											38	2	38	2	573	
8	6 H102	DIAPHRAGM	E	20		40	7.00											40	7	40	7	488	
12	6 H103	DIAPHRAGM	E	10S				2	6.00	17.50								6	6	6	2	111	
12	6 H104	DIAPHRAGM	E	10S				2	0.00	17.50								5	6	5	2	93	
60	5 H105	DIAPHRAGM	E	20		2	6.00											2	6	2	6	156	
76	6 U100	DIAPHRAGM	E	19S		9	7.5	5	7.00									6	5	6	3	713	
104	5 U101	DIAPHRAGM	E	10S				4	0.00	23.00								9	11	9	8	1,049	
24	5 U102	DIAPHRAGM	E	10S				3	3.00	23.00								8	5	8	2	204	
24	4 U103	SHEAR KEY	E	21S		21	0.00	20	5.0	21.00				17	2.5	11	0.0	5	3	4	11	79	
		Slab																					
		SLAB	E	20		56	0.00											56		56		16,822	
100	6 S2	SLAB	E	20		38	0.00											38		38		5,708	
601	6 S3	SLAB	E	20		32	5.00											32	5	32	5	29,263	
62	6 S4	SLAB	E	20	2	2	0.00											2		2			
		Incr. = 12.000"				32	0.00											32		32		1,583	
56	6 S5	SLAB	E	20	2	2	11.00											2	11	2	11		
		Incr. = 12.875"				31	9.00											31	9	31	9	1,458	
418	4 S6	SLAB	E	10S		6	0.00	5	5.0	9	0.0	6	0.0					2	8	2	4	652	
16	4 S7	SLAB	E	20		54	0.00											54		54		577	
		Barrier																					
		Type D																					
20	5 K1	BARRIER	E	27S		21	5.0	9	2.5	5	2.5	15	7.5	12	0.0	5	2.5	5	4	5		104	
56	5 K2	BARRIER	E	27S		21	5.0	9	2.5	17	2.5	4	0.0	12	0.0	17	0.0	5	4	5		292	
20	5 K4	BARRIER	E	19S	4	2	4.25	10	0.0									3	2	3	1		
		Incr. = 0.500"				2	6.25	10	0.0									3	4	3	3	66	
20	5 K5	BARRIER	E	38S	4			18	5.0	9	5.0	8	2.5	18	0.0	4	0.0	3		2	11		
		Incr. = 0.500"						20	5.0	9	5.0	8	2.5	20	0.0	4	5.0	3	2	3	1	63	
12	5 K6	BARRIER	E	19S		2	6.75	10	0.0									3	5	3	3	41	
12	5 K7	BARRIER	E	21S				2	6.75	10	0.0			2	6	0.0	6	2.5	3	5	3	4	42
36	5 K8	BARRIER	E	19S	4	2	8.50	10	0.0									3	7	3	5		
		Incr. = 0.750"				3	2.50	10	0.0									4	1	3	11	138	
36	5 K9	BARRIER	E	21S	4			2	8.50	10	0.0			2	7	7.5	6	7.5	3	7	3	6	
		Incr. = 0.750"						3	2.50	10	0.0			3	1	7.5	7	7.5	4	1	4		141
8	5 K10	BARRIER	E	19S		3	3.00	10	0.0									4	1	4		33	
8	5 K11	BARRIER	E	21S				3	3.00	10	0.0			3	2	2.5	7	7.5	4	1	4	0	33
48	5 K12	BARRIER	E	20		9	7.00											9	7	9	7	480	
16	5 K13	BARRIER	E	20	8	5	10.00											5	10	5	10		
		Incr. = 36.000"				8	10.00											8	10	8	10	122	
404	5 R1	BARRIER	E	26		3	3.00	5	5.0	2	2.5	3	1	2.5	5	5.0	3	0	7.5	6	7.5		2,844
404	5 R2	BARRIER	E	19S		19	5.0	9	5.0									2	5	2	4	983	
404	5 R3	BARRIER	E	27S				9	5.0	15	2.5	4	0.0	12	0.0	15	0.0	3	5	3	3	1,369	
80	5 R4	BARRIER	E	20		11	9.00											11	9	11	9	980	
20	5 R5	BARRIER	E	20		47	10.00											47	10	47	10	998	
20	5 R6	BARRIER	E	20		55	9.00											55	9	55	9	1,163	
20	5 R7	BARRIER	E	20		48	10.00											48	10	48	10	1,019	
		Slip-Form																					
40	5 C1	SLIP FORM	E	20		12	0.00											12		12		501	

Nominal lengths are based on out to out dimensions shown in bending diagrams and are listed to the nearest inch for fabricator's use. Actual lengths are measured along centerline bar to the nearest inch. Weights are based on actual lengths.

For bending diagrams and steel reinforcing totals, see Sheet No. 9.

Detailed Mar. 2025
Checked Mar. 2025

All bars shall be Grade 60.

BILL OF REINFORCING STEEL

Note: This drawing is not to scale. Follow dimensions.


Sheet No. 10 of 10

[illegible]

Codes: C = Required coatings, where E = Epoxy Coated and G = Galvanized.

SH = Required shape, see bending diagrams.

V = Sets of varied bars and number of bars of each length. Bar dimensions vary in equal increments between dimensions shown on this line and the following line and the actual length dimension shown on this line and the following line vary by the specified increment.

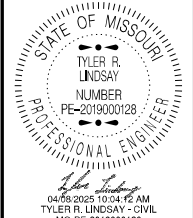

DATE PREPARED

4 / 8 / 202

ROUTE	ST
-------	----

50	M
----	---

DISTRICT SHEET
NO. 1

OR	1
----	---

COUNTY OF
JOHNSON

JOB NO.

IKB0102

CONTRACT ID

PROJECT NO. _____

BRIDGE NO.

L09012

[illegible]

MISSOURI HIGHWAYS AND TRANSPORTATION
COMMISSION

105 WEST CAPITOL
JEFFERSON CITY, MO 65102
1-888-ASK-A-MODOT (1-888-275-6636)



105 WEST CAPITOL
JEFFERSON CITY, MO 65102
1-888-ASK-MODOT (1-888-275-6636)