

JST0017B REMOVAL OF IMPROVEMENTS

PLAN SHEET

STA.

STA.

ROUTE

OFFSET

DESCRIPTION

QUANTITY

UNITS

REMARKS

GUARDRAIL (CONT.)

16-17

1176+40.33

1196+94.92

I-70

CL

HIGH-TENSION GUARD CABLE

2054.7

LF

17

1196+43.09

1215+89.88

I-70

CL

HIGH-TENSION GUARD CABLE

1946.9

LF

18

1216+52.29

1231+28.46

I-70

CL

HIGH-TENSION GUARD CABLE

1476.4

LF

18-19

1234+23.07

1260+72.88

I-70

CL

HIGH-TENSION GUARD CABLE

2650.1

LF

19-20

1260+72.88

1274+38.88

I-70

CL

HIGH-TENSION GUARD CABLE

1366.0

LF

20

1273+91.81

1285+22.25

I-70

CL

HIGH-TENSION GUARD CABLE

1130.8

LF

20

1284+72.55

1295+83.31

I-70

CL

HIGH-TENSION GUARD CABLE

1111.5

LF

20-21

1296+45.52

1306+93.93

I-70

CL

HIGH-TENSION GUARD CABLE

1048.8

LF

21

1306+93.93

1322+18.69

I-70

CL

HIGH-TENSION GUARD CABLE

1525.0

LF

22

1325+15.71

1338+43.56

I-70

CL

HIGH-TENSION GUARD CABLE

1328.4

LF

22-23

1338+43.56

1359+29.64

I-70

CL

HIGH-TENSION GUARD CABLE

2032.0

LF

23-24

1358+76.70

1379+14.63

I-70

CL

HIGH-TENSION GUARD CABLE

2038.0

LF

24

1378+62.58

1399+21.07

I-70

CL

HIGH-TENSION GUARD CABLE

2058.7

LF

24-25

1398+68.51

1407+88.48

I-70

CL

HIGH-TENSION GUARD CABLE

920.6

LF

MEDIAN BARRIER

62

1417+06

1425+90

I-70

CL

MEDIAN BARRIER

884

LF

TOTAL : 1 LUMP SUM

1

REMOVED

1

ADDED

MEDIAN GUARD CABLE

SHEET

STA.

STA.

ROUTE

OFFSET

MEIDAN GUARD CABLE
3-STRAND
(L.F.)

ANCHOR ASSEMBLY, GUARD CABLE
3-STRAND
(EA.)

REMARKS

6

784+89.38

786+89.38

I-70

CT / RT

200

1

TOTAL : 200 1

DRAINAGE PAVEMENT REPAIR

STA.

ROUTE

SIDE

PAVEMENT
AREA
SY

CONCRETE PAVEMENT
(10 IN. NON-REINFORCED)
SY

ASPHALTIC CONCRETE MIXTURE
PG 76-22 (SP125BSM MIX)
TONS

REMARKS

797+95

I-70

RT

68

68.0

7.4

Route 5 Ramp 2

897+85

I-70

RT

55

55.0

6.0

Route B Ramp 1

897+85

I-70

LT

44

44.0

4.8

Route B Ramp 2

912+85

I-70

LT

75

75.0

8.2

Route B Ramp 3

952+33

I-70

LT

51

51.0

5.6

Rest Area Ramp 3

1318+75

I-70

RT

139

139.0

15.2

Route 179 Ramp 2

TOTAL : 432.0 47.2

NOTES:
1) PAVEMENT EDGE DROP-OFF TREATMENT SHALL BE INCIDENTAL TO PAVING OPERATIONS.
2) PAYMENT FOR DRAINAGE PAVEMENT REPAIR SHALL INCLUDE DOWEL BARS TO TIE INTO EXISTING CONCRETE PAVEMENT, IF PRESENT.

1

ADDED

MOT TEMPORARY PAVEMENT

SHEET

STA.

STA.

ROUTE

BITUMINOUS PAVEMENT MIXTURE
ASPHALT PAVEMENT (SY)
PG 64-22 BASE (6.25") (Tons)
PG 64-22 BP-1 (1.75") (Tons)

AGGREGATE BASE
TYPE-5 (4") (SY)

COLDMILLING BITUMINOUS PAVEMENT
FOR REMOVAL OF SURFACING
(GREATER THAN 3" THICK (SY)

REMARKS

106-107

807+30

819+10

I-70 EB

1,302.6

453.4

125.8

1,302.6

106-107

807+30

819+10

I-70 WB

1,311.1

456.4

126.6

1,311.1

108

900+30

912+30

I-70 EB

1,309.1

455.7

126.4

1,309.1

108

900+50

912+10

I-70 WB

1,288.6

448.5

124.5

1,288.6

111

1049+20

1061+70

I-70 WB

1,376.3

479.1

132.9

1,376.3

111

1050+80

1061+10

I-70 EB

1,123.8

391.2

108.5

1,123.8

114

1226+70

1238+80

I-70 EB

1,347.2

468.9

130.1

1,347.2

114

1226+80

1238+70

I-70 WB

1,316.2

458.2

127.1

1,316.2

116

1317+60

1329+70

I-70 EB

1,388.5

483.3

134.1

1,388.5

116

1317+80

1329+50

I-70 WB

1,296.5

451.3

125.2

1,296.5

122

779+47.56

786+89.38

I-70 XO

2,214.0

770.7

213.9

2,214.0

TOTAL 13,059.9 4,546.0 1,261.2 2,214.0 13,059.9

ASPHALT ESTIMATING FACTORS:
1) PG 64-22 SP250C - 2.036 TONS/CY COMPACTED
2) PG 64-22 SP125C - 1.970 TONS/CY COMPACTED
3) PG 64-22 BASE - 1.970 TONS/CY COMPACTED
4) PG 64-22 BP-1 - 1.970 TONS/CY COMPACTED
5) PG 76-22 SP125B - 1.970 TONS/CY COMPACTED
6) PG 76-22 SP125BSM - 1.970 TONS/CY COMPACTED

1

ADDED

NOTES:
1) PAVEMENT EDGE DROP-OFF TREATMENT SHALL BE INCIDENTAL TO PAVING OPERATIONS.

1

REVISED

EARTHWORK

ROADWAY

TOTAL CUT (CY.)

EARTH CUT (CY.)

PAVEMENT REMOVAL (CY.)

FILL (CY.)

UNCLASSIFIED EXCAVATION (CY.)

EMBANKMENT IN PLACE (CY.)

COMPACTING EMBANKMENT (CY.)

COMPACTING IN CUT (STA)

REMARKS

I-70 SEG 01 STA. 784+89.38 TO STA. 875+00

57,184.5

26,416.7

30,767.8

9,891.5

26,417

0

9,892

90.0

180.0

I-70 SEG 02 STA. 875+00 TO STA.980+00

76,594.6

39,076.0

37,518.6

11,753.4

39,076

0

11754

100.0

200.0

I-70 SEG 03 STA. 980+00 TO STA.1085+00

82,424.1

45,904.8

36,519.3

11,415.7

45,905

0

11416

105.0

210.0

I-70 SEG 04 STA.1085+00 TO STA.1190+00

60,584.0

26,035.9

34,548.1

10,737.6

26,036

0

10738

98.0

196.0

I-70 SEG 05 STA.1190+00 TO STA.1265+00

47,452.1

22,956.5

24,495.6

4,586.5

22,957

0

4587

75.0

150.0

I-70 SEG 06 STA.1265+00 TO STA.1350+00

75,053.9

44,192.9

30,861.0

4,649.9

44,193

0

4650

85.0

170.0

I-70 SEG 07 STA.1350+00 TO STA.1420+90

52,204.0

27,358.2

24,845.8

5,631.5

27,359

0

5632

69.0

138.0

TOTAL : 231,943 0 58,669 622.0 1244.0

TOTAL CUT VOLUME AS SHOWN INCLUDES THE VOLUME FOR PAVEMENT REMOVAL. PAVEMENT REMOVAL IS INCLUDED IN REMOVAL OF IMPROVEMENTS.
ASSUMED 15" THICKNESS FOR EXISTING MAINLINE & RAMP PAVEMENTS FOR ROCK CUT AND 12" THICKNESS FOR EXISTING SHOULDER PAVEMENTS FOR ROCK CUT

1

REVISED

SEEDING AND MULCHING

BEGIN STA.

END STA.

ROUTE

LOCATION

SEEDING
COOL SEASON GRASSES
(ACRE)

TEMPORARY
SEEDING
(ACRE)

MULCHING
(ACRE)

784+00.00

811+00.00

I-70

LT / RT

1.6

1.6

3.2

811+00.00

838+00.00

I-70

LT / RT

1.7

1.7

3.4

838+00.00

865+00.00

I-70

LT / RT

1.4

1.4

2.8

865+00.00

892+00.00

I-70

LT / RT

1.1

1.1

2.2

892+00.00

919+00.00

I-70

LT / RT

2.0

2.0

4.0

919+00.00

946+00.00

I-70

LT / RT

1.9

1.9

3.8

946+00.00

973+00.00

I-70

LT / RT

1.3

1.3

2.6

973+00.00

1000+00.00

I-70

LT / RT

3.7

3.7

7.4

1000+00.00

1027+00.00

I-70

LT / RT

2.5

2.5

5.0

1027+00.00

1054+00.00

I-70

LT / RT

2.4

2.4

4.8

1054+00.00

1081+00.00

I-70

LT / RT

3.4

3.4

6.8

1081+00.00

1108+00.00

I-70

LT / RT

2.2

2.2

4.4

1108+00.00

1135+00.00

I-70

LT / RT

2.0

2.0

4.0

1135+00.00

1162+00.00

I-70

LT / RT

0.6

0.6

1.2

1162+00.00

1189+00.00

I-70

LT / RT

1.1

1.1

2.2

1189+00.00

1216+00.00

I-70

LT / RT

2.0

2.0

4.0

1216+00.00

1243+00.00

I-70

LT / RT

1.2

1.2

2.4

1243+00.00

1270+00.00

I-70

LT / RT

0.2

0.2

0.4

1270+00.00

1297+00.00

I-70

LT / RT

0.9

0.9

1.8

1297+00.00

1324+00.00

I-70

LT / RT

2.2

2.2

4.4

1324+00.00

1351+00.00

I-70

LT / RT

2.0

2.0

4.0

1351+00.00

1378+00.00

I-70

LT / RT

1.8

1.8

3.6

1378+00.00

1405+00.00

I-70

LT / RT

2.1

2.1

4.2

1405+00.00

1425+00.00

I-70

LT / RT

0.1

0.1

0.2

TOTAL : 41.4 41.4 82.8

STATE OF MISSOURI
RONNIE L. WILLIAMS
NUMBER
PE-2010000879
PROFESSIONAL ENGINEER

THIS SHEET HAS BEEN
SIGNED, SEALED, AND DATED
ELECTRONICALLY

DATE PREPARED
1/9/2026

ROUTE
I-70

STATE
MO

DISTRICT
CD

SHEET NO.
3

COUNTY
COOPER

JOB NO.
JST0017B

CONTRACT ID.
-

PROJECT NO.
-

BRIDGE NO.
-

DESCRIPTION
01/07/26
REMOVED & REVISED QTY

DATE
01/07/26

MISSOURI HIGHWAYS AND TRANSPORTATION
COMMISSION

MoDOT

105 WEST CAPITOL
JEFFERSON CITY, MO 65102
1-888-ASK-MODOT (1-888-275-6636)

BURNS
MCDONNELL

9400 Ward Parkway
Kansas City, MO 64114
(816) 333-9400
Certificate of Authority
No. : 000165

SUMMARY OF QUANTITIES
SHEET 09 OF 27

3:43:34 PM 1/9/2026

NOTE: CLEARING AND GRUBBING SHALL BE COMPLETED PRIOR TO THE INSTALLATION OF EROSION CONTROL DEVICES UNLESS OTHERWISE DIRECTED BY THE ENGINEER.

NOTE: CCTV CABLE SHOWN FOR INFORMATION ONLY AND SHALL BE INCLUDED IN THE ASSOCIATED LUMP SUM BID ITEM.



c:\bmcd_lib\pw_connect\trn\d0192954\003_QU_JST0017B_I1_Quantities_BMcD.dgn 9:41:31 AM 1/8/2026

MISSOURI HIGHWAYS AND TRANSPORTATION
COMMISSION

105 WEST CAPITOL
JEFFERSON CITY, MO 65102
1-888-ASK-MODOT (1-888-275-6636)

**BURNS
MCDONNELL**
9400 Ward Parkway
Kansas City, MO 64114
(816) 333-9400
Certificate of Authority
No. : 000165

CONCRETE APPROACH PAVEMENT				
SHEET	STA.	STA.	ROUTE	CONCRETE APPROACH PAVEMENT (SY)
62	1407+75.67	1407+93.95	I-70	178.8
62	1409+87.70	1410+05.98	I-70	178.8
TOTAL				357.6


ALTERNATE E - CONCRETE STRENGTHENED SHOULDER						
SHEET	STA.	STA.	ROUTE	TYPE 5 AGGREGATE BASE (14.5" THICK) (SY)	CONCRETE PAVEMENT (8.5 IN. NON-REINFORCED 12 FT JOINTS) (SY)	MODIFIED SUBGRADE (SY)
6	786+89.38	811+00.00	I-70	344.4	344.4	344.4
9	811+00.00	838+00.00	I-70	850.8	850.8	850.8
16	892+00.00	919+00.00	I-70	1,044.4	1,044.4	1,044.4
30	1027+00.00	1054+00.00	I-70	344.4	344.4	344.4
33	1054+00.00	1081+00.00	I-70	733.3	733.3	733.3
46	1216+00.00	1243+00.00	I-70	1,054.2	1,054.2	1,054.2
52	1297+00.00	1324+00.00	I-70	567.5	567.5	567.5
55	1324+00.00	1351+00.00	I-70	488.9	488.9	488.9
58	1351+00.00	1378+00.00	I-70	3,389.9	3,389.9	3,389.9
60	1378+00.00	1405+00.00	I-70	4,162.6	4,162.6	4,162.6
62	1405+00.00	1420+90.00	I-70	3,790.4	3,790.4	3,790.4
TOTAL				16,770.8	16,770.8	16,770.8

REVISED 1			3,709.4 16,689.4		ALTERNATE F - ASPHALT STRENGTHENED SHOULDER					
SHEET	STA.	STA.	ROUTE	10.5" ASPHALTIC CONCRETE MIXTURE (SY)	(2) TACK COAT (GAL.)	(1) PG 64-22 SP250C (6.5") (Tons)	(1) PG 70-22 SP125C (4") (Tons)	TYPE 5 AGGREGATE BASE (16" THICK) (SY)	MODIFIED SUBGRADE (SY)	
6	786+89.38	811+00.00	1-70	344.4	34	122.5	75.4	344.4	344.4	
9	811+00.00	838+00.00	1-70	850.8	85	302.6	186.2	850.8	850.8	
16	892+00.00	919+00.00	1-70	1,044.4	104	371.5	228.6	1,044.4	1,044.4	
30	1027+00.00	1054+00.00	1-70	344.4	34	122.5	75.4	344.4	344.4	
33	1054+00.00	1081+00.00	1-70	733.3	73	260.8	160.5	733.3	733.3	
46	1216+00.00	1243+00.00	1-70	1,054.2	105	375.0	230.8	1,054.2	1,054.2	
52	1297+00.00	1324+00.00	1-70	567.5	57	201.9	124.2	567.5	567.5	
55	1324+00.00	1351+00.00	1-70	488.9	49	173.9	107.0	488.9	488.9	
58	1351+00.00	1378+00.00	1-70	3,389.9	339	1,205.8	742.0	3,389.9	3,389.9	
60	1378+00.00	1405+00.00	1-70	4,162.6	416	1,480.6	911.1	4,162.6	4,162.6	
62	1405+00.00	1420+90.00	1-70	3,790.4	379	1,348.2	829.7	3,790.4	3,790.4	
TOTAL :				16,770.8	1,675	5,965.3	3,670.9	16,770.8	16,770.8	

MOT TEMPORARY PAVEMENT - ASPHALT WEDGE				
SEGMENT	ROUTE	BITUMINOUS PAVEMENT MIXTURE		
		ASPHALT PAVEMENT (CY)	PG 64-22 BP-1 (VAR.) (Tons)	
I-70 SEG 01	I-70 EB	743.2	1,476.7	1 REVISÉ 811.9 1,613.2 1,338.1 2,658.8
STA. 784+89 TO STA. 875+00	I-70 WB	1,228.8	2,441.6	
I-70 SEG 02	I-70 EB	1,236.0	2,455.9	1 REVISÉ 1,280.3 2,544.0
STA. 875+00 TO STA.980+00	I-70 WB	1,350.1	2,682.6	
I-70 SEG 03	I-70 EB	1,106.8	2,199.2	1,111.8 2,209.1 877.0 1,742.6
STA. 980+00 TO STA.1085+00	I-70 WB	852.6	1,694.1	
I-70 SEG 04	I-70 EB	1,593.3	3,165.9	1 REVISÉ
STA. 1085+00 TO STA.1190+00	I-70 WB	1,523.0	3,026.2	
I-70 SEG 05	I-70 EB	753.4	1,497.0	
STA. 1190+00 TO STA.1265+00	I-70 WB	632.3	1,256.4	
I-70 SEG 06	I-70 EB	356.0	707.4	550.6 1,094.0 605.0 1,202.1
STA.1265+00 TO STA.1350+00	I-70 WB	413.2	821.0	
I-70 SEG 07	I-70 EB	267.0	530.5	1 REVISÉ
STA.1350+00 TO STA.1420+90	I-70 WB	37.9	75.3	
TOTAL		12,093.6	24,029.8	12,731.7 25,297.7


 REVISED (TYP)

SUMMARY OF QUANTITIES
SHEET 17 OF 27

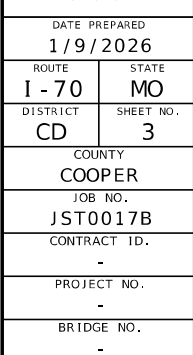

MISSOURI HIGHWAYS AND TRANSPORTATION
COMMISSION

105 WEST CAPITOL
JEFFERSON CITY, MO 65102
1-888-ASK-MODOT (1-888-275-6636)

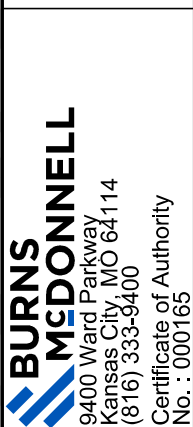

1

DISCLAIMER
THE PROFESSIONAL WHOSE SIGNATURE AND PERSONAL SEAL APPEAR HEREON ASSUMES RESPONSIBILITY ONLY FOR WHAT APPEARS ON THIS PAGE, AND DISCLAIMS (PURSUANT TO SECTION 327.411 RSMO) SPECIFICATION, ESTIMATES, REPORTS, OR OTHER DOCUMENTS OR INSTRUMENTS NOT SEALED BY THE UNDERSIGNED PROFESSIONAL RELATING TO OR INTENDED TO BE USED FOR ANY PART OR PARTS OF THE PROJECT TO WHICH THIS PAGE REFERS.

CONCRETE TRAFFIC BARRIER							
ROADWAY	STA	STA	TYPE C	TYPE D	TYPE D (MODIFIED)	TYPE D (MEDIAN)(MODIFIED)	REMARKS
			L.F.	L.F.	L.F.	L.F.	
I-70 MEDIAN	786+39	1374+00	58761				STANDARD MEDIAN BARRIER
I-70 EB	812+57	512+95		38			TYPE-D ALONG OUTSIDE SHOULDER AT BRIDGE COLUMNS
I-70 WB	813+50	813+88		38			TYPE-D ALONG OUTSIDE SHOULDER AT BRIDGE COLUMNS
I-70 EB	1232+61	1232+88		27			TYPE-D ALONG OUTSIDE SHOULDER AT BRIDGE COLUMNS
I-70 WB	1232+64	1232+91		27			TYPE-D ALONG OUTSIDE SHOULDER AT BRIDGE COLUMNS
I-70 WB	1323+34	1323+59		25			TYPE-D ALONG OUTSIDE SHOULDER AT BRIDGE COLUMNS
I-70 EB	1323+75	1324+02		27			TYPE-D ALONG OUTSIDE SHOULDER AT BRIDGE COLUMNS
I-70 MEDIAN	1374+00	1393+50			1950		TYPE-D BARRIER IN SUPERELEVATED SECTION, LOW SIDE
I-70 MEDIAN	1374+00	1393+50				1950	TYPE-D BARRIER IN SUPERELEVATED SECTION, HIGH SIDE
I-70 MEDIAN	1393+50	1420+90					STANDARD MEDIAN BARRIER
		SUBTOTAL	2740	182	1950	1950	
		PAY TOTAL	61501	182	1950	1950	

REVISED 1 1425+90

REVISED 1 3240 62001 62001

NOTE:
1. GLARE SCREEN SHALL BE RELOCATED FROM TEMPORARY TRAFFIC CONTROL BARRIER AND INSTALLED BETWEEN STATIONS 1374+00 TO 1363+50 (NO DIRECT PAY).

WILDLIFE CROSSINGS				
PL SHEET NO.	ROADWAY	STA*	WILDLIFE CROSSING (EACH)	REMARKS
3	I-70	835+00	5	
4	I-70	848+50	5	
4	I-70	856+00	5	
5	I-70	866+50	5	
5	I-70	885+00	5	
7	I-70	926+50	5	
9	I-70	981+00	5	
10	I-70	1025+00	5	
13	I-70	1085+00	5	
14	I-70	1112+50	5	
15	I-70	1153+00	5	
17	I-70	1192+00	5	
17	I-70	1213+00	5	
19	I-70	1252+50	5	
19	I-70	1260+00	5	
23	I-70	1351+25	5	
23	I-70	1368+00	5	
24	I-70	1395+00	5	
SUBTOTAL :			90	
PAY TOTAL :			90	

*STATION CALLOUT FOR CENTER LOCATION (FIVE INSTALLATIONS PER LOCATION)

SUMMARY OF QUANTITIES
SHEET 19 OF 27

STATE OF MISSOURI

CHRIS LINNEMAN

NUMBER
PE-2002016690

PROFESSIONAL ENGINEER

01/08/2026 8:23:45 AM
Chris Linneman - Civil
MO PE-2002016690

DATE PREPARED
1/7/2026

ROUTE
1-70

DISTRICT
CD

STATE
MO

SHEET NO.
3

COUNTY
COOPER

JOB NO.
JST0017B

CONTRACT ID.
-

PROJECT NO.
-

BRIDGE NO.
-

DESCRIPTION

REVISED QTY

DATE

01/07/26

.

.

.

.

.

.

MISSOURI HIGHWAYS AND TRANSPORTATION COMMISSION

MoDOT

105 WEST CAPITOL
JEFFERSON CITY, MO 65102
1-888-ASK-MODOT (1-888-275-6636)

EFK Moen

Civil Engineering Design

13523 Barrett Parkway Dr
Suite 250
St. Louis, MO 63021

Phone 314-394-3100
Fax 314-394-3199

Missouri Certificate of Authority: 001578

c:\bmcd_lib\pw_connect\trn\d0192954\003_QU_JST0017B_I1_Quantities_EFKMoen.dgn 3:15:21 PM 1/7/2026

JST0017B BID ITEMS			
BID ITEM NO.	BID ITEM DESCRIPTION	QUANTITY	UNITS
GRADING (LUMP SUM BID ITEM NO. 203.99.01)			
2013000	CLEARING AND GRUBBING	41.0	ACRE
2035000	UNCLASSIFIED EXCAVATION	231,943	C.Y.
2036000	COMPACTING EMBANKMENT	58,669	C.Y.
2037075	COMPACTING IN CUT	622	STA.
ALTERNATE PAVEMENT A (LUMP SUM BID ITEM NO. 505.99.01)			
2051010	MODIFIED SUBGRADE	766,000	S.Y.
3030610A	PLACING ROCK BASE 12" THICK	766,000	S.Y.
5021311	CONCRETE PAVEMENT (11 IN. NON-REINFORCED, 15 FT. JOINTS)	656,708.5	S.Y.
6262000A	PORTLAND CEMENT CONCRETE SHOULDER RUMBLE STRIP	2,474.2	STA.
5041000	CONCRETE APPROACH PAVEMENT	357.6	S.Y.
ALTERNATE PAVEMENT B (LUMP SUM BID ITEM NO. 403.99.01)			
2051010	MODIFIED SUBGRADE	766,000	S.Y.
3030610A	PLACING ROCK BASE 12" THICK	766,000	S.Y.
4039905	MISC. {14.5 IN. ASPHALTIC CONCRETE MIXTURE}	656,708.5	S.Y.
6261000A	BITUMINOUS SHOULDER RUMBLE STRIP	2,474.2	STA.
ALTERNATE PAVEMENT C - TYPE A2 SHOULDERS - CONCRETE (LUMP SUM BID ITEM NO. 505.99.01)			
5021340	TYPE A2 SHOULDER	109,282.2	S.Y.
ALTERNATE PAVEMENT D - TYPE A2 SHOULDERS - ASPHALT (LUMP SUM BID ITEM NO. 403.99.01)			
4010150	TYPE A2 SHOULDER	109,282.2	S.Y.
ALTERNATE PAVEMENT E - STRENGTHENED CONCRETE SHOULDERS (LUMP SUM BID ITEM NO. 505.99.01)			
2051010	MODIFIED SUBGRADE	16,771	S.Y.
3049905	MISC. {TYPE 5 AGGREGATE FOR BASE (14.5 IN. THICK)}	16,771	S.Y.
5029905	CONCRETE PAVEMENT (8 1/2 IN. NON-REINFORCED, 12 FT. JOINTS)	16,770.8	S.Y.
ALTERNATE PAVEMENT F - STRENGTHENED ASPHALT SHOULDERS (LUMP SUM BID ITEM NO. 403.99.01)			
2051010	MODIFIED SUBGRADE	16,771	S.Y.
3049905	MISC. {TYPE 5 AGGREGATE FOR BASE (16 IN. THICK)}	16,771	S.Y.
4039905	MISC. {10.5 IN. ASPHALTIC CONCRETE MIXTURE}	16,770.8	S.Y.
GUARDRAIL AND GUARD CABLE (LUMP SUM BID ITEM NO. 606.99.01)			
2051010	MODIFIED SUBGRADE	11	S.Y.
6061061	MGS GUARDRIAL, 8 FT. POSTS, 6 FT. - 3IN. SPACING	61,737	L.F.
6061069	MGS BRIDGE APPROACH TRANSITION SECTION (REGULAR/NO CURB)	4	EACH
6061070	MGS VERTICAL CONCRETE BARRIER TRANSITION	7	EACH
6061080	MGS END ANCHOR	46	EACH
6063014	TYPE A CRASHWORTHY END TERMINAL (MASH)	51	EACH
6063022	TYPE E CRASHWORTHY END TERMINAL (MASH)	1	EACH
6064100	MEDIAN GUARD CABLE 3 - STRAND	200	L.F.
6064110	ANCHOR ASSEMBLY, GUARD CABLE 3-STRAND	1	EACH
LIGHTING AND ITS (LUMP SUM BID ITEM NO. 901.99.01)			
9011064	LIGHTING POLE, 45 FT. OR 13.5 M. TYPE AT DESIGN 1	19	EACH
9011115	BRACKET ARM, 15 FT. OR 4.6 M	20	EACH
9011312	LUMINAIRE, LED-B	20	EACH
9012230	BASE MOUNTED CONTROL STATION 240 VOLT - 4 CIRCUIT	2	EACH
9013003	CONDUIT, 3 IN. RIGID, IN TRENCH	36	L.F.
9014003	CONDUIT, 3 IN. RIGID, PUSHED	1,302	L.F.
9015010	TRENCHING TYPE 1	10,881	L.F.
9016120	PULL BOX, CONCRETE, STANDARD	20	EACH
9017002	CABLE, 2 AWG 1 CONDUCTOR	70	L.F.
9017110	CABLE, 10 AWG 1 CONDUCTOR, POLE AND BRACKET	2,600	L.F.
9017202	WIRE, 2 AWG, BARE NEUTRAL	40	L.F.
9017407	CABLE-CONDUIT, 1 IN., 2 CONDUCTORS AND 1 BARE NEUTRAL, 8 AWG	12,980	L.F.
9018245	POLE FOUNDATION (45 FT. OR 13.5 M MOUNTING HEIGHT)	20	EACH
9018610	POWER SUPPLY ASSEMBLY, TYPE 2, 240/120 VOLT SERVICE, LIGHTING ONLY	2	EACH
9019902	MISC. {LIGHTING POLE, 40 FT. OR 12.2 M. TYPE AT DESIGN 3}	1	EACH
9103700	CCTV CAMERA ASSEMBLY, INSTALLED	1	EACH
9105201	CONDUIT, 3 IN., RIGID, IN TRENCH	175	L.F.
9107201	CONDUIT, 3 IN., RIGID, PUSHED	300	L.F.
9108202	CABLE, 2 AWG, 1 CONDUCTOR, POWER	530	L.F.
9108402	WIRE, 2 AWG, BARE NEUTRAL	270	L.F.
9108621	POWER SUPPLY ASSEMBLY, TYPE 2, 240/120 VOLT SERVICE, ITS	1	EACH
9108820	PULL BOX, CONCRETE, STANDARD	2	EACH
9109100	BASE, CONCRETE	1	C.Y.
9109901	MISC. {PERMANENT TRAFFIC COUNTING SYSTEM}	1	L.S.
9109902	MISC. {CCTV POLE, 60 FT. WITH LOWERING DEVICE, FURNISH AND INSTALL}	1	EACH
PERMANENT SIGNING (LUMP SUM BID ITEM NO. 903.99.01)			
9031005	SQUARE STEEL SIGN POST (4 IN.) BASE	10	EACH
9031010	CONCRETE FOOTINGS, EMBEDDED	61.1	C.Y.
9031020	CONCRETE FOOTINGS, BOLT DOWN	35.7	C.Y.
9031210	STRUCTURAL STEEL POSTS	29,420	LBS
9031220	PIPE POSTS	4,600	LBS
9031230	4 IN. SQUARE STEEL POST	199	L.F.
9031252	7 FT. CHANNEL POST DELINEATOR, DOUBLE STACKED WHITE	161	EACH
9031256	7 FT. CHANNEL POST DELINEATOR, WHITE	48	EACH
9031257A	7 FT. CHANNEL POST DELINEATOR, YELLOW	11	EACH

Diagram illustrating the evolution of a list of numbers through four stages of revision, with each revision marked by a triangle containing the number 1.

- Stage 1:** A list containing the number 1244.0. A triangle with 1 indicates a revision.
- Stage 2:** A list containing 765,247, 765,247, and 655,956.1. A triangle with 1 indicates a revision.
- Stage 3:** A list containing 765,247, 765,247, and 655,956.1. A triangle with 1 indicates a revision. A separate triangle with 1 indicates an addition.
- Stage 4:** A list containing 16,689, 16,689, 16,689.4, 16,689, and 16,689.4. Two triangles with 1 indicate revisions.
- Final Stage:** A list containing 0, 0, and 0. A triangle with 1 indicates a revision.

THIS SHEET HAS BEEN SIGNED, SEALED, AND DATED ELECTRONICALLY					
DATE PREPARED 1/8/2026					
ROUTE I - 70		STATE MO			
DISTRICT CD		SHEET NO. 3			
COUNTY COOPER					
JOB NO. JST0017B					
CONTRACT ID. -					
PROJECT NO. -					
BRIDGE NO. -					
		DESCRIPTION			
DATE	REVISED QTY				
01/07/26	1				
MISSOURI HIGHWAYS AND TRANSPORTATION COMMISSION		 105 WEST CAPITOL JEFFERSON CITY, MO 65102 1-888-ASK-MODOT (1-888-275-6636)			
 BURNS & McDONNELL 9400 Ward Parkway Kansas City, MO 64114 (816) 333-9400 Certificate of Authority No.: 000165					

JST0017B BID ITEMS			
BID ITEM NO.	BID ITEM DESCRIPTION	QUANTITY	UNITS
EROSION CONTROL (LUMP SUM BID ITEM NO. 806.99.01)			
6113010	FURNISHING TYPE 1 ROCK BLANKET	2,631	C.Y.
6113030	PLACING TYPE 1 ROCK BLANKET	2,631	C.Y.
6113020	FURNISHING TYPE 2 ROCK BLANKET	637	C.Y.
6113040	PLACING TYPE 2 ROCK BLANKET	637	C.Y.
6181020	ADDITIONAL MOBILIZATION FOR SEEDING	4	EACH
6240103A	PERMANENT EROSION CONTROL GEOTEXTILE	12,789	S.Y.
8025006	MULCHING	82.8	ACRE
8051000A	SEEDING - COOL SEASON GRASSES	41.4	ACRE
8061003	SEDIMENT TRAP EXCAVATION	277.5	C.Y.
8061004	SEDIMENT TRAP ROCK	277.5	C.Y.
8061005	ROCK DITCH CHECK	3,876	L.F.
8061006	ALTERNATE DITCH CHECK	7,280	L.F.
8061007A	CURB INLET CHECK	6	EACH
8061017	TEMPORARY SEEDING	41.4	ACRE
8061019	SILT FENCE	60,731	L.F.
8064140	TYPE 3B EROSION CONTROL BLANKET	42,571	S.Y.
MEDIAN BARRIER (LUMP SUM BID ITEM NO. 617.99.01)			
2051010	MODIFIED SUBGRADE	2,762	S.Y.
3030610A	PLACING ROCK BASE	2,773	S.Y.
5021305	CONCRETE PAVEMENT (5 3/4 IN. NON-REINFORCED, 15 FT. JOINTS)	1,165.6	S.Y.
5021312	CONCRETE PAVEMENT (12 IN. NON-REINFORCED 15 FT. JOINTS)	1,607	S.Y.
6173000	CONCRETE TRAFFIC BARRIER, TYPE C	61,501	L.F.
6173100	CONCRETE TRAFFIC BARRIER, TYPE D	182	L.F.
6173101	CONCRETE TRAFFIC BARRIER, TYPE D (MODIFIED)	1,950	L.F.
6179902	MISC. {WILDLIFE CROSSINGS}	90	EACH
6179903	MISC. {CONCRETE TRAFFIC BARRIER, TYPE D (MEDIAN)(MODIFIED)}	1,950	L.F.
6262000A	PORTLAND CEMENT CONCRETE SHOULDER RUMBLE STRIP	78	STA.
PERMANENT PAVEMENT MARKING (LUMP SUM BID ITEM NO. 602.99.01)			
6200054	PREFORMED THERMOPLASTIC PAVEMENT MARKING, LANE REDUCTION ARROW	4	EACH
6205902B	6 IN. WHITE CLASS 2 PAVEMENT MARKING PAINT (25-MIL, TYPE L BEADS)	222,184	L.F.
6205903B	6 IN. YELLOW CLASS 2 PAVEMENT MARKING PAINT (25-MIL, TYPE L BEADS)	148,775	L.F.
6205906B	12 IN. WHITE CLASS 2 PAVEMENT MARKING PAINT (25-MIL, TYPE L BEADS)	8,370	L.F.
6209902	MISC. {INLAID PAVEMENT MARKER INSTALLATION}	3,427	EACH
DRAINAGE (LUMP SUM BID ITEM NO. 726.99.01)			
2063000	CLASS 3 EXCAVATION	7,665	C.Y.
2063300	CLASS 4 EXCAVATION	184	C.Y.
2063500	CULVERT CLEANOUT	6	EACH
4030132	ASPHALTIC CONCRETE MIXTURE PG 76-22 (SP125BSM MIX)	47.2	TON
5021110	CONCRETE PAVEMENT (10 IN. NON-REINF)	432	S.Y.
6044011	PIPE COLLAR, TYPE A	14	EACH
6053030A	PIPE AGGREGATE PAVEMENT EDGE DRAIN	2,267	L.F.
6096020	FURNISHING TYPE 2 ROCK DITCH LINER	608	C.Y.
6096042	PLACING TYPE 2 ROCK DITCH LINER	608	C.Y.
6097000	ROCK LINING	204	C.Y.
6141022	GRATE AND BEARING PLATE (3 FT. X 3 FT.)	17	EACH
6141024	GRATE AND BEARING PLATE (5 FT. X 3 FT.)	1	EACH
6141121	CURVED GRATE AND BEARING PLATE (4 FT. X 2 FT)	11	EACH
6143014	MANHOLE FRAME AND COVER, TYPE 4	6	EACH
6214600A	FLOWABLE BACKFILL	240	C.Y.
6240103A	PERMANENT EROSION CONTROL GEOTEXTILE	3,052	S.Y.
7034001	CLASS B-1 CONCRETE	109.5	C.Y.
7061030	REINFORCING STEEL (CULVERTS)	10,660	LBS
7261018	18 IN. PIPE GROUP A	203	L.F.
7261024	24 IN. PIPE GROUP A	4,017	L.F.
7261030	30 IN. PIPE GROUP A	600	L.F.
7261036	36 IN. PIPE GROUP A	28	L.F.
7261042	42 IN. PIPE GROUP A	20	L.F.
7265024	JACKED 24 IN. CLASS III REINFORCED CONCRETE PIPE CULVERTS (GASKET TYPE)	343	L.F.
7265030	JACKED 30 IN. CLASS III REINFORCED CONCRETE PIPE CULVERTS (GASKET TYPE)	143	L.F.
7310048	PRECAST CONCRETE MANHOLE - 48 IN.	41	EACH
7311033	PRECAST CONCRETE DROP INLET 3 FT X 3 FT	73	L.F.
7311042	PRECAST CONCRETE DROP INLET 4 FT X 2 FT	88	L.F.
7311053	PRECAST CONCRETE DROP INLET 5 FT X 3 FT	4	L.F.
7319902	MISC. {MODIFY EXISTING MEDIAN DROP INLETS}	1	EACH
7320624A	24 IN. OR ALLOWED SUBSTITUTE GROUP A FLARED END SECTION	17	EACH
7320630A	30 IN. OR ALLOWED SUBSTITUTE GROUP A FLARED END SECTION	7	EACH
7320636A	36 IN. OR ALLOWED SUBSTITUTE GROUP A FLARED END SECTION	2	EACH
7321019A	42 IN. OR ALLOWED SUBSTITUTE SAFETY FLARED END SECTION	2	EACH

62,001

1

REVISED

DESCRIPTION	
DATE	REVISED QTY
01/07/26	

MISSOURI HIGHWAYS AND TRANSPORTATION COMMISSION

MoDOT

105 WEST CAPITOL JEFFERSON CITY, MO 65102 1-888-ASK-MODOT (1-888-275-6636)

BURNS MCDONNELL

9400 Ward Parkway Kansas City, MO 64114 (816) 333-9400

Certificate of Authority No. : 000165

SUMMARY OF QUANTITIES SHEET 26 OF 27

JST0017B BID ITEMS			
BID ITEM NO.	BID ITEM DESCRIPTION	QUANTITY	UNITS
TRAFFIC CONTROL (LUMP SUM BID ITEM NO. 616.99.01)			
2063000	CLASS 3 EXCAVATION	366	C.Y.
3040504	TYPE 5 AGGREGATE FOR BASE (4 IN. THICK)	2214	S.Y.
4011209	BITUMINOUS PAVEMENT MIXTURE PG64-22, (BP-1)	25,291	TON
4013000	BITUMINOUS PAVEMENT MIXTURE PG64-22 (BASE)	4,546	TON
6044011	PIPE COLLAR, TYPE A	10	EACH
6122019	IMPACT ATTENUATOR 70 MPH (SAND BARREL ARRAY)	2	EACH
6122020	REPLACEMENT SAND BARREL	10	EACH
6122030	IMPACT ATTENUATOR (RELOCATION)	6	EACH
6122040	WORK ZONE CRASH CUSHION (NARROW)	12	EACH
6122041	WORK ZONE CRASH CUSHION (NARROW)(RELOCATION)	24	EACH
6161005	CONSTRUCTION SIGNS	4,018	S.F.
6161010	RELOCATED SIGNS	4,746	S.F.
6161020	CHANNELIZER (DRUM-LIKE)	1,149	EACH
6161030	TYPE 3 MOVEABLE BARRICADE	50	EACH
6161040	FLASHING ARROW PANEL	1	EACH
6161095	RADAR SPEED ADVISORY SYSTEM	2	EACH
6161099	CHANGEABLE MESSAGE SIGN WITH COMMUNICATION INTERFACE, CONTRACTOR FURNISHED / RETAINED	5	EACH
6162002	TEMPORARY LONG-TERM RUMBLE STRIPS	16	EACH
6169901	MISC. {WORK ZONE INTELLIGENT TRANSPORTATION SYSTEM}	1	L.S.
6207001	PAVEMENT MARKING REMOVAL	311,607	L.F.
6208076	4 IN TEMPORARY PAVEMENT MARKING PAINT	844,023	L.F.
6214600A	FLOWABLE BACKFILL	252	C.Y.
6221003	COLDMILLING BITUMINOUS PAVEMENT FOR REMOVAL OF SURFACING (GREATER THAN 3 IN. THICK)	13,060	S.Y.
6229909	FILLING EXISTING BITUMINOUS RUMBLE STRIP	248.3	STA
7261018	18 IN. PIPE GROUP A	64	L.F.
7261024	24 IN. PIPE GROUP A	187	L.F.
7311022	PRECAST CONCRETE DROP INLET 2 FT X 2 FT	107	L.F.
GENERAL - ROADWAY (PAID FOR PER THE UNIT BID PRICE OF EACH BID ITEM)			
2010000	MOWING	248.4	ACRE
2022010	REMOVAL OF IMPROVEMENTS	1	L.S.
2069907	EXCAVATING AND DISPOSING OF UNSUITABLE MATERIAL (SMALL AREA)	1	C.Y.
2069907	EXCAVATING AND DISPOSING OF UNSUITABLE MATERIAL (LARGE AREA)	1	C.Y.
2143000	PLACING ROCK FILL	1	C.Y.
4011209	BITUMINOUS PAVEMENT MIXTURE PG64-22, (BP-1)	24,944	TON
5041000	CONCRETE APPROACH PAVEMENT	357.6	S.Y.
6181000	MOBILIZATION	1	L.S.
6181015	RAILROAD PLAN SUBMITTAL	1	L.S.
6274000	CONTRACTOR FURNISHED SURVEYING AND STAKING	1	L.S.
8061016	SEDIMENT REMOVAL	715	C.Y.
6173600D	TEMPORARY TRAFFIC BARRIER, CONTRACTOR FURNISHED / RETAINED	193,521	L.F.
6173700B	TEMPORARY TRAFFIC BARRIER ANCHORED, CONTRACTOR FURNISHED / RETAINED	1,179	L.F.
6174000A	TEMPORARY TRAFFIC BARRIER HEIGHT TRANSITION, CONTRACTOR FURNISHED / RETAINED	2	EACH
6175010A	RELOCATING TEMPORARY TRAFFIC BARRIER	138,520	L.F.
6175011B	RELOCATING TEMPORARY TRAFFIC BARRIER ANCHORED	22,653	L.F.
6178003A	TRAFFIC BARRIER DELINEATOR, YELLOW/YELLOW	3,196	EACH
6178004	TRAFFIC BARRIER DELINEATOR, WHITE/WHITE	1,598	EACH
GENERAL - BRIDGE A01532 (PAID FOR PER THE UNIT BID PRICE OF EACH BID ITEM)			
7011105	DRILLED SHAFTS (3 FT. 6 IN. DIA)	186	L.F.
7011204	ROCK SOCKETS (3 FT. 0 IN. DIA)	32	L.F.
RETAINING WALL (LUMP SUM BID ITEM NO. 703.99.01)			
6091042	CONCRETE GUTTER TYPE B	310	L.F.
6096020	FURNISHING TYPE 2 ROCK DITCH LINER	2	C.Y.
6096042	PLACING TYPE 2 ROCK DITCH LINER	2	C.Y.
6240103A	PERMANENT EROSION CONTROL GEOTEXTILE	6	S.Y.
7039904	MISC. {GRAVITY BLOCK RETAINING WALL}	1,448	S.F.
BRIDGE A00082 (LUMP SUM BID ITEM NO. 703.99.01)			
7049902	MISC. {PARTIAL REMOVAL OF EXISTING SLAB DRAIN}	4	EA.
BRIDGE A01532 (LUMP SUM BID ITEM NO. 703.99.01)			
2061000	CLASS 1 EXCAVATION	40	C.Y.
2163000	PARTIAL REMOVAL OF EXISTING BRIDGE DECK	768	S.F.
2164000	CURB REMOVAL	337	S.F.
5031010A	BRIDGE APPROACH SLAB (MAJOR)	479	S.Y.
6239905	MISC. {EPOXY URETHANE POLYMER WEARING SURFACE WITH HEALER/SEALER}	2,321	S.Y.
7011300	VIDEO CAMERA INSPECTION	4	EACH
7011400	FOUNDATION INSPECTION HOLES	72	L.F.
7011600	SONIC LOGGING TESTING	4	EACH
7021212	GALVANIZED STRUCTURAL STEEL PILES (12 IN.)	424	L.F.
7027000	PILE POINT REINFORCEMENT	8	EACH
7032003	CLASS B CONCRETE (SUBSTRUCTURE)	117.4	C.Y.
7034212	SLAB ON STEEL	572	S.Y.
7034219A	TYPE D BARRIER	634	L.F.
7034413	TYPE C BARRIER TRANSITION	45	L.F.
7061060	REINFORCING STEEL (BRIDGES)	36,850	LBS
7121111	FABRICATED STRUCTURAL LOW ALLOY STEEL (I-BEAM) A709, GRADE 50	98,660	LBS
7123610	SLAB DRAIN	18	EACH
7123620	DRAINAGE SYSTEM (ON STRUCTURE)	1	L.S.
7125397	FINISH FIELD COAT (SYSTEM L)	5,000	S.F.
7151001	VERTICAL DRAINS AT END BENTS	2	EACH
7161003	LAMINATED NEOPRENE BEARING PAD (TAPERED)	8	EACH
7162000	LAMINATED NEOPRENE BEARING PAD ASSEMBLY	8	EACH
NON CONTRACTURAL BID ITEMS			
1099904	MISC. {LOGO SIGNS - ST-STRUCTURAL}	2,538	S.F.
1099911	MISC. {LOGO SIGNS - STRUCTURAL STEEL POSTS}	9,720	LBS
1099907	MISC. {LOGO SIGNS - CONCRETE FOOTINGS, EMBEDDED}}	14.2	C.Y.

1

ADDED ITEM

1,475.1

5,316.7

1

REVISED

1

ADDED ITEM

3,995

4,636

1

REVISED

1,054,918

1

REVISED

1

ADDED

7311032

PRECAST CONCRETE DROP INLET 3 FT X 2 FT

107

L.F.

1

REVISED

1

ADDED

1

ADDED ITEM FOR ASPHALT WEDGING

1

ADDED

113,452

35,442

1

REVISED

203,195

1

ADDED

0

0

1

REVISED

STATE OF MISSOURI
RONNIE L. WILLIAMS
NUMBER
PE-2010000879
PROFESSIONAL ENGINEER

THIS SHEET HAS BEEN
SIGNED, SEALED, AND DATED
ELECTRONICALLY

DATE PREPARED
1/8/2026

ROUTE
1 - 70

STATE
MO

DISTRICT
CD

SHEET NO.
3

COUNTY
COOPER

JOB NO.
JST0017B

CONTRACT ID.
-

PROJECT NO.
-

BRIDGE NO.
-

DESCRIPTION

REVISED QTY

DATE

01/07/26

MISSOURI HIGHWAYS AND TRANSPORTATION
COMMISSION

MoDOT


105 WEST CAPITOL
JEFFERSON CITY, MO 65102
1-888-ASK-MODOT (1-888-275-6636)

BURNS
MCDONNELL

9400 Ward Parkway
Kansas City, MO 64114
(816) 333-9400
Certificate of Authority
No. : 000165

SUMMARY OF QUANTITIES
SHEET 27 OF 27

c:\bmcd_lib\pw_connect\trn\d0192954\003_QU_JST0017B_I1_Quantities_BMcD.dgn 2:41:37 PM 1/8/2026

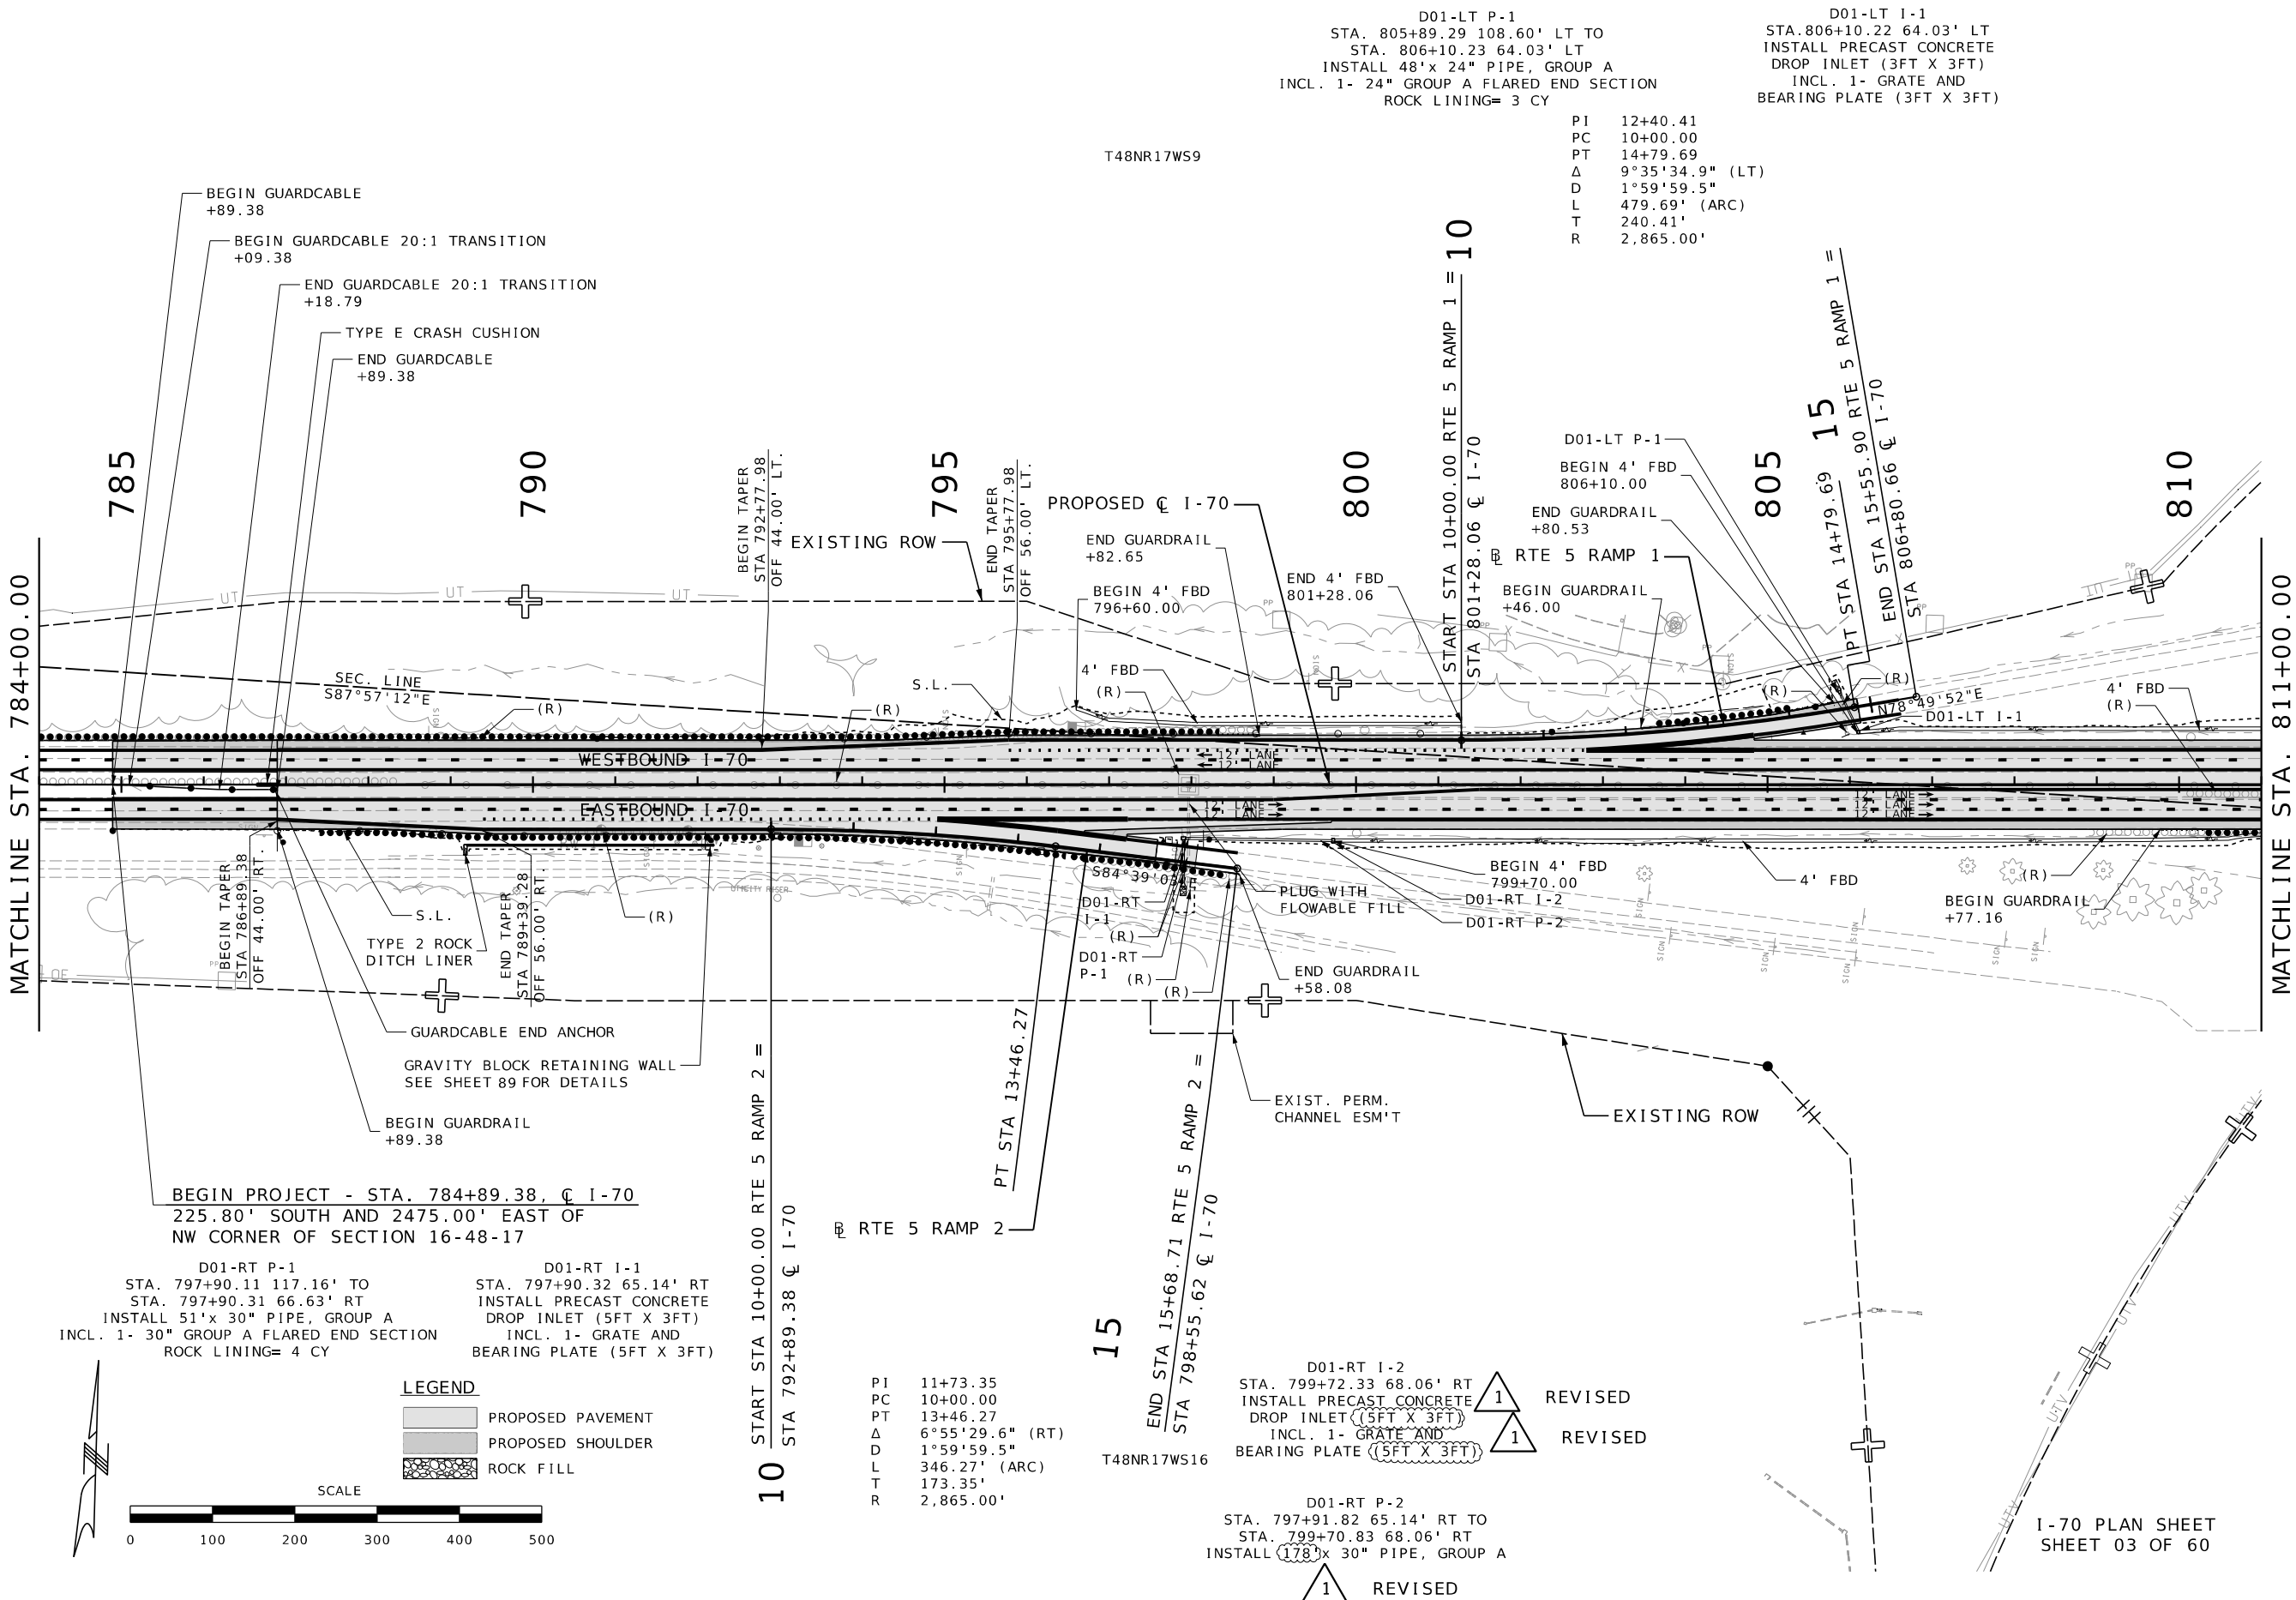

D01-LT P-1
STA. 805+89.29 108.60' LT TO
STA. 806+10.23 64.03' LT
INSTALL 48'x 24" PIPE, GROUP A
INCL. 1- 24" GROUP A FLARED END SECTION
ROCK LINING= 3 CY

D01-LT I-1
STA. 806+10.22 64.03' LT
INSTALL PRECAST CONCRETE
DROP INLET (3FT X 3FT)
INCL. 1- GRATE AND
BEARING PLATE (3FT X 3FT)

P1 12+40.41
PC 10+00.00
PT 14+79.69
Δ 9°35'34.9" (LT)
D 1°59'59.5"
L 479.69' (ARC)
T 240.41'
R 2,865.00'

D01-RT P-1
STA. 797+90.11 117.16' TO
STA. 797+90.31 66.63' RT
INSTALL 51'x 30" PIPE, GROUP A
INCL. 1- 30" GROUP A FLARED END SECTION
ROCK LINING= 4 CY



D01-RT I-1
STA. 797+90.32 65.14' RT
INSTALL PRECAST CONCRETE
DROP INLET (5FT X 3FT)
INCL. 1- GRATE AND
BEARING PLATE (5FT X 3FT)

P1 11+73.35
PC 10+00.00
PT 13+46.27
Δ 6°55'29.6" (RT)
D 1°59'59.5"
L 346.27' (ARC)
T 173.35'
R 2,865.00'

D01-RT I-2
STA. 799+72.33 68.06' RT
INSTALL PRECAST CONCRETE
DROP INLET (5FT X 3FT)
INCL. 1- GRATE AND
BEARING PLATE (5FT X 3FT)

D01-RT P-2
STA. 797+91.82 65.14' RT TO
STA. 799+70.83 68.06' RT
INSTALL 51'x 30" PIPE, GROUP A

1 REVISED
1 REVISED

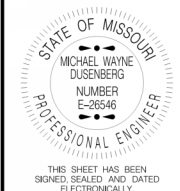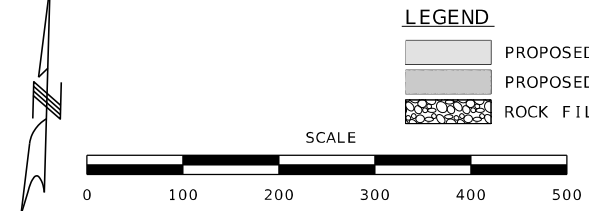

DATE PREPARED 1/7/2026	
ROUTE I - 70	STATE MO
DISTRICT CD	SHEET NO. 6
COUNTY COOPER	
JOB NO. JST0017B	
CONTRACT ID. -	
PROJECT NO. -	
BRIDGE NO. -	

DATE	DESCRIPTION
01/07/26	REVISED GROUP A PIPE
01/07/26	REVISED DROP INLET
01/07/26	REVISED GRATE AND BEARING PLATE


MISSOURI HIGHWAYS AND TRANSPORTATION
COMMISSION

105 WEST CAPITOL
JEFFERSON CITY, MO 65102
1-888-ASK-MODOT (1-888-273-6636)

**BURNS
MCDONNELL**

9400 Ward Parkway
Kansas City, MO 64114
(816) 333-9400
Certificate of Authority
No. : 000165

MATCHLINE STA. 1027+00.00

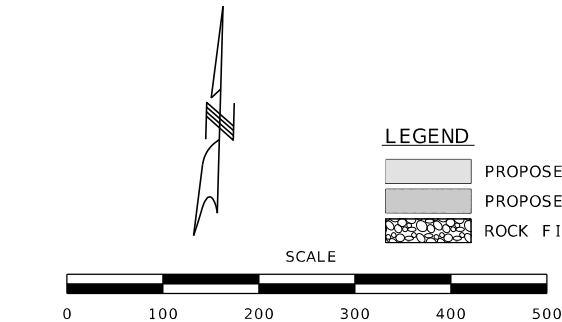

LEGEND

- PROPOSED PAVEMENT
- PROPOSED SHOULDER
- ROCK FILL

CULVERT F
STA. 1037+12.31 101.36' LT TO
STA. 1037+14.65 110.12' LT
INSTALL 9 LF 14"x 8" RCB.
REMOVE EXISTING WINGWALL
BUILD STRAIGHT WINGWALL, 15° LA

D06-LT P-1
STA. 1047+55.88 111.25' LT TO
STA. 1047+65.51 60.81' LT
INSTALL 51'x 24" PIPE, GROUP A
INCL. 1- 24" GROUP A FLARED END SECTION
ROCK LINING= 3 CY

PI 11+98.57
PC 10+00.00
PT 13+96.51
Δ 7°55'46.8" (LT)
D 1°59'59.5"
L 396.51' (ARC)
T 198.57'
R 2,865.00'

D06-LT P-2
STA. 1047+65.23 58.83' LT TO
STA. 1048+31.19 62.13' LT
INSTALL 64'x 24" PIPE, GROUP A

D06-LT I-1
STA. 1048+32.19 62.13' LT
INSTALL PRECAST CONCRETE
DROP INLET (3FT X 3FT)
INCL. 1- GRATE AND
BEARING PLATE (3FT X 3FT)

LG2878

D06-LT MH-1
STA. 1047+65.79 58.83' LT
INSTALL PRECAST CONCRETE
MANHOLE, 48"
INCL. 1- MANHOLE FRAME AND
COVER, TYPE 4

10 START STA 10+00.00 RTE 87 RAMP 1 = 10
STA 1042+73.90 C I-70
RTE 87 RAMP 2 = 10
STA 1047+37.08 C I-70

D06-LT P-1
(R)
D06-LT MH-1
(R)
D06-LT
P-2
(R)

1050

END VARIABLE DITCH
BEGIN 4' FBD
1048+32.69

END STA 18+10.00 RTE 87 RAMP 1 =
STA 1051+41.86 C I-70

MATCHLINE STA. 1054+00.00

T48NR16WS8

1040

1045

15

PROPOSED C I-70

RTE 87 RAMP 1

END GUARDRAIL
+60.03

PT STA 13+96.51

N88°25'13"E

PT STA 13+48.42

15

END STA 16+00.00 RTE 87 RAMP 2 =
STA 1048+71.18 C I-70

D06-RT P-2
STA. 1047+75.86' 60.26' RT TO
STA. 1048+80.25 60.29' RT
INSTALL 105'x 24" PIPE, GROUP A

D06-RT I-2
STA. 1047+81.75 64.06' RT
INSTALL PRECAST CONCRETE
DROP INLET (3FT X 3FT)
INCL. 1- GRATE AND
BEARING PLATE (3FT X 3FT)

D06-RT I-1
STA. 1047+74.36 60.26' LT
INSTALL PRECAST CONCRETE
DROP INLET (3FT X 3FT)
INCL. 1- GRATE AND
BEARING PLATE (3FT X 3FT)


1 REVISED

I-70 PLAN SHEET
SHEET 27 OF 60

PI 11+74.42
PC 10+00.00
PT 13+48.42
Δ 6°58'4.3" (RT)
D 1°59'59.5"
L 348.42' (ARC)
T 174.42'
R 2,865.00'

T48NR16WS8

D06-RT P-1
STA. 1047+68.15 120.54' RT TO
STA. 1047+74.33 60.26' RT
INSTALL 59'x 30" PIPE, GROUP A
INCL. 1- 30" GROUP A FLARED END SECTION
ROCK LINING= 4 CY

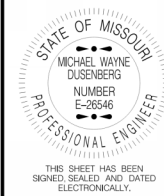

DATE PREPARED
1/7/2026

ROUTE
I-70
STATE
MO
DISTRICT
CD
SHEET NO.
30

COUNTY
COOPER

JOB NO.
JST0017B

CONTRACT ID.
-

PROJECT NO.
-



BRIDGE NO.
-

DATE	DESCRIPTION
01/07/26	REVISED DROP INLET
01/07/26	REVISED GRATE AND BEARING PLATE

MISSOURI HIGHWAYS AND TRANSPORTATION
COMMISSION



**BURNS
MCDONNELL**
9400 Ward Parkway
Kansas City, MO 64114
(816) 333-9400
Certificate of Authority
No.: 000165

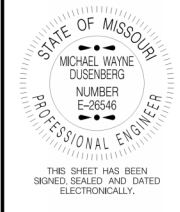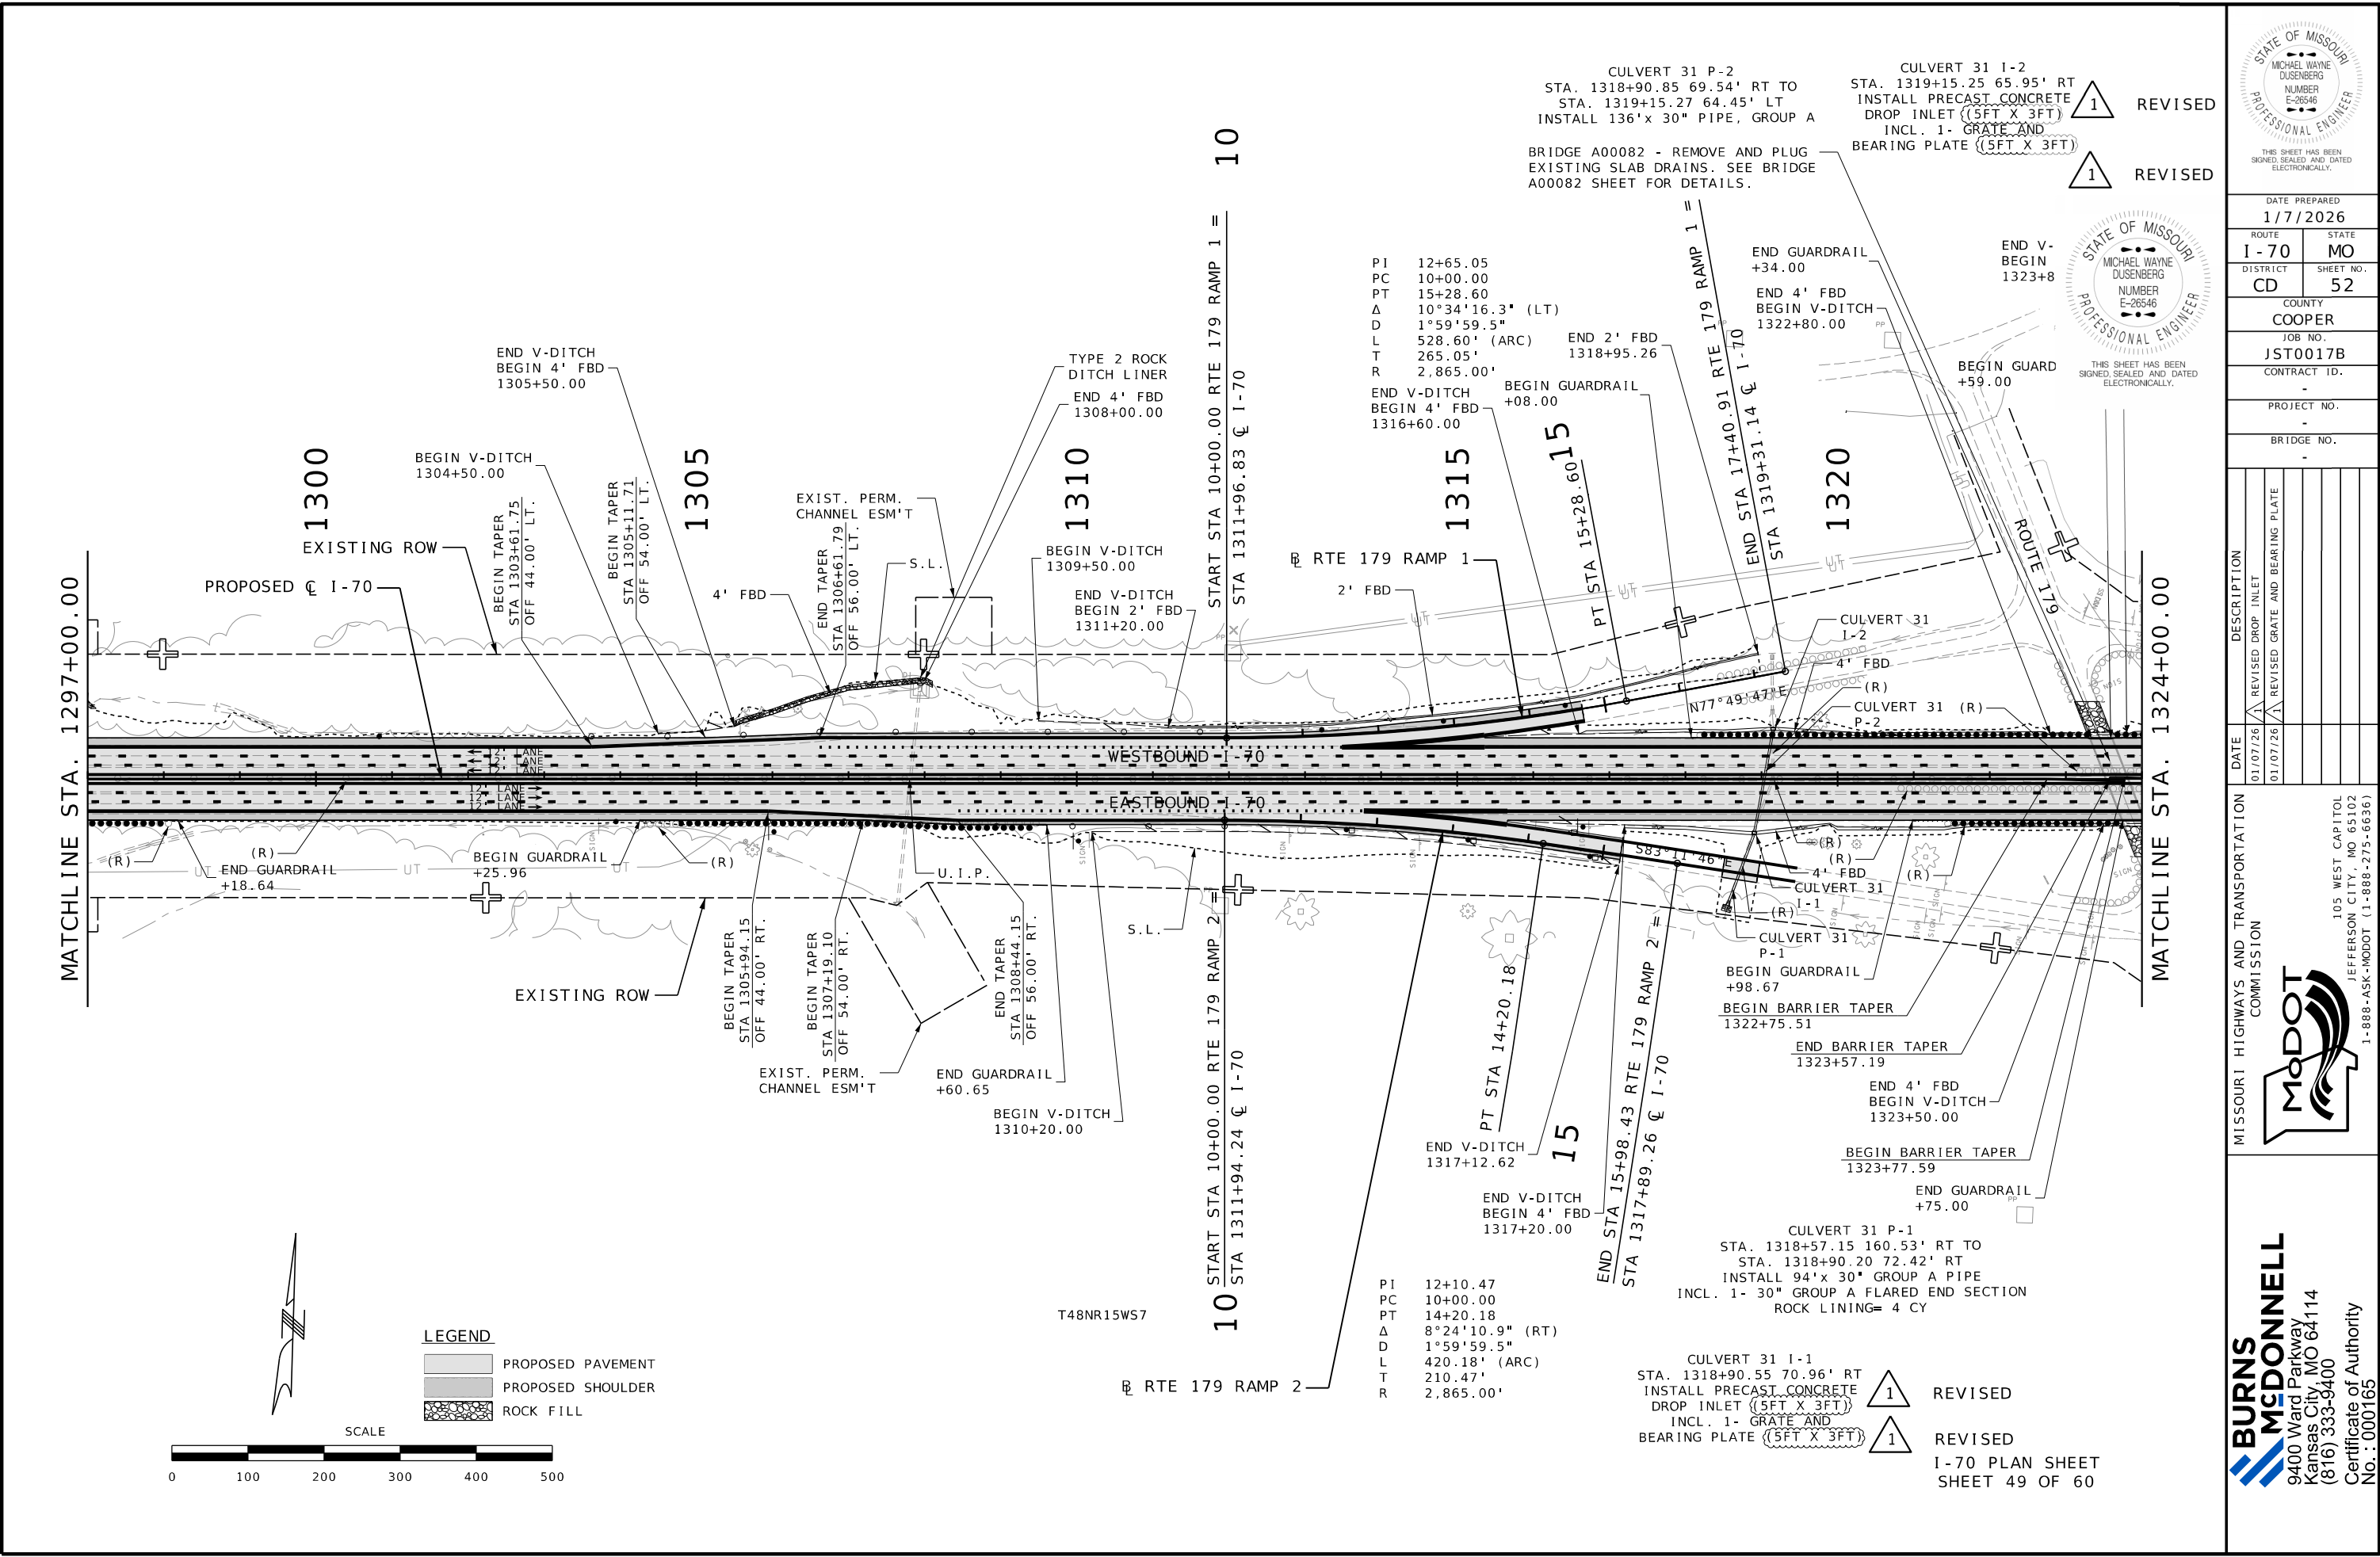

DATE PREPARED 1/7/2026	
ROUTE 1-70	STATE MO
DISTRICT CD	SHEET NO. 52

COUNTY
COOPER
JOB NO.
JST0017B
CONTRACT ID.
-


PROJECT NO.
-
BRIDGE NO.
-

DATE	DESCRIPTION
01/07/26	REVISED DROP INLET
01/07/26	REVISED GRATE AND BEARING PLATE

MISSOURI HIGHWAYS AND TRANSPORTATION COMMISSION

105 WEST CAPITOL
JEFFERSON CITY, MO 65102
1-888-ASK-MODOT (1-888-275-6636)

BURNS & MCDONNELL
9400 Ward Parkway
Kansas City, MO 64114
(816) 333-9400
Certificate of Authority
No. : 000165

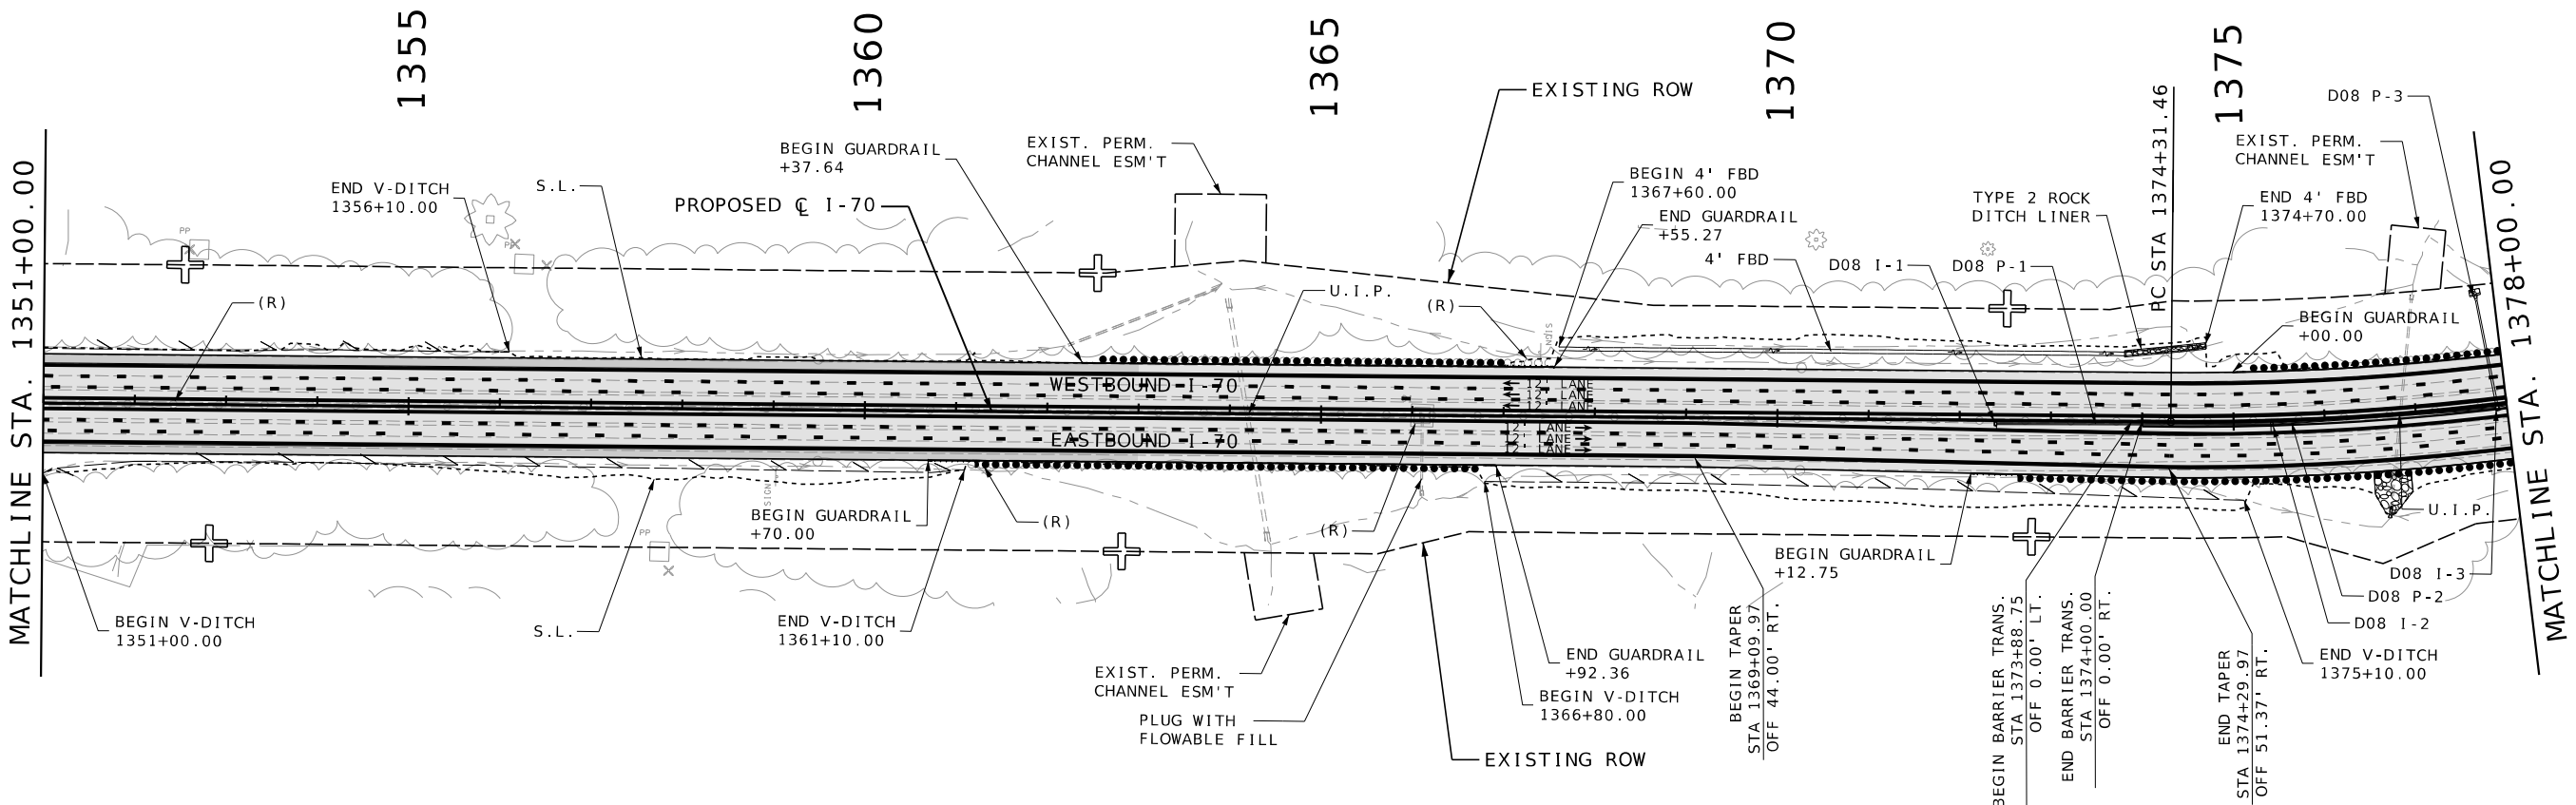

1
D08 P-3
STA. 1377+79.83 115.02' LT TO
STA. 1377+89.45 1.60' RT
BUILD 117'x24" PIPE, GROUP A
INCL. 1- 24" GROUP A FLARED END SECTION
ROCK LINING= 3 CY

1
D08 I-3
STA. 1377+89.45 3.53' RT
INSTALL PRECAST CONCRETE
DROP INLET (5FT X 3FT)
INCL. 1- GRATE AND
BEARING PLATE (5FT X 3FT)


1
D08 P-1
STA. 1372+40.22 3.80' RT TO
STA. 1375+40.87 3.69' RT
INSTALL 301'x 24" PIPE, GROUP A

1
D08 P-2
STA. 1375+42.87 3.75' RT TO
STA. 1377+88.45 3.60' RT
INSTALL 246'x 24" PIPE, GROUP A

1
D08 I-1
STA. 1372+39.22 3.80' RT
INSTALL PRECAST CONCRETE
DROP INLET (4FT X 2FT)
INCL. 1- GRATE AND
BEARING PLATE (4FT X 2FT)

1
D08 I-2
STA. 1375+40.87 3.69' RT
INSTALL PRECAST CONCRETE
DROP INLET (4FT X 2FT)
INCL. 1- GRATE AND
BEARING PLATE (4FT X 2FT)

1
CULVERT 35
STA. 1376+64.80 106.97' RT TO
STA. 1376+65.61 102.05' RT
BUILD 5'x 24" GROUP A PIPE
INCL. 1- PIPE COLLAR, TYPE A
INCL. 1- 24" GROUP A FLARED END SECTION

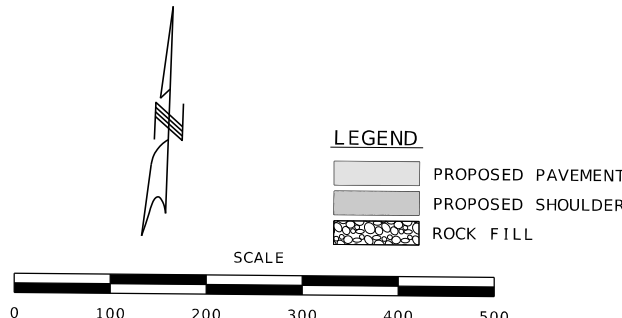

STATE OF MISSOURI

MICHAEL WAYNE DUSEBERG

NUMBER E-26546

PROFESSIONAL ENGINEER

THIS SHEET HAS BEEN SIGNED, SEALED AND DATED ELECTRONICALLY.

DATE PREPARED

1/7/2026

ROUTE

I - 70

STATE

MO

DISTRICT

CD

SHEET NO.

58

COUNTY

COOPER

JOB NO.

JST0017B

CONTRACT ID.

-

PROJECT NO.

-

BRIDGE NO.

-

DESCRIPTION

REVISED GROUP A PIPE

REVISED DROP INLET

REVISED GRATE AND BEARING PLATE

DATE

01/07/26

01/07/26

01/07/26

MISSOURI HIGHWAYS AND TRANSPORTATION COMMISSION

MoDOT

105 WEST CAPITOL

JEFFERSON CITY, MO 65102

1-888-ASK-MODOT (1-888-275-6636)

BURNS MCDONNELL

9400 Ward Parkway

Kansas City, MO 64114

(816) 333-9400


Certificate of Authority

No. : 000165


1/7/2026

8:47:08 AM


d0185119\058_PP_JST0017B_I100_I-70.dgn

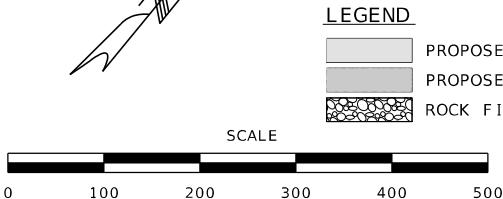


c:\bmcd_lib\pw_connect\trn\d0185119\062_PP_JST0017B_I100_I-70.dgn 2:35:26 PM 1/7/2026

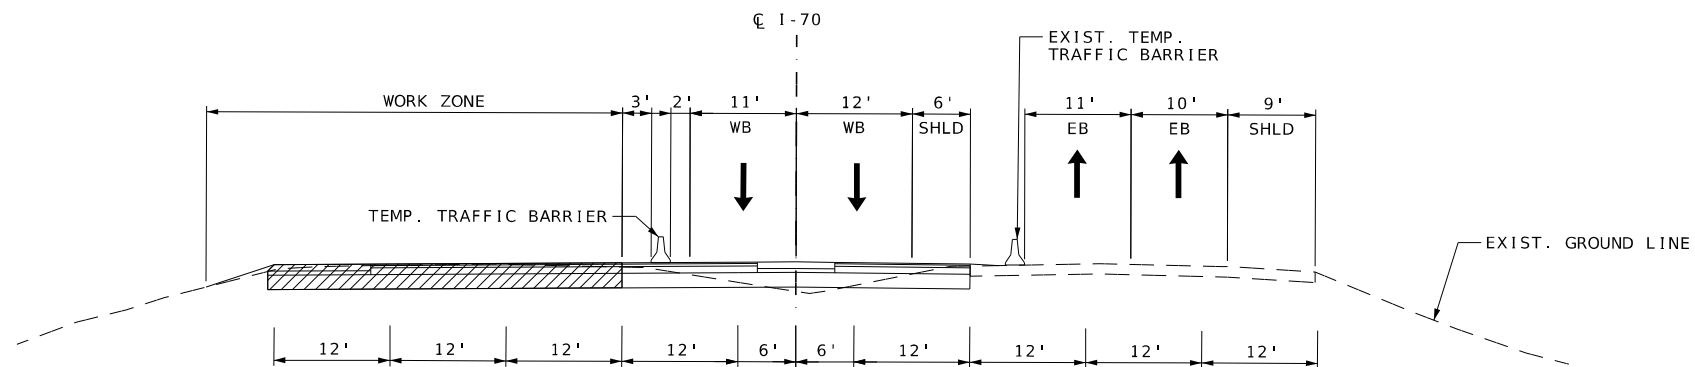


SECTION ON TANGENT
TYPICAL SECTION I-70
PHASE 2

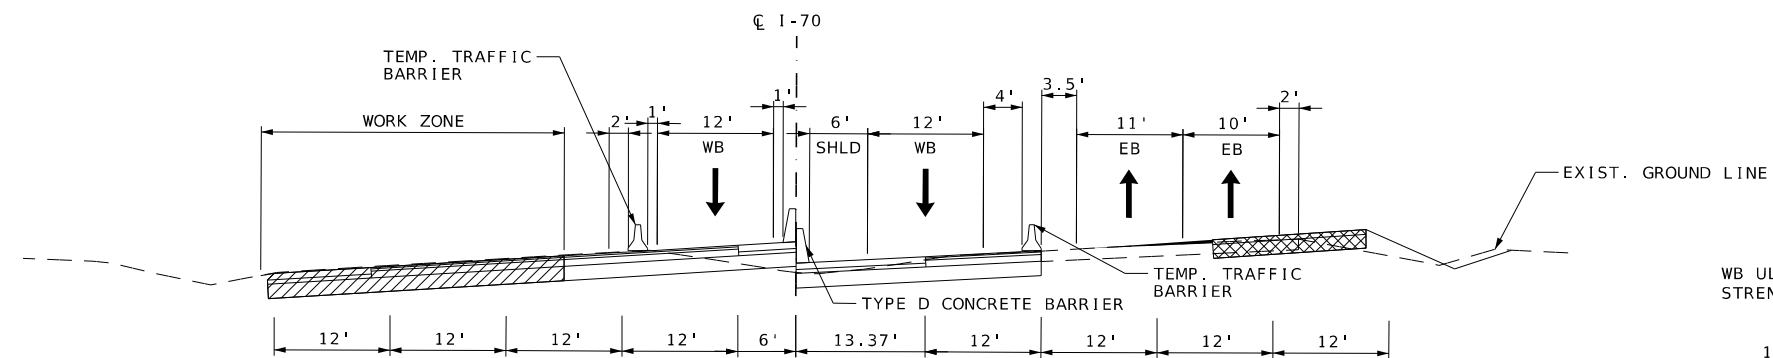

SECTION ON CURVE
TYPICAL SECTION I-70
PHASE 2

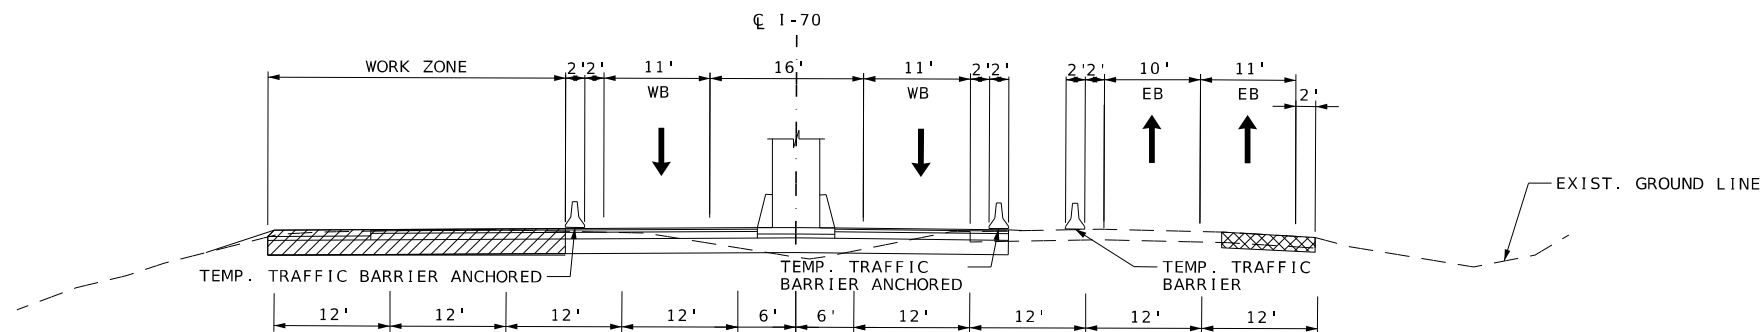

SECTION ON TANGENT
TYPICAL SECTION I-70
PHASE 2
STA. 810+29 TO 816+16
STA. 897+79 TO 903+29
STA. 1052+99 TO 1058+80
STA. 1321+42 TO 1326+20

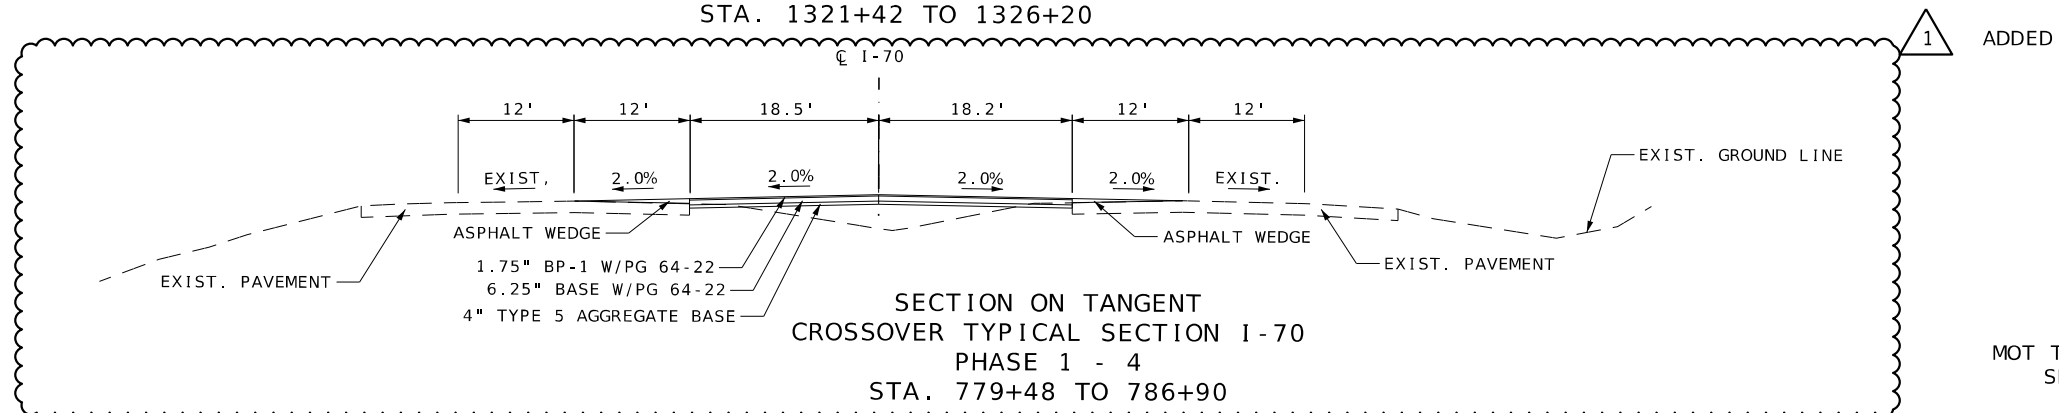

SECTION ON TANGENT
CROSSOVER TYPICAL SECTION I-70
PHASE 1 - 4
STA. 779+48 TO 786+90

WB ULTIMATE PAVEMENT WITH
STRENGTHENED SHOULDER STA
807+90 TO 818+60
901+00 TO 910+40
1050+90 TO 1060+60
1227+40 TO 1236+90
1318+90 TO 1328+40

SEE ROADWAY TYPICAL SECTION FOR
PAVEMENT SECTION DETAILS



THIS SHEET HAS BEEN
SIGNED, SEALED, AND DATED
ELECTRONICALLY

DATE PREPARED
1/7/2026

ROUTE
I-70

STATE
MO

DISTRICT
CD

SHEET NO.
93

COUNTY
COOPER

JOB NO.
JST0017B

CONTRACT ID.
-

PROJECT NO.
-

BRIDGE NO.
-

DESCRIPTION
ADDED CROSSOVER TYPICAL SECTION

DATE
01/07/26

MISSOURI HIGHWAYS AND TRANSPORTATION
COMMISSION

105 WEST CAPITOL
JEFFERSON CITY, MO 65102

1-888-ASK-MODOT (1-888-275-6636)

MoDOT




BURNS
MCDONNELL

9400 Ward Parkway
Kansas City, MO 64114

(816) 333-9400

Certificate of Authority
No. : 000165

MOT TYPICAL SECTION
SHEET 2 OF 3

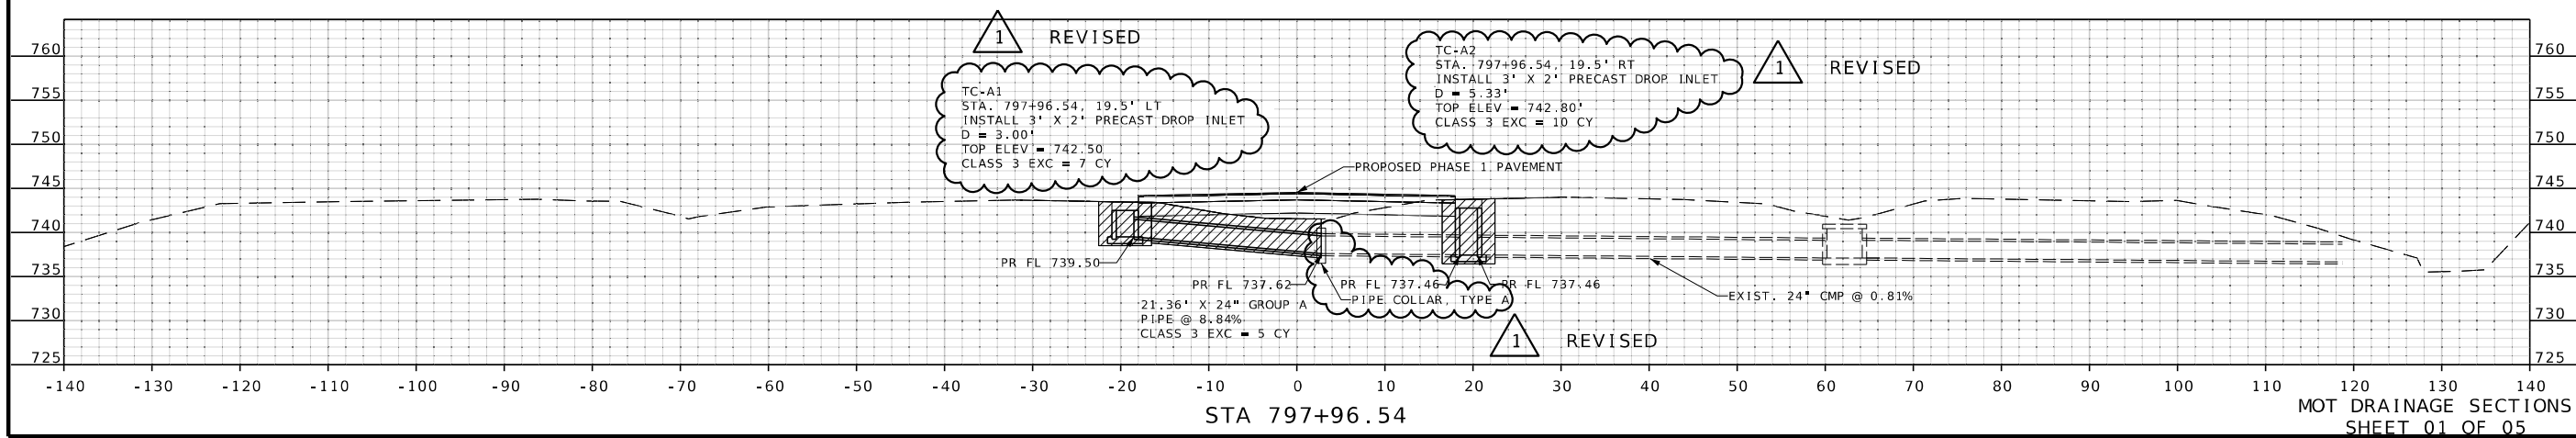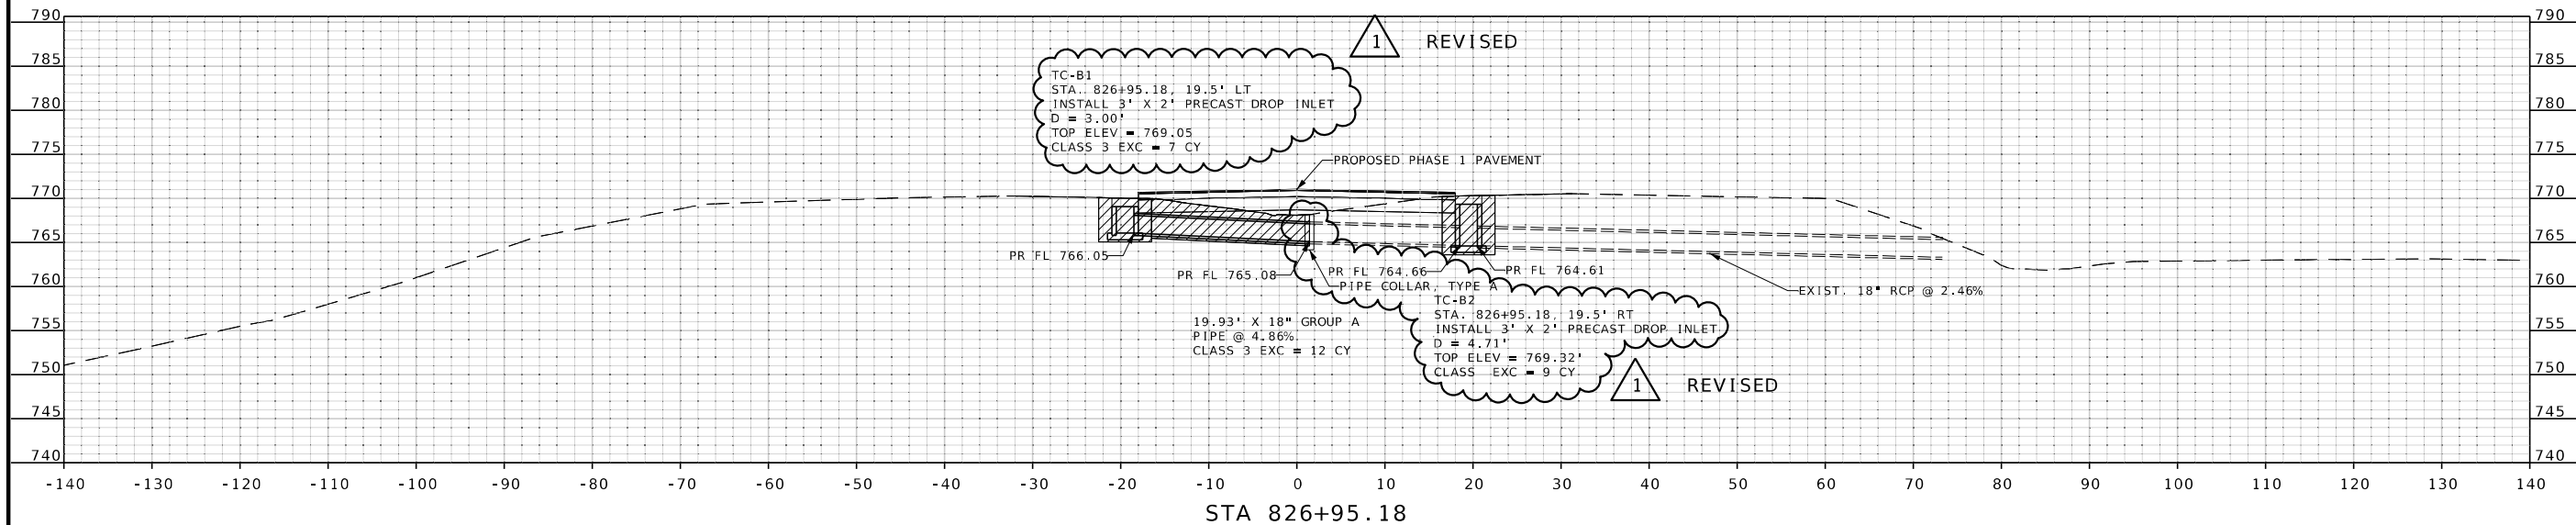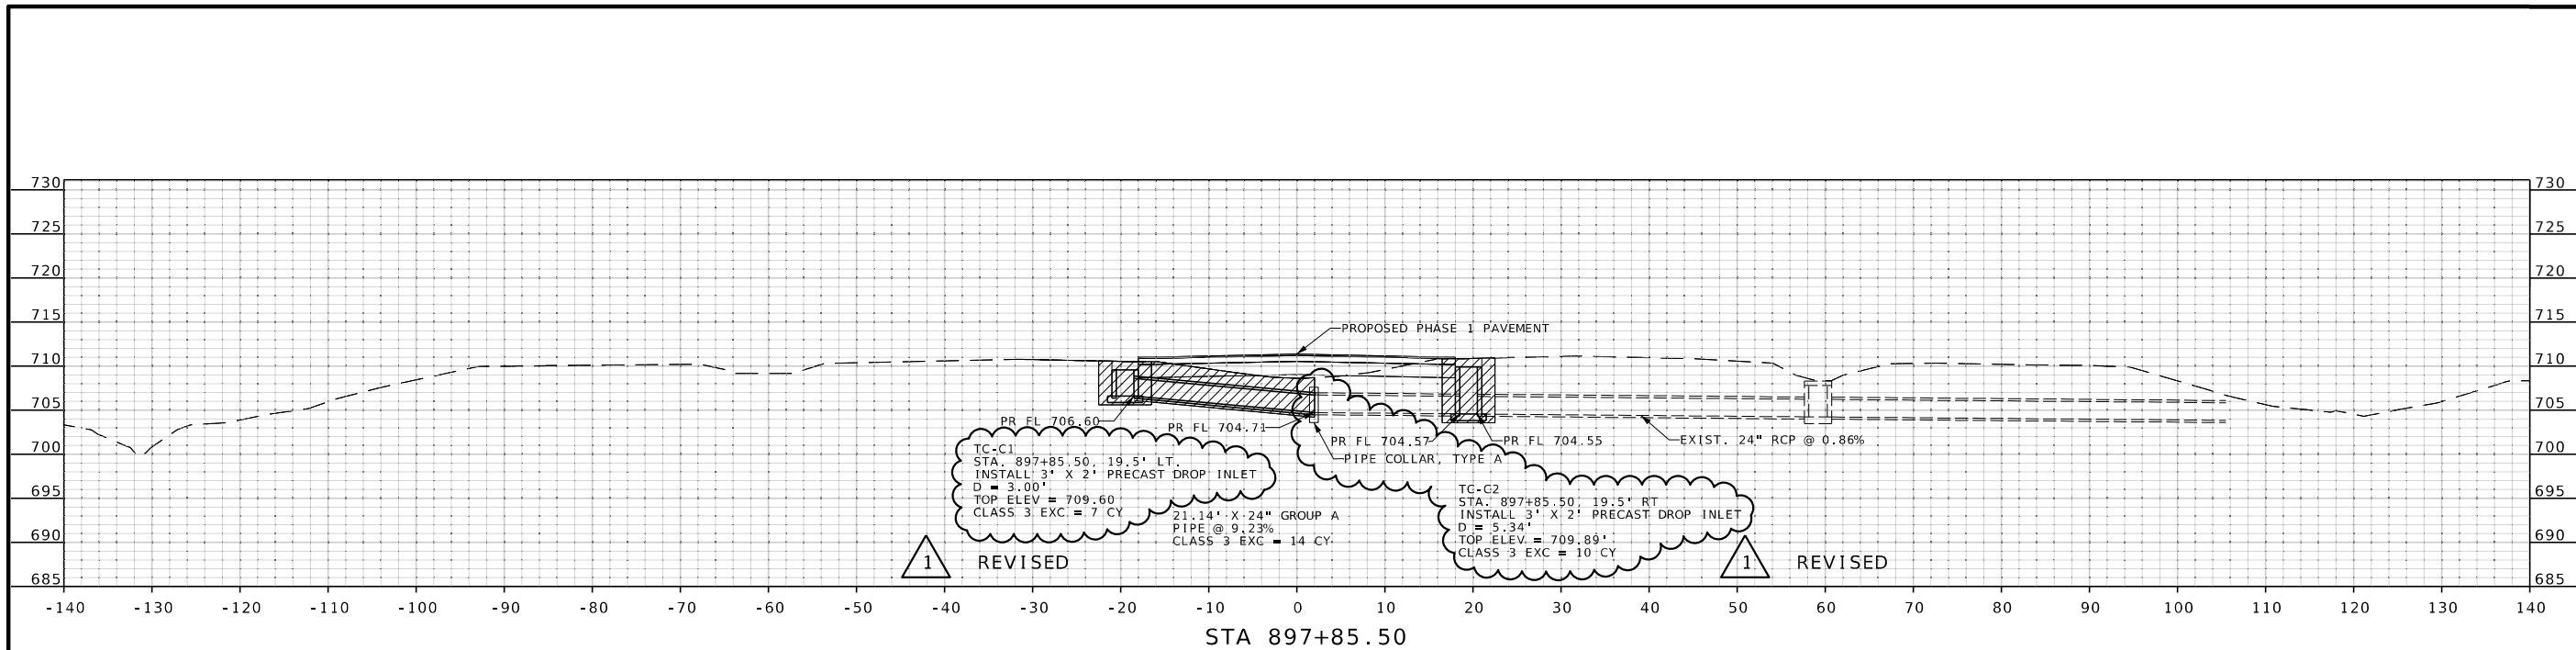

STATE OF MISSOURI

RONNIE WILLIAMS

NUMBER PE-2010000879

PROFESSIONAL ENGINEER

THIS SHEET HAS BEEN SIGNED, SEALED, AND DATED ELECTRONICALLY

DATE PREPARED 1/7/2026

ROUTE 1-70 STATE MO

DISTRICT CD SHEET NO. 96

COUNTY COOPER

JOB NO. JST0017B

CONTRACT ID. -

PROJECT NO. -

BRIDGE NO. -

DATE	DESCRIPTION
01/07/26	REVISED INLET SIZE & PIPE COLLARS

MISSOURI HIGHWAYS AND TRANSPORTATION COMMISSION

MoDOT


105 WEST CAPITOL JEFFERSON CITY, MO 65102 1-888-ASK-MODOT (1-888-275-6636)

BURNS MCDONNELL

9400 Ward Parkway Kansas City, MO 64114 (816) 333-9400

Certificate of Authority No. : 000165

c:\bmc_d_lib\pw_connect\trn\d0185116\096-100_TC_JST0017B_110_Typ-05-09.dgn 4:56:44 PM 1/7/2026

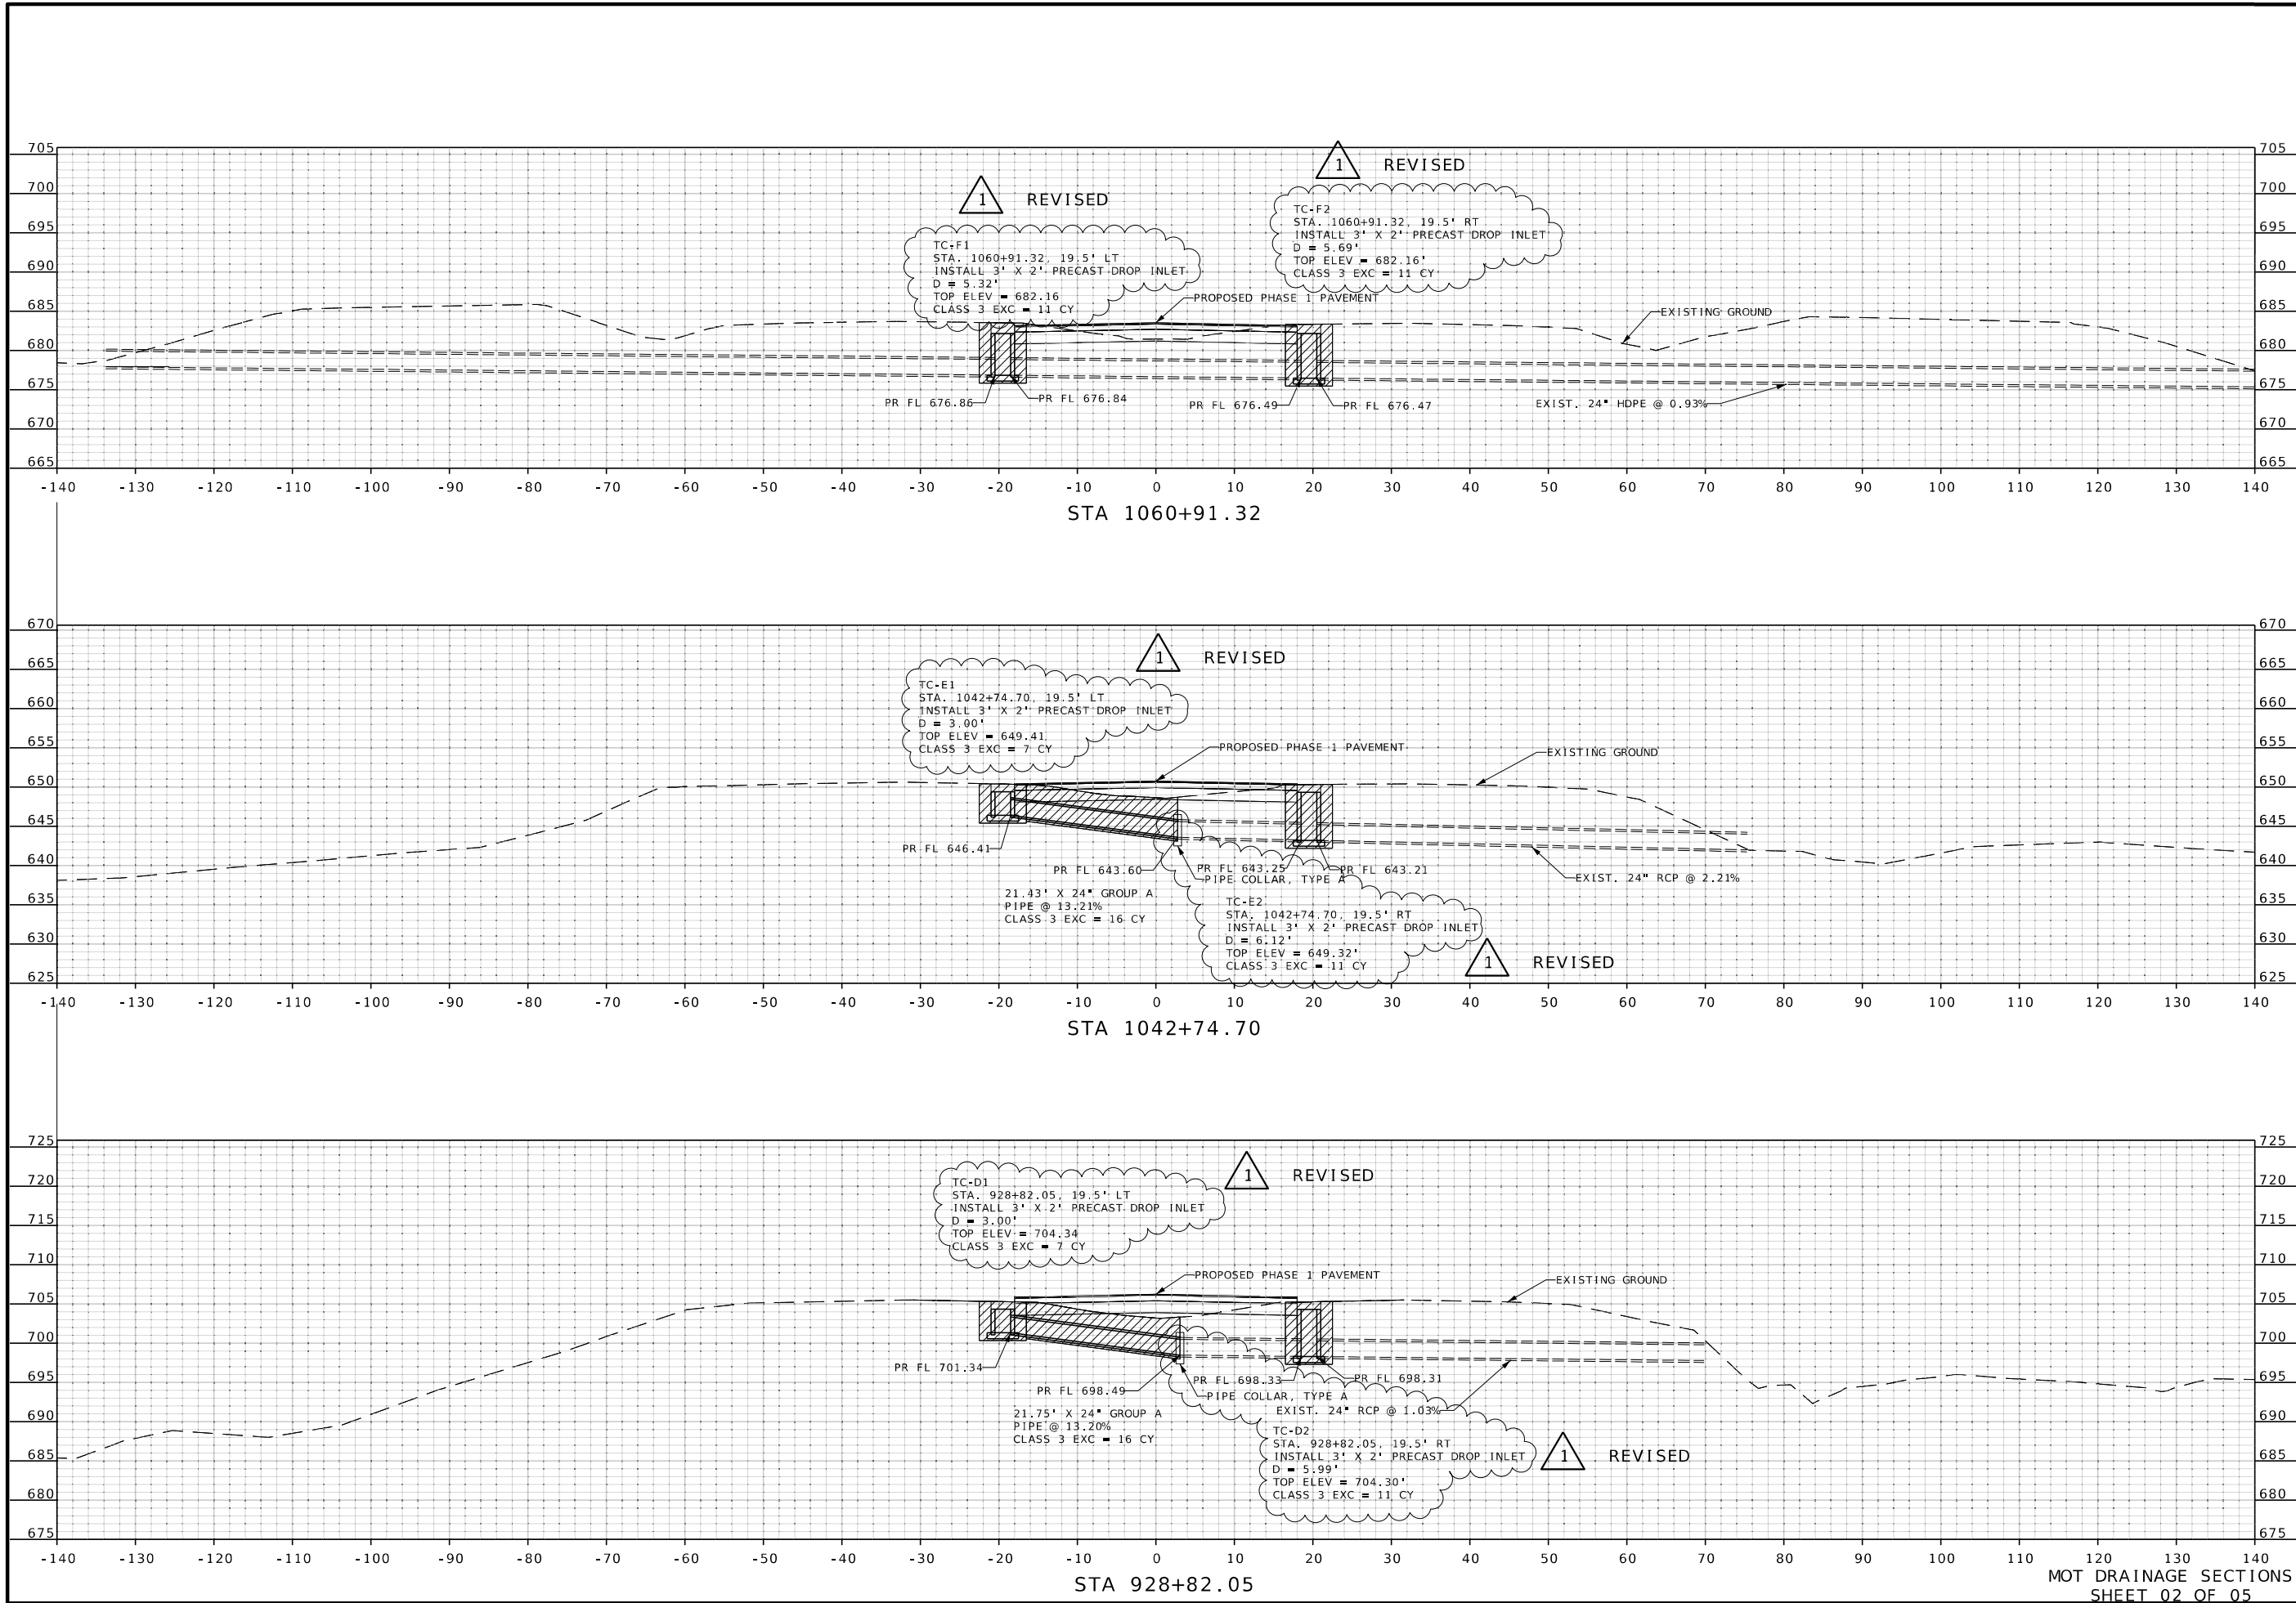

STATE OF MISSOURI

RONNIE WILLIAMS

NUMBER PE-2010000879

PROFESSIONAL ENGINEER

THIS SHEET HAS BEEN SIGNED, SEALED, AND DATED ELECTRONICALLY

DATE PREPARED 1/7/2026

ROUTE 1-70

STATE MO

DISTRICT CD

SHEET NO. 97

COUNTY COOPER

JOB NO. JST0017B

CONTRACT ID. -

PROJECT NO. -

BRIDGE NO. -

DESCRIPTION

DATE 01/07/26

REVISIONS

INLET SIZE & PIPE COLLARS

MISSOURI HIGHWAYS AND TRANSPORTATION COMMISSION

MoDOT

105 WEST CAPITOL

JEFFERSON CITY, MO 65102

1-888-ASK-MODOT (1-888-275-6636)

BURNS MCDONNELL

9400 Ward Parkway



Kansas City, MO 64114

(816) 333-9400

Certificate of Authority

No. : 000165

c:\bmcad_lib\pw_connect\trn\d0185116\096-100_TC_JST0017B_I10_Typ-05-09.dgn 4:58:28 PM 1/7/2026

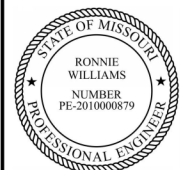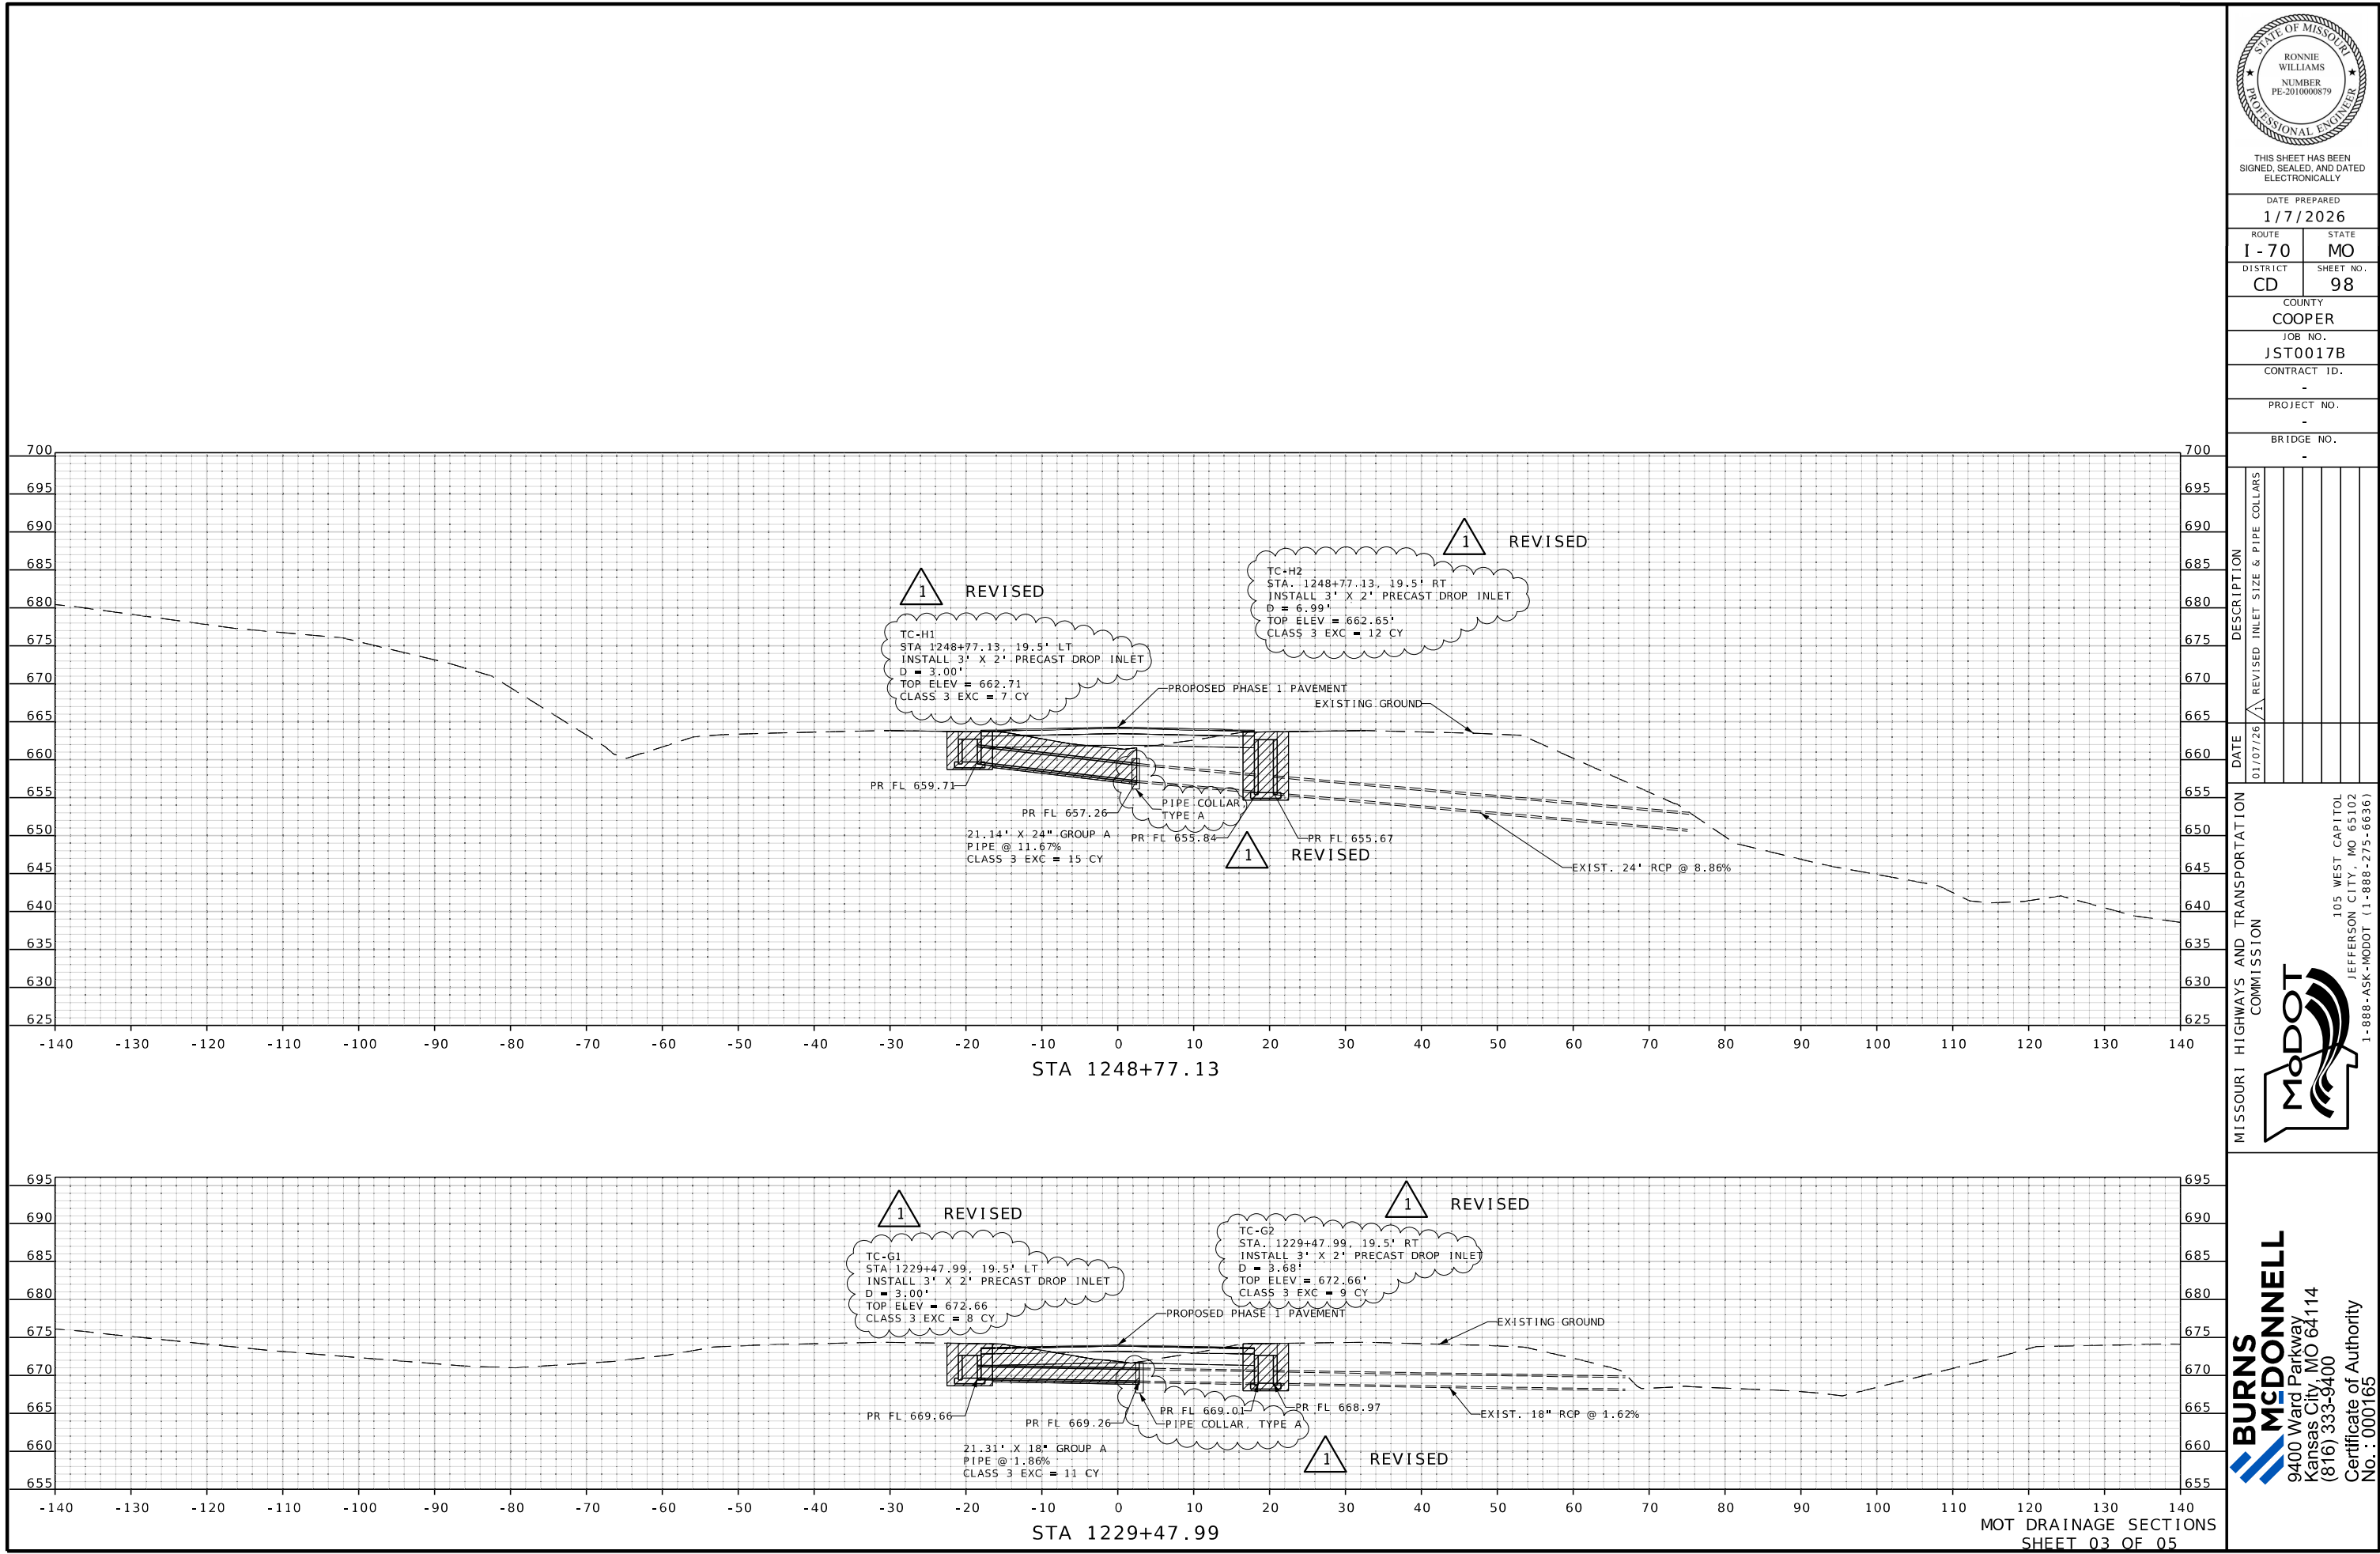

THIS SHEET HAS BEEN
SIGNED, SEALED, AND DATED
ELECTRONICALLY

DATE PREPARED
1/7/2026

ROUTE 1-70 STATE MO

DISTRICT CD SHEET NO. 98

COUNTY COOPER

JOB NO. JST0017B

CONTRACT ID. -

PROJECT NO. -

BRIDGE NO. -

DATE	DESCRIPTION
01/07/26	REVISED INLET SIZE & PIPE COLLARS



MISSOURI HIGHWAYS AND TRANSPORTATION
COMMISSION

105 WEST CAPITOL
JEFFERSON CITY, MO 65102
1-888-ASK-MODOT (1-888-275-6636)

**BURNS
MCDONNELL**

9400 Ward Parkway
Kansas City, MO 64114
(816) 333-9400

Certificate of Authority
No. : 000165

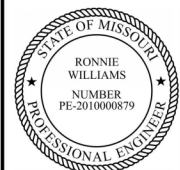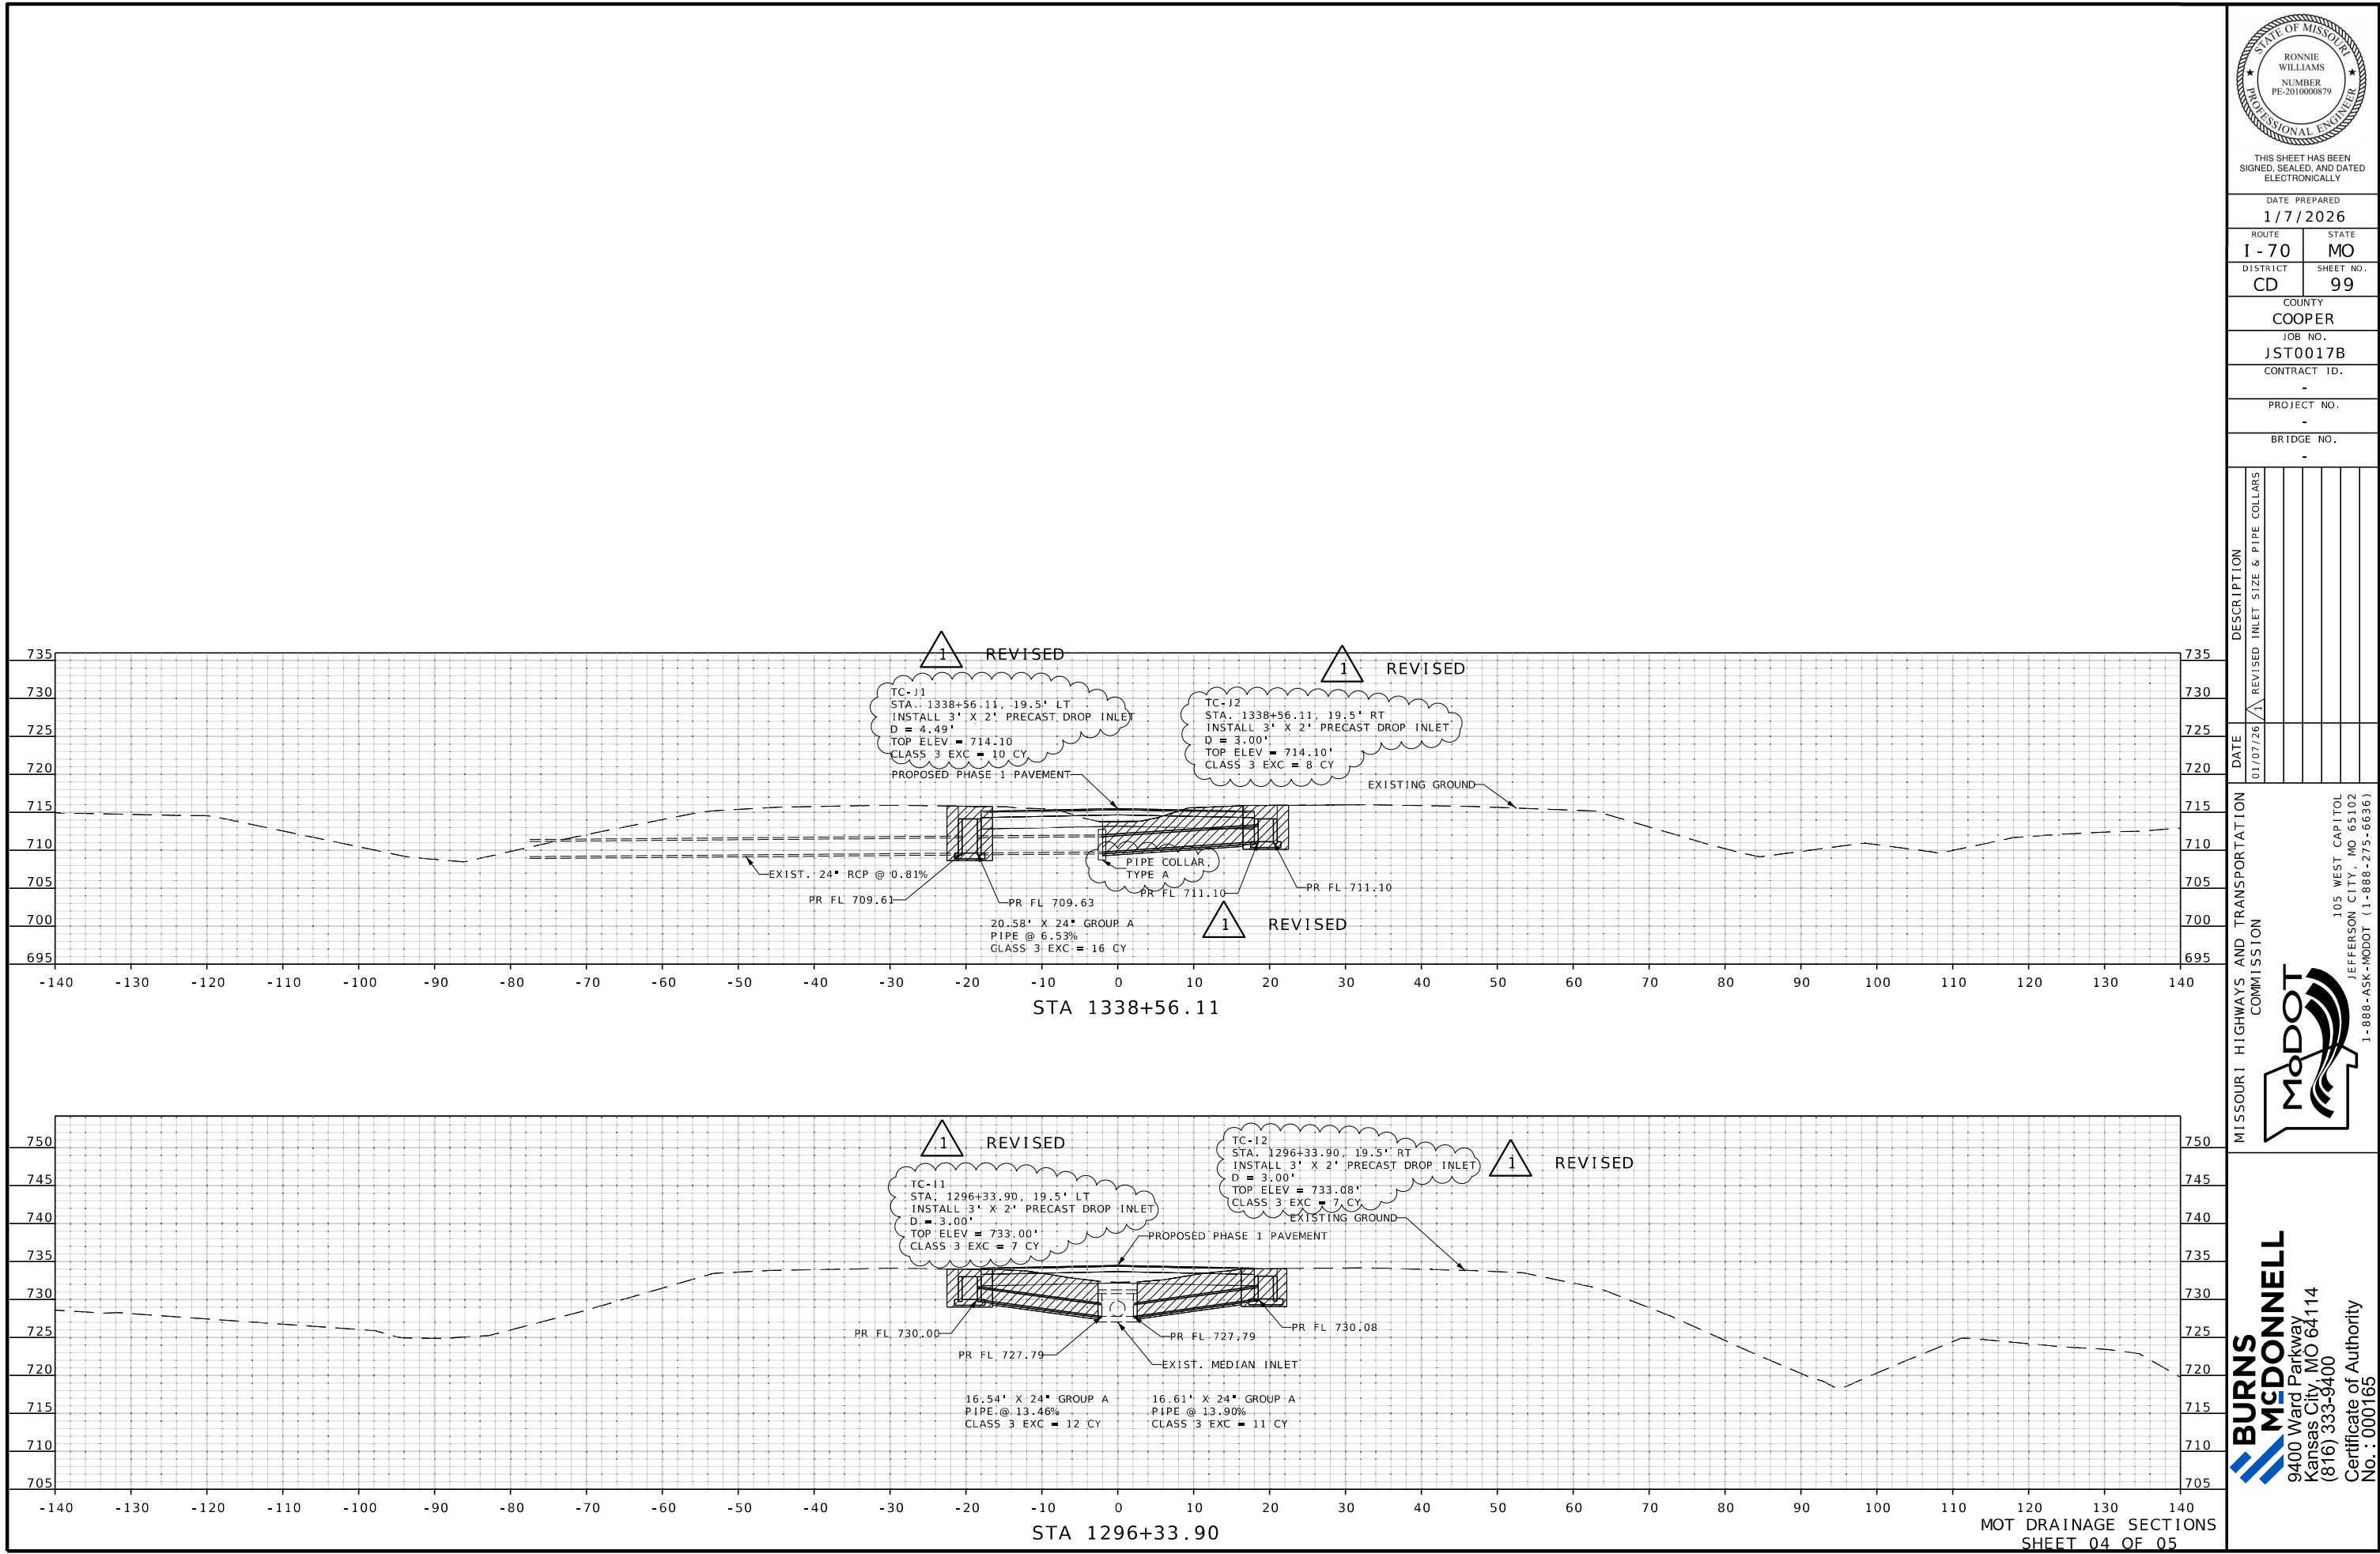

THIS SHEET HAS BEEN
SIGNED, SEALED, AND DATED
ELECTRONICALLY

DATE PREPARED
1/7/2026

ROUTE 1-70 STATE MO

DISTRICT CD SHEET NO. 99

COUNTY COOPER

JOB NO. JST0017B

CONTRACT ID. -

PROJECT NO. -

BRIDGE NO. -

DESCRIPTION	DATE
REVISED INLET SIZE & PIPE COLLARS	01/07/26



MISSOURI HIGHWAYS AND TRANSPORTATION
COMMISSION

105 WEST CAPITOL
JEFFERSON CITY, MO 65102
1-888-ASK-MODOT (1-888-275-6636)

**BURNS
MCDONNELL**

9400 Ward Parkway
Kansas City, MO 64114
(816) 333-9400

Certificate of Authority
No. : 000165

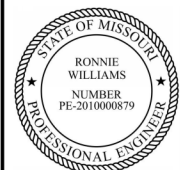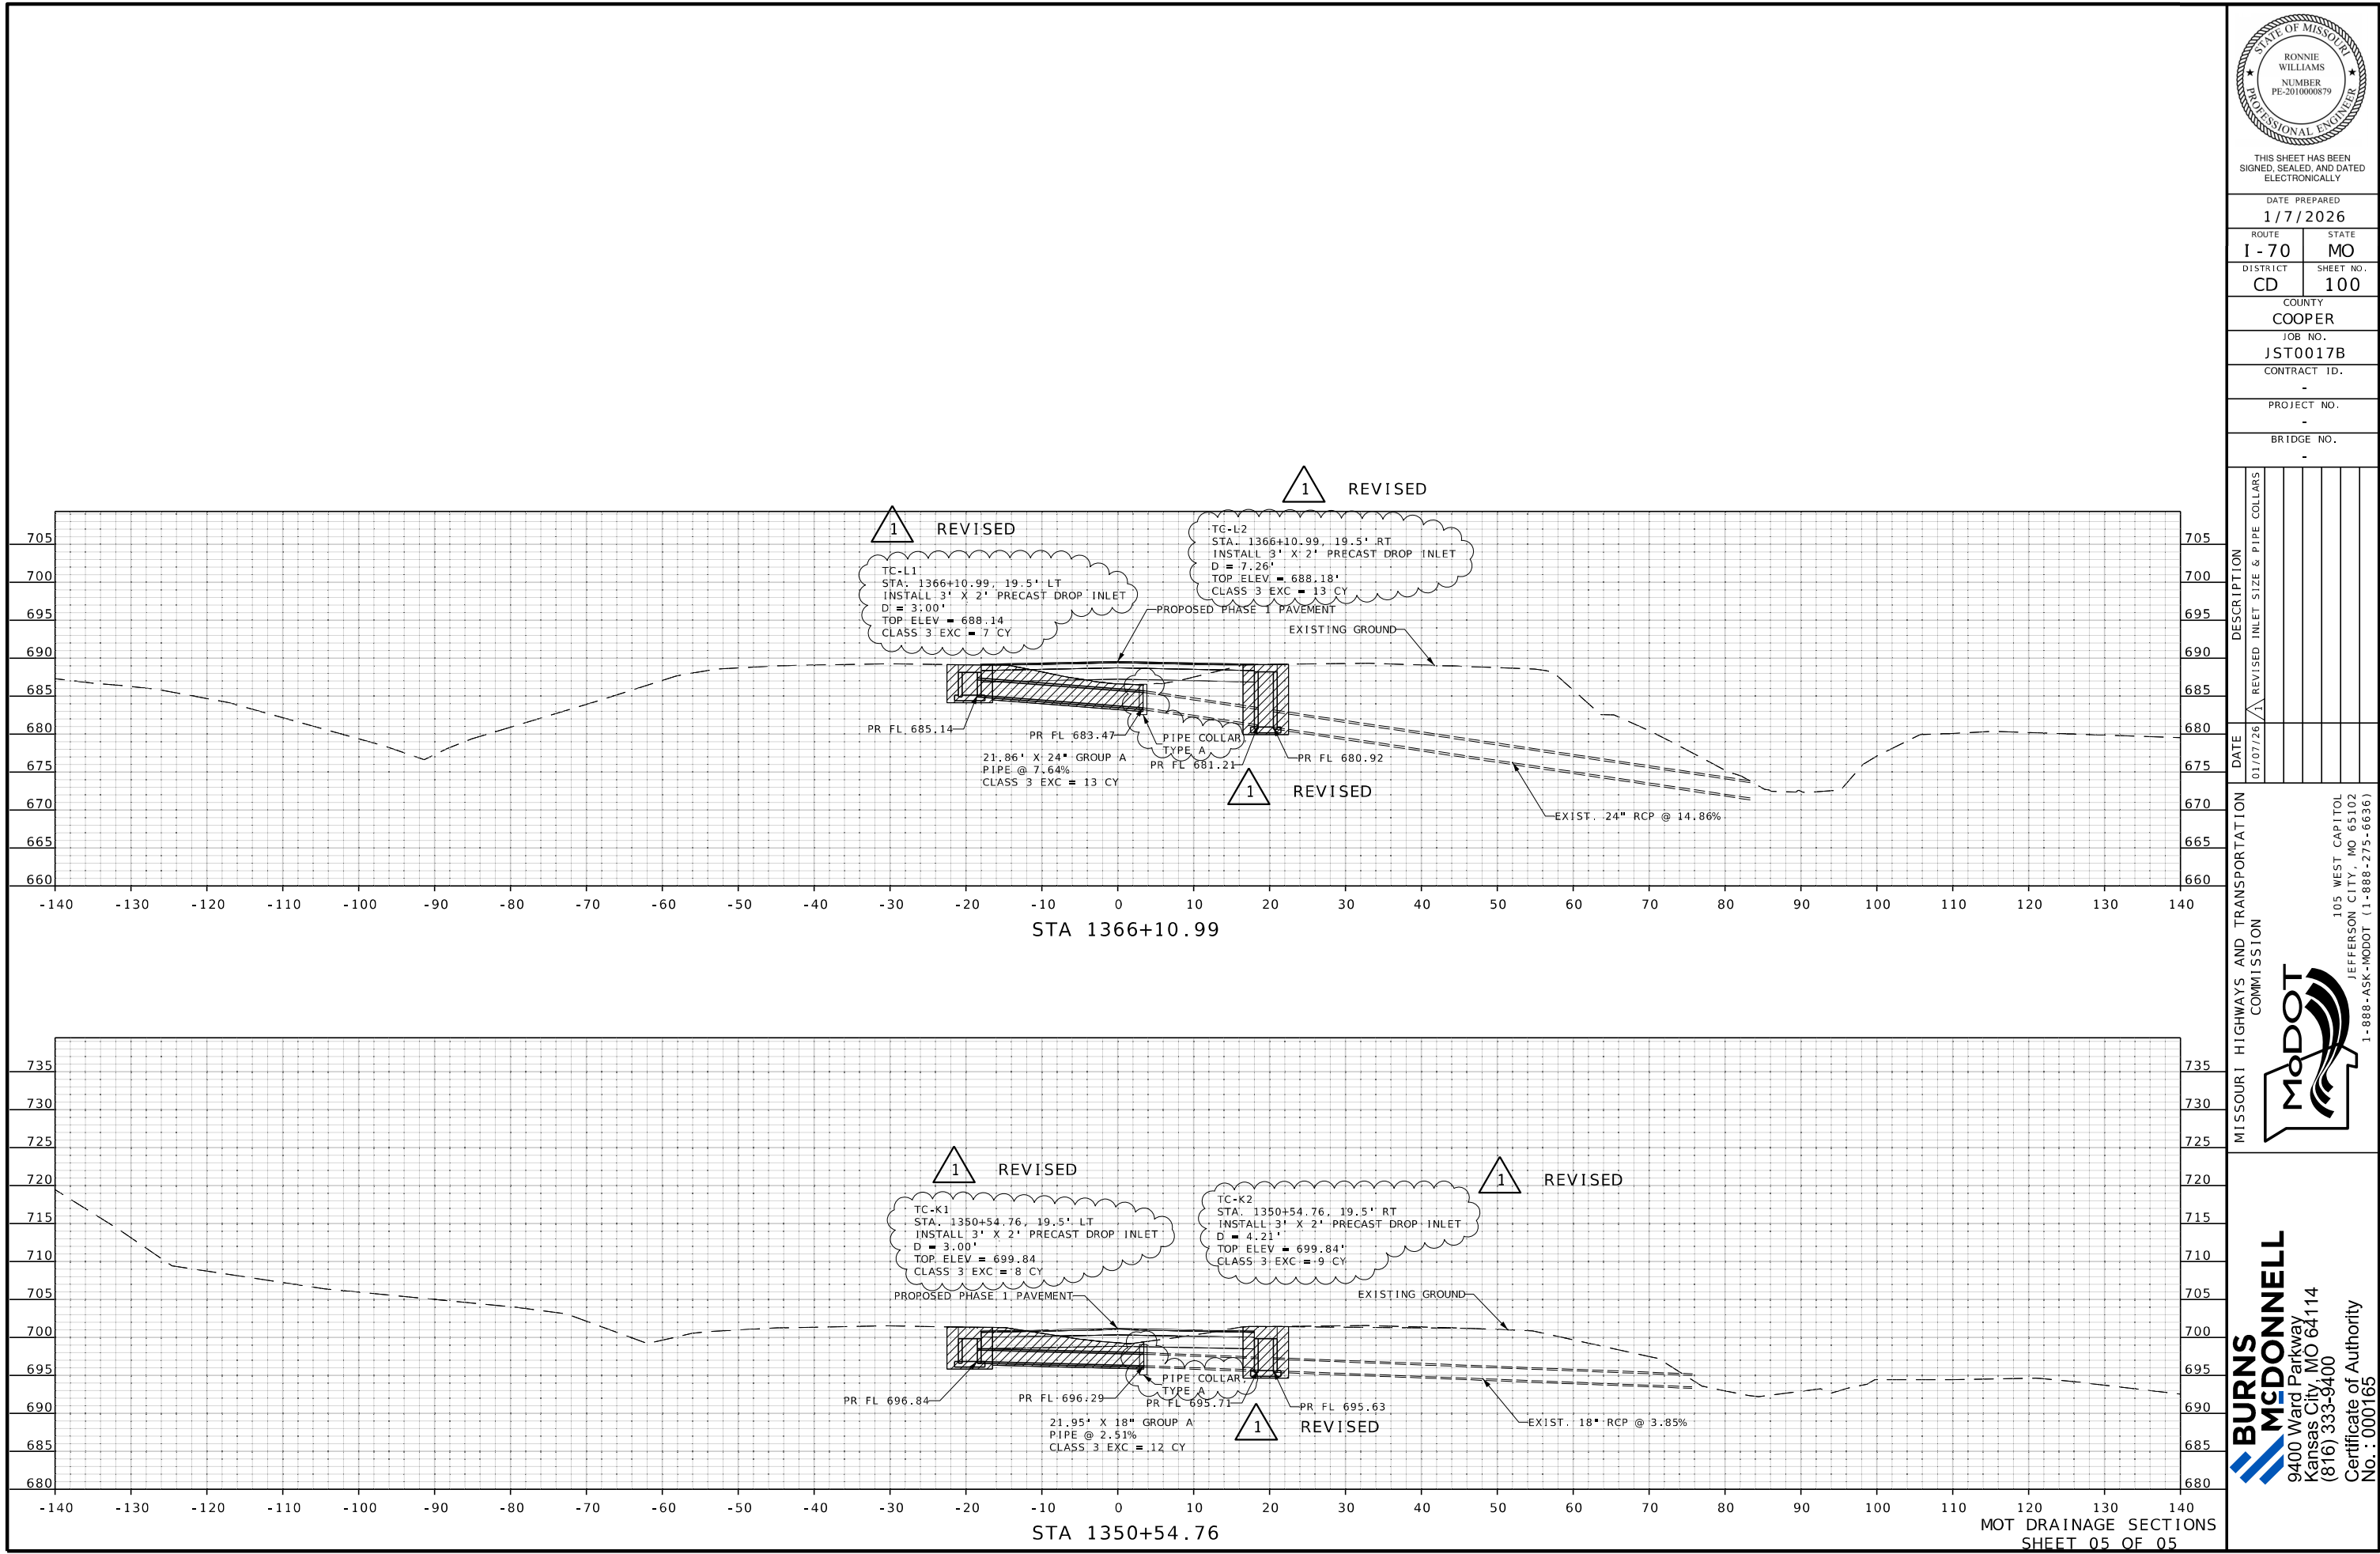

THIS SHEET HAS BEEN
SIGNED, SEALED, AND DATED
ELECTRONICALLY

DATE PREPARED
1/7/2026

ROUTE 1-70 STATE MO

DISTRICT CD SHEET NO. 100

COUNTY COOPER

JOB NO. JST0017B

CONTRACT ID. -

PROJECT NO. -


BRIDGE NO. -

DATE	DESCRIPTION
01/07/26	REVISED INLET SIZE & PIPE COLLARS

MISSOURI HIGHWAYS AND TRANSPORTATION
COMMISSION

105 WEST CAPITOL
JEFFERSON CITY, MO 65102
1-888-ASK-MODOT (1-888-275-6636)

**BURNS
MCDONNELL**
9400 Ward Parkway
Kansas City, MO 64114
(816) 333-9400
Certificate of Authority
No. : 000165

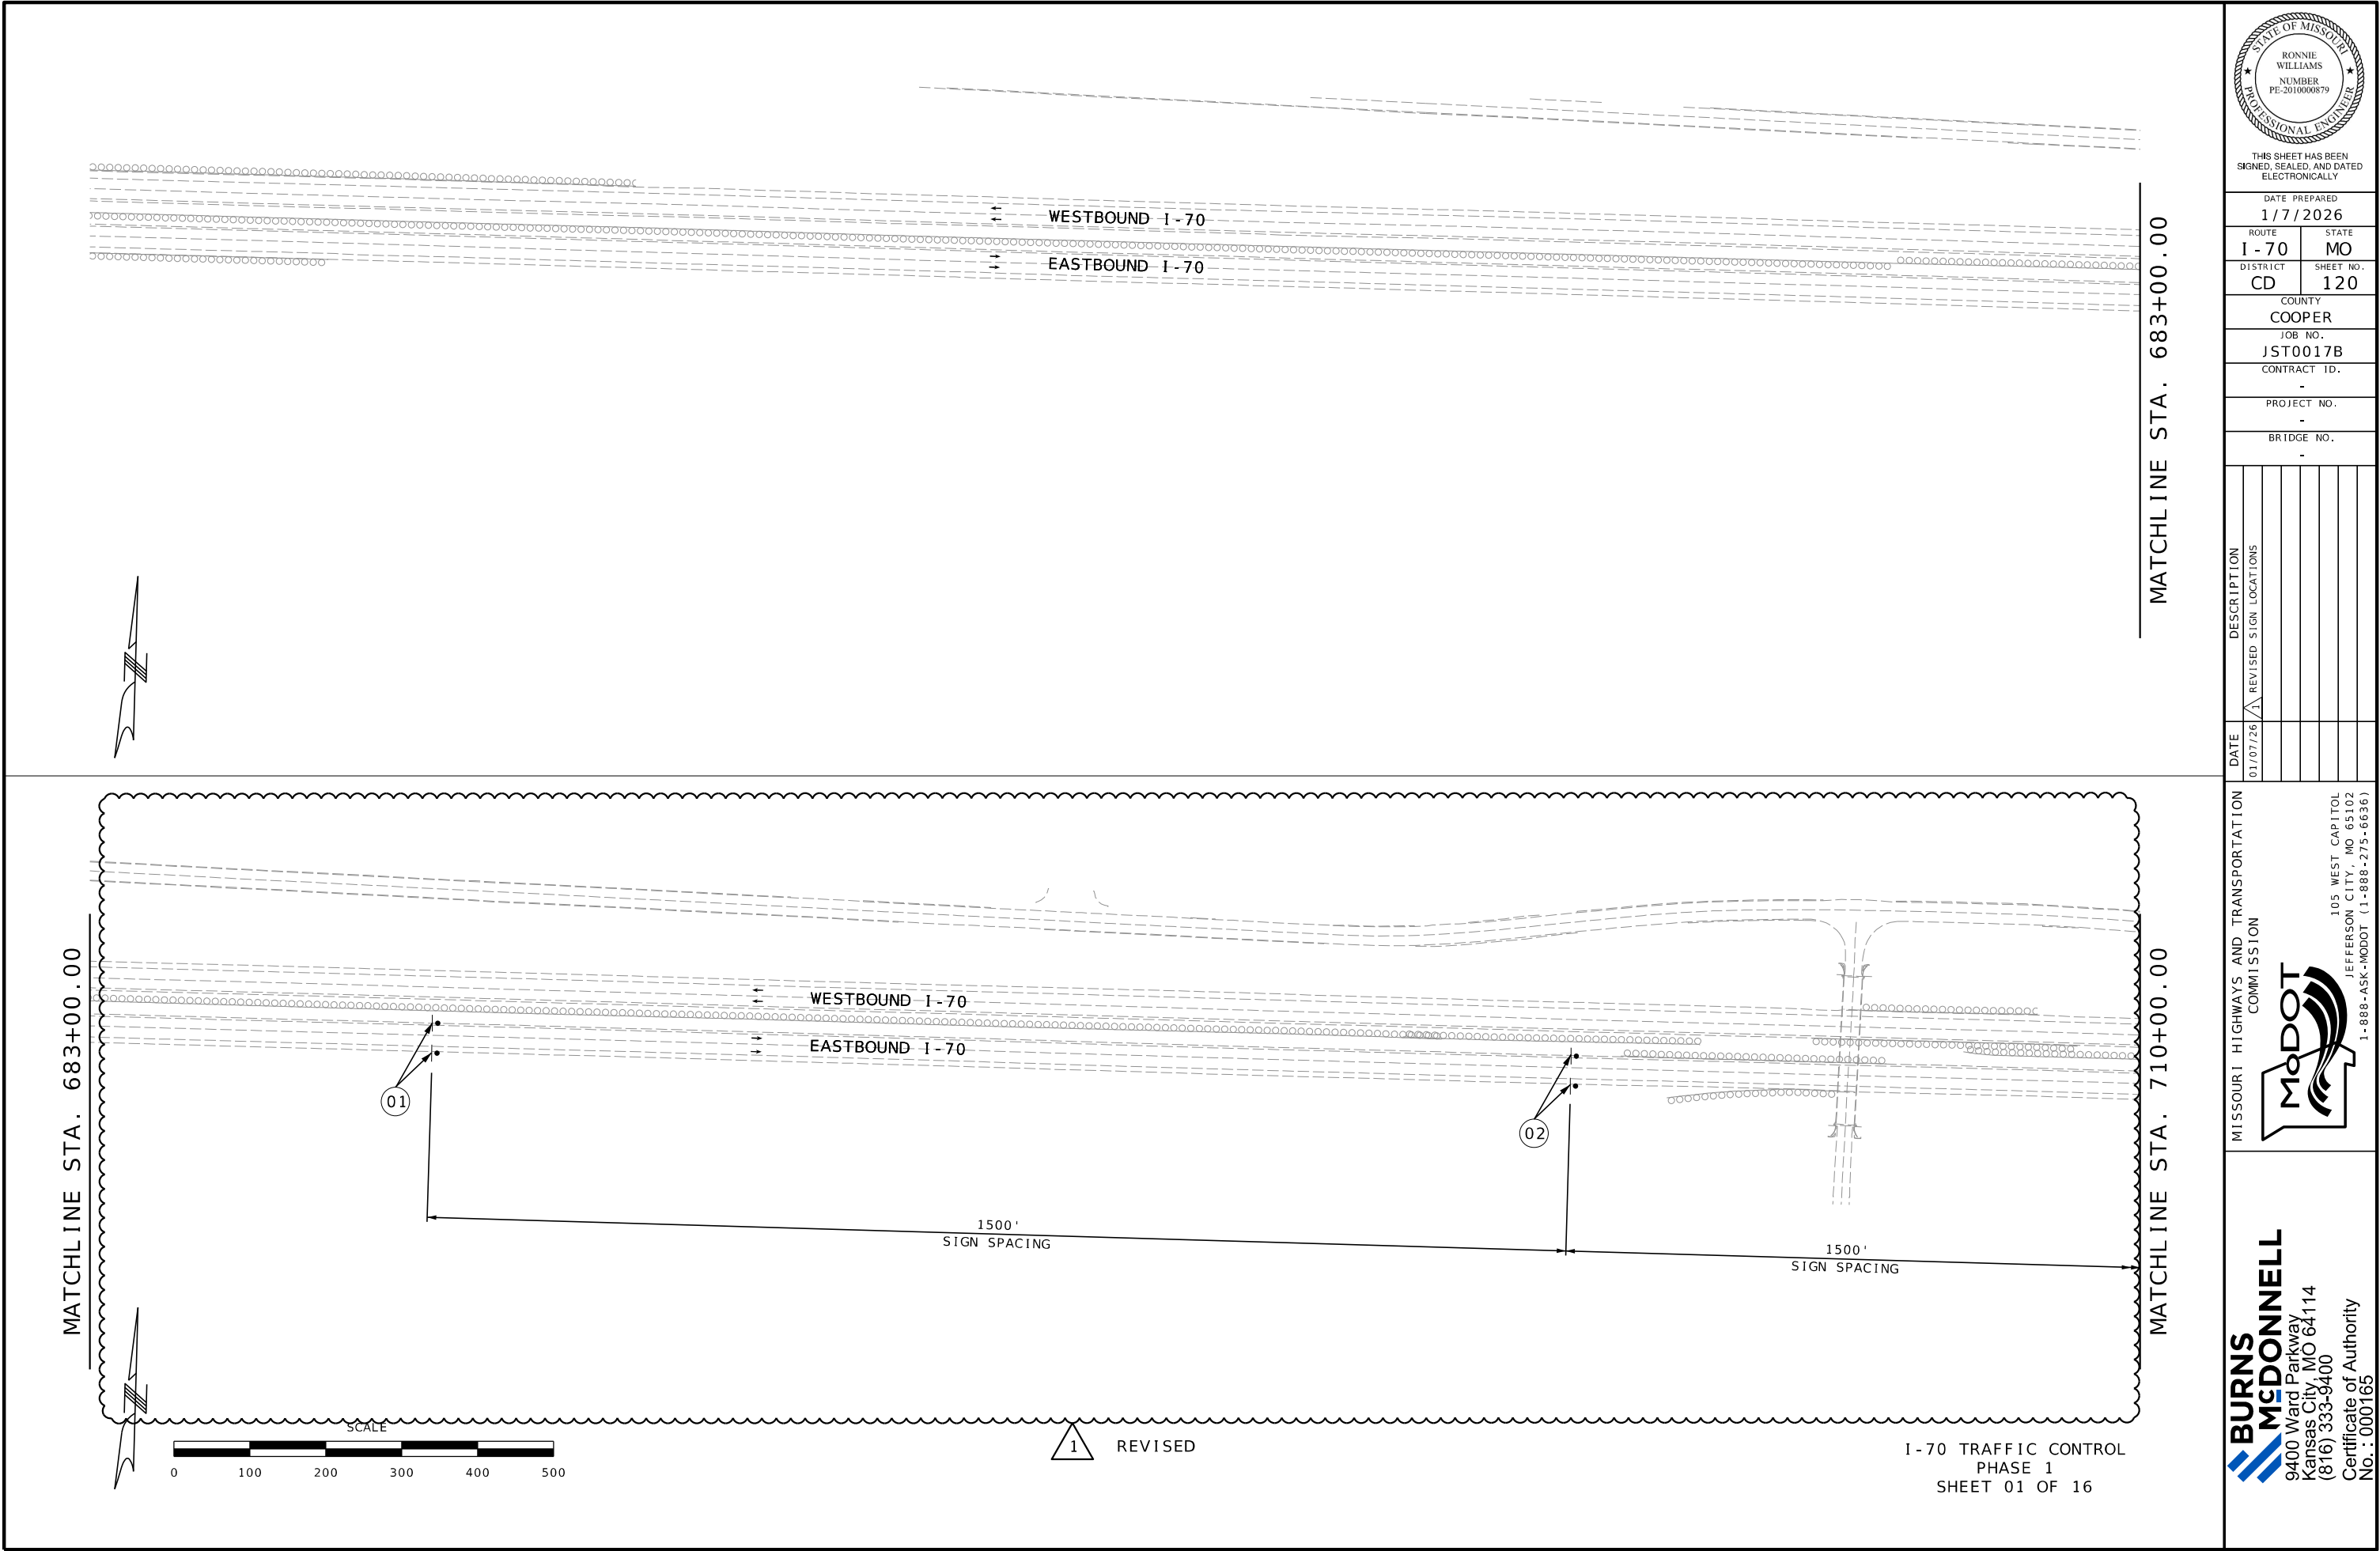

THIS SHEET HAS BEEN
SIGNED, SEALED, AND DATED
ELECTRONICALLY

DATE PREPARED
1/7/2026

ROUTE
I-70

STATE
MO

DISTRICT
CD

SHEET NO.
120

COUNTY
COOPER

JOB NO.
JST0017B

CONTRACT ID.
-

PROJECT NO.
-

BRIDGE NO.
-

DATE	DESCRIPTION
01/07/26	REVISED SIGN LOCATIONS


MISSOURI HIGHWAYS AND TRANSPORTATION
COMMISSION

MoDOT

105 WEST CAPITOL
JEFFERSON CITY, MO 65102
1-888-ASK-MODOT (1-888-273-6636)

**BURNS
MCDONNELL**

9400 Ward Parkway
Kansas City, MO 64114
(816) 333-9400
Certificate of Authority
No. : 000165

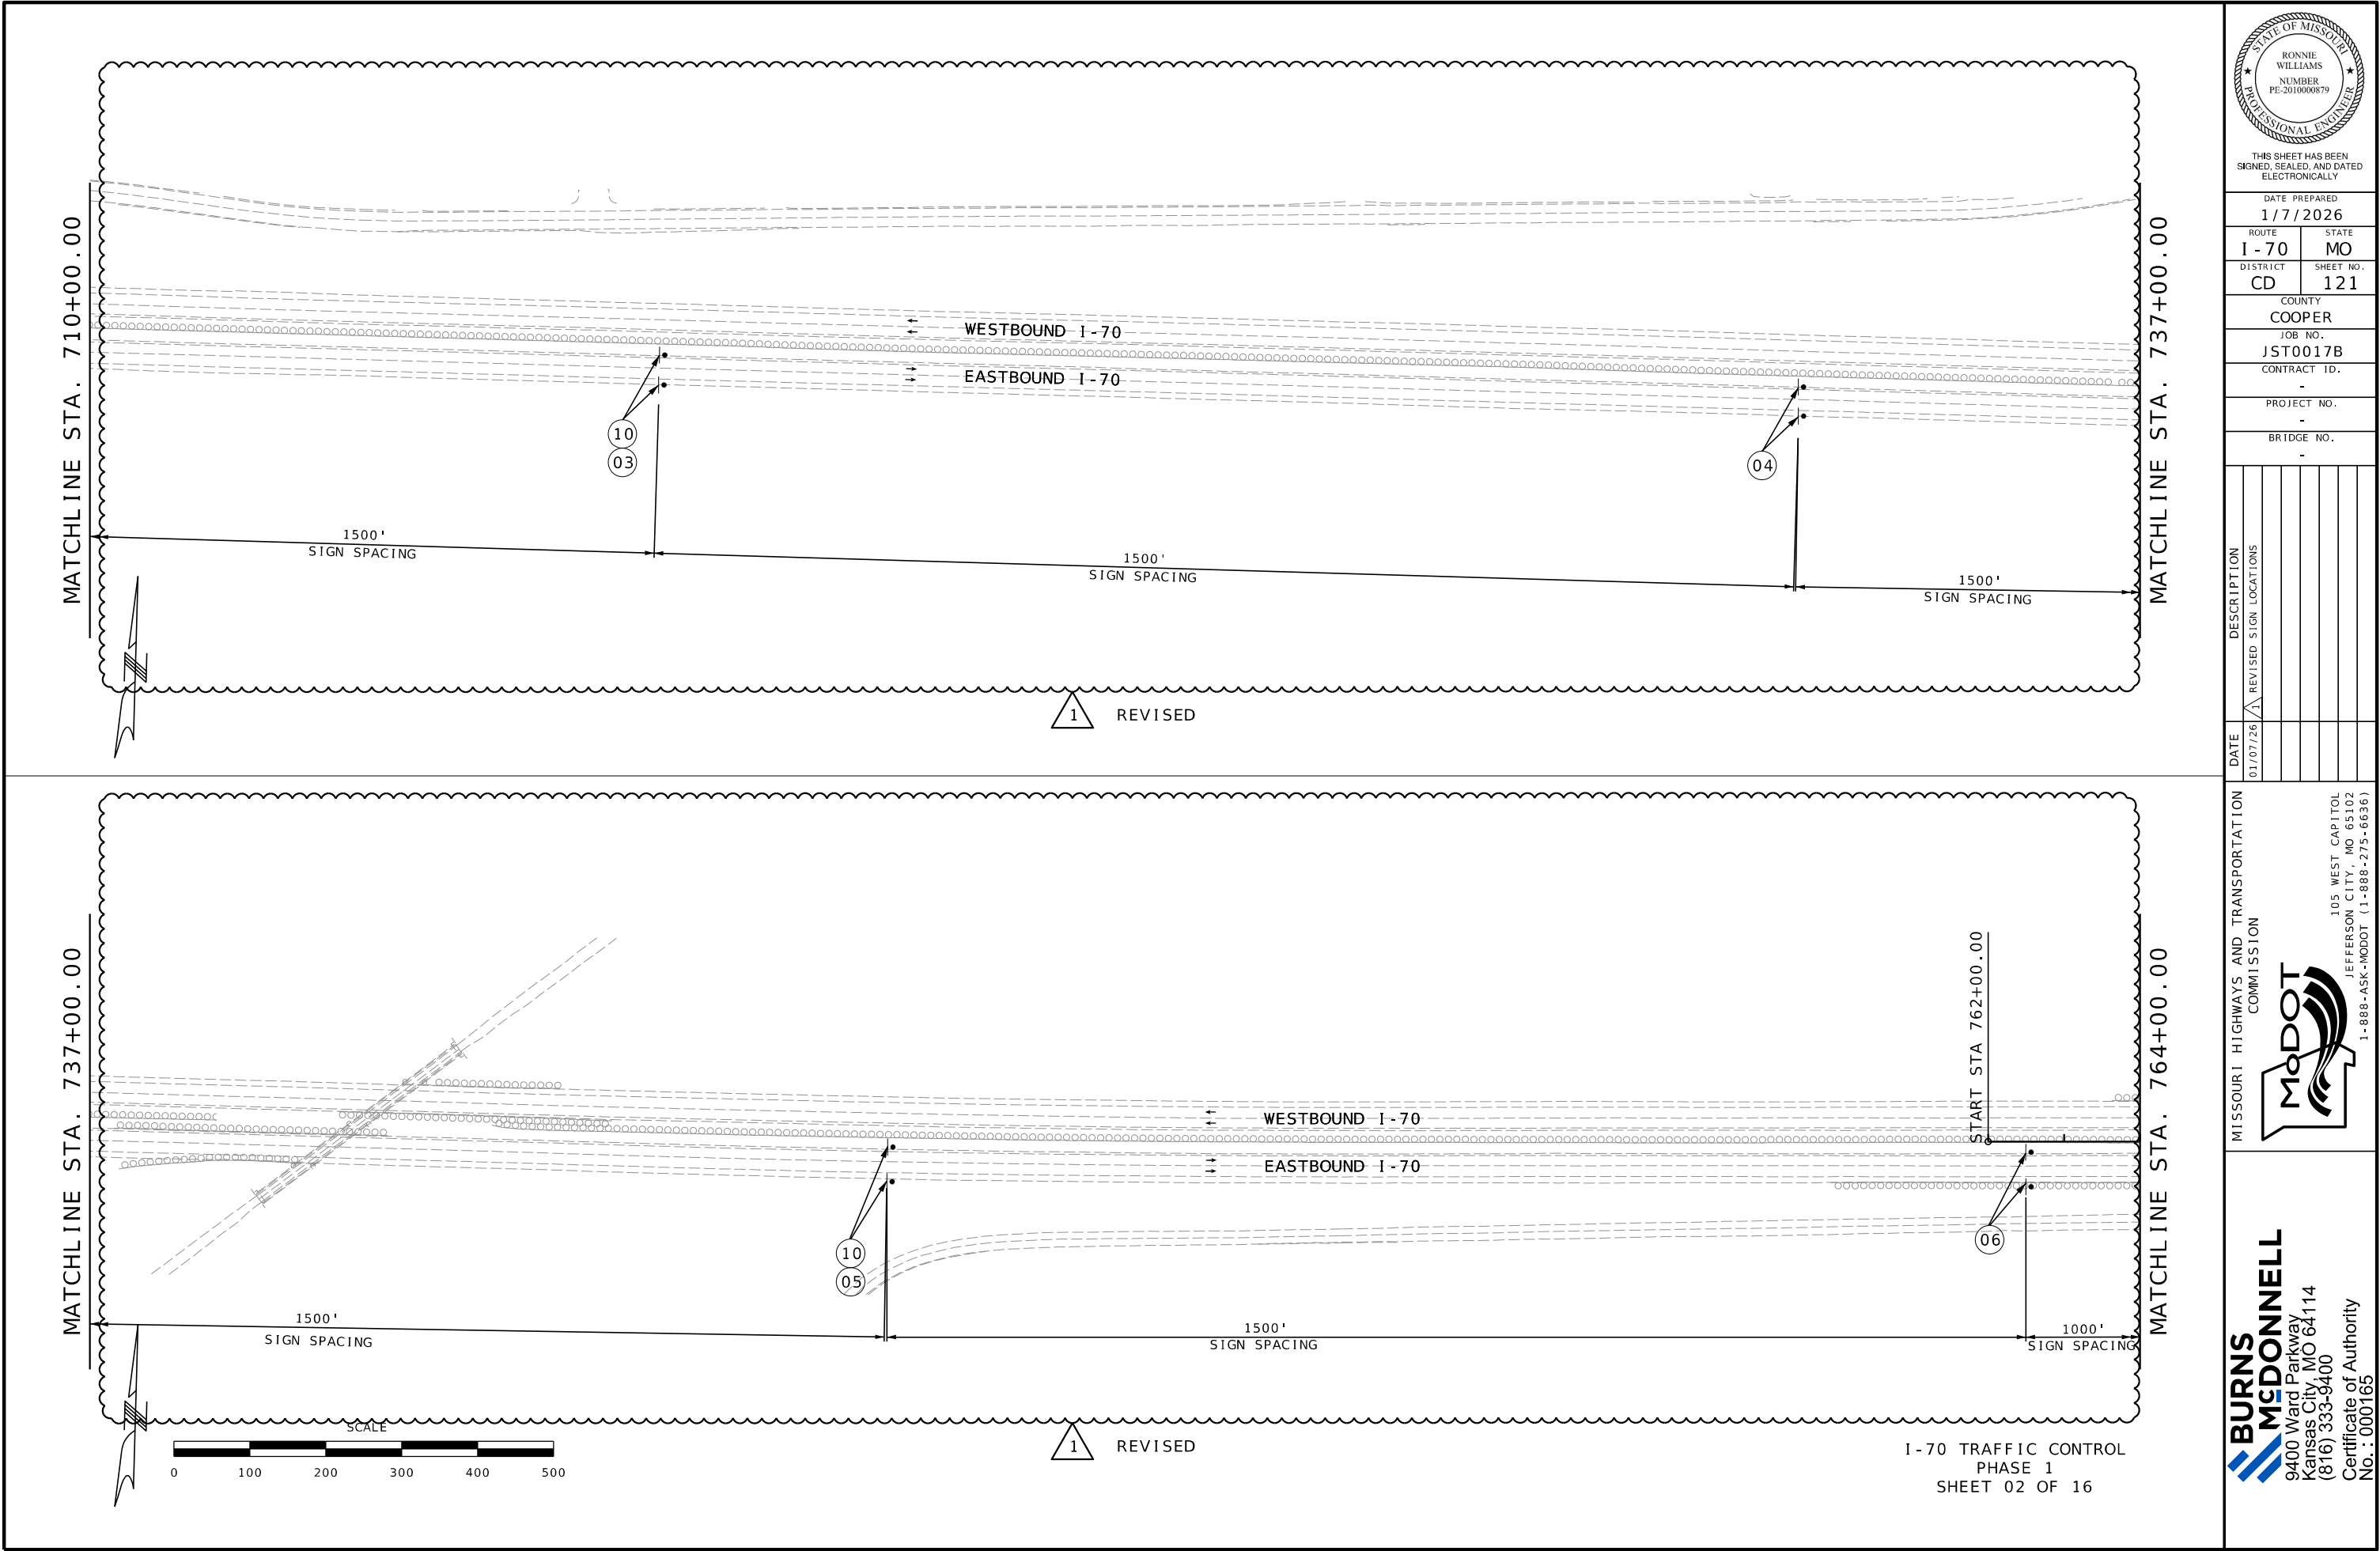

THIS SHEET HAS BEEN
SIGNED, SEALED, AND DATED
ELECTRONICALLY

DATE PREPARED
1/7/2026

ROUTE I - 70	STATE MO
DISTRICT CD	SHEET NO. 121

COUNTY
COOPER

JOB NO.
JST0017B

CONTRACT ID.
-

PROJECT NO.
-

BRIDGE NO.
-

DATE	DESCRIPTION
01/07/26	REVISED SIGN LOCATIONS


MISSOURI HIGHWAYS AND TRANSPORTATION
COMMISSION



105 WEST CAPITOL
JEFFERSON CITY, MO 65102
1-888-ASK-MODOT (1-888-275-6636)

**BURNS
MCDONNELL**

9400 Ward Parkway
Kansas City, MO 64114
(816) 333-9400
Certificate of Authority
No. : 000165

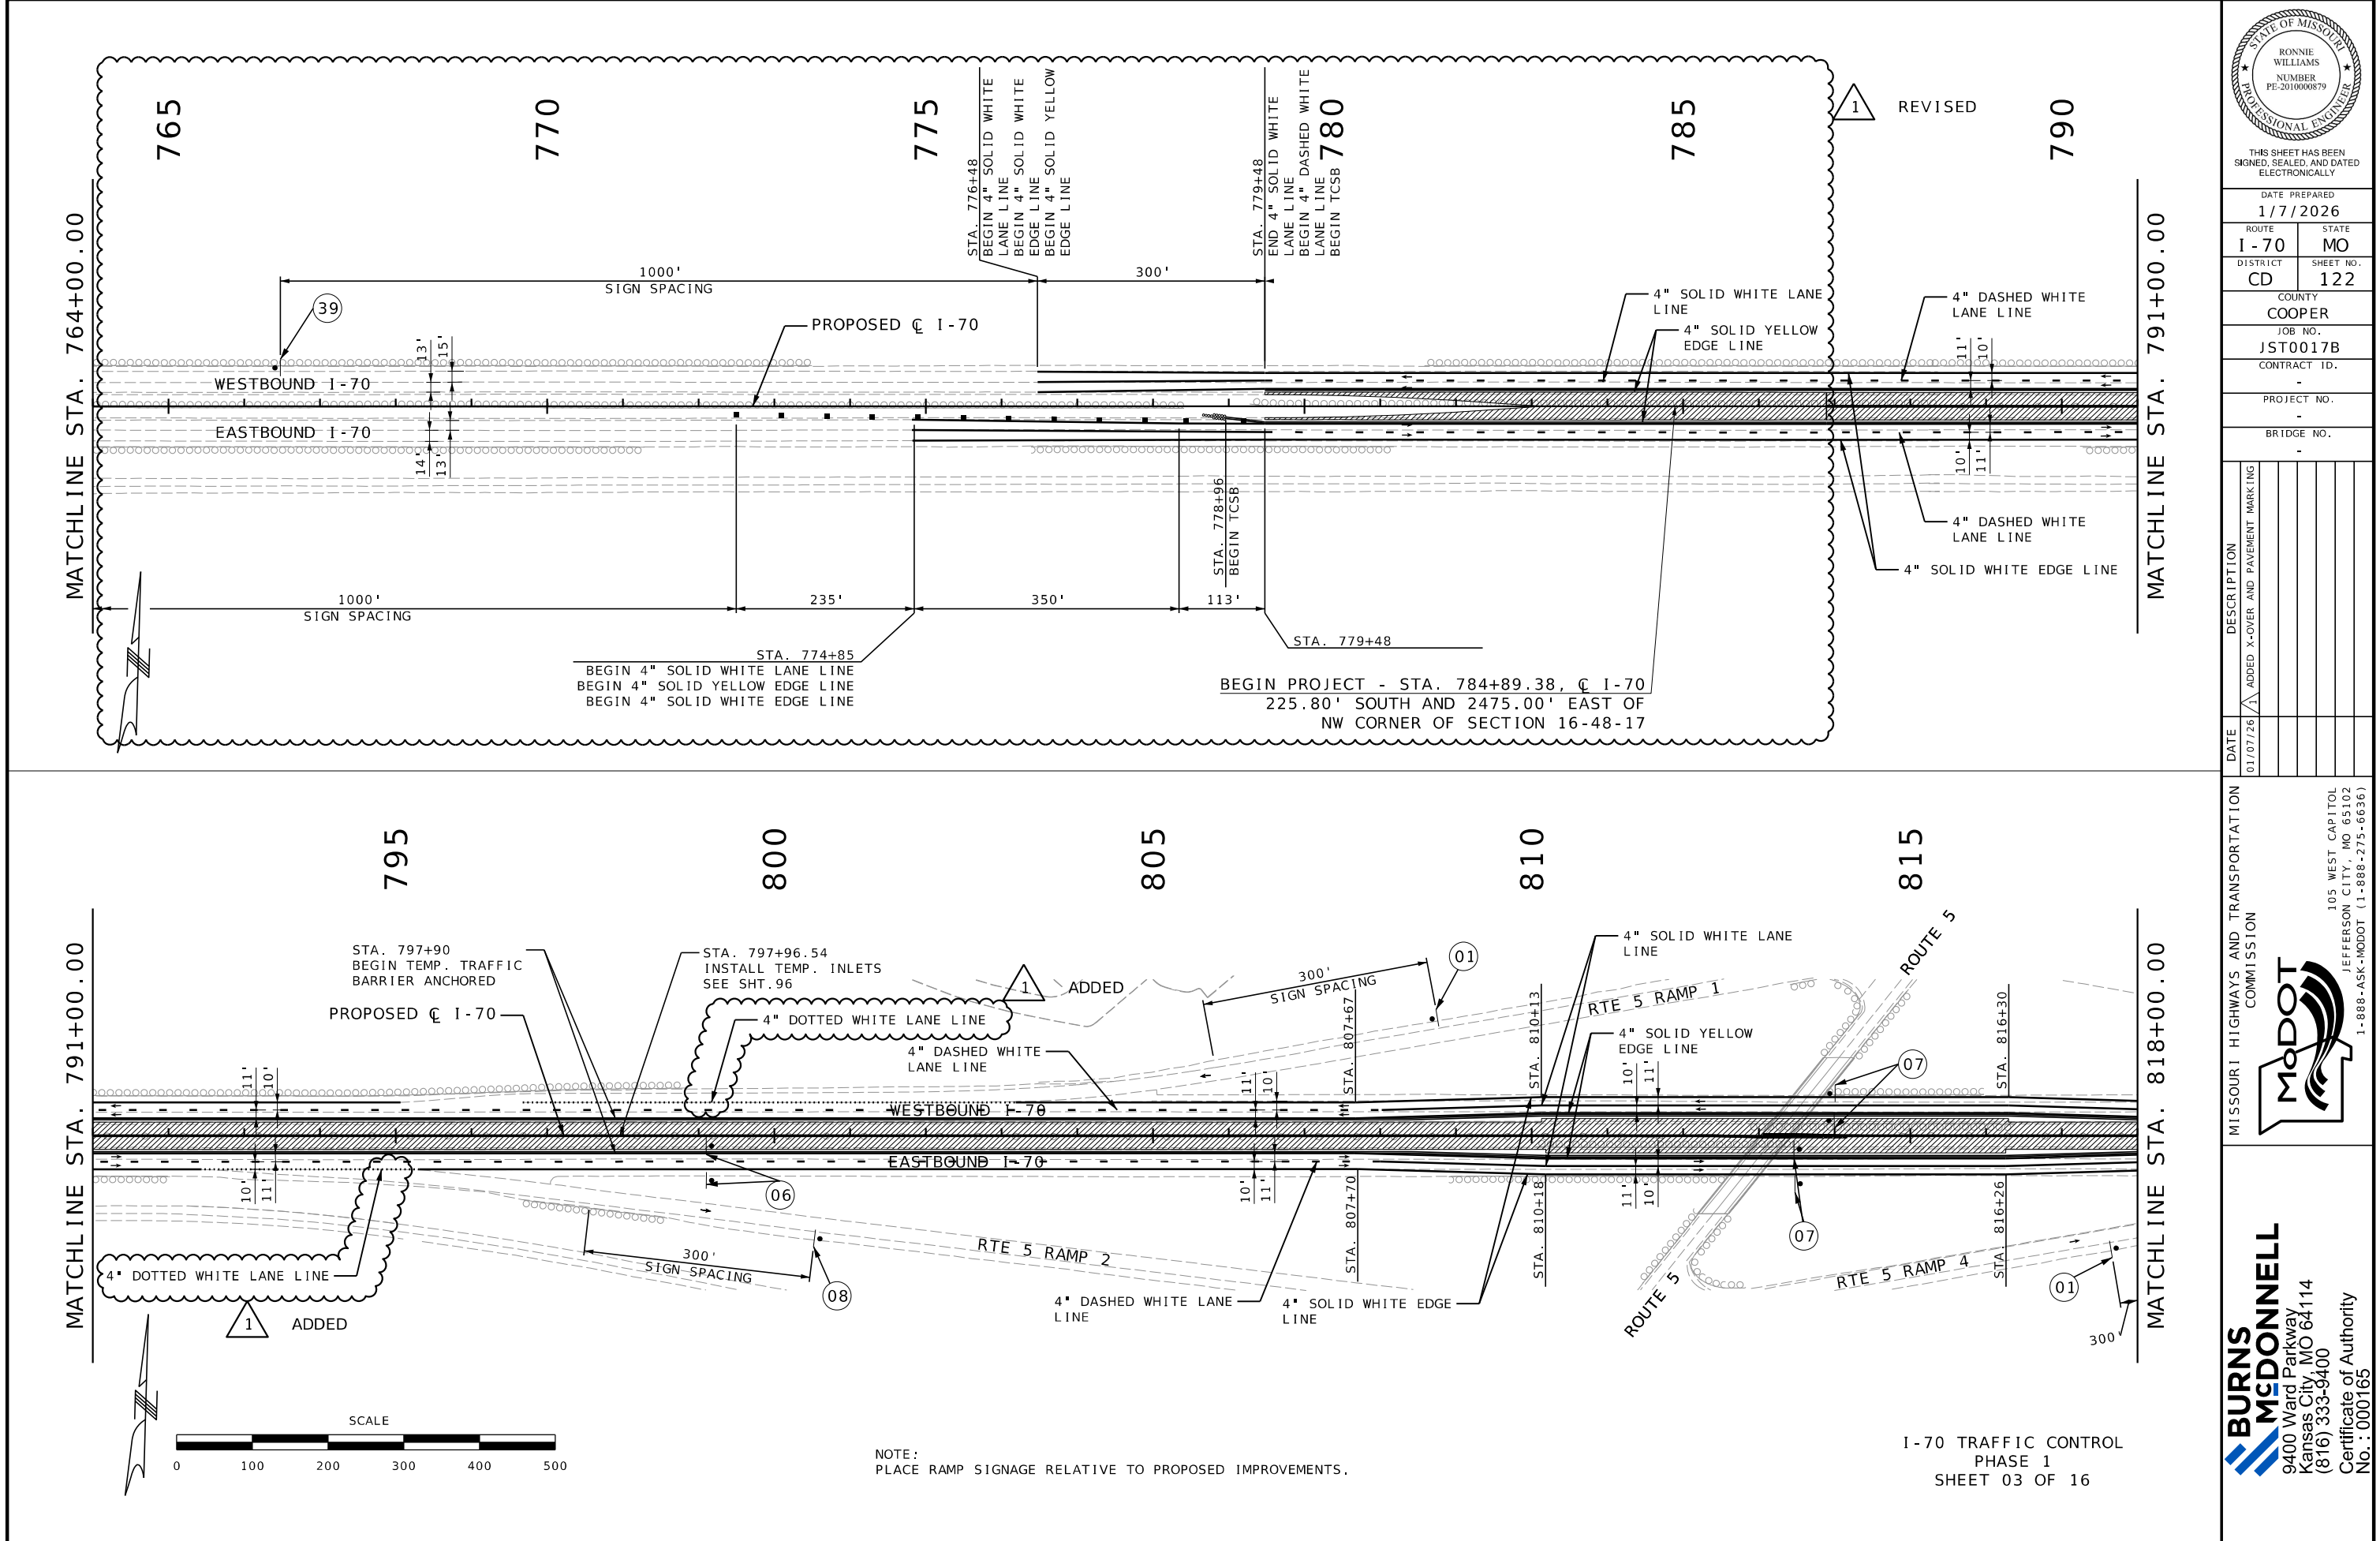

THIS SHEET HAS BEEN
SIGNED, SEALED, AND DATED
ELECTRONICALLY

DATE PREPARED
1/7/2026

ROUTE I-70 STATE MO

DISTRICT CD SHEET NO. 122

COUNTY COOPER

JOB NO. JST0017B

CONTRACT ID.

PROJECT NO.

BRIDGE NO.

DATE	DESCRIPTION
01/07/26	ADDED X-OVER AND PAVEMENT MARKING

MISSOURI HIGHWAYS AND TRANSPORTATION
COMMISSION





105 WEST CAPITOL
JEFFERSON CITY, MO 65102
1-888-ASK-MODOT (1-888-275-6636)



9400 Ward Parkway
Kansas City, MO 64114
(816) 333-9400
Certificate of Authority
No. : 000165

I-70 TRAFFIC CONTROL
PHASE 1
SHEET 03 OF 16

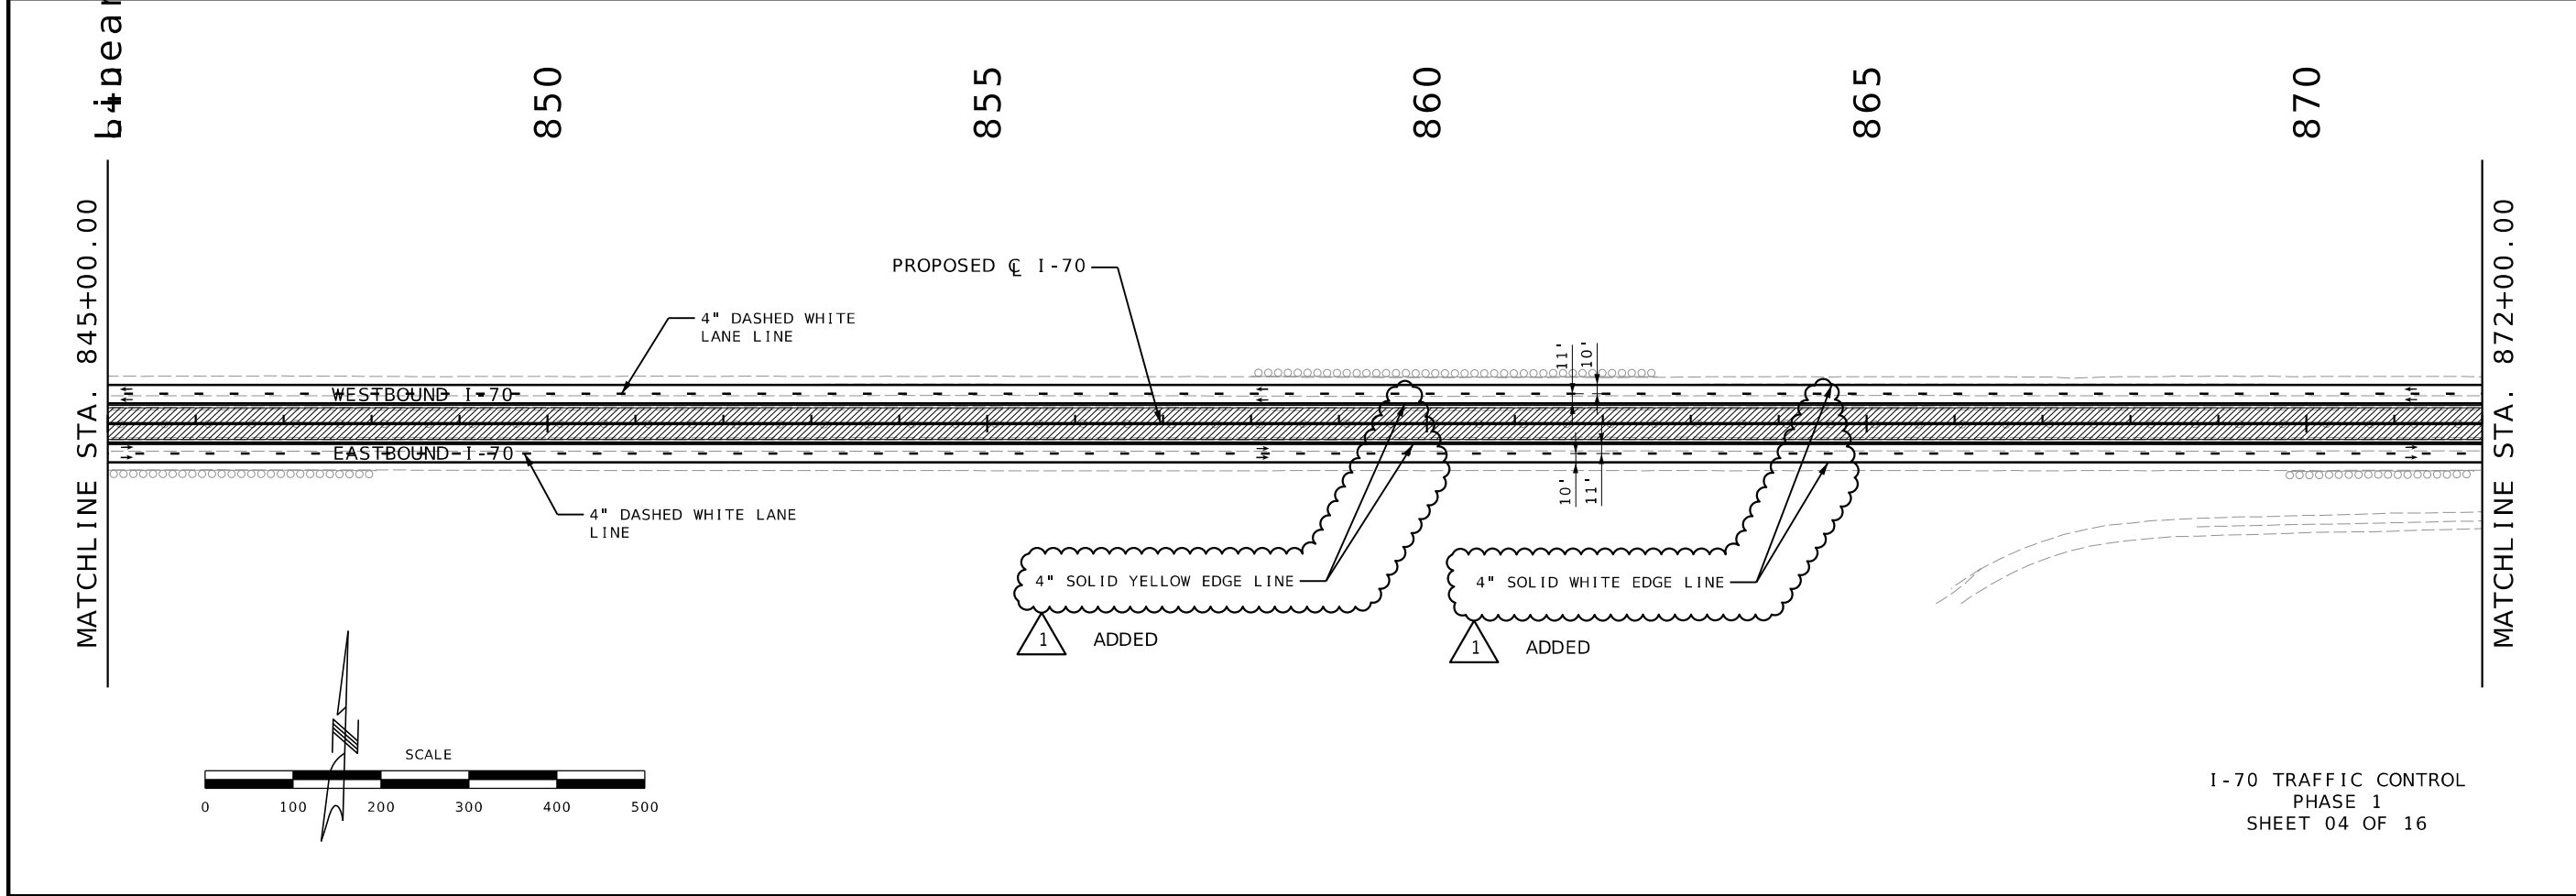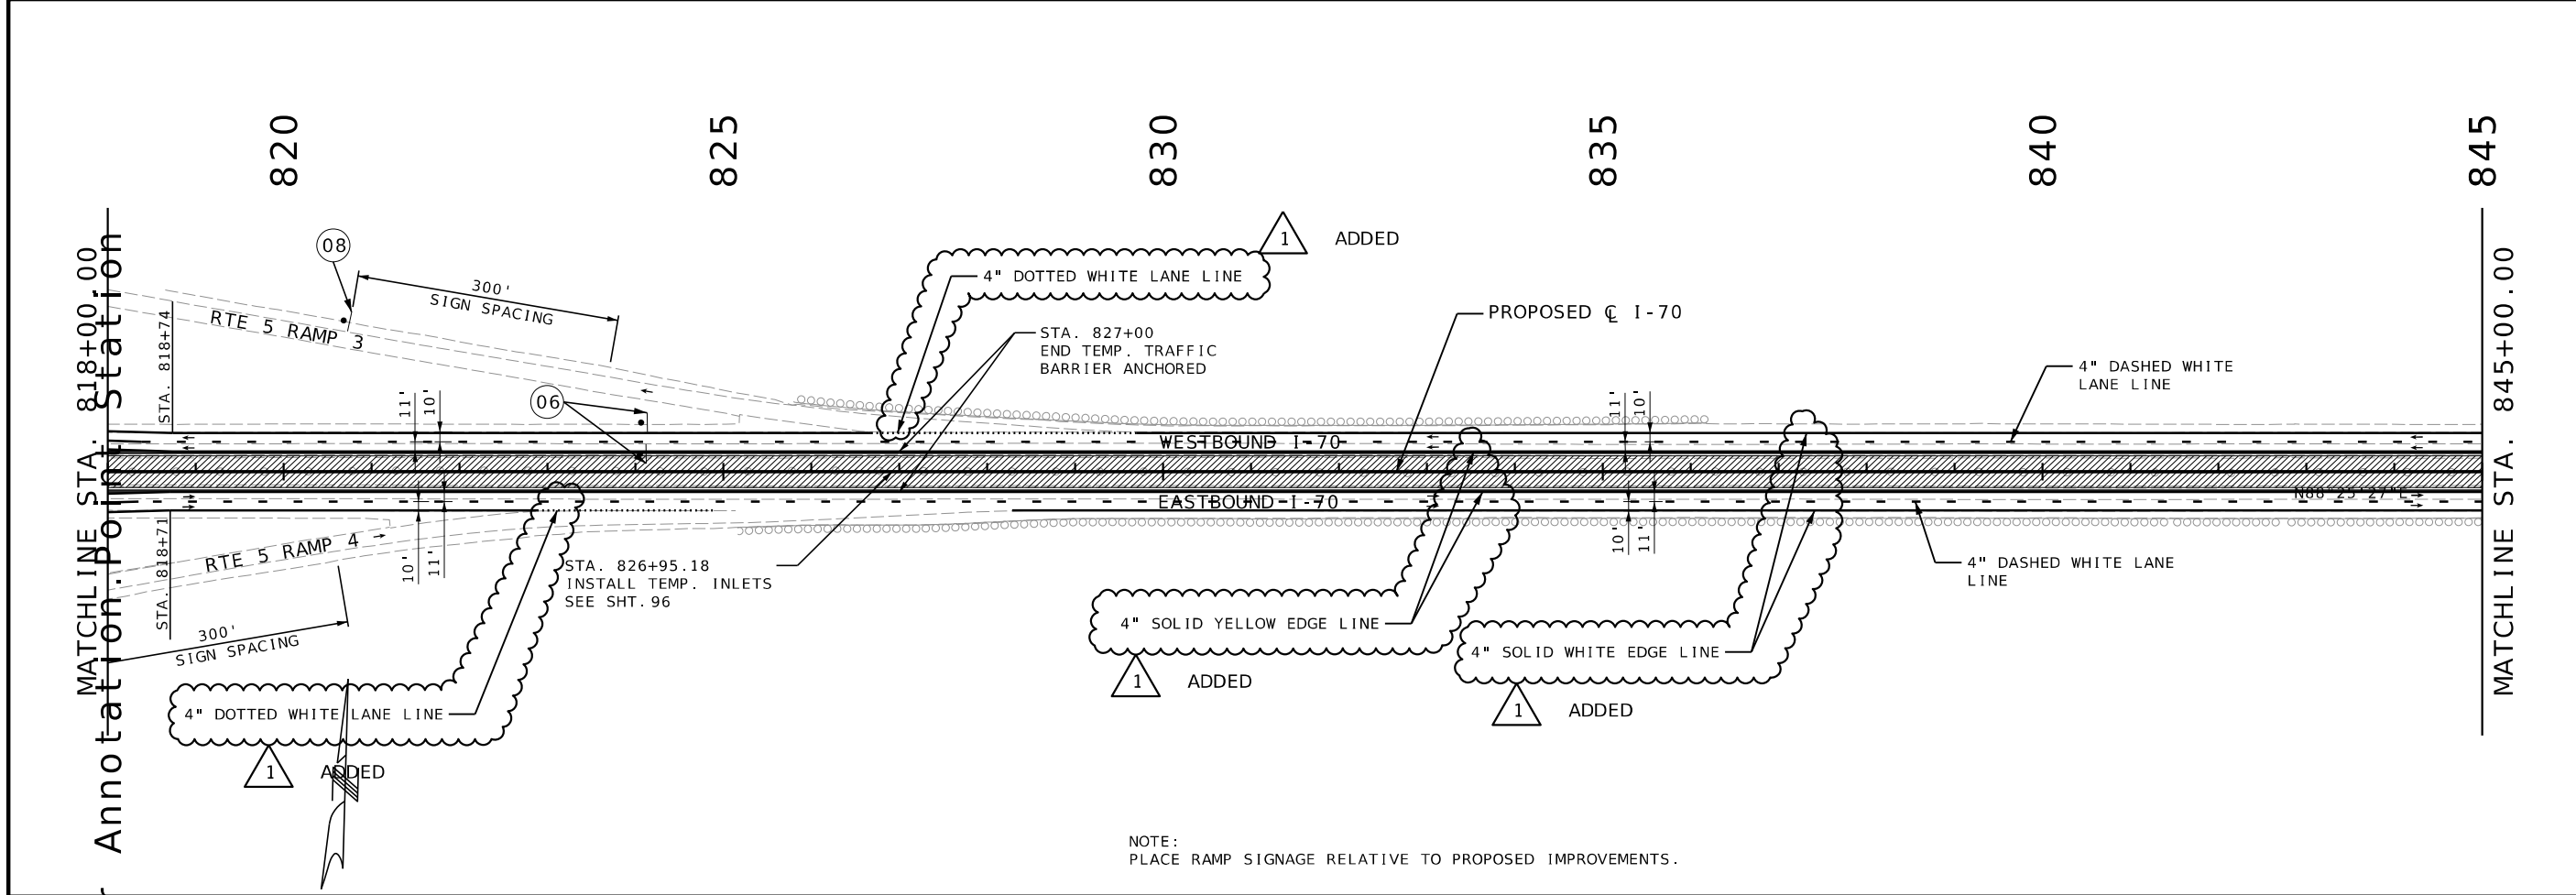

STATE OF MISSOURI

RONNIE WILLIAMS

NUMBER PE-2010000879

PROFESSIONAL ENGINEER

THIS SHEET HAS BEEN SIGNED, SEALED, AND DATED ELECTRONICALLY

DATE PREPARED 1/7/2026

ROUTE 1-70

DISTRICT CD

STATE MO

SHEET NO. 123

COUNTY COOPER

JOB NO. JST0017B

CONTRACT ID. -

PROJECT NO. -

BRIDGE NO. -

DATE	DESCRIPTION
01/07/26	ADDED PAVEMENT MARKING

MISSOURI HIGHWAYS AND TRANSPORTATION COMMISSION

MoDOT



105 WEST CAPITOL JEFFERSON CITY, MO 65102 1-888-ASK-MODOT (1-888-275-6636)

BURNS MCDONNELL

9400 Ward Parkway Kansas City, MO 64114 (816) 333-9400

Certificate of Authority No. : 000165

c:\bmcd_lib\pw_connect\trn\d0185116\123_MOT_Phase 1_JST0017B_I100_I-70.dgn 11:44:50 AM 1/7/2026

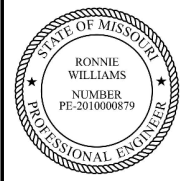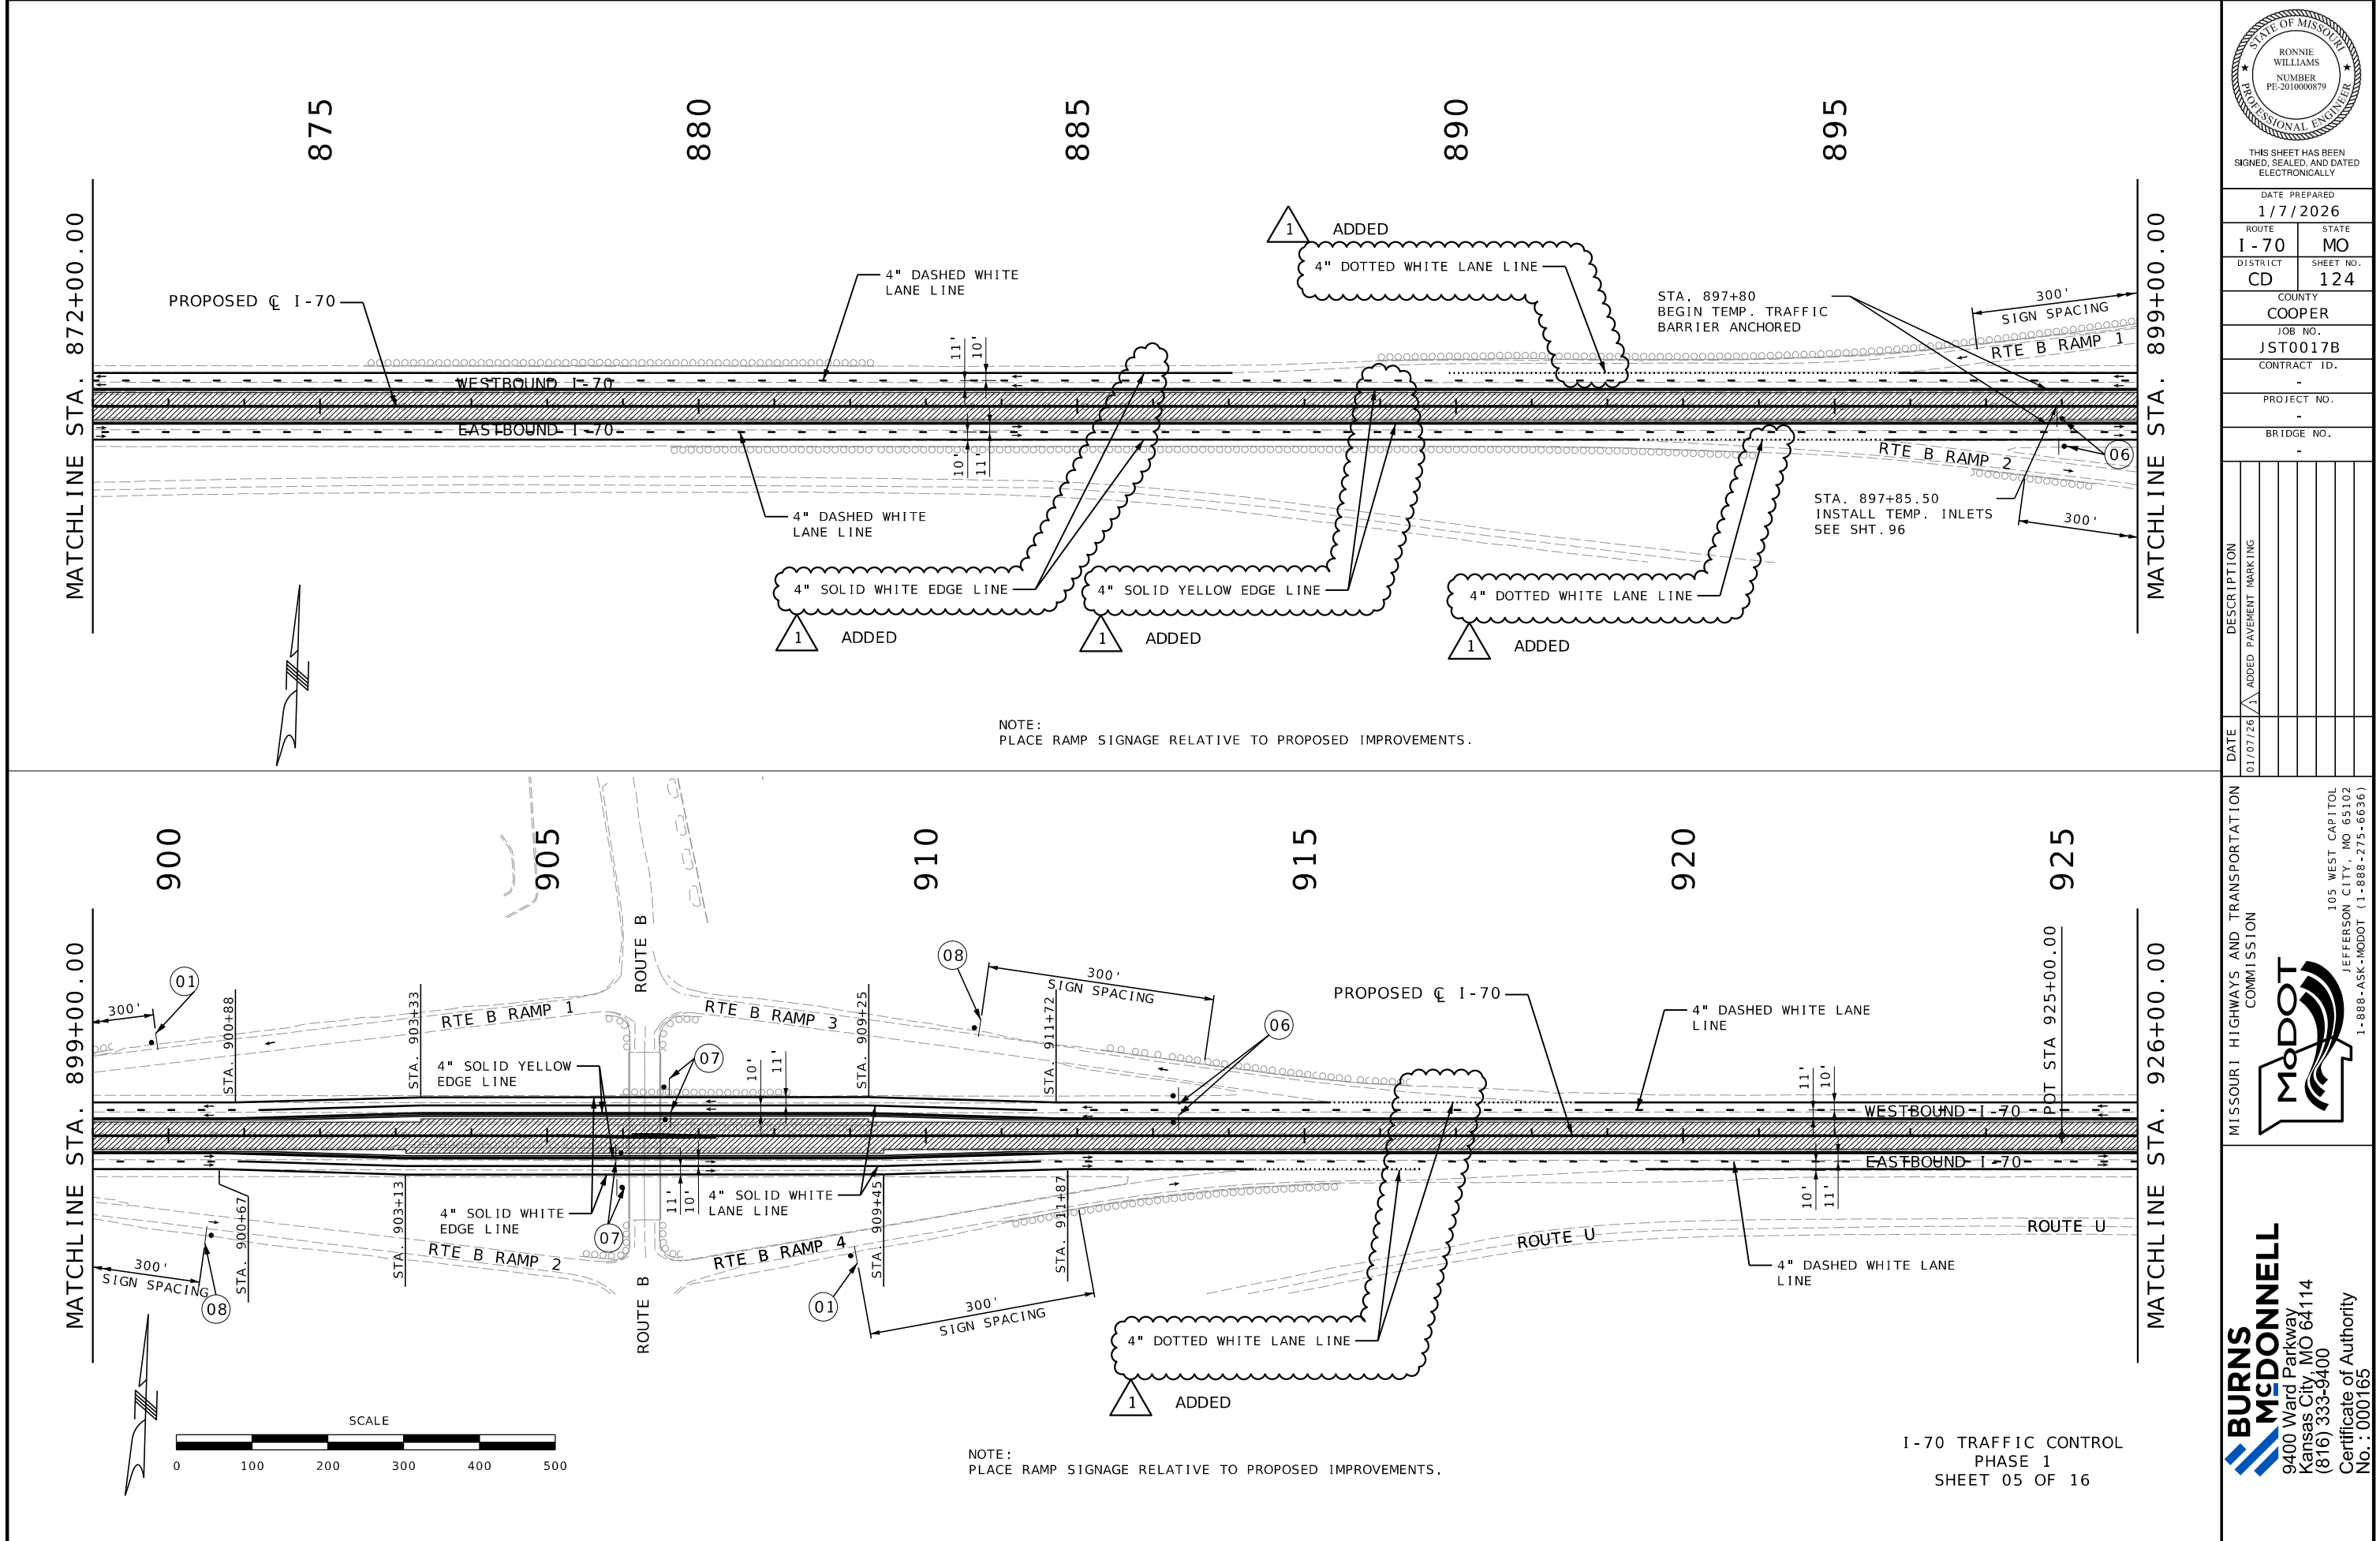

THIS SHEET HAS BEEN
SIGNED, SEALED, AND DATED
ELECTRONICALLY

DATE PREPARED
1/7/2026

ROUTE	STATE
I-70	MO
DISTRICT	SHEET NO.
CD	124

COUNTY
COOPER

JOB NO.
JST0017B

CONTRACT ID.
-

PROJECT NO.
-

BRIDGE NO.
-


DATE	DESCRIPTION
01/07/26	ADDED PAVEMENT MARKING


MISSOURI HIGHWAYS AND TRANSPORTATION
COMMISSION


105 WEST CAPITOL
JEFFERSON CITY, MO 65102
1-888-ASK-MODOT (1-888-275-6636)

**BURNS
MCDONNELL**

9400 Ward Parkway
Kansas City, MO 64114
(816) 333-9400
Certificate of Authority
No. : 000165

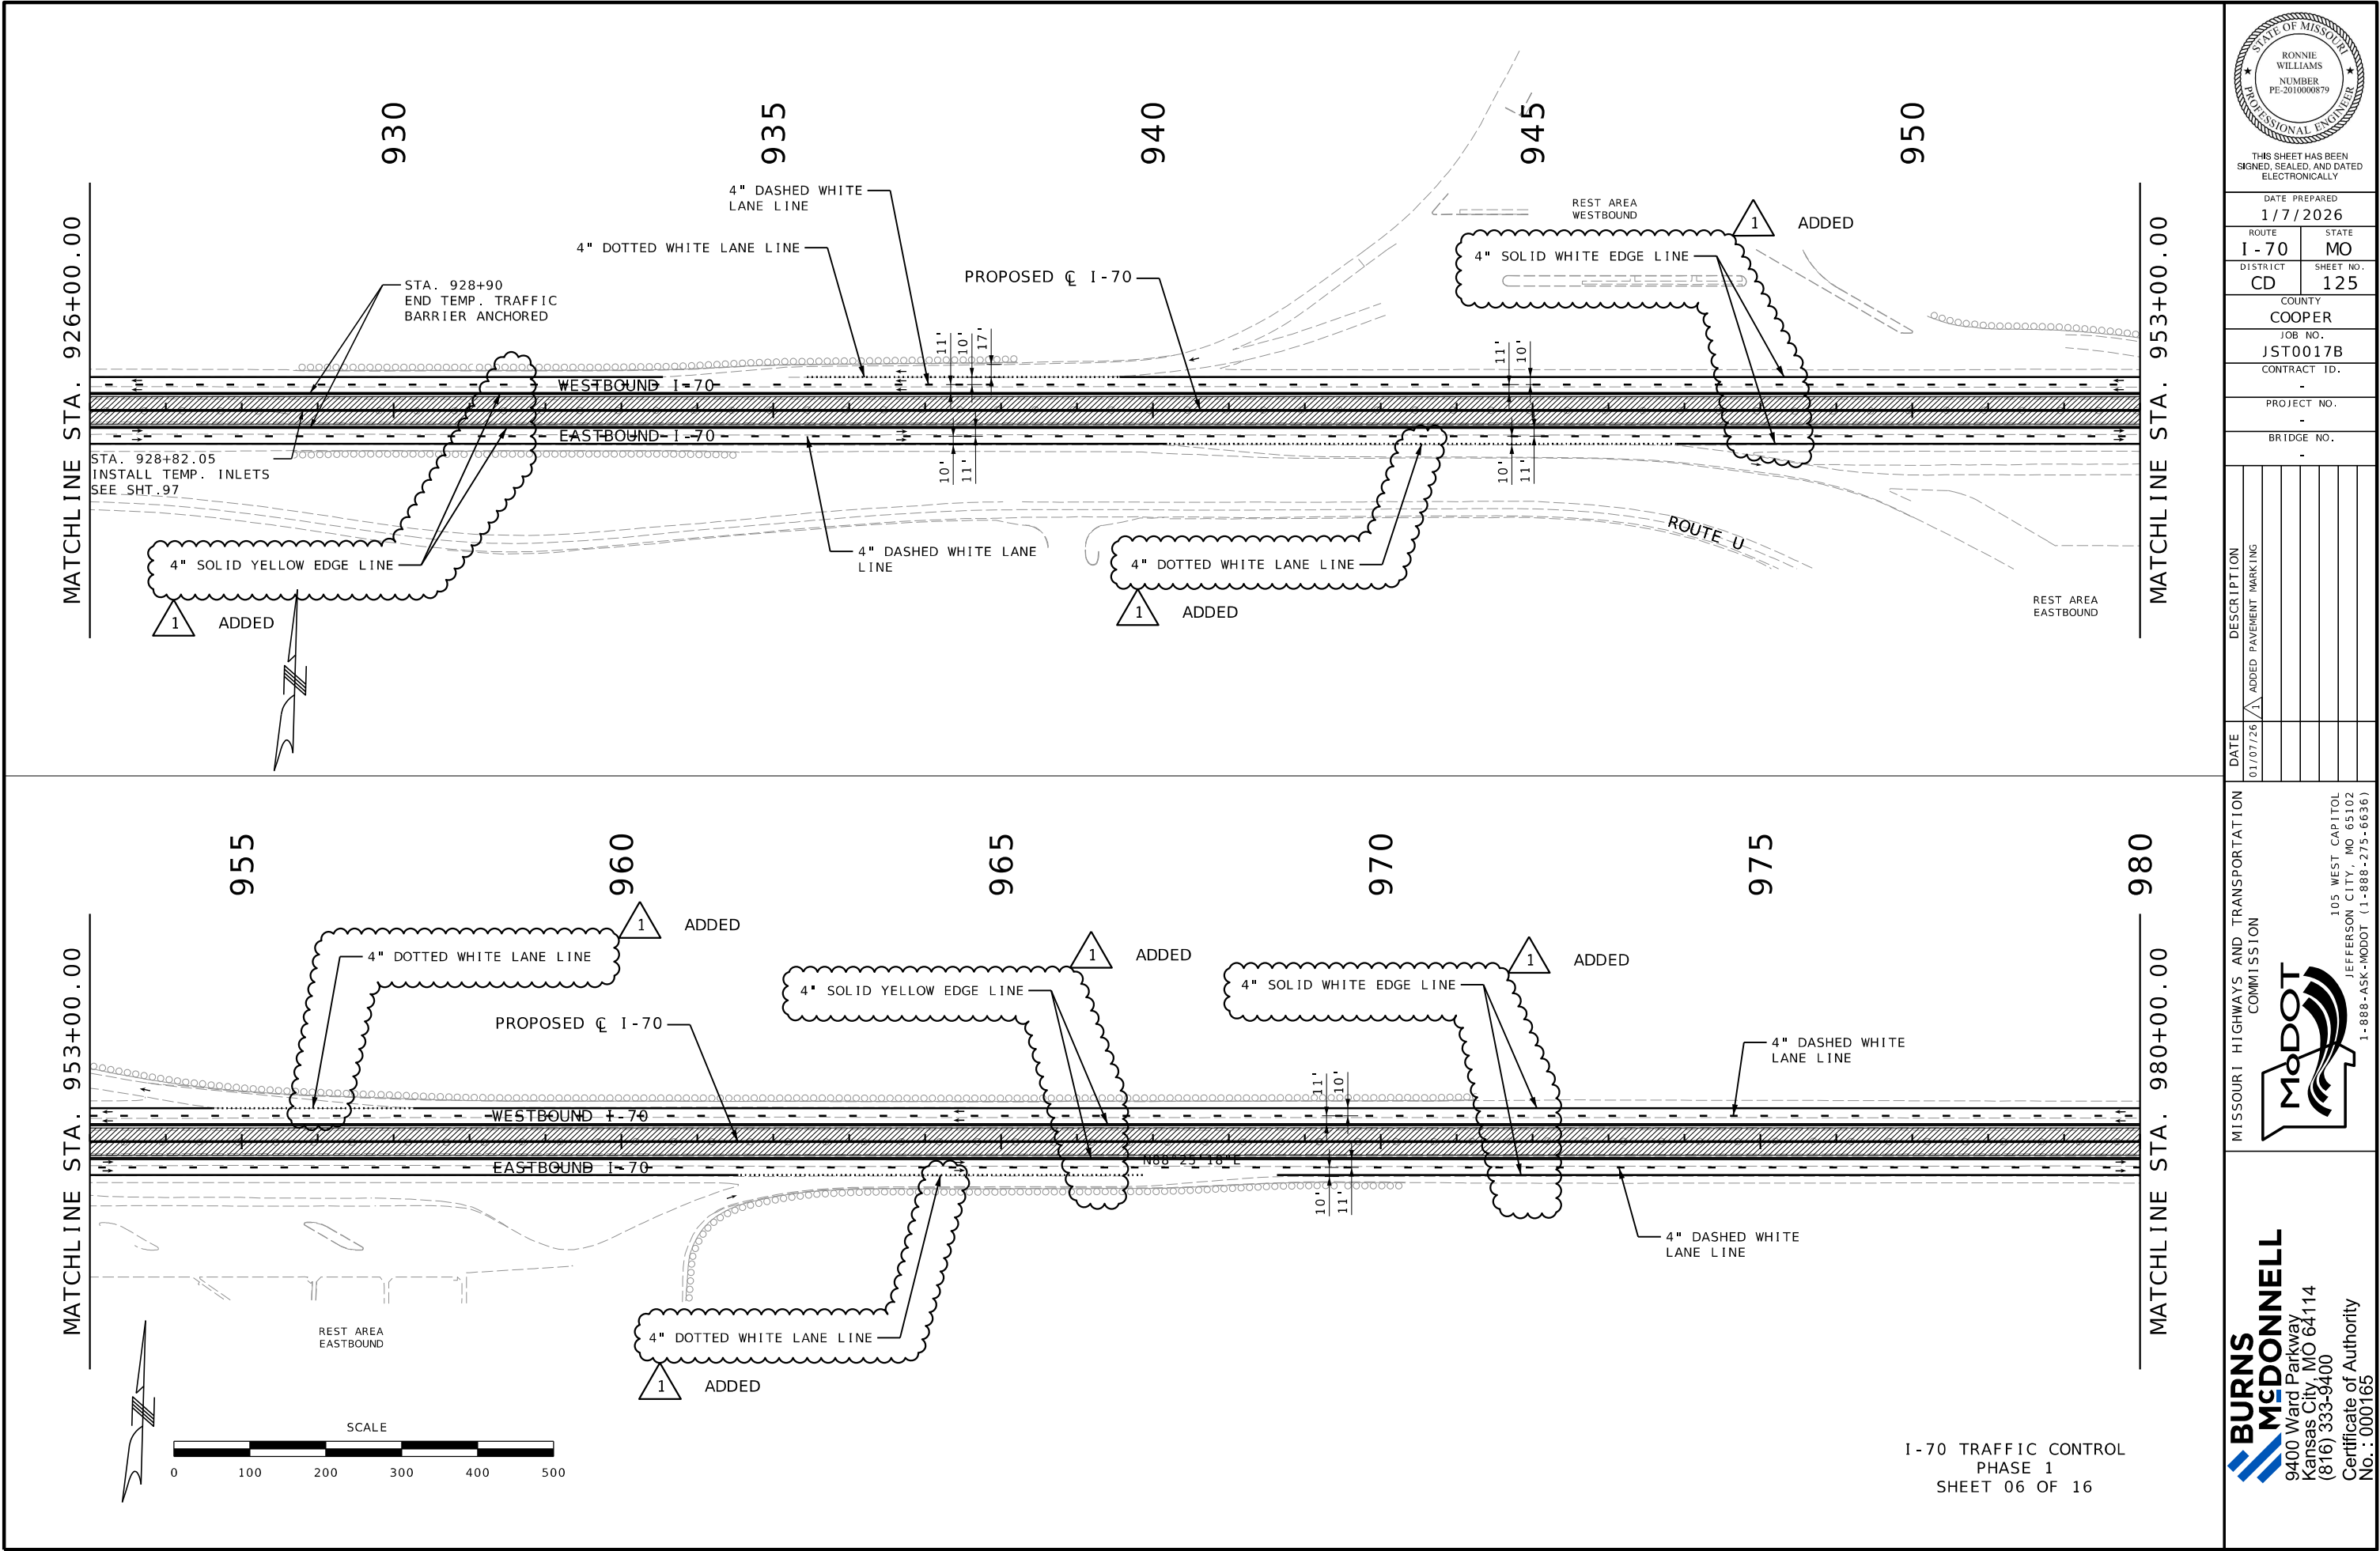

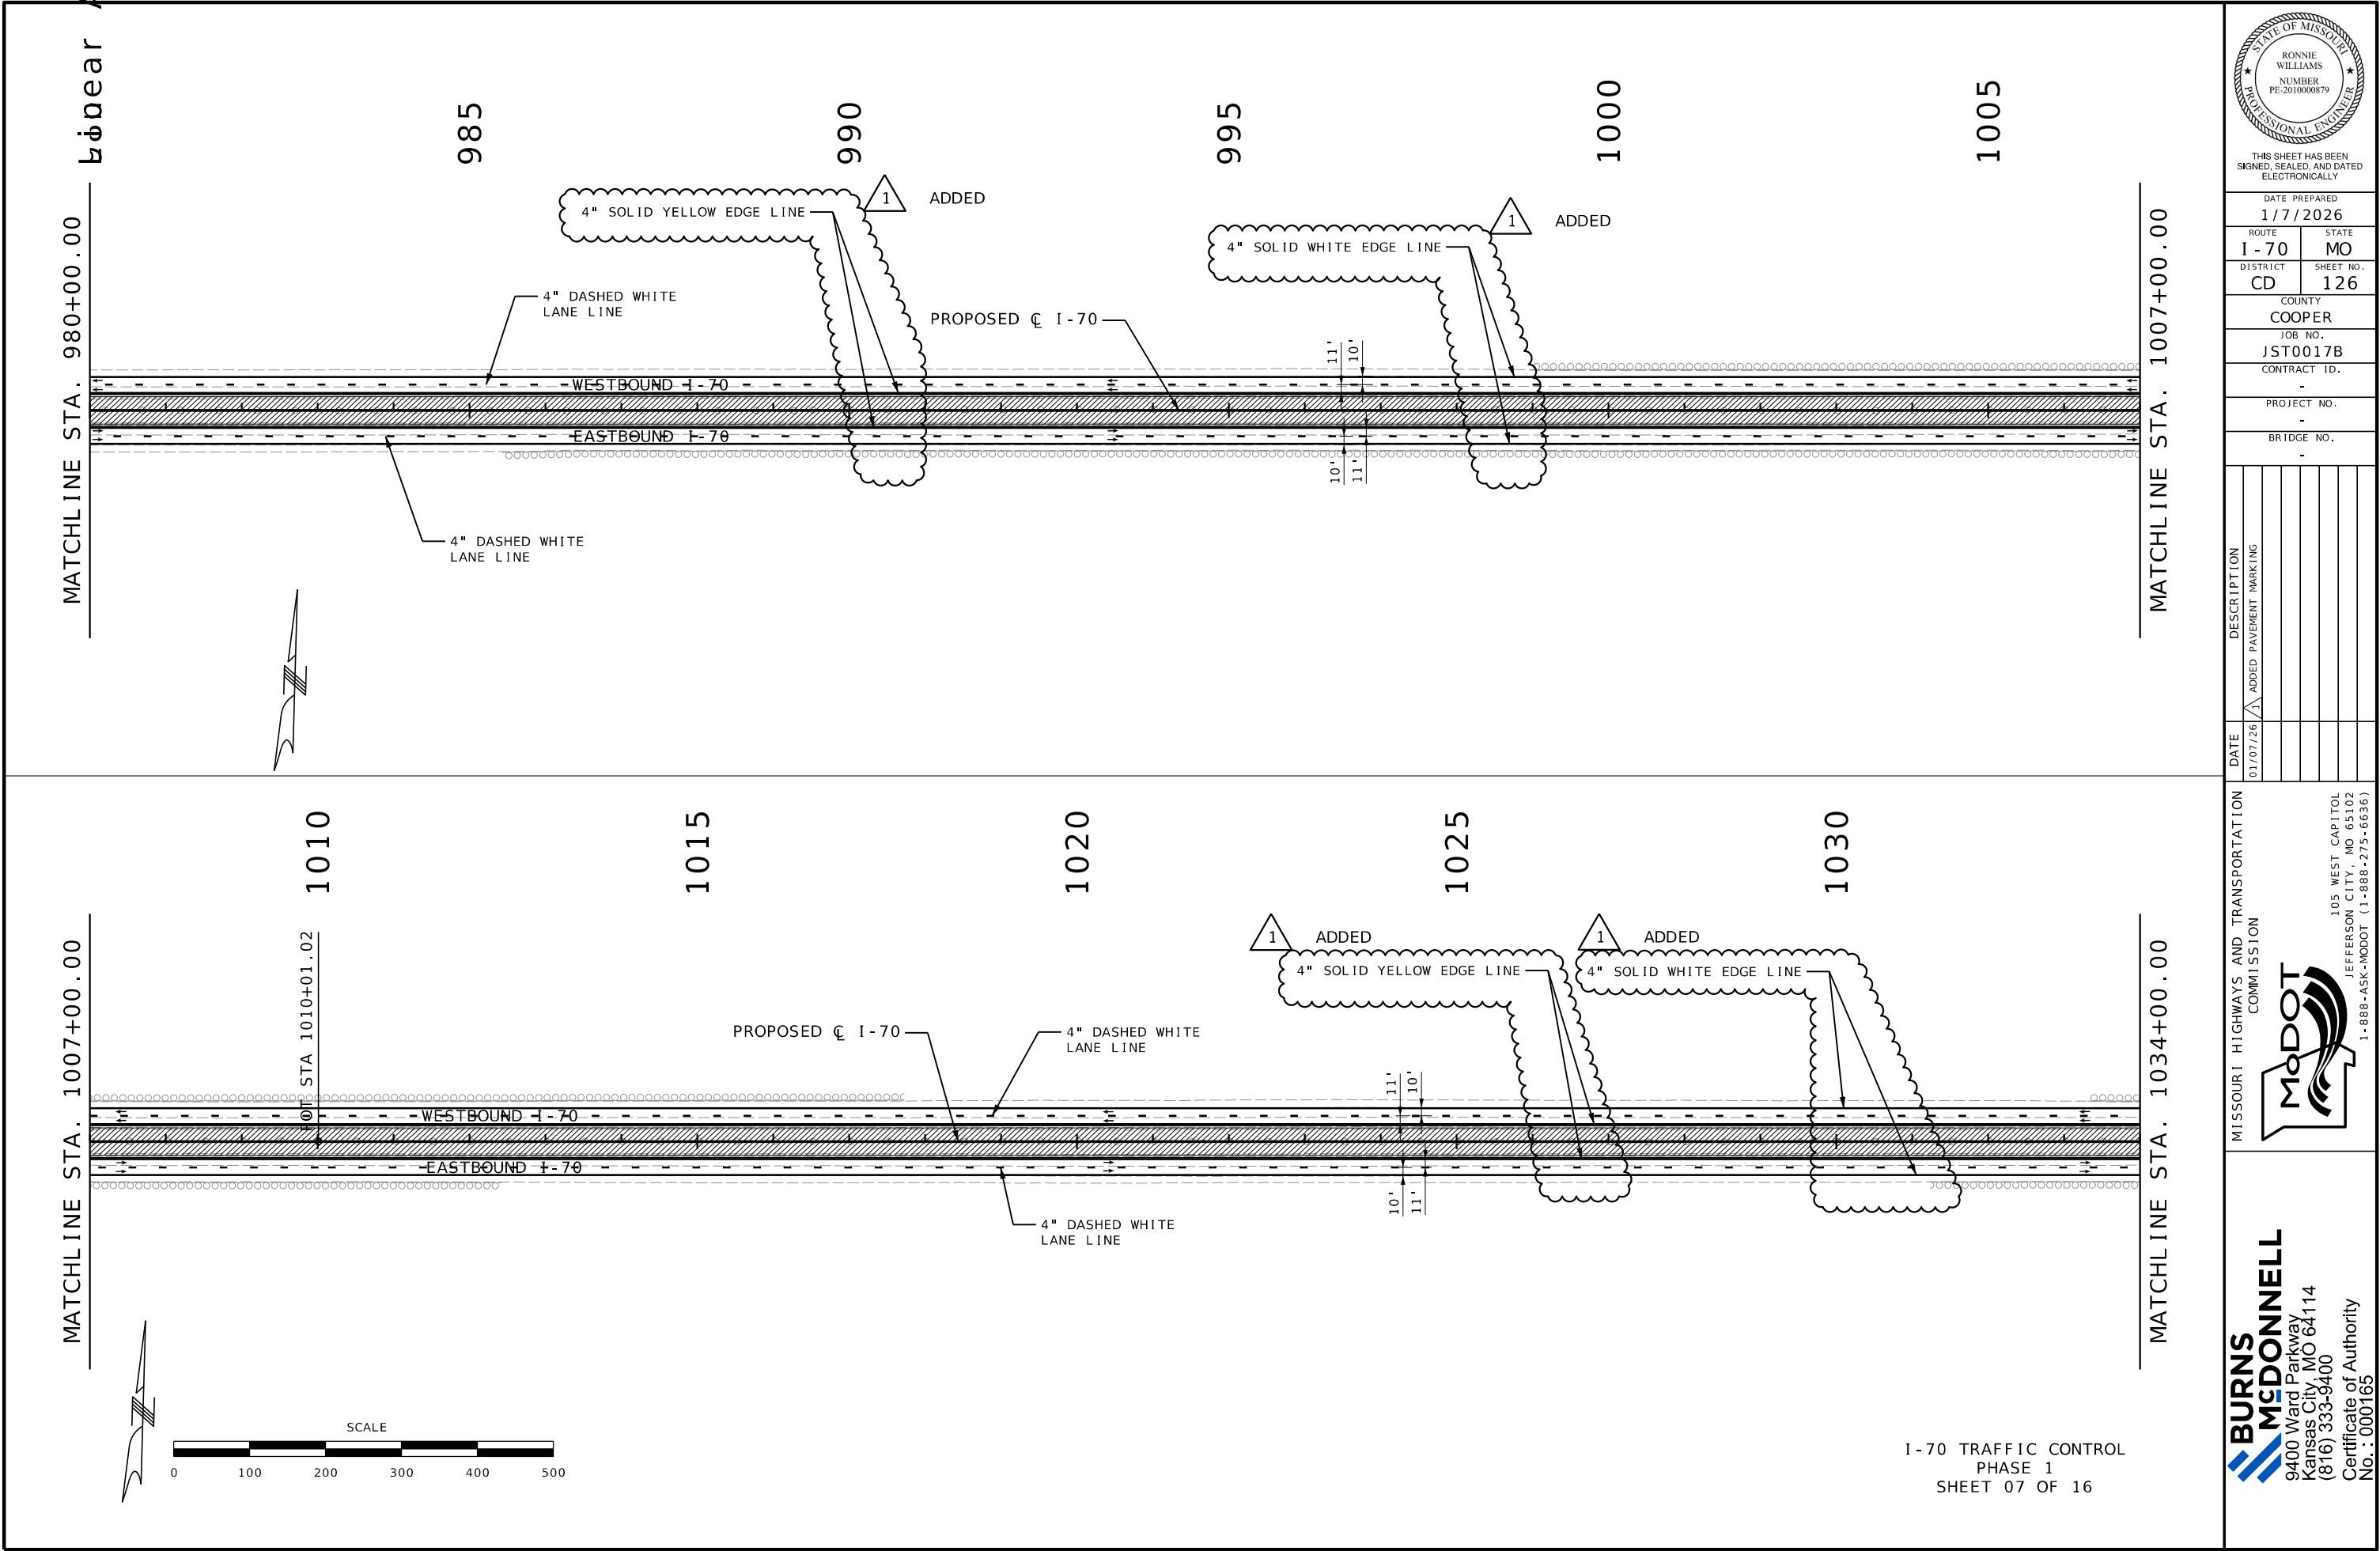

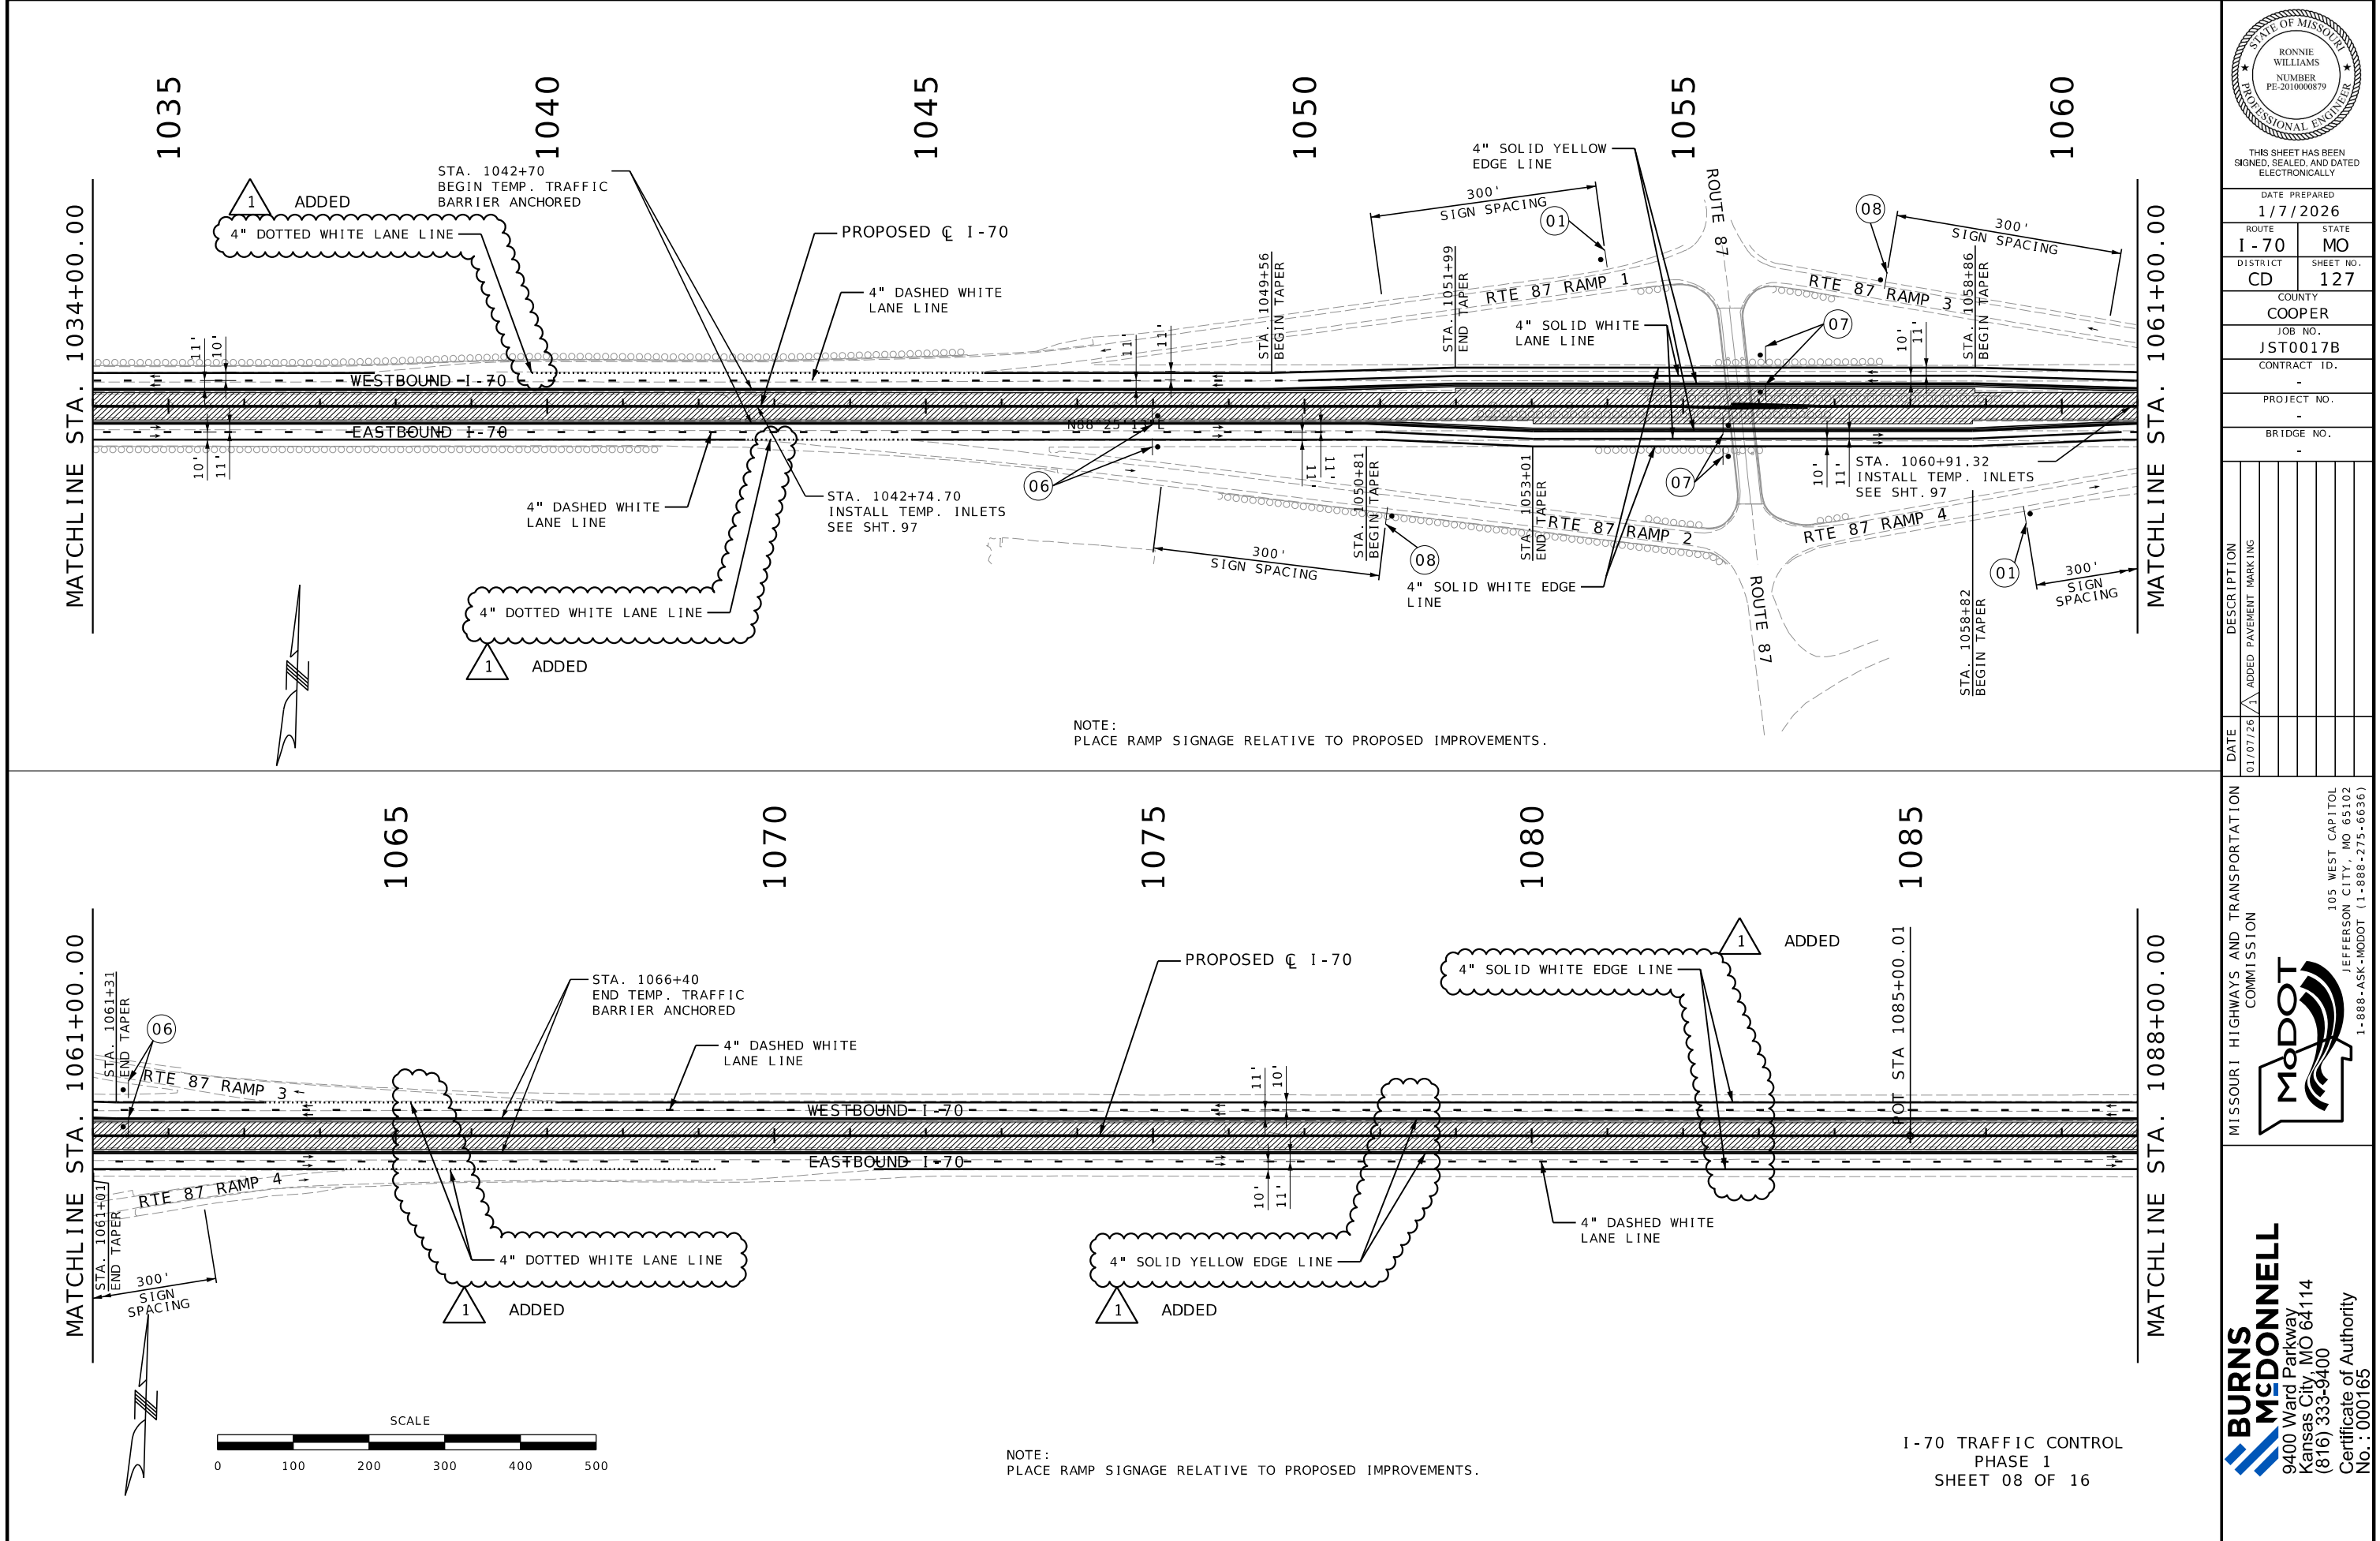

THIS SHEET HAS BEEN
SIGNED, SEALED, AND DATED
ELECTRONICALLY

DATE PREPARED
1/7/2026

ROUTE 1-70	STATE MO
DISTRICT CD	SHEET NO. 127

COUNTY
COOPER

JOB NO.
JST0017B

CONTRACT ID.
-

PROJECT NO.
-


BRIDGE NO.
-


DATE	DESCRIPTION
01/07/26	ADDED PAVEMENT MARKING


MISSOURI HIGHWAYS AND TRANSPORTATION
COMMISSION





**BURNS
MCDONNELL**
9400 Ward Parkway
Kansas City, MO 64114
(816) 333-9400
Certificate of Authority
No. : 000165

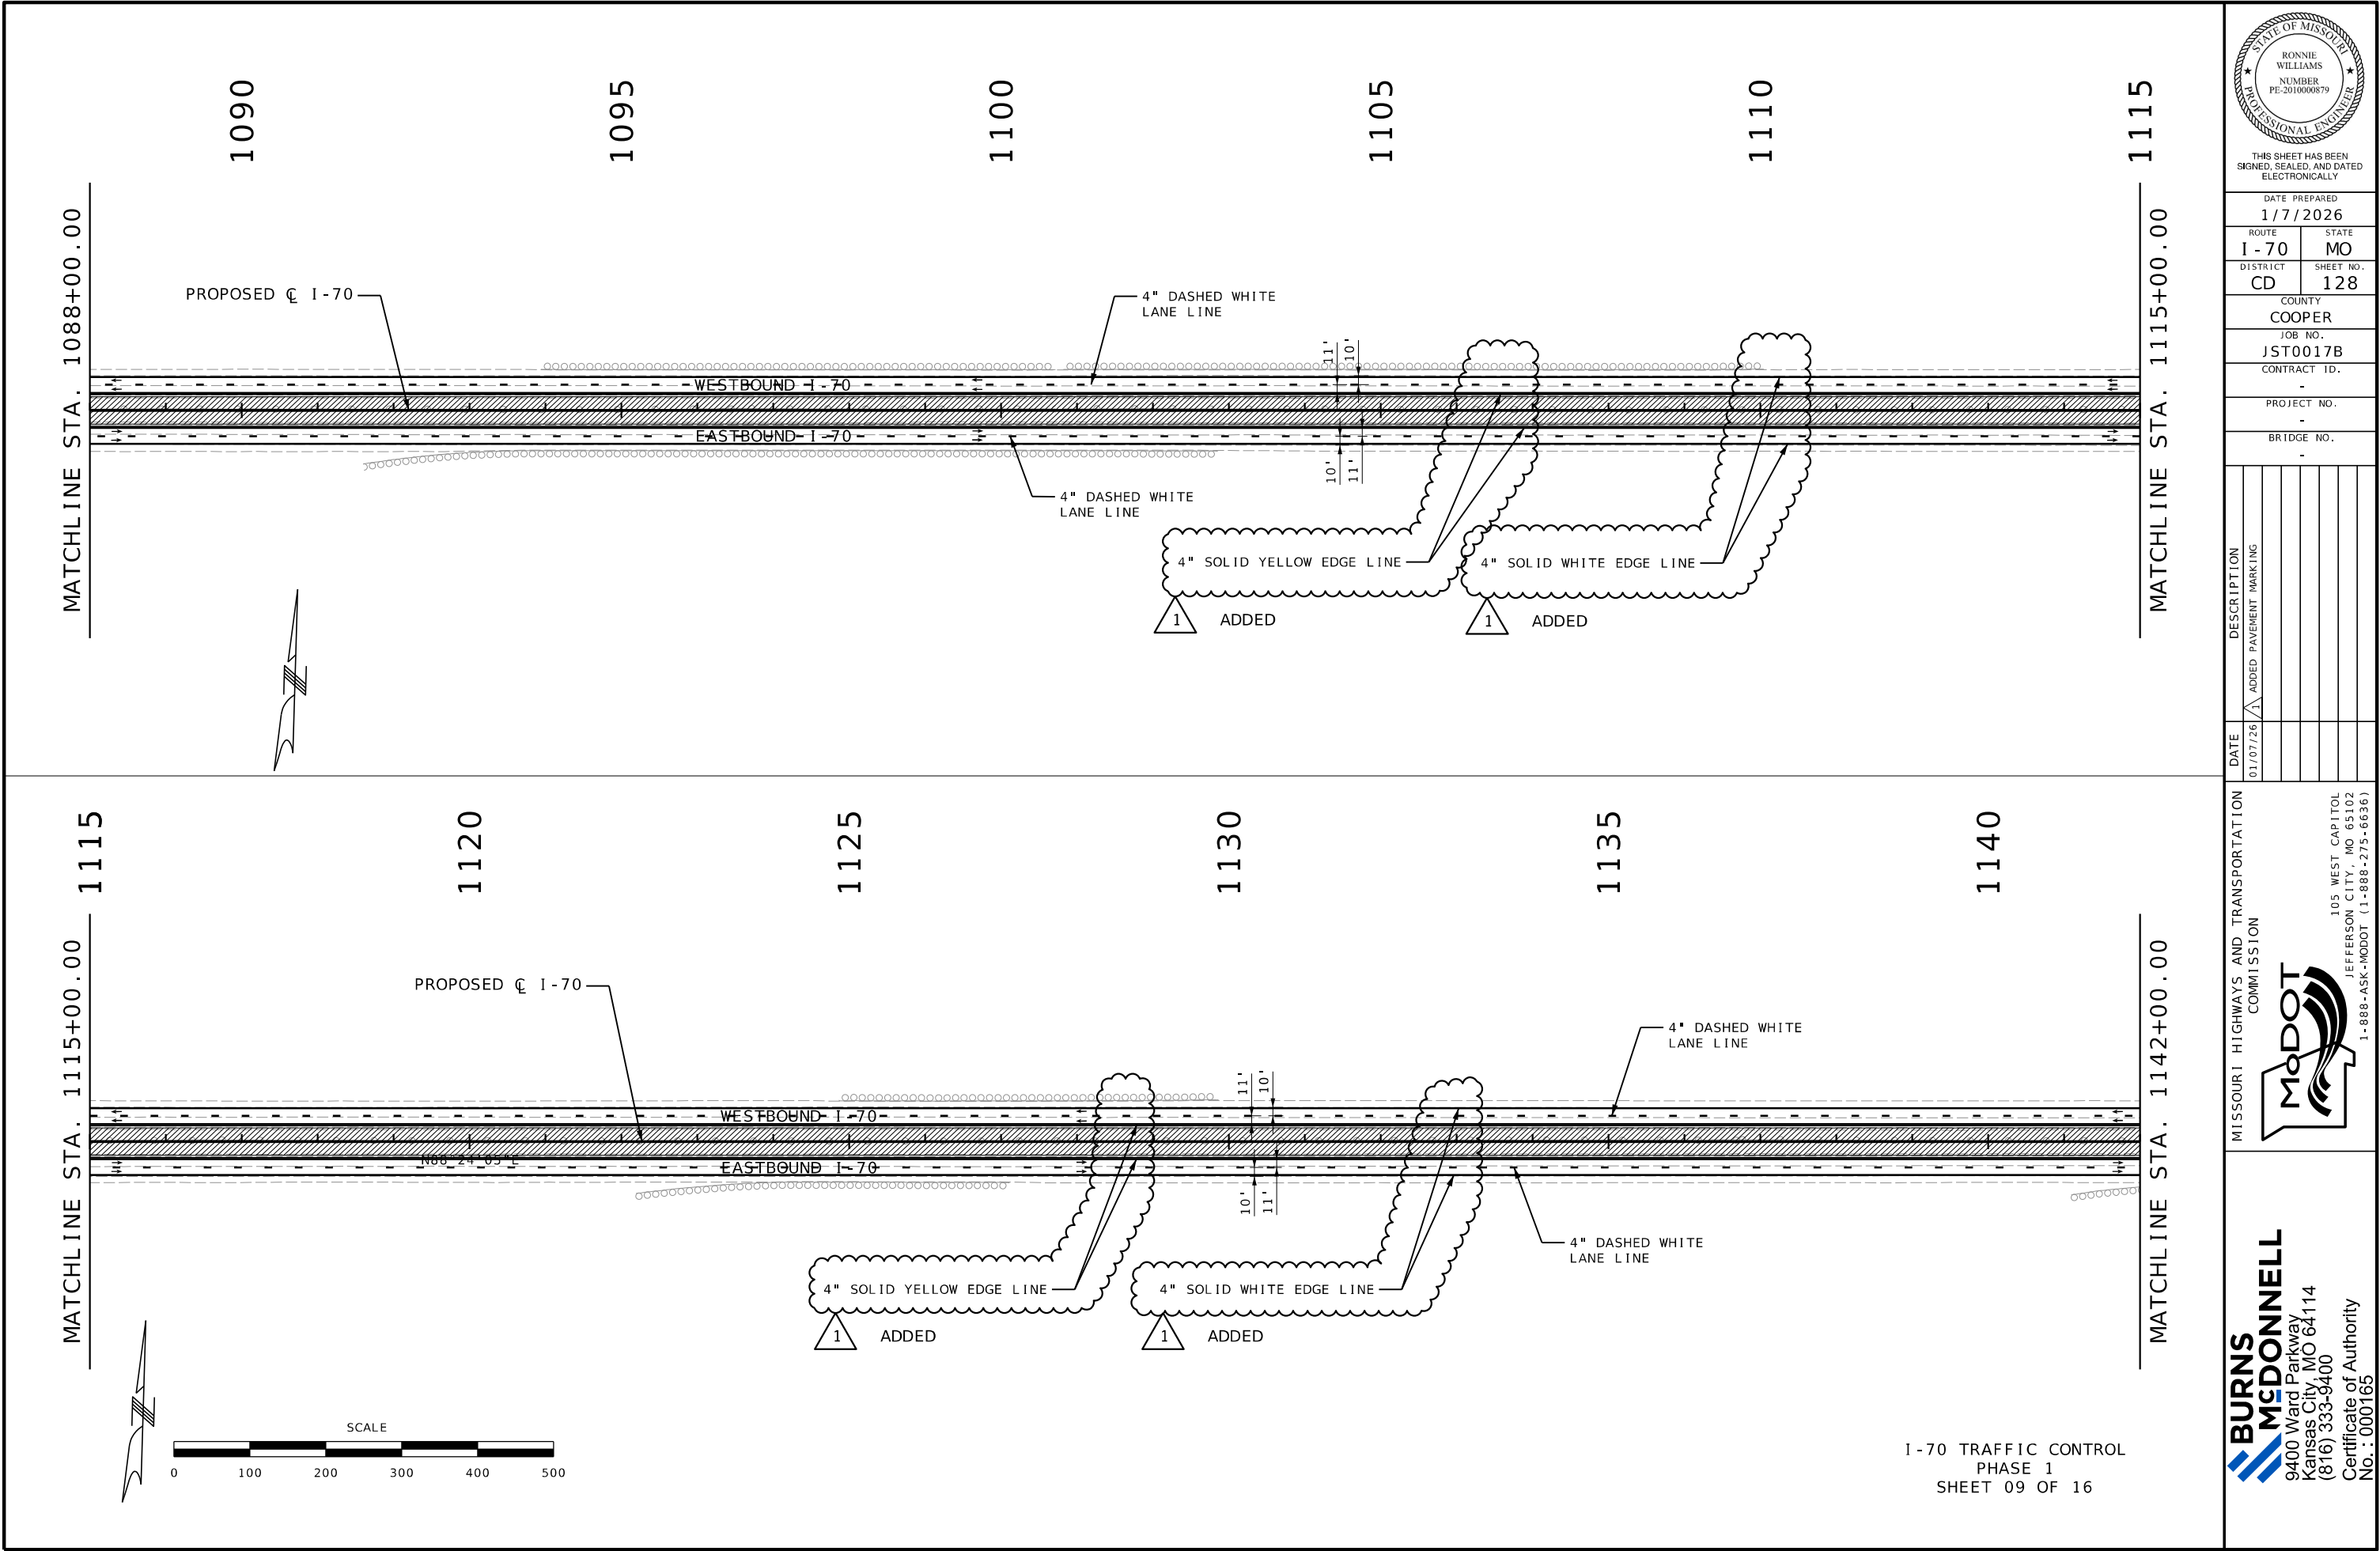

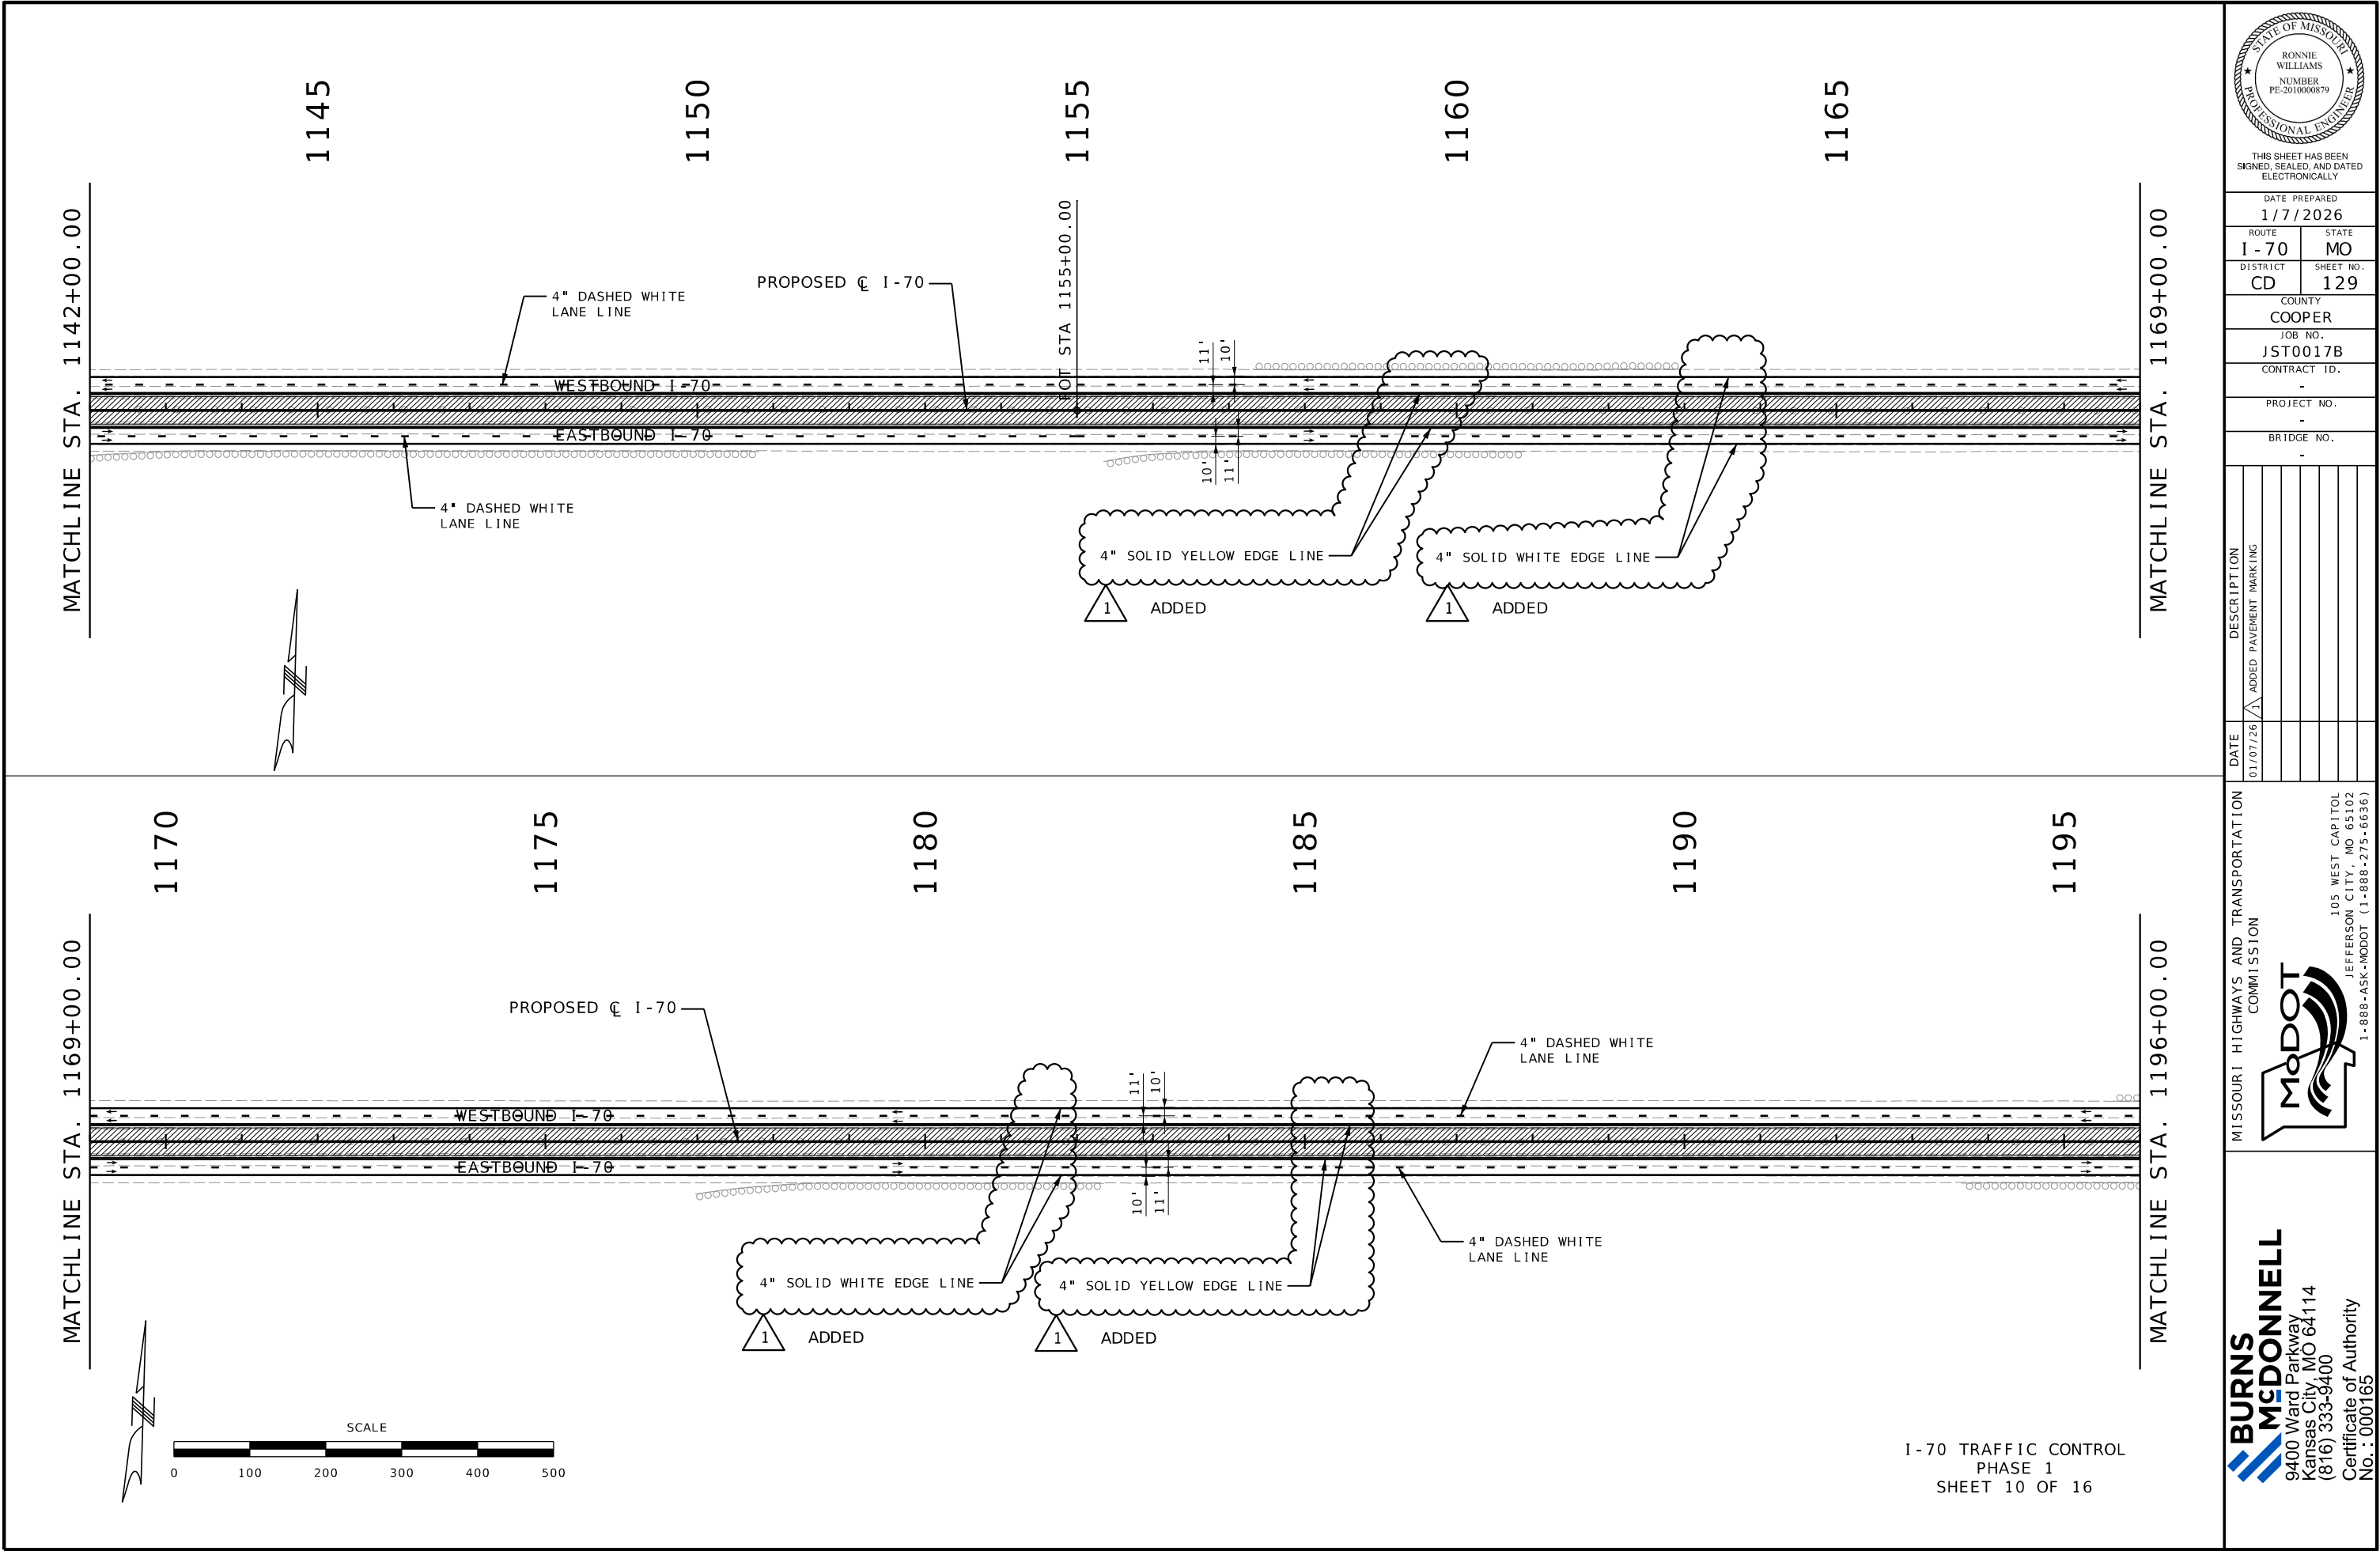

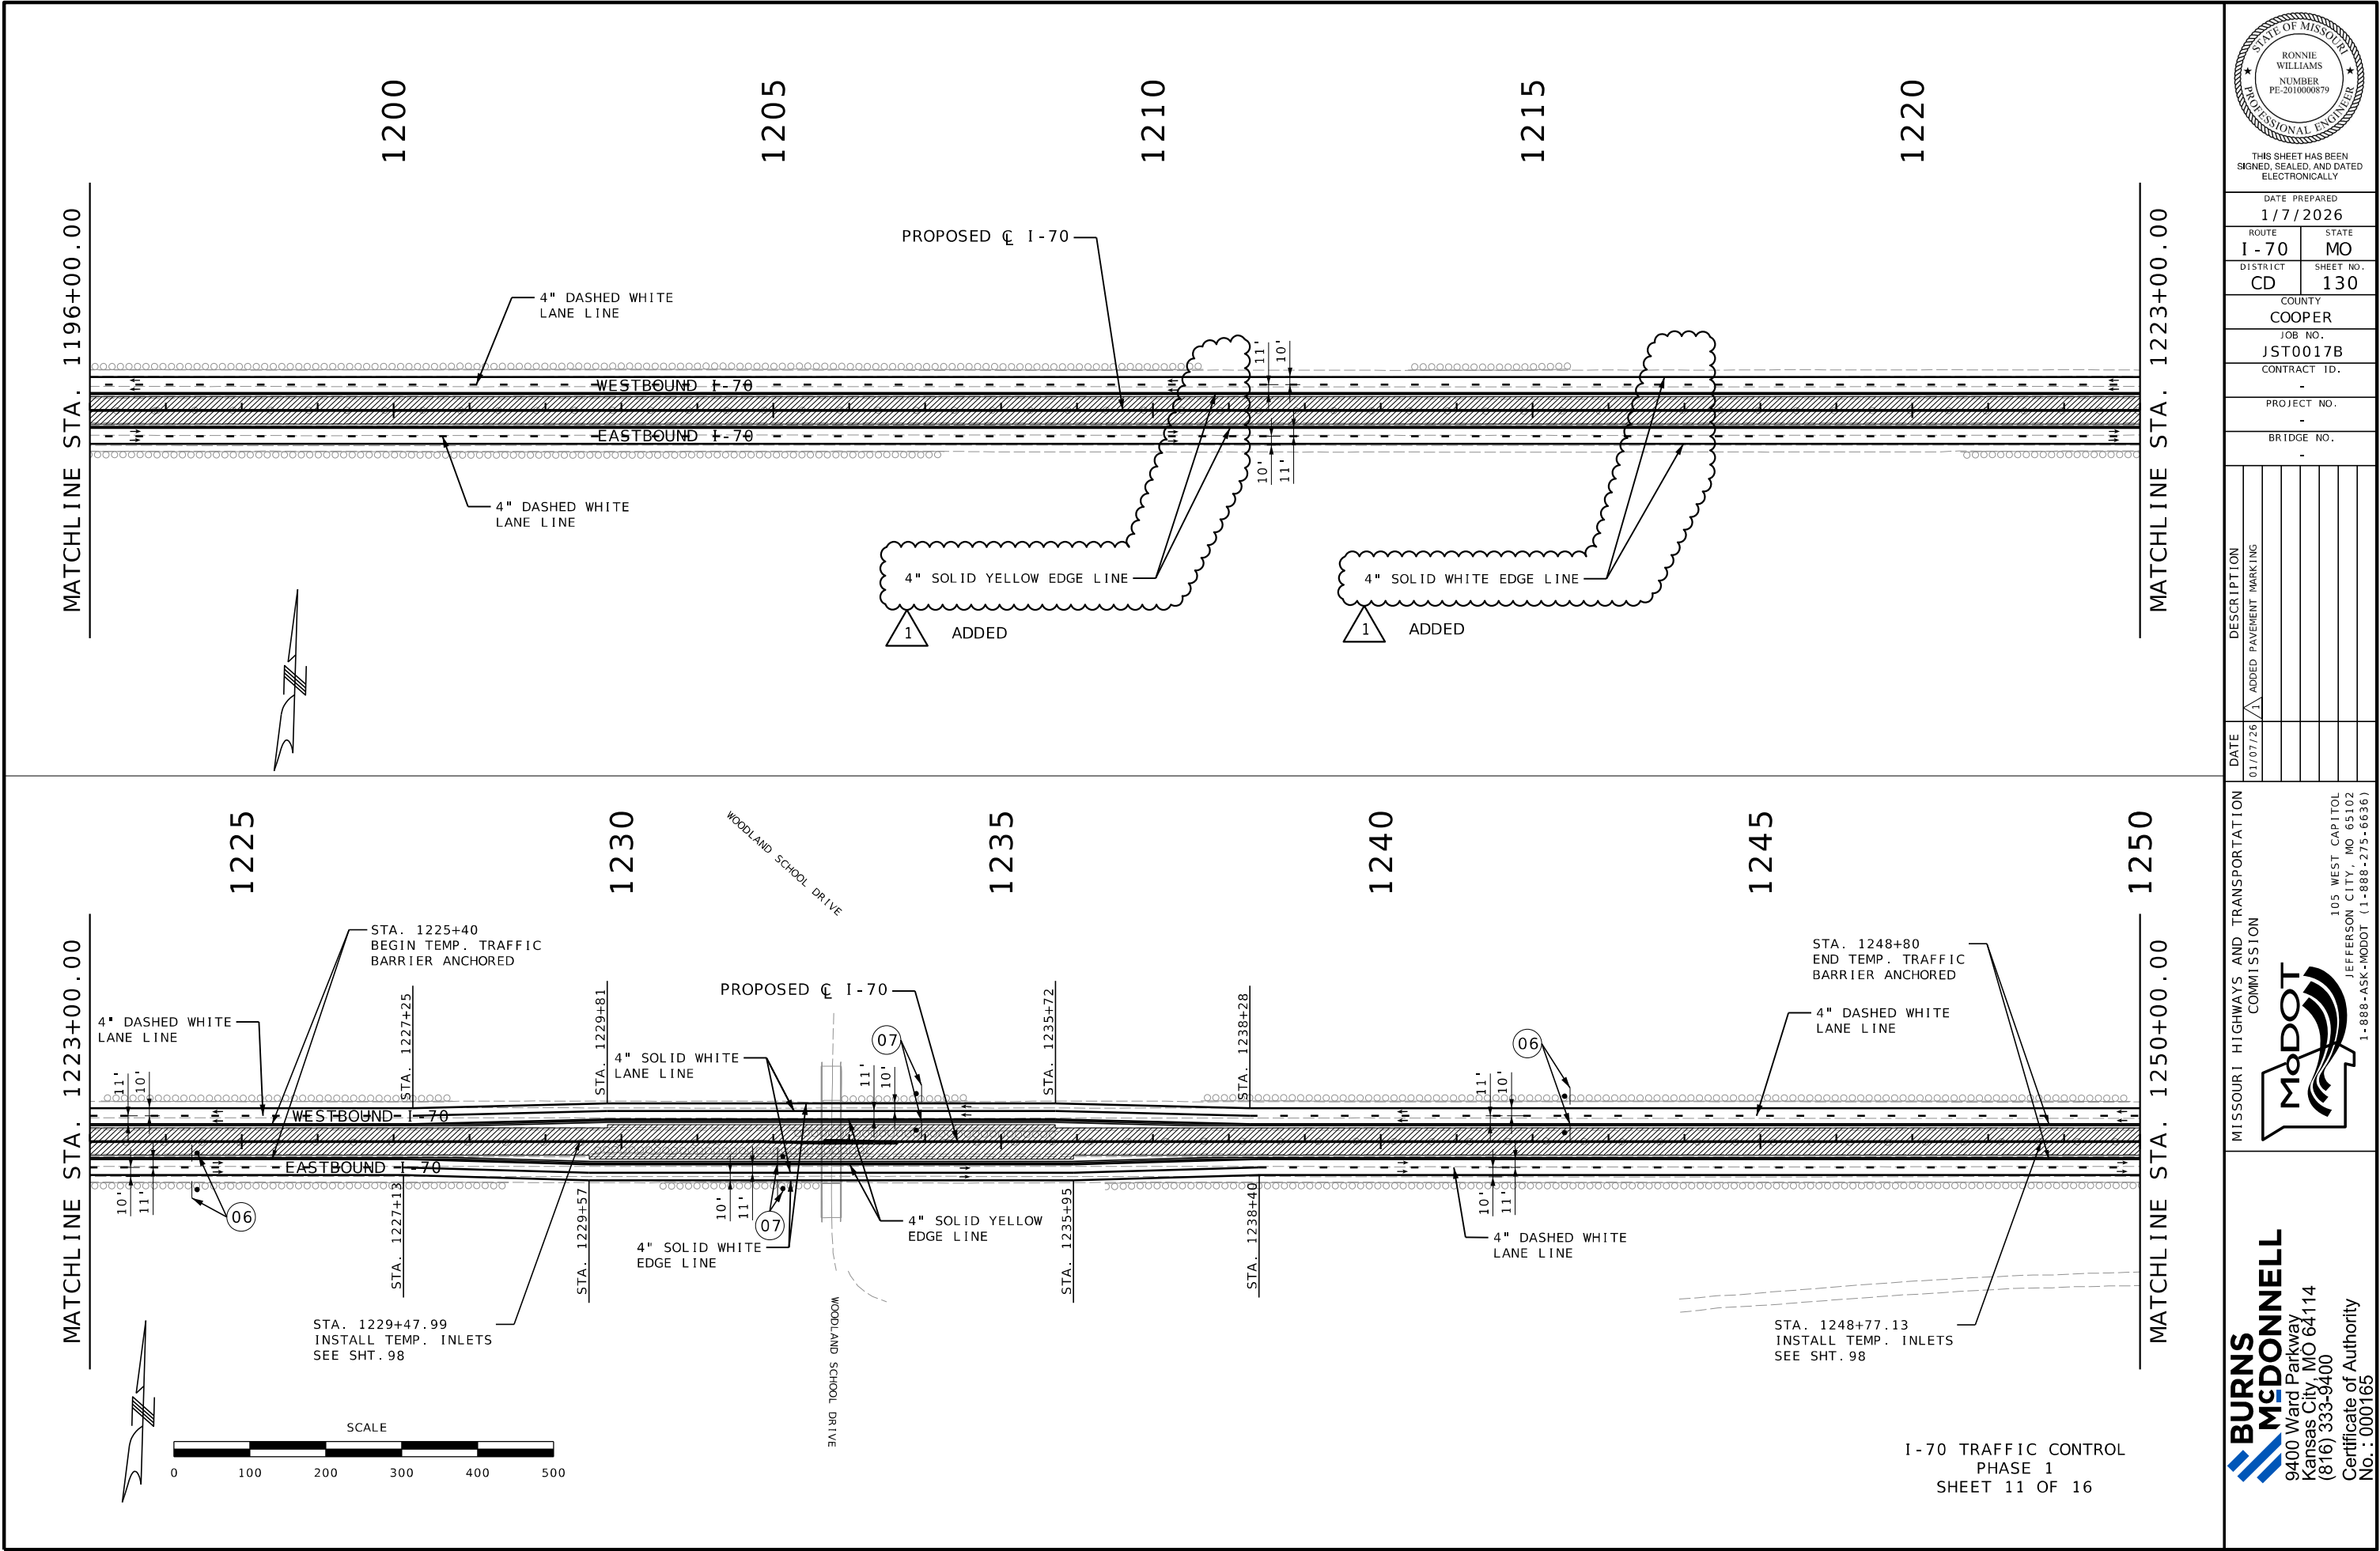

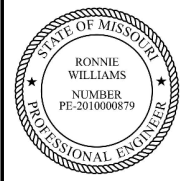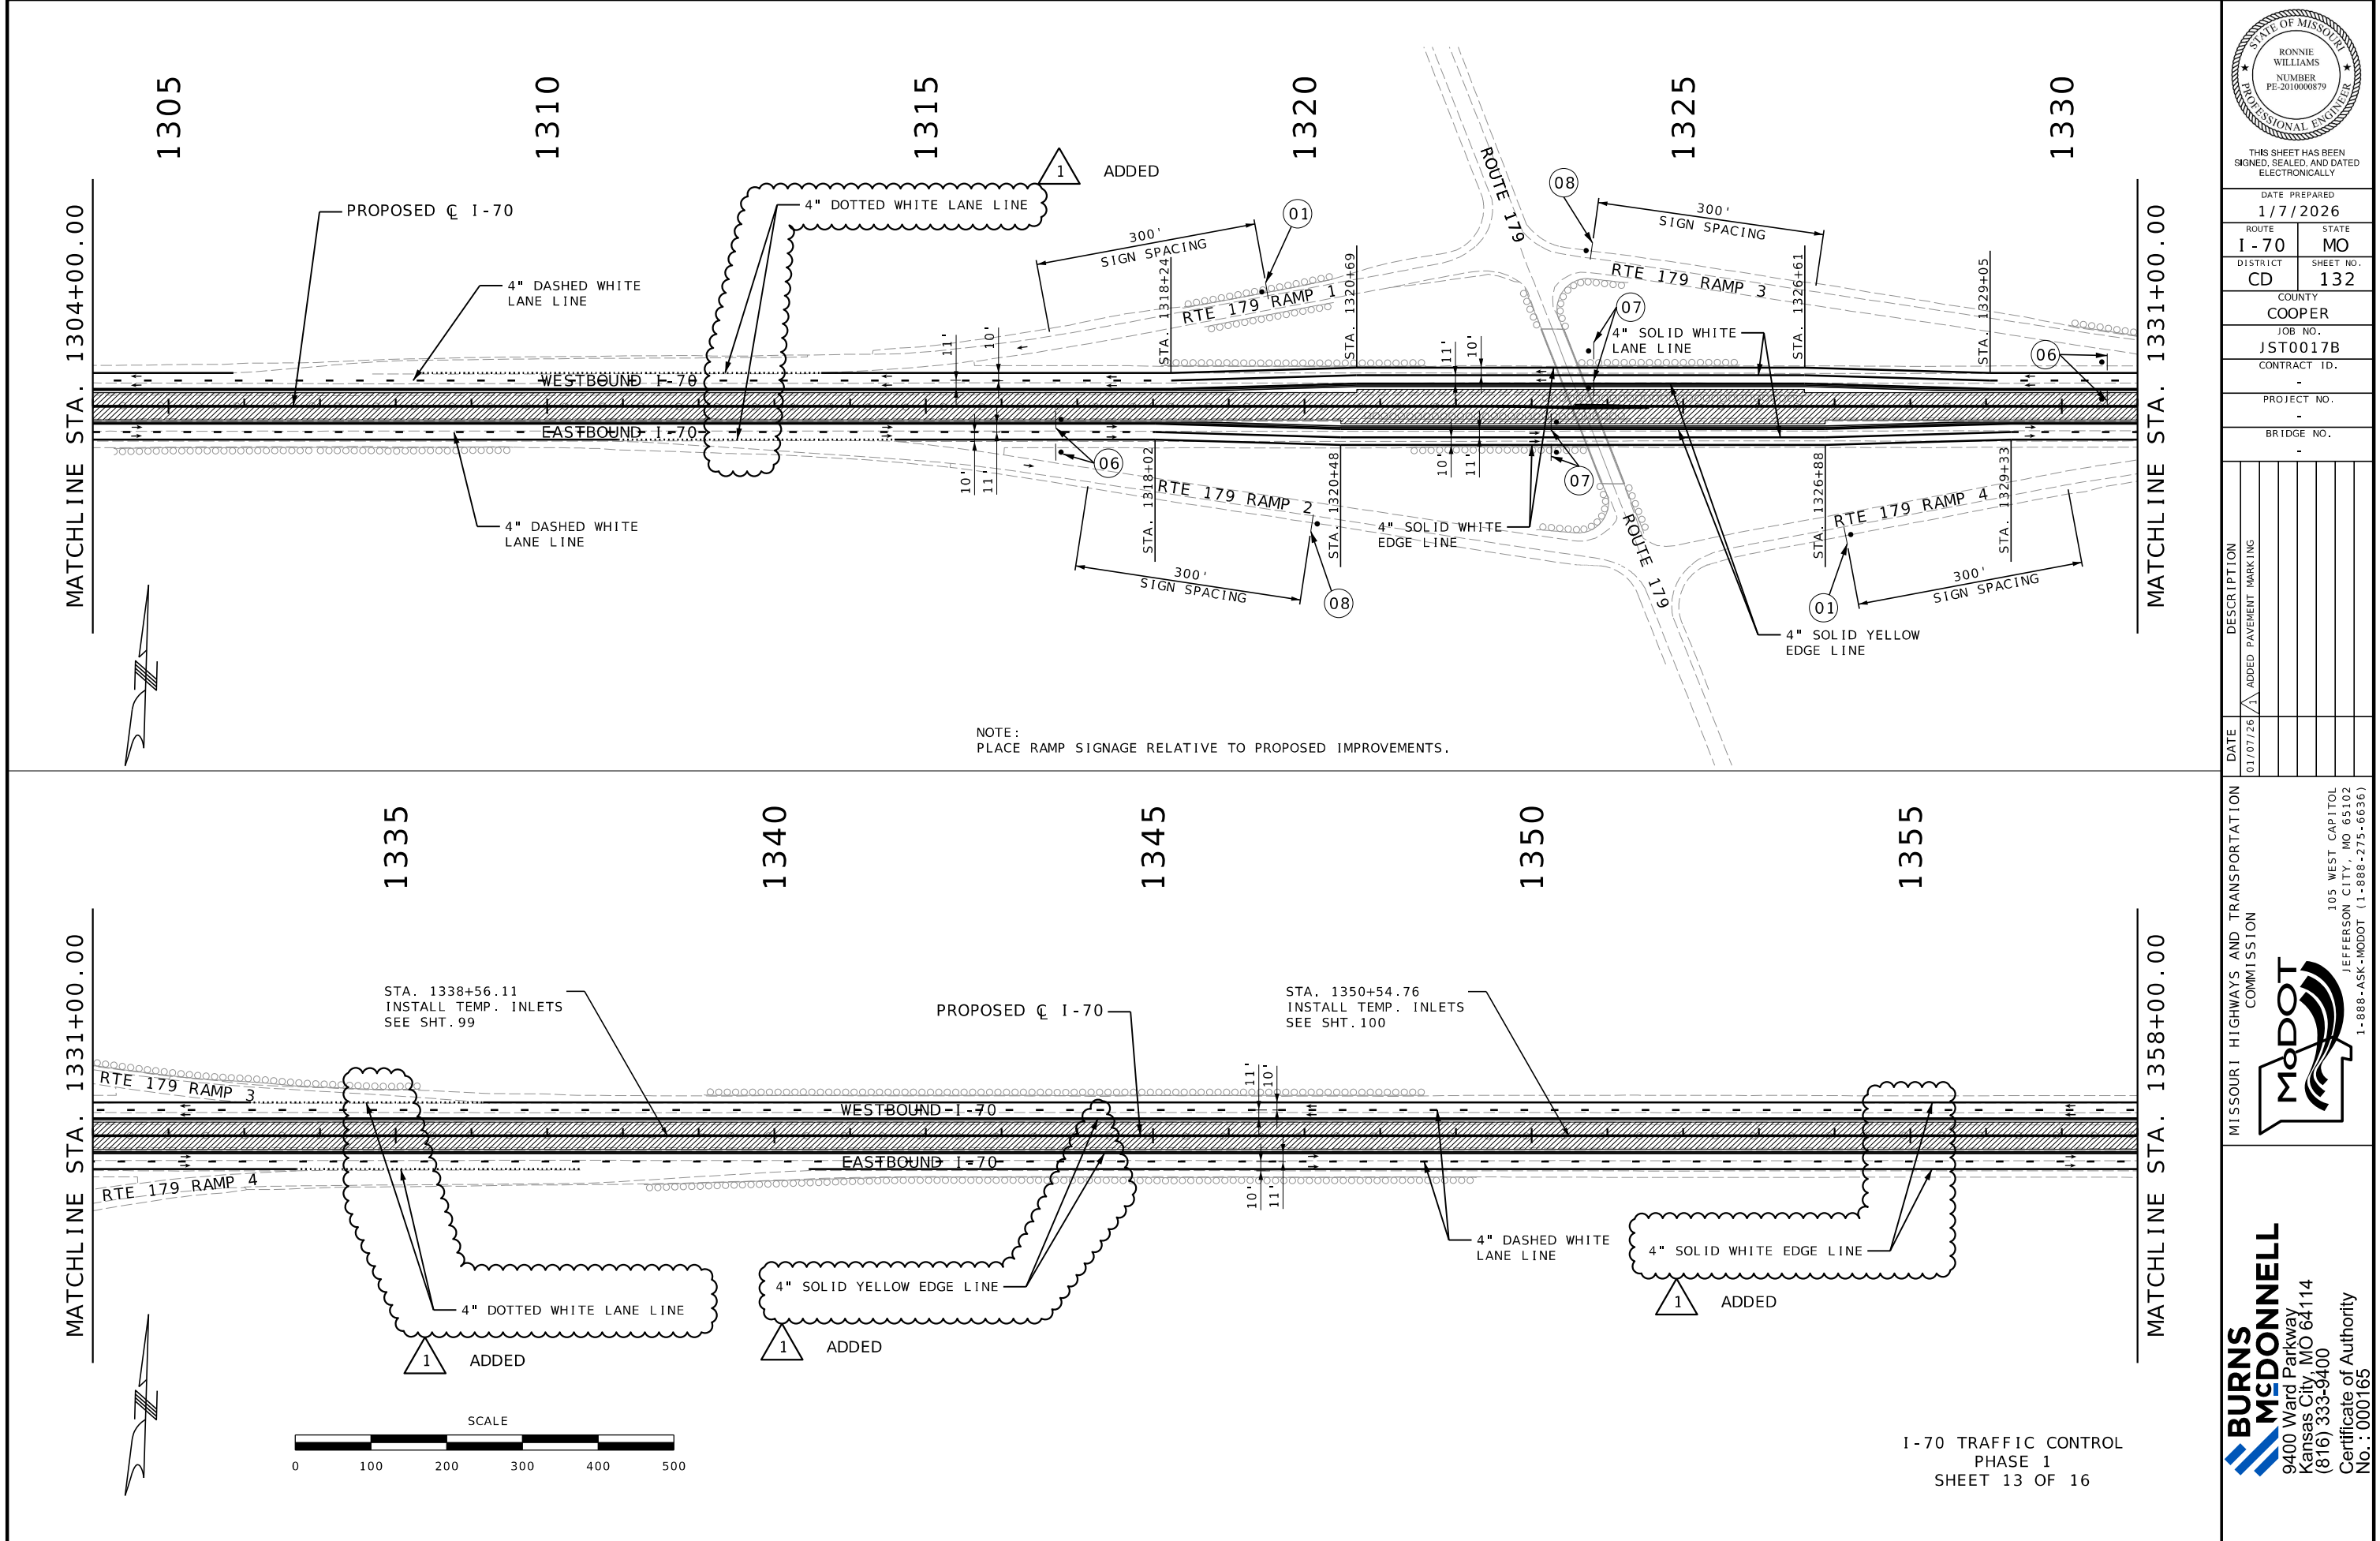

THIS SHEET HAS BEEN
SIGNED, SEALED, AND DATED
ELECTRONICALLY

DATE PREPARED
1/7/2026

ROUTE
1-70

STATE
MO

DISTRICT
CD

SHEET NO.
132

COUNTY
COOPER

JOB NO.
JST0017B

CONTRACT ID.
-

PROJECT NO.
-

BRIDGE NO.
-



DATE	DESCRIPTION
01/07/26	ADDED PAVEMENT MARKING

MISSOURI HIGHWAYS AND TRANSPORTATION
COMMISSION



105 WEST CAPITOL
JEFFERSON CITY, MO 65102
1-888-ASK-MODOT (1-888-273-6636)

**BURNS
MCDONNELL**
9400 Ward Parkway
Kansas City, MO 64114
(816) 333-9400
Certificate of Authority
No. : 000165

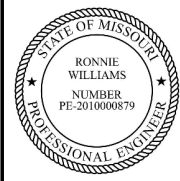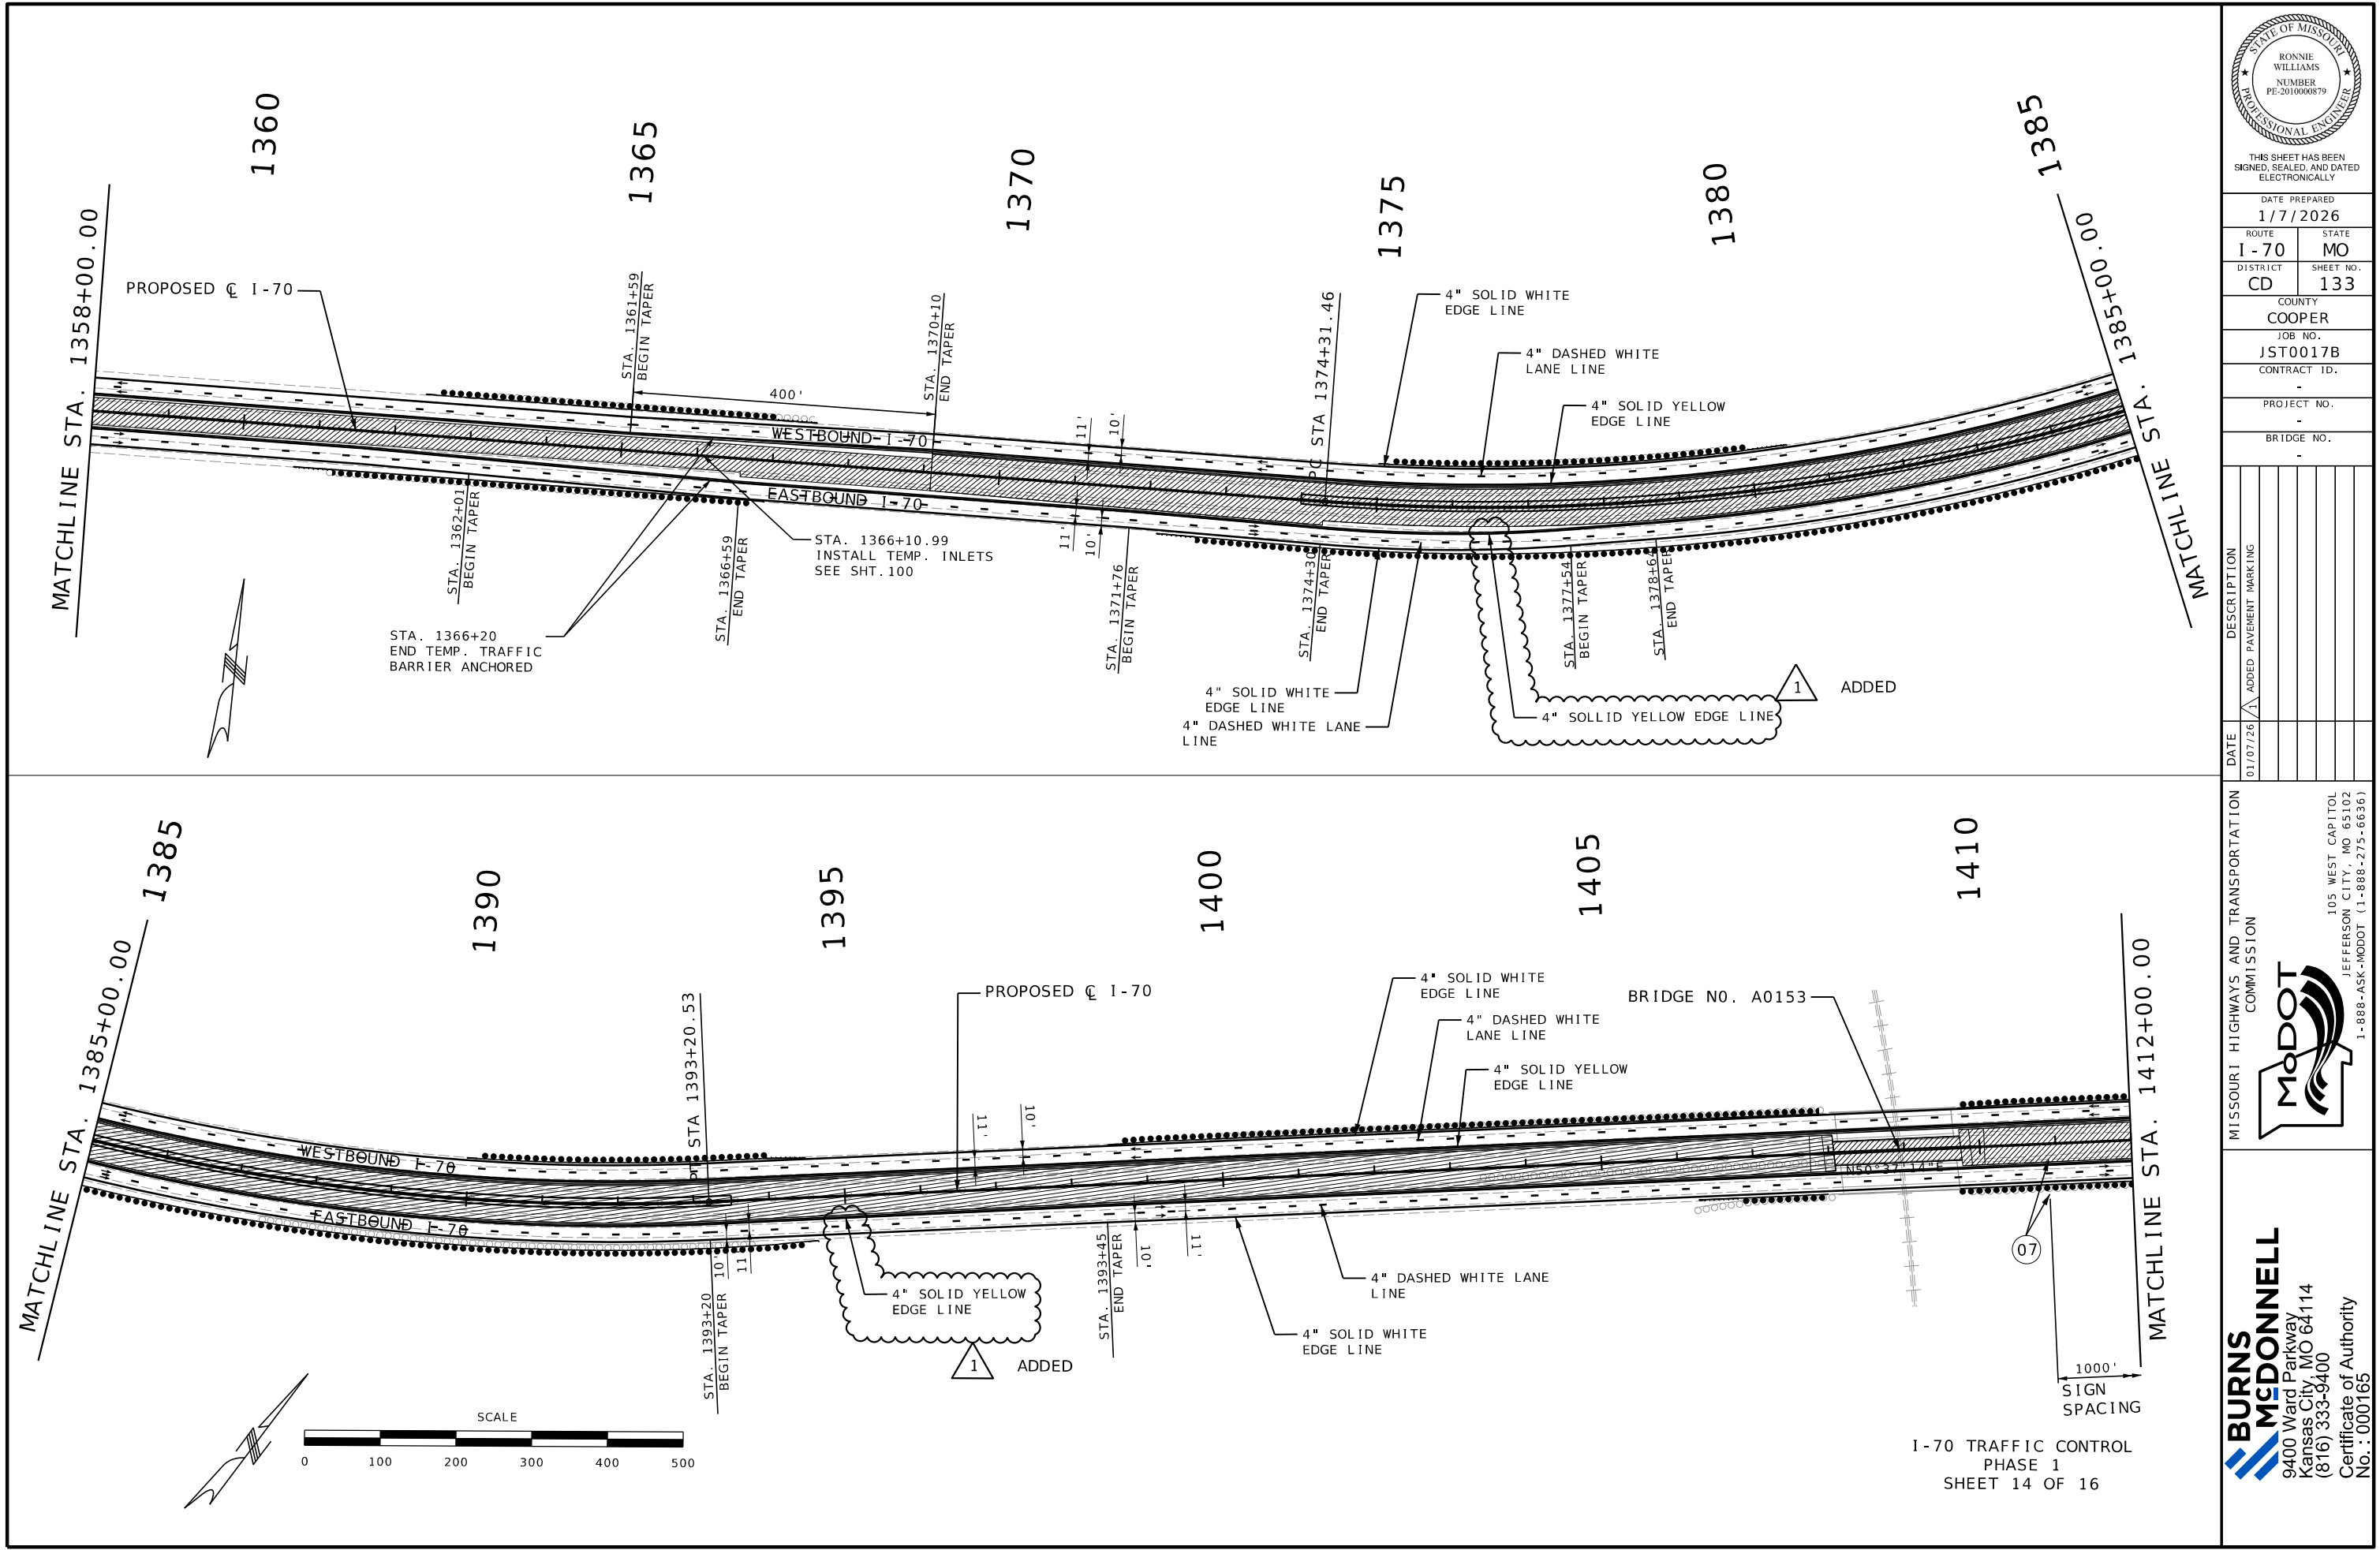

THIS SHEET HAS BEEN
SIGNED, SEALED, AND DATED
ELECTRONICALLY

DATE PREPARED
1/7/2026

ROUTE STATE
I - 70 MO

DISTRICT SHEET NO.
CD 133

COUNTY
COOPER

JOB NO.
JST0017B

CONTRACT ID.
-

PROJECT NO.
-

BRIDGE NO.
-

DATE	DESCRIPTION
01/07/26	ADDED PAVEMENT MARKING


MISSOURI HIGHWAYS AND TRANSPORTATION
COMMISSION

105 WEST CAPITOL
JEFFERSON CITY, MO 65102
1-888-ASK-MODOT (1-888-275-6636)

**BURNS
MCDONNELL**

9400 Ward Parkway
Kansas City, MO 64114
(816) 333-9400

Certificate of Authority
No. : 000165

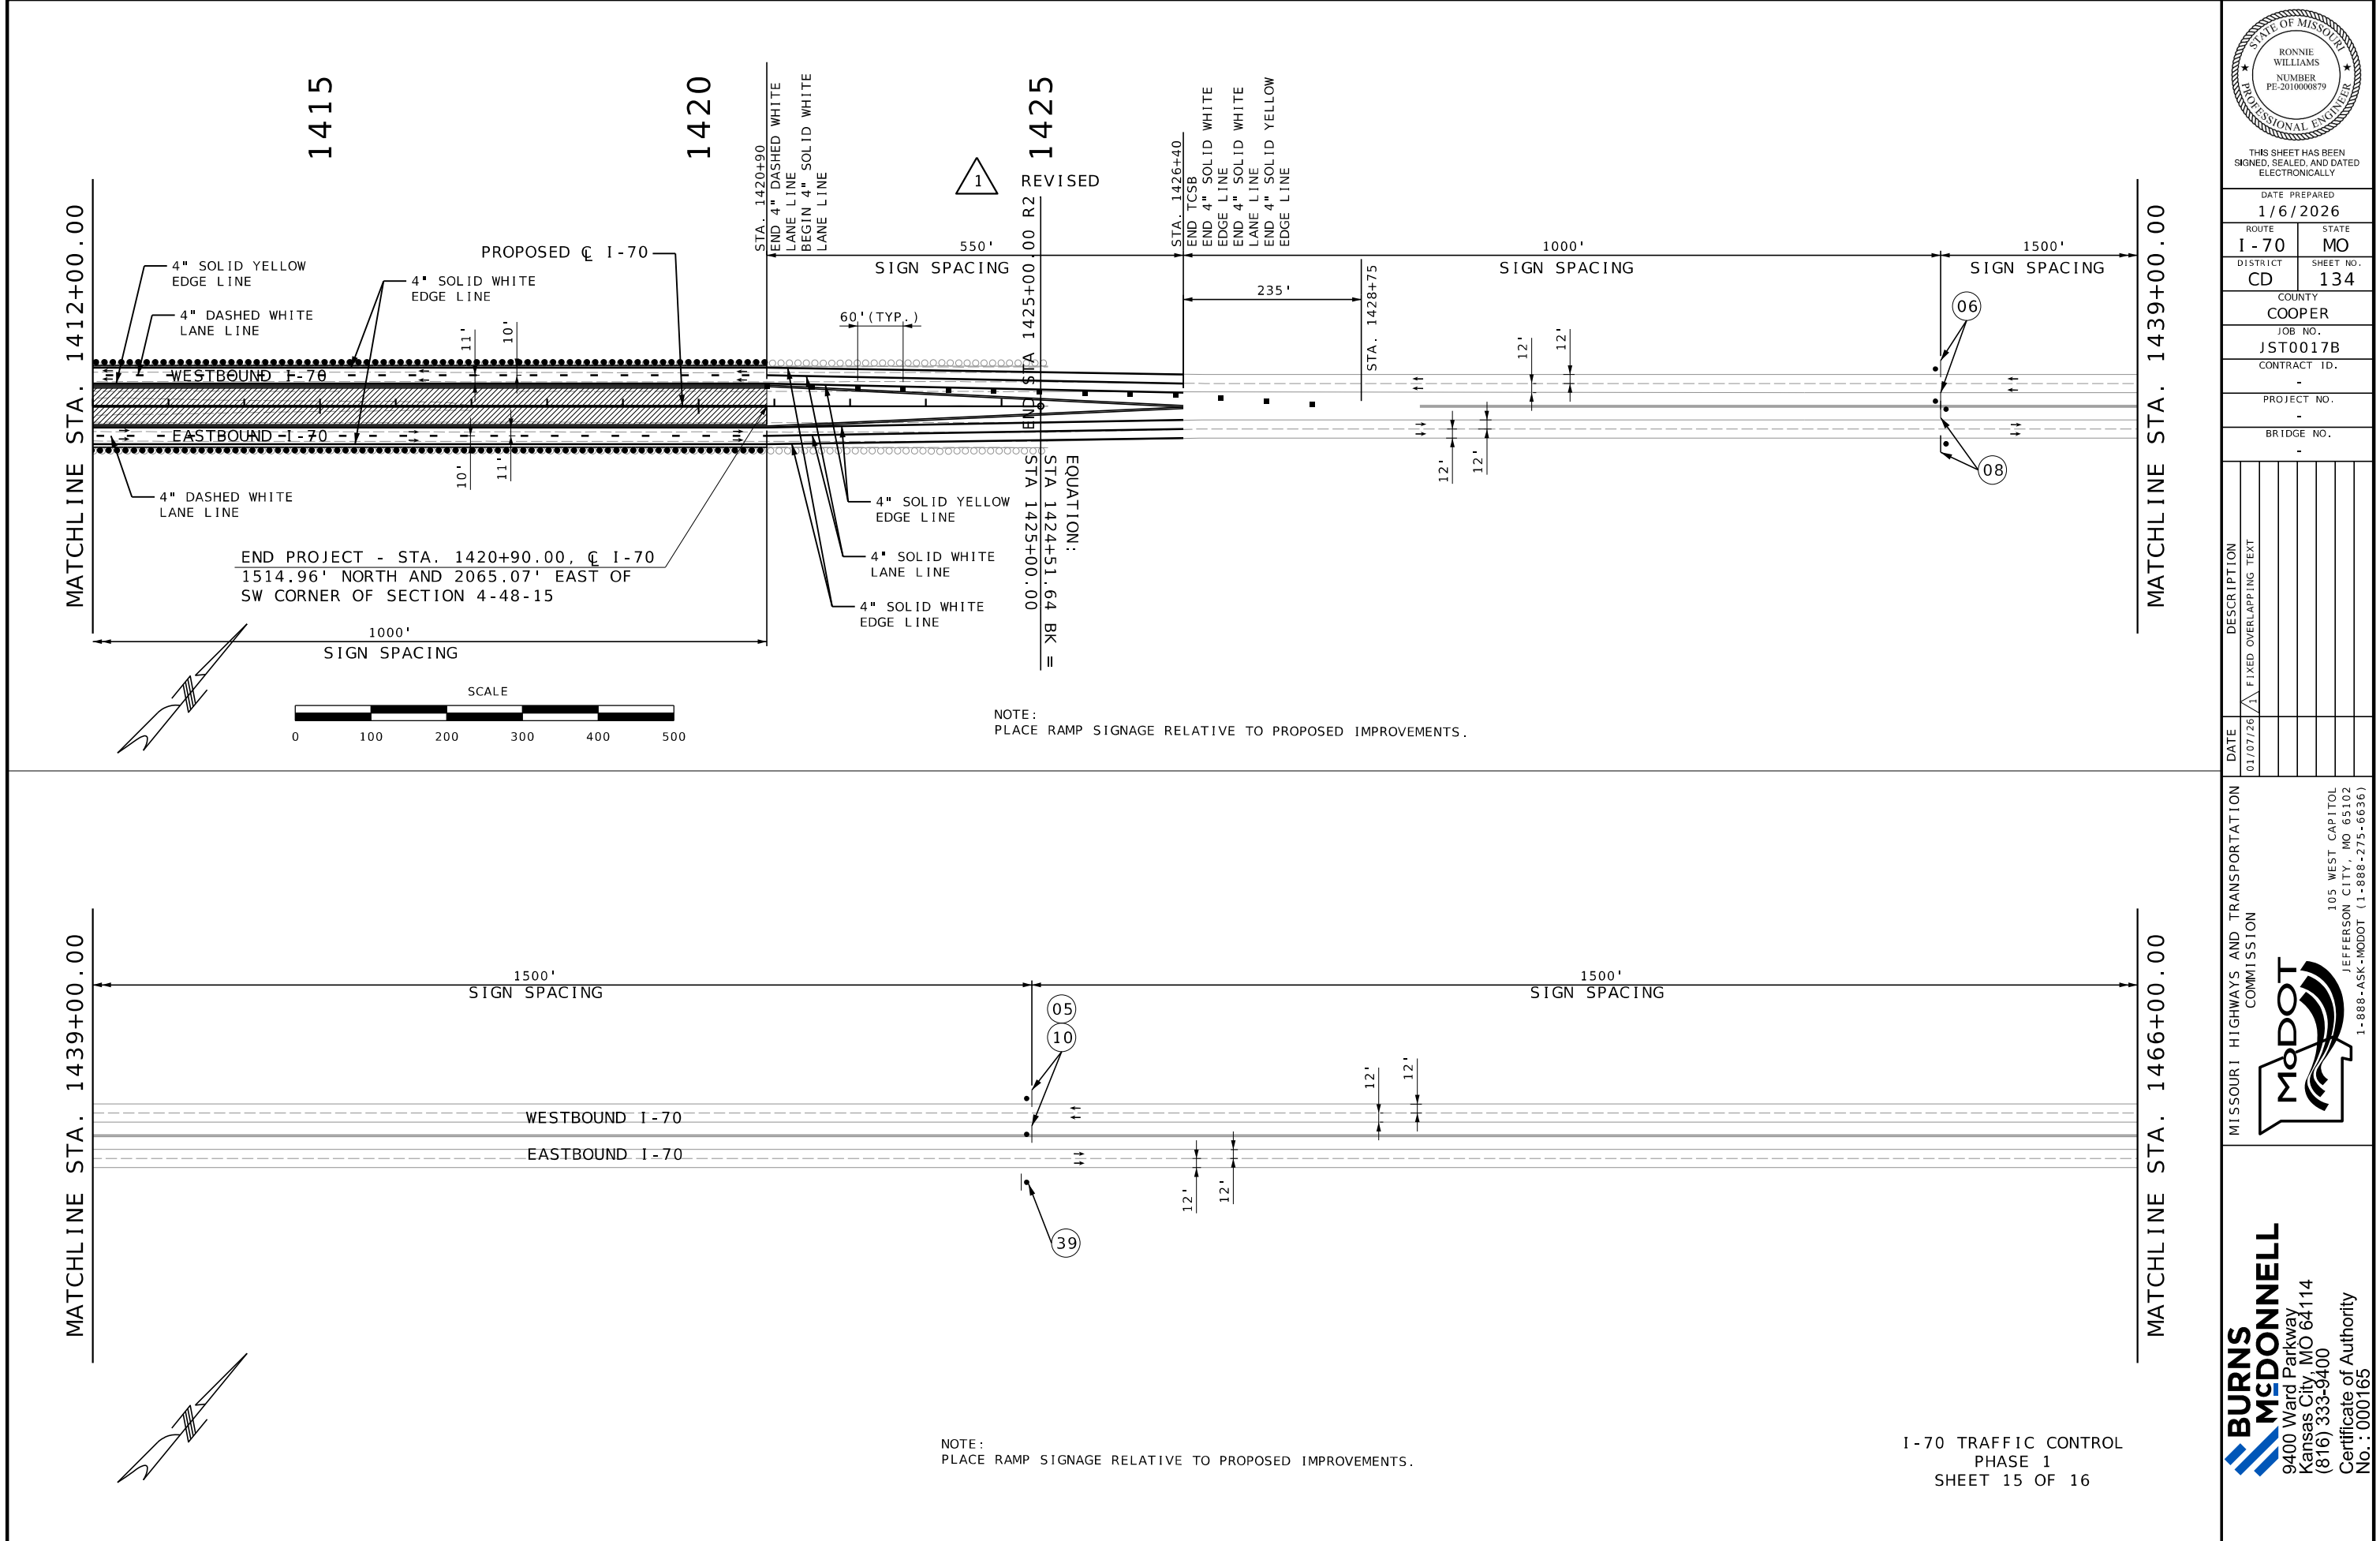

THIS SHEET HAS BEEN
SIGNED, SEALED, AND DATED
ELECTRONICALLY

DATE PREPARED
1/6/2026

ROUTE STATE
I - 70 MO

DISTRICT SHEET NO.
CD 134

COUNTY
COOPER

JOB NO.
JST0017B

CONTRACT ID.
-

PROJECT NO.
-

BRIDGE NO.
-

DATE	DESCRIPTION
01/07/26	FIXED OVERLAPPING TEXT


MISSOURI HIGHWAYS AND TRANSPORTATION
COMMISSION



105 WEST CAPITOL
JEFFERSON CITY, MO 65102
1-888-ASK-MODOT (1-888-275-6636)

**BURNS
MCDONNELL**

9400 Ward Parkway
Kansas City, MO 64114
(816) 333-9400
Certificate of Authority
No. : 000165

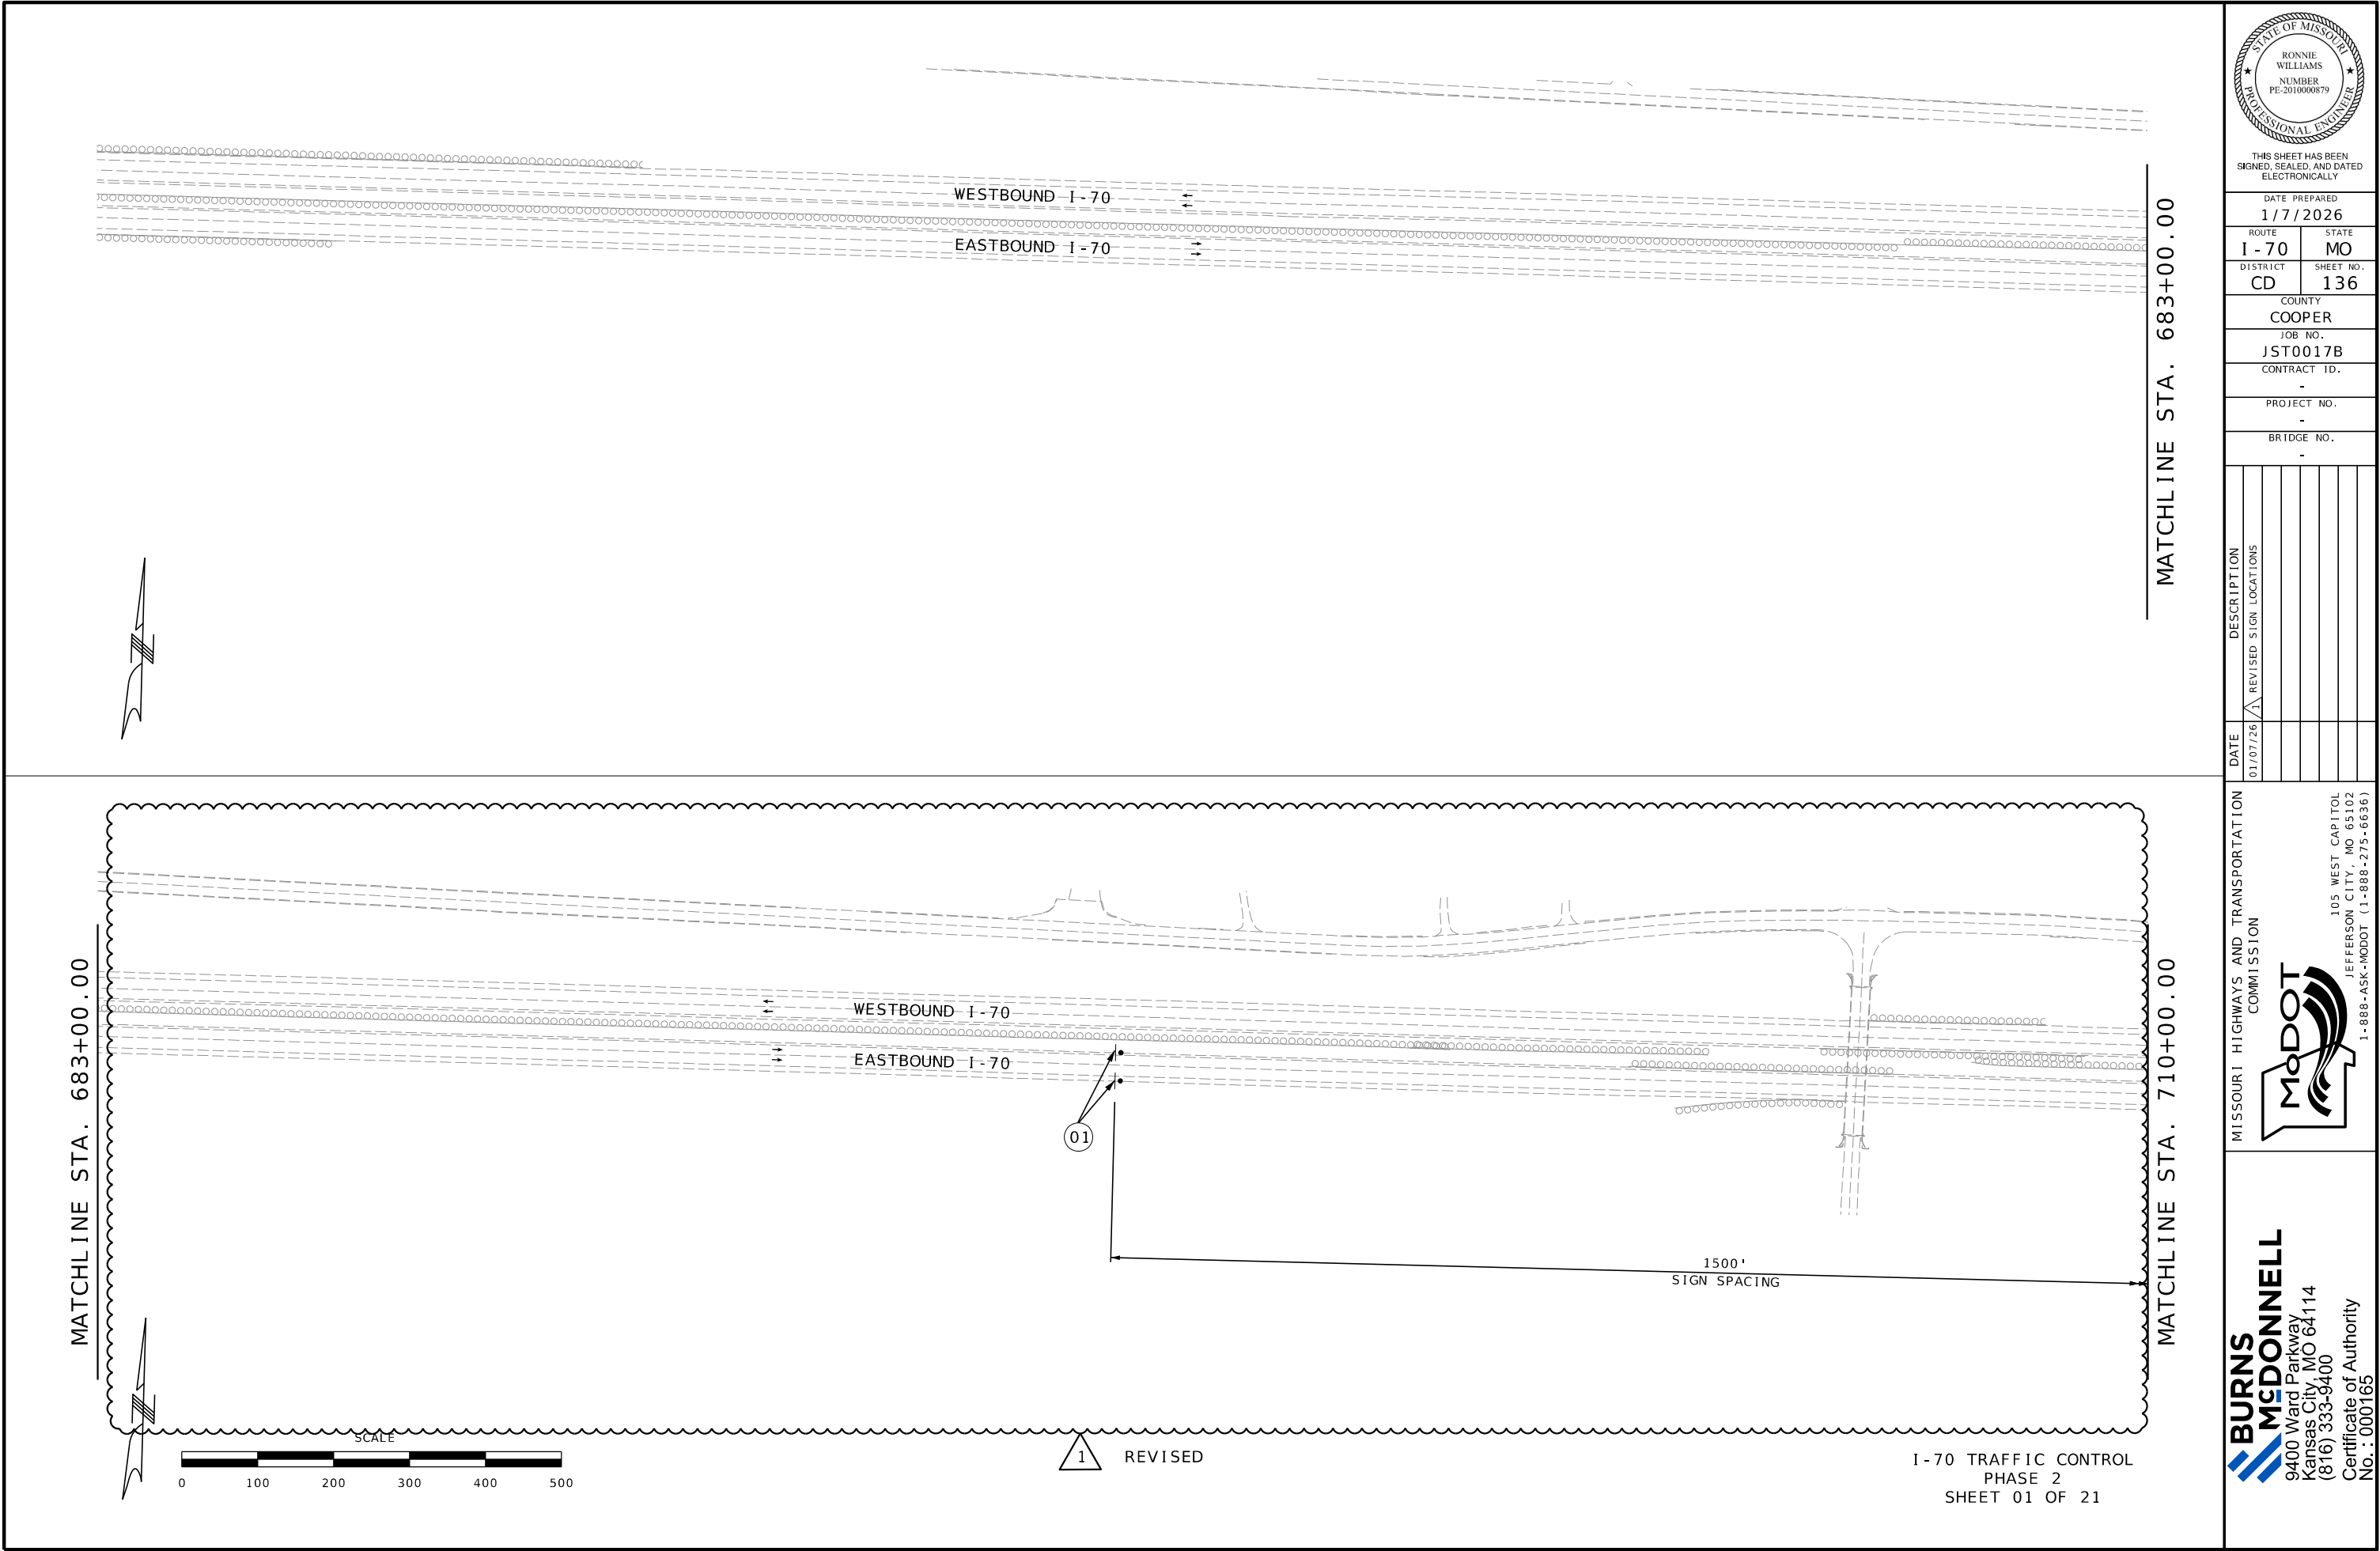

THIS SHEET HAS BEEN
SIGNED, SEALED, AND DATED
ELECTRONICALLY

DATE PREPARED
1/7/2026

ROUTE I-70	STATE MO
DISTRICT CD	SHEET NO. 136

COUNTY
COOPER

JOB NO.
JST0017B

CONTRACT ID.
-

PROJECT NO.
-

BRIDGE NO.
-

DATE	DESCRIPTION
01/07/26	REVISED SIGN LOCATIONS



MISSOURI HIGHWAYS AND TRANSPORTATION
COMMISSION

MoDOT


105 WEST CAPITOL
JEFFERSON CITY, MO 65102
1-888-ASK-MODOT (1-888-273-6636)

**BURNS
MCDONNELL**

9400 Ward Parkway
Kansas City, MO 64114
(816) 333-9400
Certificate of Authority
No. : 000165

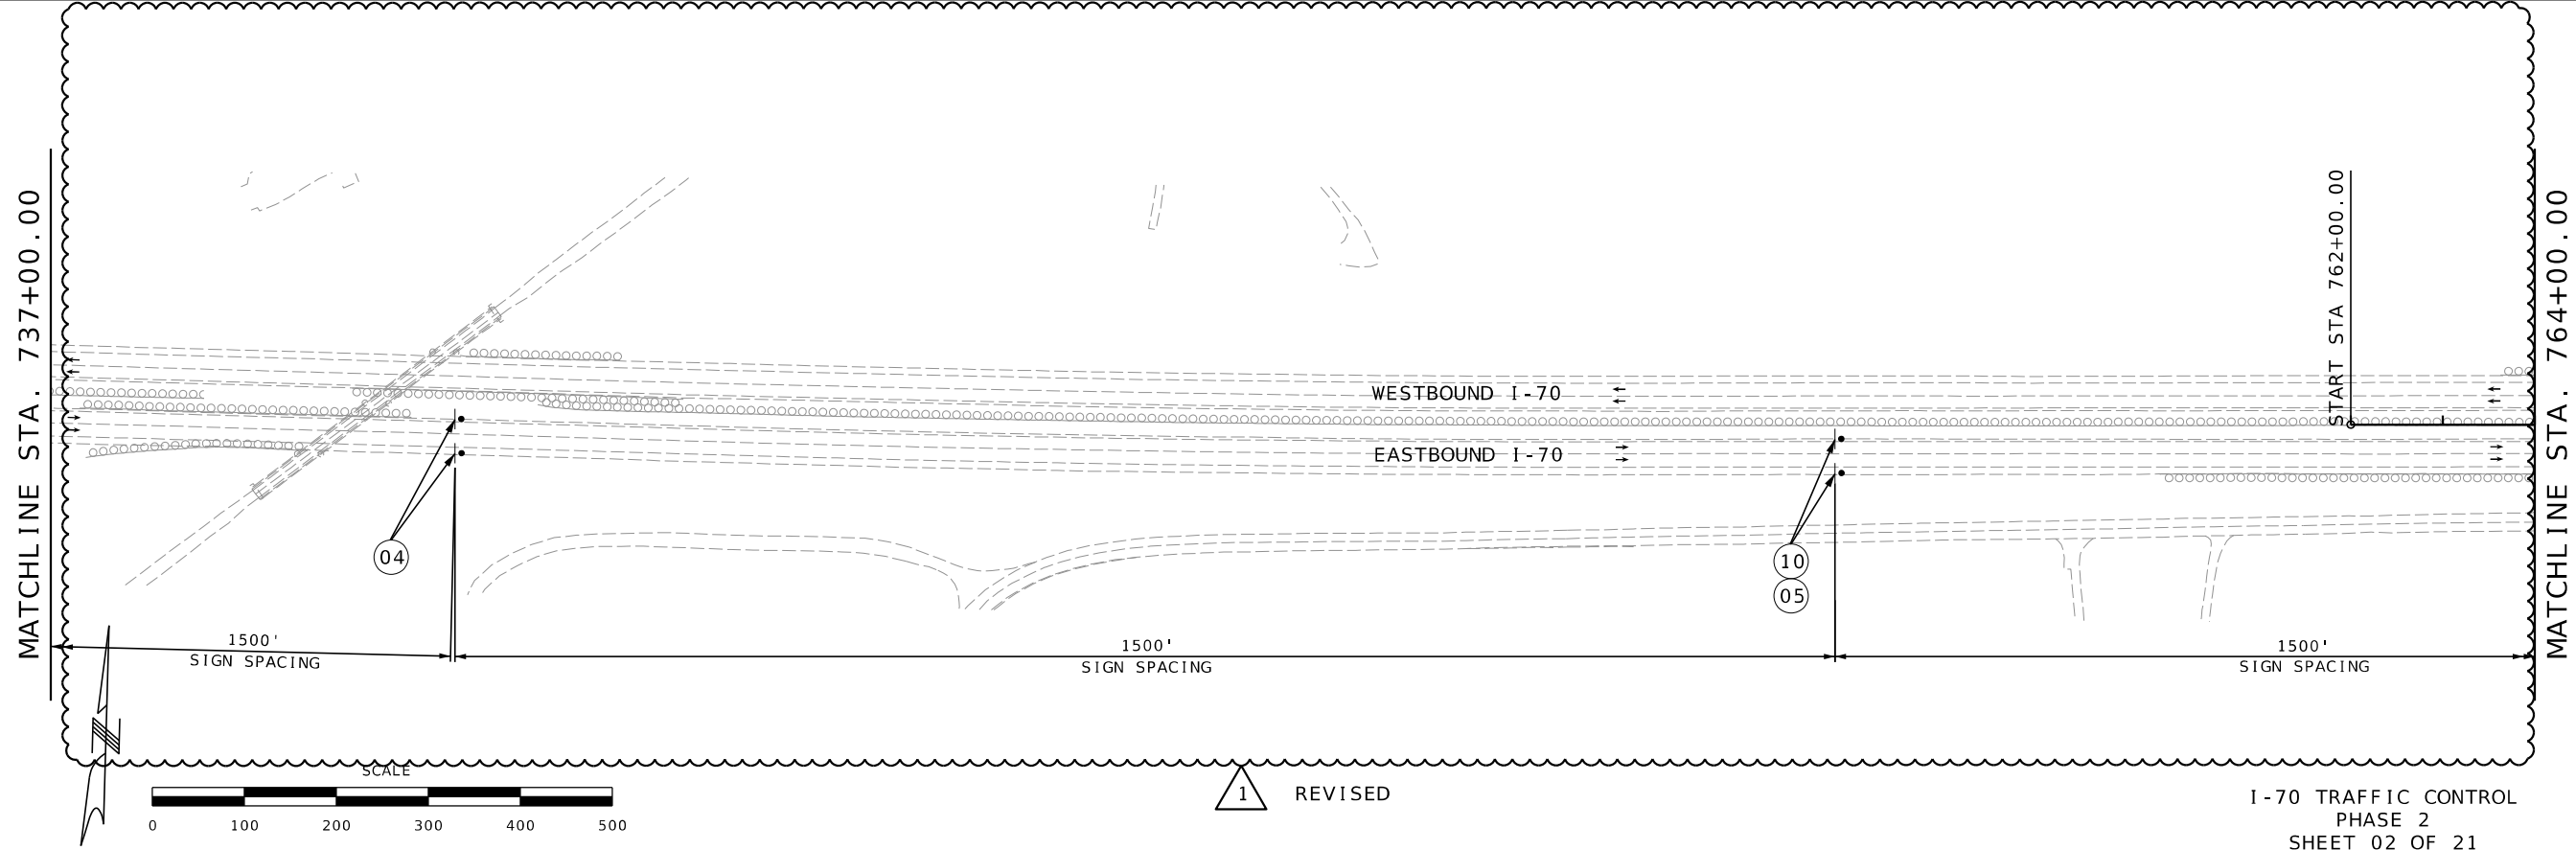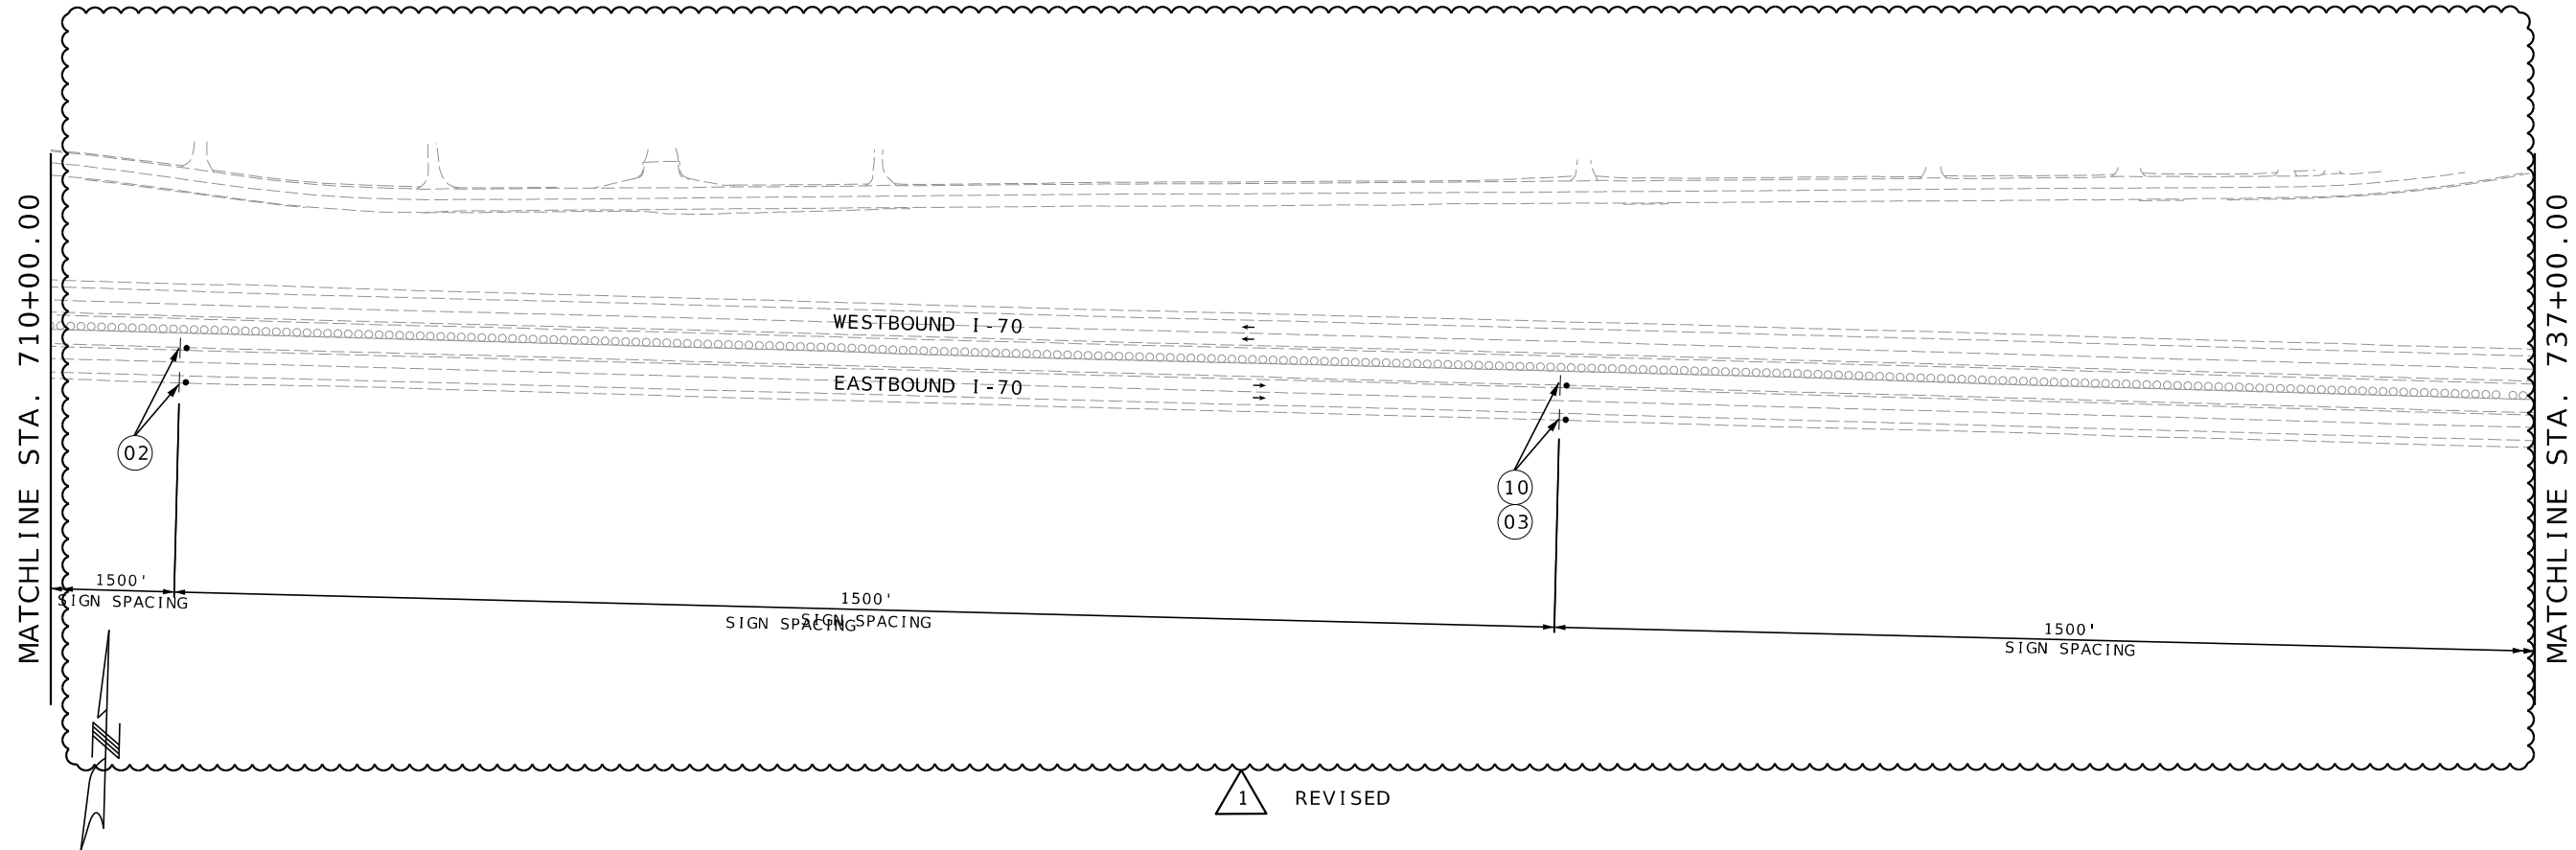

I-70 TRAFFIC CONTROL
PHASE 2
SHEET 02 OF 21

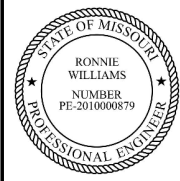

THIS SHEET HAS BEEN
SIGNED, SEALED, AND DATED
ELECTRONICALLY

DATE PREPARED
1/7/2026

ROUTE
I-70

STATE
MO

DISTRICT
CD

SHEET NO.
137

COUNTY
COOPER

JOB NO.
JST0017B

CONTRACT ID.
-

PROJECT NO.
-

BRIDGE NO.
-



DATE	DESCRIPTION
01/07/26	REVISED SIGN LOCATIONS

MISSOURI HIGHWAYS AND TRANSPORTATION
COMMISSION



105 WEST CAPITOL
JEFFERSON CITY, MO 65102
1-888-ASK-MODOT (1-888-275-6636)

**BURNS
MCDONNELL**
9400 Ward Parkway
Kansas City, MO 64114
(816) 333-9400
Certificate of Authority
No. : 000165

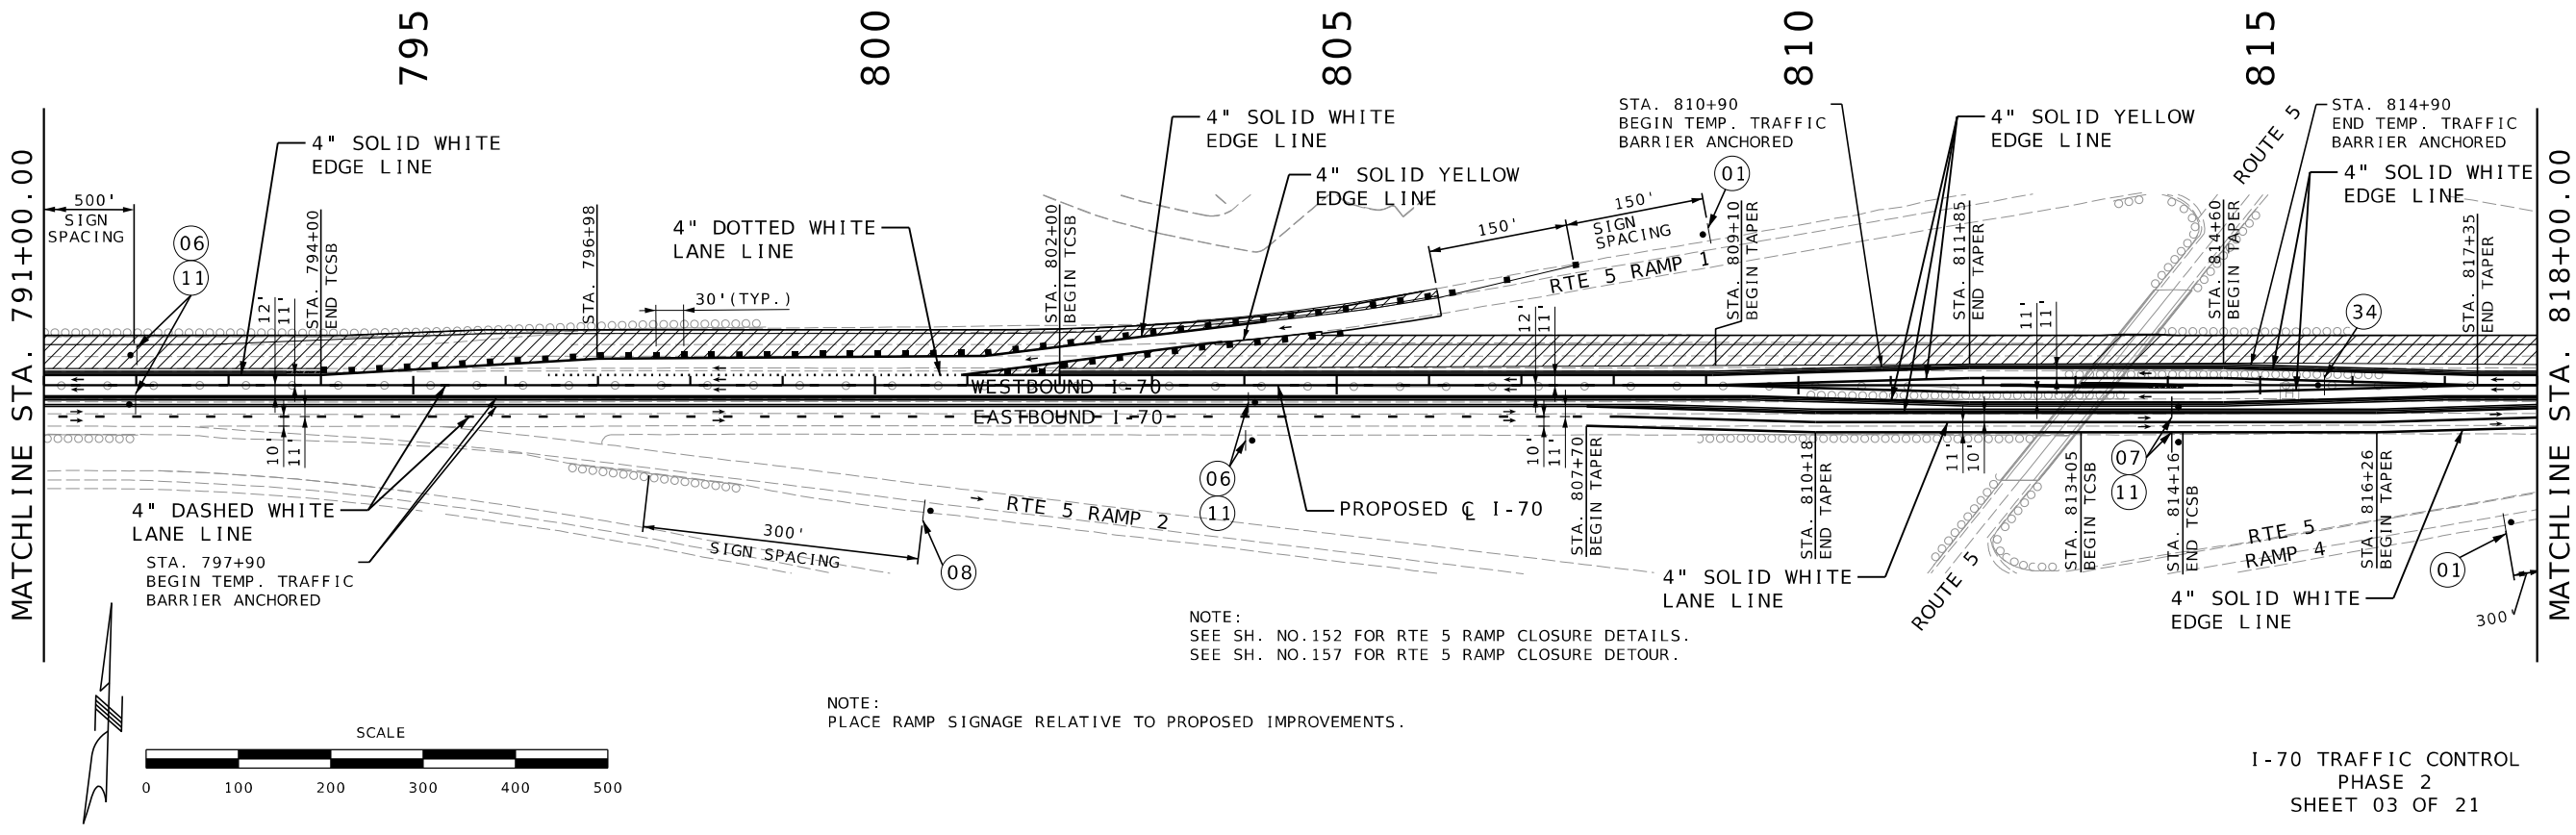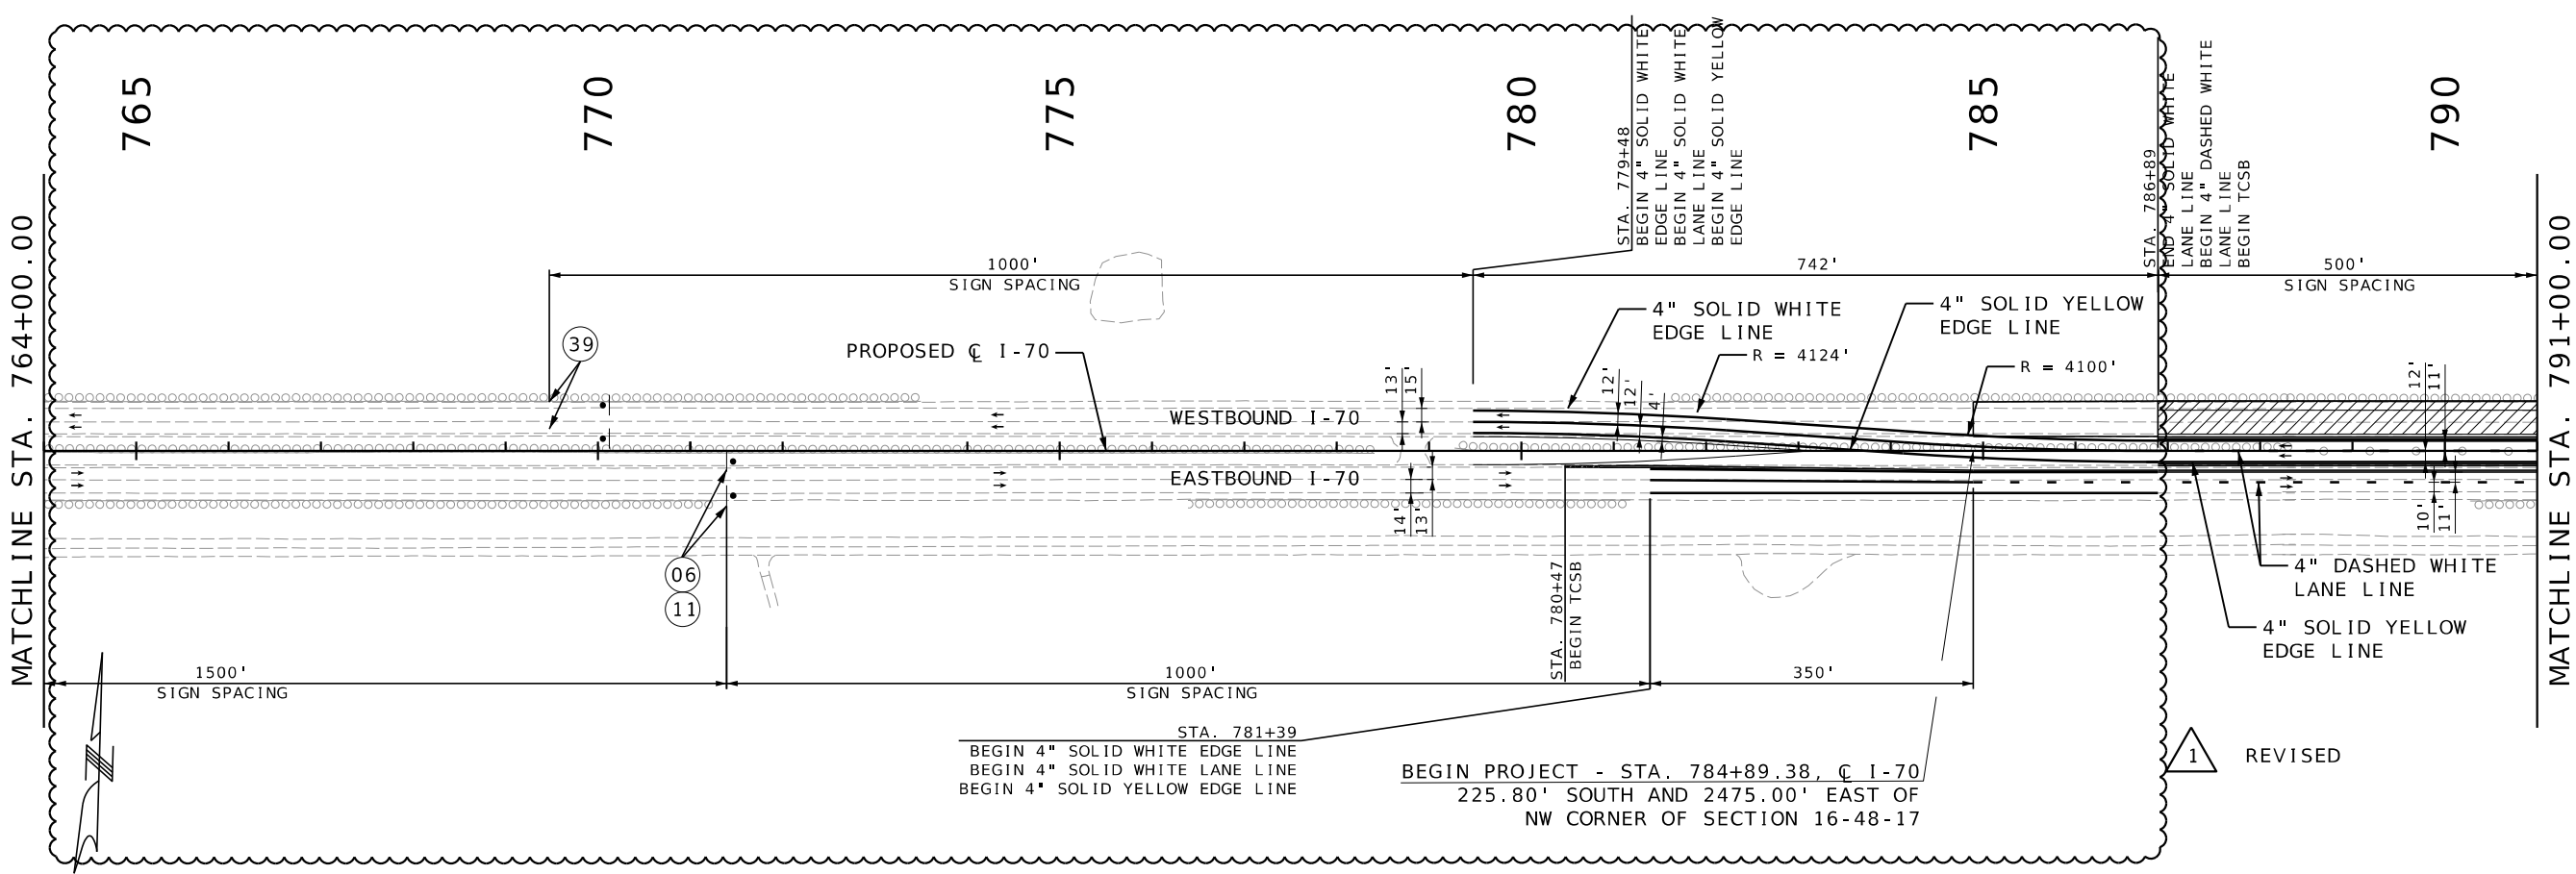

STATE OF MISSOURI

RONNIE WILLIAMS

NUMBER PE-2010000879

PROFESSIONAL ENGINEER

THIS SHEET HAS BEEN SIGNED, SEALED, AND DATED ELECTRONICALLY

DATE PREPARED 1/7/2026

ROUTE 1-70 STATE MO

DISTRICT CD SHEET NO. 138

COUNTY COOPER

JOB NO. JST0017B

CONTRACT ID.

PROJECT NO.

BRIDGE NO.

DESCRIPTION

REVISED LAYOUT & PAVEMENT MARKING

DATE

01/07/26

MISSOURI HIGHWAYS AND TRANSPORTATION COMMISSION

MoDOT


105 WEST CAPITOL JEFFERSON CITY, MO 65102 1-888-ASK-MODOT (1-888-275-6636)

BURNS MCDONNELL

9400 Ward Parkway Kansas City, MO 64114 (816) 333-9400

Certificate of Authority No. : 000165

c:\bmcd_lib\pw_connect\trn\d0185116\138_MOT_Phase 2_JST0017B_I100_1-70.dgn 3:23:00 PM 1/7/2026

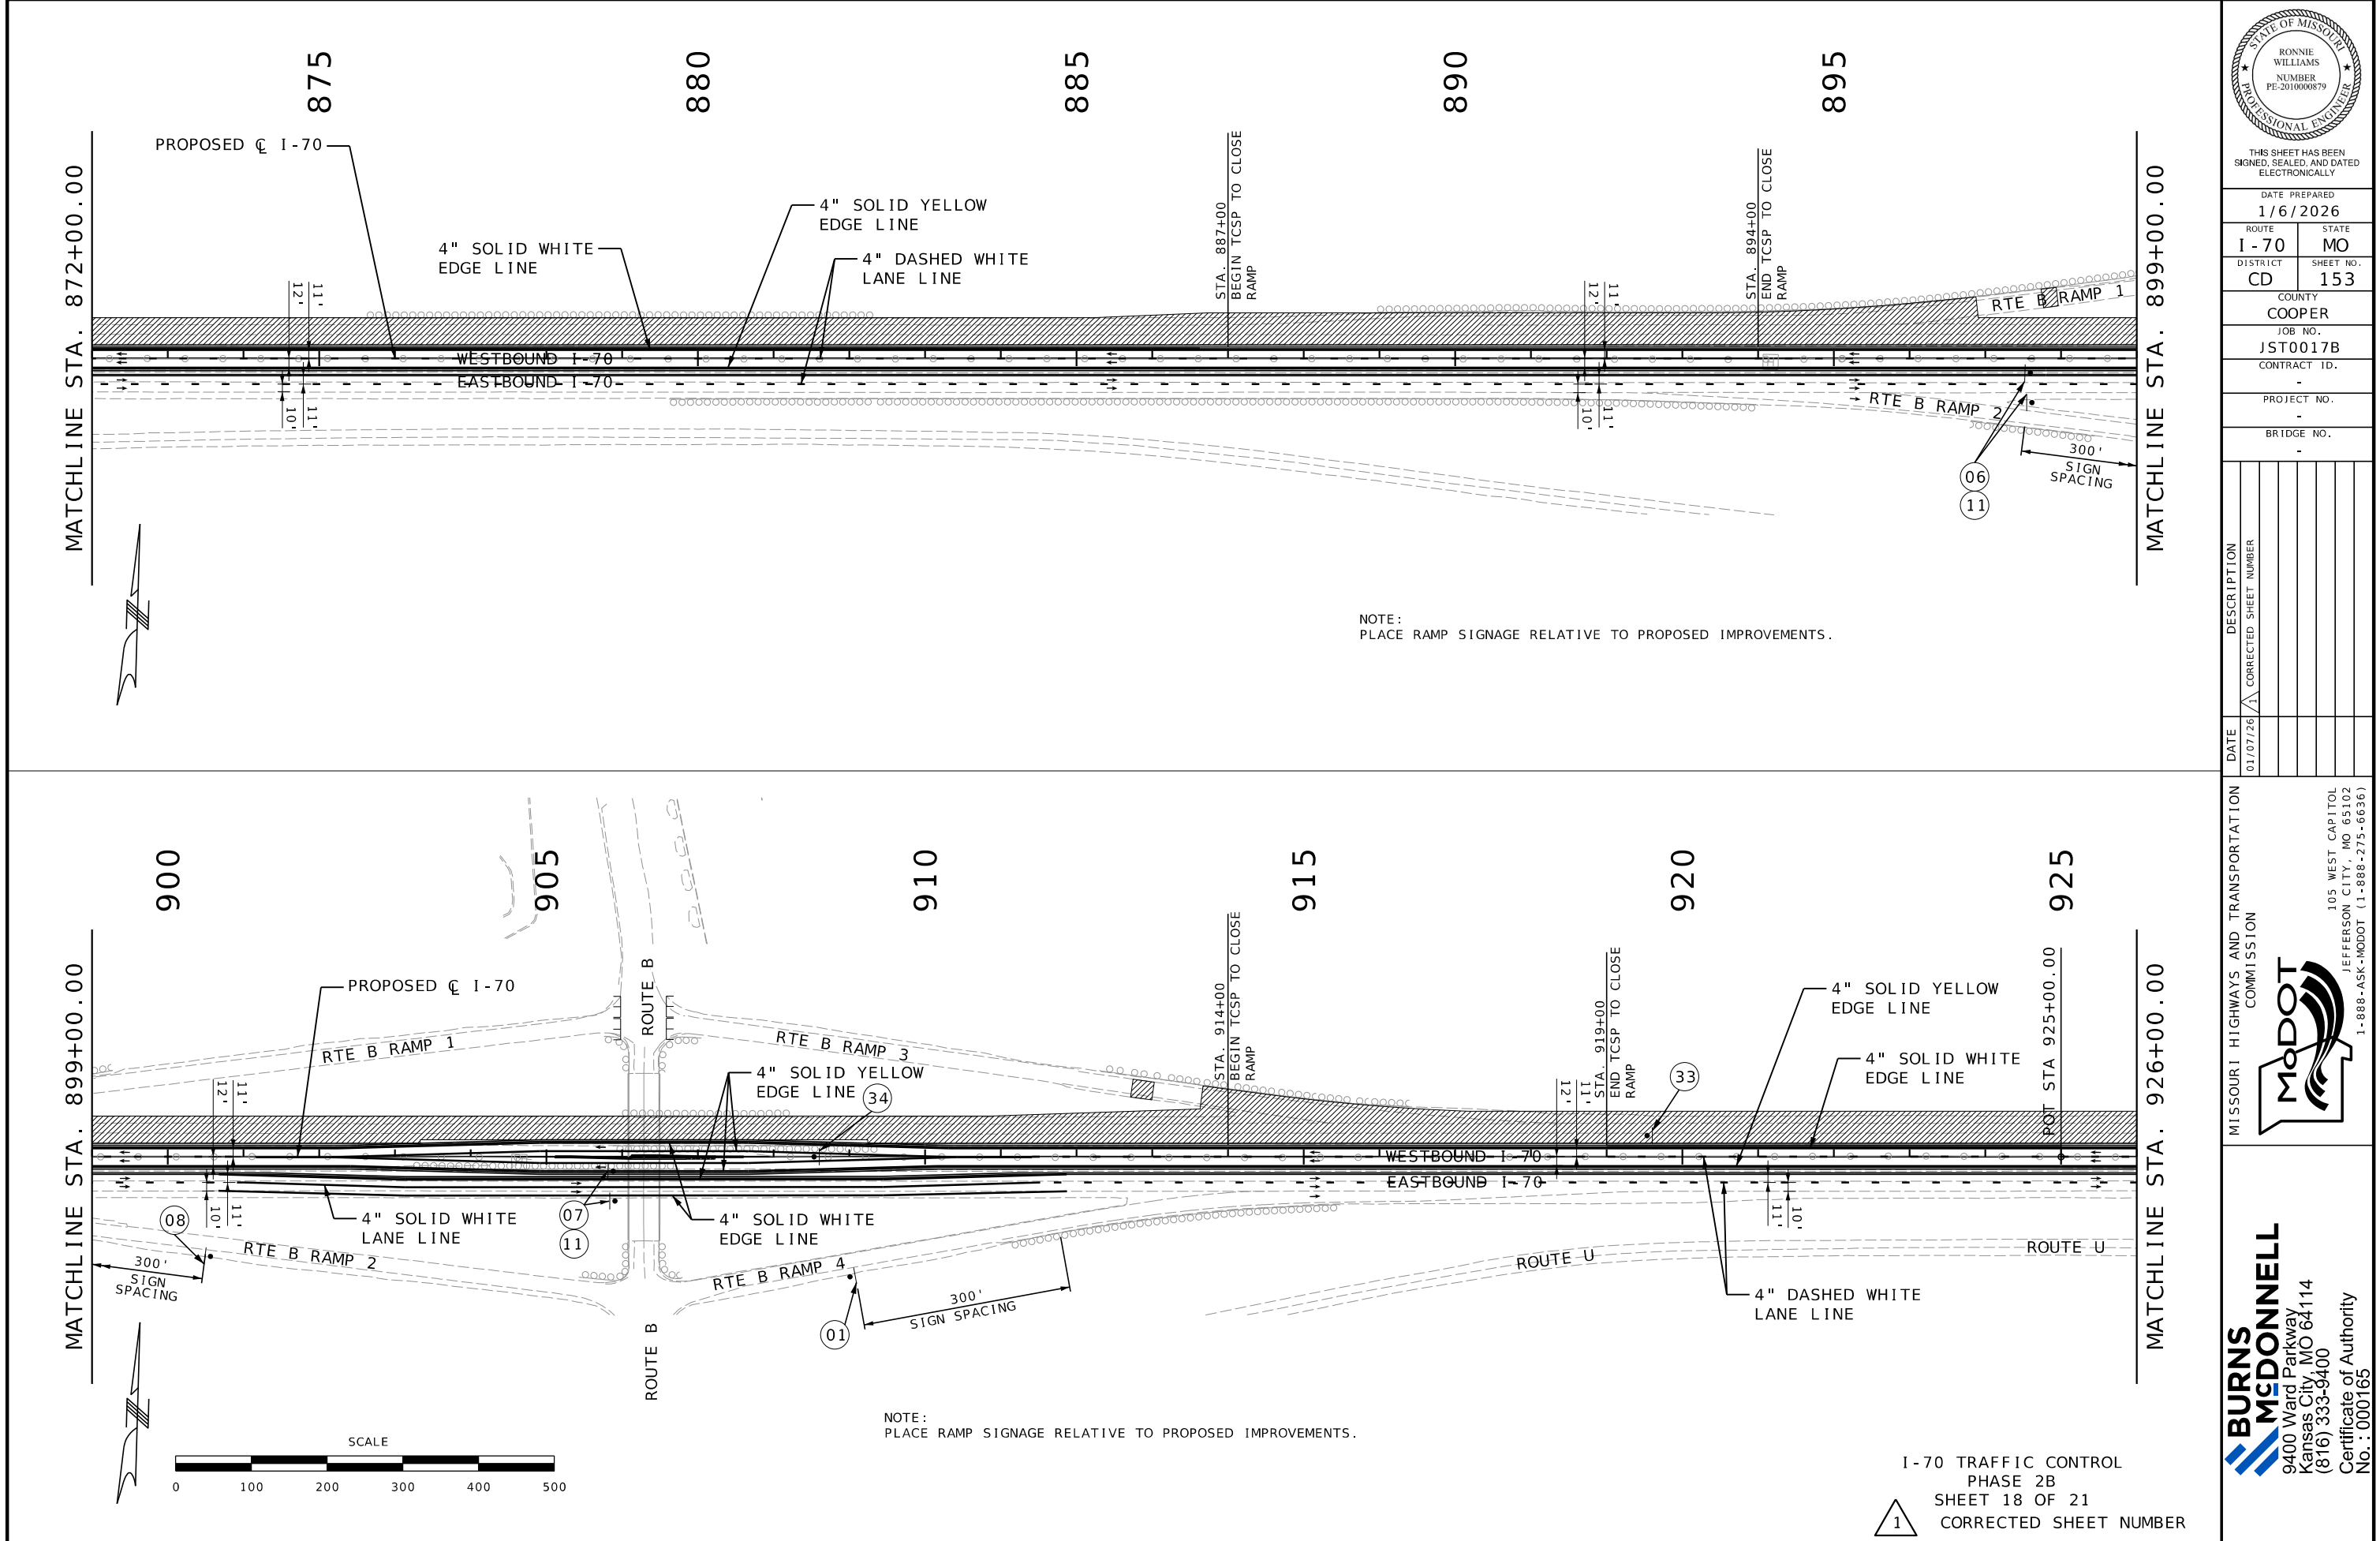

THIS SHEET HAS BEEN
SIGNED, SEALED, AND DATED
ELECTRONICALLY

DATE PREPARED
1/6/2026

ROUTE	STATE
I - 70	MO
DISTRICT	SHEET NO.
CD	153

COUNTY
COOPER
JOB NO.
JST0017B
CONTRACT ID.

PROJECT NO.
-

BRIDGE NO.
-


DATE	DESCRIPTION
01/07/26	CORRECTED SHEET NUMBER

MISSOURI HIGHWAYS AND TRANSPORTATION
COMMISSION

105 WEST CAPITOL
JEFFERSON CITY, MO 65102
1-888-ASK-MODOT (1-888-275-6636)

**BURNS
MCDONNELL**
9400 Ward Parkway
Kansas City, MO 64114
(816) 333-9400
Certificate of Authority
No. : 000165

I-70 TRAFFIC CONTROL
PHASE 2B
SHEET 18 OF 21
CORRECTED SHEET NUMBER
1

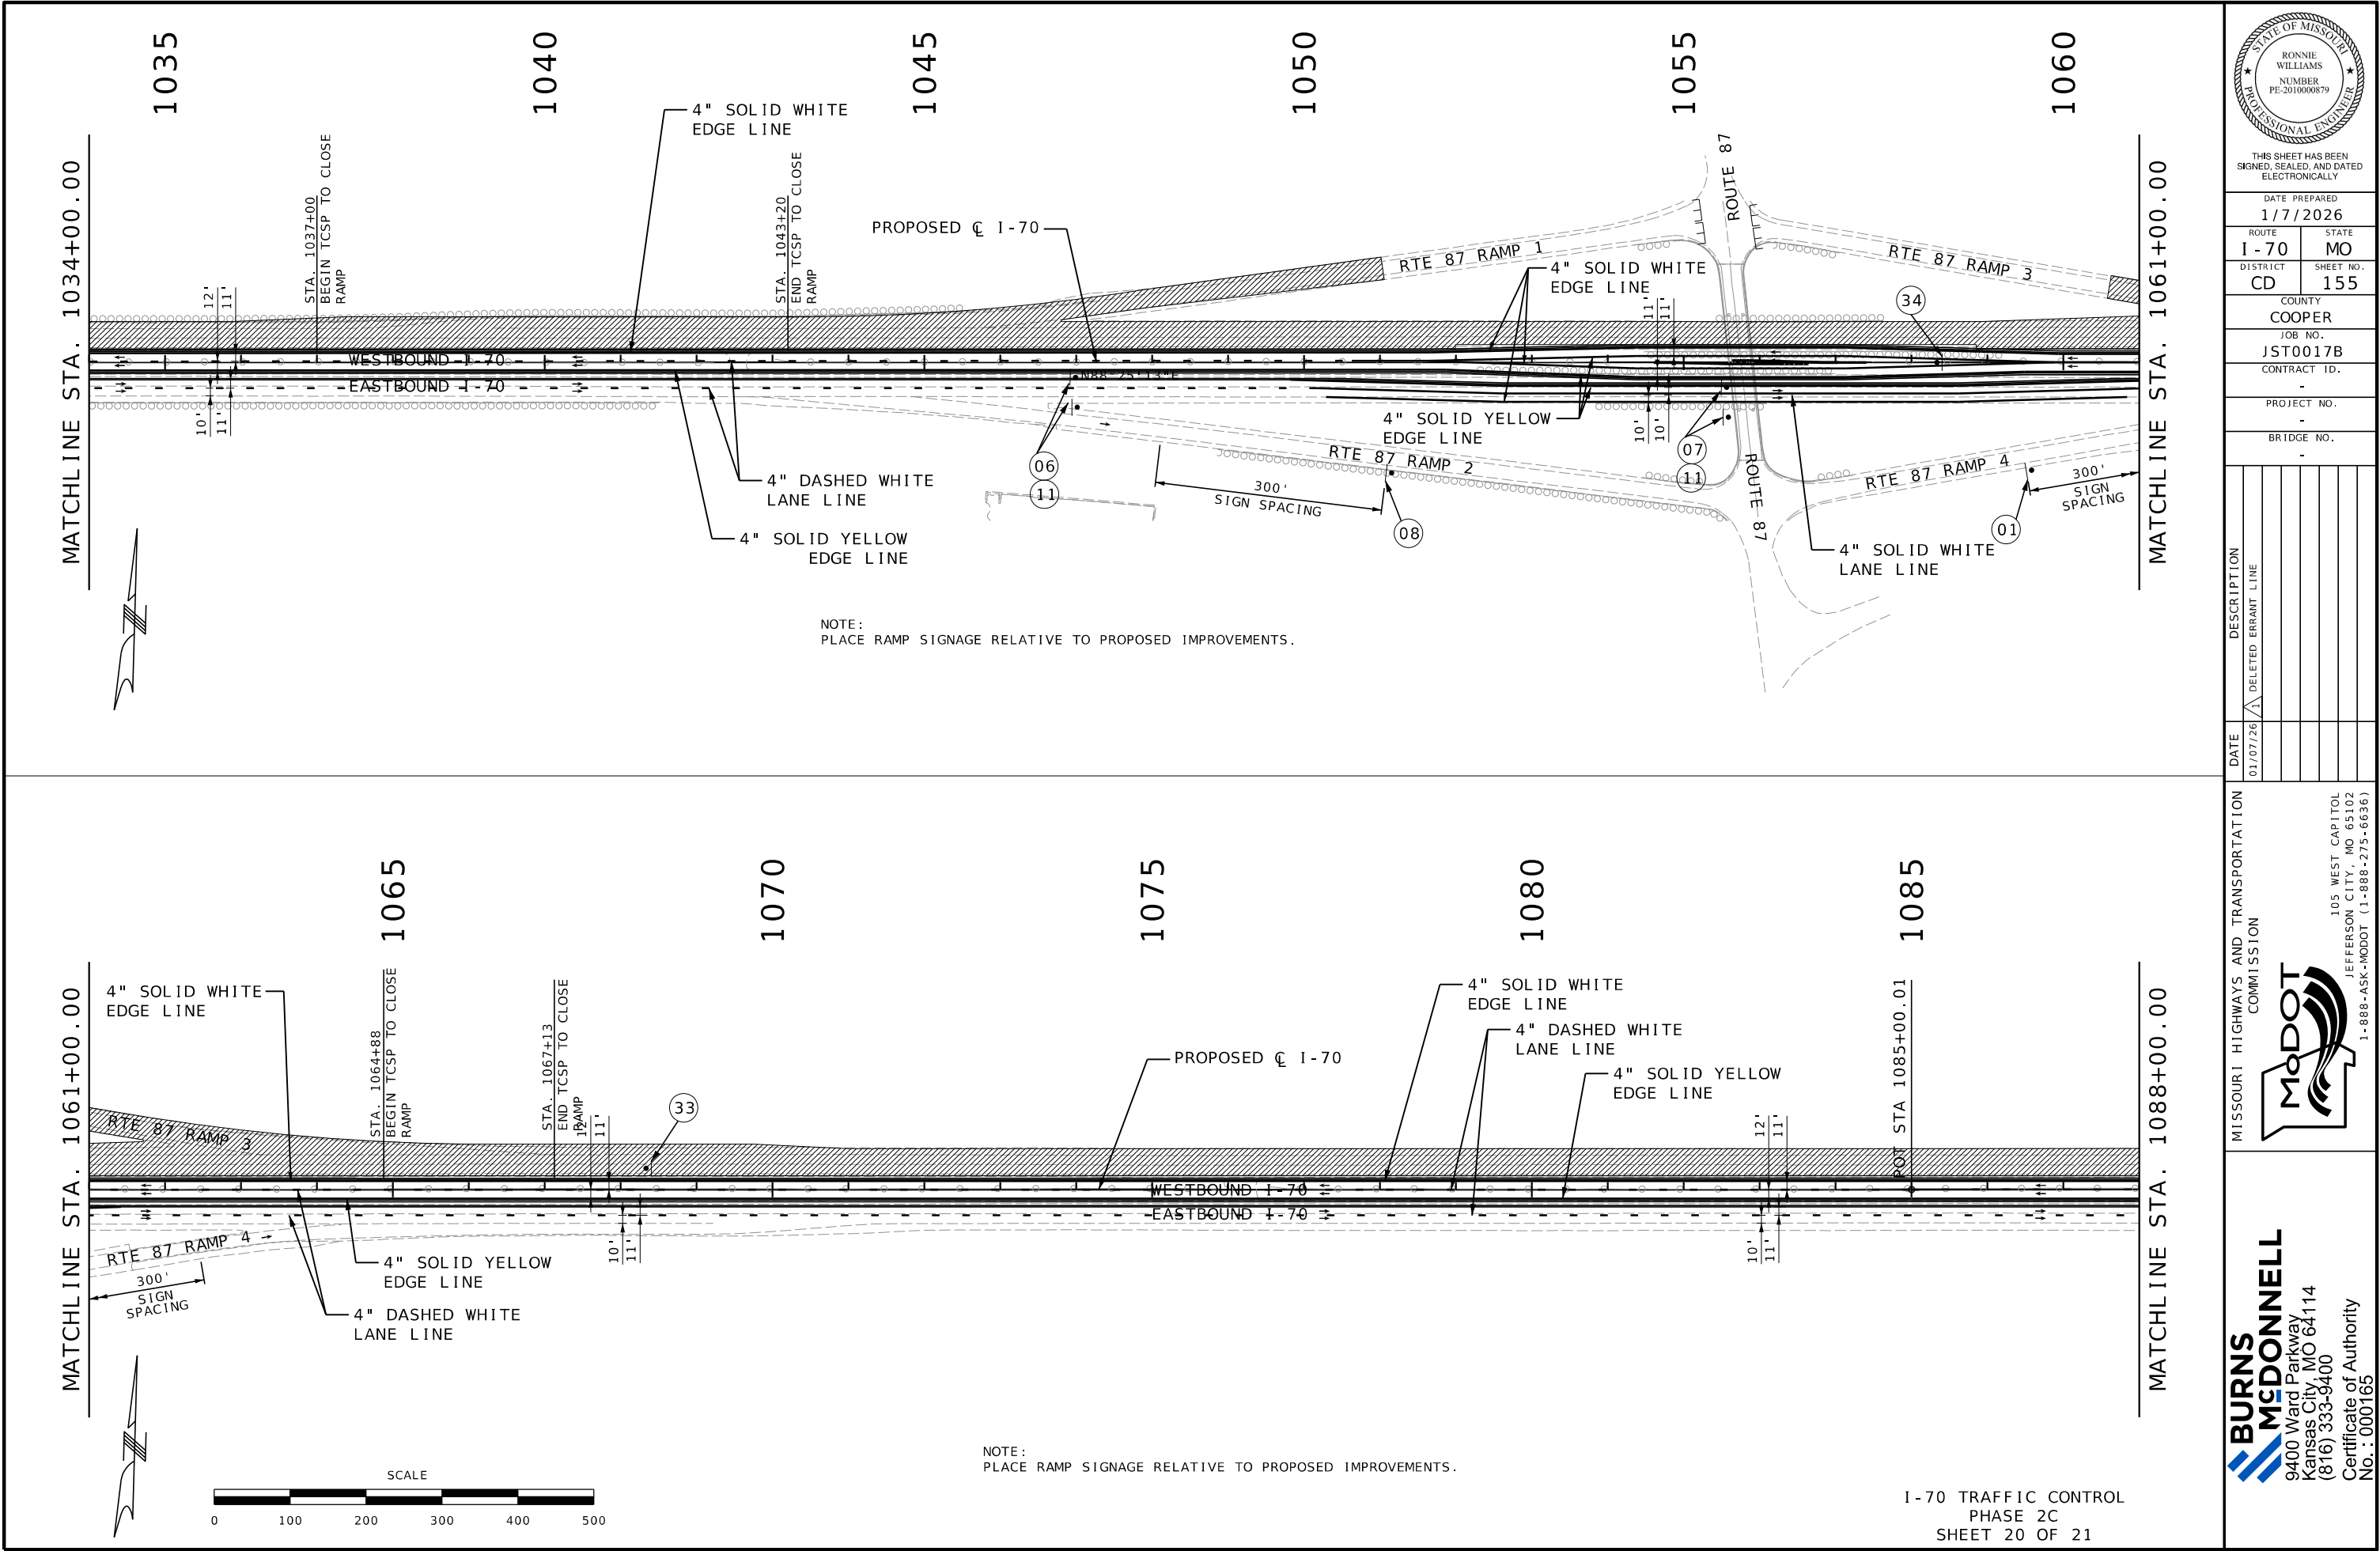

THIS SHEET HAS BEEN
SIGNED, SEALED, AND DATED
ELECTRONICALLY

DATE PREPARED
1/7/2026

ROUTE	STATE
I-70	MO
DISTRICT	SHEET NO.
CD	155

COUNTY
COOPER
JOB NO.
JST0017B
CONTRACT ID.

PROJECT NO.
BRIDGE NO.


DATE	DESCRIPTION
01/07/26	DELETED ERRANT LINE

MISSOURI HIGHWAYS AND TRANSPORTATION
COMMISSION

105 WEST CAPITOL
JEFFERSON CITY, MO 65102
1-888-ASK-MODOT (1-888-273-6636)

**BURNS
MCDONNELL**
9400 Ward Parkway
Kansas City, MO 64114
(816) 333-9400
Certificate of Authority
No. : 000165

I-70 TRAFFIC CONTROL
PHASE 2C
SHEET 20 OF 21

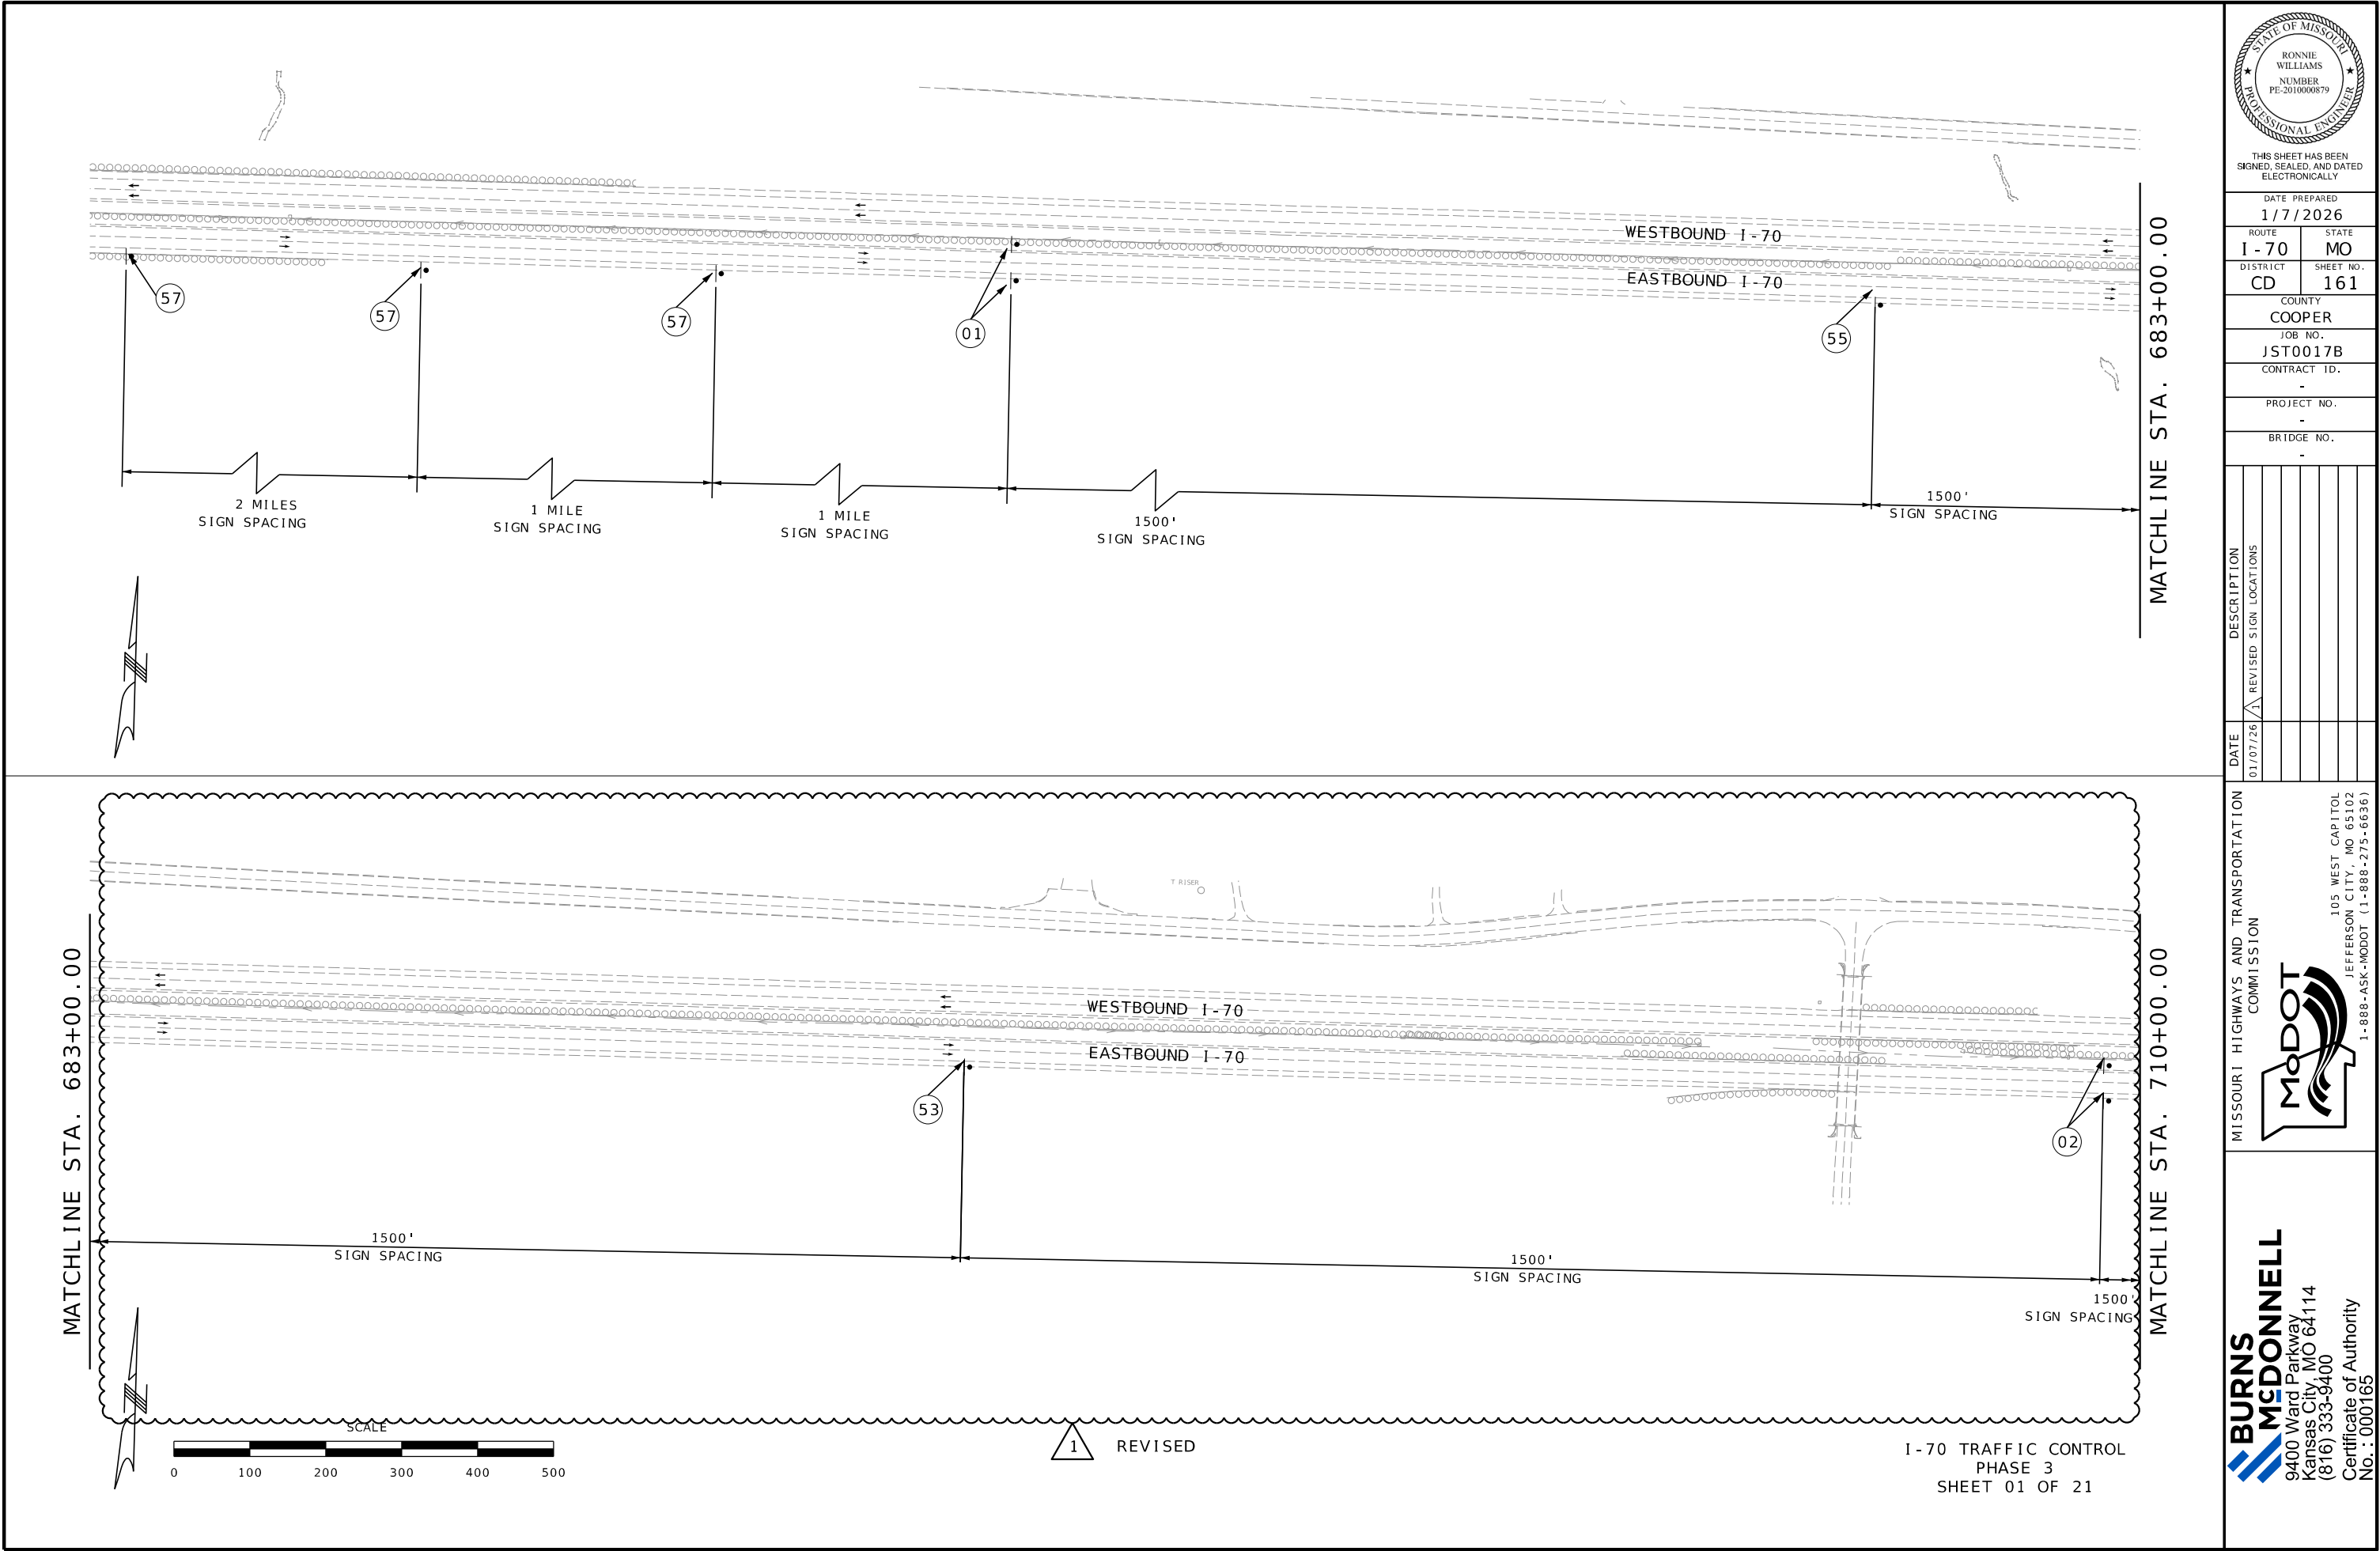

THIS SHEET HAS BEEN
SIGNED, SEALED, AND DATED
ELECTRONICALLY

DATE PREPARED
1/7/2026

ROUTE
I-70

STATE
MO

DISTRICT
CD

SHEET NO.
161

COUNTY
COOPER

JOB NO.
JST0017B

CONTRACT ID.
-

PROJECT NO.
-

BRIDGE NO.
-

DATE	DESCRIPTION
01/07/26	REVISED SIGN LOCATIONS


MISSOURI HIGHWAYS AND TRANSPORTATION
COMMISSION

MoDOT

105 WEST CAPITOL
JEFFERSON CITY, MO 65102
1-888-ASK-MODOT (1-888-273-6636)

**BURNS
MCDONNELL**

9400 Ward Parkway
Kansas City, MO 64114
(816) 333-9400
Certificate of Authority
No. : 000165

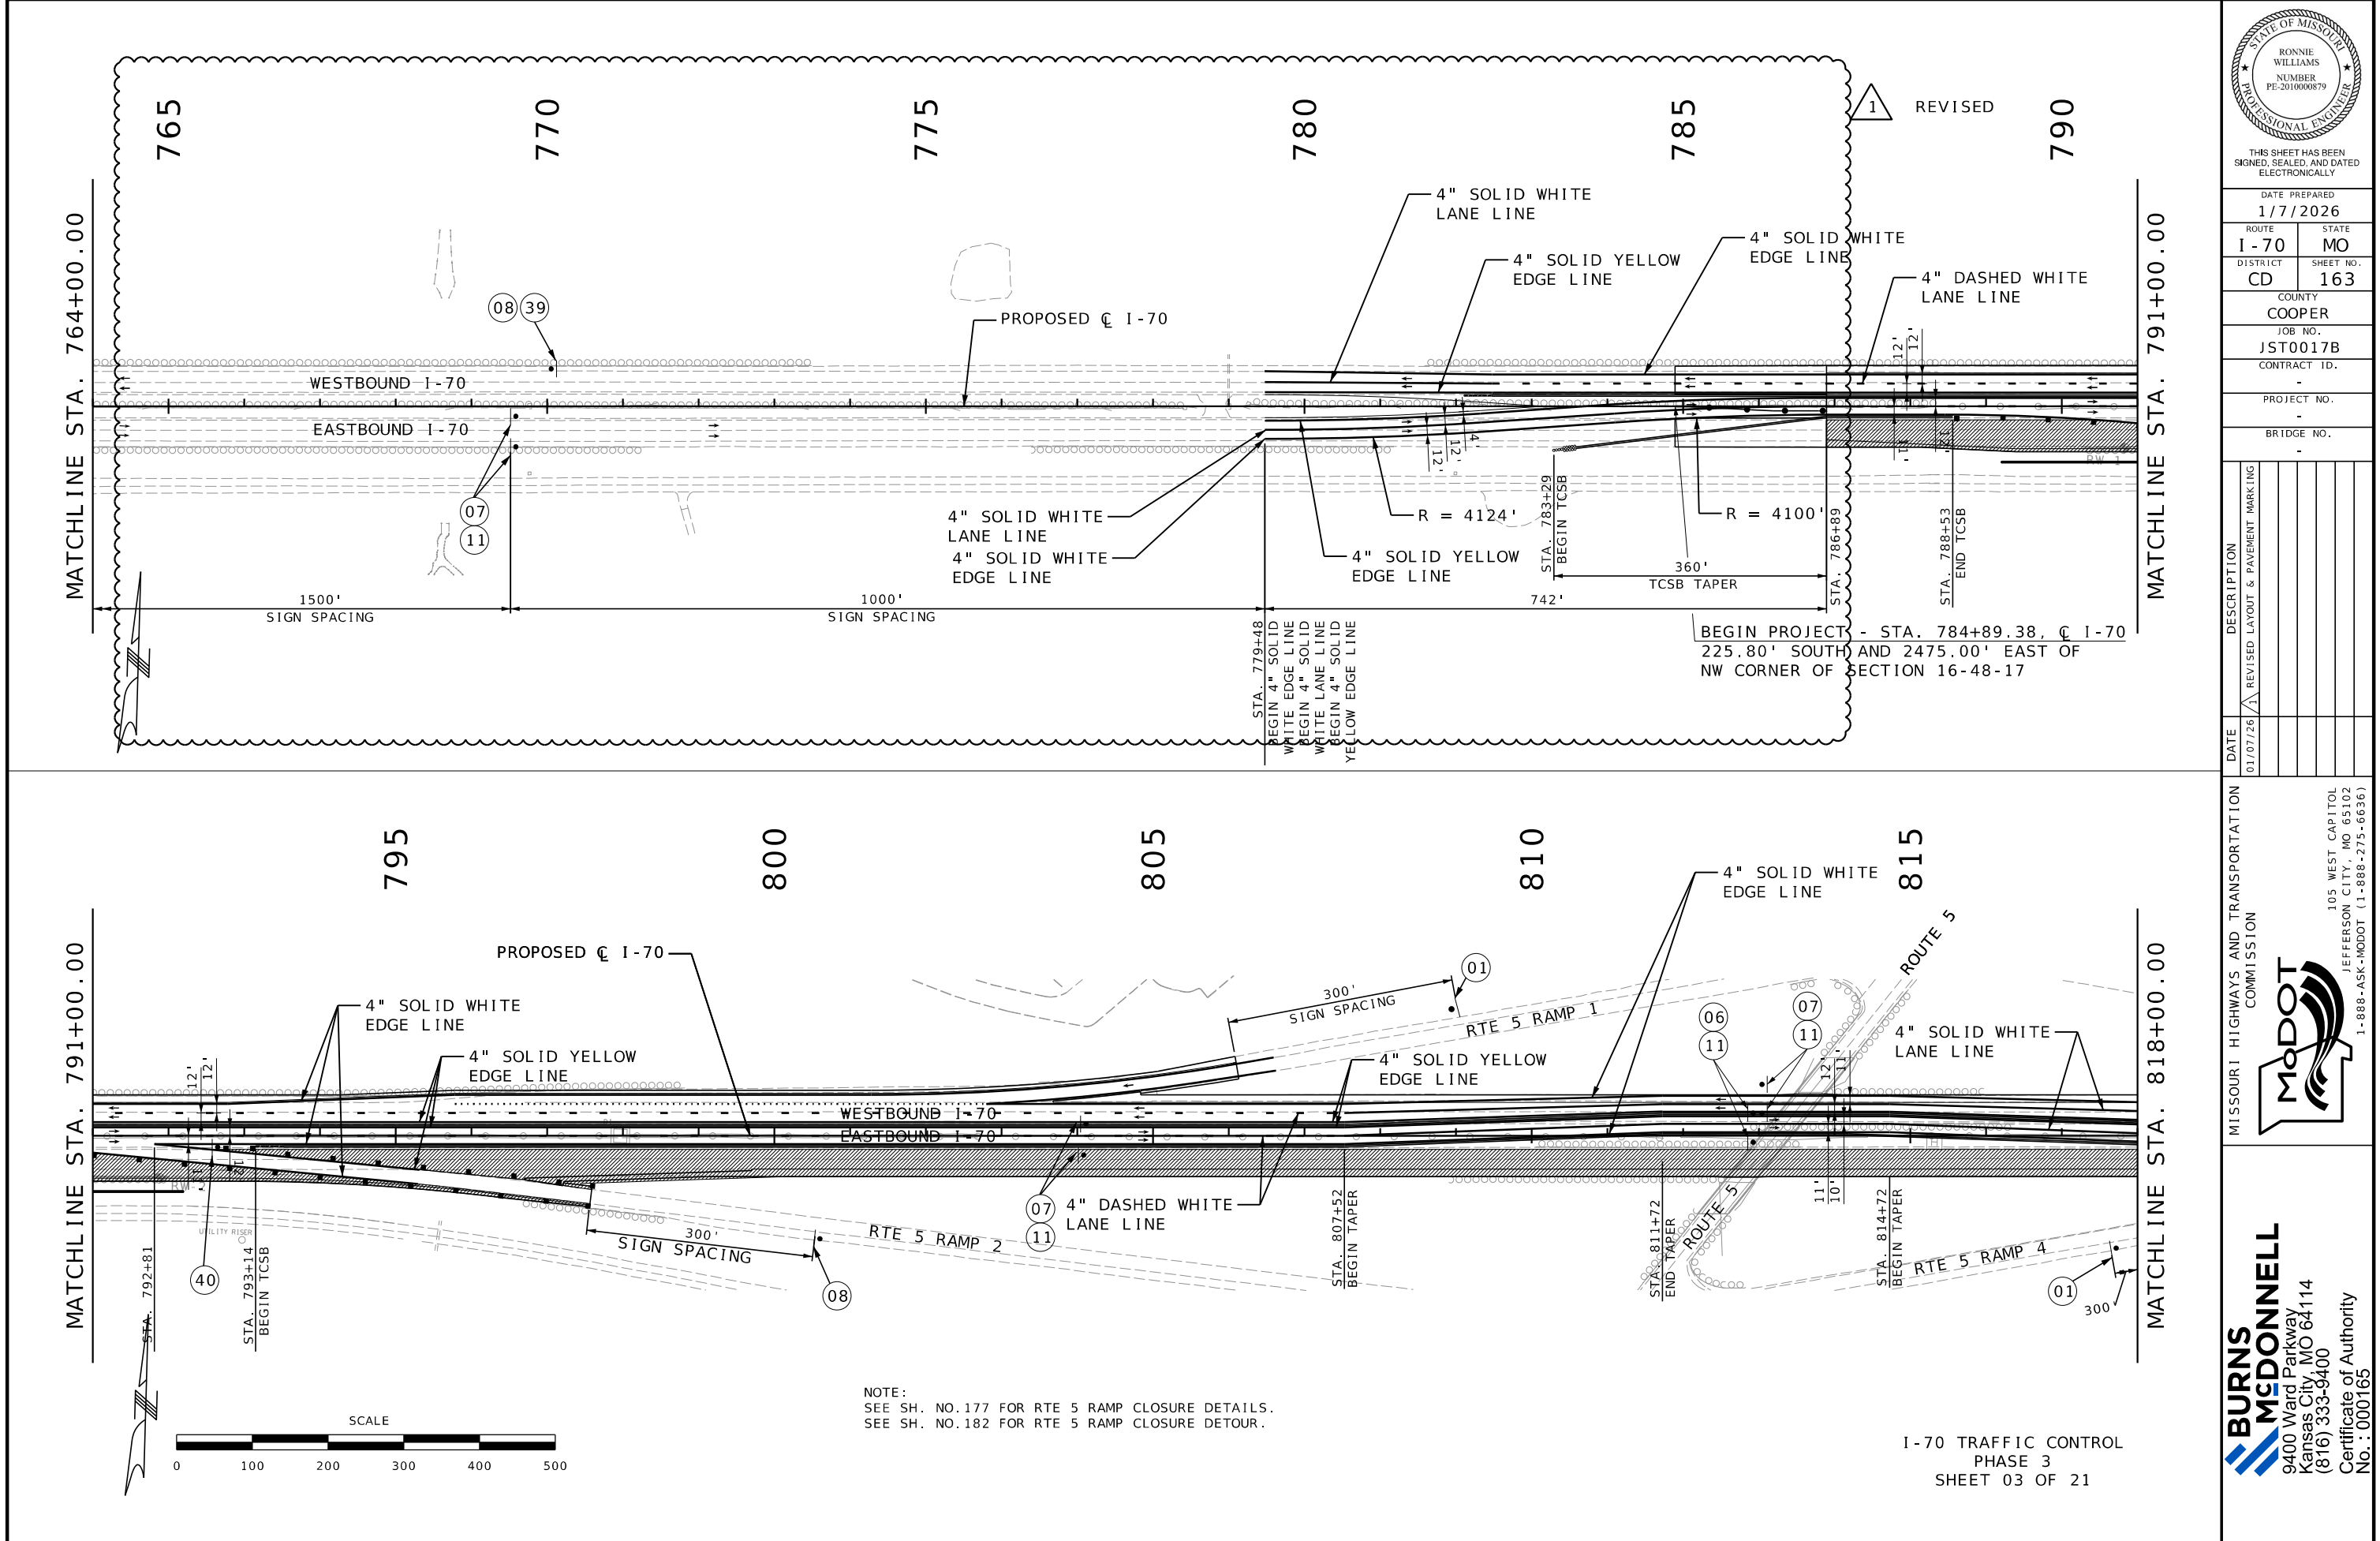

THIS SHEET HAS BEEN
SIGNED, SEALED, AND DATED
ELECTRONICALLY

DATE PREPARED
1/7/2026

ROUTE 1-70 STATE MO

DISTRICT CD SHEET NO. 163

COUNTY COOPER

JOB NO. JST0017B

CONTRACT ID.

PROJECT NO.

BRIDGE NO.


DATE	DESCRIPTION
01/07/26	REVISED LAYOUT & PAVEMENT MARKING

MISSOURI HIGHWAYS AND TRANSPORTATION
COMMISSION

105 WEST CAPITOL
JEFFERSON CITY, MO 65102
1-888-ASK-MODOT (1-888-275-6636)

**BURNS
MCDONNELL**

9400 Ward Parkway
Kansas City, MO 64114
(816) 333-9400
Certificate of Authority
No. : 000165

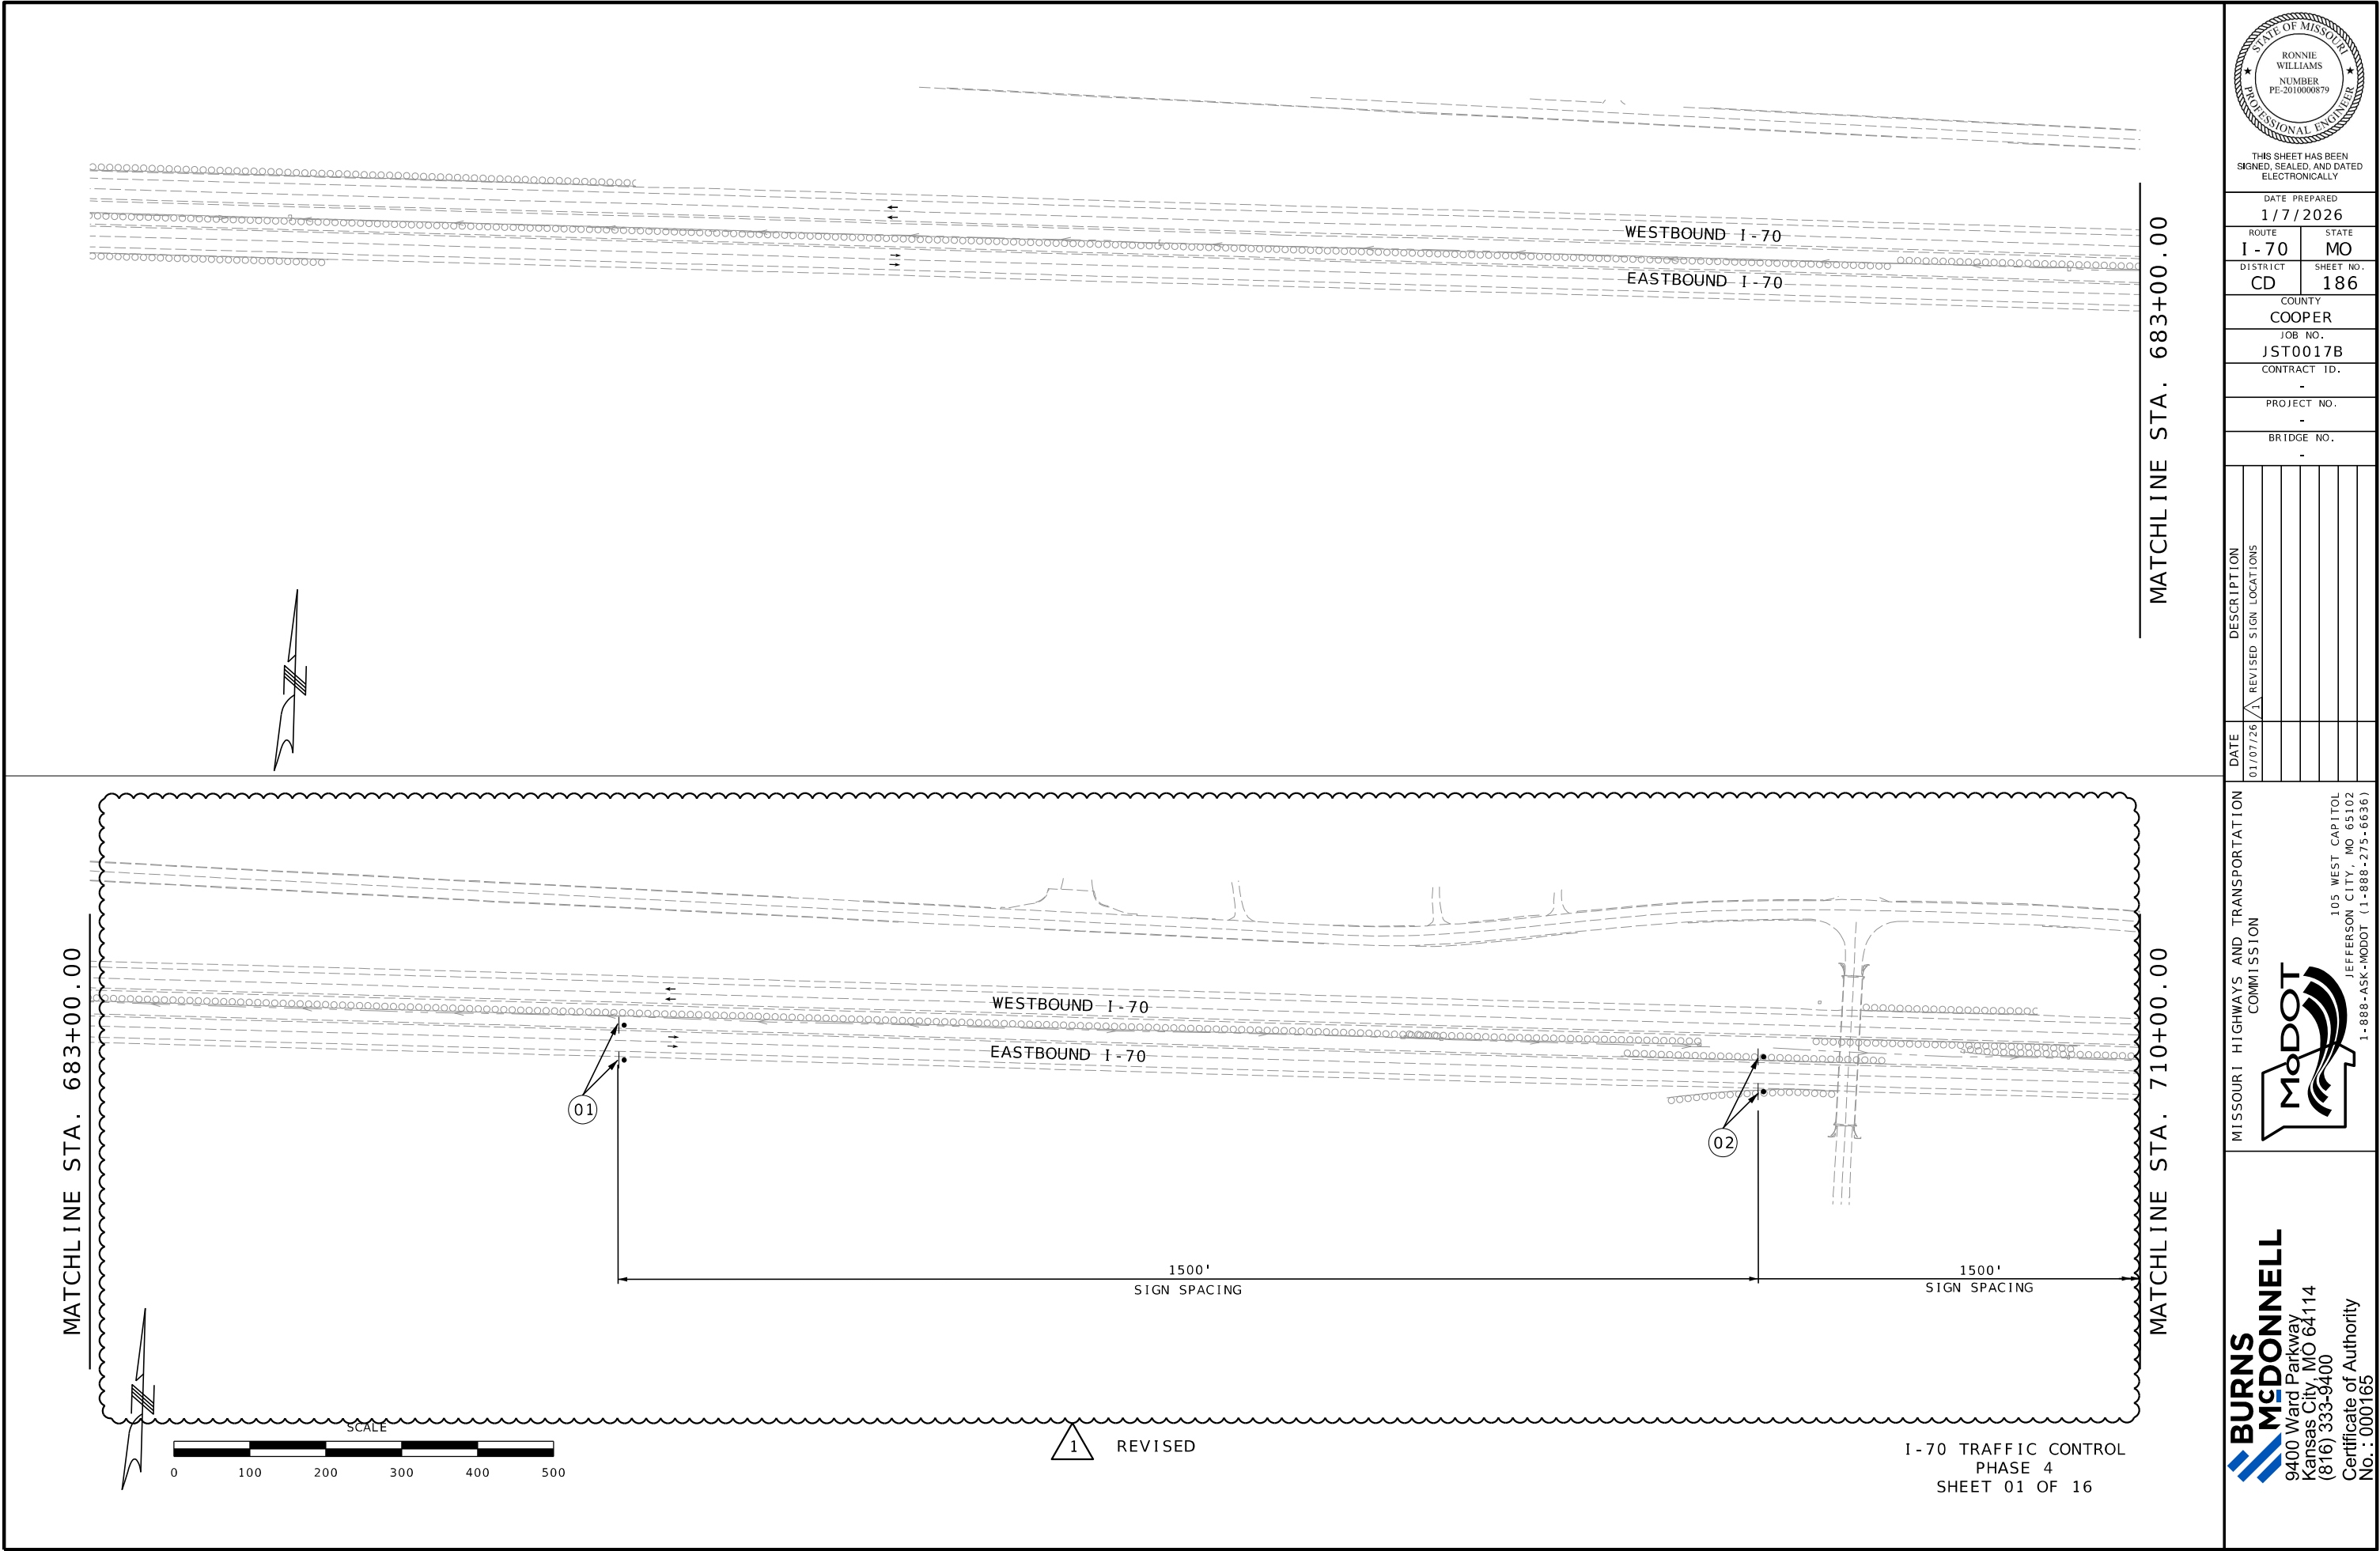

THIS SHEET HAS BEEN
SIGNED, SEALED, AND DATED
ELECTRONICALLY

DATE PREPARED
1/7/2026

ROUTE I-70	STATE MO
DISTRICT CD	SHEET NO. 186

COUNTY
COOPER

JOB NO.
JST0017B

CONTRACT ID.
-

PROJECT NO.
-

BRIDGE NO.
-

DATE	DESCRIPTION
01/07/26	REVISED SIGN LOCATIONS


MISSOURI HIGHWAYS AND TRANSPORTATION
COMMISSION

MoDOT

105 WEST CAPITOL
JEFFERSON CITY, MO 65102
1-888-ASK-MODOT (1-888-273-6636)

**BURNS
MCDONNELL**

9400 Ward Parkway
Kansas City, MO 64114
(816) 333-9400
Certificate of Authority
No. : 000165

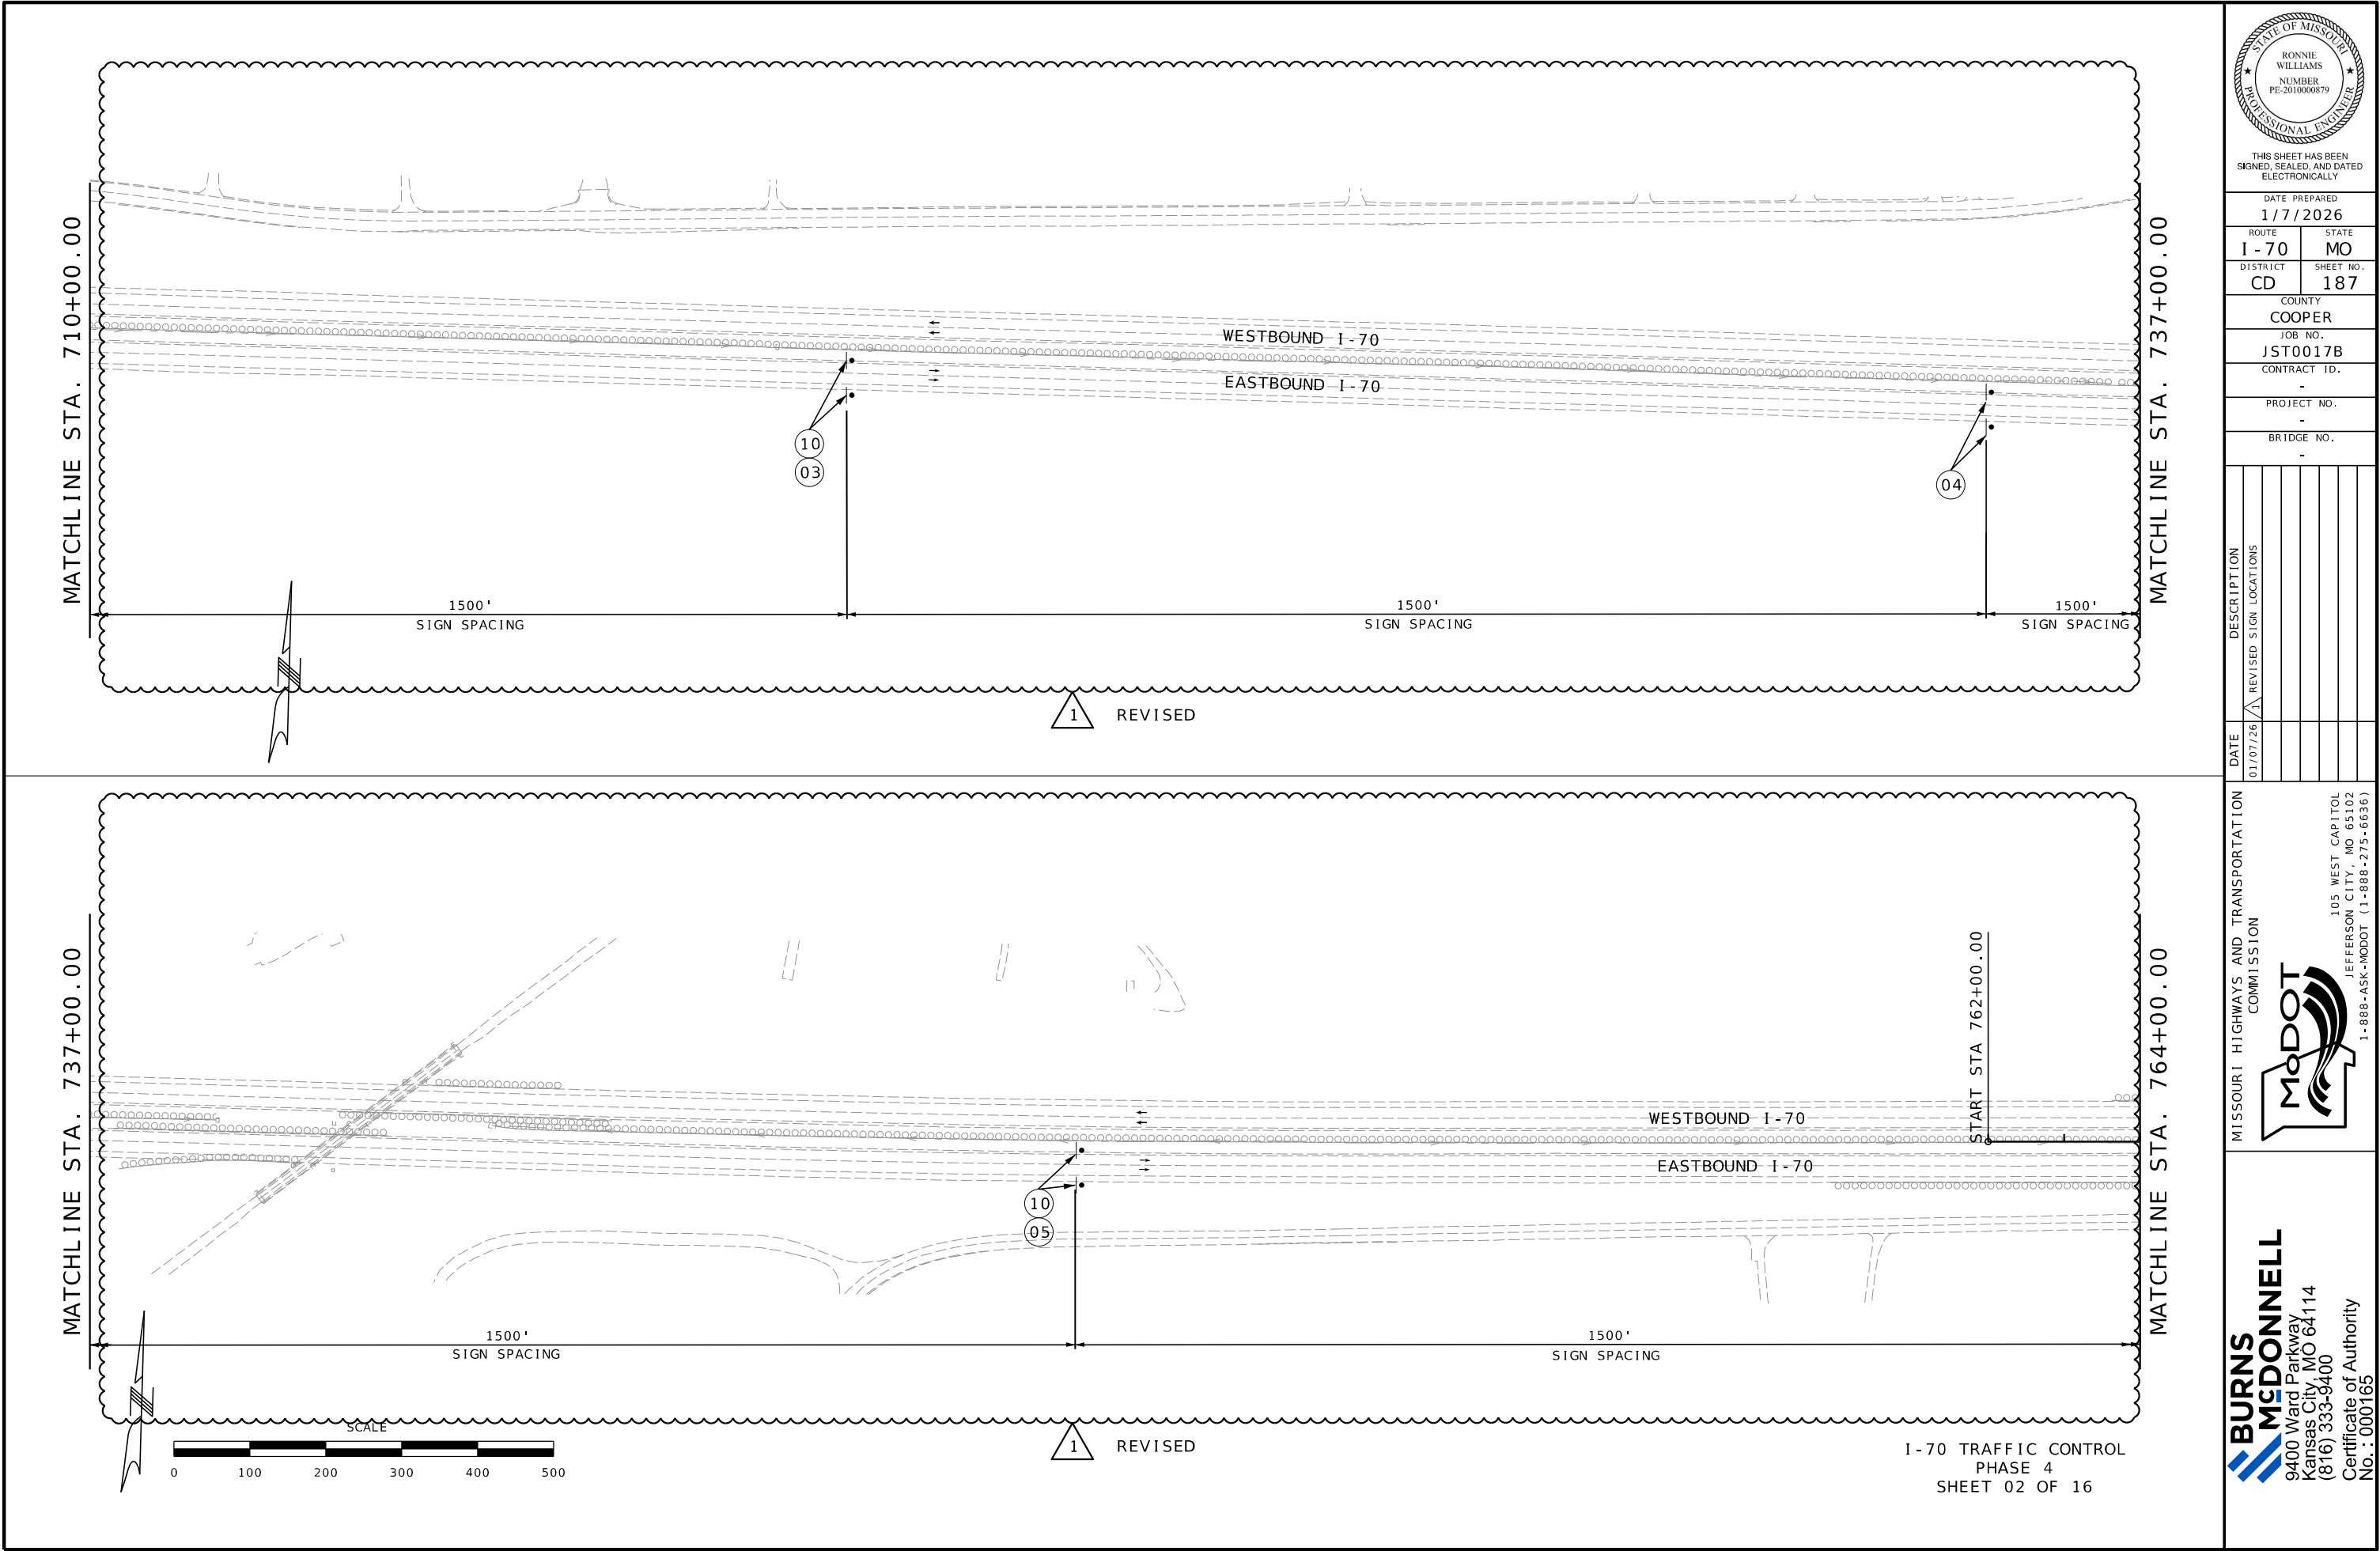

THIS SHEET HAS BEEN
SIGNED, SEALED, AND DATED
ELECTRONICALLY

DATE PREPARED
1/7/2026

ROUTE 1 - 70	STATE MO
DISTRICT CD	SHEET NO. 187

COUNTY
COOPER

JOB NO.
JST0017B

CONTRACT ID.
-

PROJECT NO.
-

BRIDGE NO.
-

DATE	DESCRIPTION
01/07/26	REVISED SIGN LOCATIONS


MISSOURI HIGHWAYS AND TRANSPORTATION
COMMISSION



105 WEST CAPITOL
JEFFERSON CITY, MO 65102
1-888-ASK-MODOT (1-888-275-6636)

**BURNS
MCDONNELL**

9400 Ward Parkway
Kansas City, MO 64114
(816) 333-9400
Certificate of Authority
No. : 000165

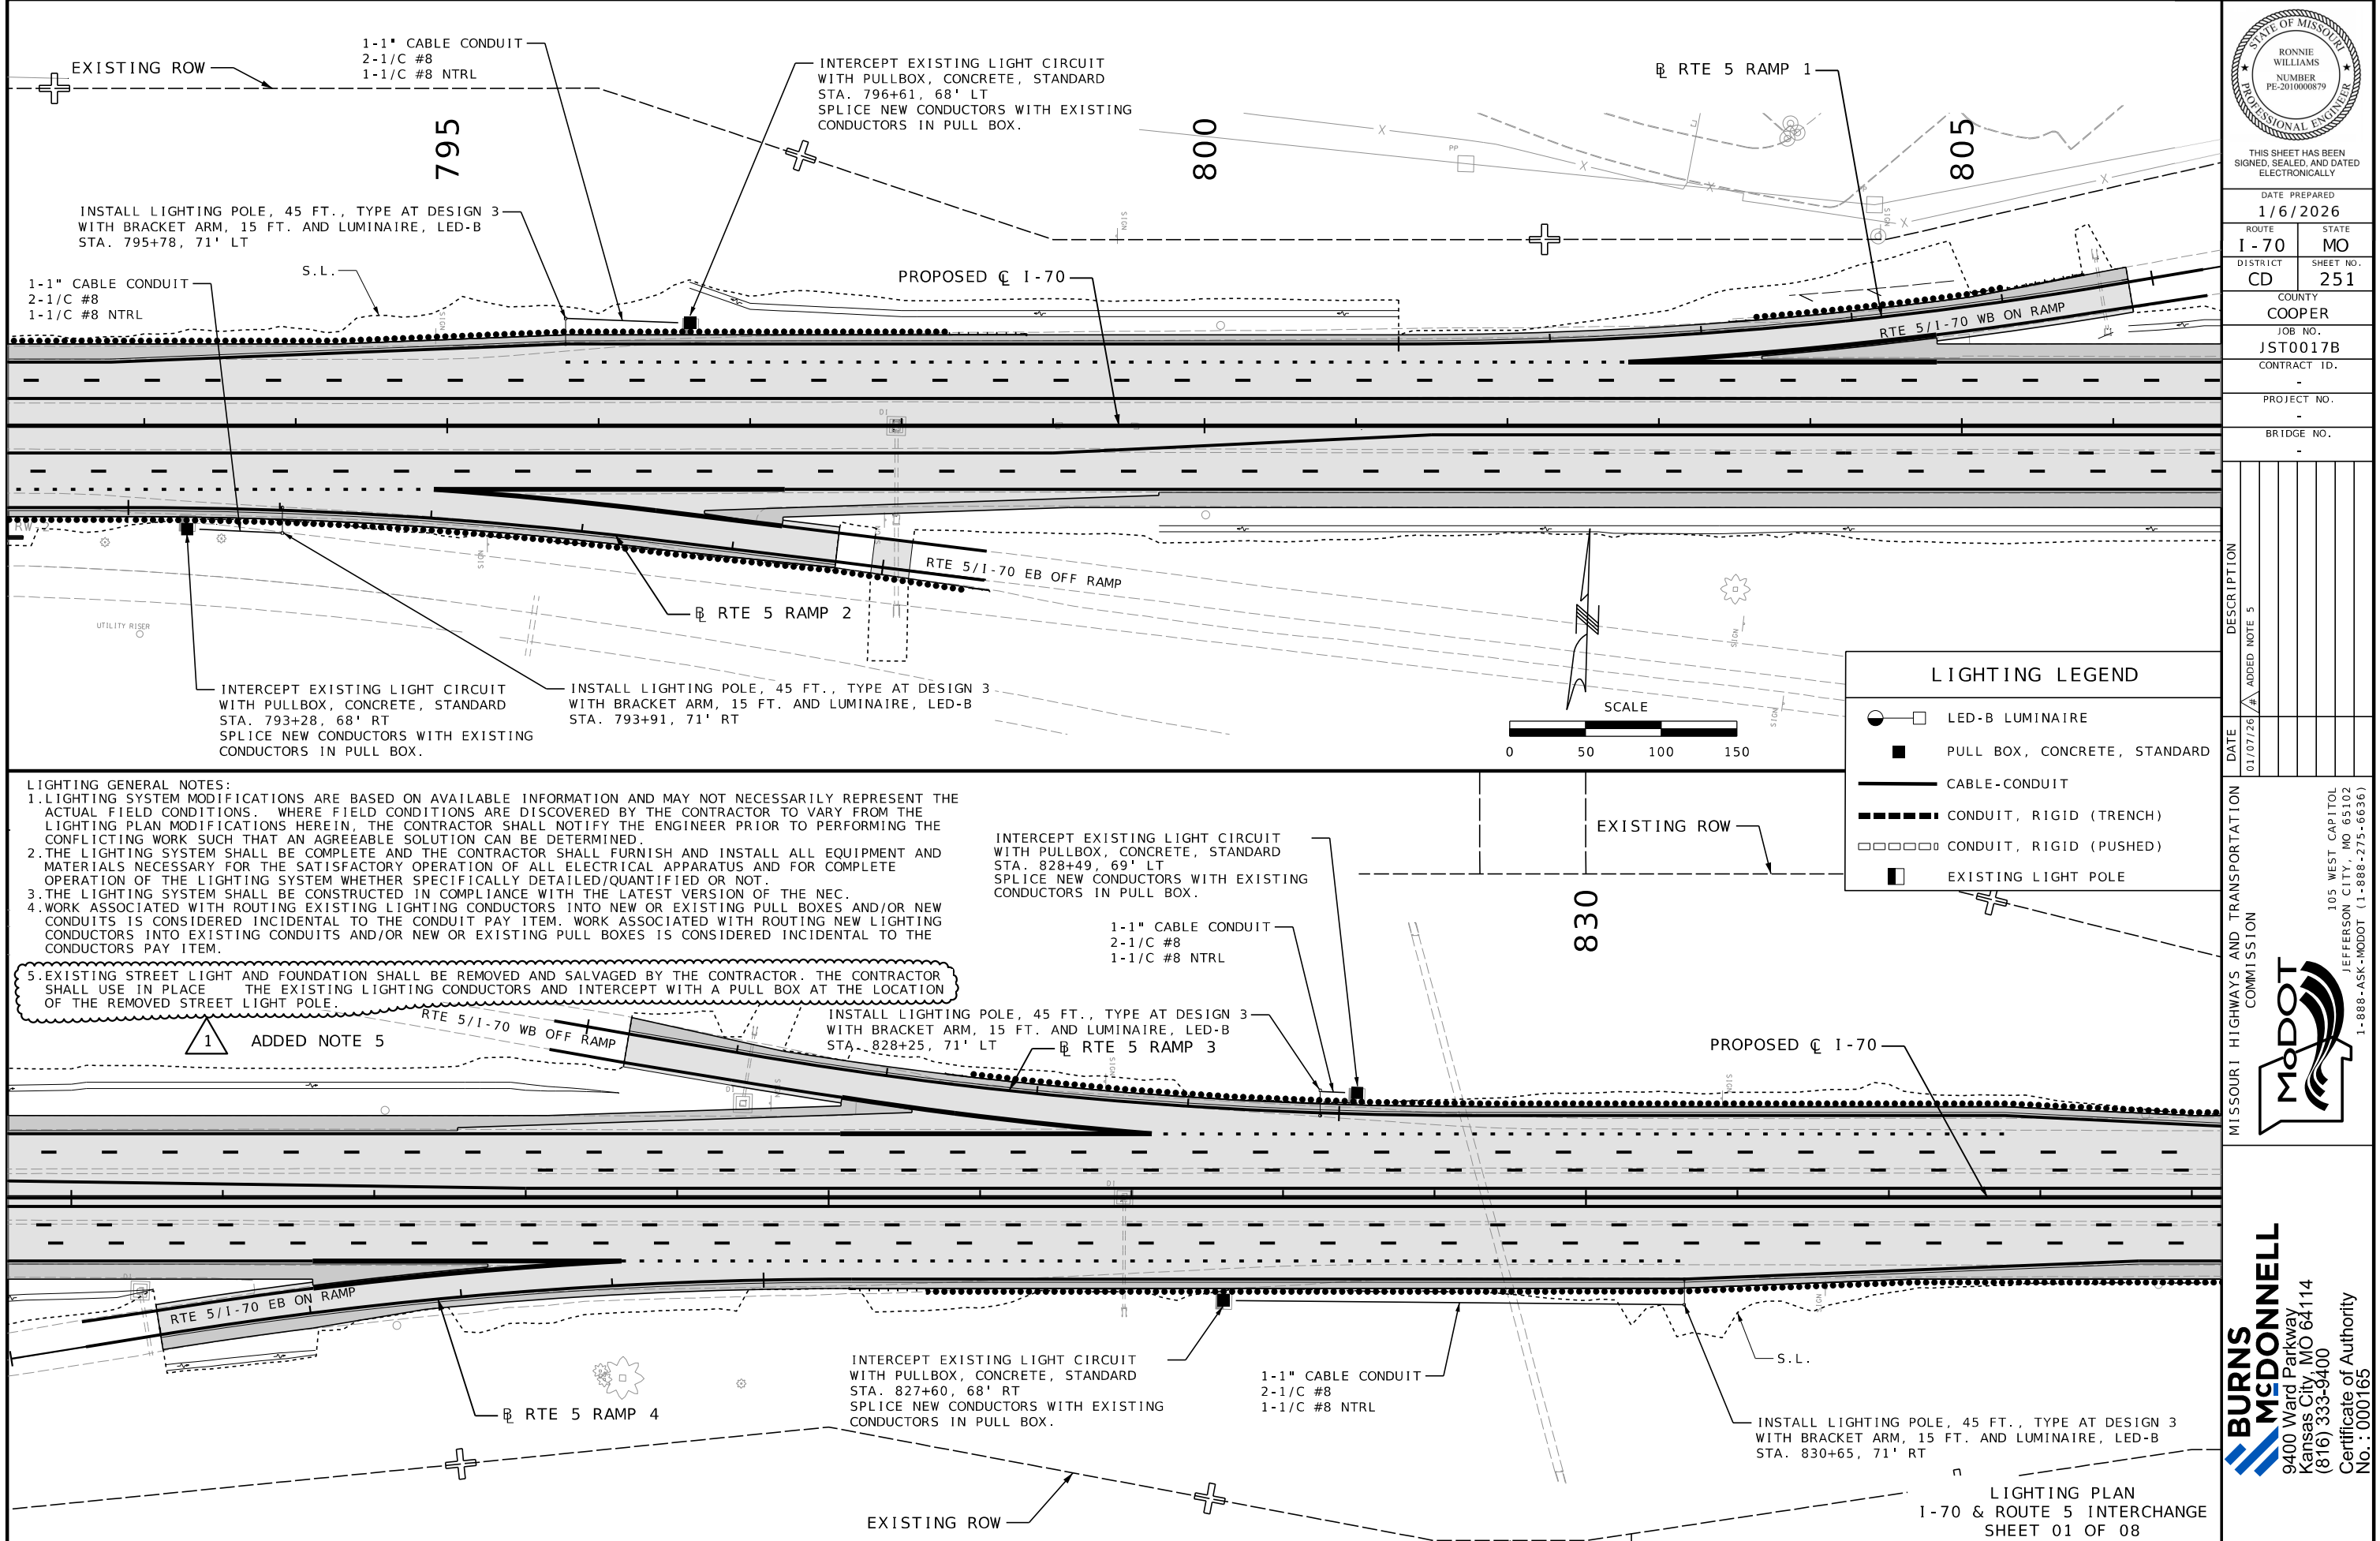

LIGHTING GENERAL NOTES:
1. LIGHTING SYSTEM MODIFICATIONS ARE BASED ON AVAILABLE INFORMATION AND MAY NOT NECESSARILY REPRESENT THE ACTUAL FIELD CONDITIONS. WHERE FIELD CONDITIONS ARE DISCOVERED BY THE CONTRACTOR TO VARY FROM THE LIGHTING PLAN MODIFICATIONS HEREIN, THE CONTRACTOR SHALL NOTIFY THE ENGINEER PRIOR TO PERFORMING THE CONFLICTING WORK SUCH THAT AN AGREEABLE SOLUTION CAN BE DETERMINED.
2. THE LIGHTING SYSTEM SHALL BE COMPLETE AND THE CONTRACTOR SHALL FURNISH AND INSTALL ALL EQUIPMENT AND MATERIALS NECESSARY FOR THE SATISFACTORY OPERATION OF ALL ELECTRICAL APPARATUS AND FOR COMPLETE OPERATION OF THE LIGHTING SYSTEM WHETHER SPECIFICALLY DETAILED/QUANTIFIED OR NOT.
3. THE LIGHTING SYSTEM SHALL BE CONSTRUCTED IN COMPLIANCE WITH THE LATEST VERSION OF THE NEC.
4. WORK ASSOCIATED WITH ROUTING EXISTING LIGHTING CONDUCTORS INTO NEW OR EXISTING PULL BOXES AND/OR NEW CONDUITS IS CONSIDERED INCIDENTAL TO THE CONDUIT PAY ITEM. WORK ASSOCIATED WITH ROUTING NEW LIGHTING CONDUCTORS INTO EXISTING CONDUITS AND/OR NEW OR EXISTING PULL BOXES IS CONSIDERED INCIDENTAL TO THE CONDUCTORS PAY ITEM.
5. EXISTING STREET LIGHT AND FOUNDATION SHALL BE REMOVED AND SALVAGED BY THE CONTRACTOR. THE CONTRACTOR SHALL USE IN PLACE THE EXISTING LIGHTING CONDUCTORS AND INTERCEPT WITH A PULL BOX AT THE LOCATION OF THE REMOVED STREET LIGHT POLE.

1. ADDED NOTE 5

STATE OF MISSOURI
RONNIE WILLIAMS
NUMBER
PE-201000879
PROFESSIONAL ENGINEER

THIS SHEET HAS BEEN
SIGNED, SEALED, AND DATED
ELECTRONICALLY

DATE PREPARED
1/6/2026

ROUTE
I-70

STATE
MO

DISTRICT
CD

SHEET NO.
251

COUNTY
COOPER

JOB NO.
JST0017B

CONTRACT ID.
-

PROJECT NO.
-

BRIDGE NO.
-

DESCRIPTION

ADDED NOTE 5

DATE

01/07/26

MISSOURI HIGHWAYS AND TRANSPORTATION
COMMISSION


MoDOT

105 WEST CAPITOL
JEFFERSON CITY, MO 65102
1-888-ASK-MODOT (1-888-275-6636)

BURNS
MCDONNELL


9400 Ward Parkway
Kansas City, MO 64114
(816) 333-9400
Certificate of Authority
No. : 000165

c:\bmc_d_lib\pw_connect\trn\d0200069\251_LT_JST0017B_150_Rte 5.dgn 6:18:40 PM 1/6/2026

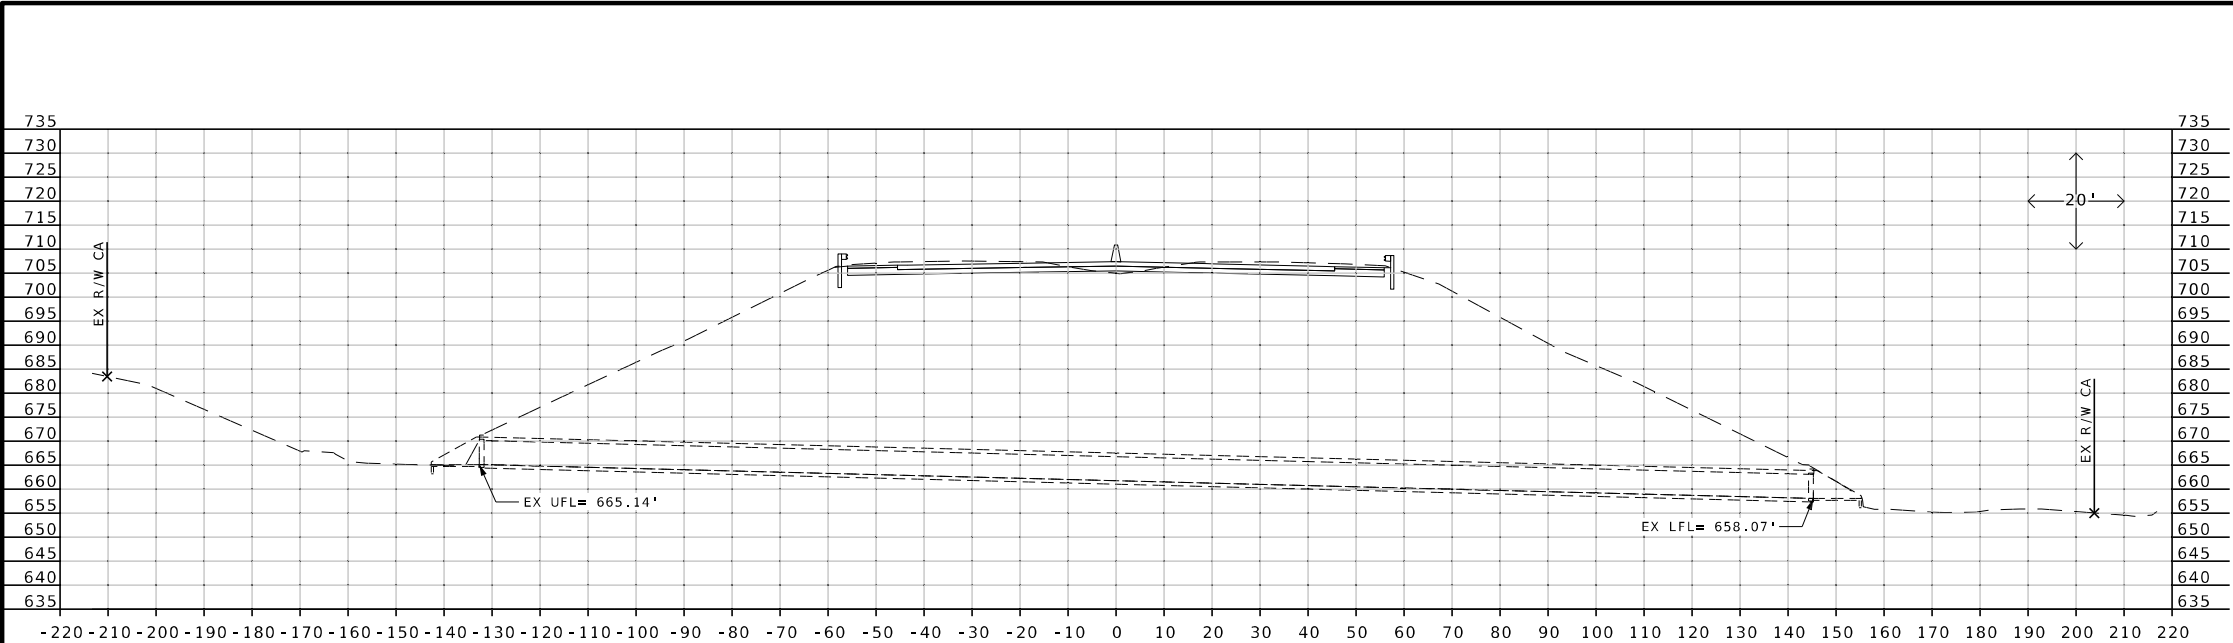


CULVERT 33 (STA 1345+34.79)

© I-70
STA 1345+00.61 128.26' LT TO
STA 1345+72.24 140.36' RT
278' x 5' x 5' RCB @ 2.54%
U.I.P.

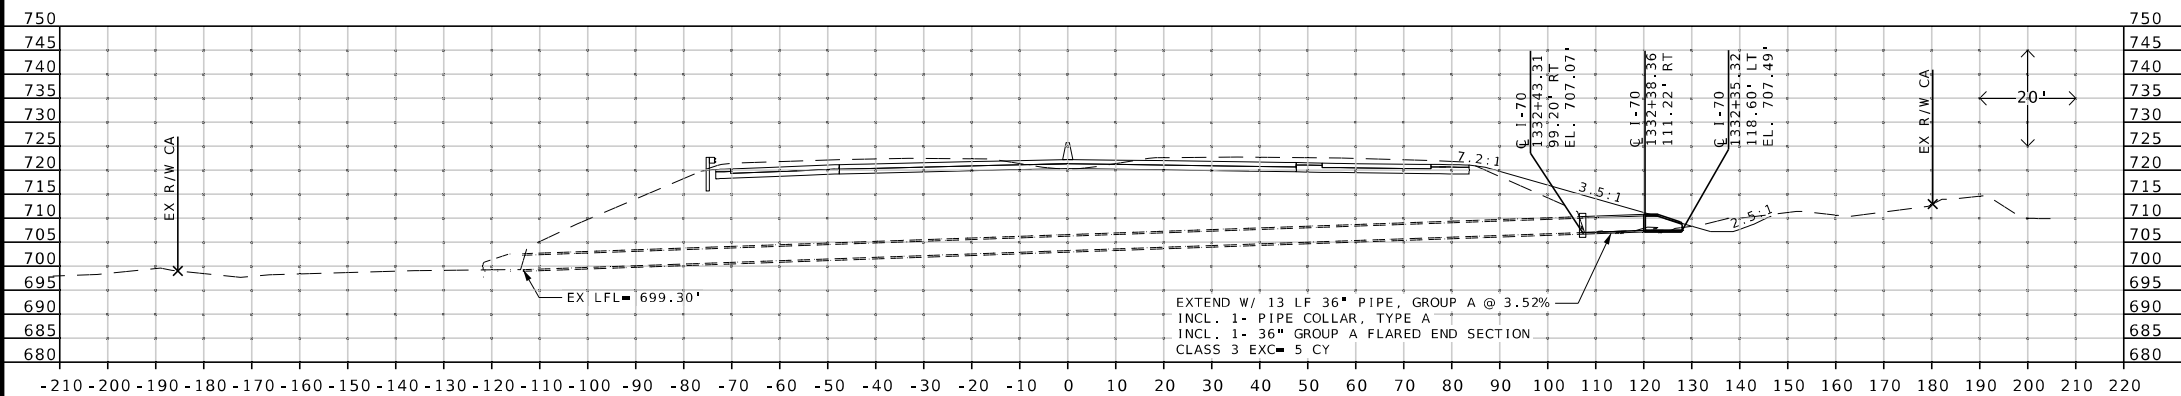


CULVERT 32 (STA 1332+84.15)

© I-70
STA 1332+43.31 99.20' LT TO
STA 1333+27.37 104.91' RT
221' x 36" RCP @ 3.52%

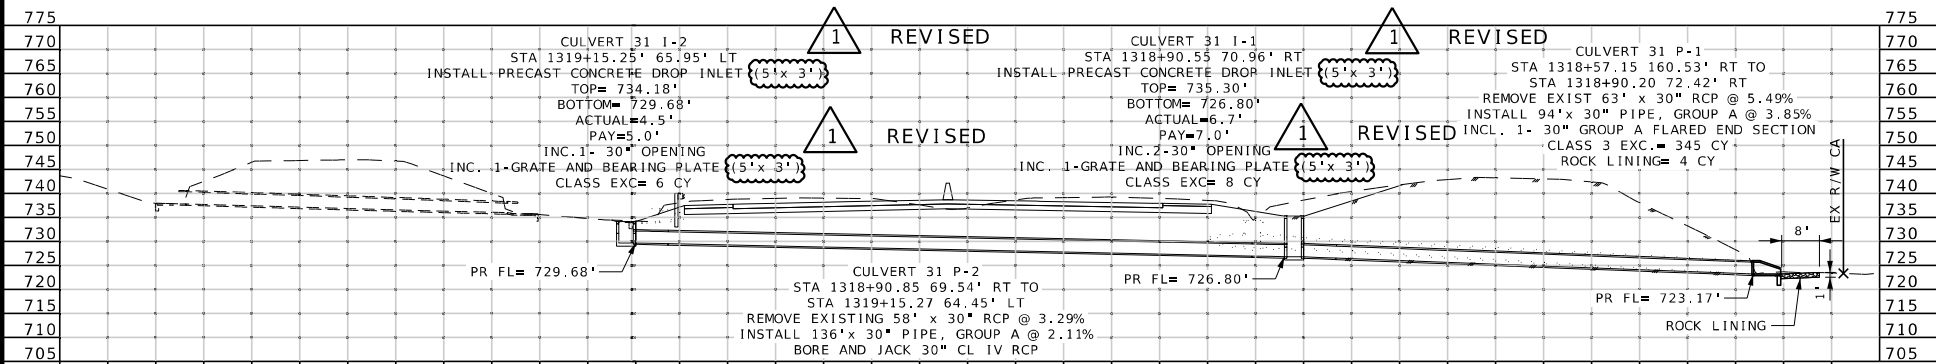

CULVERT 31 (STA 1319+14.41)

I-70 CULVERT SECTIONS
SHEET 13 OF 15

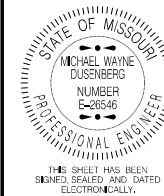

DATE PREPARED 1/7/2026	
ROUTE I-70	STATE MO
DISTRICT CD	SHEET NO. 338
COUNTY COOPER	
JOB NO. JST0017B	
CONTRACT ID. -	
PROJECT NO. -	
BRIDGE NO. -	


DATE	DESCRIPTION
01/07/26	REVISED DROP INLET
01/07/26	REVISED GRATE AND BEARING PLATE

MISSOURI HIGHWAYS AND TRANSPORTATION
COMMISSION


105 WEST CAPITOL
JEFFERSON CITY, MO 65102
1-888-ASK-MODOT (1-888-275-6636)

Bartlett & West


601 MONROE ST. SUITE 201 - JEFFERSON CITY, MO 65101
PHONE 573-634-3181
CERTIFICATE OF AUTHORITY NO. 000167 - ENGINEERING
WWW.BARTLETTWEST.COM

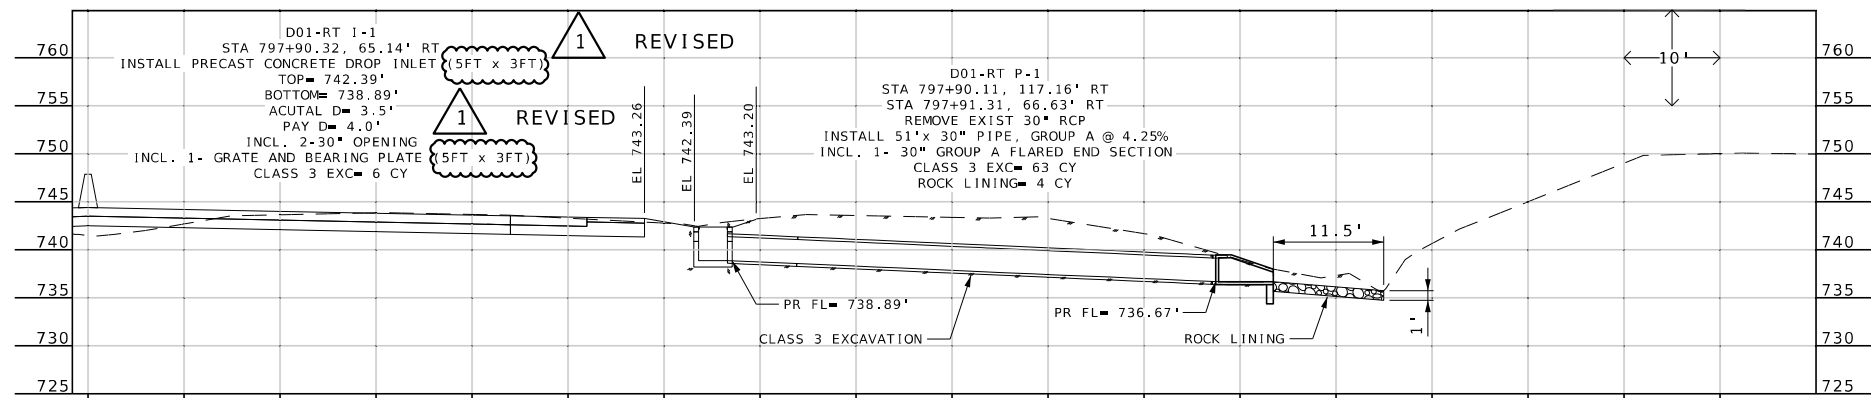


D01-RT

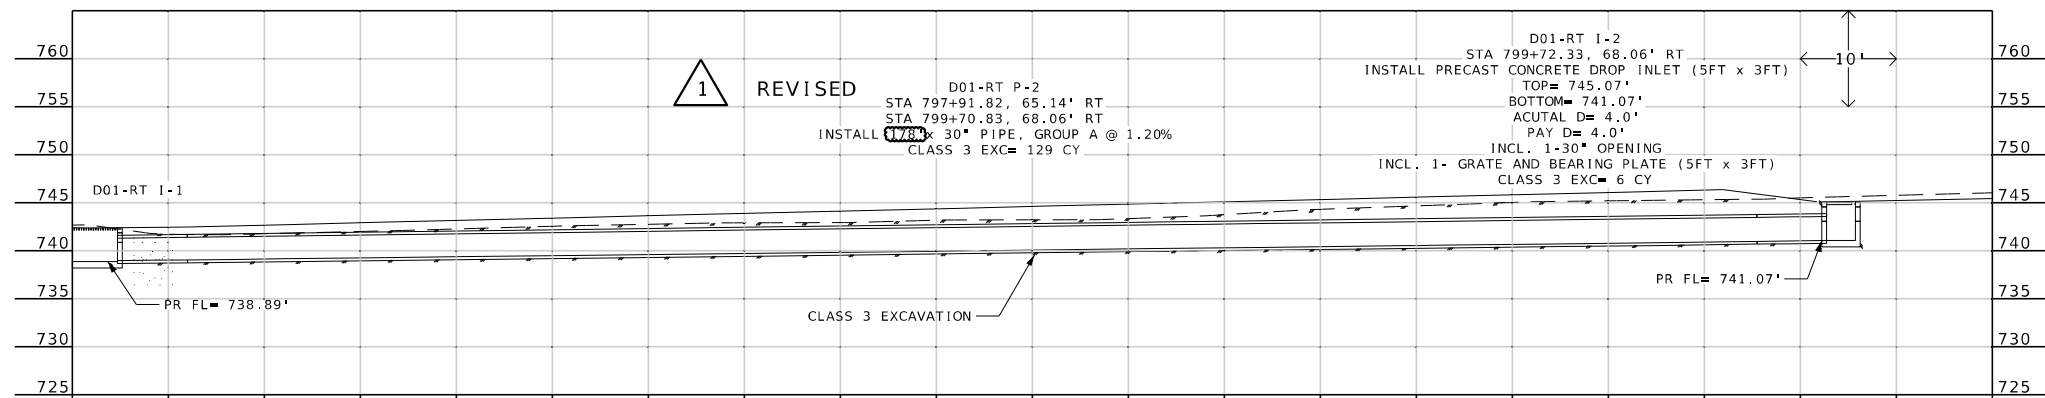

D01-RT

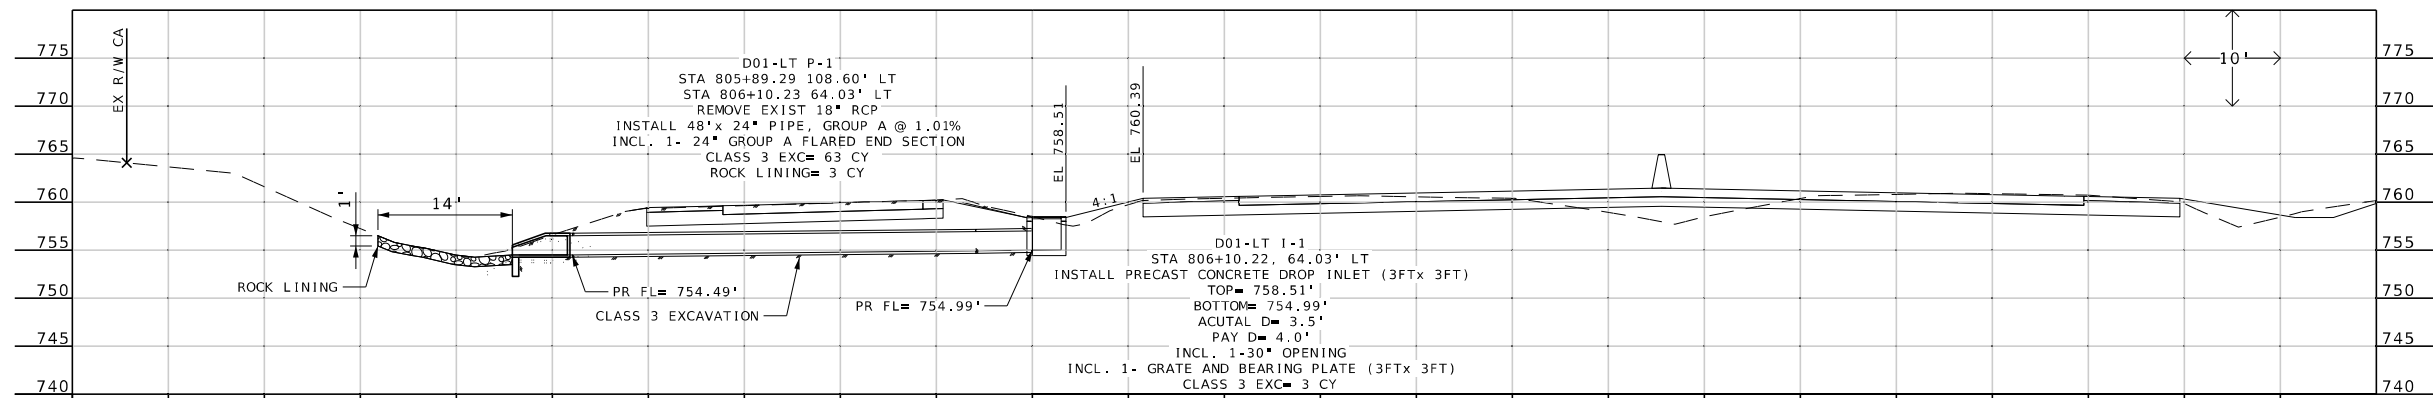


D01-LT

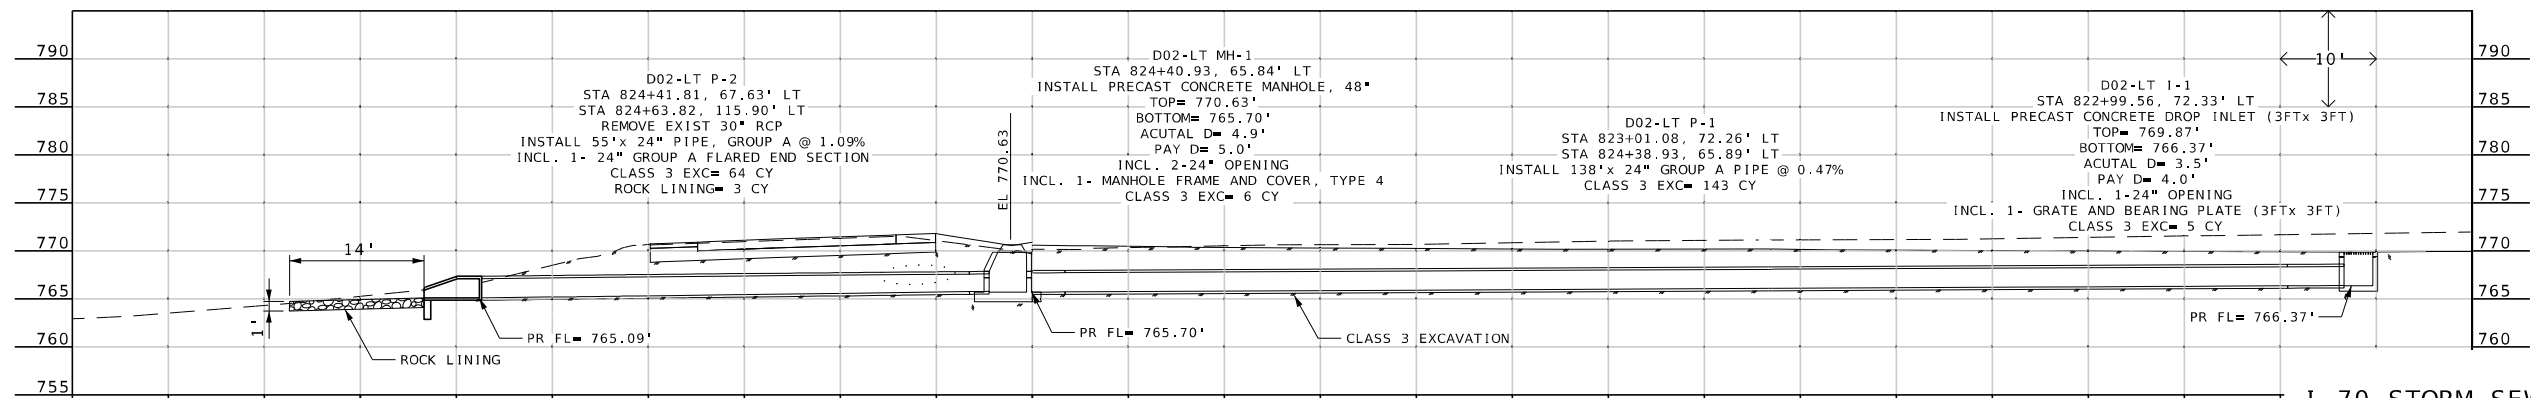

D02-LT

I-70 STORM SEWER SYSTEM
SHEET 1 OF 6

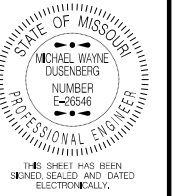

DATE PREPARED 1/7/2026	
ROUTE I-70	STATE MO
DISTRICT CD	SHEET NO. 341
COUNTY COOPER	
JOB NO. JST0017B	
CONTRACT ID. -	
PROJECT NO. -	
BRIDGE NO. -	

DATE	DESCRIPTION
01/07/26	REVISED DROP INLET
01/07/26	REVISED GRATE AND BEARING PLATE
01/07/26	REVISED GROUP A PIPE








MISSOURI HIGHWAYS AND TRANSPORTATION
COMMISSION

MoDOT

105 WEST CAPITOL
JEFFERSON CITY, MO 65102
1-888-ASK-MODOT (1-888-275-6636)

Bartlett & West

601 MONROE ST. SUITE 201 - JEFFERSON CITY, MO 65101
PHONE 573-634-3181
CERTIFICATE OF AUTHORITY NO. 000167 - ENGINEERING
WWW.BARTLETTWEST.COM

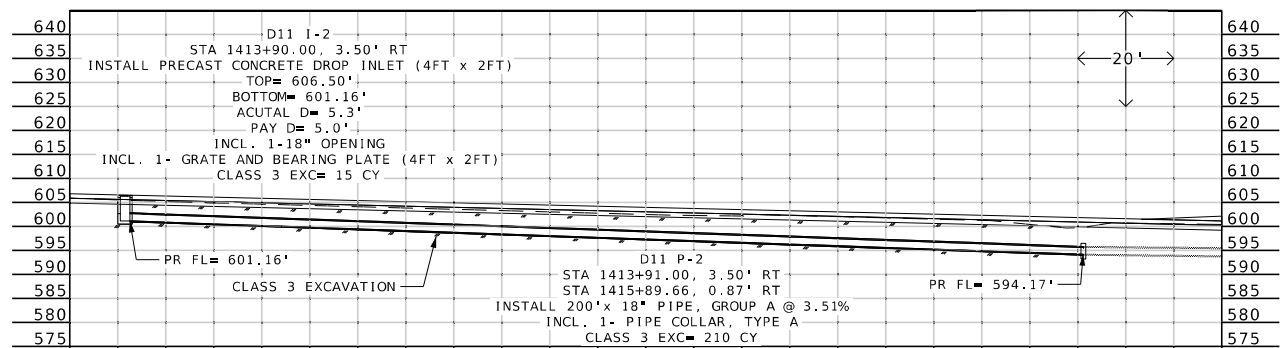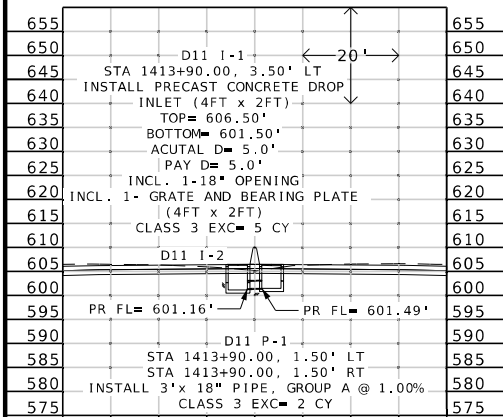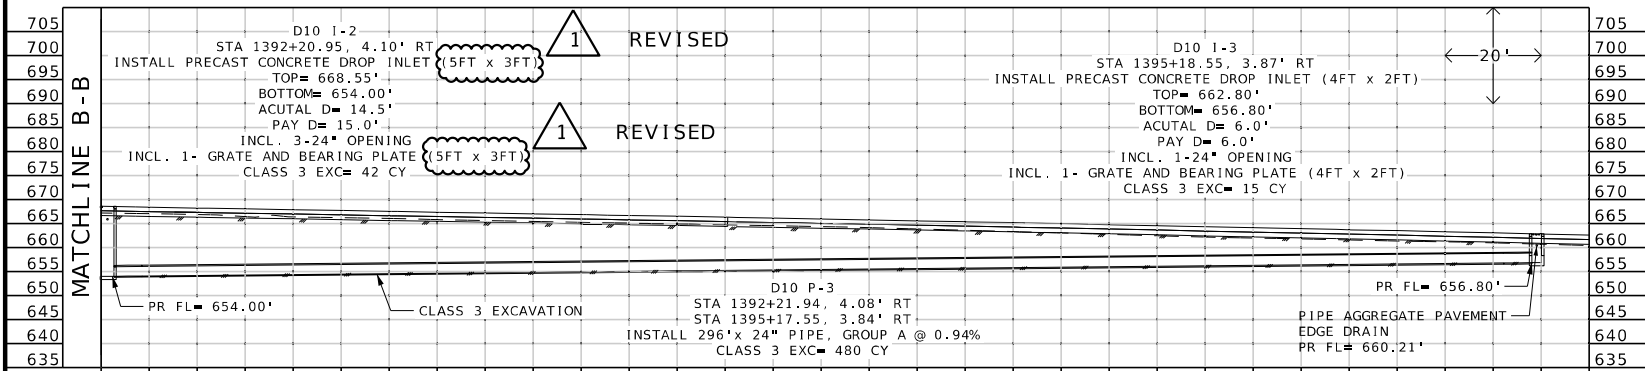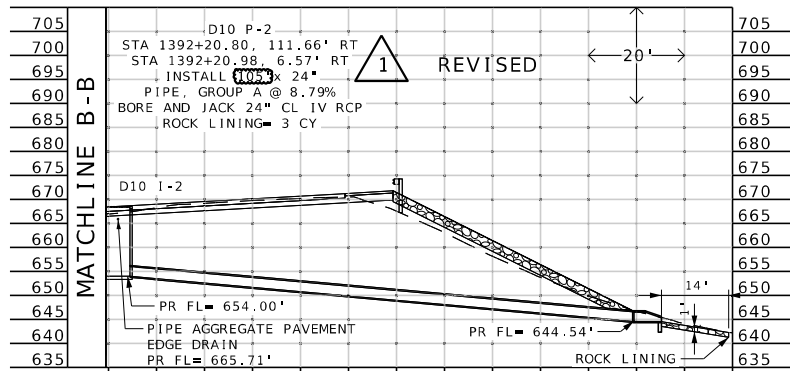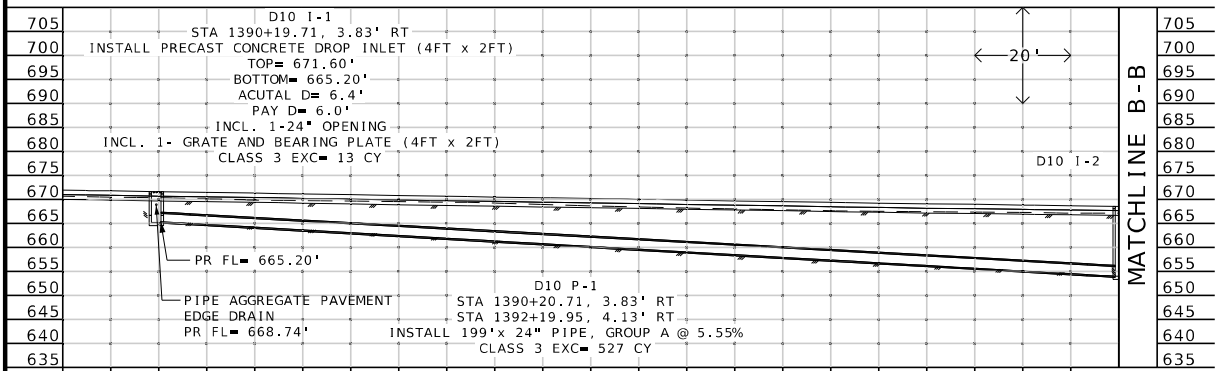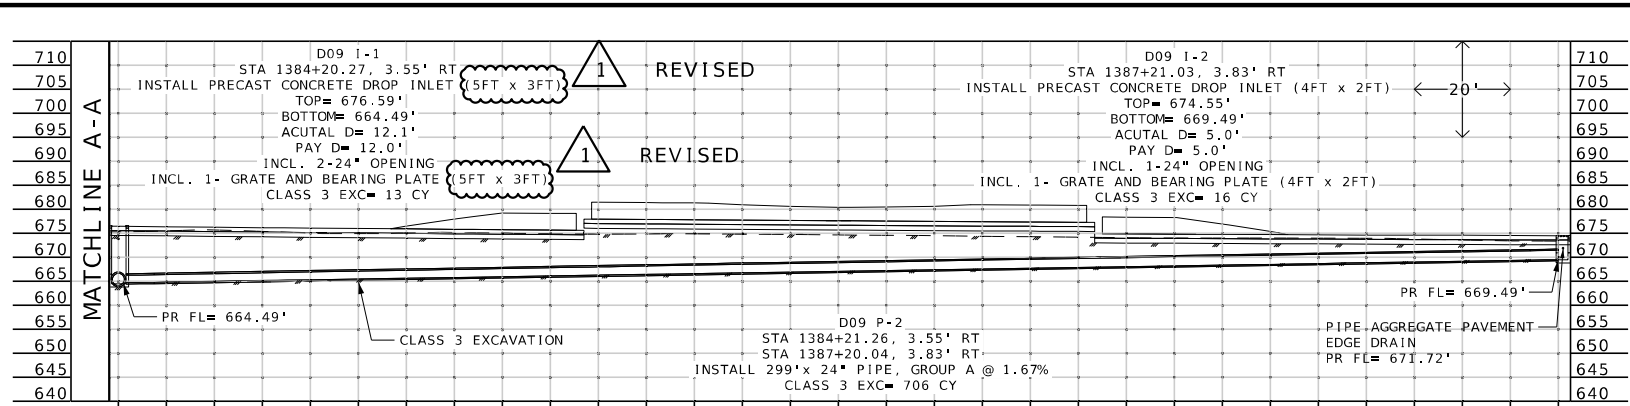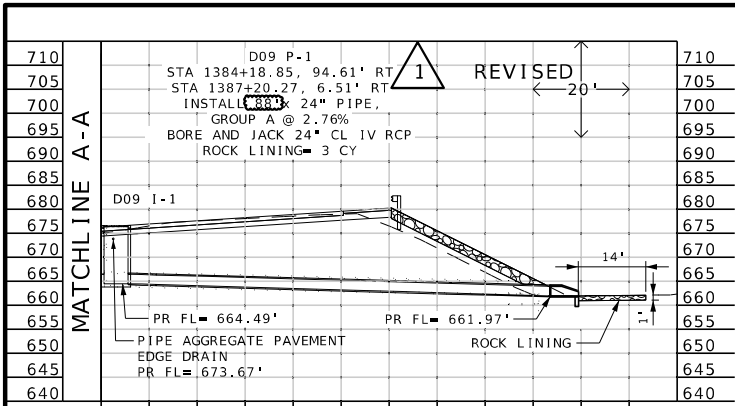

I-70 STORM SEWER SYSTEM
SHEET 6 OF 6

STATE OF MISSOURI

MICHAEL WAYNE DUSENBERG

NUMBER E-28546

PROFESSIONAL ENGINEER

THIS SHEET HAS BEEN SIGNED, SEALED AND DATED ELECTRONICALLY.

DATE PREPARED
1/7/2026

ROUTE
I-70

STATE
MO

DISTRICT
CD

SHEET NO.
346

COUNTY
COOPER

JOB NO.
JST0017B

CONTRACT ID.
-

PROJECT NO.
-

BRIDGE NO.
-

DATE	DESCRIPTION
01/07/26	REVISED GROUP A PIPE
01/07/26	REVISED DROP INLET
01/07/26	REVISED GRATE AND BEARING PLATE

MISSOURI HIGHWAYS AND TRANSPORTATION COMMISSION

MoDOT

105 WEST CAPITOL
JEFFERSON CITY, MO 65102
1-888-ASK-MODOT (1-888-273-6636)

Bartlett & West

601 MONROE ST. SUITE 201 - JEFFERSON CITY, MO 65101
PHONE 573-634-3181
CERTIFICATE OF AUTHORITY NO. 000167 - ENGINEERING
WWW.BARTLETTWEST.COM

c:\bmc_d_lib\pw_connect\trn\d0185110\346_CC_JST0017B_I100_I-70.dgn 8:27:51 AM 1/7/2026